




GROUND FLOOR PLAN

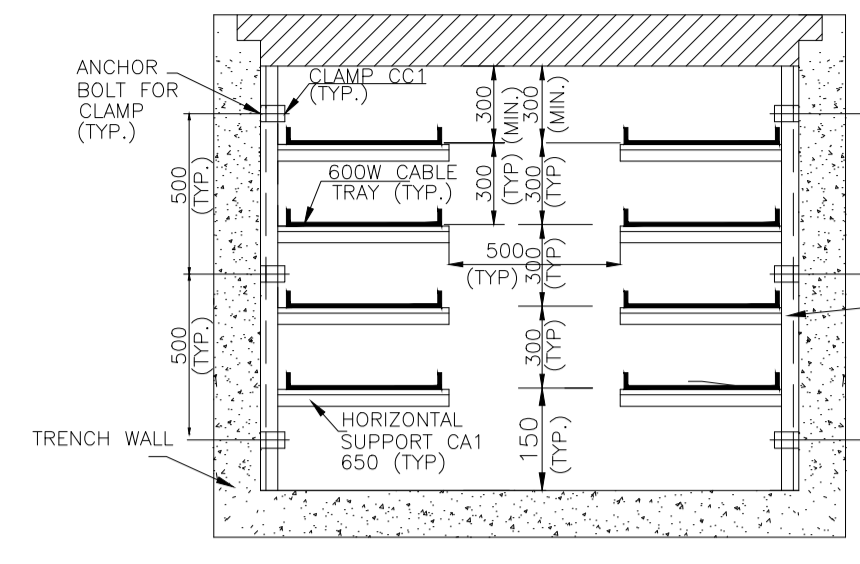


TRENCH DETAIL  
1800WX1350D  
TR A-A

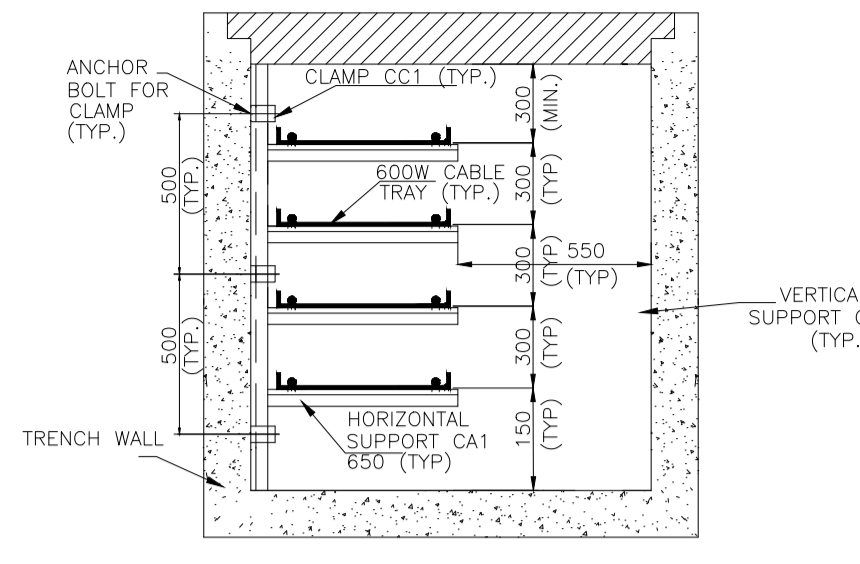


TRENCH DETAIL  
1200WX1350D

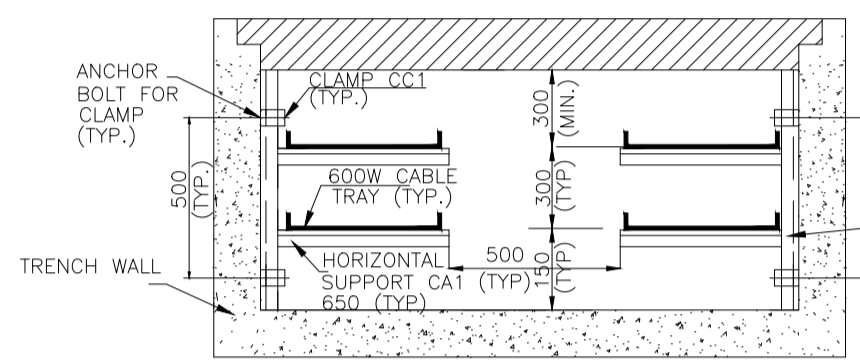


TRENCH DETAIL  
1800WX750D  
TR B-B

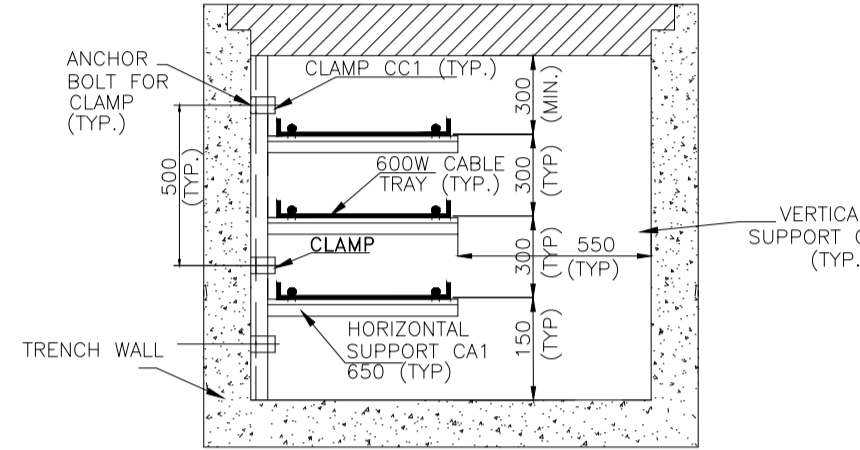


TRENCH DETAIL  
1200WX1050D  
TR D-D

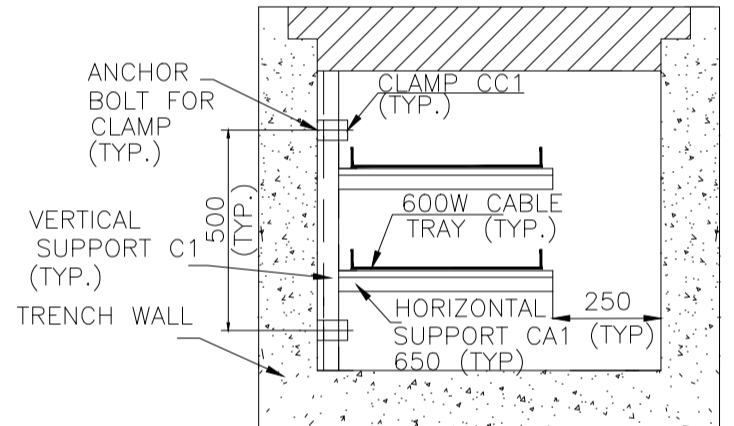

TRENCH DETAIL  
900WX750D  
TR E-E

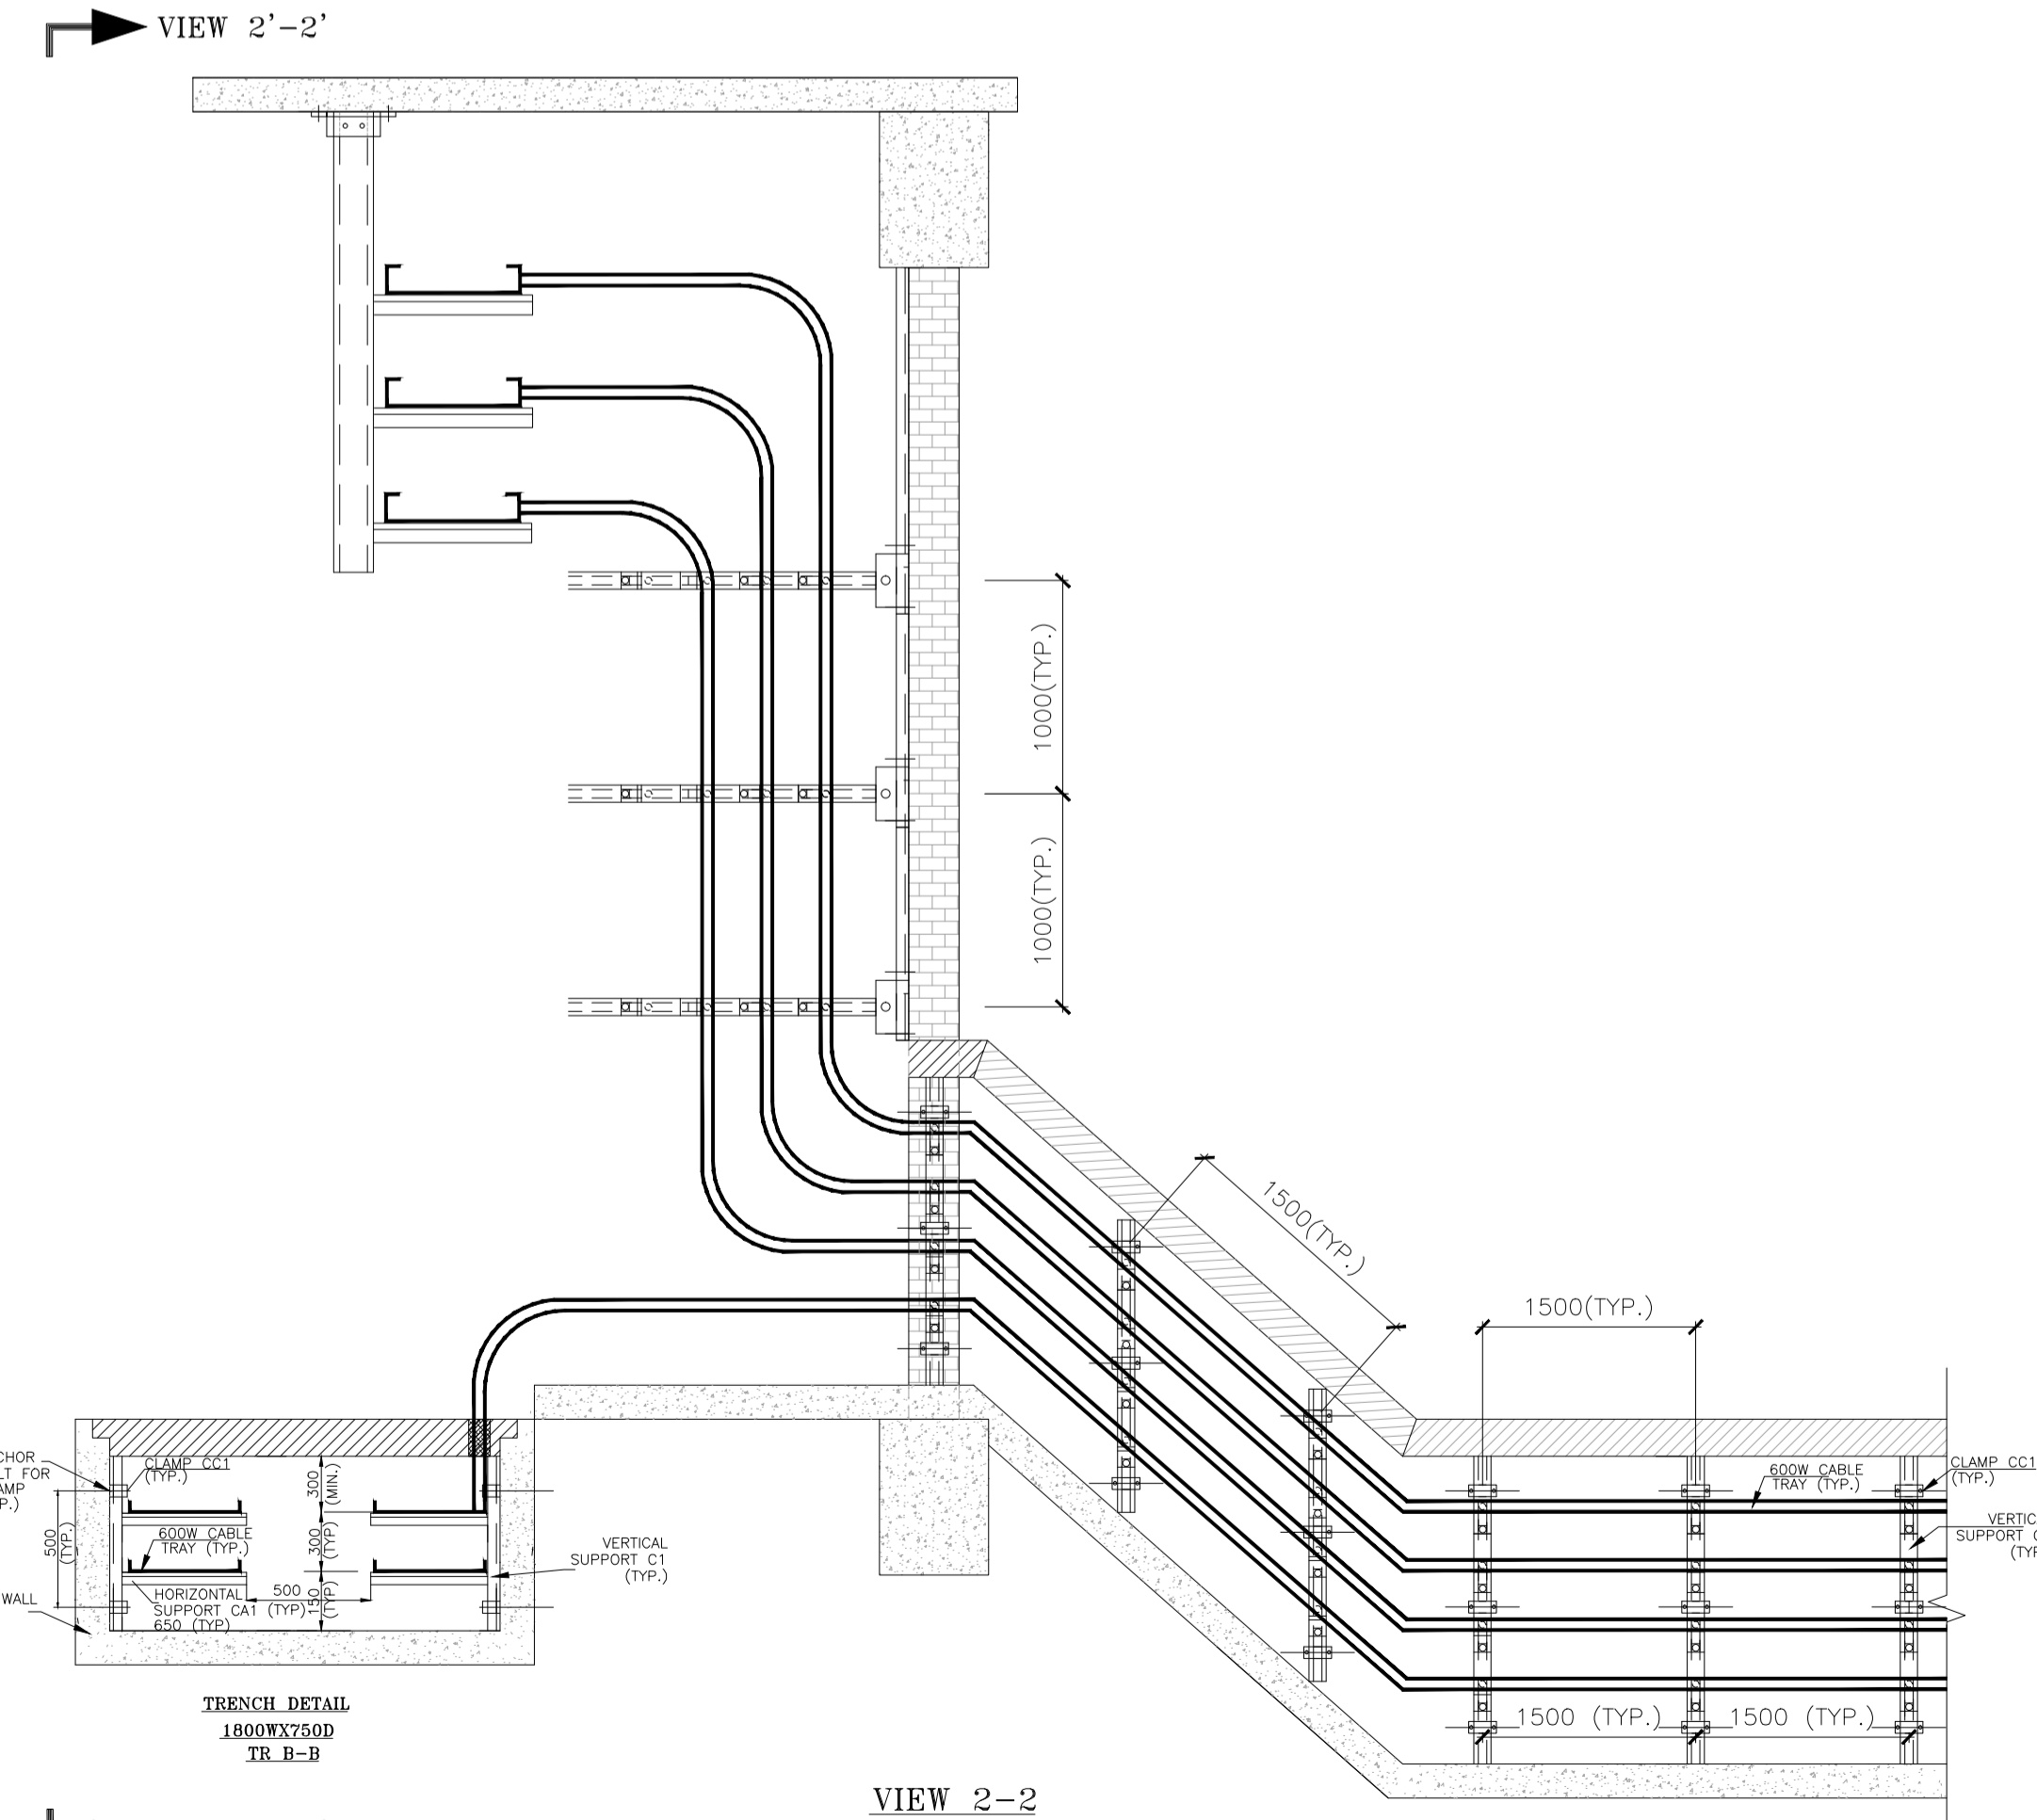

TRENCH DETAIL  
1800WX750D  
TR B-B

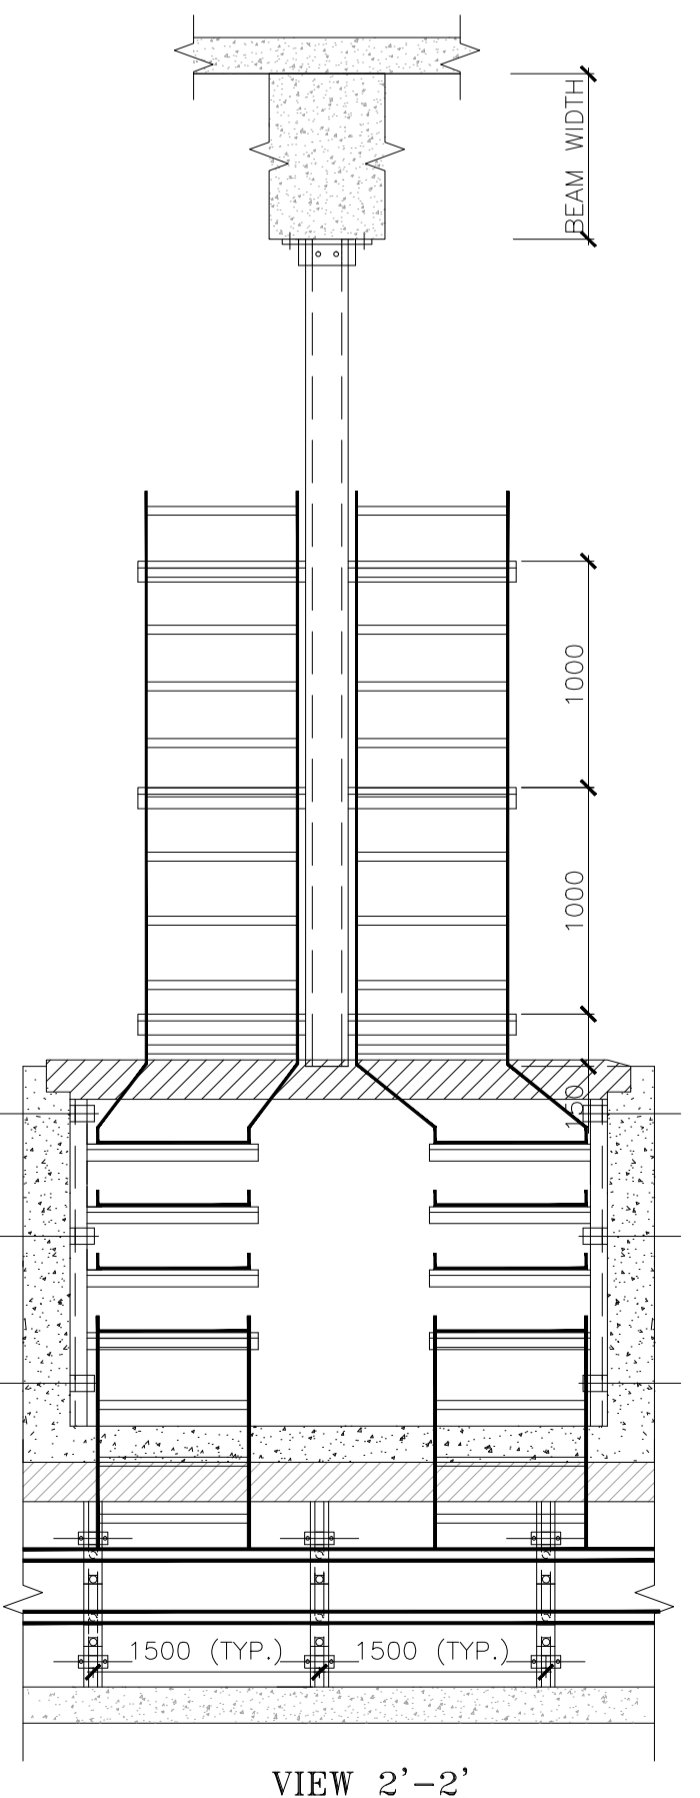

TRENCH DETAIL  
900WX750D  
TR E-E

NOTES:-  
THIS DRAWING SHALL BE REFERRED ONLY FOR INSTALLATION OF CABLE TRAY AND CABLE TRAY SUPPORT SYSTEM.  
PLEASE REFER SHEET 2 FOR DETAIL NOTES.

INVENTORY No. COMPUTER DRG. PATH NAME : REF. DRG. No. SIGN. & DATE

ADDITIONAL INFORMATION W.D.M. #4097		TAMILNADU GENERATION AND DISTRIBUTION CORPORATION (TANGEDCO)	
STATUS OF DRAWING DISTRIBUTION OF PRINTS		40KV GIS AT 2 X 660 MW ENCORE SEE SUPERCRITICAL THERMAL POWER PROJECT AT ASH DYEK OF NCTPS	
NAME OF CONSULTANT		DESIGN PRIVATE LIMITED, NEW DELHI.	
BHARAT HEAVY ELECTRICALS LTD. TRANSMISSION BUSINESS GROUP		DESIGNED / NAME / DATE / SIGN. / SCALE / DATE 20.10.17	CHECKED / NAME / DATE / SIGN. / SCALE / DATE 20.10.17
REV. DATE 01 14.08.17 02 14.08.17 03 14.08.17	APPROVED / DATE APPROVED / DATE APPROVED / DATE	SHEET / SCALE 1/400 1:400	SHEET NO. / DRAWING NO. / DATE 00 / TB-378-510-008 / 00

COPY RIGHT AND CONFIDENTIAL  
The information on this document is the property of BHARAT HEAVY ELECTRICALS LIMITED  
It must not be used directly or indirectly in anyway detrimental to the interest of the company.