


43325009543'00'00'DWG

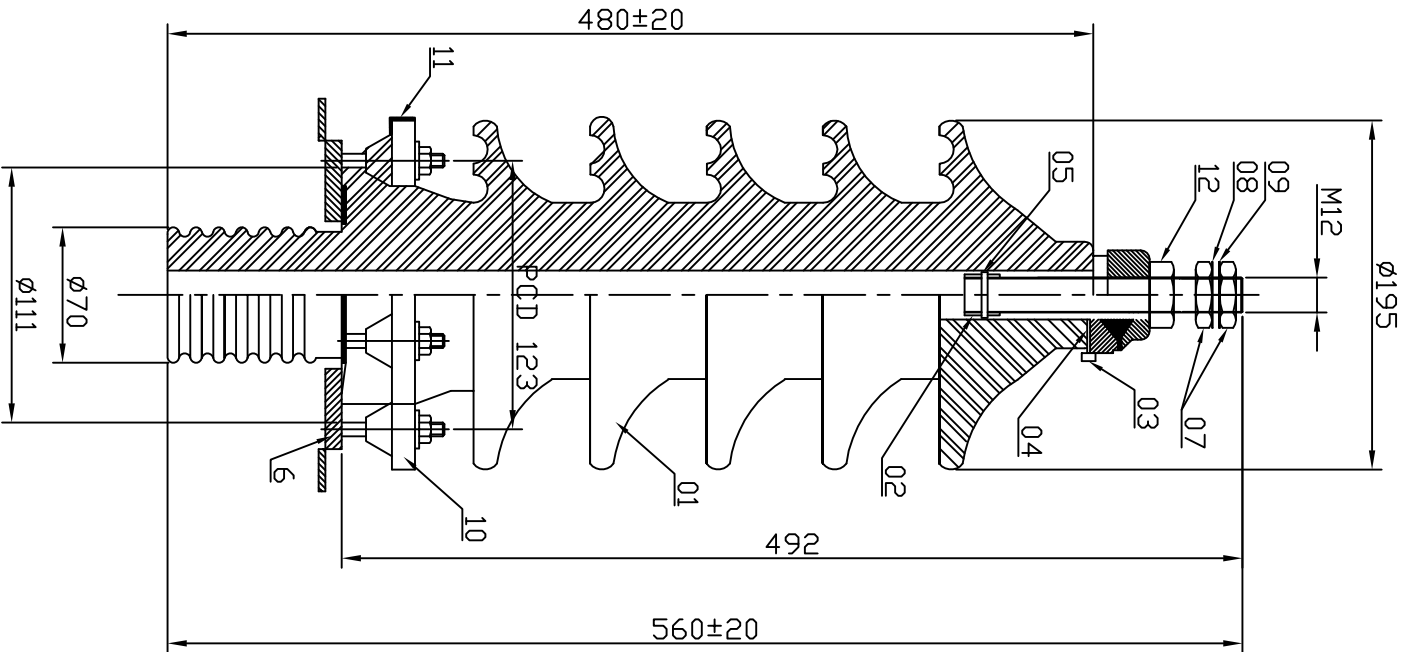


NO.	DESCRIPTION	MAT.	QTY.
01	PORCELAIN INSULATOR	PORCELAIN	01
02	STEM	BRASS	01
03	CAP	BRASS	01
04	SEALING WASHER	NITRILE	01
05	SEPERATOR	NITRILE/SRBC	01
06	SEALING WASHER	NITRILE/SRBC	01
07	LOCK NUT M12	BRASS	02
08	PLAIN WASHER	BRASS	01
09	SPRING WASHER	SP. STEEL	01
10	CLAMPING RING	M.S.	01
11	CLAMPING MEMBER	ALUMINIUM	04
12	FULL NUT M12	BRASS	01

TECHNICAL DETAILS

RATED VOLTAGE	36 KV
RATED CURRENT	250 Amp
TOTAL CREEPAGE DISTANCE	900mm
ONE MIN. DRY/WET 50Hz WITH STAND	80 KVrms
1.2/50 μ SEC. IMPULSE WITH STAND	170 Kvp

INVENTORY NO. TR20116B	SIGN AND DATE	REF. DRG. NO. PDW315754. DWG
---------------------------	---------------	---------------------------------

ADDITIONAL INFORMATION 71733A17700									
STATUS OF DRAWING									
DISTRIBUTION OF PRINTS									
TRE	PPC	BAY 1&2	BAY 3,4&5	BAY 6&7	BAY 8	BAY 9	LM	Other	
									0
REV	DATE	ALTERED CHECKED APPROVED							
ZONE									

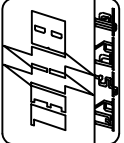PROJECT NAME : 65 MW SVPP, NEWVELI, CUDDALORE SOLAR POWER PLANT									
PO NO. : CONTS/0003D/PV SOLAR POWER/NEY&BP/2016 DATED 04.06.2016									
TYPE OF PRODUCT OR 27 NOS 2700/1350-1350 KVA 33/0.35-0.35 KV SOLAR INVERTER TRANSFORMER									
NAME OF CUSTOMER/PROJECT M/S NEWVELI LIGNITE CORPORATION LTD.									
		BHARAT HEAVY ELECTRICALS LTD.		JHANSI		NAME		SIGN	DATE
						JDN		S.K.YADAV	20.10.16
						CND		DNB	VAR
						APPD		VJ	
DEPT-TRE		UN. TOL. DIM. C/M/F		SCALE		WEIGHT (KG)		REF. TO ASSY. NO.	
CODE-406								14560050945	
TITLE 36KV, 250AMPS HV BUSHING									
DRAWING NO. 34560052334									
REV. OF 00									
SHT NO 1					NO OF SHT 1				