


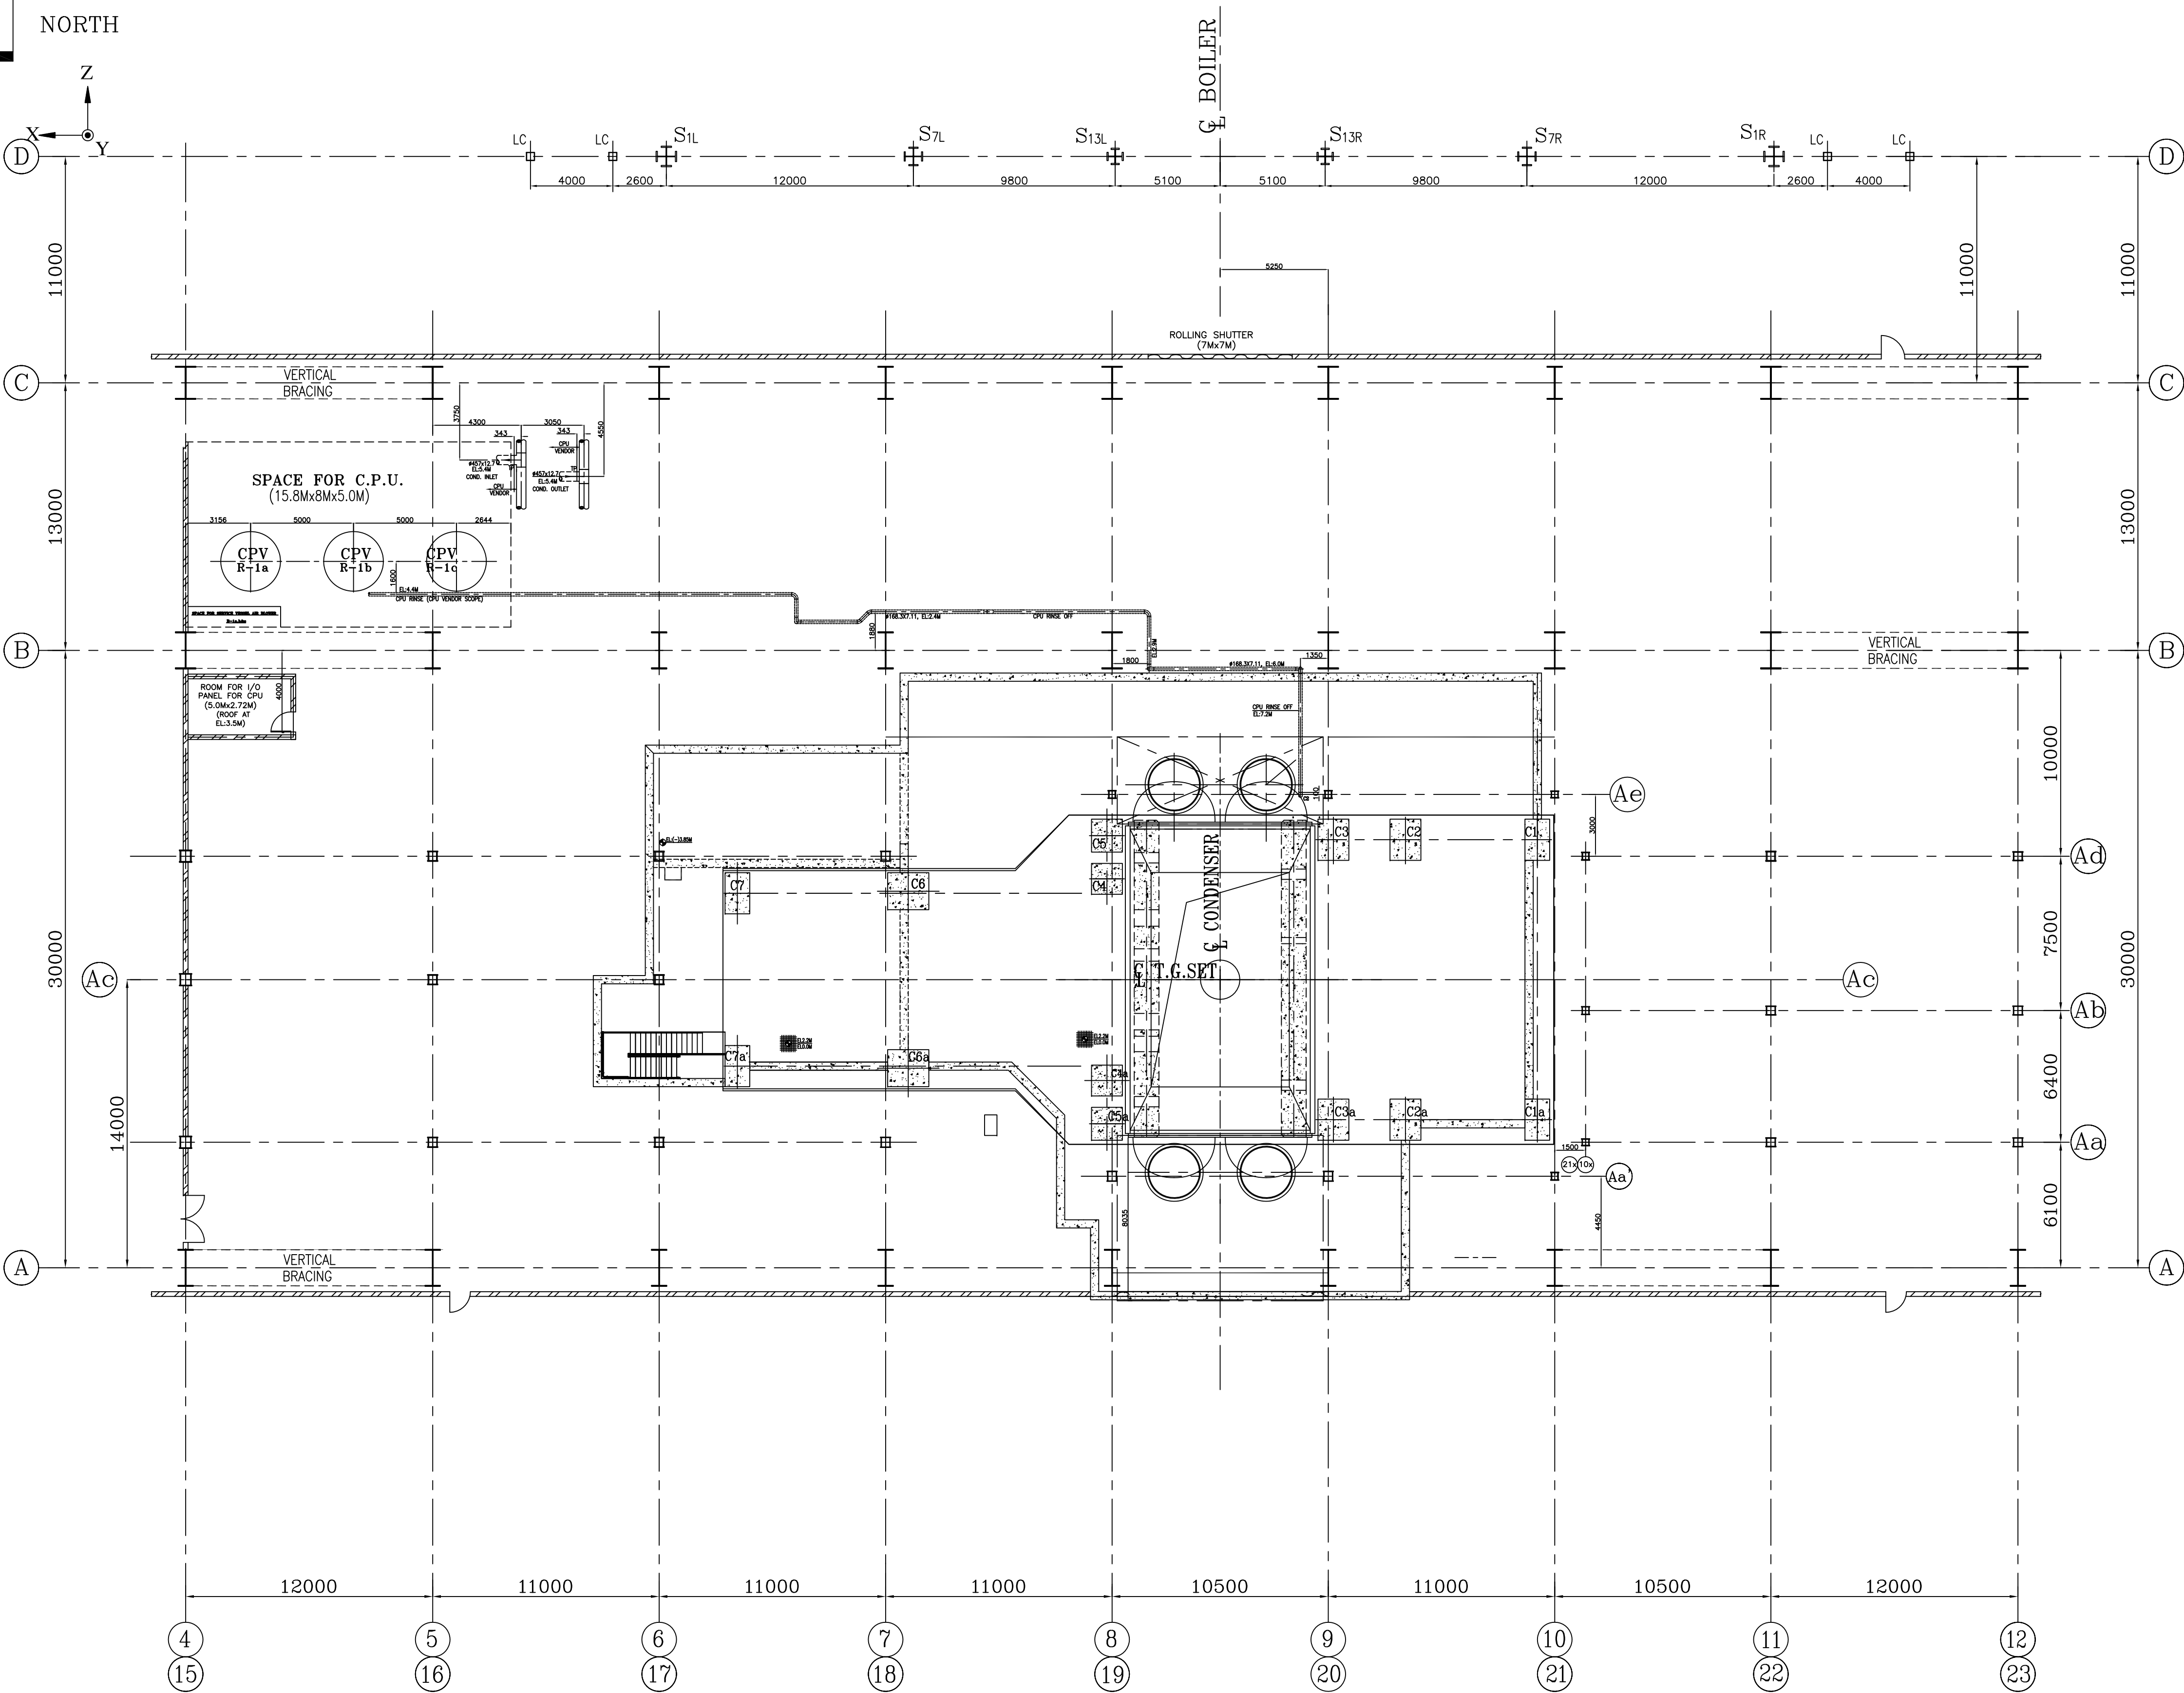

NOTES:

1. ALL DIMENSIONS ARE IN MM'S AND ELEVATIONS ARE IN METERS.
2. ALL ELEVATIONS INDICATED IN THE DRG. ARE W.R.T. POWER HOUSE GROUND FLOOR ELEVATION AS 0.00M, WHICH CORRESPONDS TO RL.(+)10.0M.



PROJECT	2x660MW ENNORE SEZ SUPERCRITICAL THERMAL POWER PROJECT AT ASH DYKE OF NCTPS, CHENNAI		
OWNER	TAMILNADU GENERATION & DISTRIBUTION CORPORATION LIMITED		
OWNER'S CONSULTANT	DESEIN PRIVATE LIMITED DESEIN HOUSE, NEW DELHI		
EPC CONTRACTOR	BHARAT HEAVY ELECTRICALS LTD		

JOB NO.	412			
STATUS	CONTRACT			
DISTRIBUTION				
TO				
NO. OF				
REV.	DATE	ALTD	CHD	APPD
1.	14/03/17	SD	SK	SK

DEPT	NAME	SIGN	DATE
POWER SECTOR	POWER SECTOR		13.08.2015
PROJECT ENGINEERING MANAGEMENT	PROJECT ENGINEERING MANAGEMENT		13.08.2015
Noida	Noida		13.08.2015

TITLE	
COMPOSITE PIPING LAYOUT BELOW 8.5M	
DEPT.	SCALE: 1:125
DRAWING NO.	PE-DG-412-100-M032
SHEET	1 OF 1
REV.	01

REV.	DATE	ALTD	CHD	APPD