


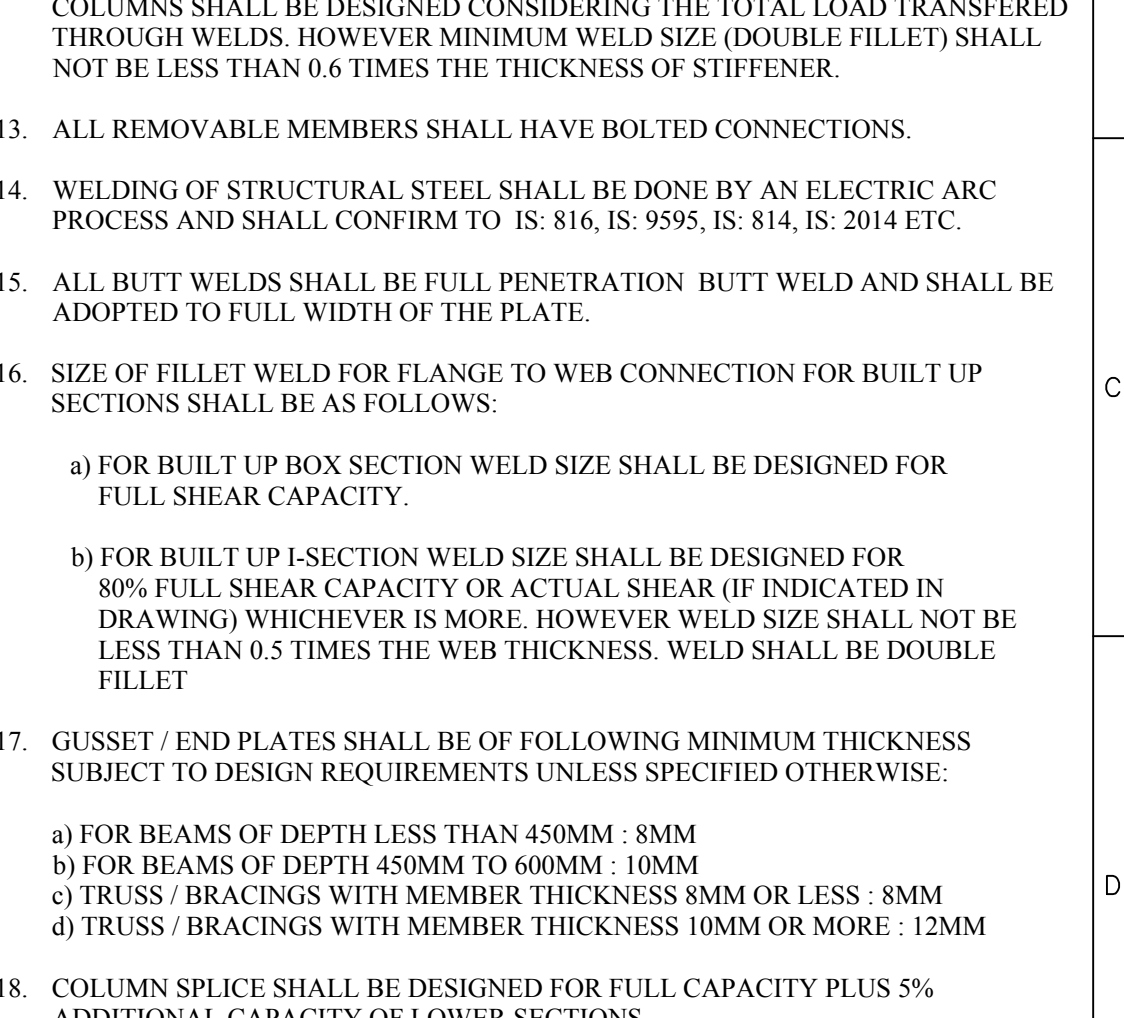


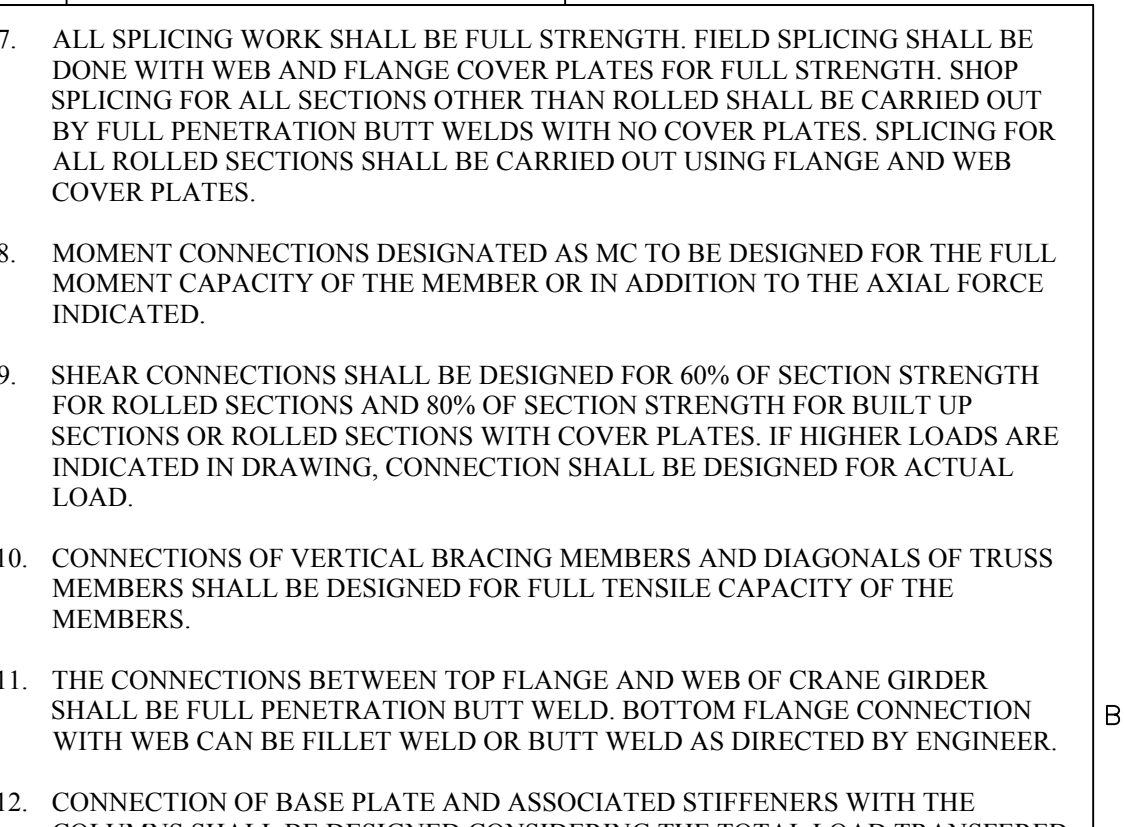


STRUCTURAL MEMBER TYPE	CODE / GRADE
------------------------	--------------

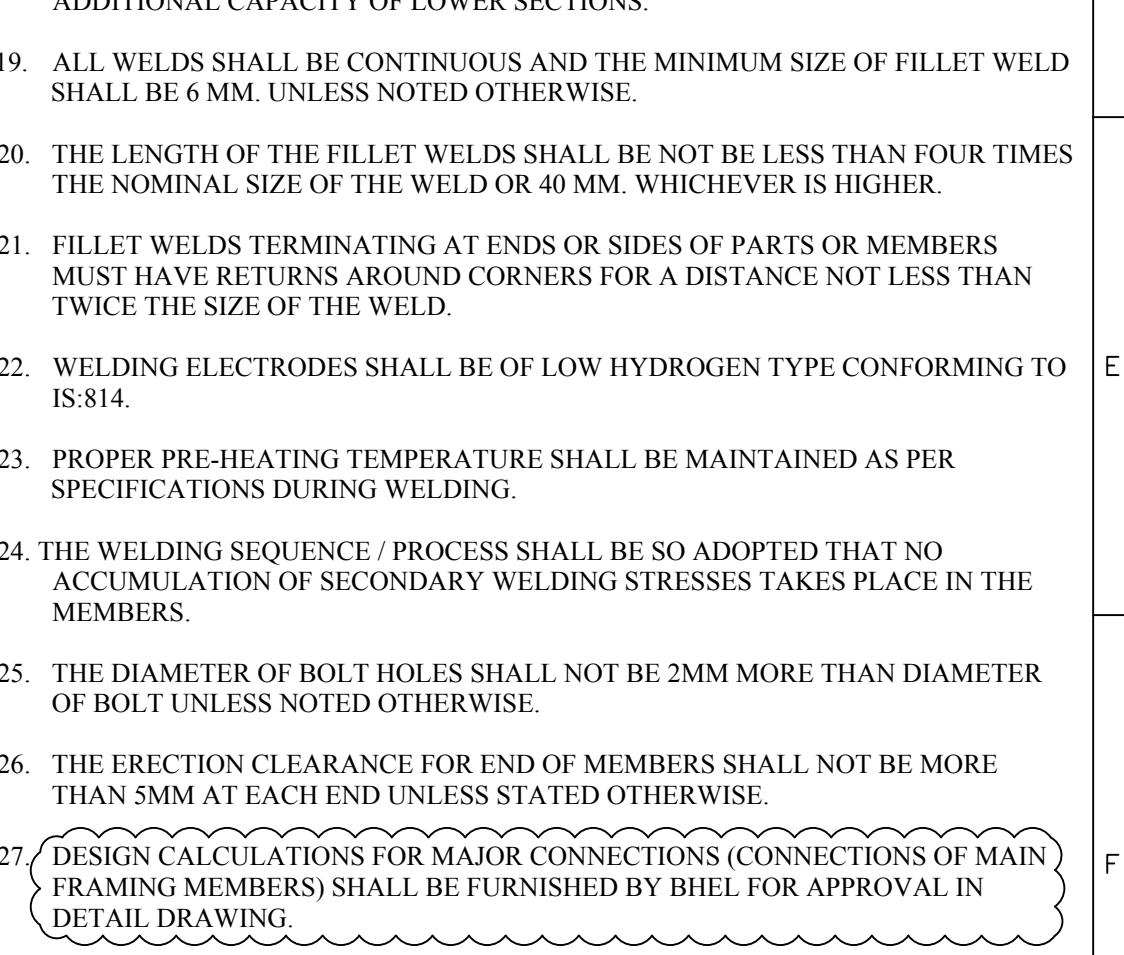


STRUCTURAL MEMBER TYPE	CODE / GRADE
PLATES UP TO 20 MM THICK	A36, A572-50, A588, A992, AR500, AR508, AR588, AR600, AR608, AR688, AR700, AR708, AR750, AR758, AR800, AR808, AR850, AR858, AR900, AR908, AR950, AR958, AR1000, AR1008, AR1050, AR1058, AR1100, AR1108, AR1150, AR1158, AR1200, AR1208, AR1250, AR1258, AR1300, AR1308, AR1350, AR1358, AR1400, AR1408, AR1450, AR1458, AR1500, AR1508, AR1550, AR1558, AR1600, AR1608, AR1650, AR1658, AR1700, AR1708, AR1750, AR1758, AR1800, AR1808, AR1850, AR1858, AR1900, AR1908, AR1950, AR1958, AR2000, AR2008, AR2050, AR2058, AR2100, AR2108, AR2150, AR2158, AR2200, AR2208, AR2250, AR2258, AR2300, AR2308, AR2350, AR2358, AR2400, AR2408, AR2450, AR2458, AR2500, AR2508, AR2550, AR2558, AR2600, AR2608, AR2650, AR2658, AR2700, AR2708, AR2750, AR2758, AR2800, AR2808, AR2850, AR2858, AR2900, AR2908, AR2950, AR2958, AR3000, AR3008, AR3050, AR3058, AR3100, AR3108, AR3150, AR3158, AR3200, AR3208, AR3250, AR3258, AR3300, AR3308, AR3350, AR3358, AR3400, AR3408, AR3450, AR3458, AR3500, AR3508, AR3550, AR3558, AR3600, AR3608, AR3650, AR3658, AR3700, AR3708, AR3750, AR3758, AR3800, AR3808, AR3850, AR3858, AR3900, AR3908, AR3950, AR3958, AR4000, AR4008, AR4050, AR4058, AR4100, AR4108, AR4150, AR4158, AR4200, AR4208, AR4250, AR4258, AR4300, AR4308, AR4350, AR4358, AR4400, AR4408, AR4450, AR4458, AR4500, AR4508, AR4550, AR4558, AR4600, AR4608, AR4650, AR4658, AR4700, AR4708, AR4750, AR4758, AR4800, AR4808, AR4850, AR4858, AR4900, AR4908, AR4950, AR4958, AR5000, AR5008, AR5050, AR5058, AR5100, AR5108, AR5150, AR5158, AR5200, AR5208, AR5250, AR5258, AR5300, AR5308, AR5350, AR5358, AR5400, AR5408, AR5450, AR5458, AR5500, AR5508, AR5550, AR5558, AR5600, AR5608, AR5650, AR5658, AR5700, AR5708, AR5750, AR5758, AR5800, AR5808, AR5850, AR5858, AR5900, AR5908, AR5950, AR5958, AR6000, AR6008, AR6050, AR6058, AR6100, AR6108, AR6150, AR6158, AR6200, AR6208, AR6250, AR6258, AR6300, AR6308, AR6350, AR6358, AR6400, AR6408, AR6450, AR6458, AR6500, AR6508, AR6550, AR6558, AR6600, AR6608, AR6650, AR6658, AR6700, AR6708, AR6750, AR6758, AR6800, AR6808, AR6850, AR6858, AR6900, AR6908, AR6950, AR6958, AR7000, AR7008, AR7050, AR7058, AR7100, AR7108, AR7150, AR7158, AR7200, AR7208, AR7250, AR7258, AR7300, AR7308, AR7350, AR7358, AR7400, AR7408, AR7450, AR7458, AR7500, AR7508, AR7550, AR7558, AR7600, AR7608, AR7650, AR7658, AR7700, AR7708, AR7750, AR7758, AR7800, AR7808, AR7850, AR7858, AR7900, AR7908, AR7950, AR7958, AR8000, AR8008, AR8050, AR8058, AR8100, AR8108, AR8150, AR8158, AR8200, AR8208, AR8250, AR8258, AR8300, AR8308, AR8350, AR8358, AR8400, AR8408, AR8450, AR8458, AR8500, AR8508, AR8550, AR8558, AR8600, AR8608, AR8650, AR8658, AR8700, AR8708, AR8750, AR8758, AR8800, AR8808, AR8850, AR8858, AR8900, AR8908, AR8950, AR8958, AR9000, AR9008, AR9050, AR9058, AR9100, AR9108, AR9150, AR9158, AR9200, AR9208, AR9250, AR9258, AR9300, AR9308, AR9350, AR9358, AR9400, AR9408, AR9450, AR9458, AR9500, AR9508, AR9550, AR9558, AR9600, AR9608, AR9650, AR9658, AR9700, AR9708, AR9750, AR9758, AR9800, AR9808, AR9850, AR9858, AR9900, AR9908, AR9950, AR9958, A508-CL3, A508-CL4, A508-CL5, A508-CL188, A508-CL189

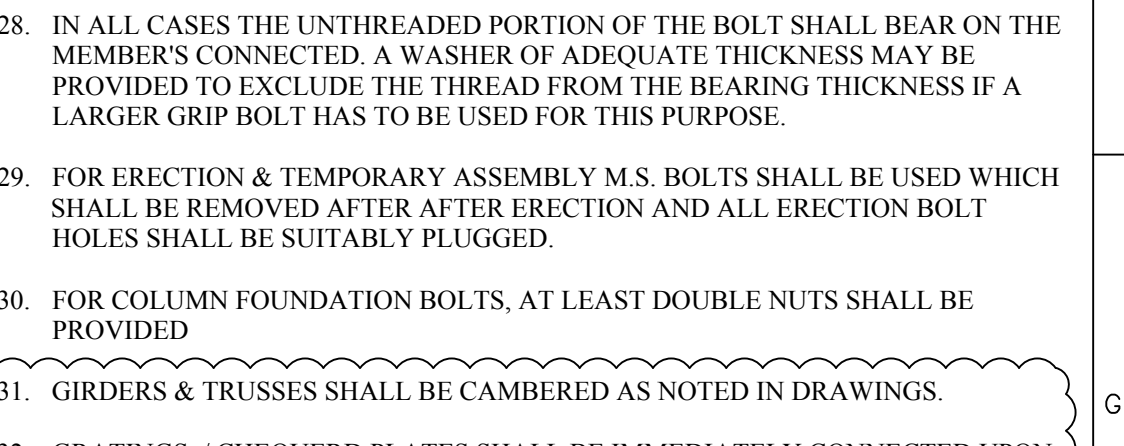


3.0	JOINTS & CONNECTIONS
-----	----------------------

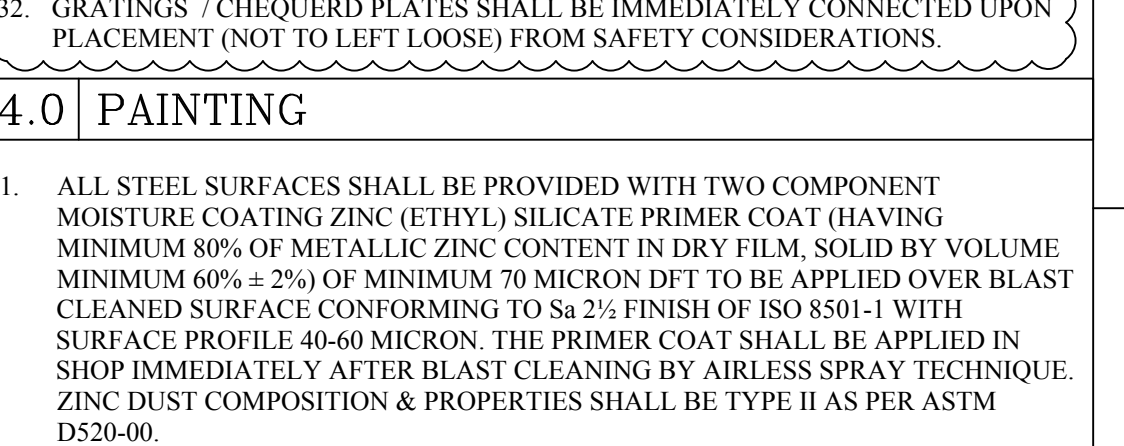


4. FOR BOLTED CONNECTIONS, IS:4000, IS:3757, IS:6623 & IS:6649 SHALL BE FOLLOWED AND FOR WELDING OF STRUCTURES IS:814, IS:816, IS:1024, IS:4353 &

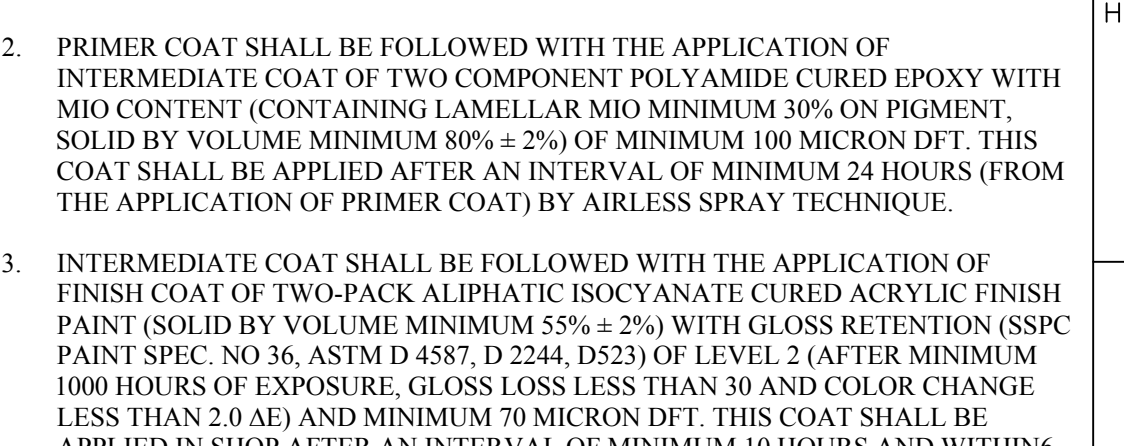

OTHERWISE.	☐ 5 THK. PIT.
------------	--------------------------------------

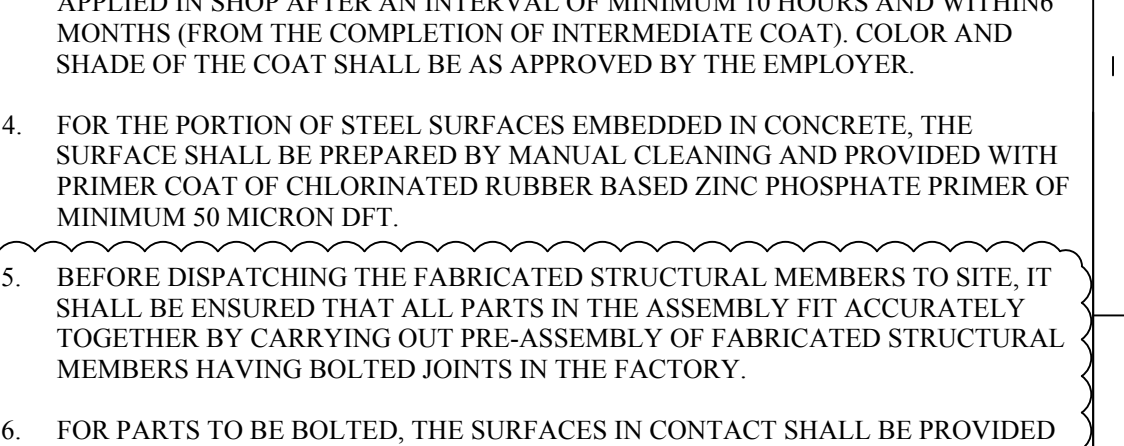

CONCRETE SLAB EDGE WITH GRATING

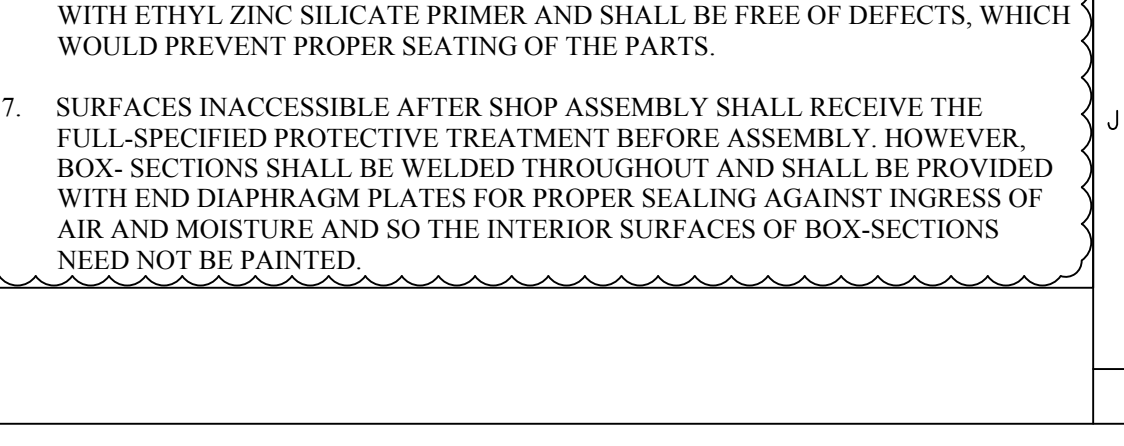

M	SHEL-PROJECT ENGINEERING MANAGEMENT(CIVIL)	NTPC DW
	THIS DRAWING MARKED () IS RELEASED FOR ✓	

☒ COMMENTS/APPROVAL ☐ PLANNING/INFORMATION ☐ CUSTOMER

NTPC DWG. NO: 9585-001-315-PVC-C-0089A

एन टी पी सी
NTPC LIMITED

3X800 MW PATRATU SUPER THERMAL POWER PLANT

MINISTRY OF ENERGY AND POWER
PROJECT ENGINEERING MANAGEMENT

COPY RIGHT AND CONFIDENTIAL The information on this document is the property of	DEPT		NAME	SIGN	DATE
	CODE	DRN	G.K.SINGH	-sd-	04.04.18

			APPD	A.K.SINGH	-sd-	04.04.18
TITLE	GENERAL NOTES AND STANDARD DETAILS					

MPL	C&I	MSE	MAUX	ELEC.	CIVIL	DEPT.	SCALE 1:100	DRAWING No.
-----	-----	-----	------	-------	-------	-------	-------------	-------------

						DATE		SHEET 1 OF 1	REV R1	SIZE-A
--	--	--	--	--	--	------	---	--------------	--------	--------