


19-09511AS

AB/25 506

415 V, 3 PHASE, 4 WIRE BUS

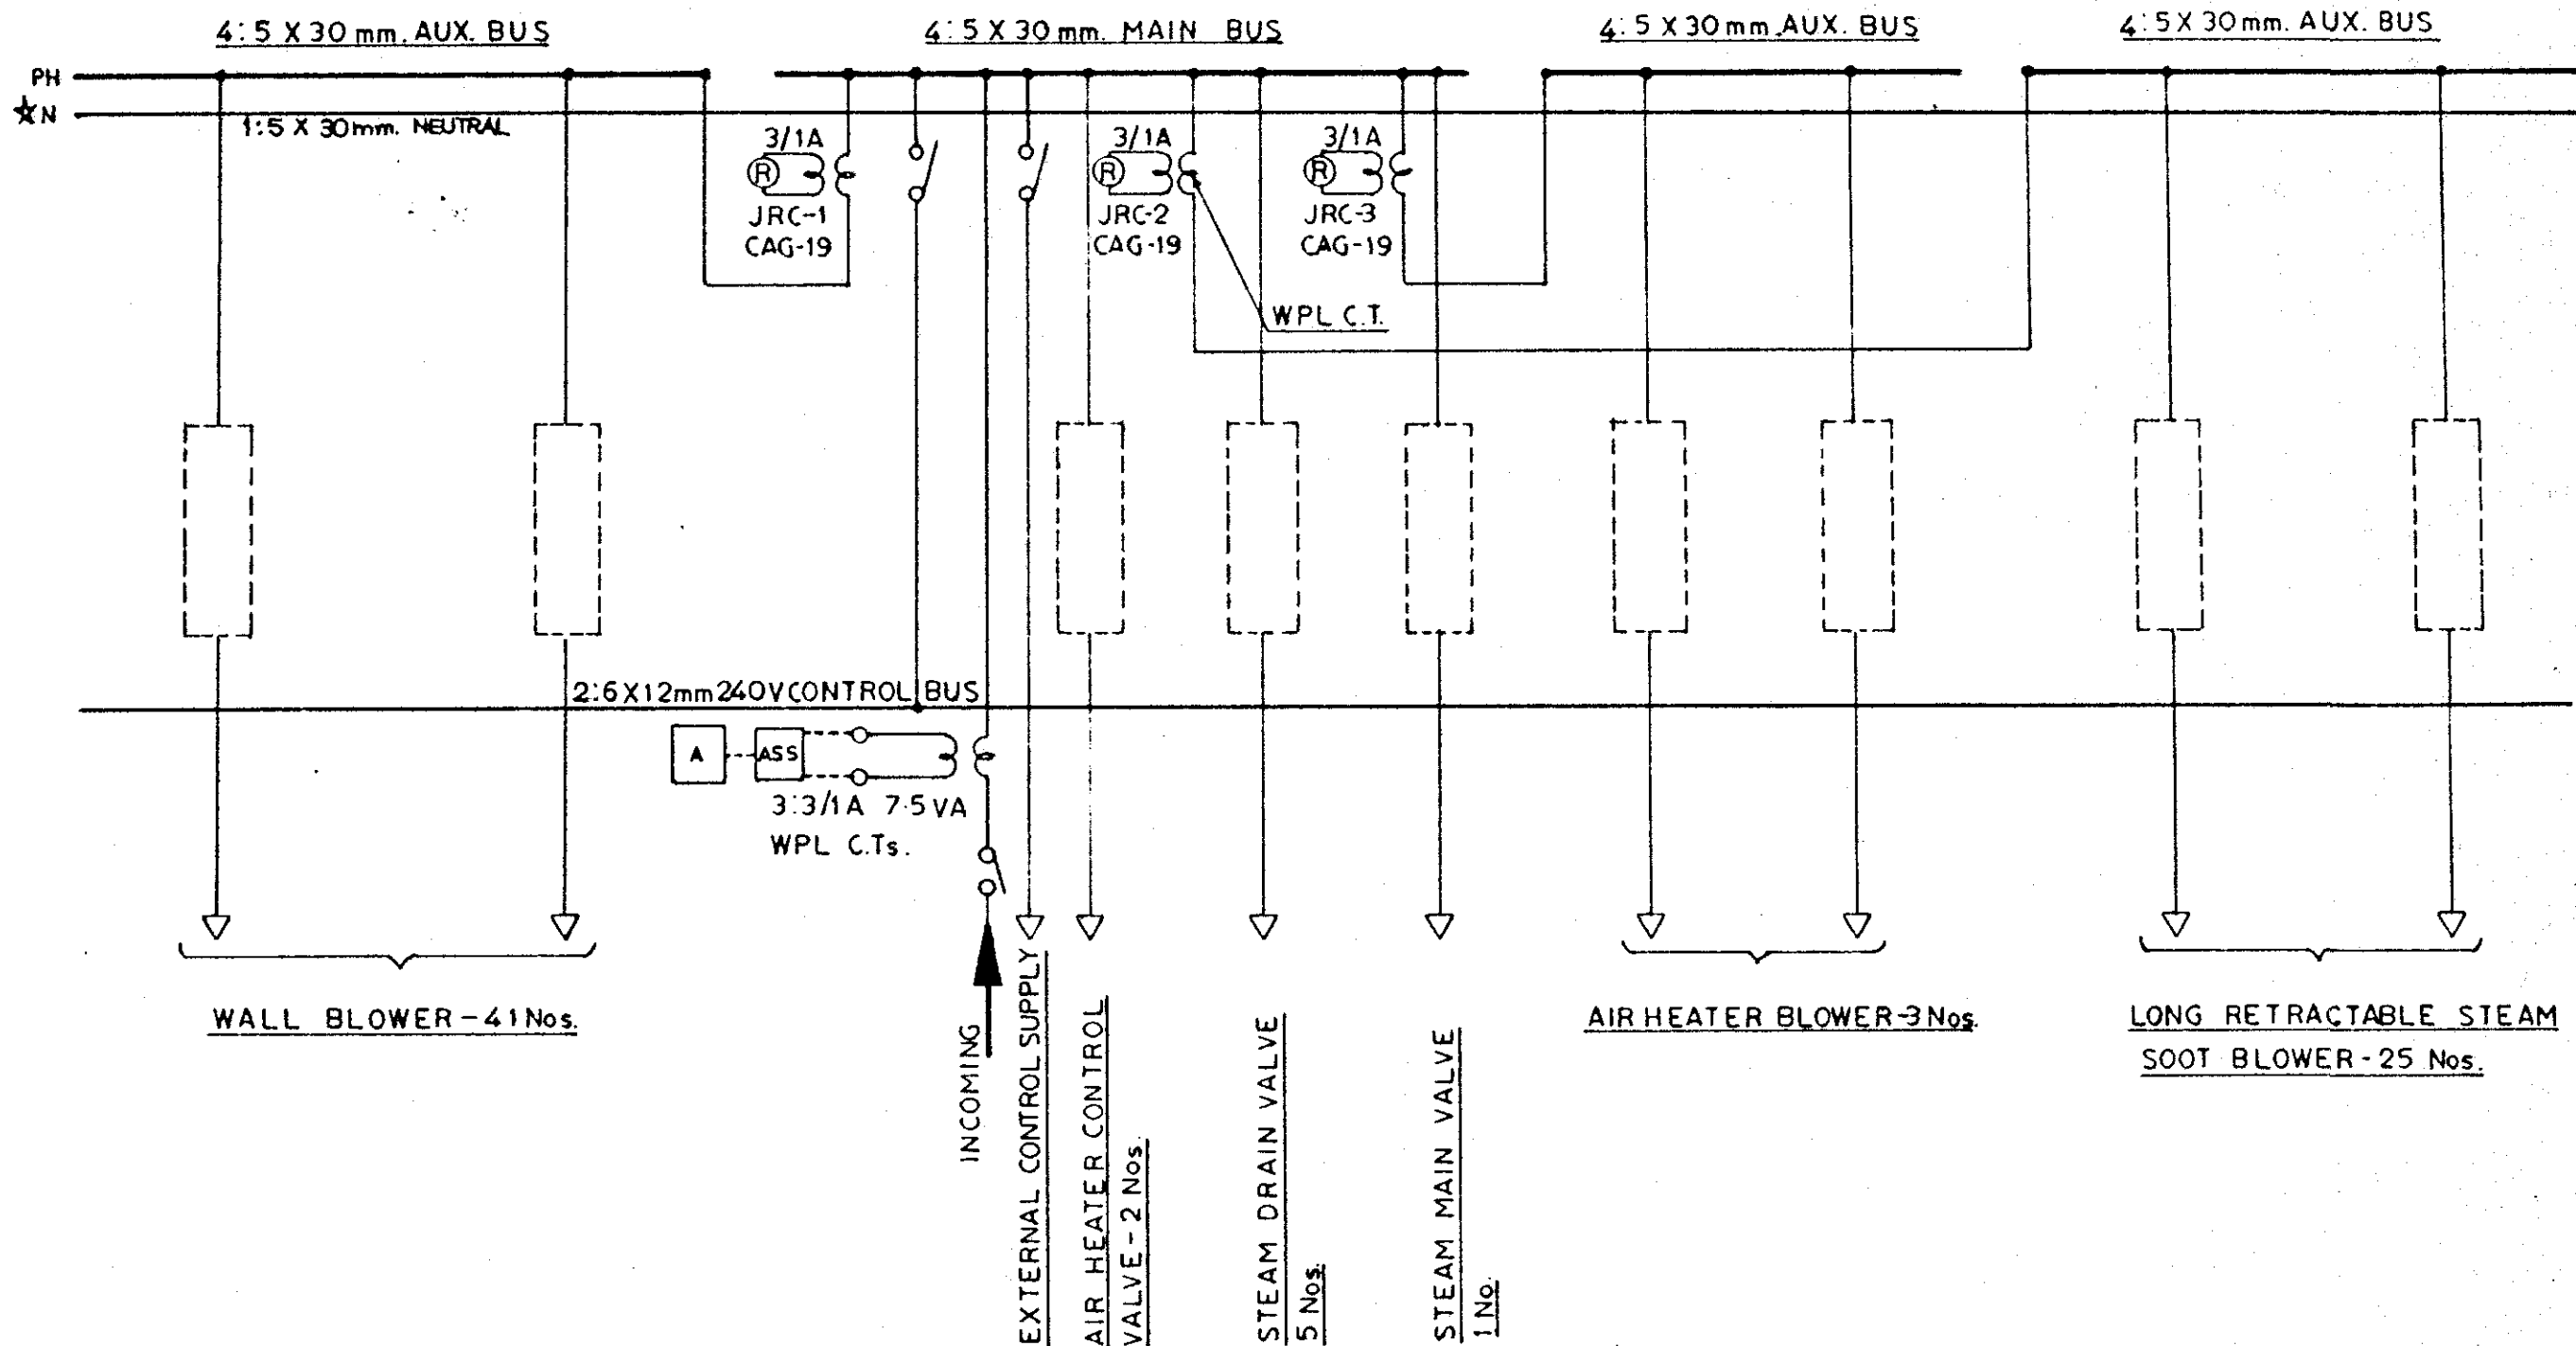

WALL BLOWER - 41 Nos.

AIR HEATER BLOWER - 3 Nos.

LONG RETRACTABLE STEAM  
SOOT BLOWER - 25 Nos.

INCOMING

EXTERNAL CONTROL SUPPLY

AIR HEATER CONTROL  
VALVE - 2 Nos.

STEAM DRAIN VALVE  
5 Nos.

STEAM MAIN VALVE  
1 No.

★: NEUTRAL WILL BE CONTINUOUS.

SINGLE LINE DIAGRAM

MICROFILMED ON  
ROLL 0004871 FRAME 1183

BHEL DRG. NO 3-95-822-01446

THIS DRAWING AND DESIGN IS THE PROPERTY OF  
LARSEN & TOUBRO LIMITED  
AND MUST NOT BE COPIED OR LENT WITHOUT  
THEIR PERMISSION IN WRITING

1	DRN. BY:	DRN. BY: 30/11/78	PWO. No: 36/6121
	CHD. BY:	CHD. BY: 21-21	DEPT: 21-21
	APPRD BY:	APPRD BY: 27-11-78	SCALE: --
	REV. DATE:	DATE: 27-11-78	

LARSEN & TOUBRO LIMITED, ENGINEERS BOMBAY.

SOOT BLOWER M.C.C.

SY11560-61 3

SHEET 3 OF 9

REV.

SPE: F0251:PSW