

FORMAT NO. : SG 07 3 04 R0

ALL DIMENSIONS ARE IN MM & WEIGHTS ARE IN kg PER UNIT
UNLESS OTHER WISE, SPECIFIED.

ALL INFORMATION CONTAINED IN THIS DOCUMENT IS CONFIDENTIAL AND THE PROPERTY OF
TOSHIBA TRANSMISSION & DISTRIBUTION SYSTEMS (INDIA) PRIVATE LIMITED. REPRODUCTION
OF THIS IN ANY FORM IS TO BE DONE WITH THE SPECIFIC PERMISSION OF THE ORGANISATION.

A
B
C
D
E
F
G
H
J

COVER SHEET

CHECKED
A.G.M (Elect)
ENGG. & QUALITY
OPTCL, BHUBANESWAR

APPROVED
Sr. G.M. (Elect)
ENGG. & QUALITY
OPTCL, BHUBANESWAR

02	AS PER CUST.COMMENT	23.05.2024	△	SIGN NAME				
01	AS PER CUST.COMMENT	18.05.2024	△	SIGN NAME				
00	FIRST ISSUE	06.02.2024	△	SIGN NAME				
REV	DETAILS OF MODIFICATION	DATE	REV.MARK		MODIFIED	CHECKED	APPROVED	

TOSHIBA
TRANSMISSION & DISTRIBUTION SYSTEMS (INDIA) PRIVATE LIMITED
SWITCHGEAR PRODUCTS DIVISION

CLIENT : ODISHA POWER TRANSMISSION CO.LTD.
PROJECT : 400/220kV GIS S.S AT ERSAMA, ODISHA & 400kV AIS FEEDER BAY EXTENSION AT DUBURI, ODISHA
CUSTOMER DRAWING NO. : TB-420-516-071-10A

PAGE DESCRIPTION : COVER SHEET


BAY NAME : GA, INTERNAL ARRANGEMENT & SCHEMATICS OF LCP FOR 220KV BUS COUPLER & 220KV BUS PT-(D04&D05)	APPROVED K.IKEDA K.I 02.02.2024	SCALE : NTS
DRAWING NO. : DEEUGBI69513004	CHECKED M.SREEDHAR M.S 02.02.2024	REV : 02
	DRAWN K.MAHESH K.M 01.02.2024	PAGE 1
	DESIGN SRIDEVI.Y S.Y 11.01.2024	117 PAGES
	NAME SIGN DATE	

ALL INFORMATION CONTAINED IN THIS DOCUMENT IS CONFIDENTIAL AND THE PROPERTY OF
TOSHIBA TRANSMISSION & DISTRIBUTION SYSTEMS (INDIA) PRIVATE LIMITED. REPRODUCTION
UNLESS OTHERWISE SPECIFIED.

1. INTERNAL WIRE SIZE & COLORING

S.NO.	KIND OF CIRCUIT	WIRE TYPE	WIRE SIZE (MIN)	COLORING
1	GCB MOTOR & CONTROL CKT	PVC INSULATED FRLS	2.5 SQ.MM	GREY
2	DS/ES MOTOR CKT	PVC INSULATED FRLS	2.5 SQ.MM	
3	ANNUNCIATOR	PVC INSULATED FRLS	2.5 SQ.MM	
4	DC CONTROL CIRCUITS	PVC INSULATED FRLS	2.5 SQ.MM	
5	POWER SUPPLY CKT	PVC INSULATED FRLS	2.5 SQ.MM	
6	AC CONTROL CIRCUITS	PVC INSULATED FRLS	2.5 SQ.MM	BLACK
7	CT SECONDARY	PVC INSULATED FRLS	4 SQ.MM	RED,YELLOW,BLUE FOR PHASES BLACK FOR NEUTRAL
8	VT SECONDARY	PVC INSULATED FRLS	4 SQ.MM	
9	GROUND(EARTH)	PVC INSULATED FRLS	4.0 SQ.MM	GREEN/YELLOW

2. WIRING SYSTEM

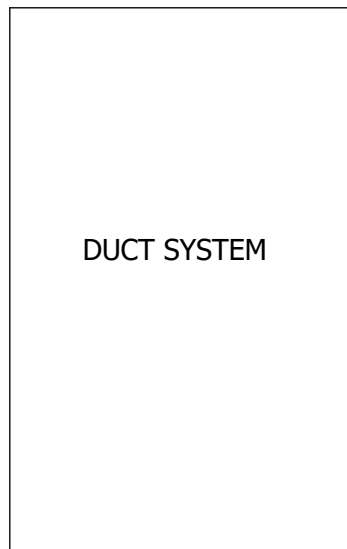


5. IDENTIFICATION OF THE VOLTAGES


INDICATION	DESCRIPTION	RATING
P/N	POSITIVE/NEGATIVE POLE	220V DC
PH /NH	AC VOLTAGE PHASE	230V AC
PT1/NT1	CIRCUIT BREAKER TRIP CIRCUIT -1	220V DC
PT2/NT2	CIRCUIT BREAKER TRIP CIRCUIT -2	220V DC
PC1/NC1	CIRCUIT BREAKER CONTROL CIRCUIT	220V DC
PM0/NM0	CIRCUIT BREAKER MOTOR CIRCUIT	220V DC
PM1/NM1	DS/ES/HES MOTOR CIRCUIT	220V DC
PC2/NC2	DS/ES/HES STATUS MOINITORING & INTERLOCKING CIRCUIT	220V DC
PA1/NA1	INDICATION, GAS MONITORING & ANNUNCIATION CIRCUIT	220V DC
PPS/NPS	GAS PRESSURE SENSOR MONITORING CIRCUIT	220V DC

6. DETAIL OF WIRING


(1) INSULATED RING TYPE COMPRESSED TERMINAL CABLE/WIRE LUG(CT, VT, EARTHING)

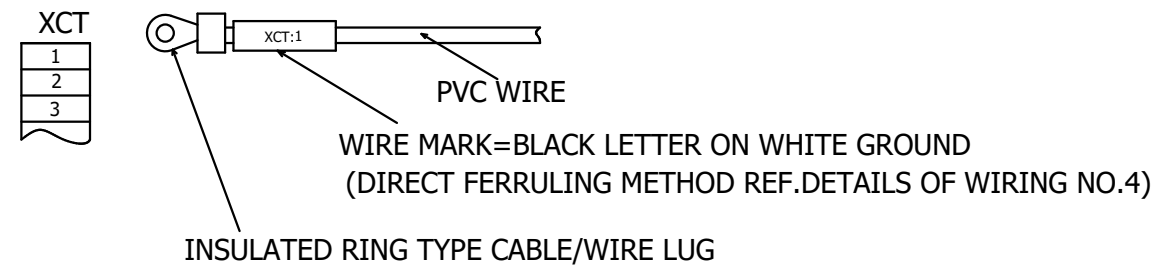


(2) INSULATED PIN TYPE COMPRESSED TERMINAL CABLE/WIRE LUG (CONTACTOR, MCB, TERMINAL BLOCKS & ANNUNCIATOR)

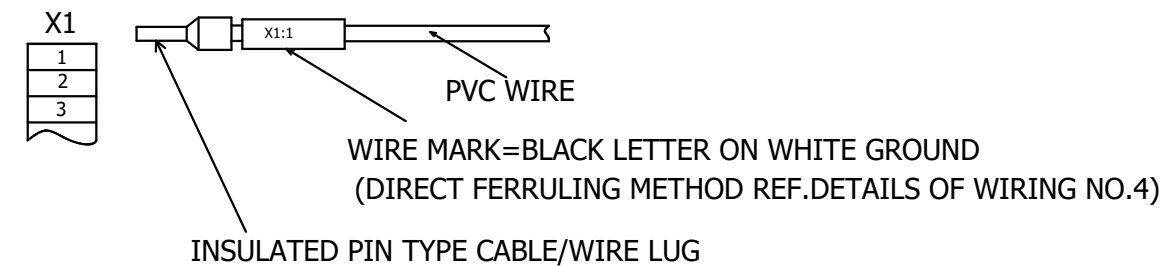


(3)INSULATED FASTON TYPE COMPRESSED TERMINALCABLE/WIRE LUG (AUXILIARY RELAY BOX ETC. WIRING)

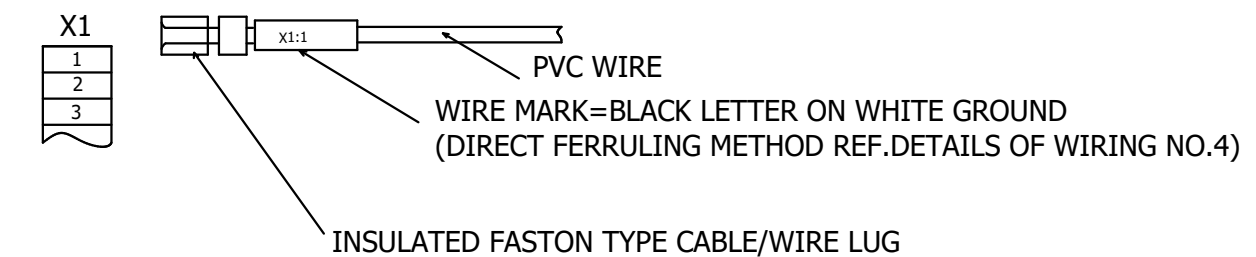

(4)INSULATED FORK TYPE TERMINAL CABLE/WIRE LUG (OMRON RELAY WIRING)

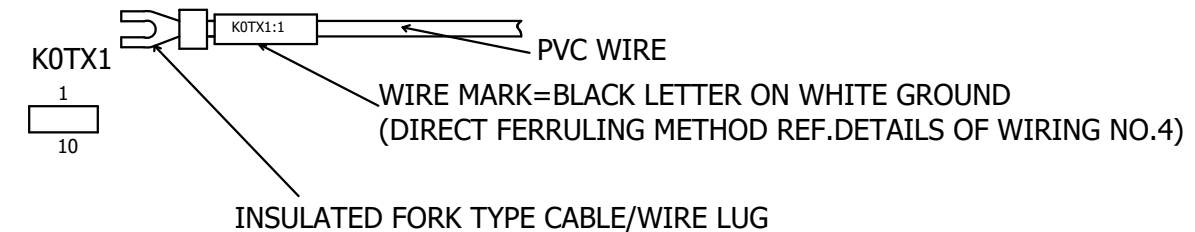

(5) INSERTION OF WIRE MARK (EX. COMPRESSED TERMINAL)

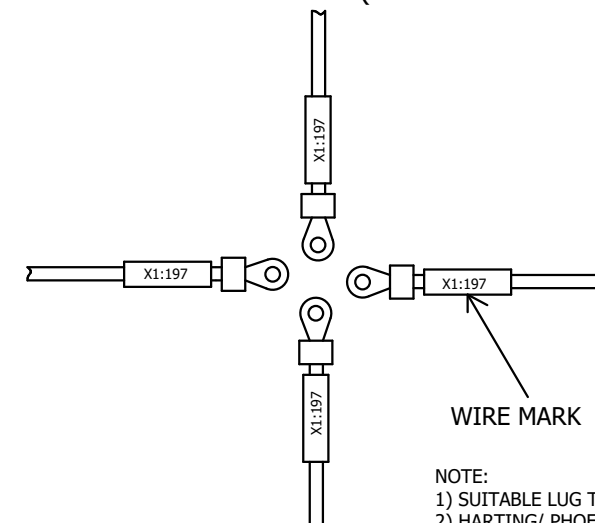

NOTE:

NOTE:

- 1) SUITABLE LUG TO BE USED FOR OTHER COMPONENTS LIKE BCU, PM, AUXILIARY RELAY BOX, ETC.,
- 2) HARTING/ PHOENIX TO BE PROVIDED SINGLE ENTRY OF CABLE.
- 3) DO NOT USE HEAT SHRINKABLE LUGS



CHECKED

 A.G.M. (Elect)
ENGG. & QUALITY
OPTCL, BHUBANESWAR

APPROVED

 Sr. G.M. (Elect)
ENGG. & QUALITY
OPTCL, BHUBANESWAR

02	AS PER CUST.COMMENT	23.05.2024	△	SIGN NAME					TOSHIBA TRANSMISSION & DISTRIBUTION SYSTEMS (INDIA) PRIVATE LIMITED	CLIENT : ODISHA POWER TRANSMISSION CO.LTD. PROJECT : 400/220kV GIS S.S AT ERSAMA, ODISHA & 400kV AIS FEEDER BAY EXTENSION AT DUBURI, ODISHA CUSTOMER DRAWING NO. : TB-420-516-071-10A	PAGE DESCRIPTION : GENERAL SPECIFICATION	BAY NAME : GA, INTERNAL ARRANGEMENT & SCHEMATICS OF LCP FOR 220KV BUS COUPLER & 220KV BUS PT-(D04&D05)	APPROVED	K.IKEDA	K.I	02.02.2024	SCALE : NTS
01	AS PER CUST.COMMENT	18.05.2024	△	SIGN NAME									CHECKED	M.SREEDHAR	M.S	02.02.2024	REV : 02
00	FIRST ISSUE	06.02.2024	△	SIGN NAME									DRAWN	K.MAHESH	K.M	01.02.2024	
REV	DETAILS OF MODIFICATION	DATE	REV.MARK	NAME	MODIFIED	CHECKED	APPROVED	SWITCHGEAR PRODUCTS DIVISION					DESIGN	SRIDEVI.Y	S.Y	11.01.2024	PAGE 3
														NAME	SIGN	DATE	117 PAGES


ALL DIMENSIONS ARE IN MM & WEIGHTS ARE IN kg PER UNIT
UNLESS OTHER WISE, SPECIFIED.

ALL INFORMATION CONTAINED IN THIS DOCUMENT IS CONFIDENTIAL AND THE PROPERTY OF
TOSHIBA TRANSMISSION & DISTRIBUTION SYSTEMS (INDIA) PRIVATE LIMITED. REPRODUCTION
OF THIS IN ANY FORM IS TO BE DONE WITH THE SPECIFIC PERMISSION OF THE ORGANISATION.

FORMAT NO. : SG 07 3 04 R0

REFERENCE: -

A	DT	B	C	D	E	F	G	H	J	SYMBOL DESCRIPTION	SYMBOL DESCRIPTION	SYMBOL DESCRIPTION	SYMBOL DESCRIPTION
										MAKE CONTACT	THERMAL OVERLOAD RELAY	CIRCUIT BREAKER	
										BREAK CONTACT	HEATER	DISCONNECTOR SWITCH	
										CHANGE -OVER CONTACT	VOLTAGE TRANSFORMER	CURRENT TRANSFORMER	
										MINIATURE CIRCUIT BREAKER, SINGLE POLE	SWITCH, NO CONTACT, OPERATED BY TURNING SWITCH, NC CONTACT, OPERATED BY TURNING	FLUORESCENT LAMP	
										THERMOSTAT & HUMIDISTAT	PUSHBUTTON, NO CONTACT, OPERATED BY PUSHING PUSHBUTTON, NC CONTACT, OPERATED BY PUSHING	DISCONNECT TERMINAL BLOCK	
										LAMP, INDICATOR LIGHT	PUSHBUTTON, NO CONTACT, OPERATED BY TURNING PUSHBUTTON, NC CONTACT, OPERATED BY TURNING	RETURN ARROW	
										RESISTER	DIODE	NC CONTACT, DOOR SWITCH	
										RECEPTACLE WITH PE, THREE POLE	POWER NO CONTACT OF A CONTACTOR	SWITCH, NO CONTACT, OPERATED BY TURNING , 3 SW.POSITION SWITCH, NC CONTACT, OPERATED BY TURNING , 3 SW.POSITION	
										RECEPTACLE WITH PE, THREE POLE & SWITCH	NO CONTACT LEADING NC CONTACT LATE BREAK	SWITCH, NO CONTACT, OPERATED BY TURNING , 4 SW.POSITION SWITCH, NC CONTACT, OPERATED BY TURNING , 4 SW.POSITION	
A	DT	B	C	D	E	F	G	H	J	TERMINAL BLOCK	SWITCH, CHANGE -OVER CONTACT, OPERATED BY TURNING	AMMETER	OFF DELAY TIMER
										RELAY / CONTACTOR	VOLTMETER	CONDENSER	
										TIMER (ON DELAY TIMER)	WATTMETER	LATCHING RELAY	
										SWITCH, NO CONTACT, OPERATED BY PUSHING SWITCH, NC CONTACT, OPERATED BY PUSHING	BCU - CHANNEL	DISCREPANCY LAMP	
										FEMALE/MALE PIN WITH PLUG	CHANGE -OVER CONTACT, WITH DROP OUT DELAY	CHANGE -OVER CONTACT, WITH PICK-UP DELAY	DISCONNECTOR / EARTHING POSITION INDICATION LIGHT CROSS WITH LED
										NO CONTACT, WITH DELAYED CLOSING NC CONTACT, WITH DELAYED OPENING	LIGHT -EMITTING DIODE (LED), GENERAL	EARTHING	CIRCUIT BREAKER POSITION INDICATION LIGHT CROSS WITH LED
										DIODE TERMINAL BLOCK			
										LIMIT SWITCH, NO CONTACT LIMIT SWITCH, NC CONTACT			
										HORN			
										DC MOTOR	AC MOTOR		

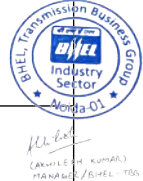

(Signature of Manager)
MANAGER / BHEL - TSS


CHECKED
A.G.M (Elect)
ENGG. & QUALITY
OPTCL, BHUBANESWAR

APPROVED
Sr. G.M. (Elect)
ENGG. & QUALITY
OPTCL, BHUBANESWAR

ALL INFORMATION CONTAINED IN THIS DOCUMENT IS CONFIDENTIAL AND THE PROPERTY OF
TOSHIBA TRANSMISSION & DISTRIBUTION SYSTEMS (INDIA) PRIVATE LIMITED. REPRODUCTION
UNLESS OTHERWISE SPECIFIED.

EXPLANATION OF CONTACTS TABLE


LETTER CODE OF THE DIFFERENT ITEMS

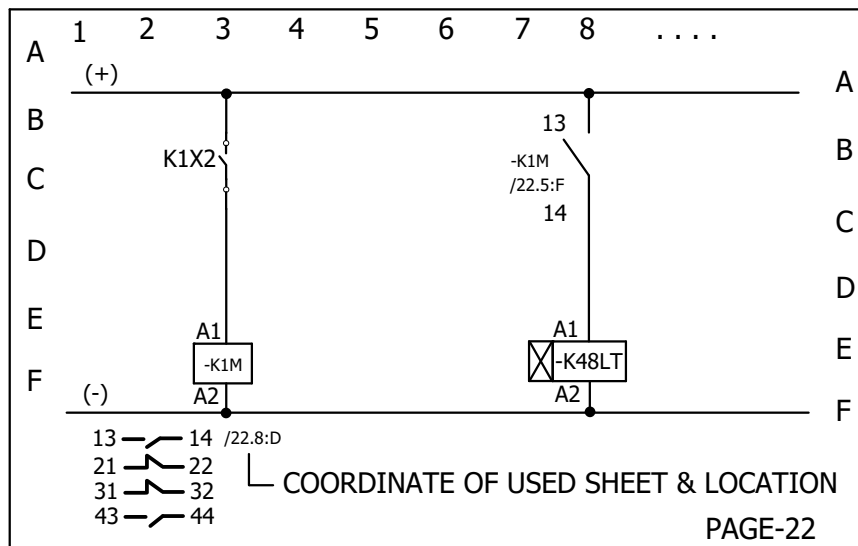


INDICATION	DESCRIPTION
A	ANNUNCIATOR
B	BCU/THERMOSTAT/HUMIDISTAT
E	HEATER/CUBICLE LIGHT/EMER.PUSH BUTTON/RECEIVER
F	PROTECTIVE DEVICES
K	RELAYS, CONTACTORS & TIMERS
P	POWER METER
S	SWITCHES
T	TRANSFORMERS
W	CONTROL CABLES
X	TERMINALS & PLUGS
Q	HIGH VOLTAGE DEVICES
H	INDICATOR

3 POSITION MOMENTARY SWITCH

3 POSITION MOMENTARY SW. FOR H.V
APPARATUS SELECTION SPRING RETURN TO "0" POSITION

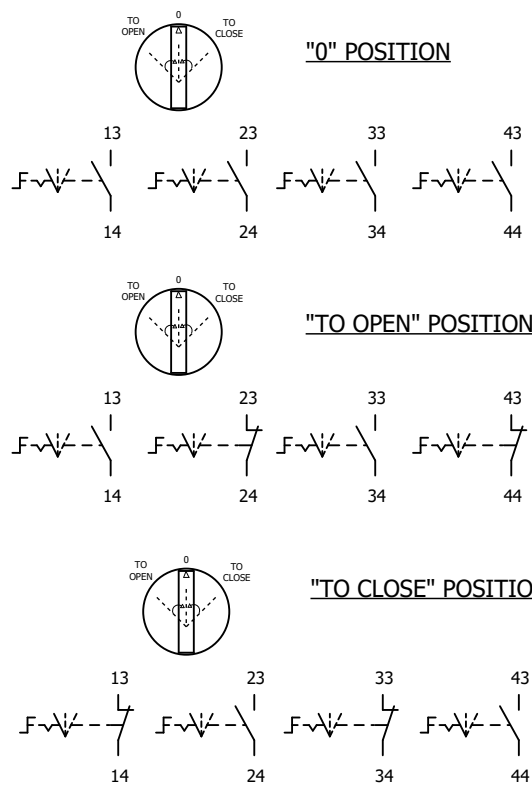

EXPLANATION OF TERMINAL DIAGRAM

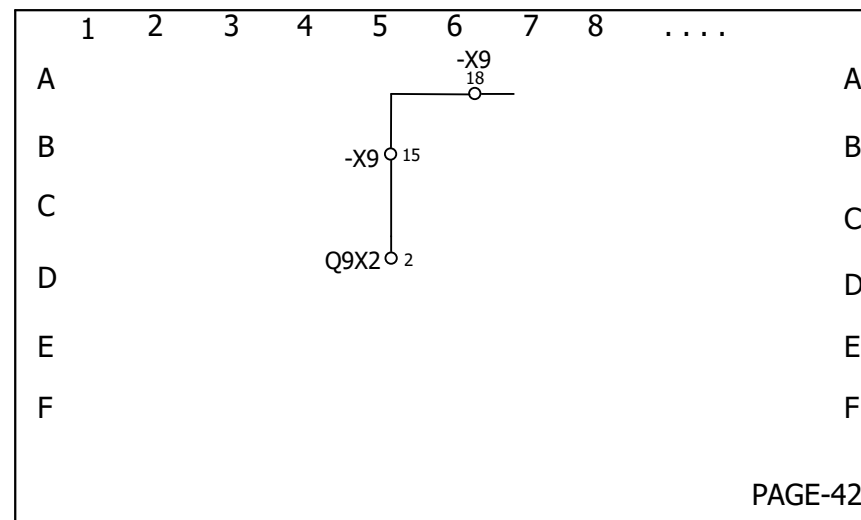

(FROM)
INTERNAL
TARGET

X9 ○ 15

EXTERNAL
TARGET
(TO)

INTERNAL TARGET		X9	EXTERNAL TARGET	
X9-18	42.6:A	15	Q9X1-2	42.5.A



CHECKED

A.G.M (Electrical)
ENGG. & QUALITY
OPTCL, BHUBANESHWAR

APPROVED



Sr. G.M. (Elect)
ENGG. & QUALITY
OPTCL BHUBANESWAR



02	AS PER CUST.COMMENT	23.05.2024	△	SIGN					TOSHIBA TRANSMISSION & DISTRIBUTION SYSTEMS (INDIA) PRIVATE LIMITED SWITCHGEAR PRODUCTS DIVISION	CLIENT : ODISHA POWER TRANSMISSION CO.LTD. PROJECT : 400/220kV GIS S.S AT ERSAMA, ODISHA & 400kV AIS FEEDER BAY EXTENSION AT DUBURI, ODISHA CUSTOMER DRAWING NO. : TB-420-516-071-10A	PAGE DESCRIPTION : SWITCH OPERATION SEQUENCES	BAY NAME : GA, INTERNAL ARRANGEMENT & SCHEMATICS OF LCP FOR 220KV BUS COUPLER & 220KV BUS PT-(D04&D05)	APPROVED	K.IKEDA	K.I	02.02.2024	SCALE : NTS
01	AS PER CUST.COMMENT	18.05.2024	△	NAME									CHECKED	M.SREEDHAR	M.S	02.02.2024	REV : 02
00	FIRST ISSUE	06.02.2024	△	SIGN									DRAWN	K.MAHESH	K.M	01.02.2024	PAGE 5
				NAME									DESIGN	SRIDEVI.Y	S.Y	11.01.2024	
														NAME	SIGN	DATE	117 PAGES
REV	DETAILS OF MODIFICATION	DATE	REV.MARK		MODIFIED	CHECKED	APPROVED					DRAWING NO. : DEEUGBI69513004					

FORMAT NO. : SG 07 3 04 R0

ALL DIMENSIONS ARE IN MM & WEIGHTS ARE IN kg PER UNIT
UNLESS OTHER WISE, SPECIFIED.

REFERENCE: -

ALL INFORMATION CONTAINED IN THIS DOCUMENT IS CONFIDENTIAL AND THE PROPERTY OF
TOSHIBA TRANSMISSION & DISTRIBUTION SYSTEMS (INDIA) PRIVATE LIMITED. REPRODUCTION
OF THIS IN ANY FORM IS TO BE DONE WITH THE SPECIFIC PERMISSION OF THE ORGANISATION.

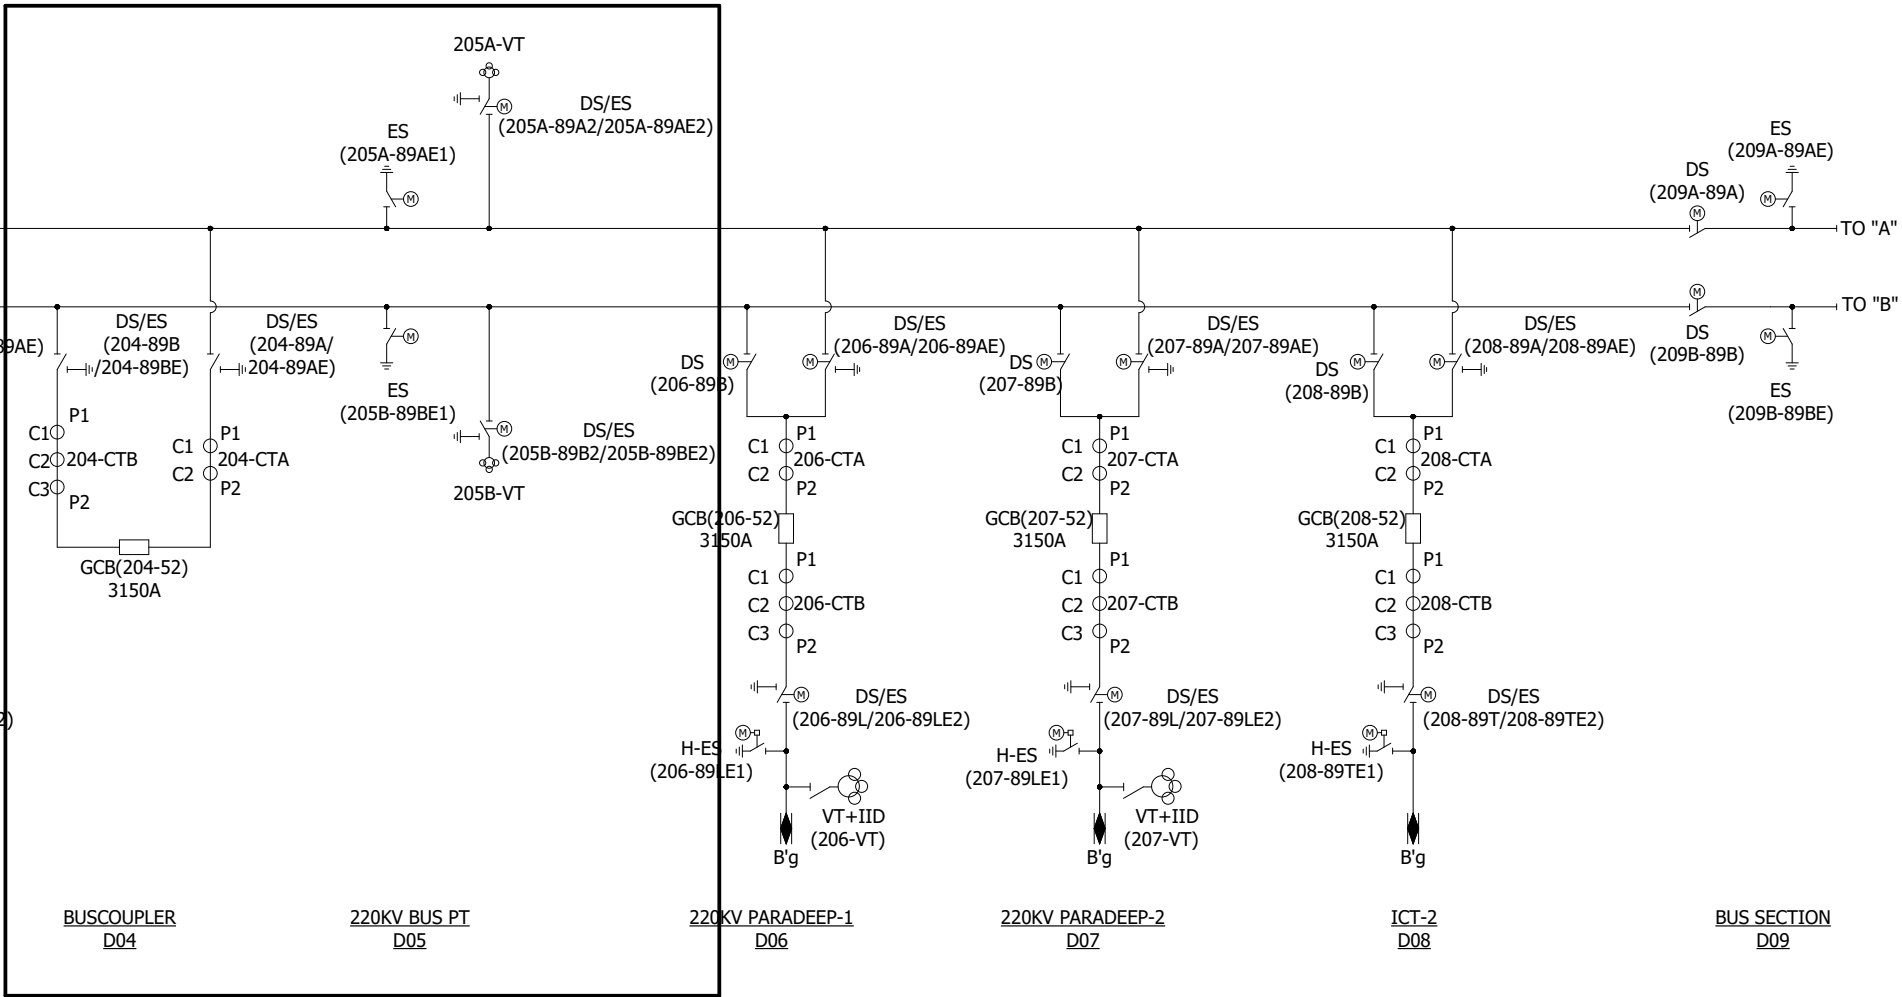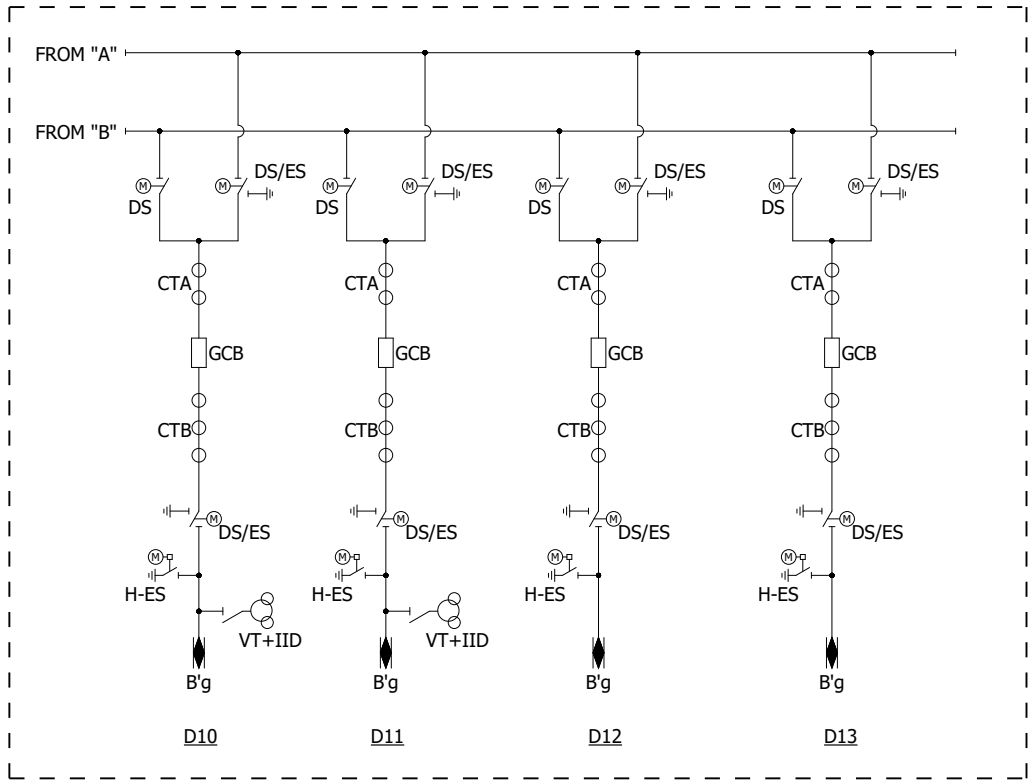

(Signature)
MANAGER/BHEL TSS

CHECKED
A.G.M (Elect)
ENGG. & QUALITY
OPTCL, BHUBANESWAR

APPROVED
Sr. G.M. (Elect)
ENGG. & QUALITY
OPTCL, BHUBANESWAR

02	AS PER CUST.COMMENT	23.05.2024	△	SIGN NAME				
01	AS PER CUST.COMMENT	18.05.2024	△	SIGN NAME				
00	FIRST ISSUE	06.02.2024	△	SIGN NAME				
REV	DETAILS OF MODIFICATION	DATE	REV.MARK	MODIFIED	CHECKED	APPROVED	SWITCHGEAR PRODUCTS DIVISION	

TOSHIBA

TRANSMISSION & DISTRIBUTION SYSTEMS
(INDIA) PRIVATE LIMITED

CLIENT : ODISHA POWER TRANSMISSION CO.LTD.
PROJECT : 400/220kV GIS S.S AT ERSAMA, ODISHA & 400kV
AIS FEEDER BAY EXTENSION AT DUBURI, ODISHA
CUSTOMER DRAWING NO. : TB-420-516-071-10A

PAGE DESCRIPTION :
SINGLE LINE DIAGRAM

BAY NAME : GA, INTERNAL ARRANGEMENT &
SCHEMATICS OF LCP FOR 220KV BUS
COUPLER & 220KV BUS PT-(D04&D05)
DRAWING NO. : DEEUGBI69513004


APPROVED	K.IKEDA	K.I	02.02.2024	SCALE : NTS
CHECKED	M.SREEDHAR	M.S	02.02.2024	REV : 02
DRAWN	K.MAHESH	K.M	01.02.2024	PAGE 6
DESIGN	SRIDEVI.Y	S.Y	11.01.2024	117 PAGES
	NAME	SIGN	DATE	

FORMAT NO. : SG 07 3 04 R0

ALL DIMENSIONS ARE IN MM & WEIGHTS ARE IN kg PER UNIT
UNLESS OTHER WISE, SPECIFIED.

ALL INFORMATION CONTAINED IN THIS DOCUMENT IS CONFIDENTIAL AND THE PROPERTY OF
TOSHIBA TRANSMISSION & DISTRIBUTION SYSTEMS (INDIA) PRIVATE LIMITED. REPRODUCTION
OF THIS IN ANY FORM IS TO BE DONE WITH THE SPECIFIC PERMISSION OF THE ORGANISATION.

A
B
C
D
E
F
G
H
J

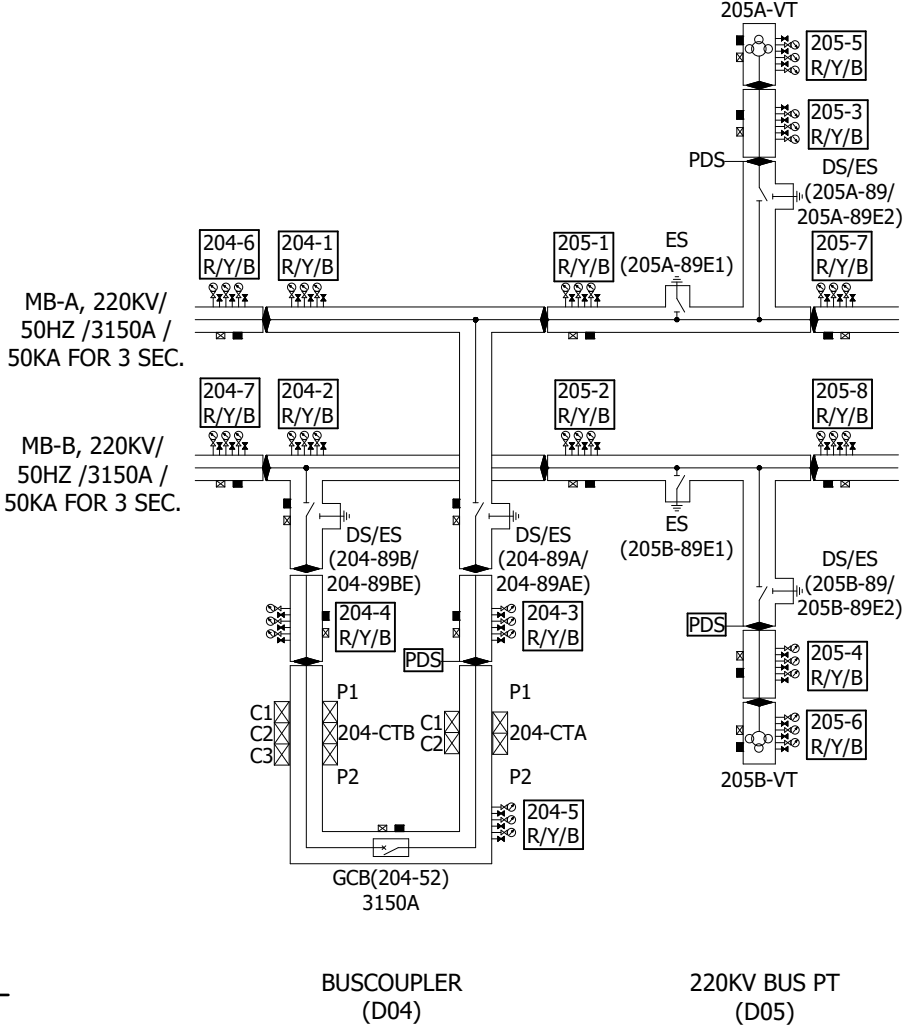

HIGH VOLTAGE DEVICES

TOSHIBA'S NAME	DESIGNATION
GCB (52)	GAS CIRCUIT BREAKER
DS(89A)	MB-A SIDE DISCONNECTOR SWITCH
DS(89B)	MB-B SIDE DISCONNECTOR SWITCH
ES(89AE)	MB-A SIDE EARTHING SWITCH
ES(89BE)	MB-B SIDE EARTHING SWITCH
ES(89AE1)	MB-A SIDE BUS EARTHING SWITCH
ES(89BE1)	MB-B SIDE BUS EARTHING SWITCH
DS(89A2)	MB-A SIDE BUS PT DISCONNECTOR SWITCH
DS(89B2)	MB-B SIDE BUS PT DISCONNECTOR SWITCH
ES(89AE2)	MB-A SIDE BUS PT EARTHING SWITCH
ES(89BE2)	MB-A SIDE BUS PT EARTHING SWITCH
CT	CURRENT TRANSFORMER
204-1R/Y/B	MB-A GAS COMPARTMENT
204-2R/Y/B	MB-B GAS COMPARTMENT
204-3R/Y/B	BUFFER GAS COMPARTMENT
204-4R/Y/B	BUFFER GAS COMPARTMENT
204-5R/Y/B	CIRCUIT BREAKER GAS COMPARTMENT
205-1R/Y/B	MB-A SIDE DS/ES GAS COMPARTMENT
205-2R/Y/B	MB-B SIDE DS/ES GAS COMPARTMENT
205-3R/Y/B	MB-A SIDE VT BUFFER GAS COMPARTMENT
205-4R/Y/B	MB-B SIDE VT BUFFER GAS COMPARTMENT
205-5R/Y/B	MB-A VT GAS COMPARTMENT
205-6R/Y/B	MB-B VT GAS COMPARTMENT
205-7R/Y/B	MB-A RIGHT SIDE GAS COMPARTMENT
205-8R/Y/B	MB-B RIGHT SIDE GAS COMPARTMENT

LEGEND:

SYMBOL/ ABBREVIATION	EQUIPMENT NAME	OPERATION METHOD
GCB	GAS INSULATED CIRCUIT BREAKER	MOTOR CHARGED SPRING OPERATION
DS/ES	DISCONNECTOR WITH EARTHING SWITCH	MOTOR OPERATION
DS	DISCONNECTOR	MOTOR OPERATION
ES	EARTHING SWITCH	MOTOR OPERATION
H-ES	HIGH SPEED EARTHING SWITCH	MOTOR CHARGED SPRING OPERATION
CT	CURRENT TRANSFORMER	
VT+IID	VOLTAGE TRANSFORMER WITH INTEGRATED ISOLATING DEVICE (MANUAL OPERATION)	
VT	VOLTAGE TRANSFORMER	
	DN-8 VALVE FOR GAS DENSITY MONITOR	
	DN-20 VALVE FOR GAS HANDLING	
	GAS TIGHT SPACER	
	RUPTURE DISC	
	ADSORBENT	
MB-A&B	MAIN BUS-A&B	
	PARTIAL DISCHARGE SENSOR	

SETTING VALUE OF GAS MONITOR:

COMPONENT	SETTING VALUE OF PRESSURE SWITCH	RATED PRESSURE (abs)
GCB	FIRST LOW PRESSURE ALARM : 6.70 bar. abs at 20°C SECOND LOW PRESSURE ALARM: 6.40 bar. abs at 20°C (BLOCKING PRESSURE) GUARANTEE LIWL: 1050kVp	7.0 bar at 20°C
OTHERS	FIRST LOW PRESSURE ALARM : 6.70 bar. abs at 20°C SECOND LOW PRESSURE ALARM: 6.40 bar. abs at 20°C GUARANTEE LIWL: 1050kVp	7.0 bar at 20°C



(Signature)
MANAGER/BHEL-150

CHECKED
A.G.M (Elect)
ENGG. & QUALITY
OPTCL, BHUBANESWAR

APPROVED
Sr. G.M. (Elect)
ENGG. & QUALITY
OPTCL, BHUBANESWAR

02	AS PER CUST.COMMENT	23.05.2024	△	SIGN NAME				
01	AS PER CUST.COMMENT	18.05.2024	△	SIGN NAME				
00	FIRST ISSUE	06.02.2024	△	SIGN NAME				
REV	DETAILS OF MODIFICATION	DATE	REV.MARK	MODIFIED	CHECKED	APPROVED		

TOSHIBA
TRANSMISSION & DISTRIBUTION SYSTEMS
(INDIA) PRIVATE LIMITED
SWITCHGEAR PRODUCTS DIVISION

CLIENT : ODISHA POWER TRANSMISSION CO.LTD.
PROJECT : 400/220kV GIS S.S AT ERSAMA, ODISHA & 400kV AIS FEEDER BAY EXTENSION AT DUBURI, ODISHA
CUSTOMER DRAWING NO. : TB-420-516-071-10A

PAGE DESCRIPTION :
GAS COMPARTMENT


BAY NAME : GA, INTERNAL ARRANGEMENT & SCHEMATICS OF LCP FOR 220KV BUS COUPLER & 220KV BUS PT-(D04&D05)	APPROVED	K.IKEDA	K.I	02.02.2024	SCALE : NTS
DRAWING NO. : DEEUGBI69513004	CHECKED	M.SREEDHAR	M.S	02.02.2024	REV : 02
	DRAWN	K.MAHESH	K.M	01.02.2024	
	DESIGN	SRIDEVI.Y	S.Y	11.01.2024	PAGE 7
		NAME	SIGN	DATE	117 PAGES

ALL DIMENSIONS ARE IN MM & WEIGHTS ARE IN kg PER UNIT
UNLESS OTHER WISE, SPECIFIED.

ALL INFORMATION CONTAINED IN THIS DOCUMENT IS CONFIDENTIAL AND THE PROPERTY OF
TOSHIBA TRANSMISSION & DISTRIBUTION SYSTEMS (INDIA) PRIVATE LIMITED. REPRODUCTION
OF THIS IN ANY FORM IS TO BE DONE WITH THE SPECIFIC PERMISSION OF THE ORGANISATION.

FORMAT NO. : SG 07 3 04 R0

REFERENCE: -

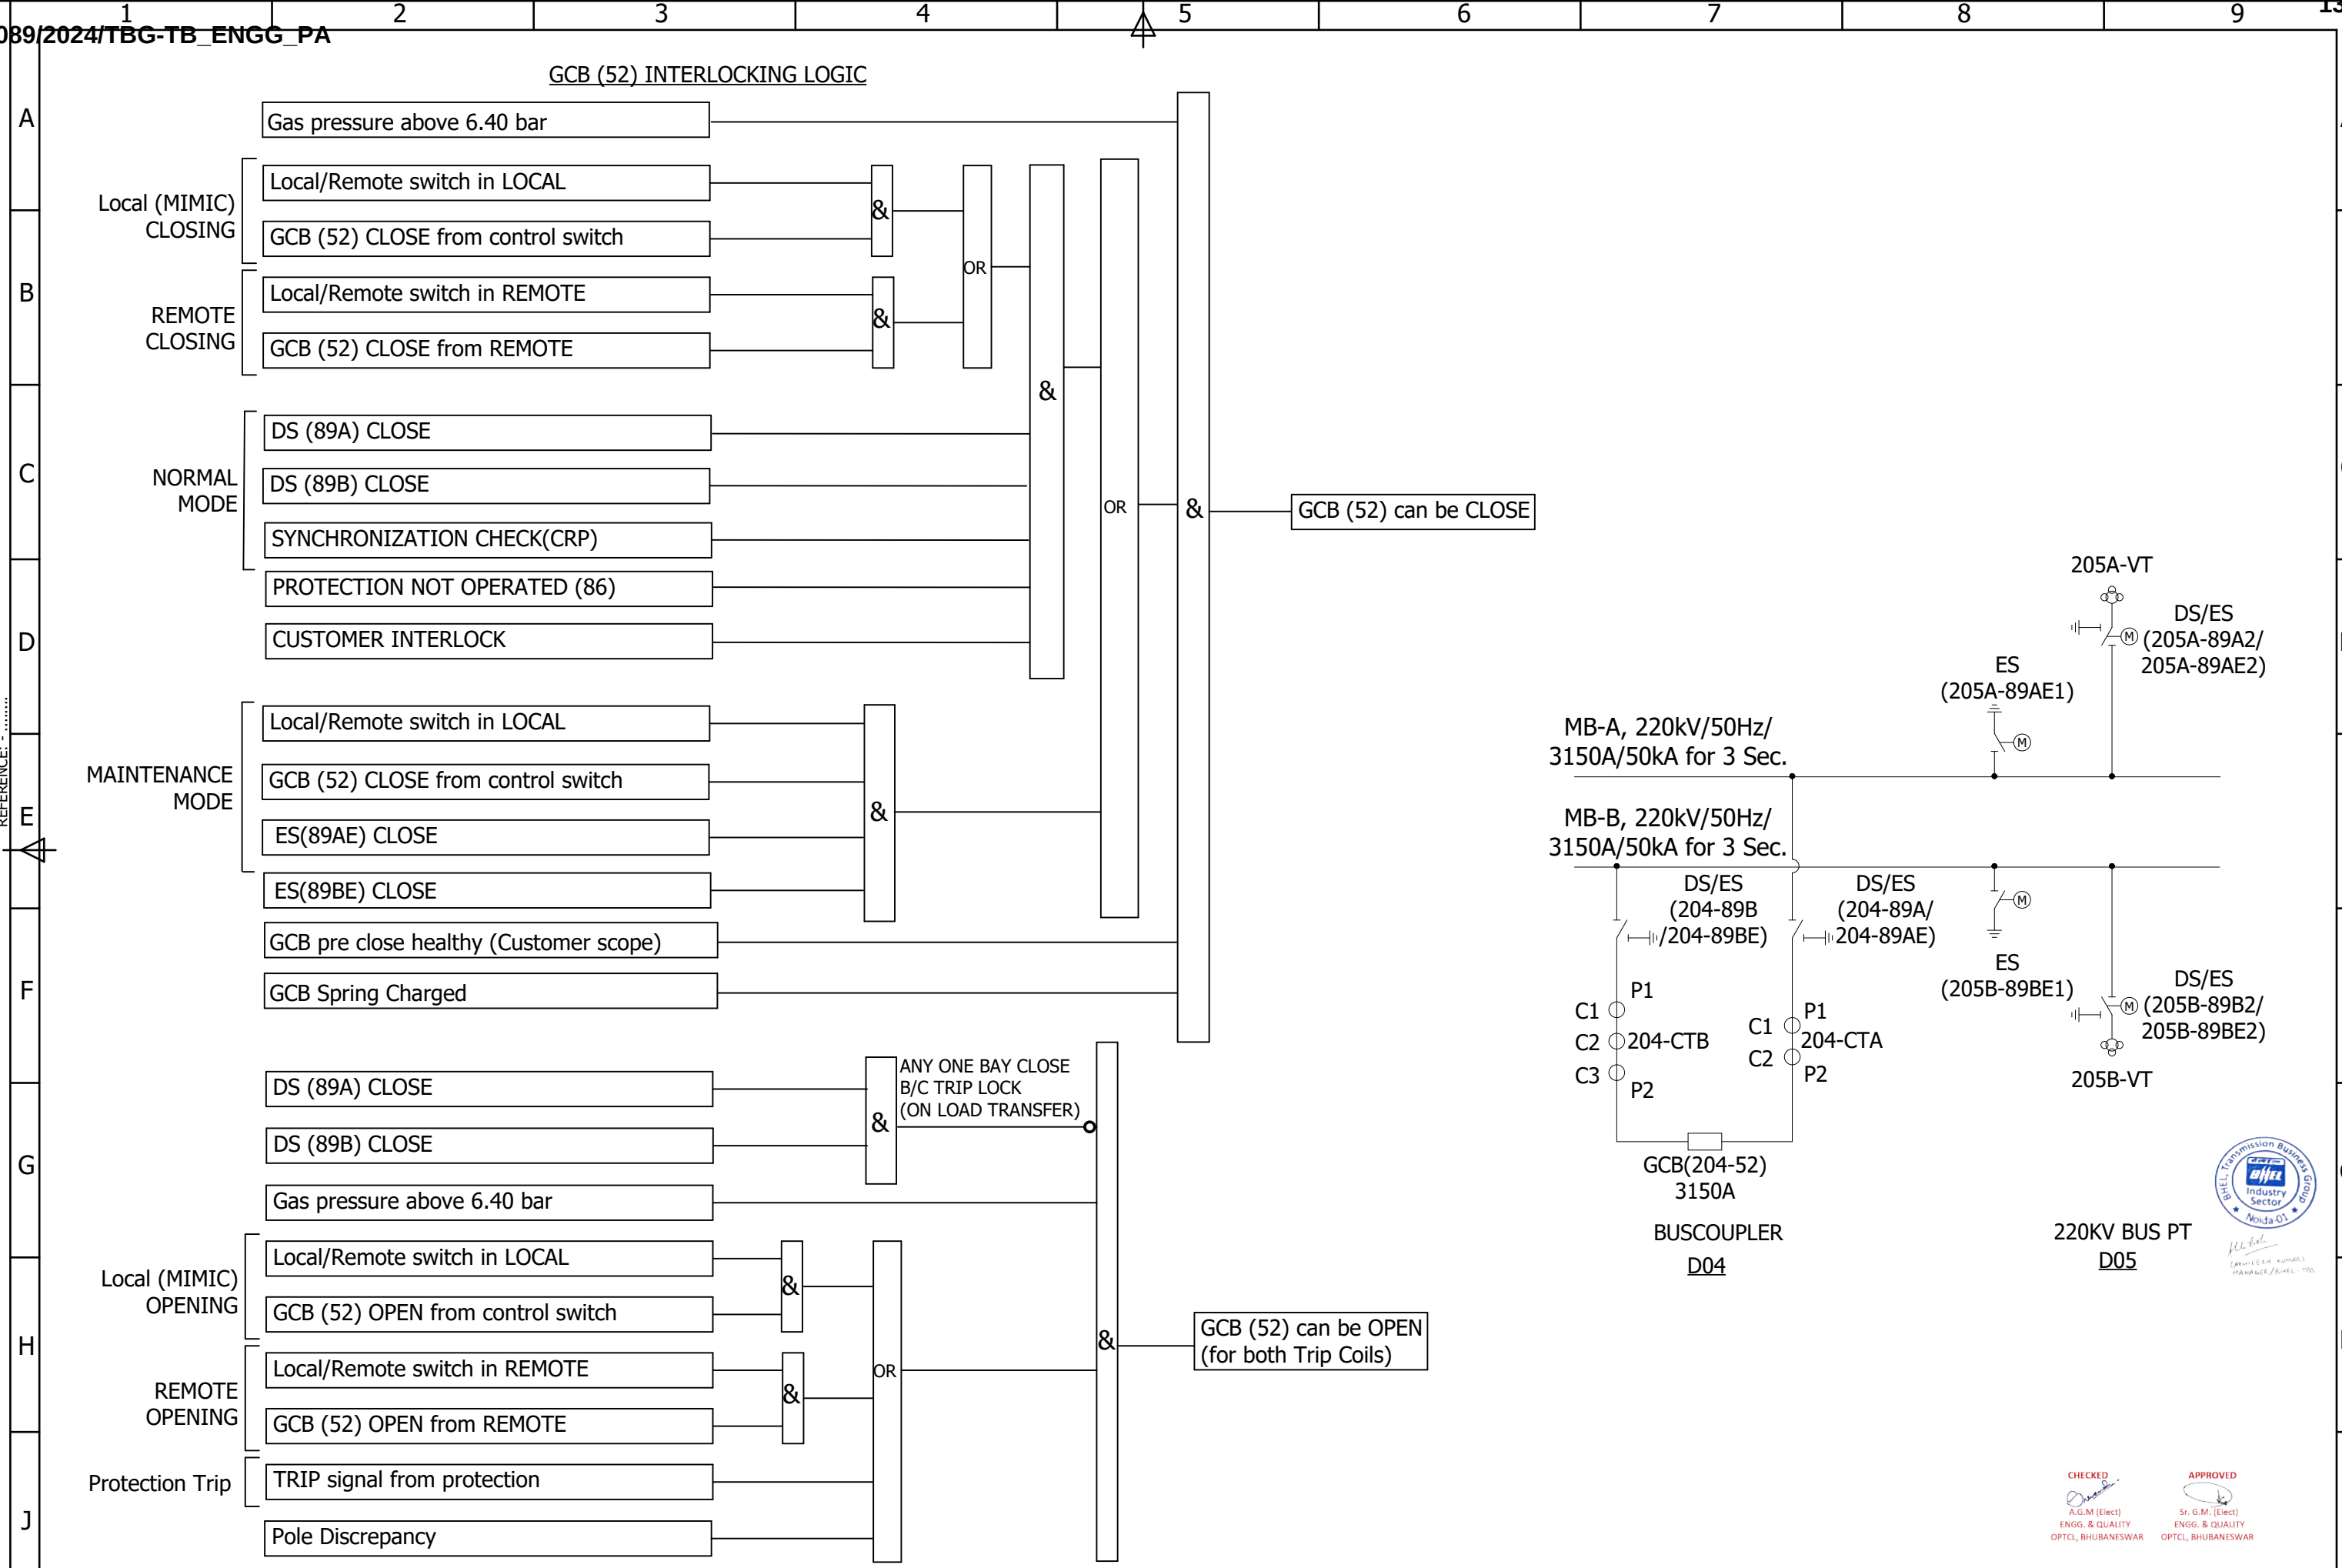

02	AS PER CUST.COMMENT	23.05.2024	△	SIGN NAME				
01	AS PER CUST.COMMENT	18.05.2024	△	SIGN NAME				
00	FIRST ISSUE	06.02.2024	△	SIGN NAME				
REV	DETAILS OF MODIFICATION	DATE	REV.MARK		MODIFIED	CHECKED	APPROVED	

TOSHIBA

TRANSMISSION & DISTRIBUTION SYSTEMS
(INDIA) PRIVATE LIMITED

SWITCHGEAR PRODUCTS DIVISION

CLIENT : ODISHA POWER TRANSMISSION CO.LTD.
PROJECT : 400/220kV GIS S.S AT ERSAMA, ODISHA & 400kV
AIS FEEDER BAY EXTENSION AT DUBURI, ODISHA
CUSTOMER DRAWING NO. : TB-420-516-071-10A

PAGE DESCRIPTION :
INTERLOCKING LOGIC-1

BAY NAME : GA, INTERNAL ARRANGEMENT &
SCHEMATICS OF LCP FOR 220KV BUS
COUPLER & 220KV BUS PT-(D04&D05)
DRAWING NO. : DEEUGBI69513004

APPROVED	K.IKEDA	K.I	02.02.2024	SCALE : NTS
CHECKED	M.SREEDHAR	M.S	02.02.2024	REV : 02
DRAWN	K.MAHESH	K.M	01.02.2024	PAGE 8
DESIGN	SRIDEVI.Y	S.Y	11.01.2024	117 PAGES
	NAME	SIGN	DATE	





CHECKED
A.G.M (Elect)
ENGG. & QUALITY
OPTCL, BHUBANESWAR

APPROVED
Sr. G.M. (Elect)
ENGG. & QUALITY
OPTCL, BHUBANESWAR

ALL DIMENSIONS ARE IN MM & WEIGHTS ARE IN kg PER UNIT
UNLESS OTHER WISE, SPECIFIED.

FORMAT NO. : SG 07 3 04 R0

ALL INFORMATION CONTAINED IN THIS DOCUMENT IS CONFIDENTIAL AND THE PROPERTY OF
TOSHIBA TRANSMISSION & DISTRIBUTION SYSTEMS (INDIA) PRIVATE LIMITED. REPRODUCTION
OF THIS IN ANY FORM IS TO BE DONE WITH THE SPECIFIC PERMISSION OF THE ORGANISATION.

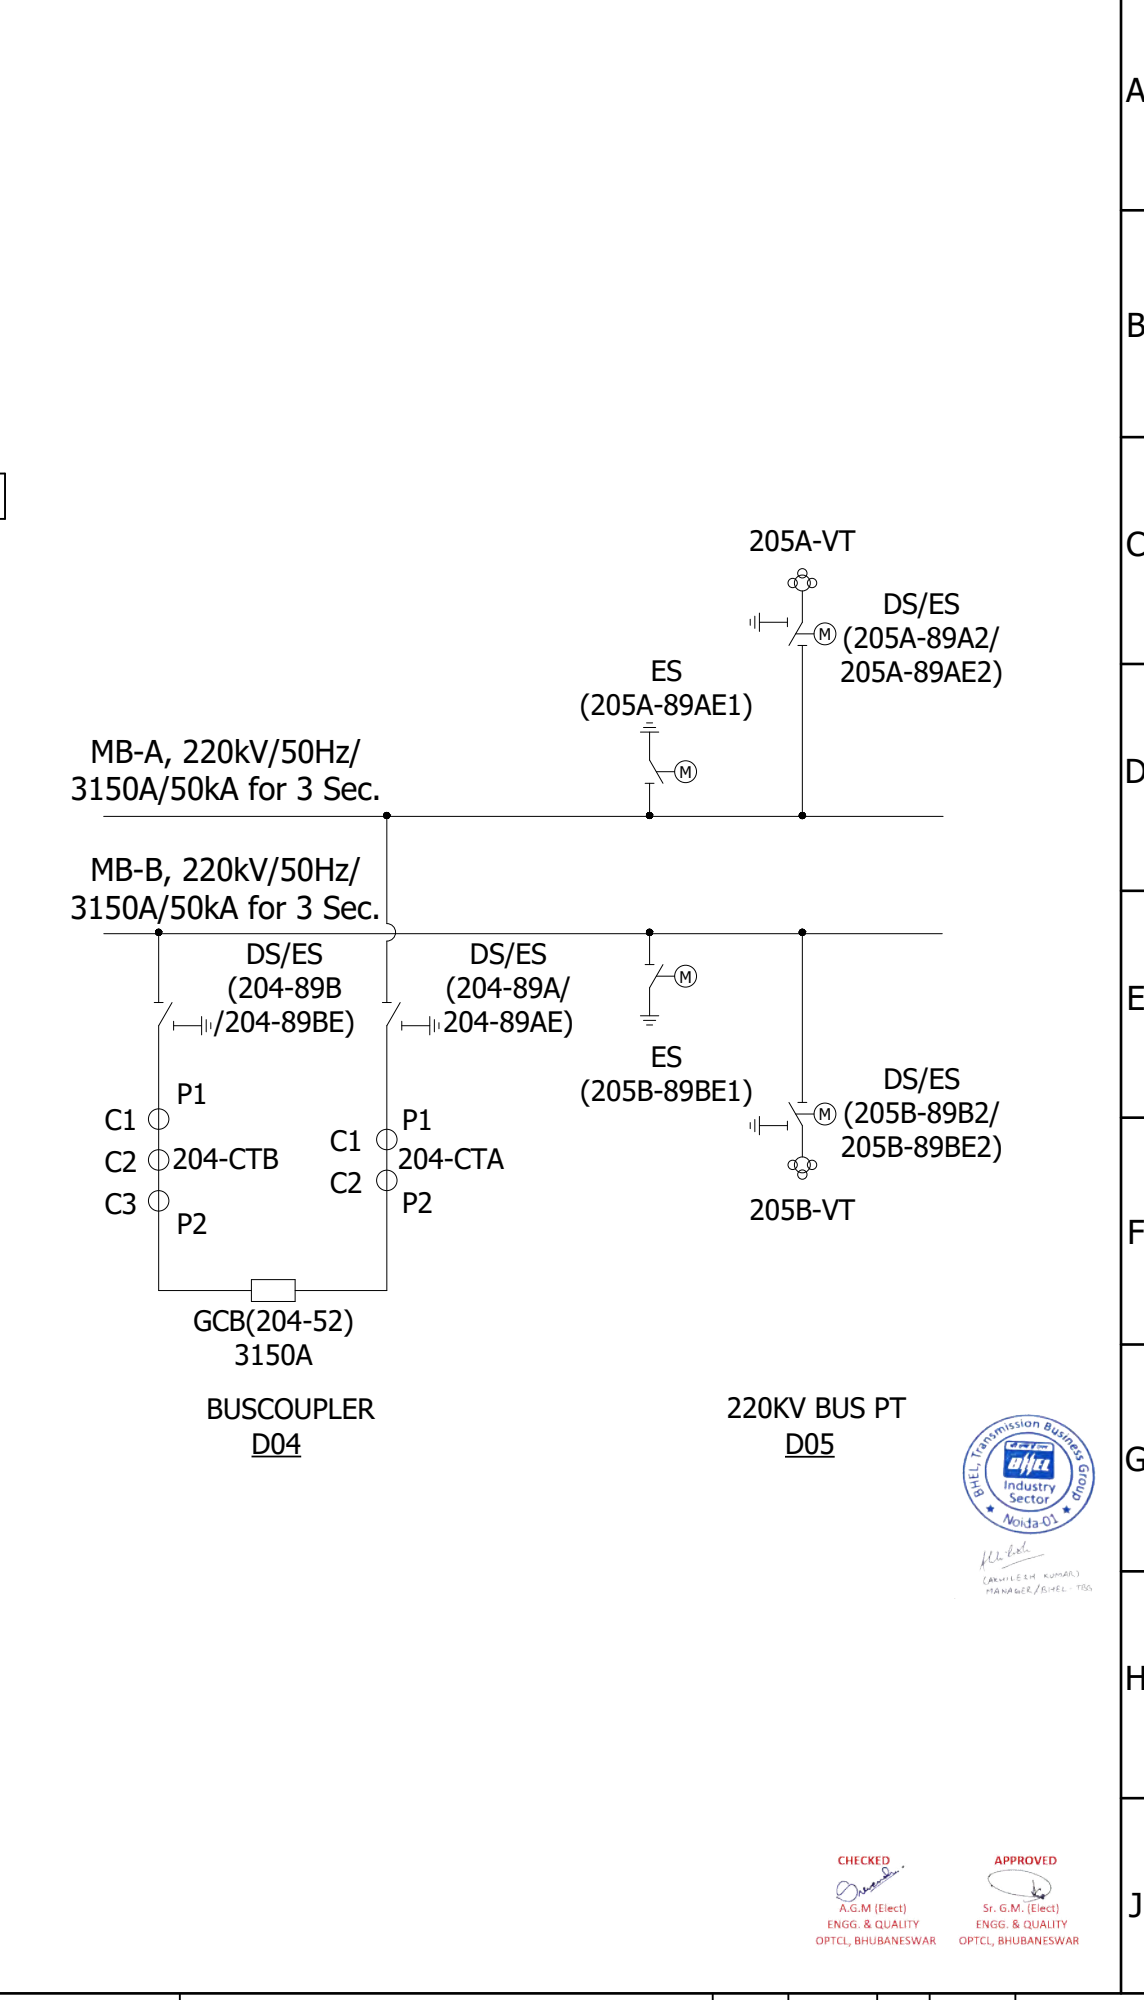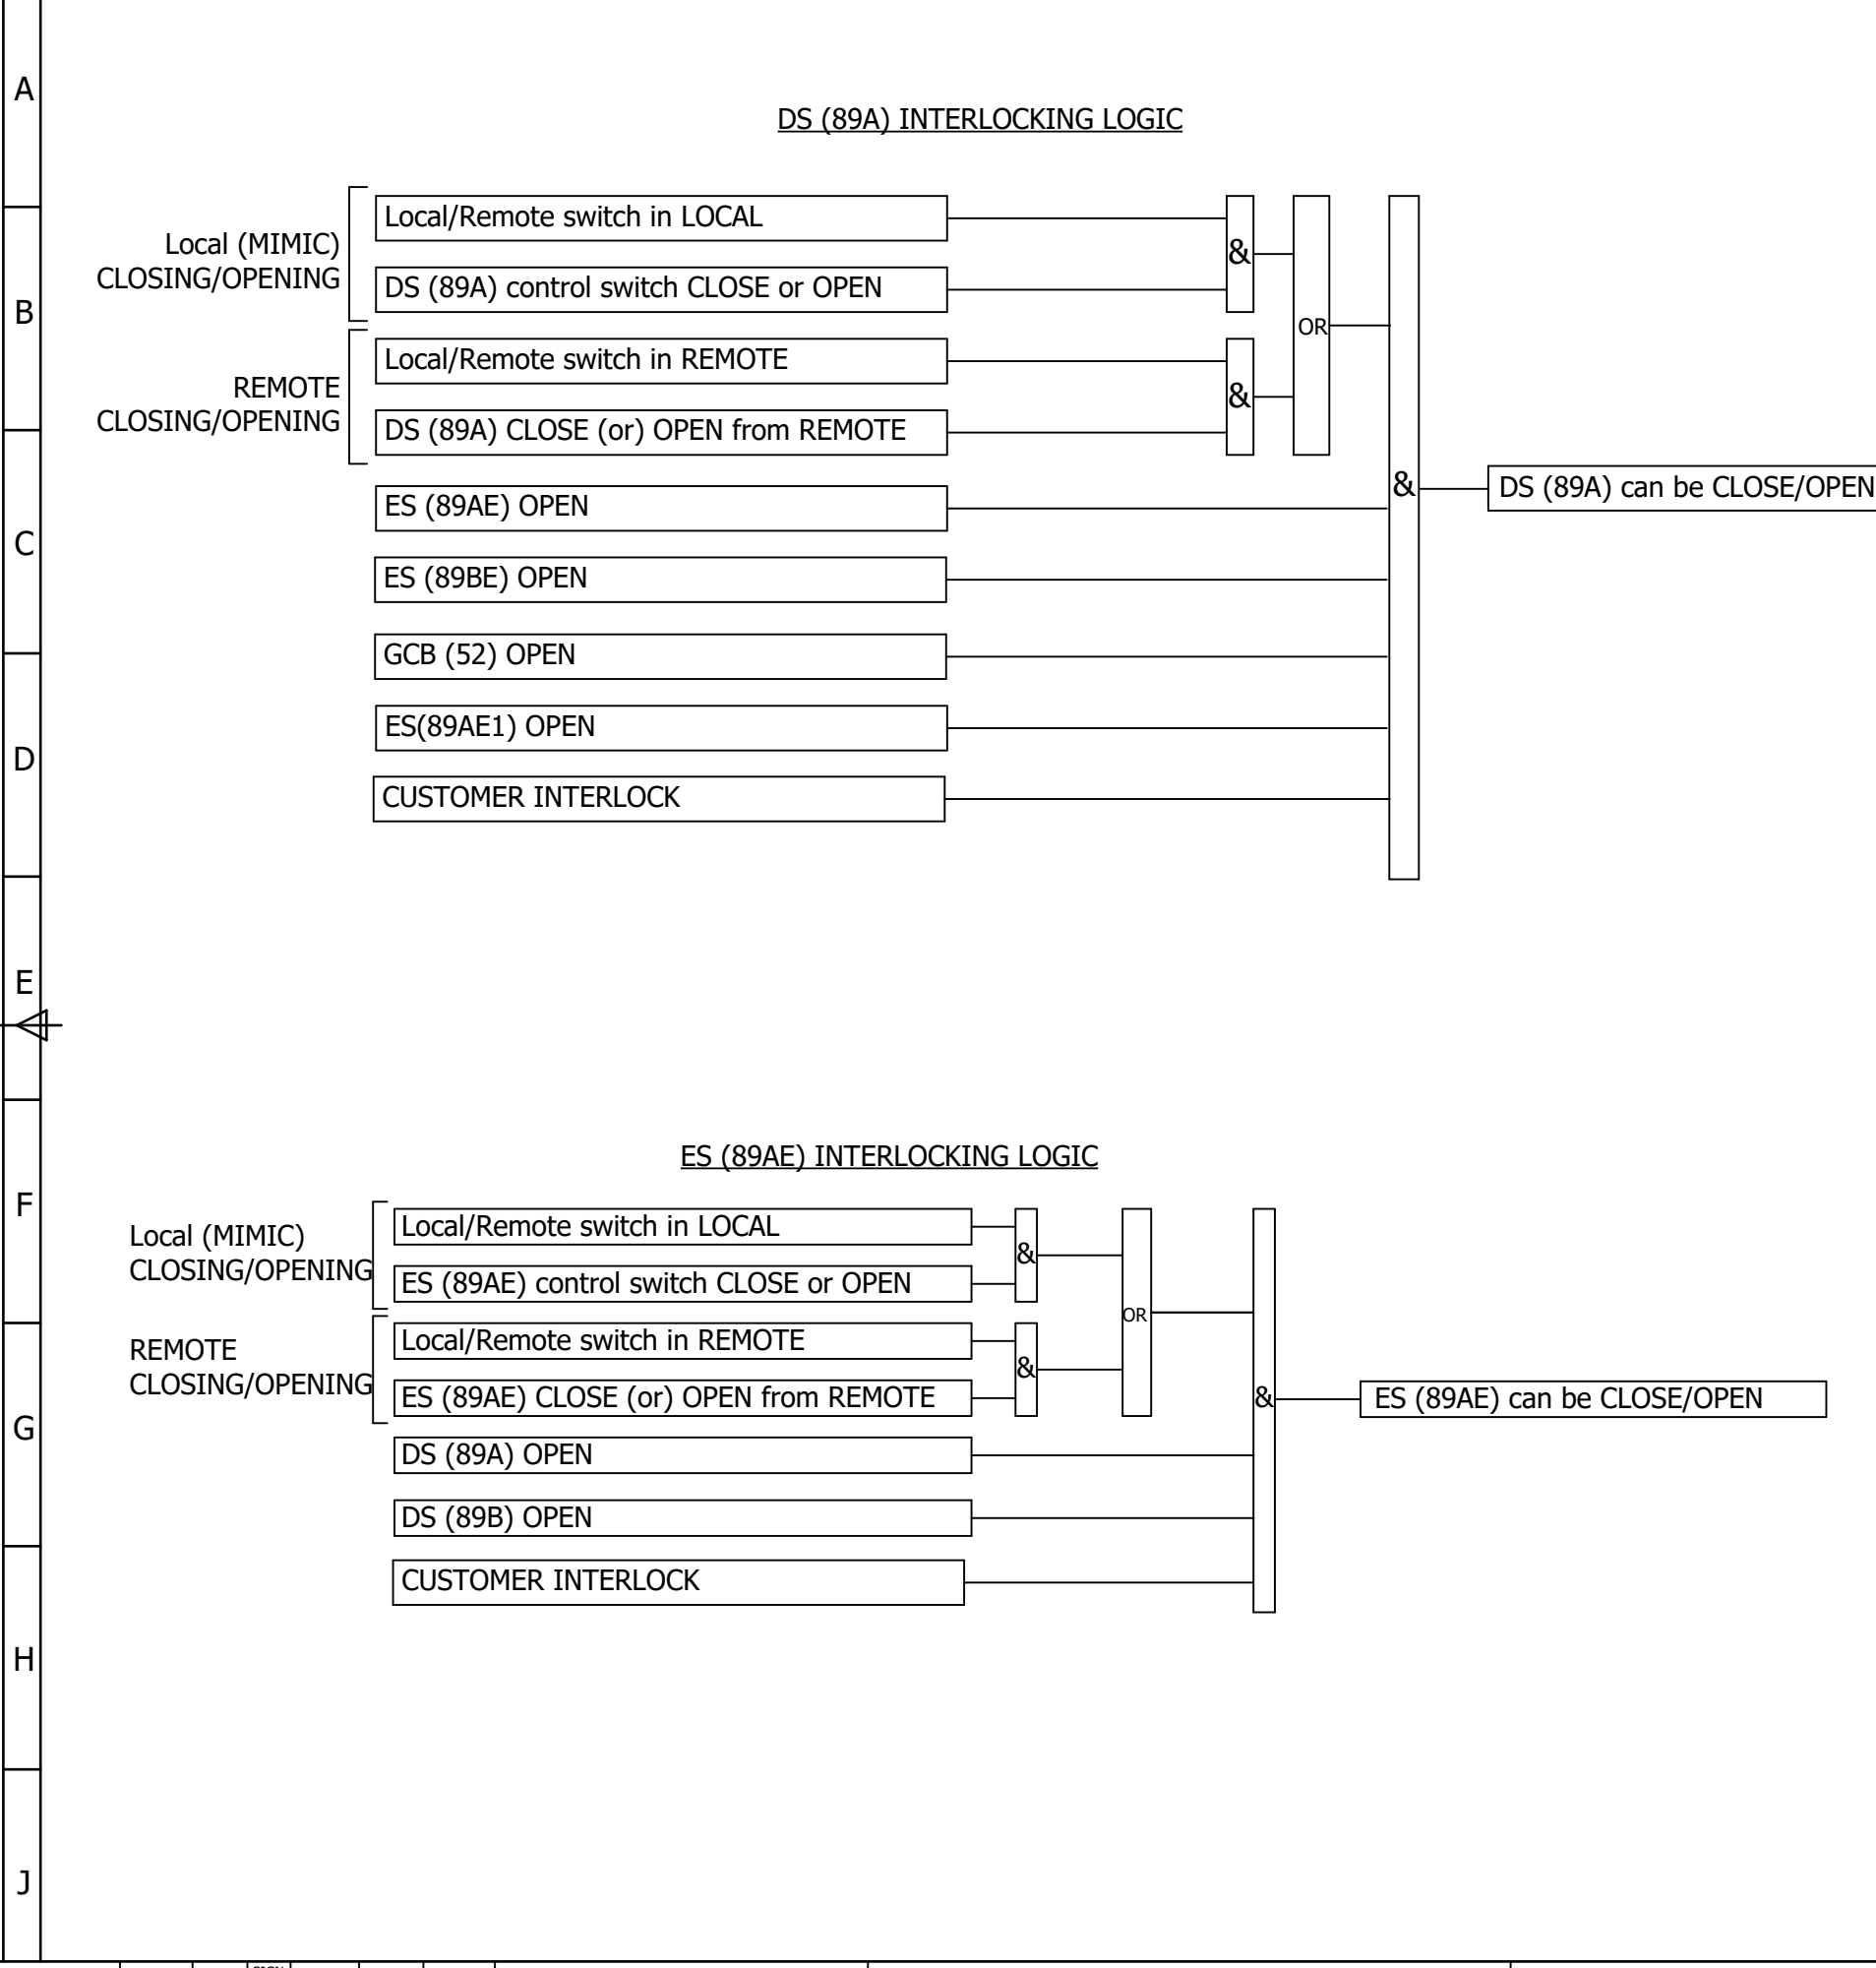


ALL DIMENSIONS ARE IN MM & WEIGHTS ARE IN kg PER UNIT
UNLESS OTHER WISE, SPECIFIED.

ALL INFORMATION CONTAINED IN THIS DOCUMENT IS CONFIDENTIAL AND THE PROPERTY OF
TOSHIBA TRANSMISSION & DISTRIBUTION SYSTEMS (INDIA) PRIVATE LIMITED. REPRODUCTION
OF THIS IN ANY FORM IS TO BE DONE WITH THE SPECIFIC PERMISSION OF THE ORGANISATION.

FORMAT NO. : SG 07 3 04 R0

REFERENCE: -

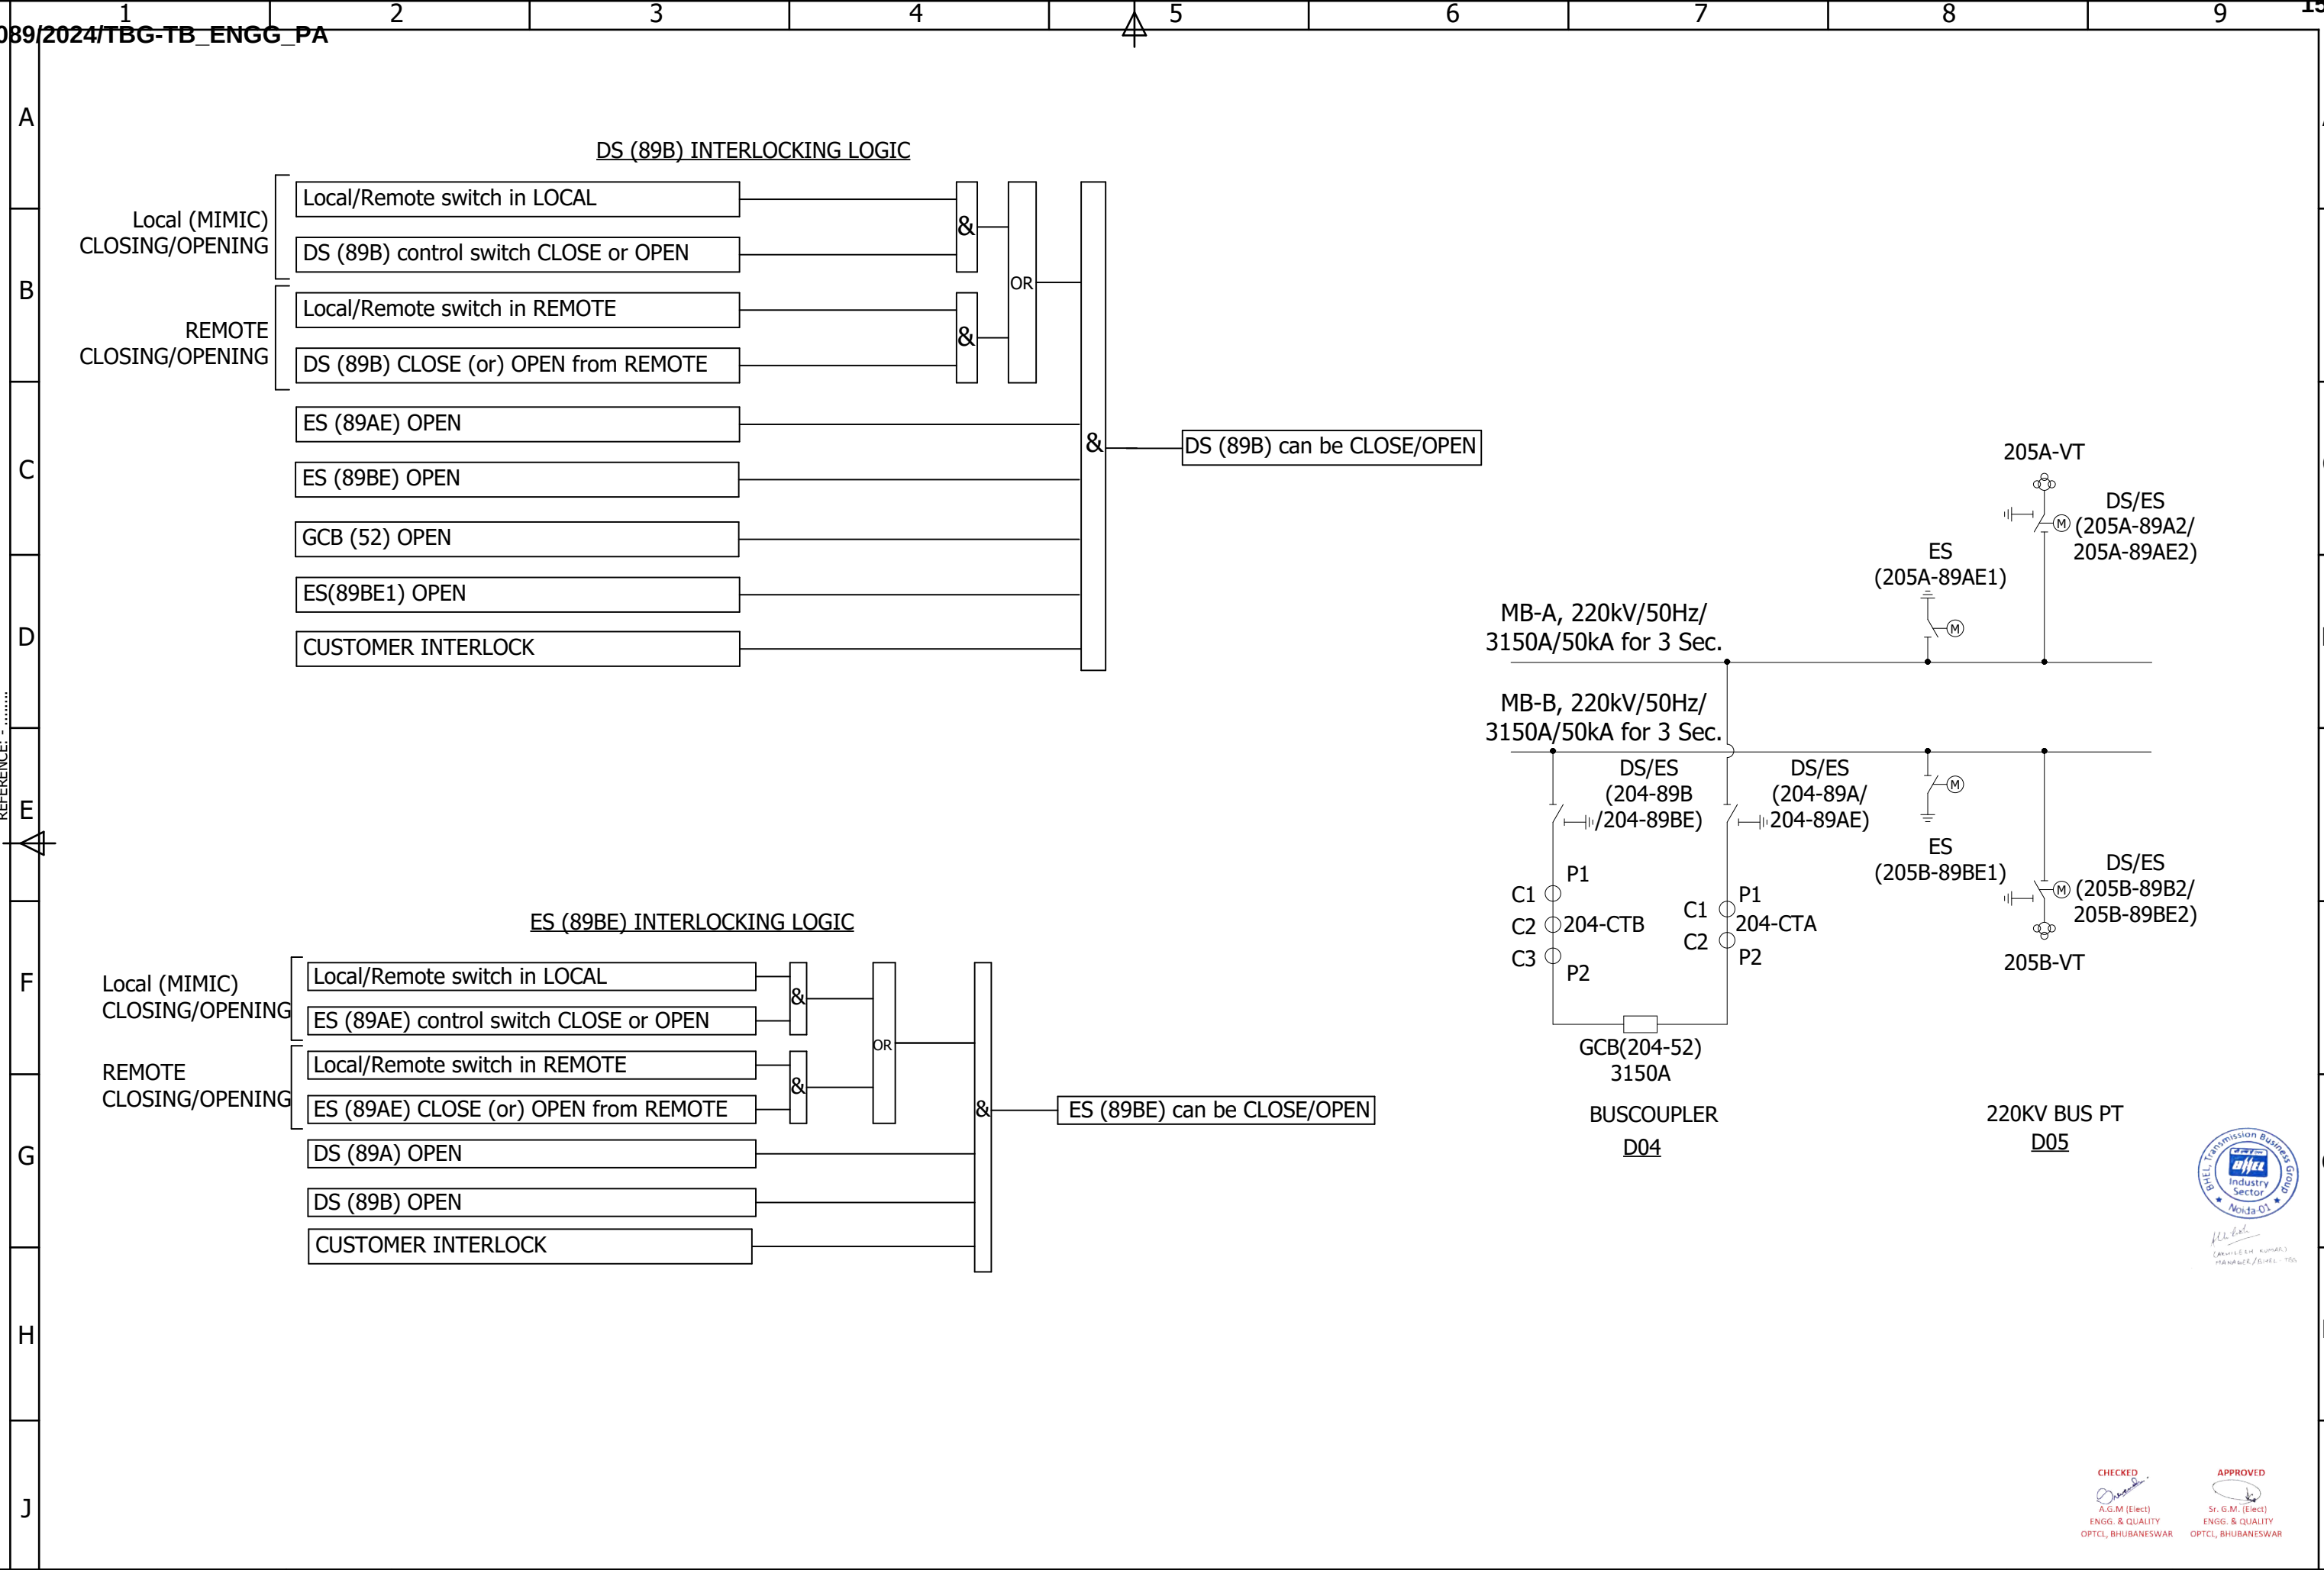

(Signature)
MANAGER/BHEL TSS

CHECKED
A.G.M (Elect)
ENGG. & QUALITY
OPTCL, BHUBANESWAR


APPROVED
Sr. G.M. (Elect)
ENGG. & QUALITY
OPTCL, BHUBANESWAR


02	AS PER CUST.COMMENT	23.05.2024	△	SIGN NAME					TOSHIBA TRANSMISSION & DISTRIBUTION SYSTEMS (INDIA) PRIVATE LIMITED SWITCHGEAR PRODUCTS DIVISION	CLIENT : ODISHA POWER TRANSMISSION CO.LTD. PROJECT : 400/220kV GIS S.S AT ERSAMA, ODISHA & 400kV AIS FEEDER BAY EXTENSION AT DUBURI, ODISHA CUSTOMER DRAWING NO. : TB-420-516-071-10A	PAGE DESCRIPTION : INTERLOCKING LOGIC-3	BAY NAME : GA, INTERNAL ARRANGEMENT & SCHEMATICS OF LCP FOR 220KV BUS COUPLER & 220KV BUS PT-(D04&D05) DRAWING NO. : DEEUGBI69513004	APPROVED	K.IKEDA	K.I	02.02.2024	SCALE : NTS
01	AS PER CUST.COMMENT	18.05.2024	△	SIGN NAME									CHECKED	M.SREEDHAR	M.S	02.02.2024	REV : 02
00	FIRST ISSUE	06.02.2024	△	SIGN NAME									DRAWN	K.MAHESH	K.M	01.02.2024	PAGE 10
REV	DETAILS OF MODIFICATION	DATE	REV.MARK		MODIFIED	CHECKED	APPROVED							NAME	SIGN	DATE	117 PAGES

ALL DIMENSIONS ARE IN MM & WEIGHTS ARE IN kg PER UNIT
UNLESS OTHER WISE, SPECIFIED.

REFERENCE: -

ALL INFORMATION CONTAINED IN THIS DOCUMENT IS CONFIDENTIAL AND THE PROPERTY OF
TOSHIBA TRANSMISSION & DISTRIBUTION SYSTEMS (INDIA) PRIVATE LIMITED. REPRODUCTION
OF THIS IN ANY FORM IS TO BE DONE WITH THE SPECIFIC PERMISSION OF THE ORGANISATION.


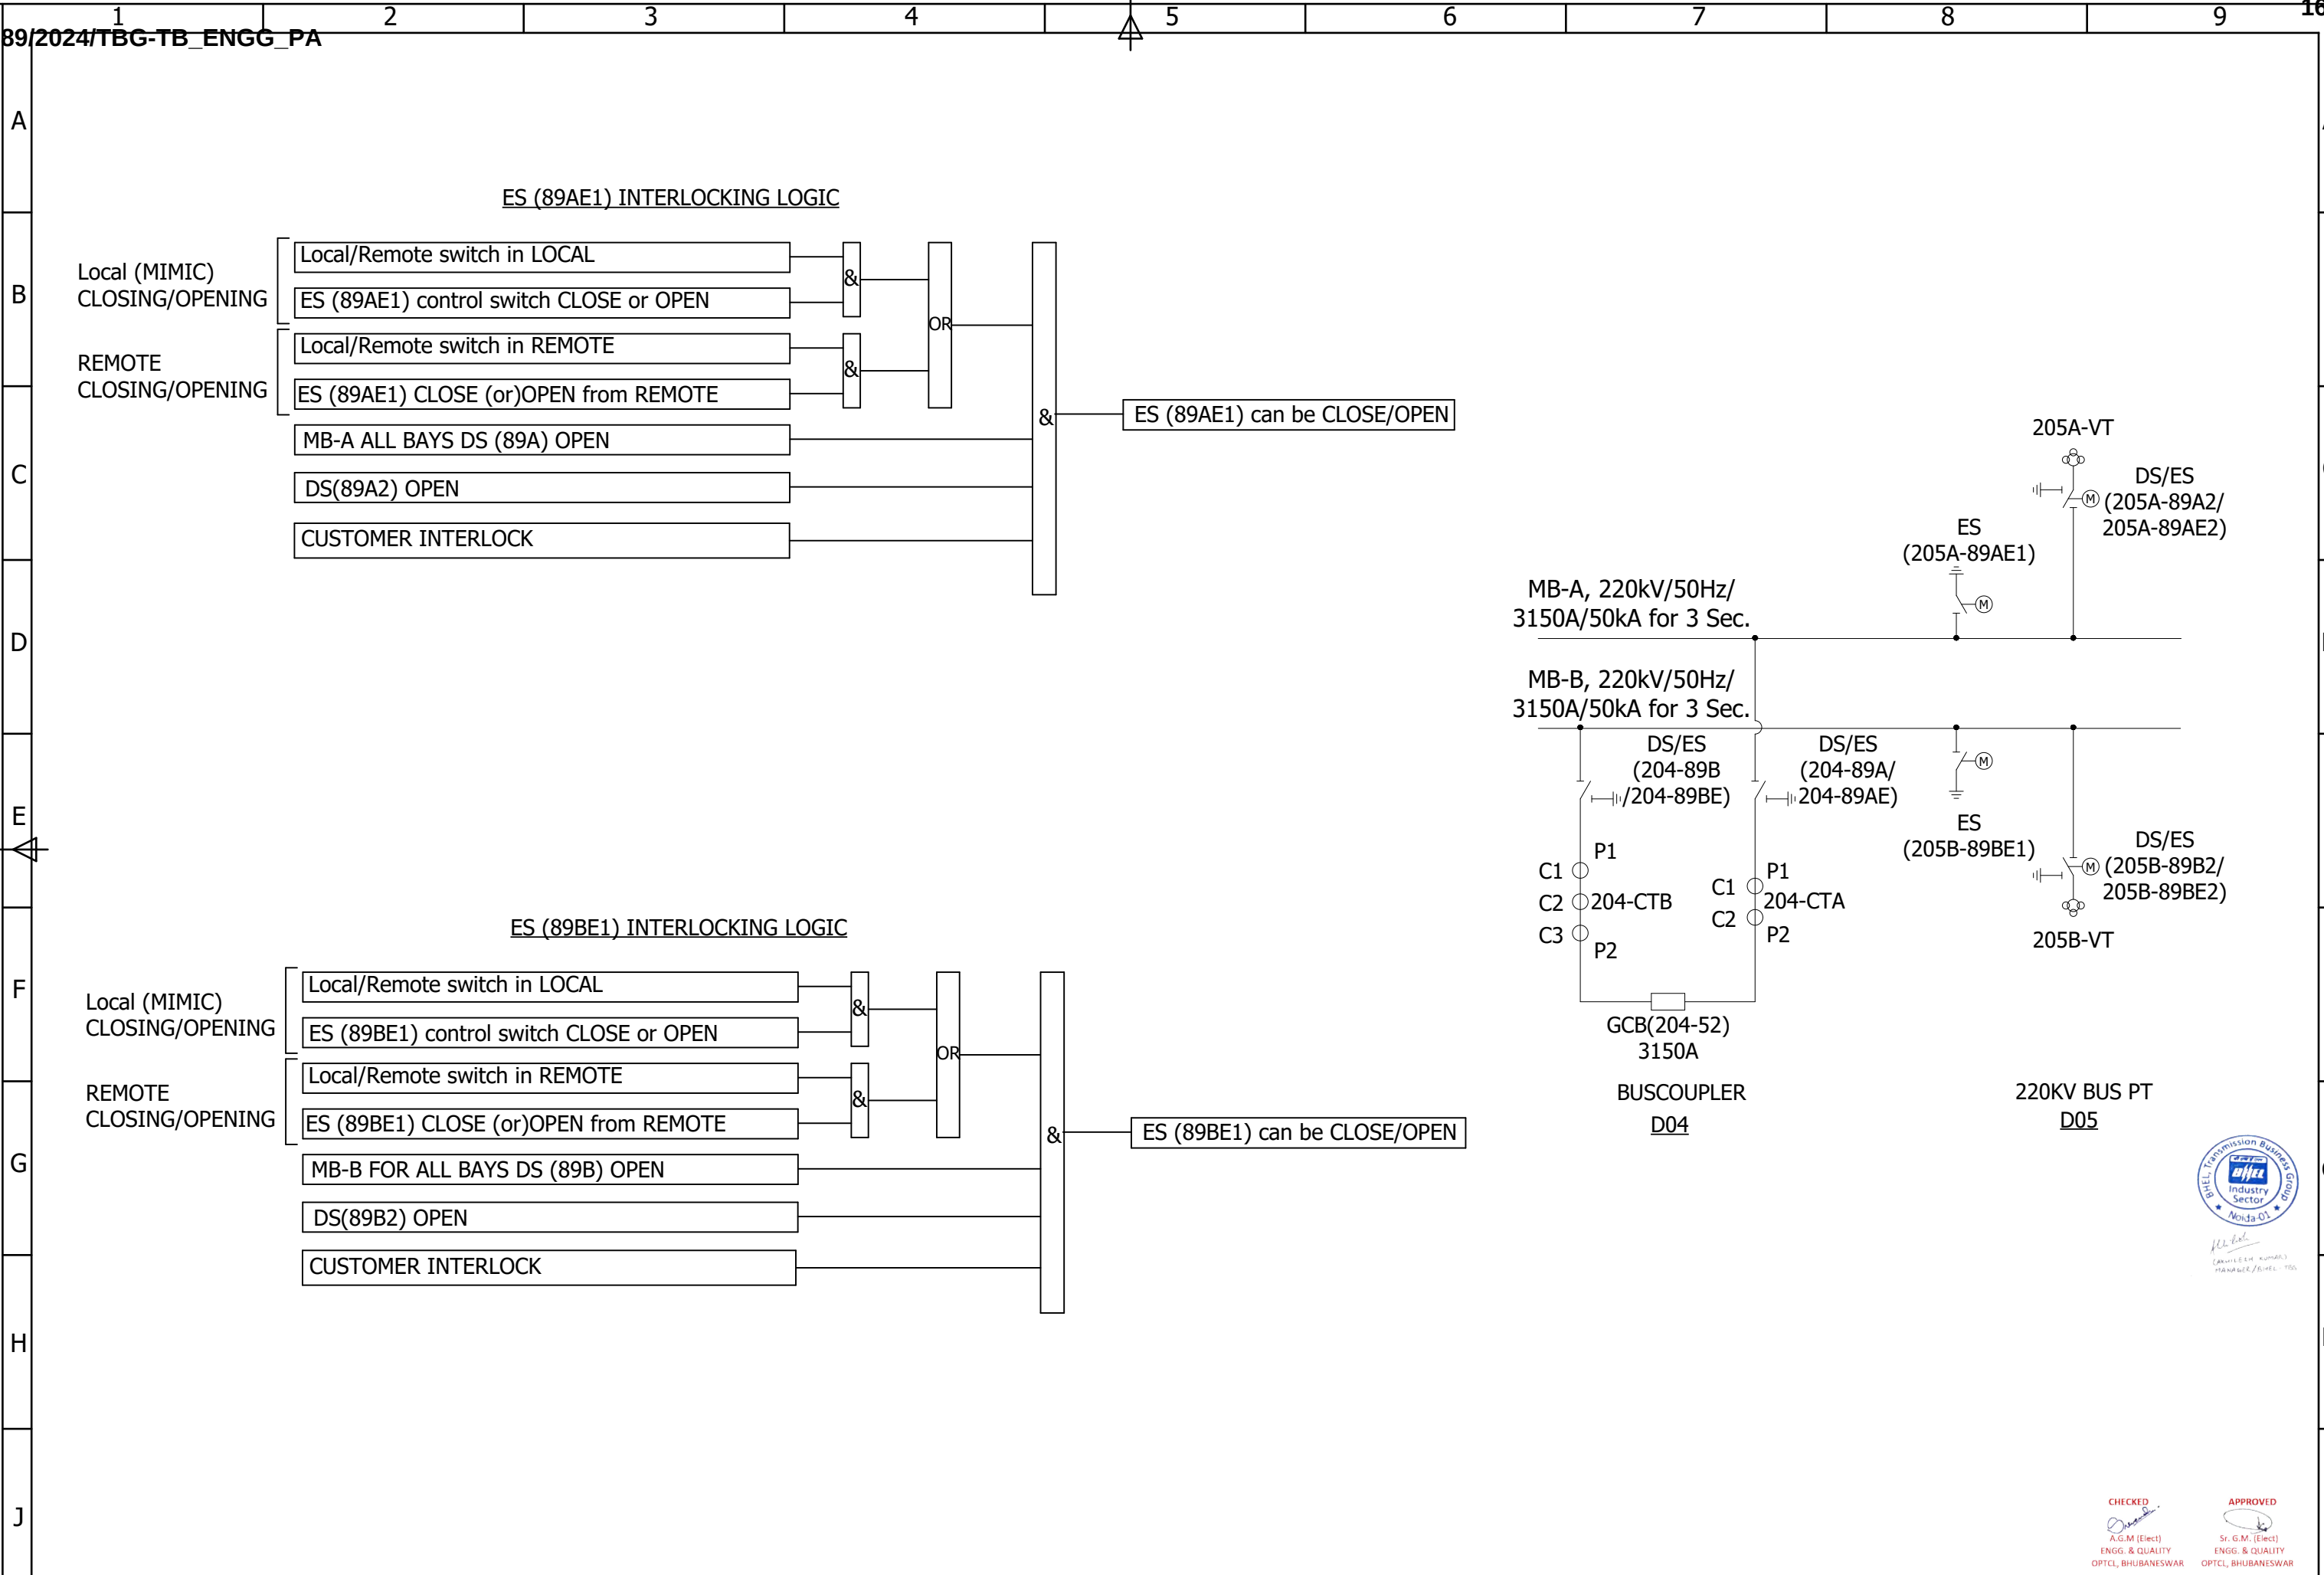


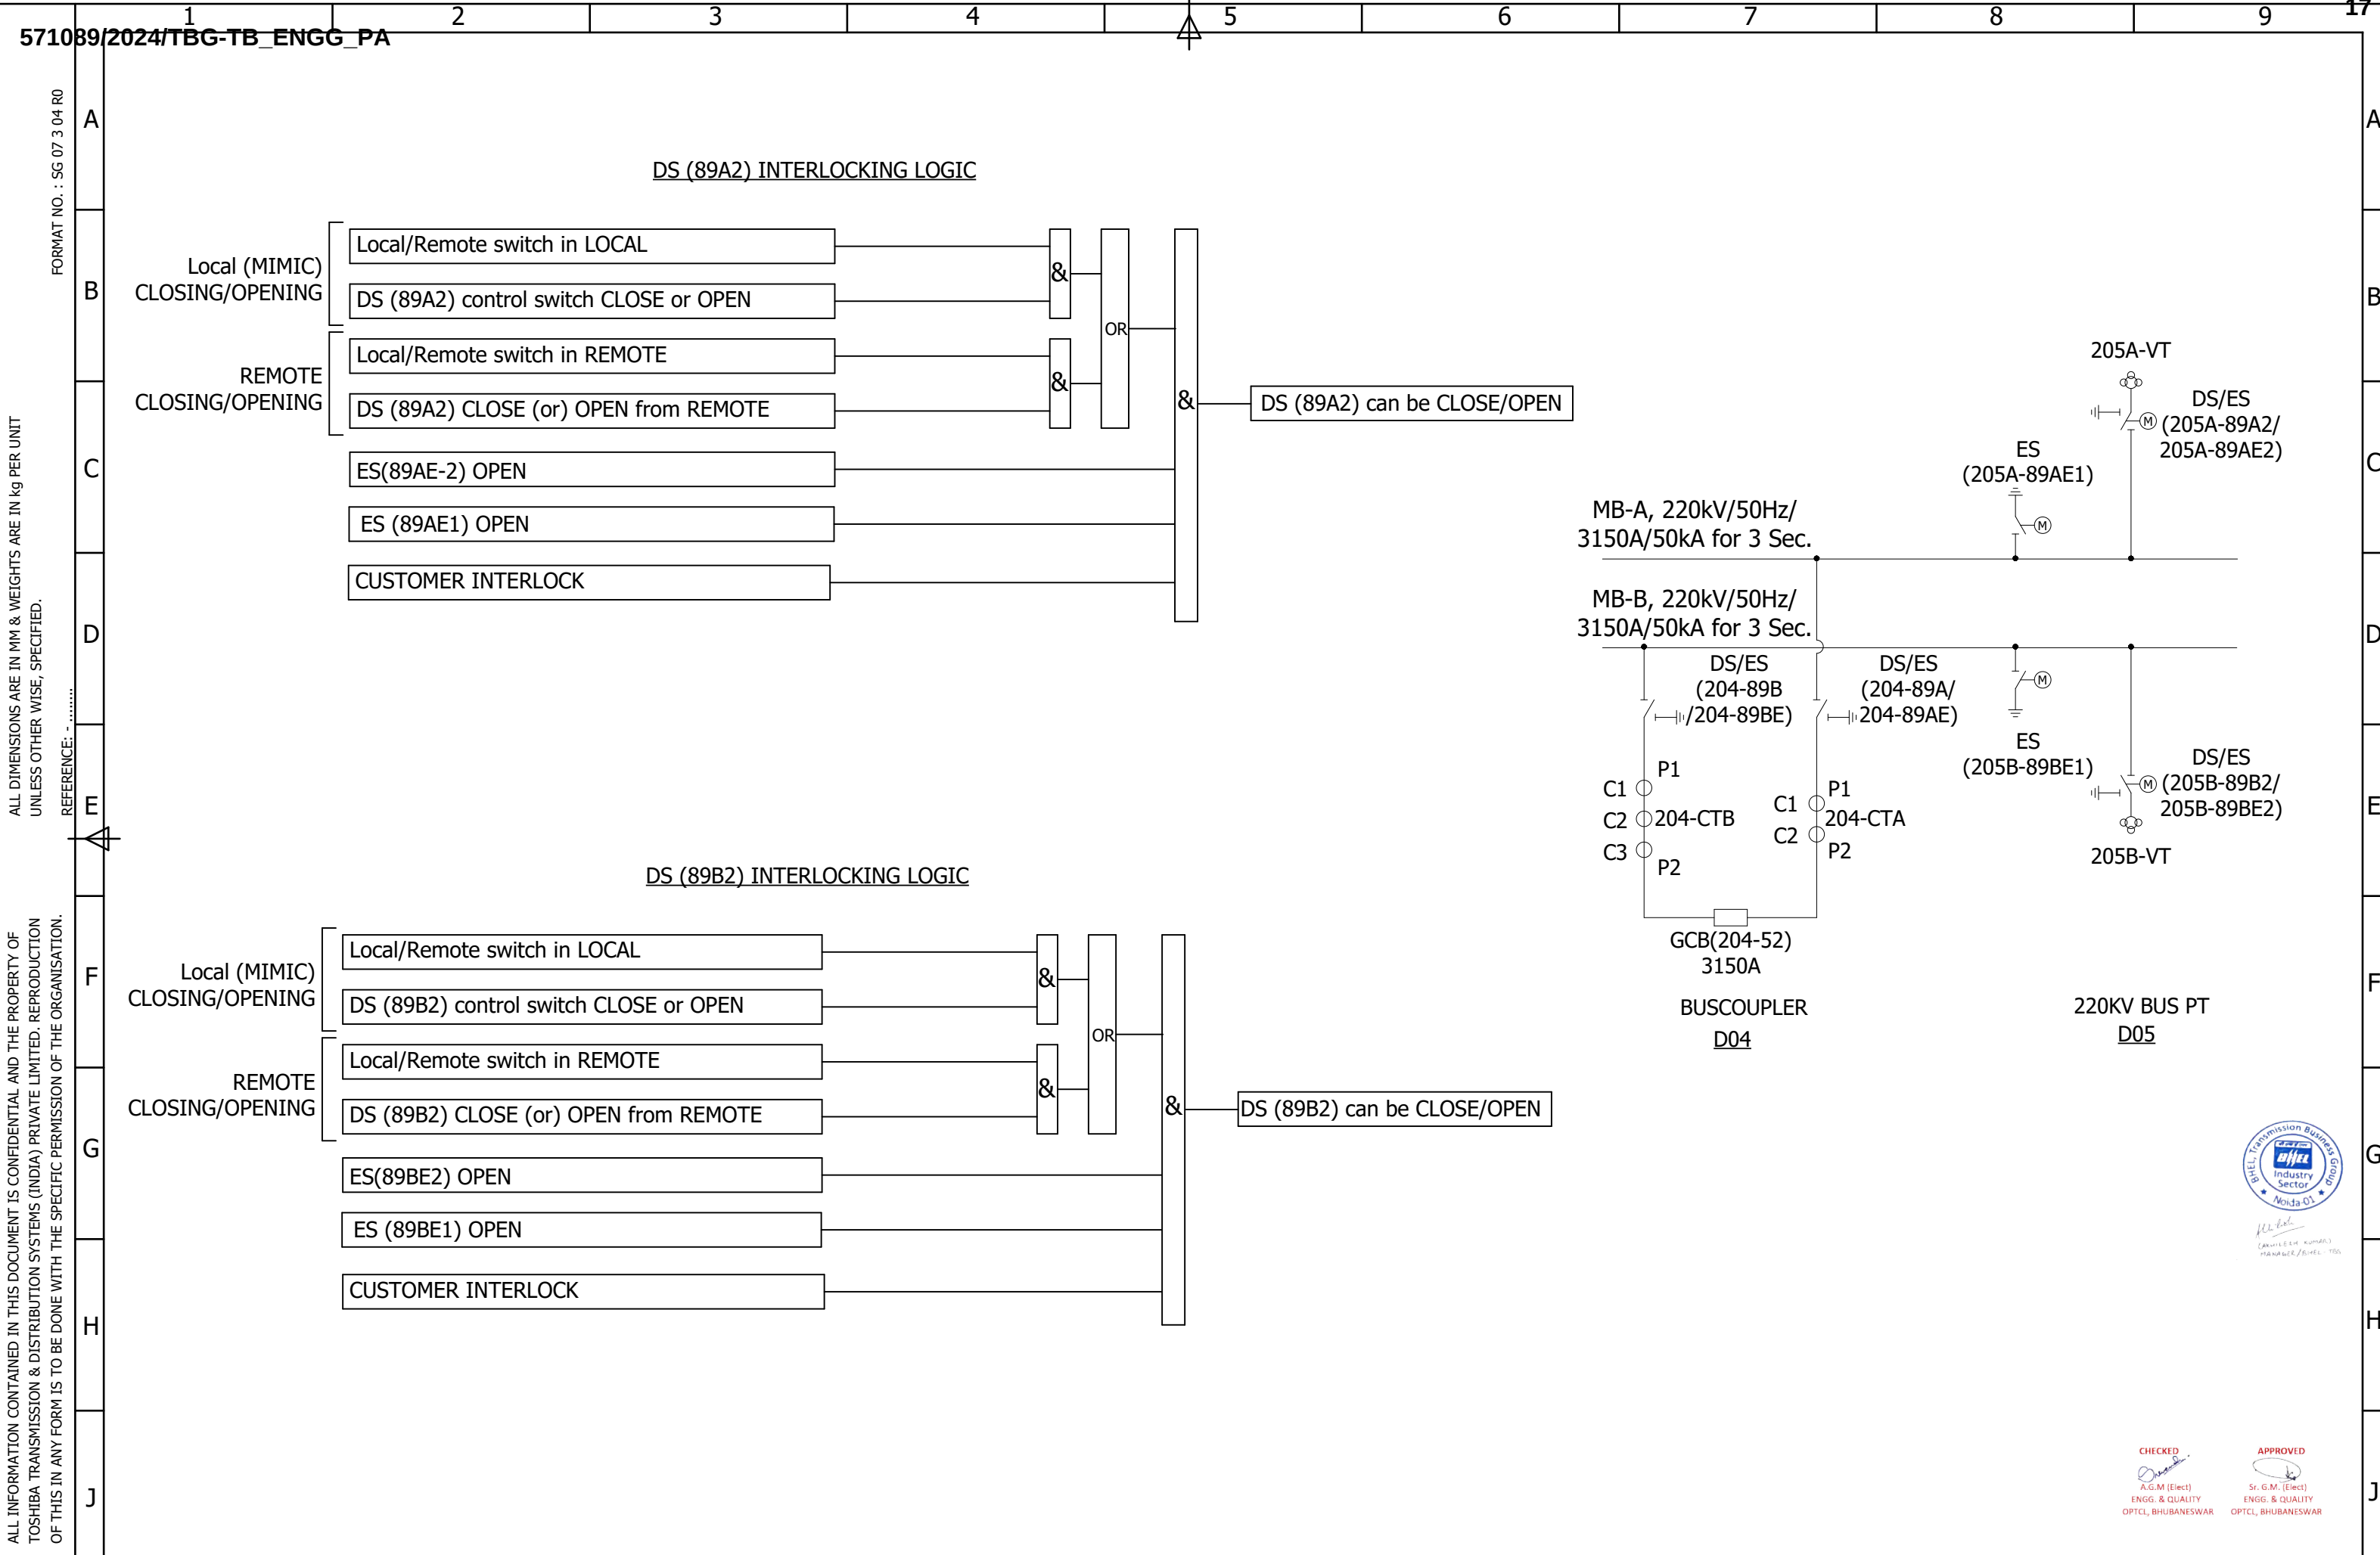

ALL DIMENSIONS ARE IN MM & WEIGHTS ARE IN kg PER UNIT
UNLESS OTHER WISE, SPECIFIED.

FORMAT NO. : SG 07 3 04 R0

ALL INFORMATION CONTAINED IN THIS DOCUMENT IS CONFIDENTIAL AND THE PROPERTY OF
TOSHIBA TRANSMISSION & DISTRIBUTION SYSTEMS (INDIA) PRIVATE LIMITED. REPRODUCTION
OF THIS IN ANY FORM IS TO BE DONE WITH THE SPECIFIC PERMISSION OF THE ORGANISATION.

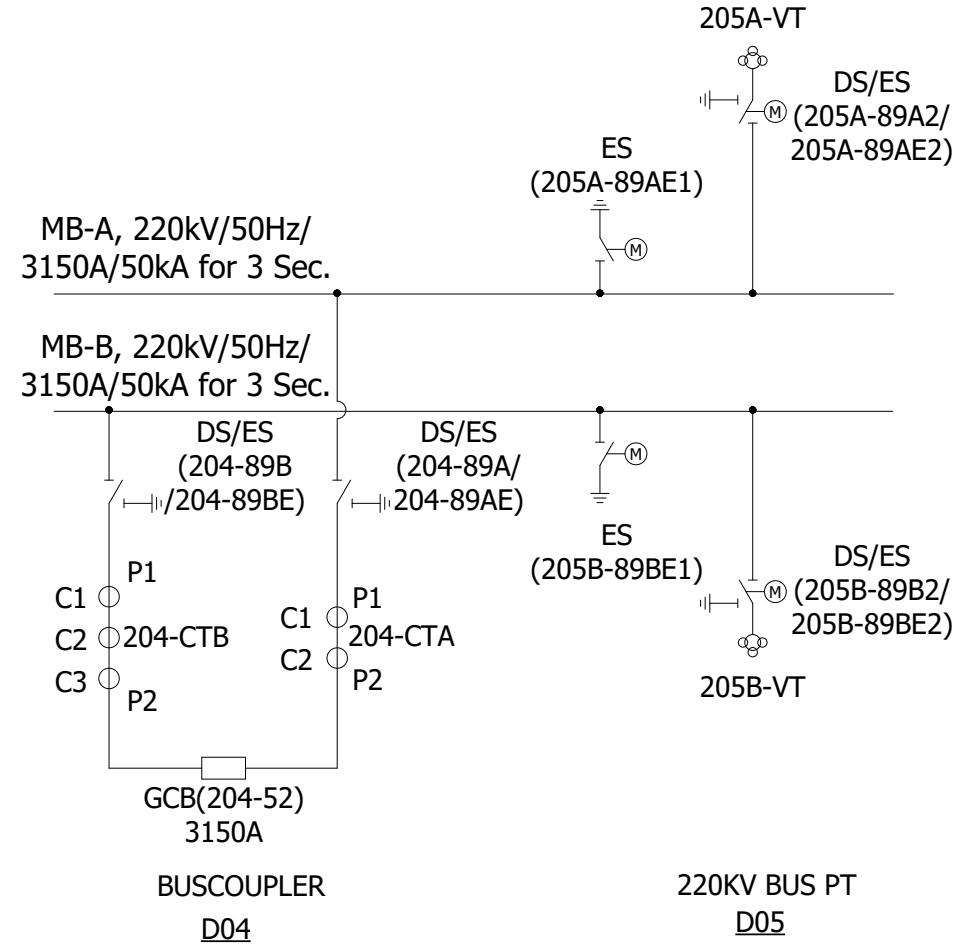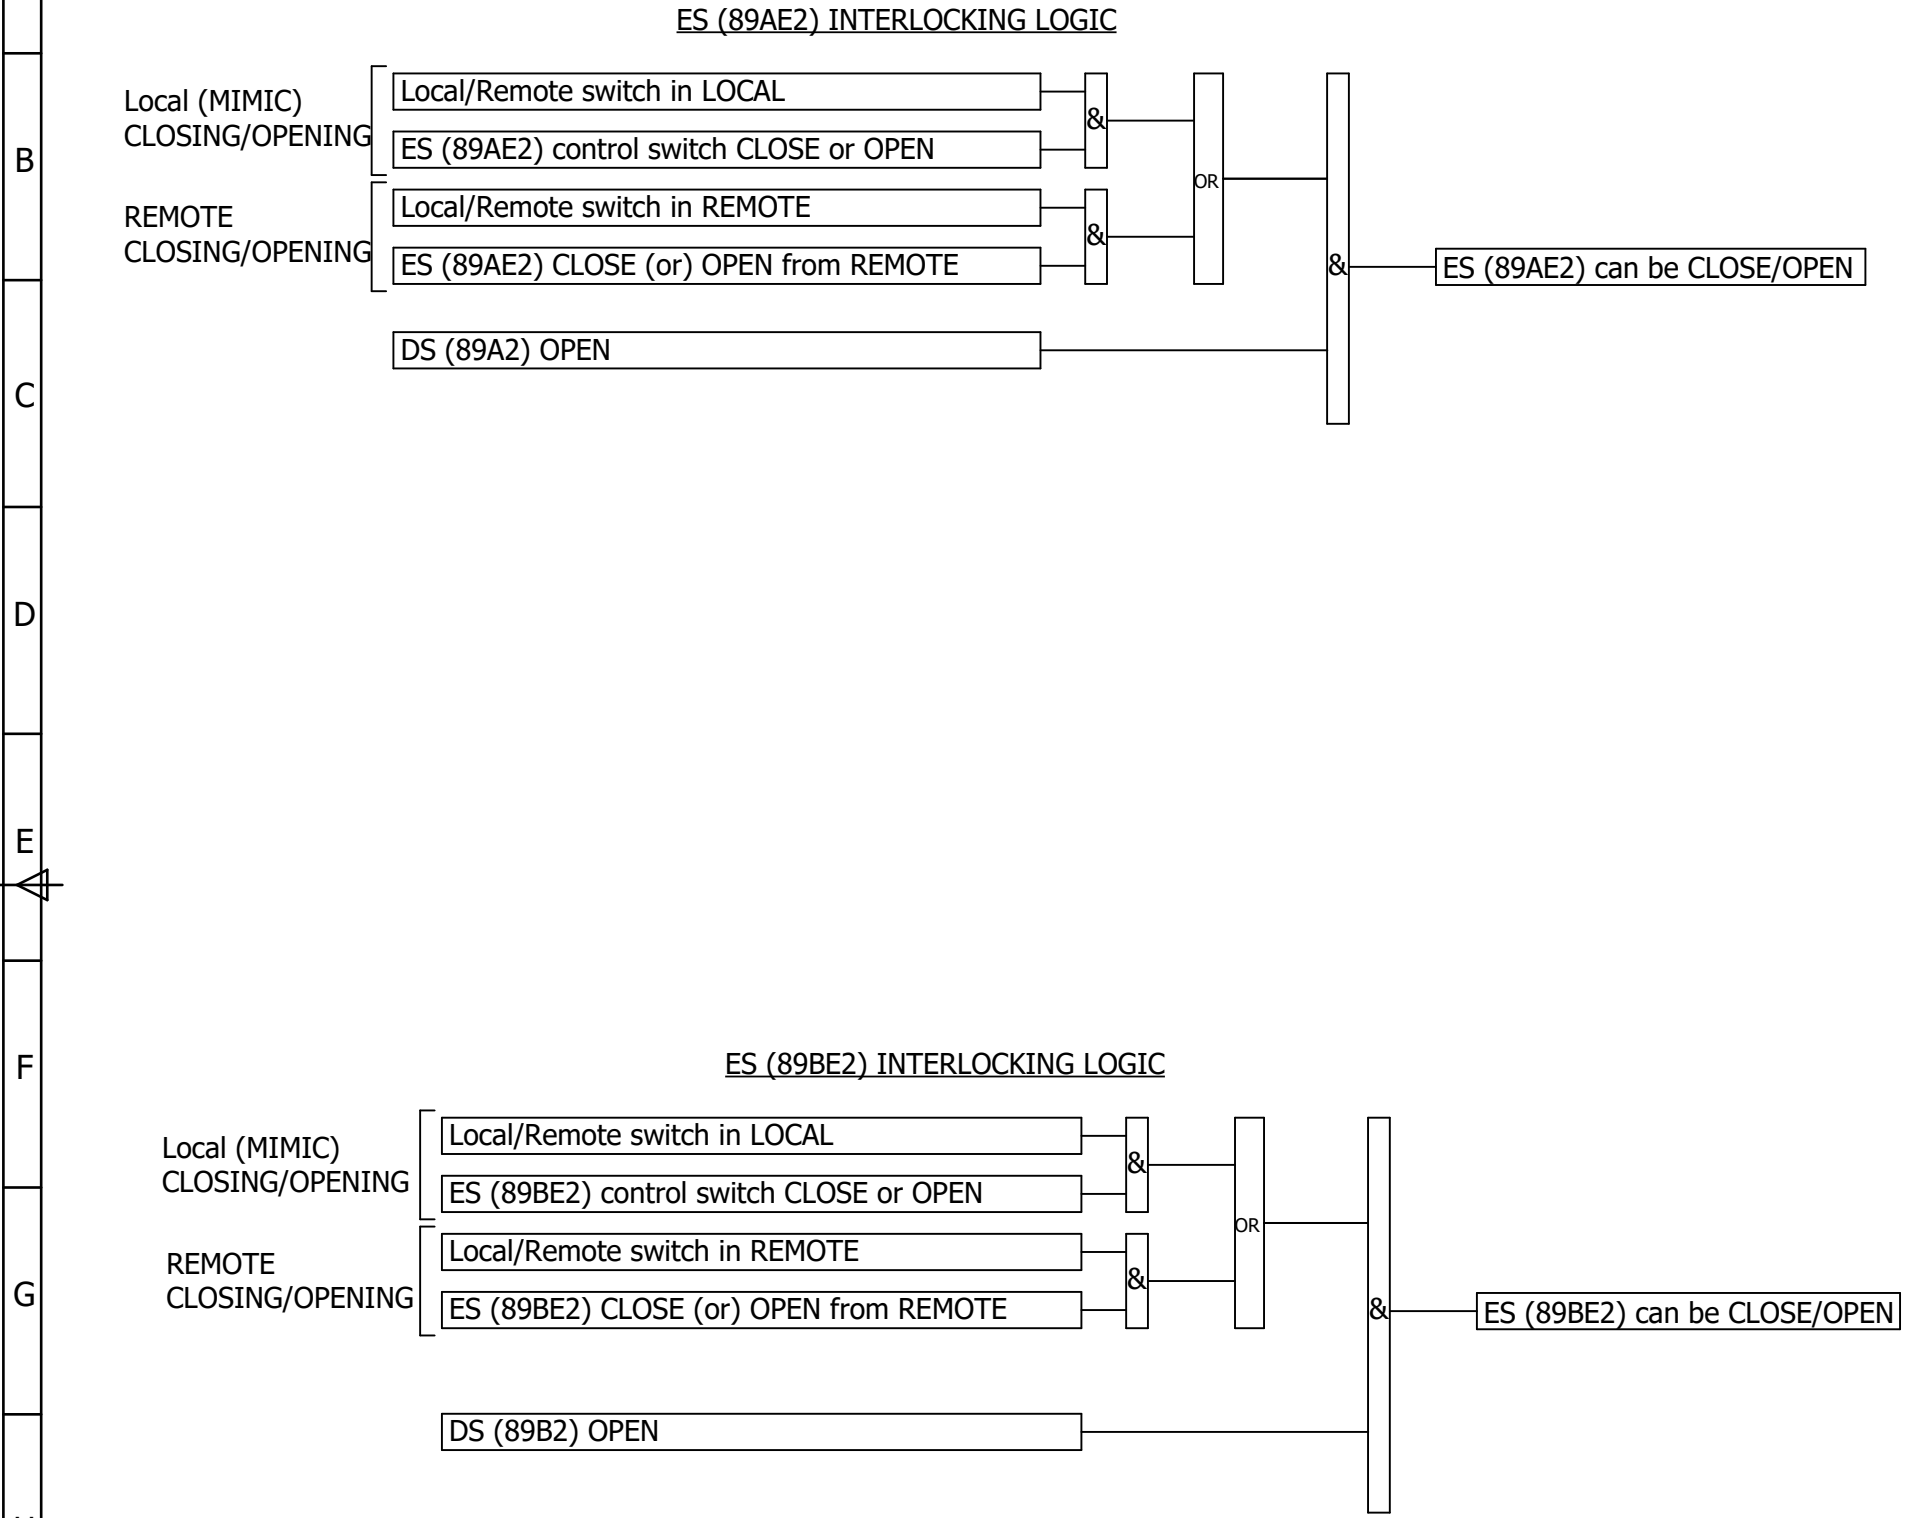

CHECKED
A.G.M (Elect)
ENGG. & QUALITY
OPTCL, BHUBANESWAR

APPROVED
Sr. G.M. (Elect)
ENGG. & QUALITY
OPTCL, BHUBANESWAR


02	AS PER CUST.COMMENT	23.05.2024	△	SIGN NAME					TOSHIBA TRANSMISSION & DISTRIBUTION SYSTEMS (INDIA) PRIVATE LIMITED SWITCHGEAR PRODUCTS DIVISION	CLIENT : ODISHA POWER TRANSMISSION CO.LTD. PROJECT : 400/220kV GIS S.S AT ERSAMA, ODISHA & 400kV AIS FEEDER BAY EXTENSION AT DUBURI, ODISHA CUSTOMER DRAWING NO. : TB-420-516-071-10A	PAGE DESCRIPTION : INTERLOCKING LOGIC-6	BAY NAME : GA, INTERNAL ARRANGEMENT & SCHEMATICS OF LCP FOR 220KV BUS COUPLER & 220KV BUS PT-(D04&D05) DRAWING NO. : DEEUGBI69513004	APPROVED	K.IKEDA	K.I	02.02.2024	SCALE : NTS
01	AS PER CUST.COMMENT	18.05.2024	△	SIGN NAME									CHECKED	M.SREEDHAR	M.S	02.02.2024	REV : 02
00	FIRST ISSUE	06.02.2024	△	SIGN NAME									DRAWN	K.MAHESH	K.M	01.02.2024	PAGE 13
REV. DETAILS OF MODIFICATION				REV. MARK		MODIFIED	CHECKED	APPROVED					DESIGN	SRIDEVI.Y	S.Y	11.01.2024	117 PAGES

ALL DIMENSIONS ARE IN MM & WEIGHTS ARE IN kg PER UNIT
UNLESS OTHER WISE, SPECIFIED.


ALL INFORMATION CONTAINED IN THIS DOCUMENT IS THE PROPERTY OF
TOSHIBA TRANSMISSION & DISTRIBUTION SYSTEMS (INDIA) PRIVATE LIMITED. REPRODUCTION
OF THIS IN ANY FORM IS TO BE DONE WITH THE SPECIFIC PERMISSION OF THE ORGANISATION.

FORMAT NO. : SG 07 3 04 R0


A
B
C
D
E
F
G
H
J

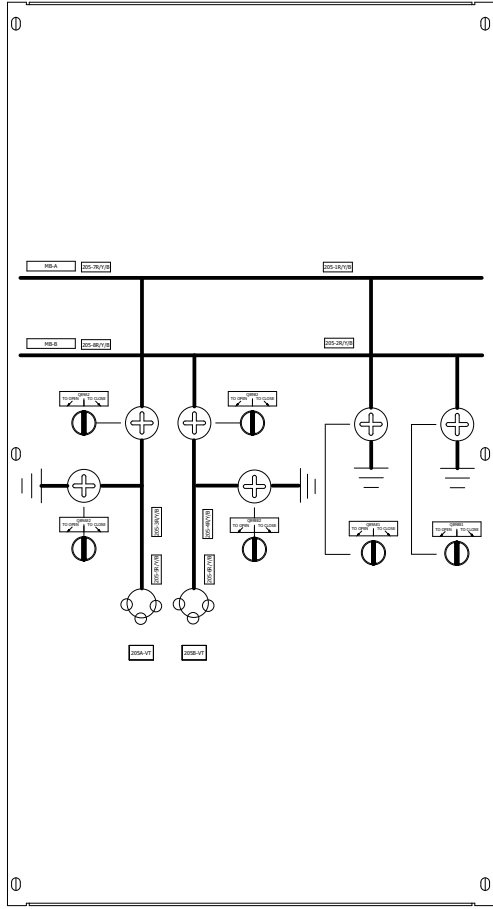


MIMIC DIAGRAM (FRONT VIEW)
220KV BUS PT (D05)

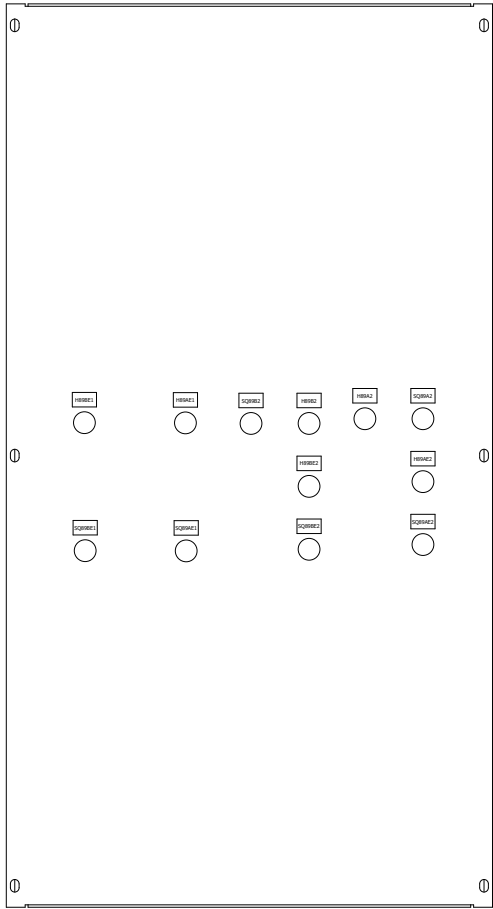

MIMIC DIAGRAM (REAR VIEW)
220KV BUS PT (D05)

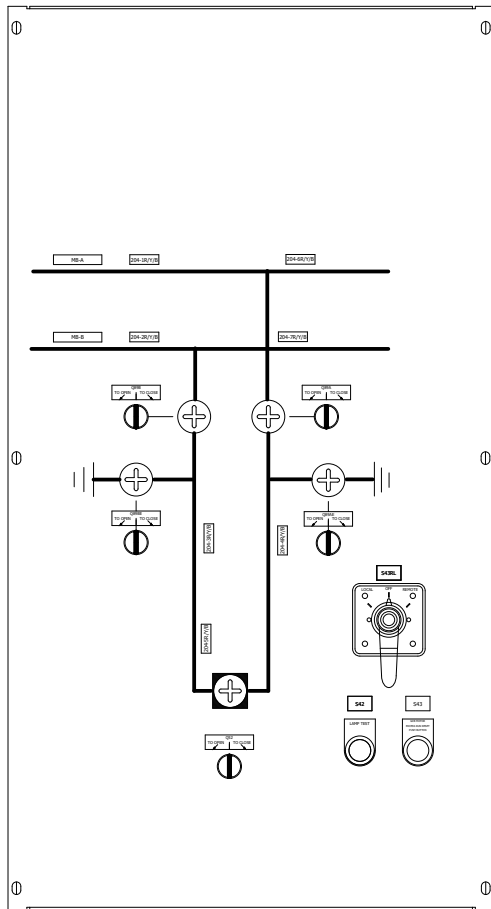

MIMIC DIAGRAM (FRONT VIEW)
BUS COUPLER (D04)

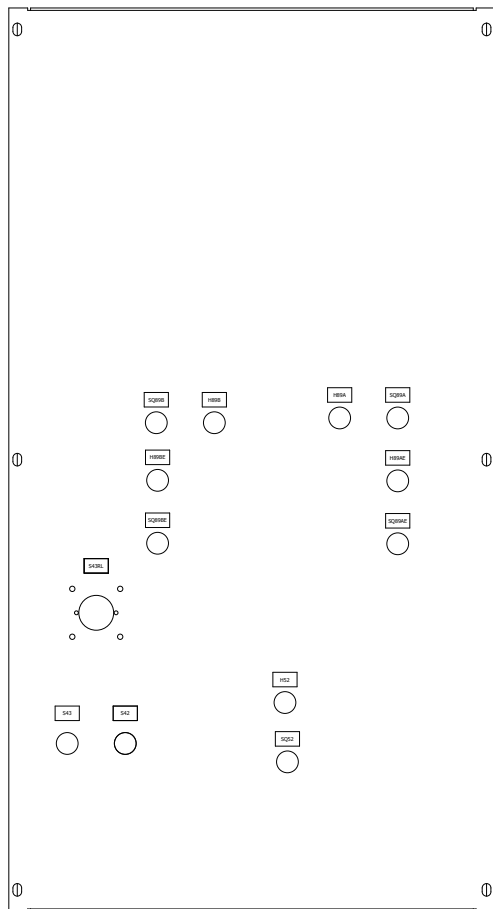

MIMIC DIAGRAM (REAR VIEW)
BUS COUPLER (D04)

TENTATIVE

CONTROL SWITCH & LAMP INDICATORS

3 POSITION SPRING RETURN SWITCH GCB & DS/ES OPEN/CLOSE OPERATION	LAMP INDICATORS	
	GCB & DS	ES & HES
TO OPEN TO OFF TO CLOSE 	RED (CLOSE) GREEN (OPEN) 	GREEN (OPEN) RED (CLOSE)
MIMIC DIAGRAM (REAR VIEW LABEL) S (52,89A,89B,89AE,89BE,89AE1,89BE1,89A2,89B2,89AE2&89BE2) - OPEN/CLOSE CONTROL SW. LABEL H (52,89A,89B,89AE,89BE,89AE1,89BE1,89A2,89B2,89AE2&89BE2) - LAMP INDICATORS LABEL S43RL - LOCAL & REMOTE SW. LABEL S42 - LAMP TEST PUSH BUTTON LABEL S43 - GCB MOTOR EXCESS RUN RESET PUSH BUTTON LABEL		

SPECIFICATION OF SWITCH

SWITCH	INSCRIPTION	SWITCH	INSCRIPTION
S43RL CHANGE OVER SWITCH *1 *3	 *2=REMOTE	S43 PUSH BUTTON	
CONTROL SWITCH FOR GCB, DS, ES	TO OPEN TO OFF TO CLOSE 	S42 PUSH BUTTON	LAMP TEST
NOTE: *1 = KEY LOCK FACILITY *2 = KEY REMOVAL POSITION *3 = STAY PUT			

SPECIFICATION OF MIMIC BUS / SYMBOLS

MATERIAL	STRIP		
CIRCUIT	COLOR	WIDTH	MARK
220kV	GOLDEN YELLOW (IS 5:356)	10mm	
EARTH	TRAFFIC BLACK (RAL 9017)	5mm	
FIXING: GLUE 			

CHECKED
A.G.M (Elect)
ENGG. & QUALITY
OPTCL, BHUBANESWAR

APPROVED
Sr. G.M. (Elect)
ENGG. & QUALITY
OPTCL, BHUBANESWAR



02	AS PER CUST.COMMENT	23.05.2024		SIGN NAME					
01	AS PER CUST.COMMENT	18.05.2024		SIGN NAME					
00	FIRST ISSUE	06.02.2024		SIGN NAME					
REVISIONS OF MODIFICATION									
REV	DETAILS OF MODIFICATION	DATE	REV.MARK	MODIFIED	CHECKED	APPROVED			

TOSHIBA

TRANSMISSION & DISTRIBUTION SYSTEMS
(INDIA) PRIVATE LIMITED
SWITCHGEAR PRODUCTS DIVISION

CLIENT : ODISHA POWER TRANSMISSION CO.LTD.
PROJECT : 400/220kV GIS S.S AT ERSAMA, ODISHA & 400kV
AIS FEEDER BAY EXTENSION AT DUBURI, ODISHA
CUSTOMER DRAWING NO. : TB-420-516-071-10A

PAGE DESCRIPTION :
MIMIC

BAY NAME : GA, INTERNAL ARRANGEMENT &
SCHEMATICS OF LCP FOR 220KV BUS
COUPLER & 220KV BUS PT-(D04&D05)
DRAWING NO. : DEEUGBI69513004


APPROVED	K.IKEDA	K.I	02.02.2024	SCALE : NTS
CHECKED	M.SREEDHAR	M.S	02.02.2024	REV : 02
DRAWN	K.MAHESH	K.M	01.02.2024	
DESIGN	SRIDEVI.Y	S.Y	11.01.2024	PAGE 14
	NAME	SIGN	DATE	117 PAGES

FORMAT NO. : SG 07 3 04 R0

ALL DIMENSIONS ARE IN MM & WEIGHTS ARE IN kg PER UNIT
UNLESS OTHER WISE, SPECIFIED.

REFERENCE: -

ALL INFORMATION CONTAINED IN THIS DOCUMENT IS CONFIDENTIAL AND THE PROPERTY OF
TOSHIBA TRANSMISSION & DISTRIBUTION SYSTEMS (INDIA) PRIVATE LIMITED. REPRODUCTION
OF THIS IN ANY FORM IS TO BE DONE WITH THE SPECIFIC PERMISSION OF THE ORGANISATION.

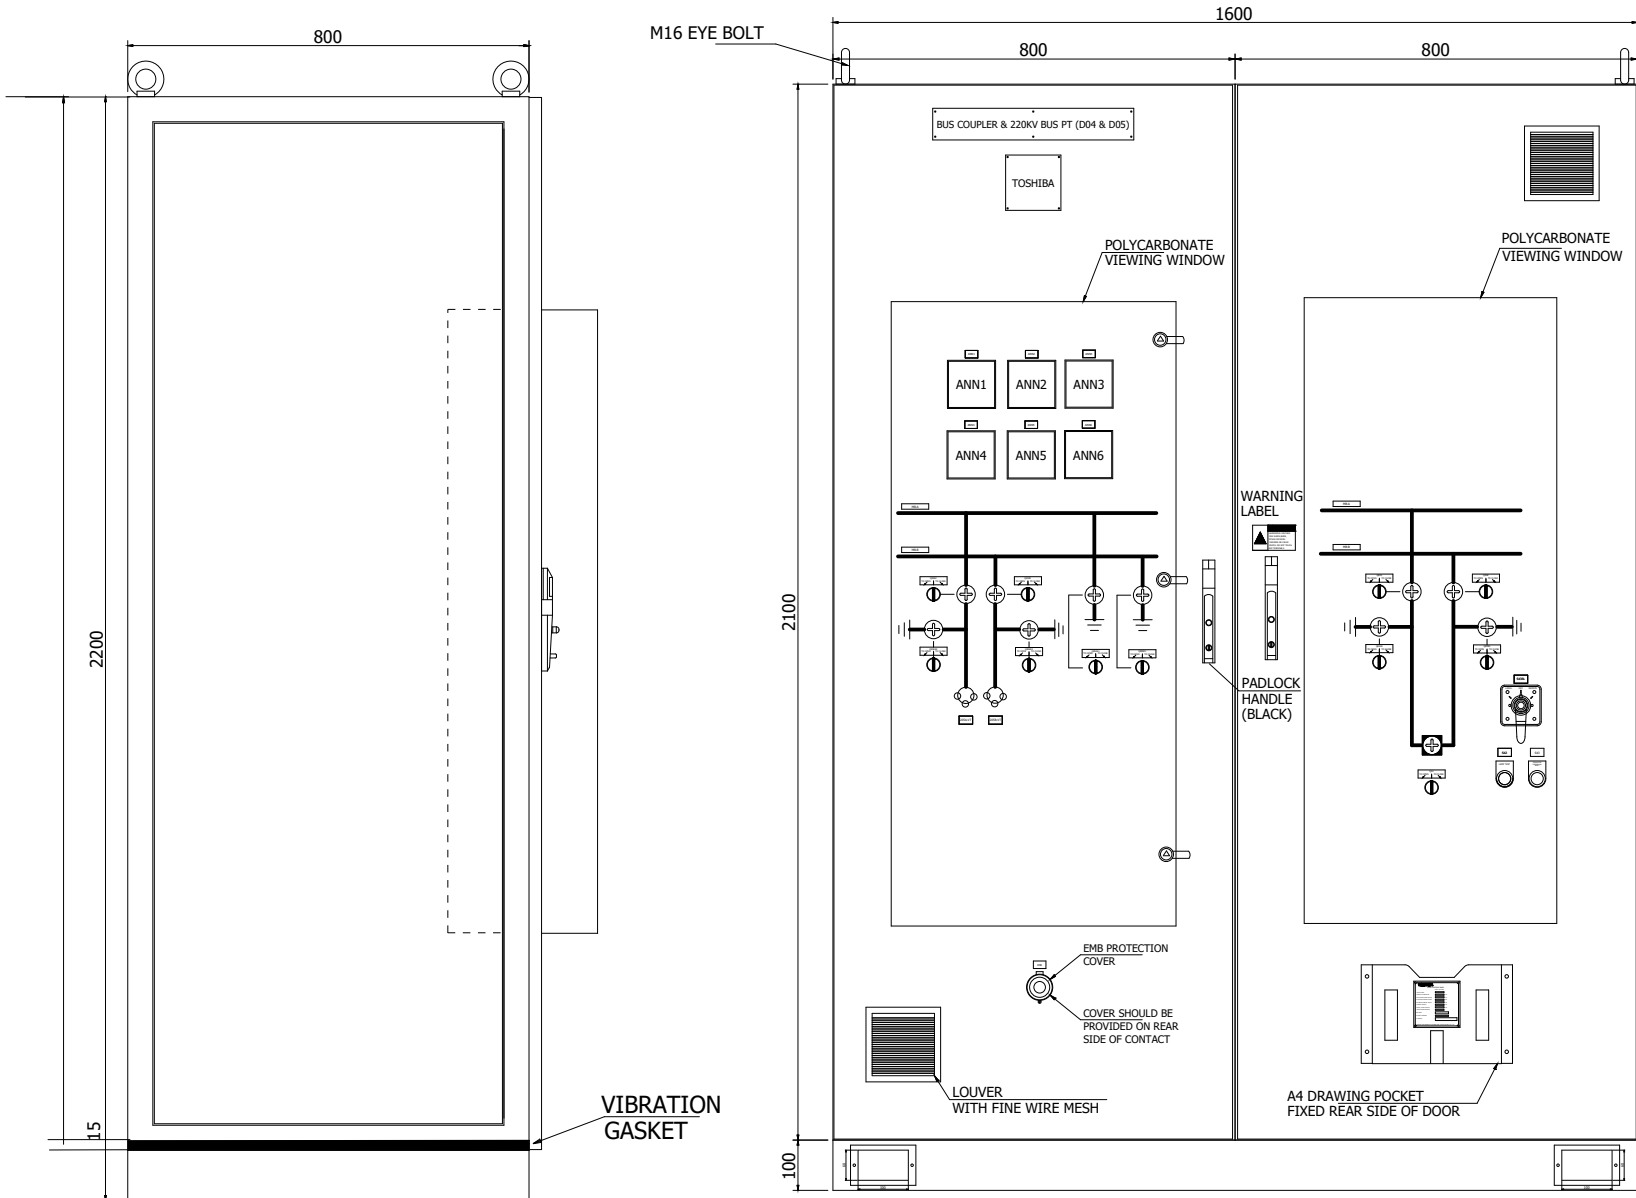

LEFT SIDE VIEW

FRONT VIEW OF OUTER DOOR

(FRONT SIDE)
BOTTOM VIEW


PANEL SPECIFICATION

- MATERIAL
 - COLD ROLLED SHEET STEEL
- SHEET THICKNESS
 - GLAND PLATE : 3MM
 - ALL OTHER : 2.5MM
- DOOR OPENING
 - LEFT DOOR : LEFT HAND OPENING
 - RIGHT DOOR : RIGHT HAND OPENING
- DOOR OPENING ANGLE: 90° & 120° (WITH STOPPER)
- PROTECTION CLASS
 - ENCLOSURE : IP 54 (INDOOR APPLICATION)
- COLOUR
 - EXTERNAL SURFACE : RAL 7035 (LIGHT GREY) (MATT FINISH)
 - INTERNAL SURFACE : RAL 9010 (WHITE) (FULL GLOSSY)
 - PLINTH : RAL 9005 (BLACK) (MATT FINISH)
 - MIMIC PLATE : RAL 9010 (WHITE) (FULL GLOSSY)
 - MIMIC : GOLDEN YELLOW-SHADE 356 OF IS 5
 - EARTH SYMBOL : BLACK
- POWDER COATING THICKNESS (OUTSIDE/INSIDE SURFACE)
 - MINIMUM-70μ, MAXIMUM-150μ
- LABEL DETAILS
 - LCP NAME PLATE : LEFT FRONT DOOR TOP
 - LCP RATING PLATE : ON DRAWING POCKET
 - FIRM NAME PLATE : LEFT DOOR ABOVE THE VIEWING WINDOW
 - WARNING LABEL : RIGHT DOOR ABOVE FRONT DOOR HANDLE
- GASKETS: LCC DOORS & PROTECTIVE SHEET DOOR TO BE GASKETED WITH NEOPRENE/EPDB GASKETS AND SHOULD NOT VISIBLE FROM OUTSIDE
- A4 SIZE DRAWING POCKET TO BE PROVIDED AT FRONT DOOR REAR SIDE BOTTOM
- OUTER DOOR 3-POINT LOCK'S PADLOCK AND IT'S LOCKING PIN MUST BE SS MATERIAL -316 GRADE
- ALL DIMENSION ARE IN MM UNLESS SPECIFIED.

TENTATIVE

CHECKED
A.G.M (Elect)
ENGG. & QUALITY
OPTCL, BHUBANESWAR

APPROVED
Sr. G.M. (Elect)
ENGG. & QUALITY
OPTCL, BHUBANESWAR

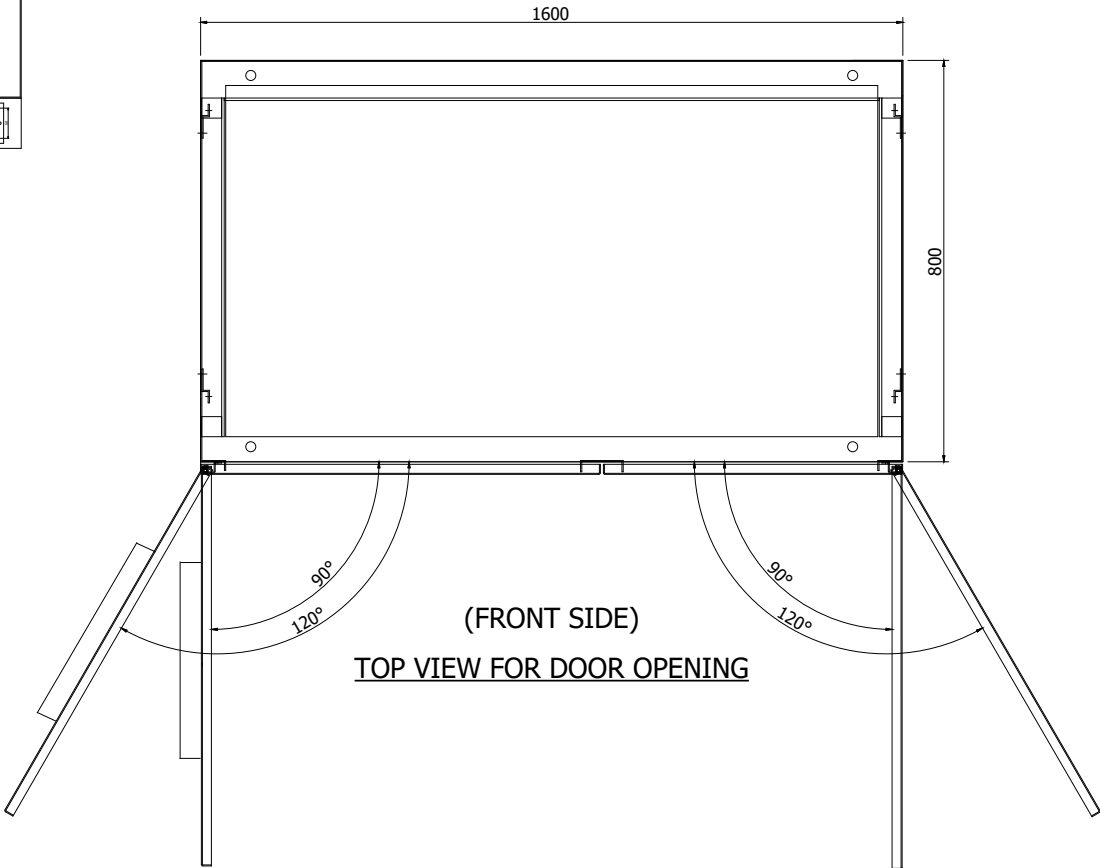

(FRONT SIDE)
TOP VIEW FOR DOOR OPENING



K. Mahesh Kumar
MANAGER/BHEL, TSD

02	AS PER CUST.COMMENT	23.05.2024	△	SIGN NAME				
01	AS PER CUST.COMMENT	18.05.2024	△	SIGN NAME				
00	FIRST ISSUE	06.02.2024	△	SIGN NAME				
REV	DETAILS OF MODIFICATION	DATE	REV.MARK	MODIFIED	CHECKED	APPROVED		

TOSHIBA

TRANSMISSION & DISTRIBUTION SYSTEMS
(INDIA) PRIVATE LIMITED

SWITCHGEAR PRODUCTS DIVISION

CLIENT : ODISHA POWER TRANSMISSION CO.LTD.
PROJECT : 400/220kV GIS S.S AT ERSAMA, ODISHA & 400kV
AIS FEEDER BAY EXTENSION AT DUBURI, ODISHA
CUSTOMER DRAWING NO. : TB-420-516-071-10A


PAGE DESCRIPTION :
OUTLINE OF LCP

BAY NAME : GA, INTERNAL ARRANGEMENT &
SCHEMATICS OF LCP FOR 220KV BUS
COUPLER & 220KV BUS PT-(D04&D05)
DRAWING NO. : DEEUGBI69513004

APPROVED	K.IKEDA	K.I	02.02.2024	SCALE : NTS
CHECKED	M.SREEDHAR	M.S	02.02.2024	REV : 02
DRAWN	K.MAHESH	K.M	01.02.2024	
DESIGN	SRIDEVI.Y	S.Y	11.01.2024	PAGE 15
	NAME	SIGN	DATE	117 PAGES

REFERENCE: -

 ALL INFORMATION CONTAINED IN THIS DOCUMENT IS CONFIDENTIAL AND THE PROPERTY OF TOSHIBA TRANSMISSION & DISTRIBUTION SYSTEMS (INDIA) PRIVATE LIMITED. REPRODUCTION OF THIS IN ANY FORM IS TO BE DONE WITH THE SPECIFIC PERMISSION OF THE ORGANISATION.



ANURAG KUMAR
MANAGER/BHEL - TBS

SYMBOL RED ON YELLOW GROUND

RED LETTER ON YELLOW GROUND

HAZARDOUS VOLTAGE
CAN SHOCK, BURN,
OTHER PHYSICAL
INJURIES OR CAUSE
DEATH. DO NOT TOUCH
ANY TERMINALS

WARNING

BLACK LETTER ON WHITE GROUND

BUSCOUPLER & 220KV BUS PT (D04&D05)



TAG NAME SHOULD BE PLACED ON BOTH PANEL & DEVICE CORRESPONDING
SPECIFICATION OF CARD PLATE:
ENGRAVED BLACK LETTER ON WHITE BACK GROUND
MATERIAL: LAMICOID
FIXING: GLUE
SIZE: SUITABLE SIZE

- 1) ALL INDIVIDUAL BOTTOM PLATES ARE GASKETTED & 3MM THICK CRCA
- 2) BOTTOM PLATES ARE DRILLED AT SITE
- 3) CABLES FROM GIS TO LCP (CABLE GLANDS & ASSOCIATED ACCESSORIES ARE SUPPLIED BY TOSHIBA-TTDI)
- 4) CABLES FROM CENTRAL CONTROL SYSTEM TO LCP (CABLES & COMPRESSION GLANDS & OTHER ASSOCIATED ACCESSORIES ARE OUT OF SCOPE OF SUPPLY)

1) COMPONENTS POSITION MAY VARY DURING DETAIL ENGINEERING AFTER APPROVAL OF SCHEMATIC.

02	AS PER CUST.COMMENT	23.05.2024	△	SIGN					TOSHIBA TRANSMISSION & DISTRIBUTION SYSTEMS (INDIA) PRIVATE LIMITED SWITCHGEAR PRODUCTS DIVISION	CLIENT : ODISHA POWER TRANSMISSION CO.LTD. PROJECT : 400/220KV GIS S.S AT ERSAMA, ODISHA & 400KV AIS FEEDER BAY EXTENSION AT DUBURI, ODISHA CUSTOMER DRAWING NO. : TB-420-516-071-10A	PAGE DESCRIPTION : INTERNAL ARRANGEMENT OF LCP	BAY NAME : GA, INTERNAL ARRANGEMENT & SCHEMATICS OF LCP FOR 220KV BUS COUPLER & 220KV BUS PT-(D04&D05) DRAWING NO. : DEEUGBI69513004	APPROVED	K.IKEDA	K.I	02.02.2024	SCALE : NTS REV : 02 PAGE 16 117 PAGE
01	AS PER CUST.COMMENT	18.05.2024	△	SIGN									CHECKED	M.SREEDHAR	M.S	02.02.2024	
00	FIRST ISSUE	06.02.2024	△	SIGN									DRAWN	K.MAHESH	K.M	01.02.2024	
REV	DETAILS OF MODIFICATION	DATE	REV.MARK	SIGN									DESIGN	SRIDEVI.Y	S.Y	11.01.2024	
				NAME										NAME	SIGN	DATE	

ALL DIMENSIONS ARE IN MM & WEIGHTS ARE IN kg PER UNIT
UNLESS OTHER WISE, SPECIFIED.

REFERENCE: -

FORMAT NO. : SG 07 3 04 R0

ANNUNCIATOR DESCRIPTION

LED COLOUR: RED

ANN1

F1●

F2●

F3●

F4●

F5●

F6●

F7●

F8●

●

LOW GAS PRES. LVL-1 ALARM (204-1R)

LOW GAS PRES. LVL-1 ALARM (204-1Y)

LOW GAS PRES. LVL-1 ALARM (204-1B)

LOW GAS PRES. LVL-1 ALARM (204-2R)

LOW GAS PRES. LVL-1 ALARM (204-2Y)

LOW GAS PRES. LVL-1 ALARM (204-2B)

LOW GAS PRES. LVL-1 ALARM (204-3R)

LOW GAS PRES. LVL-1 ALARM (204-3Y)

F9●

F10●

F11●

F12●

F13●

F14●

F15●

F16●

LOW GAS PRES. LVL-1 ALARM (203-4B)

LOW GAS PRES. LVL-1 ALARM (204-4R)

LOW GAS PRES. LVL-1 ALARM (204-4Y)

LOW GAS PRES. LVL-1 ALARM (204-4B)

LOW GAS PRES. LVL-1 GCB ALARM (204-5R)

LOW GAS PRES. LVL-1 GCB ALARM (204-5Y)

LOW GAS PRES. LVL-1 GCB ALARM (204-5B)

LOW GAS PRES. LVL-1 ALARM (204-6R)

TEST●

MUTE●

ACK.●

RST.●

MBAS 11

ALARM ANNUNCIATOR

ANN2

F1●

F2●

F3●

F4●

F5●

F6●

F7●

F8●

●

LOW GAS PRES. LVL-1 ALARM (204-6Y)

LOW GAS PRES. LVL-1 ALARM (204-6B)

LOW GAS PRES. LVL-1 ALARM (204-7R)

LOW GAS PRES. LVL-1 ALARM (204-7Y)

LOW GAS PRES. LVL-1 ALARM (204-7B)

LOW GAS PRES. LVL-1 ALARM (205-1R)

LOW GAS PRES. LVL-1 ALARM (205-1Y)

LOW GAS PRES. LVL-1 ALARM (205-1B)

F9●

F10●

F11●

F12●

F13●

F14●

F15●

F16●

LOW GAS PRES. LVL-1 ALARM (205-2R)

LOW GAS PRES. LVL-1 ALARM (205-2Y)

LOW GAS PRES. LVL-1 ALARM (205-2B)

LOW GAS PRES. LVL-2 ALARM (205-3R)

LOW GAS PRES. LVL-2 ALARM (205-3Y)

LOW GAS PRES. LVL-2 ALARM (205-3B)

LOW GAS PRES. LVL-2 ALARM (205-4R)

LOW GAS PRES. LVL-2 ALARM (205-4Y)

TEST●

MUTE●

ACK.●

RST.●

MBAS 11

ALARM ANNUNCIATOR

ANN3

F1●

F2●

F3●

F4●

F5●

F6●

F7●

F8●

●

LOW GAS PRES. LVL-1 ALARM (205-4B)

LOW GAS PRES. LVL-1 ALARM (205-5R)

LOW GAS PRES. LVL-1 ALARM (205-5Y)

LOW GAS PRES. LVL-1 ALARM (205-5B)

LOW GAS PRES. LVL-1 ALARM (205-6R)

LOW GAS PRES. LVL-1 ALARM (205-6Y)

LOW GAS PRES. LVL-1 ALARM (205-6B)

LOW GAS PRES. LVL-1 ALARM (205-7R)

F9●

F10●

F11●

F12●

F13●

F14●

F15●

F16●

LOW GAS PRES. LVL-1 ALARM (205-7Y)

LOW GAS PRES. LVL-1 ALARM (205-7B)

LOW GAS PRES. LVL-1 ALARM (205-8R)

LOW GAS PRES. LVL-1 ALARM (205-8Y)

LOW GAS PRES. LVL-1 ALARM (205-8B)

LOW GAS PRES. LVL-2 ALARM (204-1R/Y/B)

LOW GAS PRES. LVL-2 ALARM (204-2R/Y/B)

LOW GAS PRES. LVL-2 ALARM (204-3R/Y/B)

TEST●

MUTE●

ACK.●

RST.●

MBAS 11

ALARM ANNUNCIATOR

ANN4

F1●

F2●

F3●

F4●

F5●

F6●

F7●

F8●

●

LOW GAS PRES. LVL-2 ALARM (204-4R/Y/B)

LOW GAS PRES. LVL-2 GCB CLOSE BLOCK & TRIP BLOCK (204-5R)

LOW GAS PRES. LVL-2 GCB CLOSE BLOCK & TRIP BLOCK (204-5Y)

LOW GAS PRES. LVL-2 GCB CLOSE BLOCK & TRIP BLOCK (204-5B)

LOW GAS PRES. LVL-2 ALARM (204-6R/Y/B)

LOW GAS PRES. LVL-2 ALARM (204-7R/Y/B)

LOW GAS PRES. LVL-2 ALARM (205-1R/Y/B)

LOW GAS PRES. LVL-2 ALARM (205-2R/Y/B)

F9●

F10●

F11●

F12●

F13●

F14●

F15●

F16●

LOW GAS PRES. LVL-2 ALARM (205-3R/Y/B)

LOW GAS PRES. LVL-2 ALARM (205-4R/Y/B)

LOW GAS PRES. LVL-2 ALARM (205-5R/Y/B)

LOW GAS PRES. LVL-2 ALARM (205-6R/Y/B)

LOW GAS PRES. LVL-2 ALARM (205-7R/Y/B)

LOW GAS PRES. LVL-2 ALARM (205-8R/Y/B)

GCB SPRING CHARGING INCOMP. MOTOR EXC. RUN

GCB MOTOR OVER CURRENT

TEST●

MUTE●

ACK.●

RST.●

MBAS 11

ALARM ANNUNCIATOR

ANN5

F1●

F2●

F3●

F4●

F5●

F6●

F7●

F8●

●

GCB MOTOR SUPPLY FAIL

GCB POLE DISCREPANCY

GCB SPRING CHARGED

DS/ES/HES OPERATION INCOMPLETE

DS/ES/HES MOTOR O/L & CKT TROUBLE

220V DC CONTROL SUPPLY MCB OFF/TRIP

S43RL SELECTOR SWITCH IN LOCAL

S43RL SELECTOR SWITCH IN REMOTE

F9●

F10●

F11●

F12●

F13●

F14●

F15●

F16●

EMERGENCY TRIP OPERATED

DC SOURCE-I FAIL

DC SOURCE-II FAIL

GCB TRIP-1 CKT. MCB OFF/TRIP

GCB TRIP-2 CKT. MCB OFF/TRIP

MB-A VT CORE-1 MCB OFF/TRIP

MB-A VT CORE-2 MCB OFF/TRIP

MB-A VT CORE-3 MCB OFF/TRIP

TEST●

MUTE●

ACK.●

RST.●

MBAS 11

ALARM ANNUNCIATOR

ANN6

F1●

F2●

F3●

F4●

F5●

F6●

F7●

F8●

●

MB-B VT CORE-1 MCB OFF/TRIP

MB-B VT CORE-2 MCB OFF/TRIP

MB-B VT CORE-3 MCB OFF/TRIP

SPARE

SPARE

SPARE

SPARE

SPARE

F9●

F10●

F11●

F12●

F13●

F14●

F15●

F16●

SPARE

SPARE

SPARE

SPARE

SPARE

SPARE

SPARE

SPARE

TEST●

MUTE●

ACK.●

RST.●

MBAS 11

ALARM ANNUNCIATOR

COVER SHEET

APPROVED



Sr. G.M. (Elect)
ENGG. & QUALITY
OPTCL, BHUBANESWAR

			△	SIGN				TOSHIBA TRANSMISSION & DISTRIBUTION SYSTEMS (INDIA) PRIVATE LIMITED SWITCHGEAR PRODUCTS DIVISION	CLIENT : ODISHA POWER TRANSMISSION CO.LTD. PROJECT : 400/220kV GIS S.S AT ERSAMA, ODISHA & 400kV AIS FEEDER BAY EXTENSION AT DUBURI, ODISHA CUSTOMER DRAWING NO. : TB-420-516-071-10A	PAGE DESCRIPTION : COVER SHEET	BAY NAME : GA, INTERNAL ARRANGEMENT & SCHEMATICS OF LCP FOR 220KV ICT-2 & BUS SECTION (D08&D09)	APPROVED	K.IKEDA	K.I	06.02.2024	SCALE : NTS
01	AS PER CUST.COMMENTS	18.05.2024	△	SIGN								CHECKED	M.SREEDHAR	M.S	05.02.2024	REV : 01
00	FIRST ISSUE	06.02.2024	△	SIGN								DRAWN	K.MAHESH	K.M	03.02.2024	PAGE 1
REV	DETAILS OF MODIFICATION	DATE	REV.MARK	SIGN	MODIFIED	CHECKED	APPROVED					DESIGN	SRIDEVI.Y	S.Y	11.01.2024	114 PAGES
				NAME									NAME	SIGN	DATE	

A
DT

B

C

D

E

F

G

H

J

A

B

|C

D

E

F

G

 H

9

REFERENCE: -

ALL INFORMATION CONTAINED IN THIS DOCUMENT IS CONFIDENTIAL AND THE PROPERTY OF TOSHIBA TRANSMISSION & DISTRIBUTION SYSTEMS (INDIA) PRIVATE LIMITED. REPRODUCTION OF THIS IN ANY FORM IS TO BE DONE WITH THE SPECIFIC PERMISSION OF THE ORGANISATION.

			△	SIGN				TOSHIBA TRANSMISSION & DISTRIBUTION SYSTEMS (INDIA) PRIVATE LIMITED SWITCHGEAR PRODUCTS DIVISION	CLIENT : ODISHA POWER TRANSMISSION CO.LTD. PROJECT : 400/220kV GIS S.S AT ERSAMA, ODISHA & 400kV AIS FEEDER BAY EXTENSION AT DUBURI, ODISHA CUSTOMER DRAWING NO. : TB-420-516-071-10A	PAGE DESCRIPTION : ELECTRICAL SYMBOLS	BAY NAME : GA, INTERNAL ARRANGEMENT & SCHEMATICS OF LCP FOR 220KV ICT-2 & BUS SECTION (D08&D09)	APPROVED	K.IKEDA	K.I	06.02.2024	SCALE : NTS
01	AS PER CUST.COMMENTS	18.05.2024	△	SIGN								CHECKED	M.SREEDHAR	M.S	05.02.2024	REV : 01
00	FIRST ISSUE	06.02.2024	△	SIGN								DRAWN	K.MAHESH	K.M	03.02.2024	PAGE 4
REV	DETAILS OF MODIFICATION	DATE	REV.MARK	NAME	MODIFIED	CHECKED	APPROVED					DESIGN	SRIDEVI.Y	S.Y	11.01.2024	114 PAGES

ALL DIMENSIONS ARE IN MM & WEIGHTS ARE IN kg PER UNIT
UNLESS OTHER WISE, SPECIFIED.

FORMAT NO. : SG 07 3 04 R0

ALL INFORMATION CONTAINED IN THIS DOCUMENT IS CONFIDENTIAL AND THE PROPERTY OF
TOSHIBA TRANSMISSION & DISTRIBUTION SYSTEMS (INDIA) PRIVATE LIMITED. REPRODUCTION
OF THIS IN ANY FORM IS TO BE DONE WITH THE SPECIFIC PERMISSION OF THE ORGANISATION.

A

B

C

D

E



F

G


H

J

SWITCHES

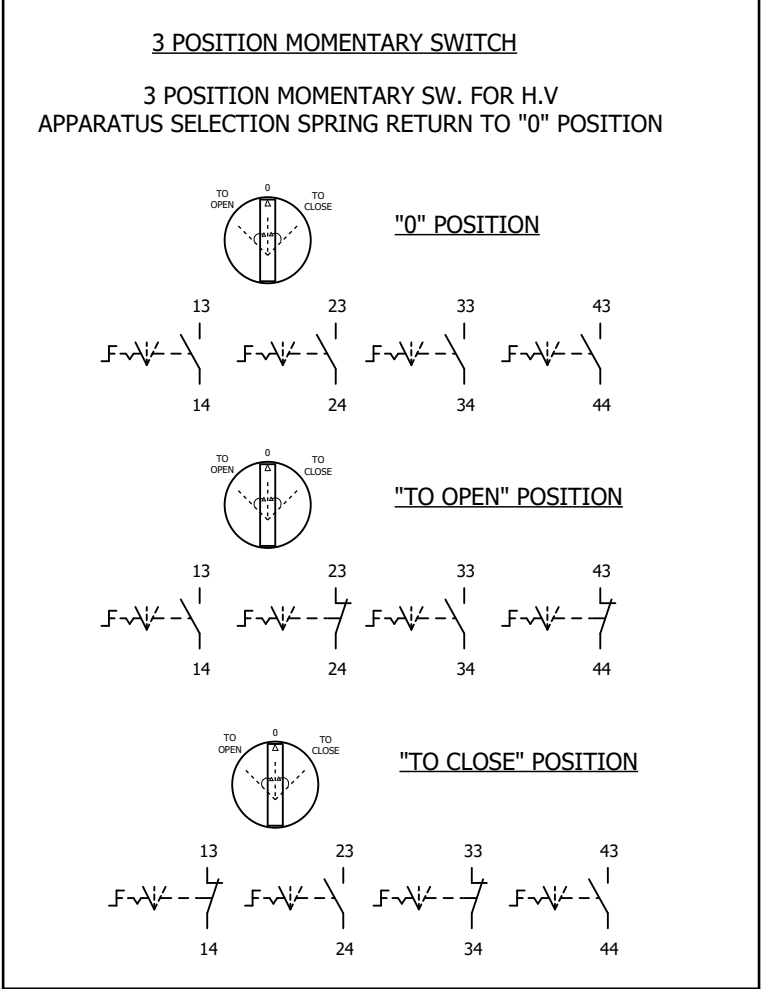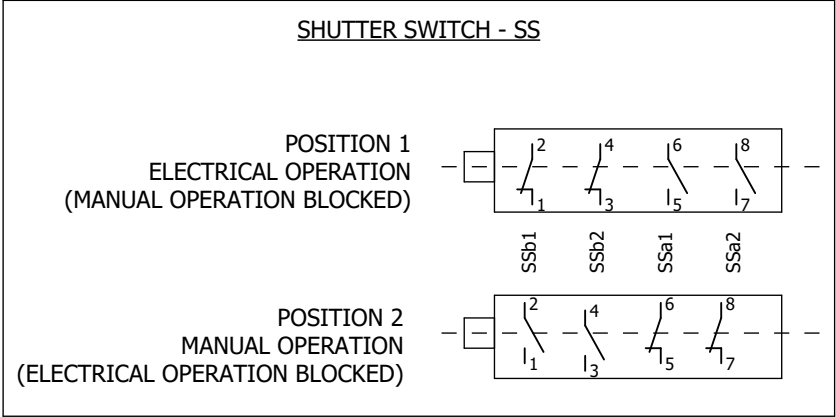


EXPLANATION OF CONTACTS TABLE

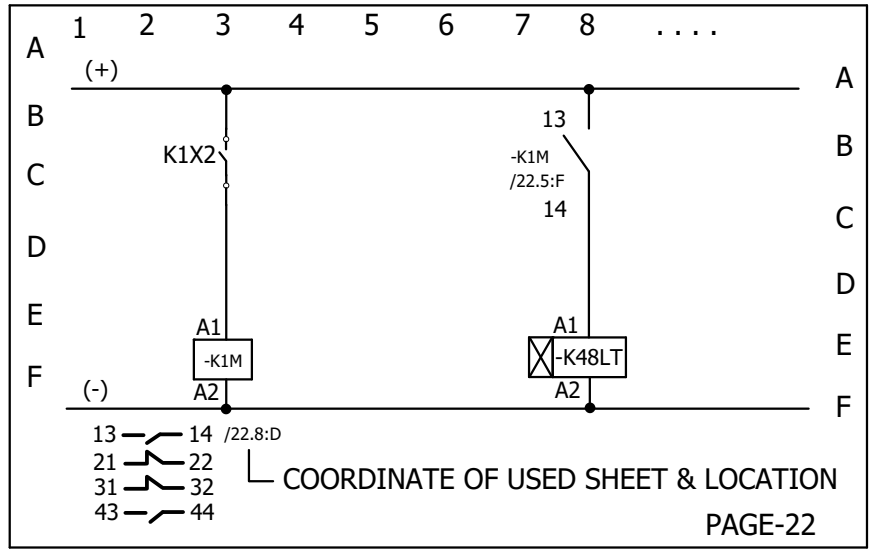

LETTER CODE OF THE DIFFERENT ITEMS

INDICATION	DESCRIPTION
A	ANNUNCIATOR
B	BCU/THERMOSTAT/HUMIDISTAT
E	HEATER/CUBICLE LIGHT/EMER.PUSH BUTTON/RECEP
F	PROTECTIVE DEVICES
K	RELAYS, CONTACTORS & TIMERS
P	POWER METER
S	SWITCHES
T	TRANSFORMERS
W	CONTROL CABLES
X	TERMINALS & PLUGS
Q	HIGH VOLTAGE DEVICES
H	INDICATOR

EXPLANATION OF TERMINAL DIAGRAM

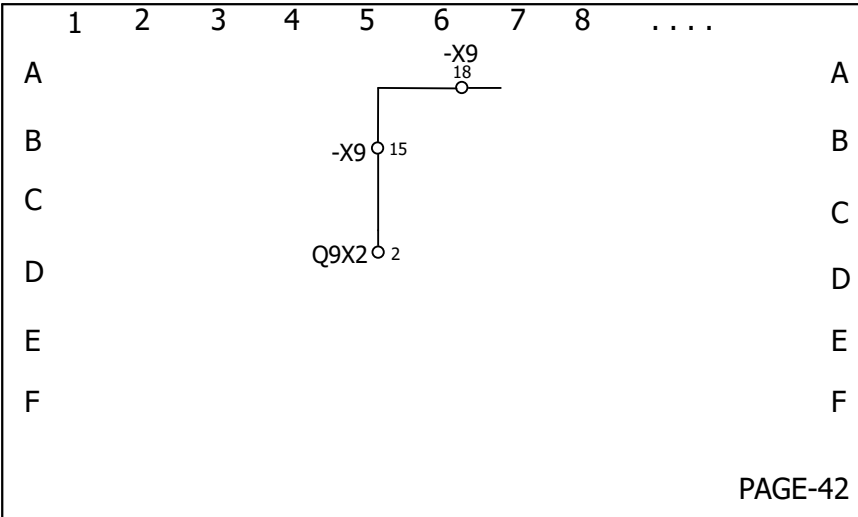

(FROM)
INTERNAL
TARGET



X9 15

EXTERNAL
TARGET
(TO)

INTERNAL TARGET		X9	EXTERNAL TARGET	
X9-18	42.6:A	15	Q9X1-2	42.5.A


CHECKED
A.G.M (Elect)
ENGG. & QUALITY
OPTCL, BHUBANESWAR

APPROVED
Sr. G.M. (Elect)
ENGG. & QUALITY
OPTCL, BHUBANESWAR

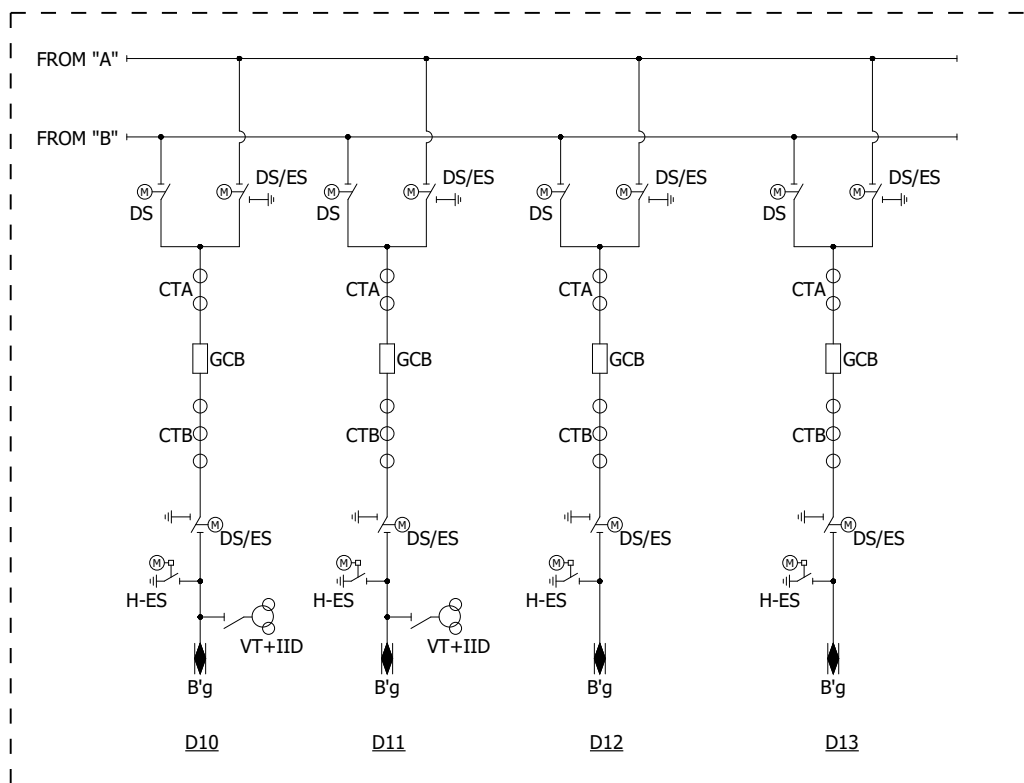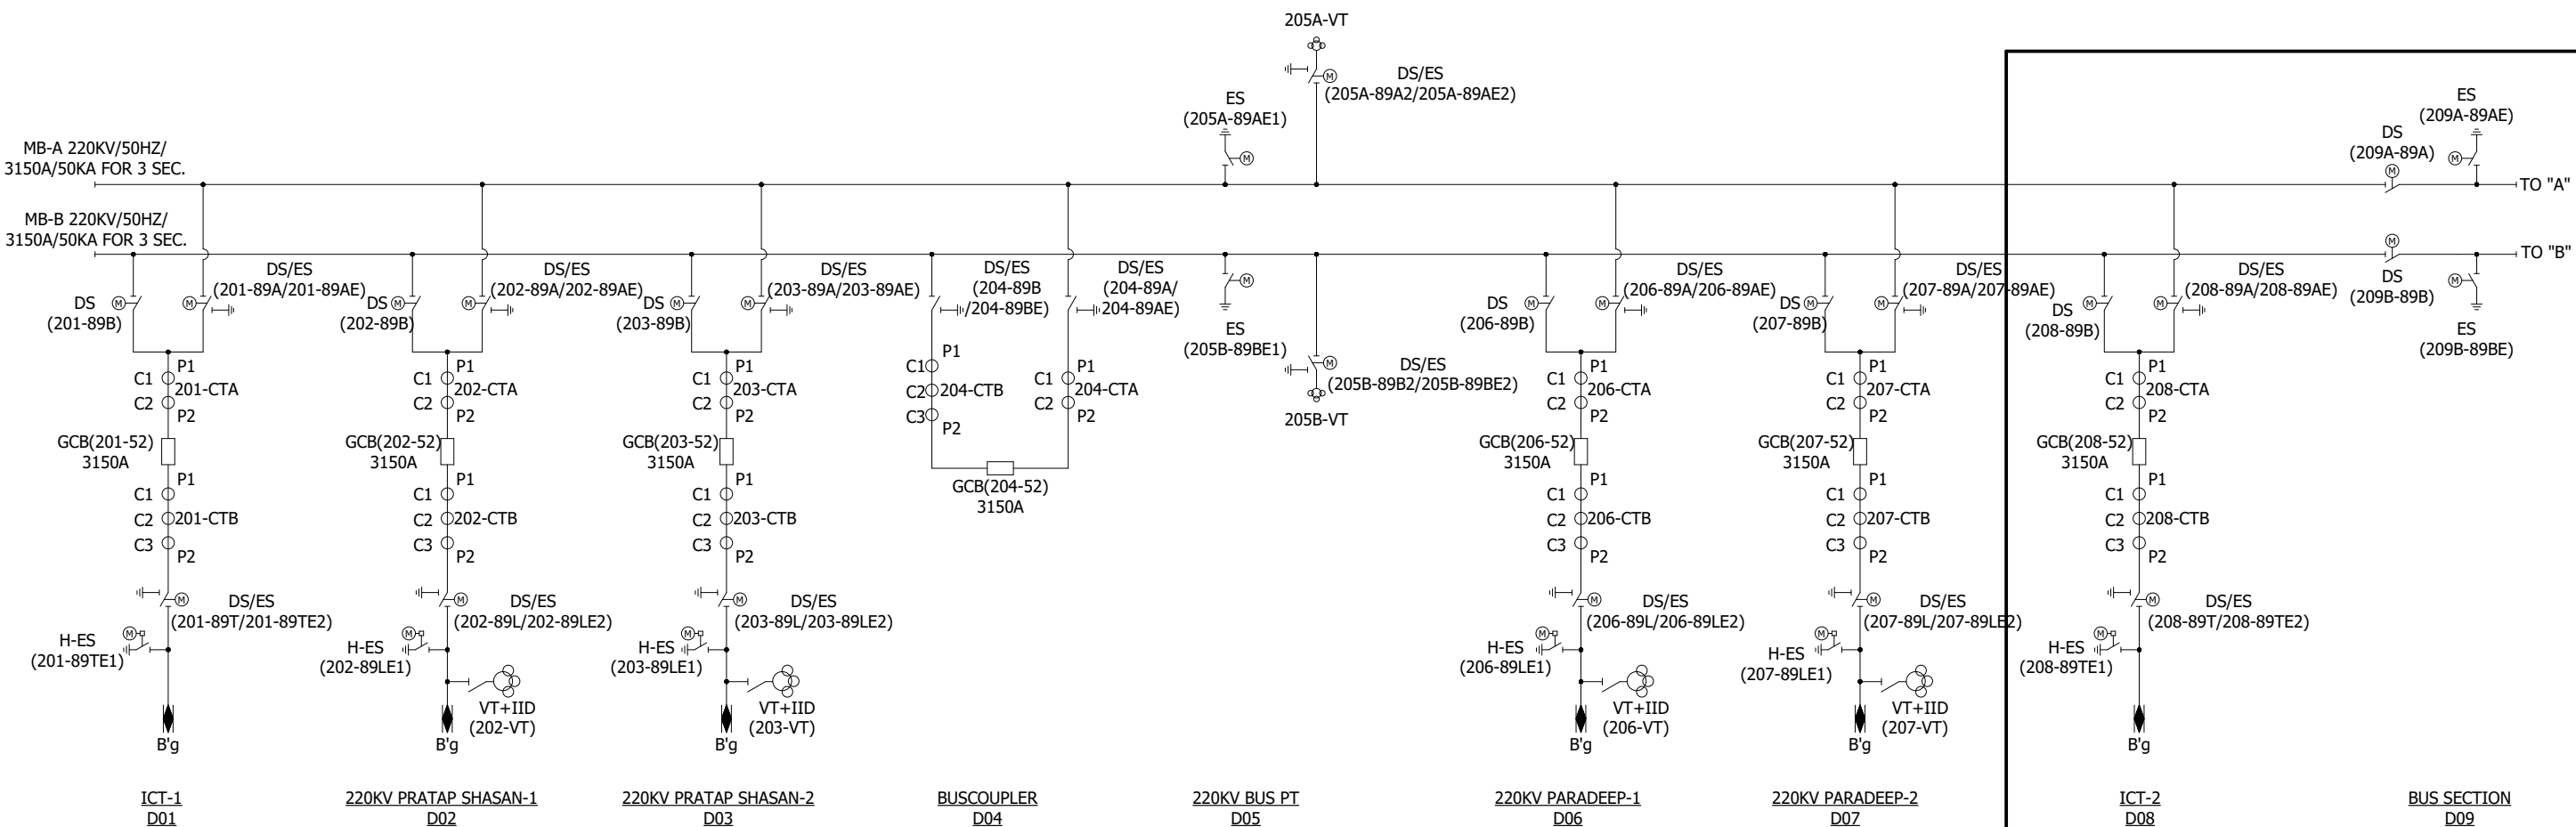

CHECKED  A.G.M (Elect) ENGG. & QUALITY OPTCL, BHUBANESWAR	APPROVED  Sr. G.M. (Elect) ENGG. & QUALITY OPTCL, BHUBANESWAR
---	---

			△	SIGN				TOSHIBA TRANSMISSION & DISTRIBUTION SYSTEMS (INDIA) PRIVATE LIMITED SWITCHGEAR PRODUCTS DIVISION	CLIENT : ODISHA POWER TRANSMISSION CO.LTD. PROJECT : 400/220kV GIS S.S AT ERSAMA, ODISHA & 400kV AIS FEEDER BAY EXTENSION AT DUBURI, ODISHA CUSTOMER DRAWING NO. : TB-420-516-071-10A	PAGE DESCRIPTION : SINGLE LINE DIAGRAM	BAY NAME : GA, INTERNAL ARRANGEMENT & SCHEMATICS OF LCP FOR 220KV ICT-2 & BUS SECTION (D08&D09)	APPROVED	K.IKEDA	K.I	06.02.2024	SCALE : NTS	
01	AS PER CUST.COMMENTS	18.05.2024	△	SIGN								CHECKED	M.SREEDHAR	M.S	05.02.2024	REV : 01	
00	FIRST ISSUE	06.02.2024	△	SIGN									DRAWN	K.MAHESH	K.M	03.02.2024	
				SIGN									DESIGN	SRIDEVI.Y	S.Y	11.01.2024	PAGE 6
REV	DETAILS OF MODIFICATION	DATE	REV.MARK	NAME	MODIFIED	CHECKED	APPROVED							NAME	SIGN	DATE	114 PAGES

 

LEGEND:

SYMBOL/ ABBREVIATION	EQUIPMENT NAME	OPERATION METHOD
 GCB	GAS INSULATED CIRCUIT BREAKER	MOTOR CHARGED SPRING OPERATION
 DS/ES	DISCONNECTOR WITH EARTHING SWITCH	MOTOR OPERATION
 DS	DISCONNECTOR	MOTOR OPERATION
 ES	EARTHING SWITCH	MOTOR OPERATION
 H-ES	HIGH SPEED EARTHING SWITCH	MOTOR CHARGED SPRING OPERATION
 CT	CURRENT TRANSFORMER	
 VT+IID	VOLTAGE TRANSFORMER WITH INTEGRATED ISOLATING DEVICE (MANUAL OPERATION)	
 VT	VOLTAGE TRANSFORMER	
	DN-8 VALVE FOR GAS DENSITY MONITOR	
	DN-20 VALVE FOR GAS HANDLING	
	GAS TIGHT SPACER	
	RUPTURE DISC	
	ADSORBENT	
MB-A&B	MAIN BUS-A&B	
	PARTIAL DISCHARGE SENSOR	

SETTING VALUE OF GAS MONITOR:

COMPONENT	SETTING VALUE OF PRESSURE SWITCH	RATED PRESSURE (abs)
GCB	FIRST LOW PRESSURE ALARM : 6.70 bar. abs at 20°C SECOND LOW PRESSURE ALARM: 6.40 bar. abs at 20°C (BLOCKING PRESSURE) GUARANTEE LIWL: 1050kVp	7.0 bar at 20°C
OTHERS	FIRST LOW PRESSURE ALARM : 6.70 bar. abs at 20°C SECOND LOW PRESSURE ALARM: 6.40 bar. abs at 20°C GUARANTEE LIWL: 1050kVp	7.0 bar at 20°C



Arvilesh Kumar
(ARVILESH KUMAR)
MANAGER/BHEL-TBS

CHECKED

A.G.M (Elect)
ENGG. & QUALITY
OPTCL, BHUBANESWAR

APPROVED



Sr. G.M. (Elect)
ENGG. & QUALITY
OPTCL, BHUBANESWAR


			△	SIGN				TOSHIBA TRANSMISSION & DISTRIBUTION SYSTEMS (INDIA) PRIVATE LIMITED SWITCHGEAR PRODUCTS DIVISION	CLIENT : ODISHA POWER TRANSMISSION CO.LTD. PROJECT : 400/220kV GIS S.S AT ERSAMA, ODISHA & 400kV AIS FEEDER BAY EXTENSION AT DUBURI, ODISHA CUSTOMER DRAWING NO. : TB-420-516-071-10A	PAGE DESCRIPTION : GAS COMPARTMENT	BAY NAME : GA, INTERNAL ARRANGEMENT & SCHEMATICS OF LCP FOR 220KV ICT-2 & BUS SECTION (D08&D09)	APPROVED	K.IKEDA	K.I	06.02.2024	SCALE : NTS
01	AS PER CUST.COMMENTS	18.05.2024	△	SIGN								CHECKED	M.SREEDHAR	M.S	05.02.2024	REV : 01
00	FIRST ISSUE	06.02.2024	△	SIGN								DRAWN	K.MAHESH	K.M	03.02.2024	
REV	DETAILS OF MODIFICATION	DATE	REV.MARK	NAME	MODIFIED	CHECKED	APPROVED					DESIGN	SRIDEVI.Y	S.Y	11.01.2024	PAGE 7
													NAME	SIGN	DATE	114 PAGES

ALL DIMENSIONS ARE IN MM & WEIGHTS ARE IN kg PER UNIT
UNLESS OTHERWISE SPECIFIED.

ALL INFORMATION CONTAINED IN THIS DOCUMENT IS CONFIDENTIAL AND THE PROPERTY OF
TOSHIBA TRANSMISSION & DISTRIBUTION SYSTEMS (INDIA) PRIVATE LIMITED. REPRODUCTION
OF THIS IN ANY FORM IS TO BE DONE WITH THE SPECIFIC PERMISSION OF THE ORGANISATION.

FORMAT NO. : SG 07 3 04 R0


REFERENCE: -

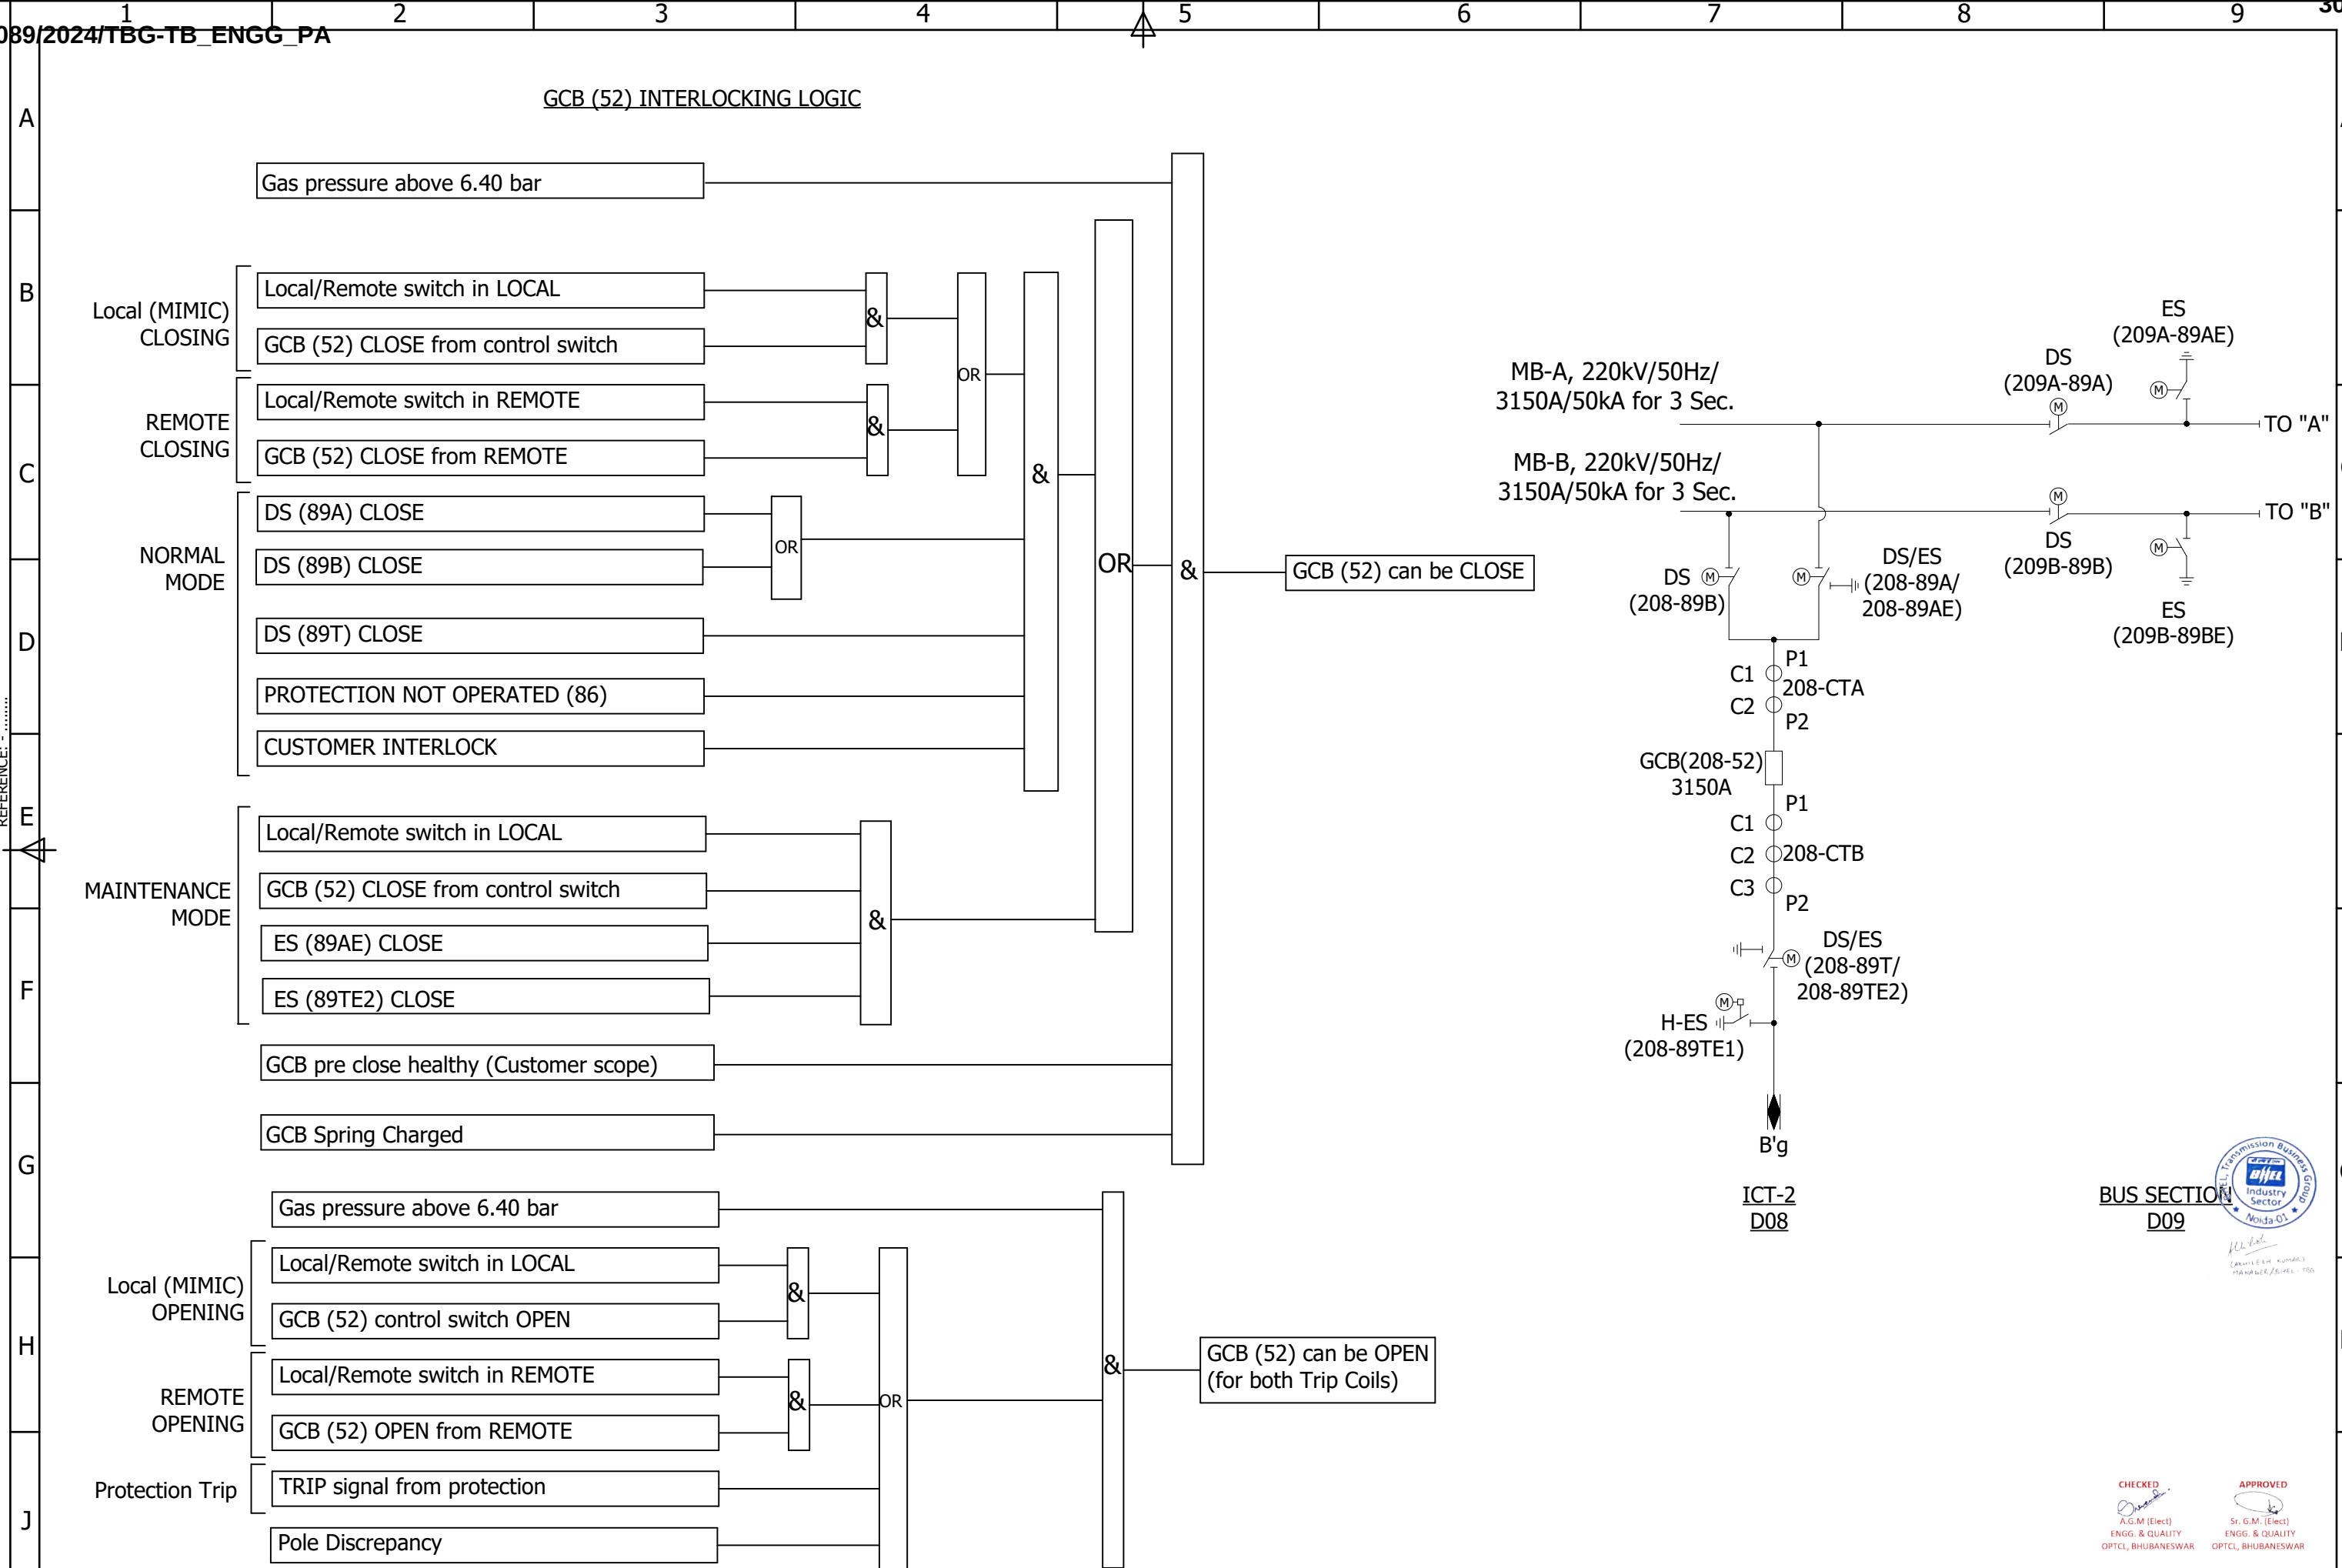


ALL DIMENSIONS ARE IN MM & WEIGHTS ARE IN kg PER UNIT
UNLESS OTHER WISE, SPECIFIED.

FORMAT NO. : SG 07 3 04 R0

ALL INFORMATION CONTAINED IN THIS DOCUMENT IS CONFIDENTIAL AND THE PROPERTY OF
TOSHIBA TRANSMISSION & DISTRIBUTION SYSTEMS (INDIA) PRIVATE LIMITED. REPRODUCTION
OF THIS IN ANY FORM IS TO BE DONE WITH THE SPECIFIC PERMISSION OF THE ORGANISATION.

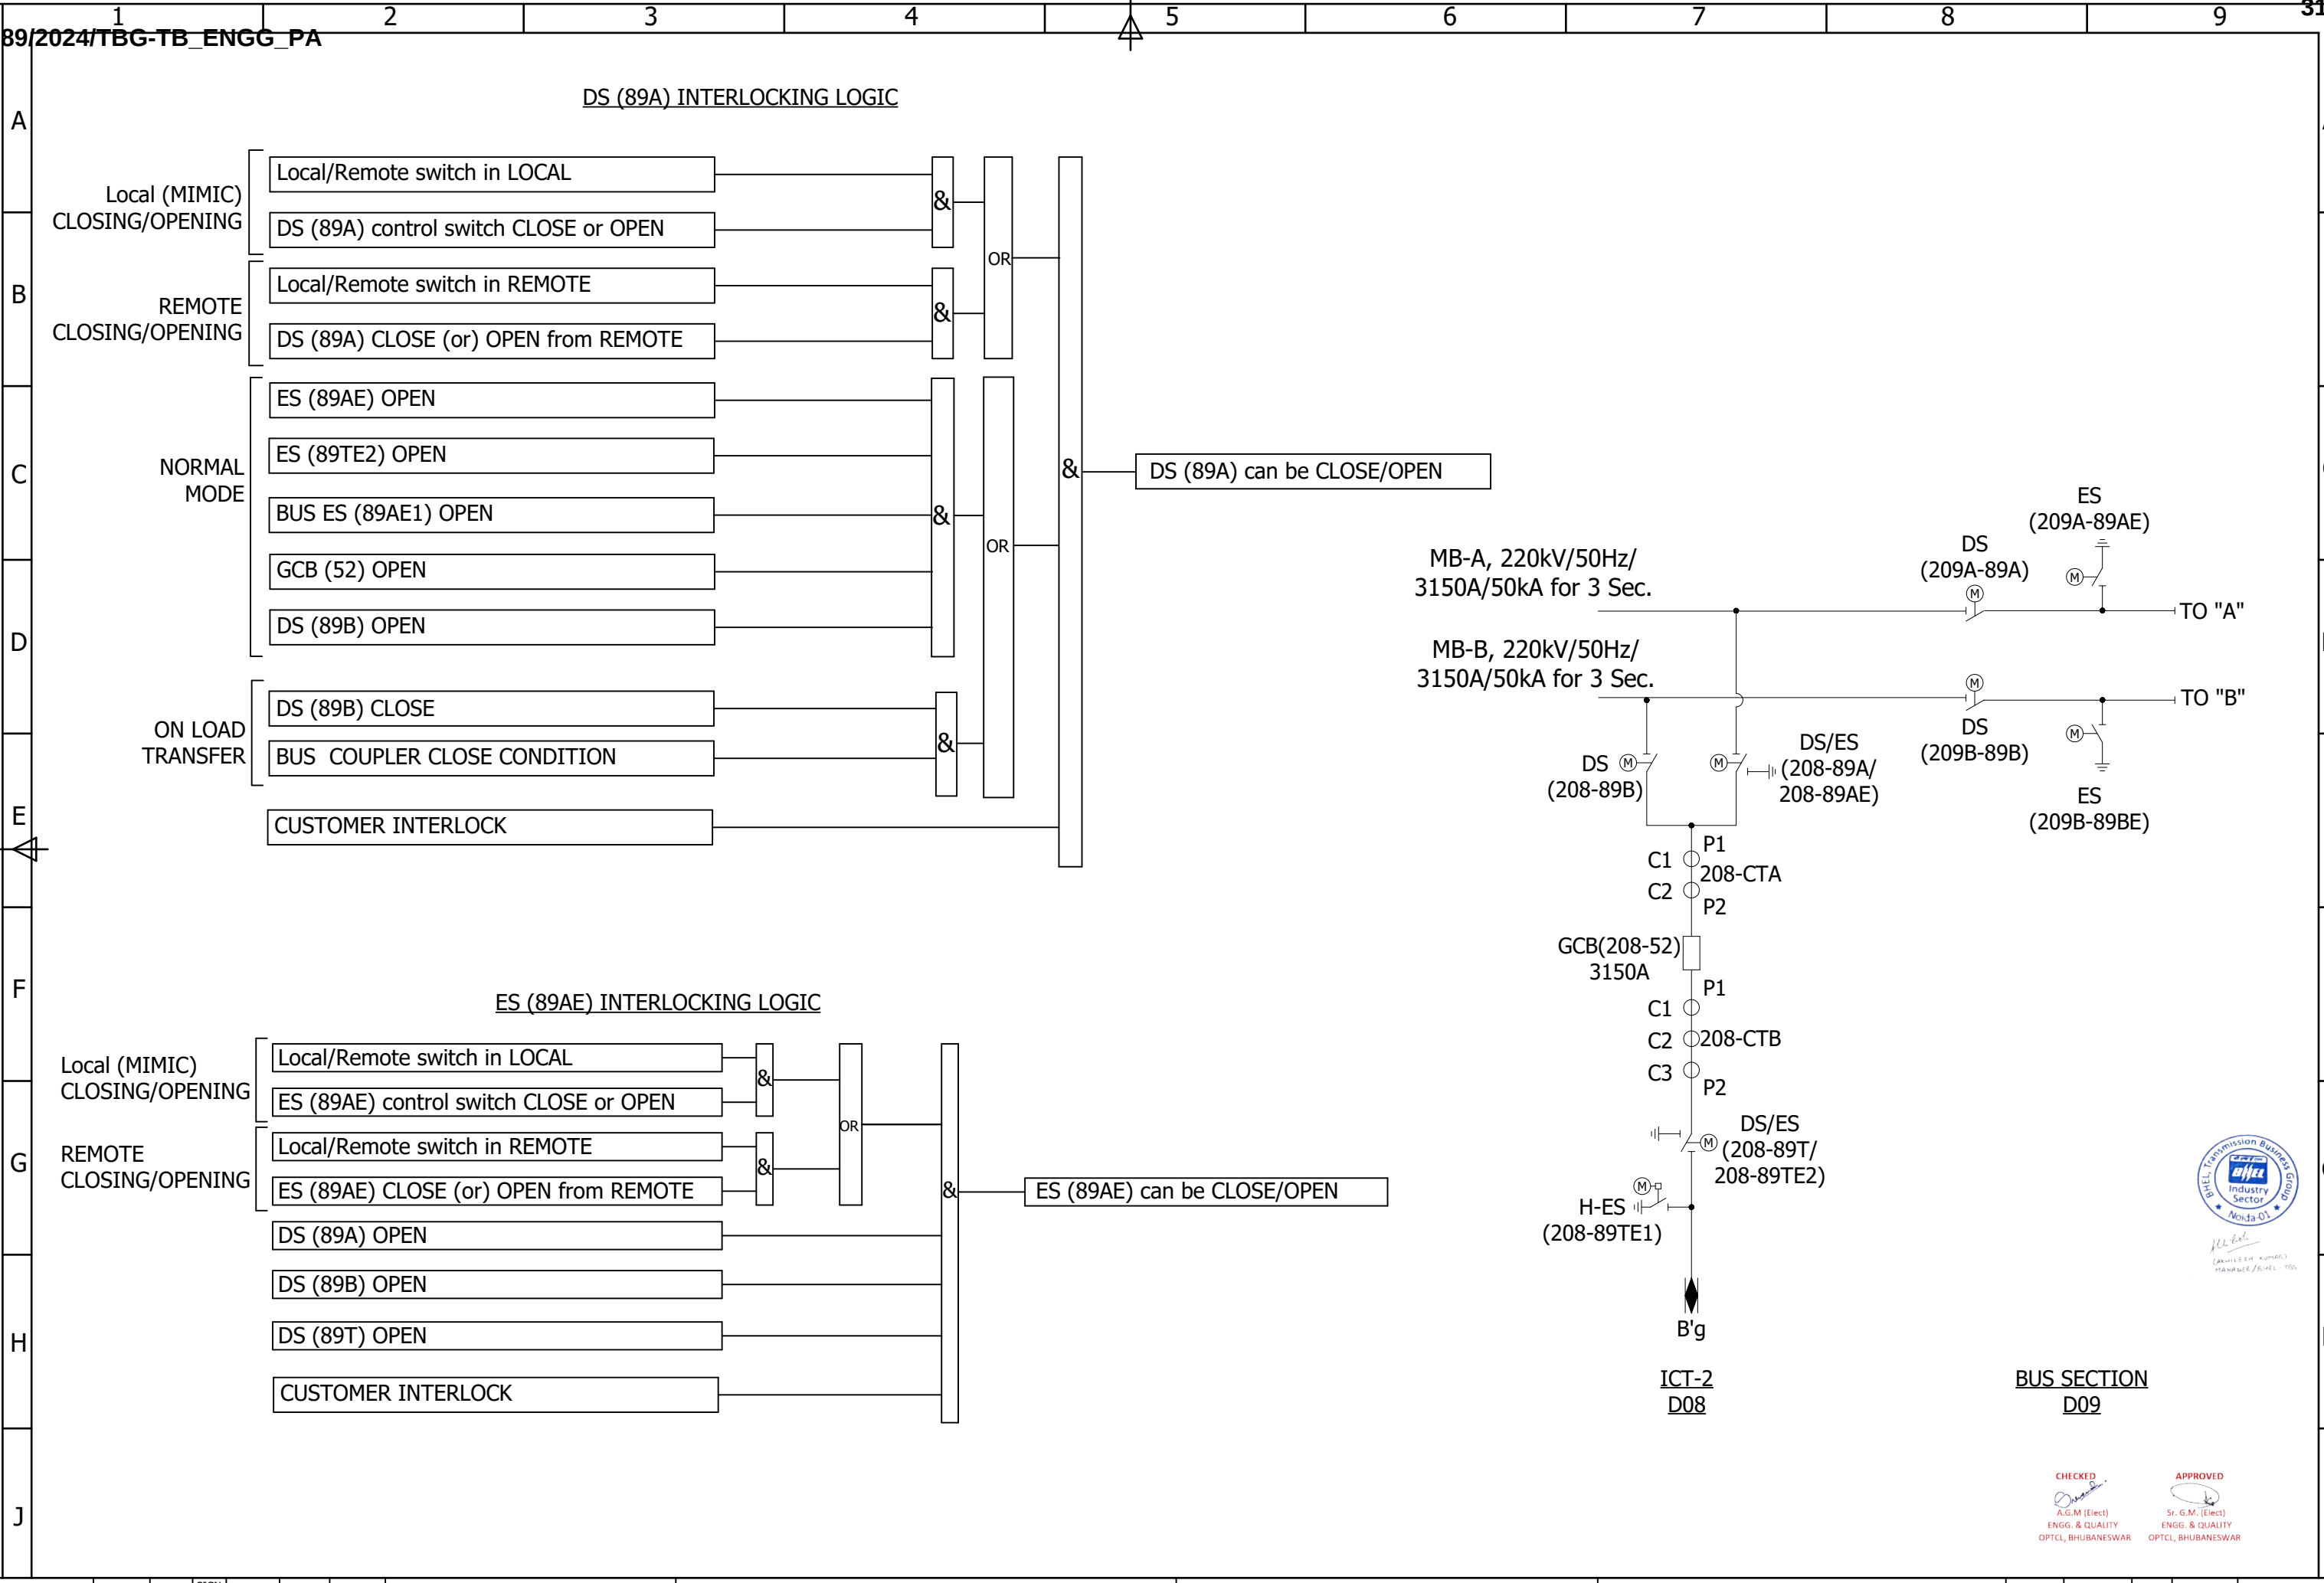


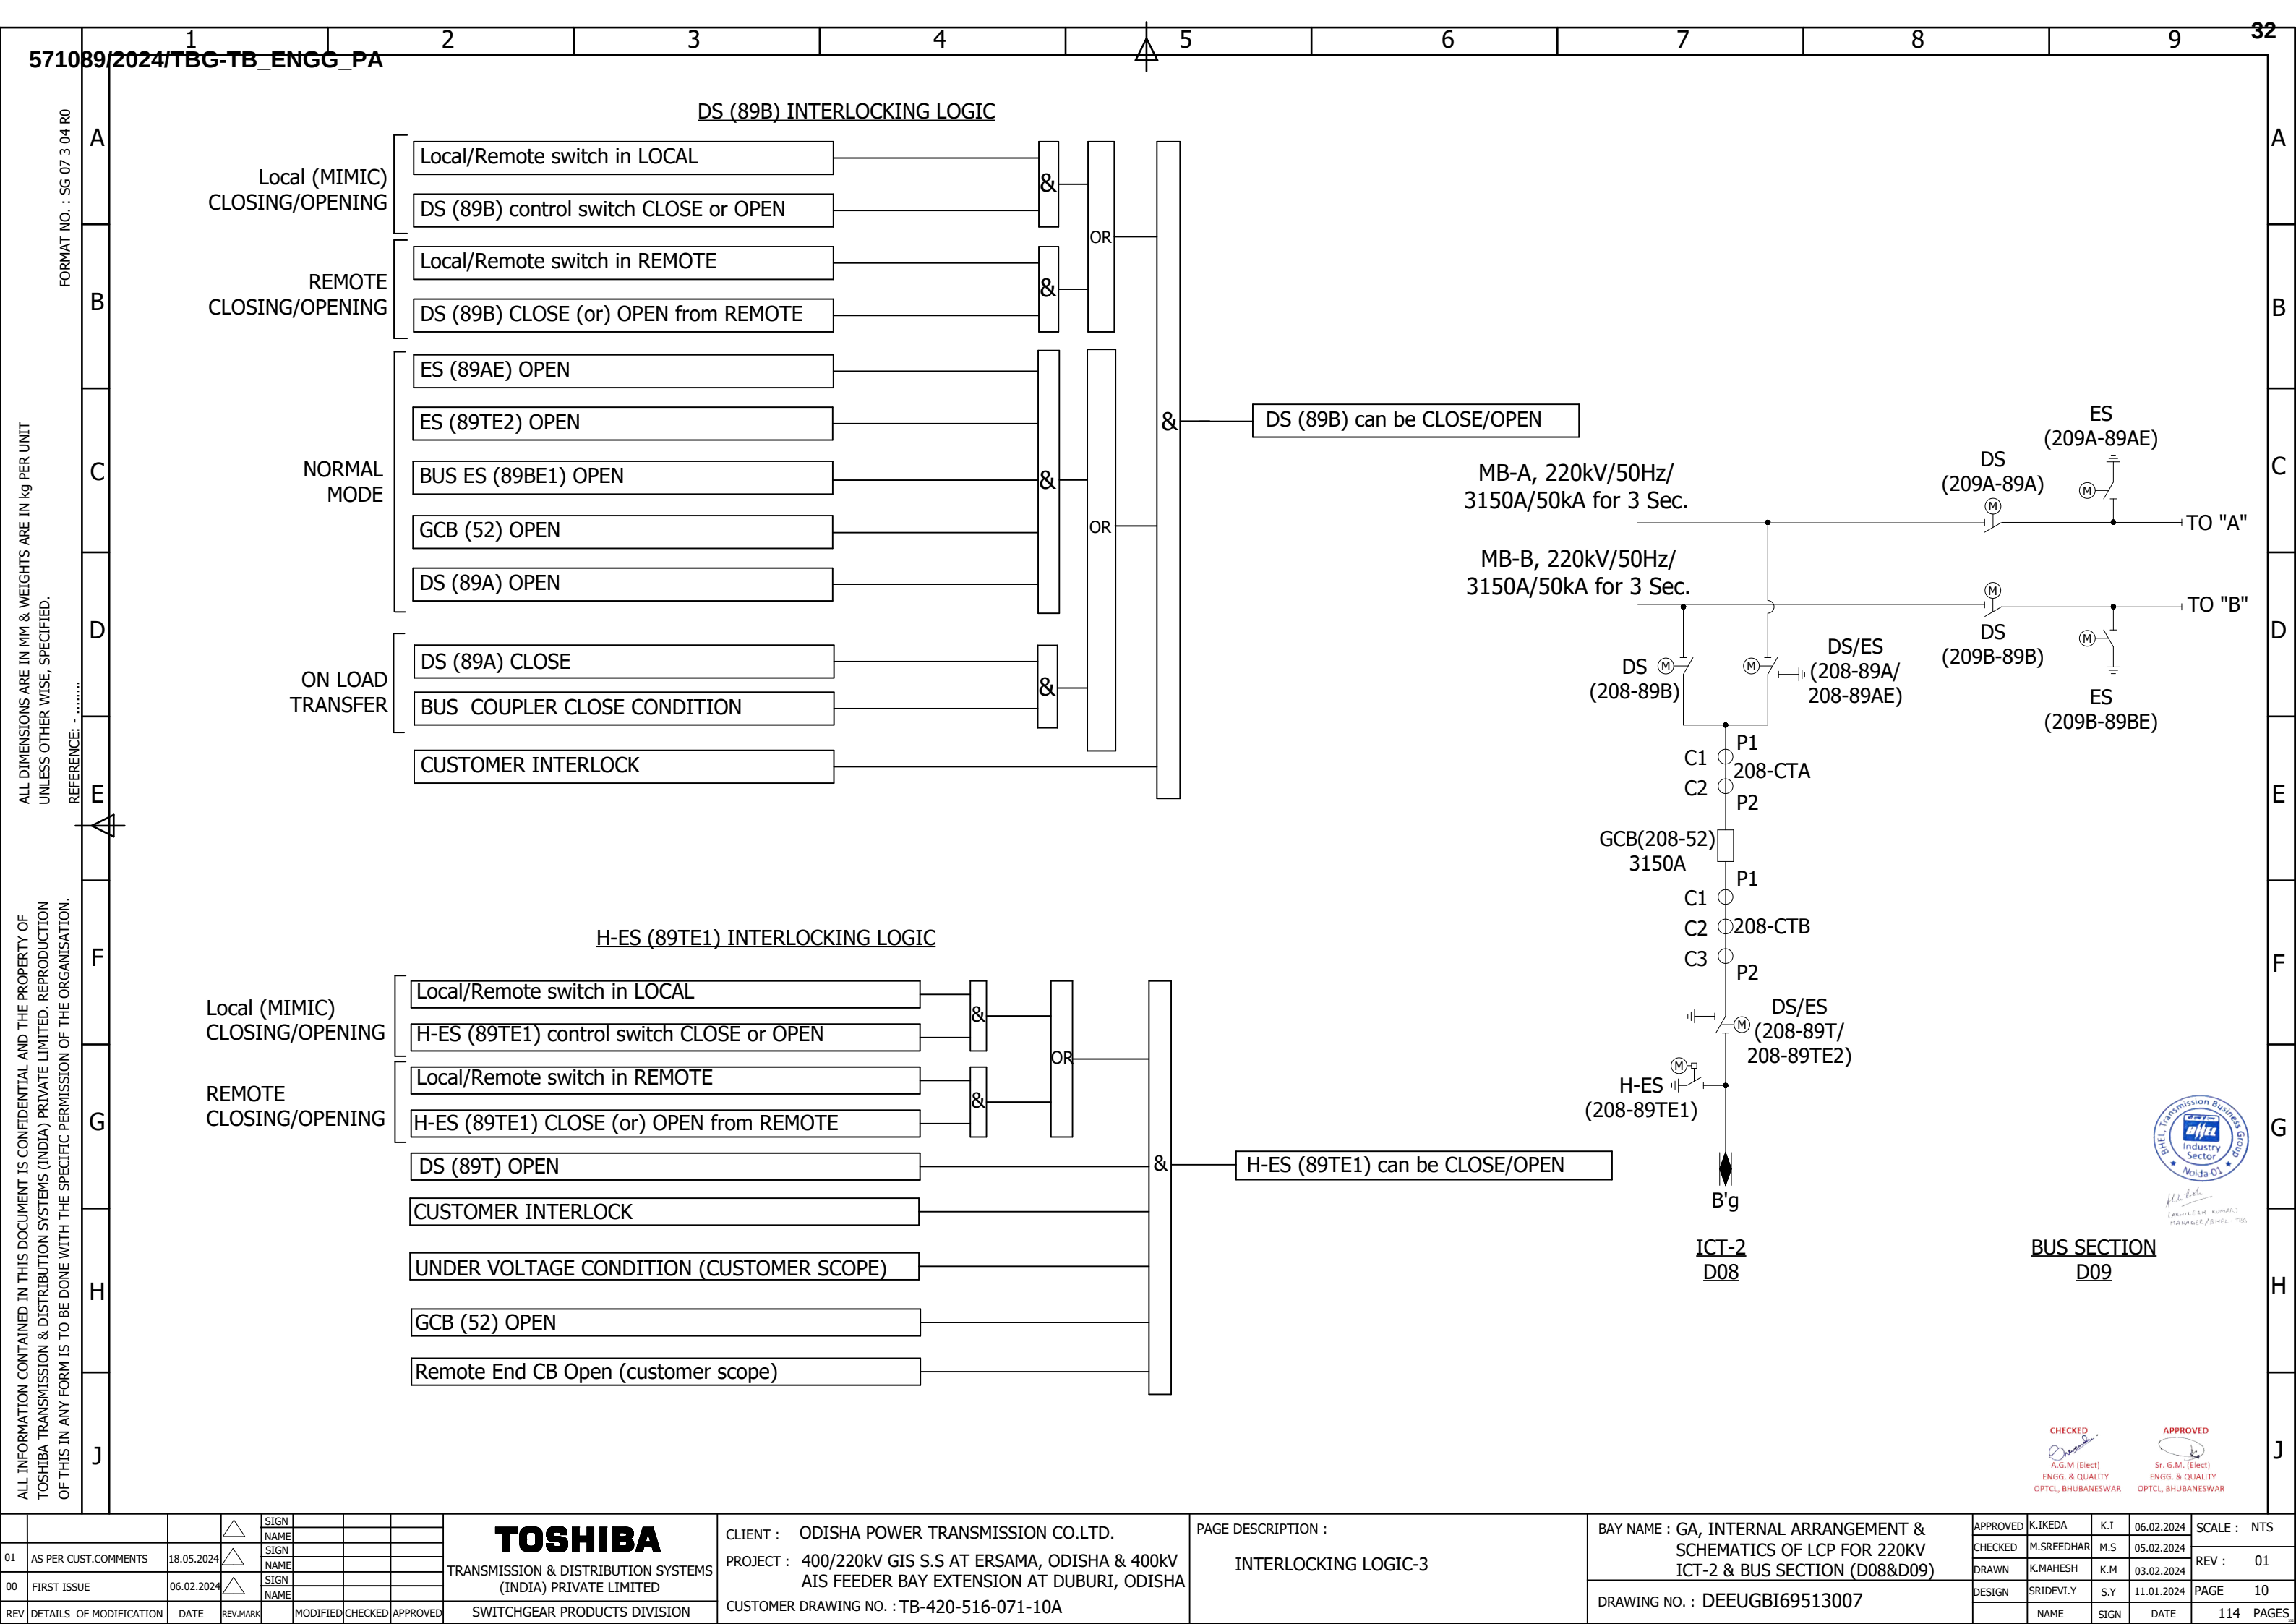


ALL DIMENSIONS ARE IN MM & WEIGHTS ARE IN kg PER UNIT
UNLESS OTHER WISE, SPECIFIED.

ALL INFORMATION CONTAINED IN THIS DOCUMENT IS CONFIDENTIAL AND THE PROPERTY OF
TOSHIBA TRANSMISSION & DISTRIBUTION SYSTEMS (INDIA) PRIVATE LIMITED. REPRODUCTION
OF THIS IN ANY FORM IS TO BE DONE WITH THE SPECIFIC PERMISSION OF THE ORGANISATION.

FORMAT NO. : SG 07 3 04 R0

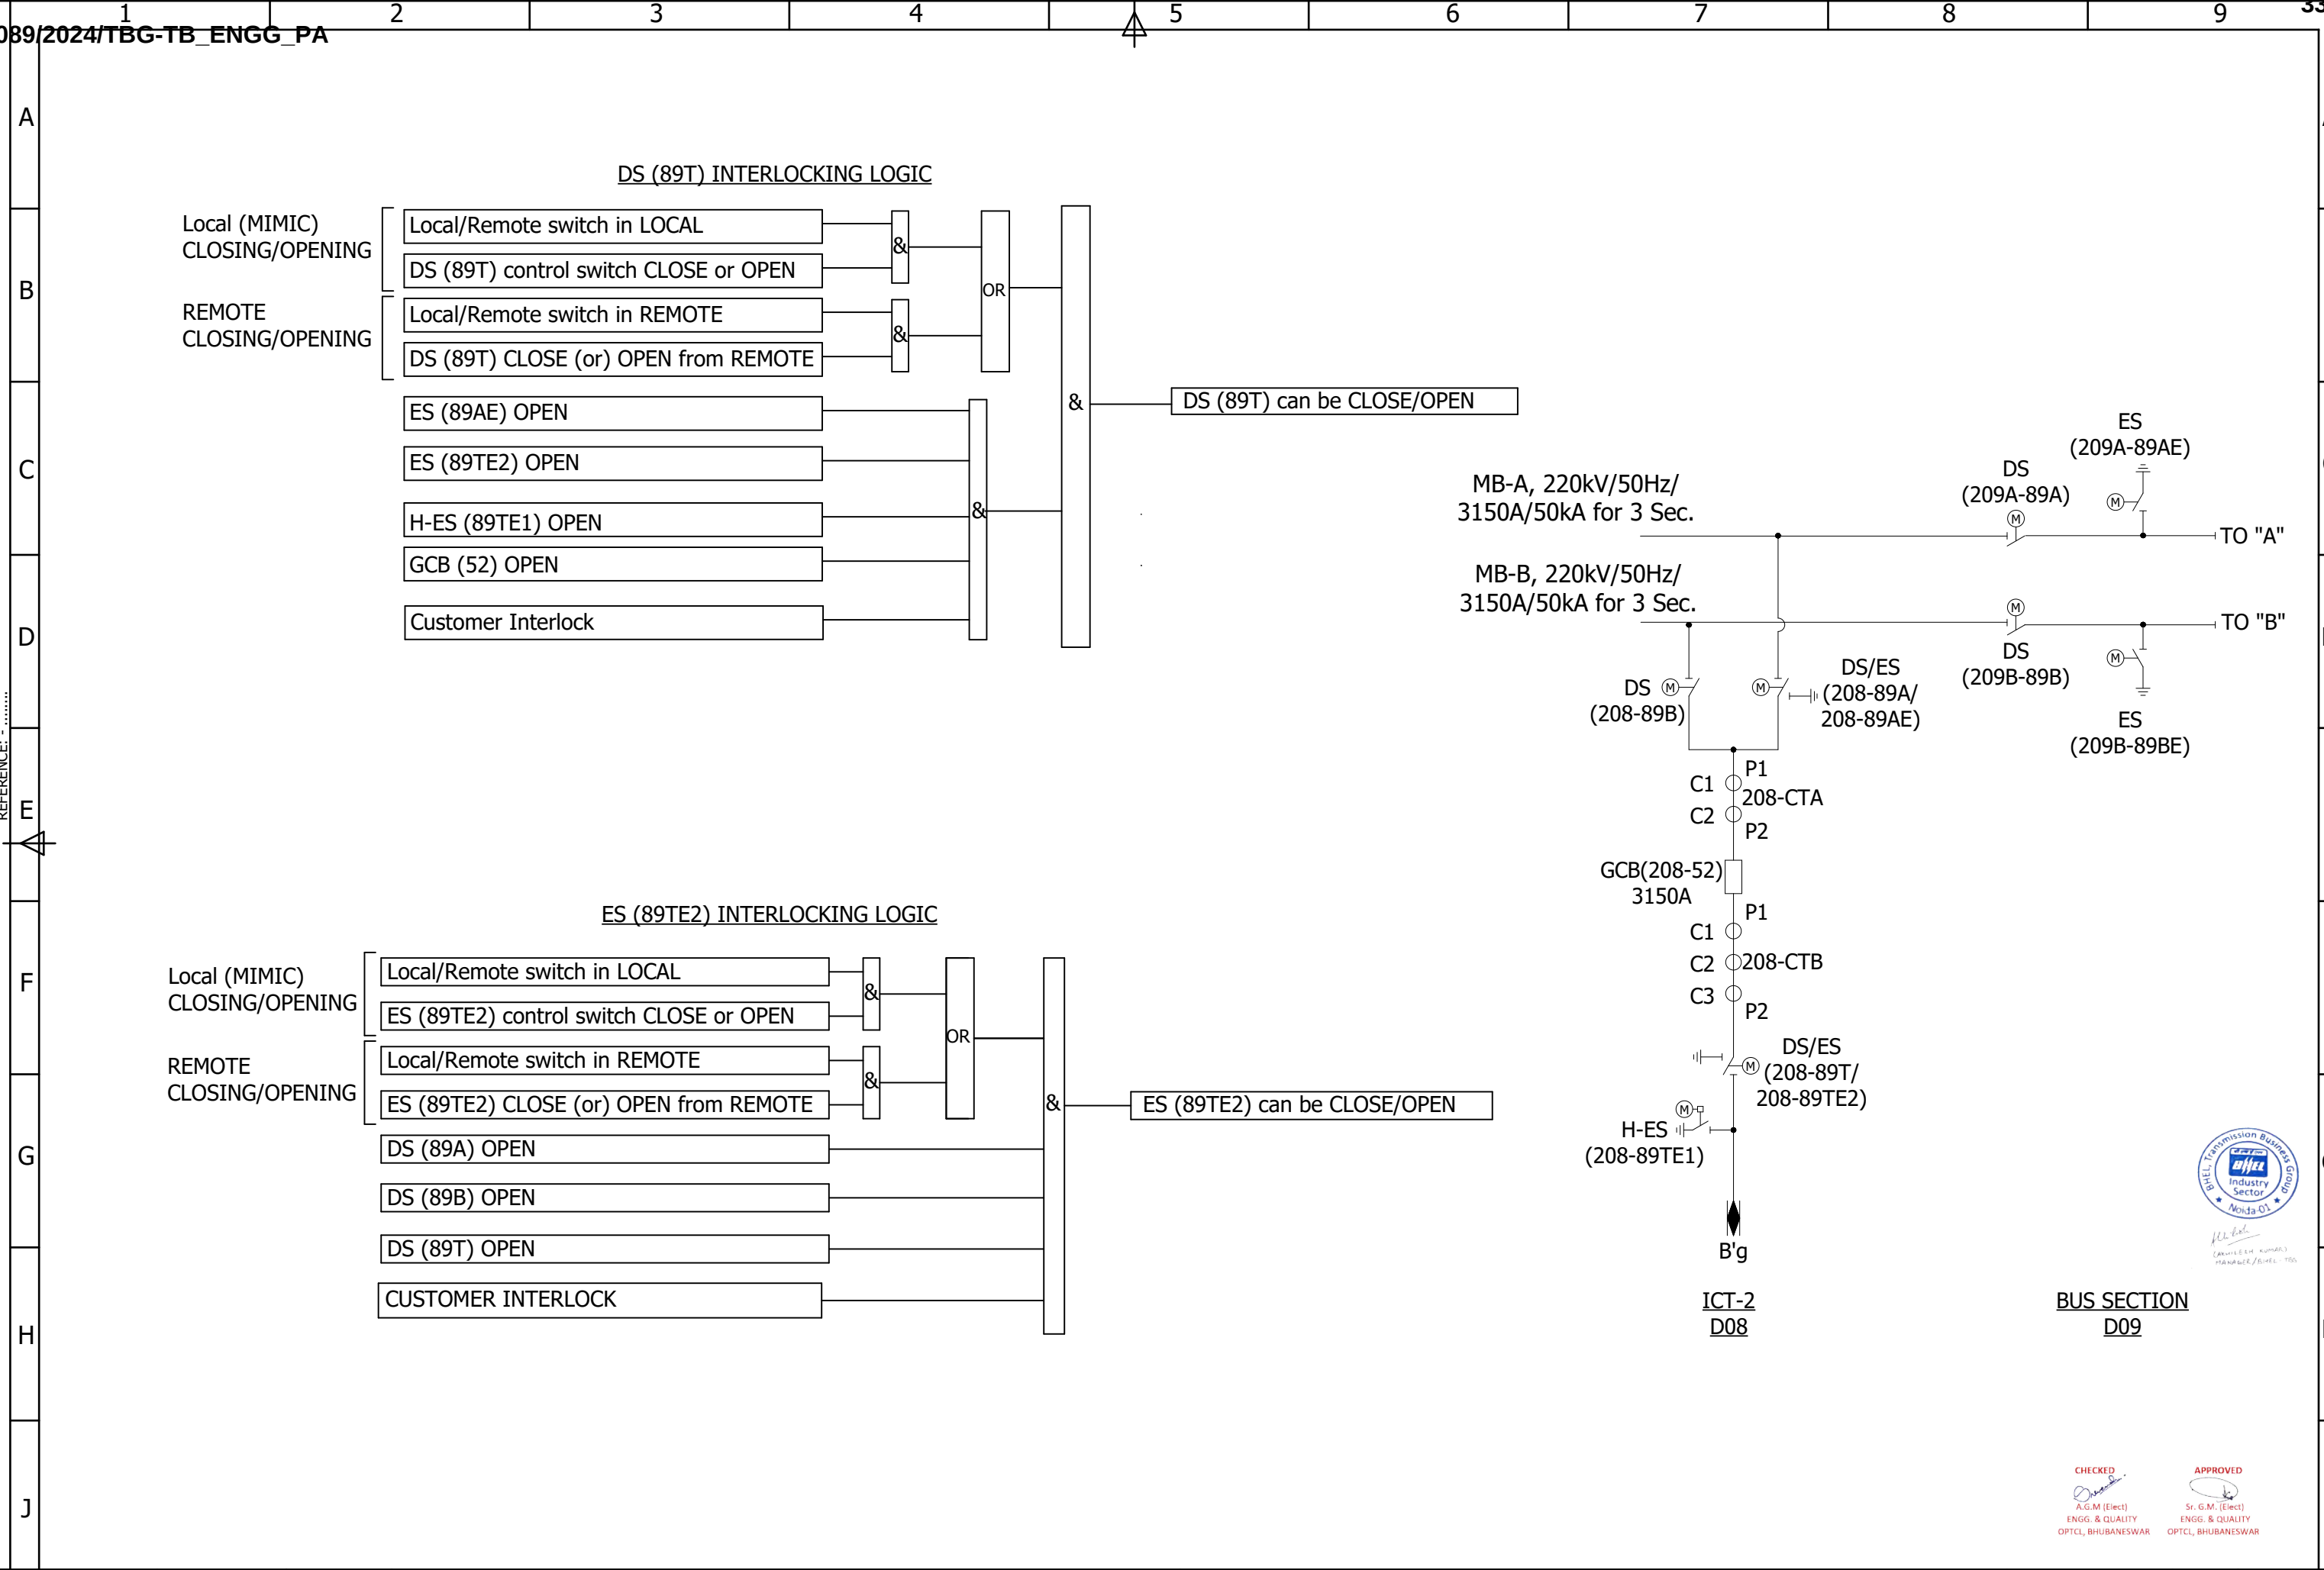

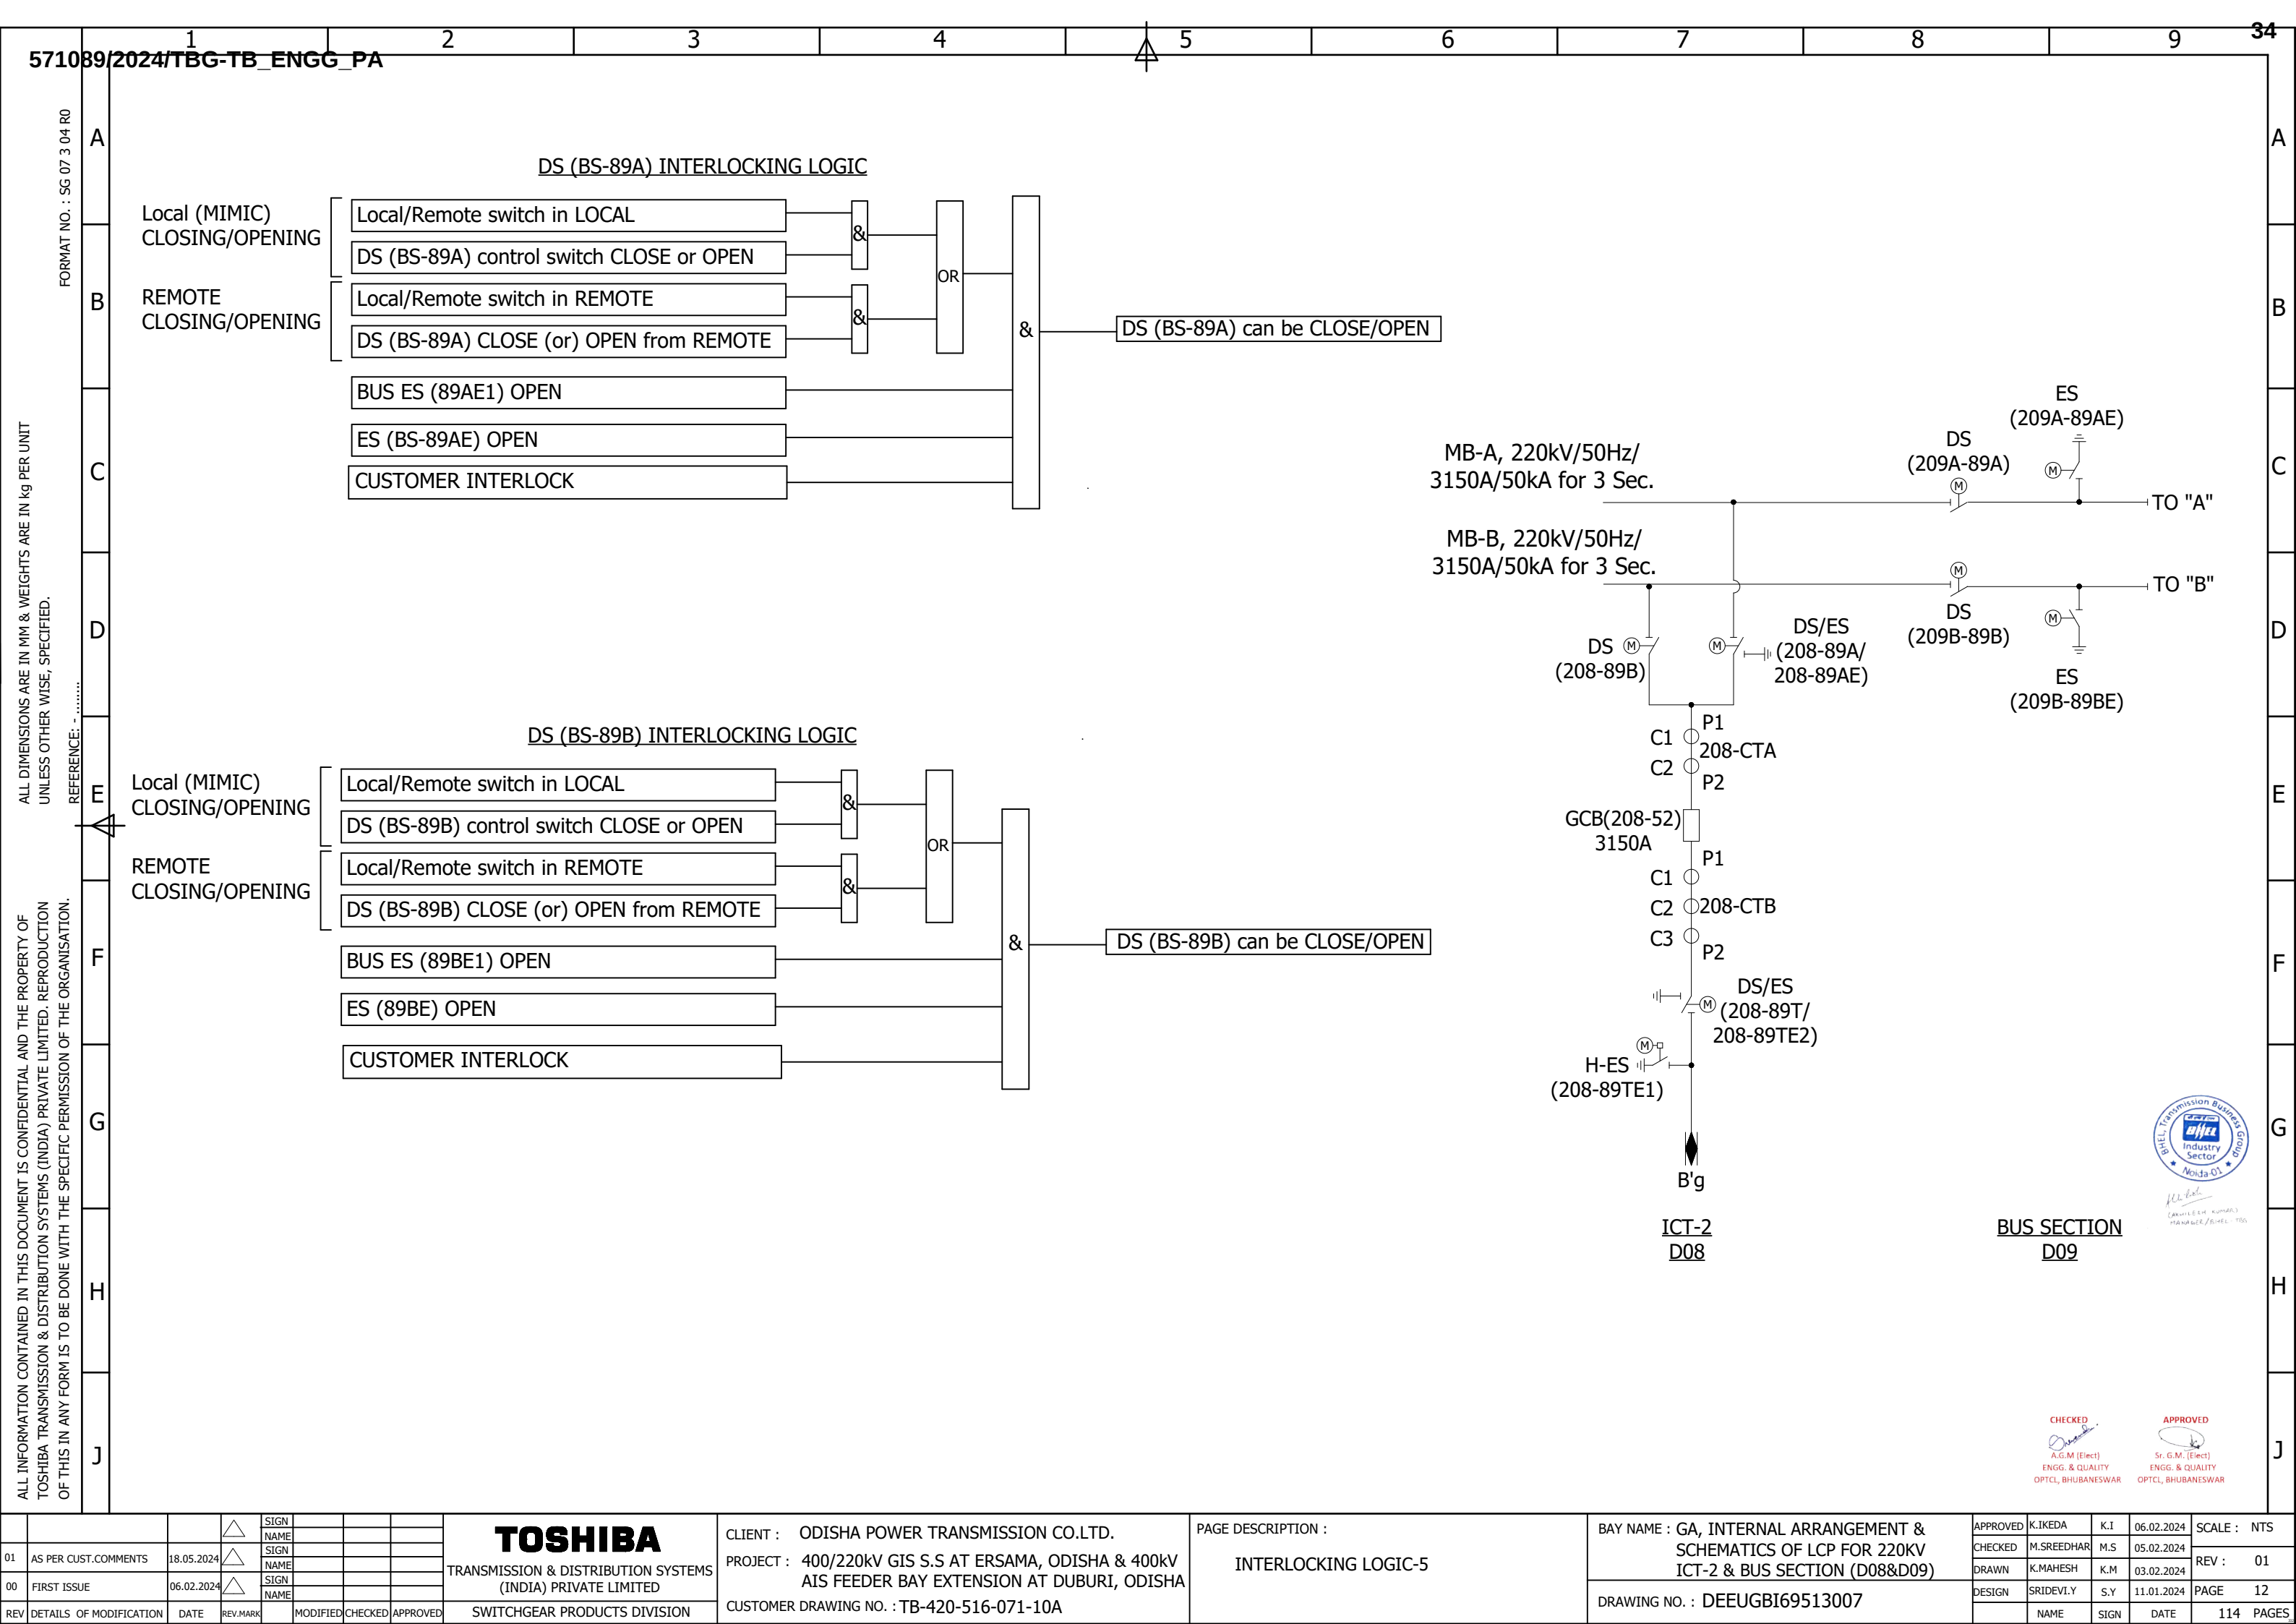

ALL DIMENSIONS ARE IN MM & WEIGHTS ARE IN kg PER UNIT
UNLESS OTHER WISE, SPECIFIED.

REFERENCE: -

ALL INFORMATION CONTAINED IN THIS DOCUMENT IS CONFIDENTIAL AND THE PROPERTY OF
TOSHIBA TRANSMISSION & DISTRIBUTION SYSTEMS (INDIA) PRIVATE LIMITED. REPRODUCTION
OF THIS IN ANY FORM IS TO BE DONE WITH THE SPECIFIC PERMISSION OF THE ORGANISATION.

A

B

C

D



E

F

G

H



J

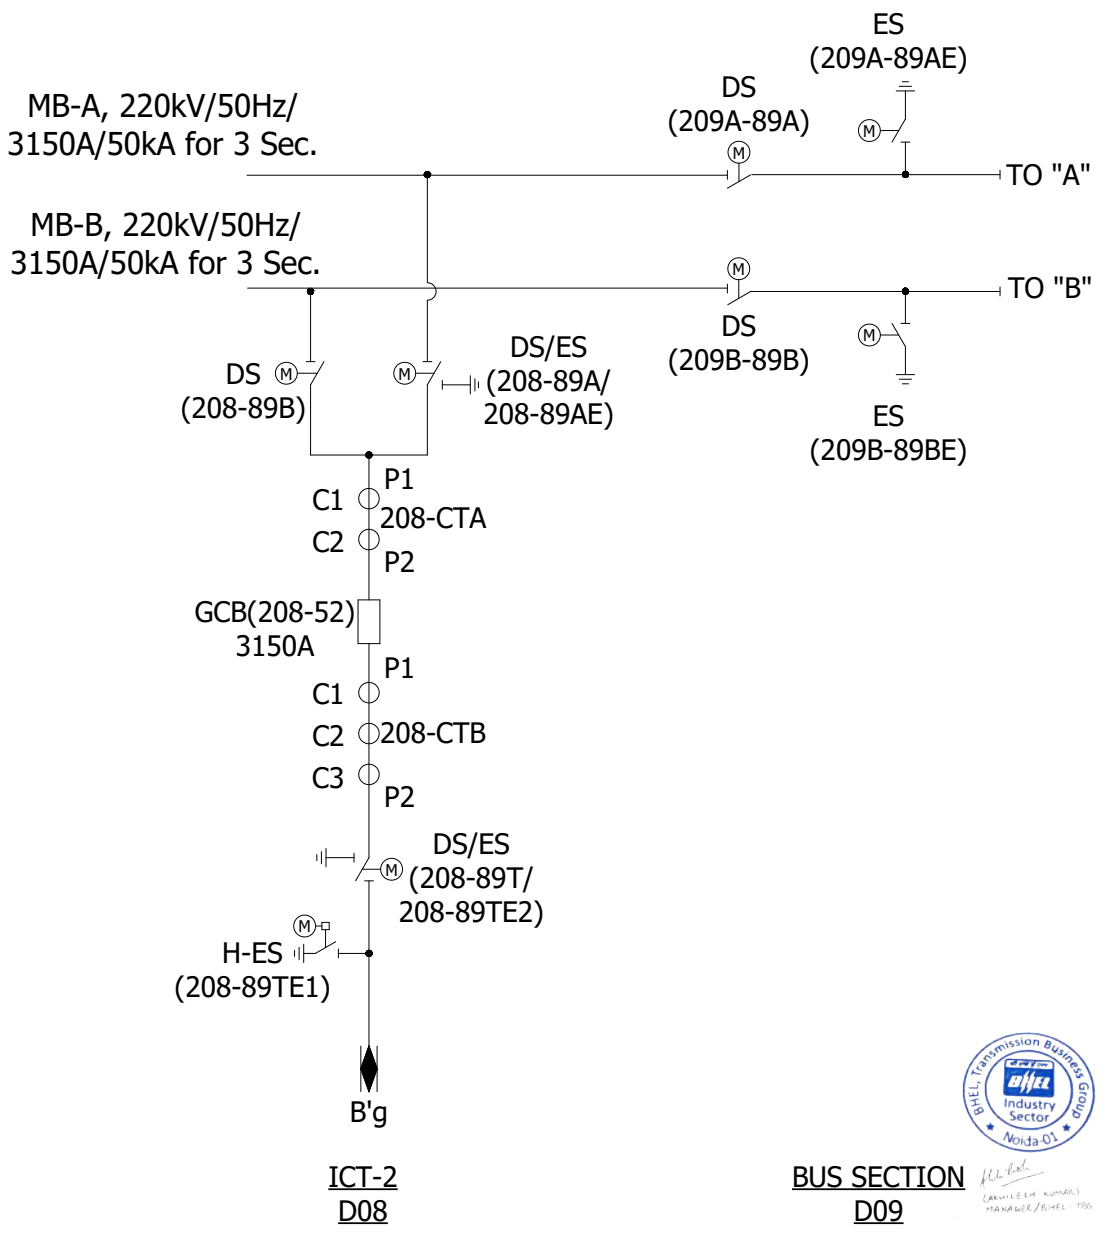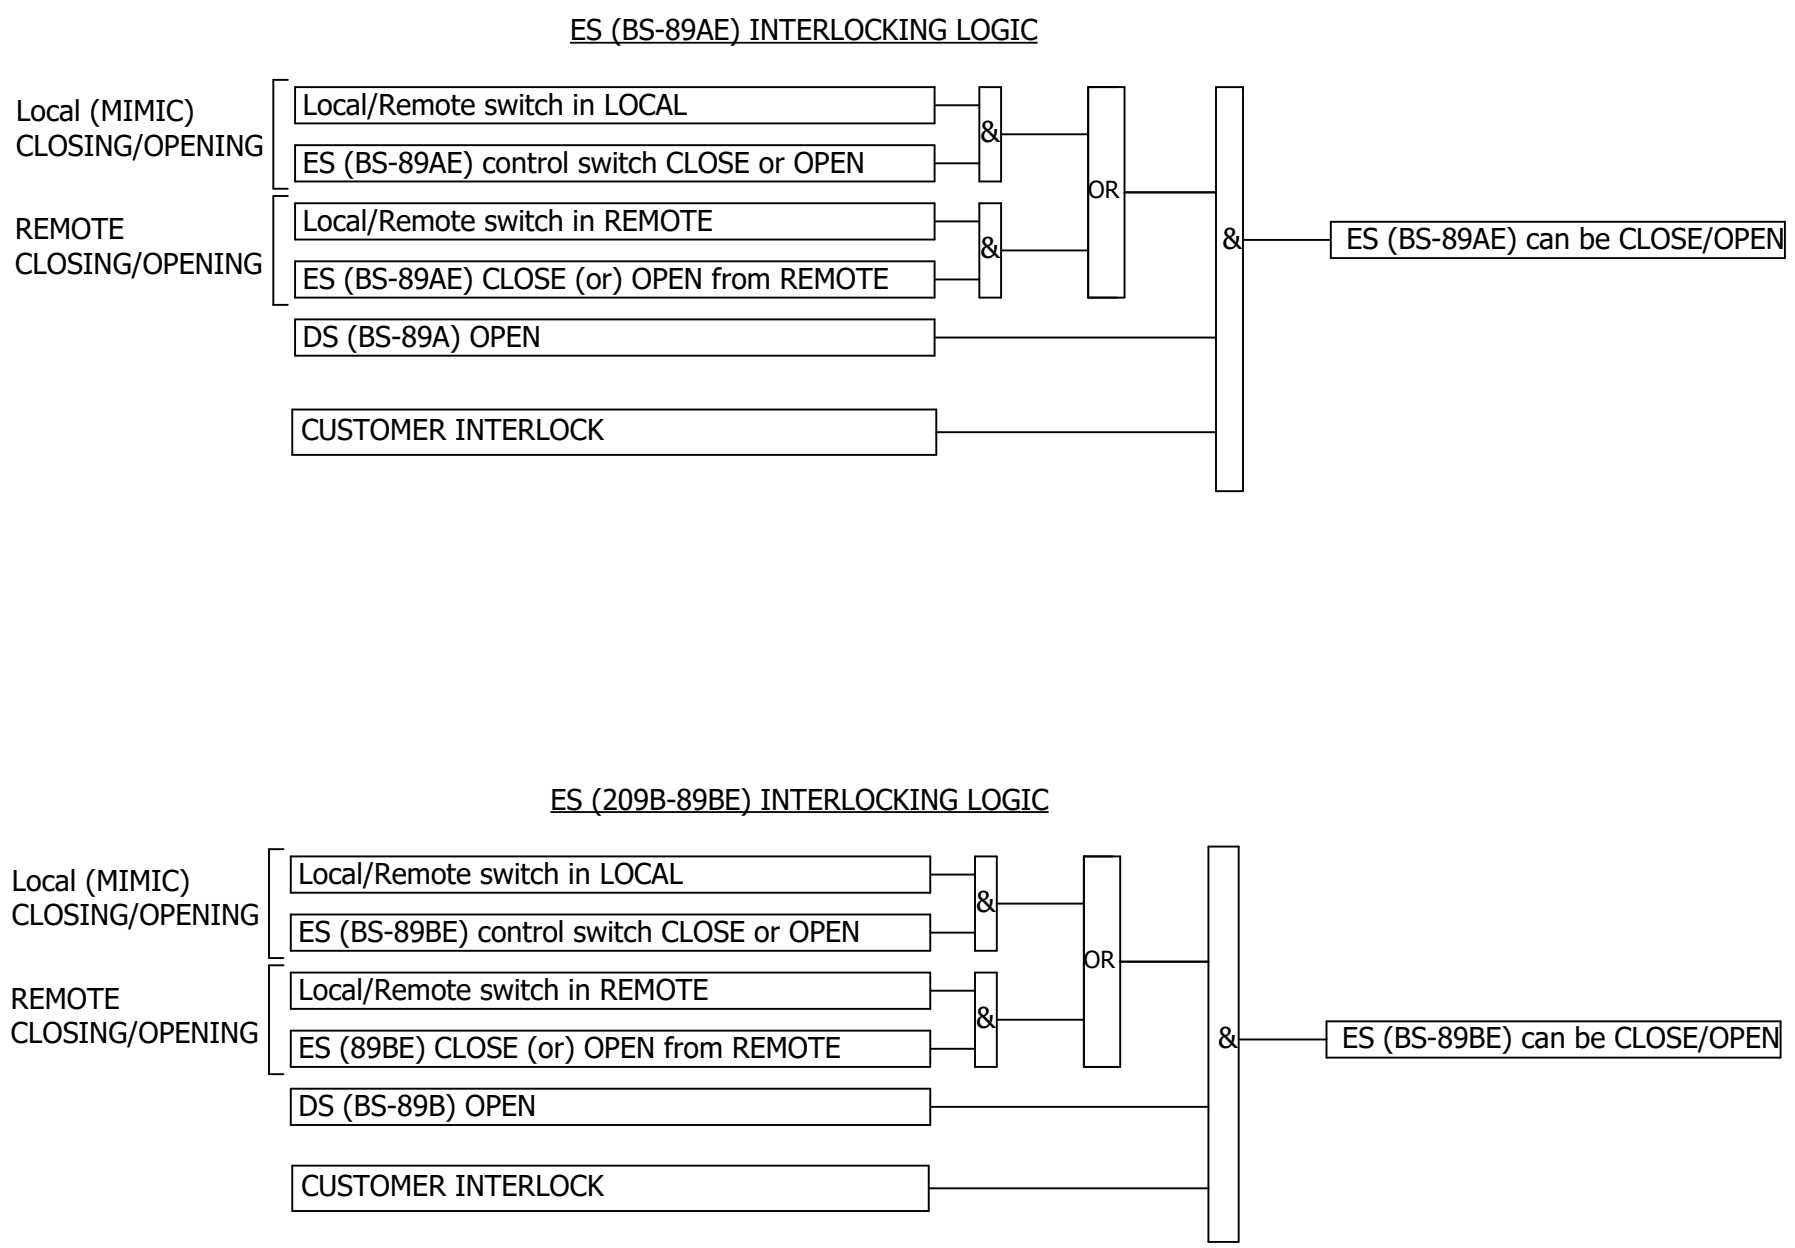

CHECKED
A.G.M (Elect)
ENGG. & QUALITY
OPTCL, BHUBANESWAR

APPROVED
Sr. G.M. (Elect)
ENGG. & QUALITY
OPTCL, BHUBANESWAR

  ALL INFORMATION CONTAINED IN THIS DOCUMENT IS CONFIDENTIAL AND THE PROPERTY OF TOSHIBA TRANSMISSION & DISTRIBUTION SYSTEMS (INDIA) PRIVATE LIMITED. REPRODUCTION OF THIS IN ANY FORM IS TO BE DONE WITH THE SPECIFIC PERMISSION OF THE ORGANISATION.



APPROVED

Sr. G.M. (Elect)
ENGG. & QUALITY
OPTCL, BHUBANESWA




Arvilesh Kumar
(ARVILESH KUMAR)
MANAGER/BHEL-TISCO


			△	SIGN				TOSHIBA TRANSMISSION & DISTRIBUTION SYSTEMS (INDIA) PRIVATE LIMITED SWITCHGEAR PRODUCTS DIVISION	CLIENT : ODISHA POWER TRANSMISSION CO.LTD. PROJECT : 400/220kV GIS S.S AT ERSAMA, ODISHA & 400kV AIS FEEDER BAY EXTENSION AT DUBURI, ODISHA CUSTOMER DRAWING NO. : TB-420-516-071-10A	PAGE DESCRIPTION : OUTLINE OF LCP	BAY NAME : GA, INTERNAL ARRANGEMENT & SCHEMATICS OF LCP FOR 220KV ICT-2 & BUS SECTION (D08&D09)	APPROVED	K.IKEDA	K.I	06.02.2024	SCALE : NTS
01	AS PER CUST.COMMENTS	18.05.2024	△	SIGN								CHECKED	M.SREEDHAR	M.S	05.02.2024	REV : 01
00	FIRST ISSUE	06.02.2024	△	SIGN								DRAWN	K.MAHESH	K.M	03.02.2024	
REV	DETAILS OF MODIFICATION	DATE	REV.MARK	SIGN								DESIGN	SRIDEVI.Y	S.Y	11.01.2024	PAGE 15
				NAME									NAME	SIGN	DATE	114 PAGES

THIS IN ANY FORM IS TO BE DONE WITH THE SPECIFIC PERMISSION OF THE ORGANISATION.


ALL INFORMATION CONTAINED IN THIS DOCUMENT IS CONFIDENTIAL AND THE PROPERTY OF
TOSHIBA TRANSMISSION & DISTRIBUTION SYSTEMS (INDIA) PRIVATE LIMITED. REPRODUCTION
UNLESS OTHERWISE SPECIFIED

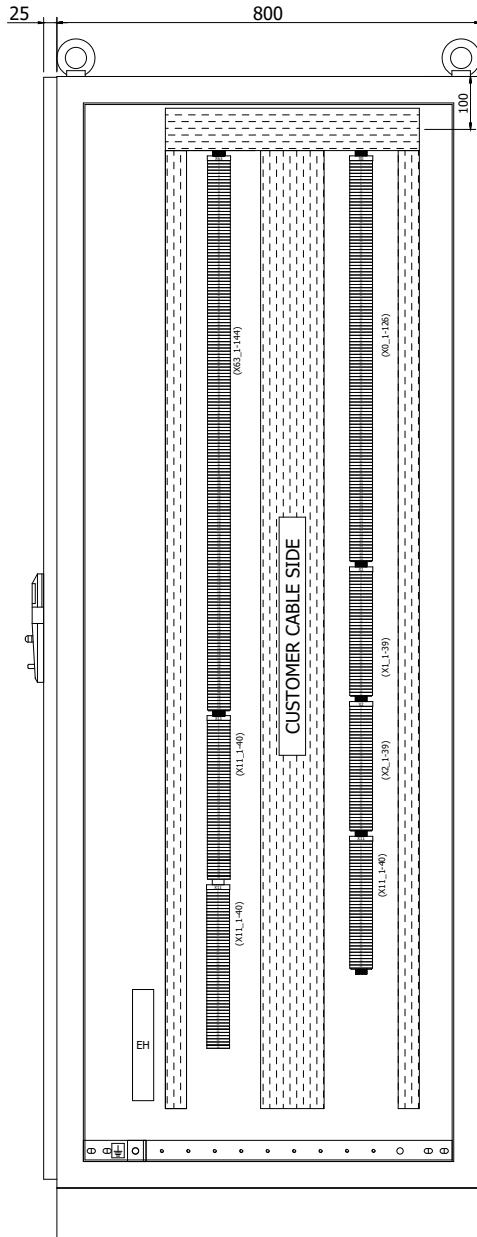

VIEW B-B

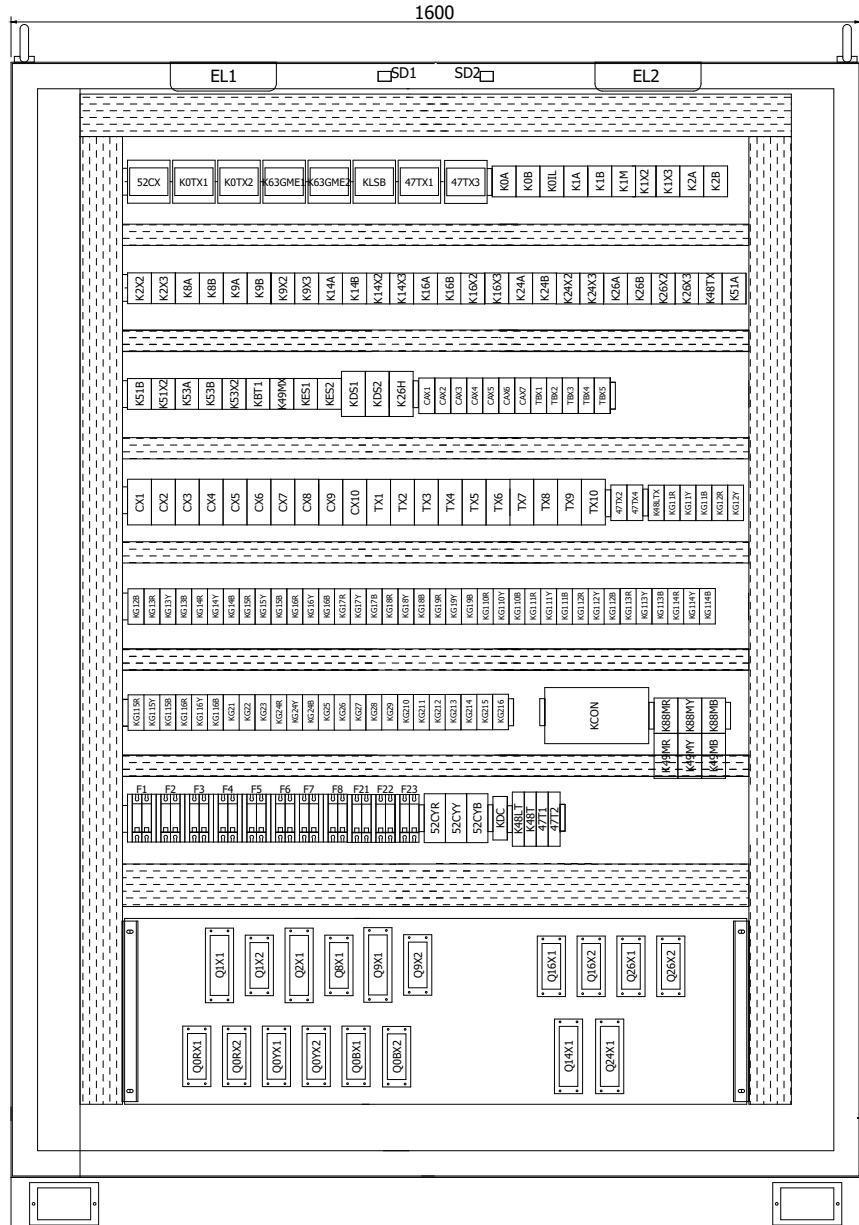


VIEW D-D

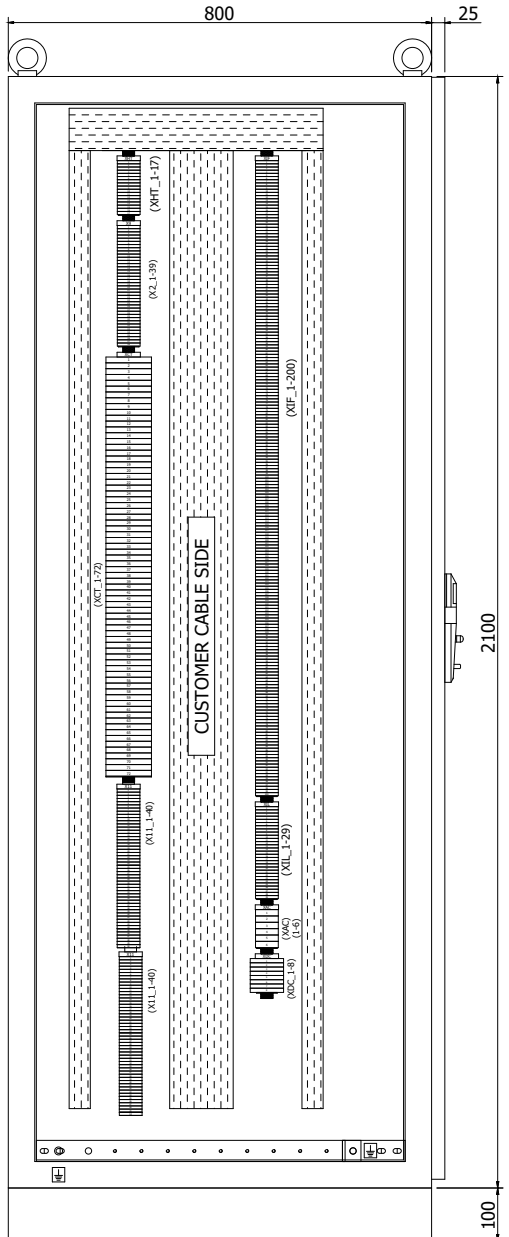


VIEW C-C

TENTATIVE

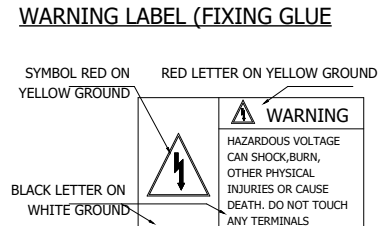

SPECIFICATION OF NAME PLATE
MATERIAL : STAINLESS STEEL (400 X 63)
FIXING : M3x8mm SS SCREW
BLACK LETTER ON SILVER GROUND

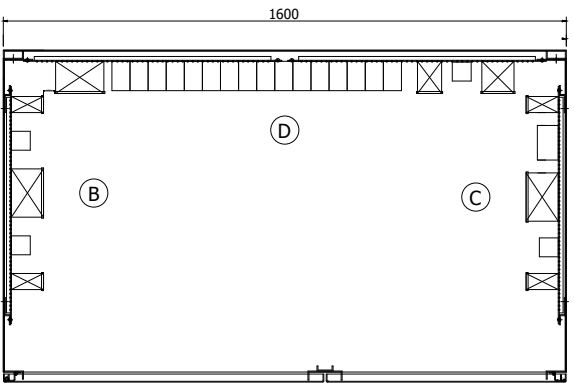

TOP VIEW

NOTE:1

TAG NAME SHOULD BE PLACED ON BOTH PANEL & DEVICE CORRESPONDING

SPECIFICATION OF CARD PLATE:

ENGRAVED BLACK LETTER ON WHITE BACK GROUND

MATERIAL: LAMICOID

FIXING: GLUE

SIZE: SUITABLE SIZE

NOTE:2

- 1) ALL INDIVIDUAL BOTTOM PLATES ARE GASKETTED & 3MM THICK CRCA
- 2) BOTTOM PLATES ARE DRILLED AT SITE
- 3) CABLES FROM GIS TO LCP (CABLE GLANDS & ASSOCIATED ACCESSORIES ARE SUPPLIED BY TOSHIBA-TTDI)
- 4) CABLES FROM CENTRAL CONTROL SYSTEM TO LCP (CABLES & COMPRESSION GLANDS & OTHER ASSOCIATED ACCESSORIES ARE OUT OF SCOPE OF SUPPLY)

NOTE:3


1) COMPONENTS POSITION MAY VARY DURING DETAIL ENGINEERING AFTER APPROVAL OF SCHEMATIC.

			△	SIGN				TOSHIBA TRANSMISSION & DISTRIBUTION SYSTEMS (INDIA) PRIVATE LIMITED SWITCHGEAR PRODUCTS DIVISION	CLIENT : ODISHA POWER TRANSMISSION CO.LTD. PROJECT : 400/220kV GIS S.S AT ERSAMA, ODISHA & 400kV AIS FEEDER BAY EXTENSION AT DUBURI, ODISHA CUSTOMER DRAWING NO. : TB-420-516-071-10A	PAGE DESCRIPTION : INTERNAL ARRANGEMENT OF LCP	BAY NAME : GA, INTERNAL ARRANGEMENT & SCHEMATICS OF LCP FOR 220KV ICT-2 & BUS SECTION (D08&D09)	APPROVED	K.IKEDA	K.I	06.02.2024	SCALE : NTS
01	AS PER CUST.COMMENTS	18.05.2024	△	SIGN								CHECKED	M.SREEDHAR	M.S	05.02.2024	REV : 01
00	FIRST ISSUE	06.02.2024	△	SIGN								DRAWN	K.MAHESH	K.M	03.02.2024	PAGE 16
REV	DETAILS OF MODIFICATION	DATE	REV.MARK	SIGN								DESIGN	SRIDEVI.Y	S.Y	11.01.2024	
				NAME									NAME	SIGN	DATE	114 PAGES

ANNUNCIATOR DESCRIPTION

LED COLOUR: RED, AUX.VOLTAGE: 220VDC


ANN1

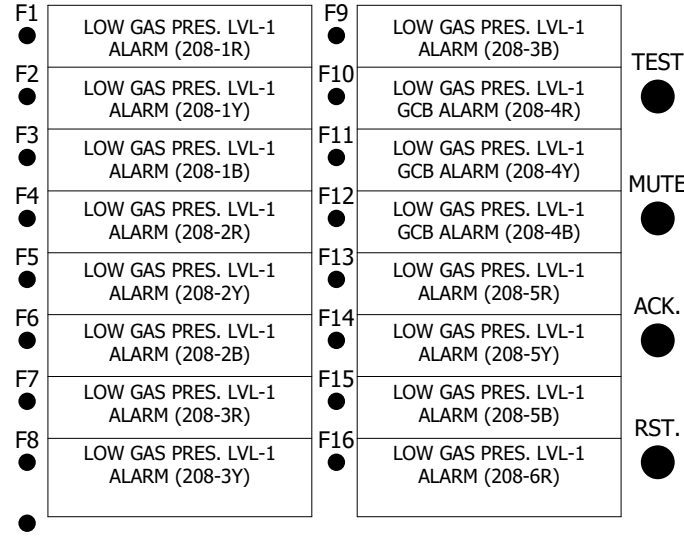

MBAS 11

ALARM ANNUNCIATOR


ANN2

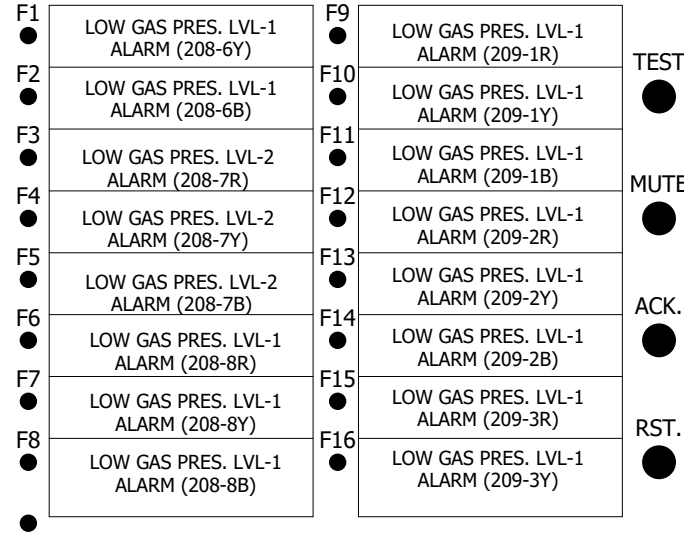

MBAS 11

ALARM ANNUNCIATOR

ANN3

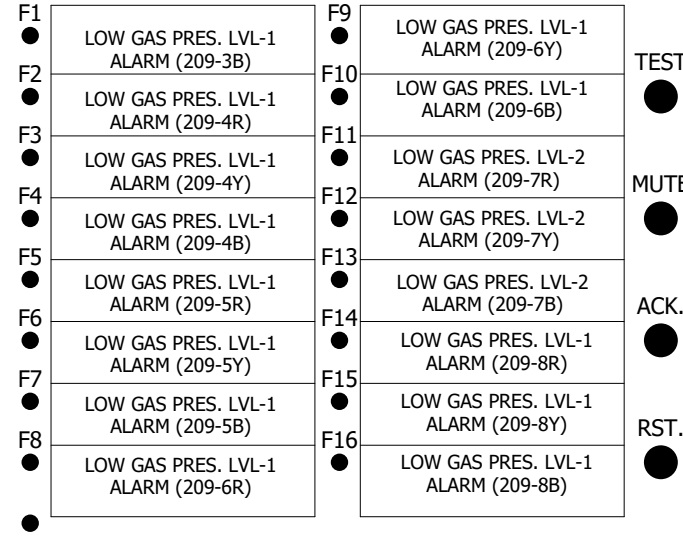

MBAS 11

ALARM ANNUNCIATOR


CHECKED

 A.G.M. (Elect)
ENGG. & QUALITY
OPTCL, BHUBANESWAR

APPROVED

 Sr. G.M. (Elect)
ENGG. & QUALITY
OPTCL, BHUBANESWAR


ANN4

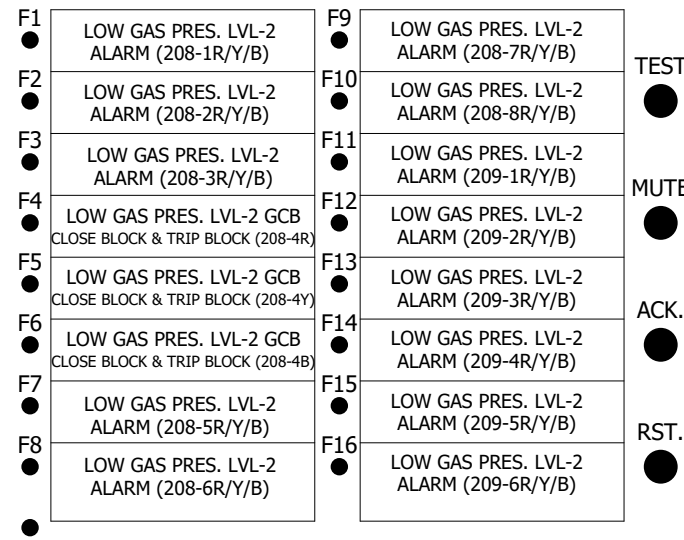

MBAS 11

ALARM ANNUNCIATOR


ANN5

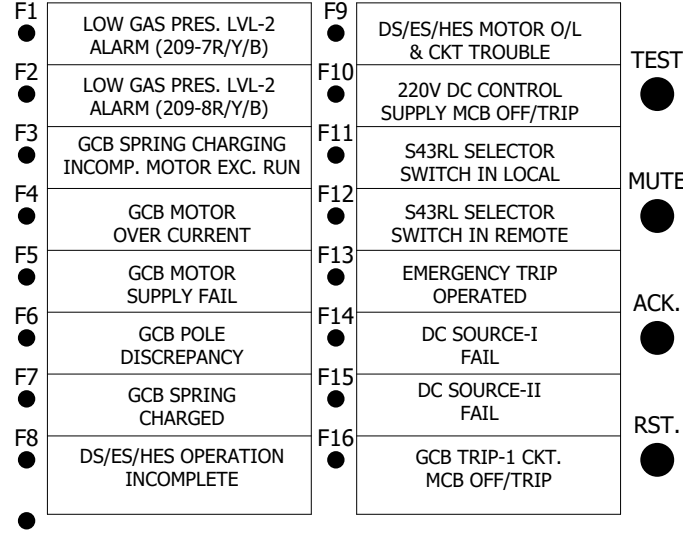

MBAS 11

ALARM ANNUNCIATOR

ANN6

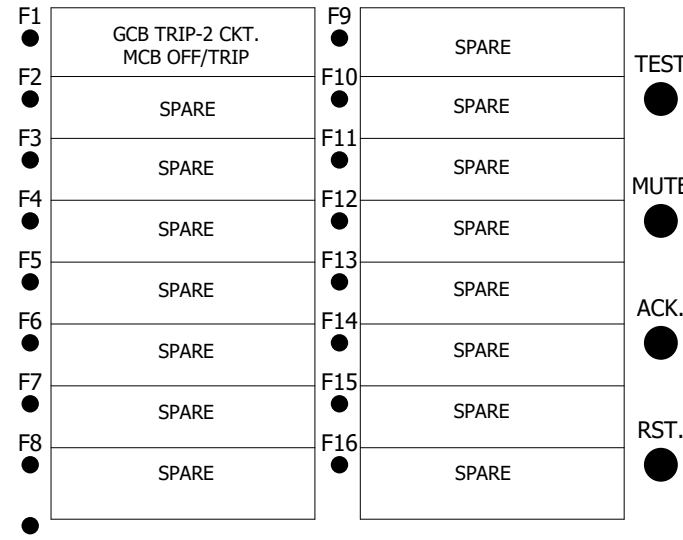

MBAS 11

ALARM ANNUNCIATOR

