

INVENTORY NO. SIGN & DATE

COMPUTER DRG. PATH NAME :

COPY RIGHT AND CONFIDENTIAL
The information on this document is the property of BHARAT HEAVY ELECTRICALS LIMITED
it must not be used directly or indirectly in anyway detrimental to the interest of the company.

DRG. NO. TB-DG-0-353-316-005

FIRST ANGLE PROJECTION

(ALL DIMENSIONS ARE IN MM)

1

2


3

4

5

6


7

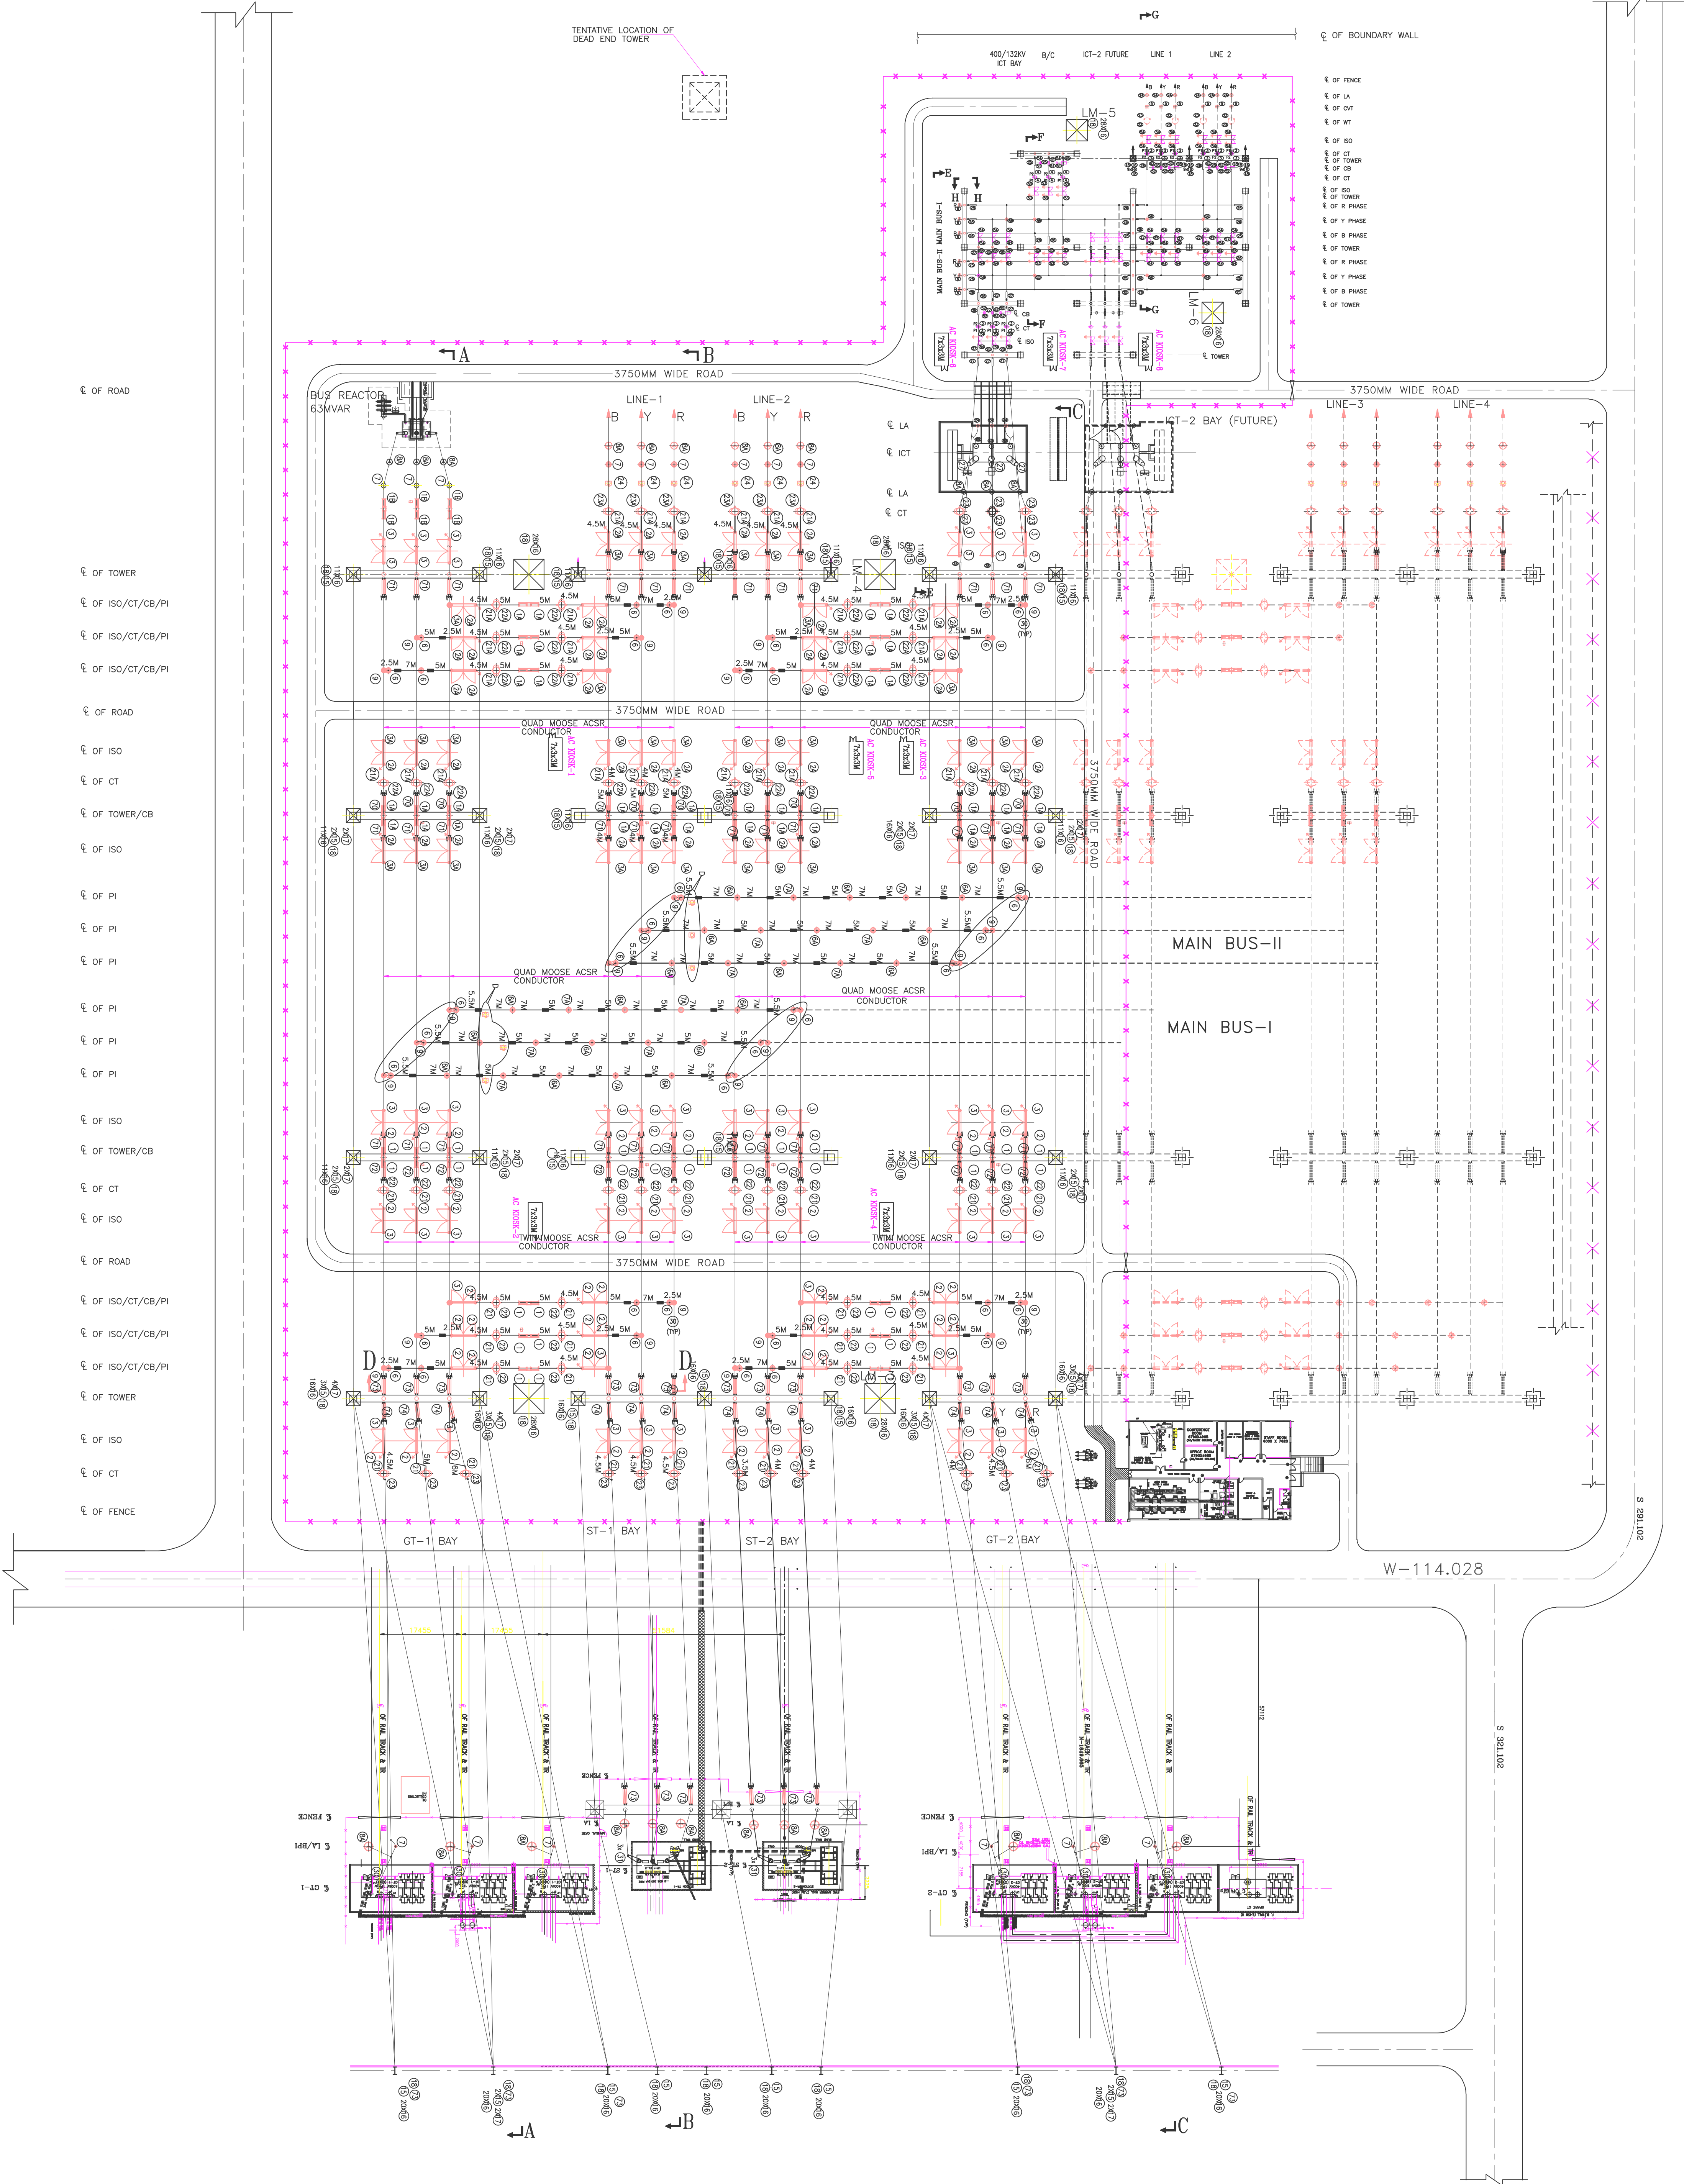

CONDUCTOR SIZE DETAILS			
EQUIPMENT INTERCONNECTION	400 KV	4" ALUMINIUM TUBE	
JACK BUS & JUMPERS	400 KV	TWIN/QUAD 'MOOSE' CONDUCTOR	

LEGEND:-

○ CONNECTION TO TWIN/QUAD MOOSE CONDUCTOR.

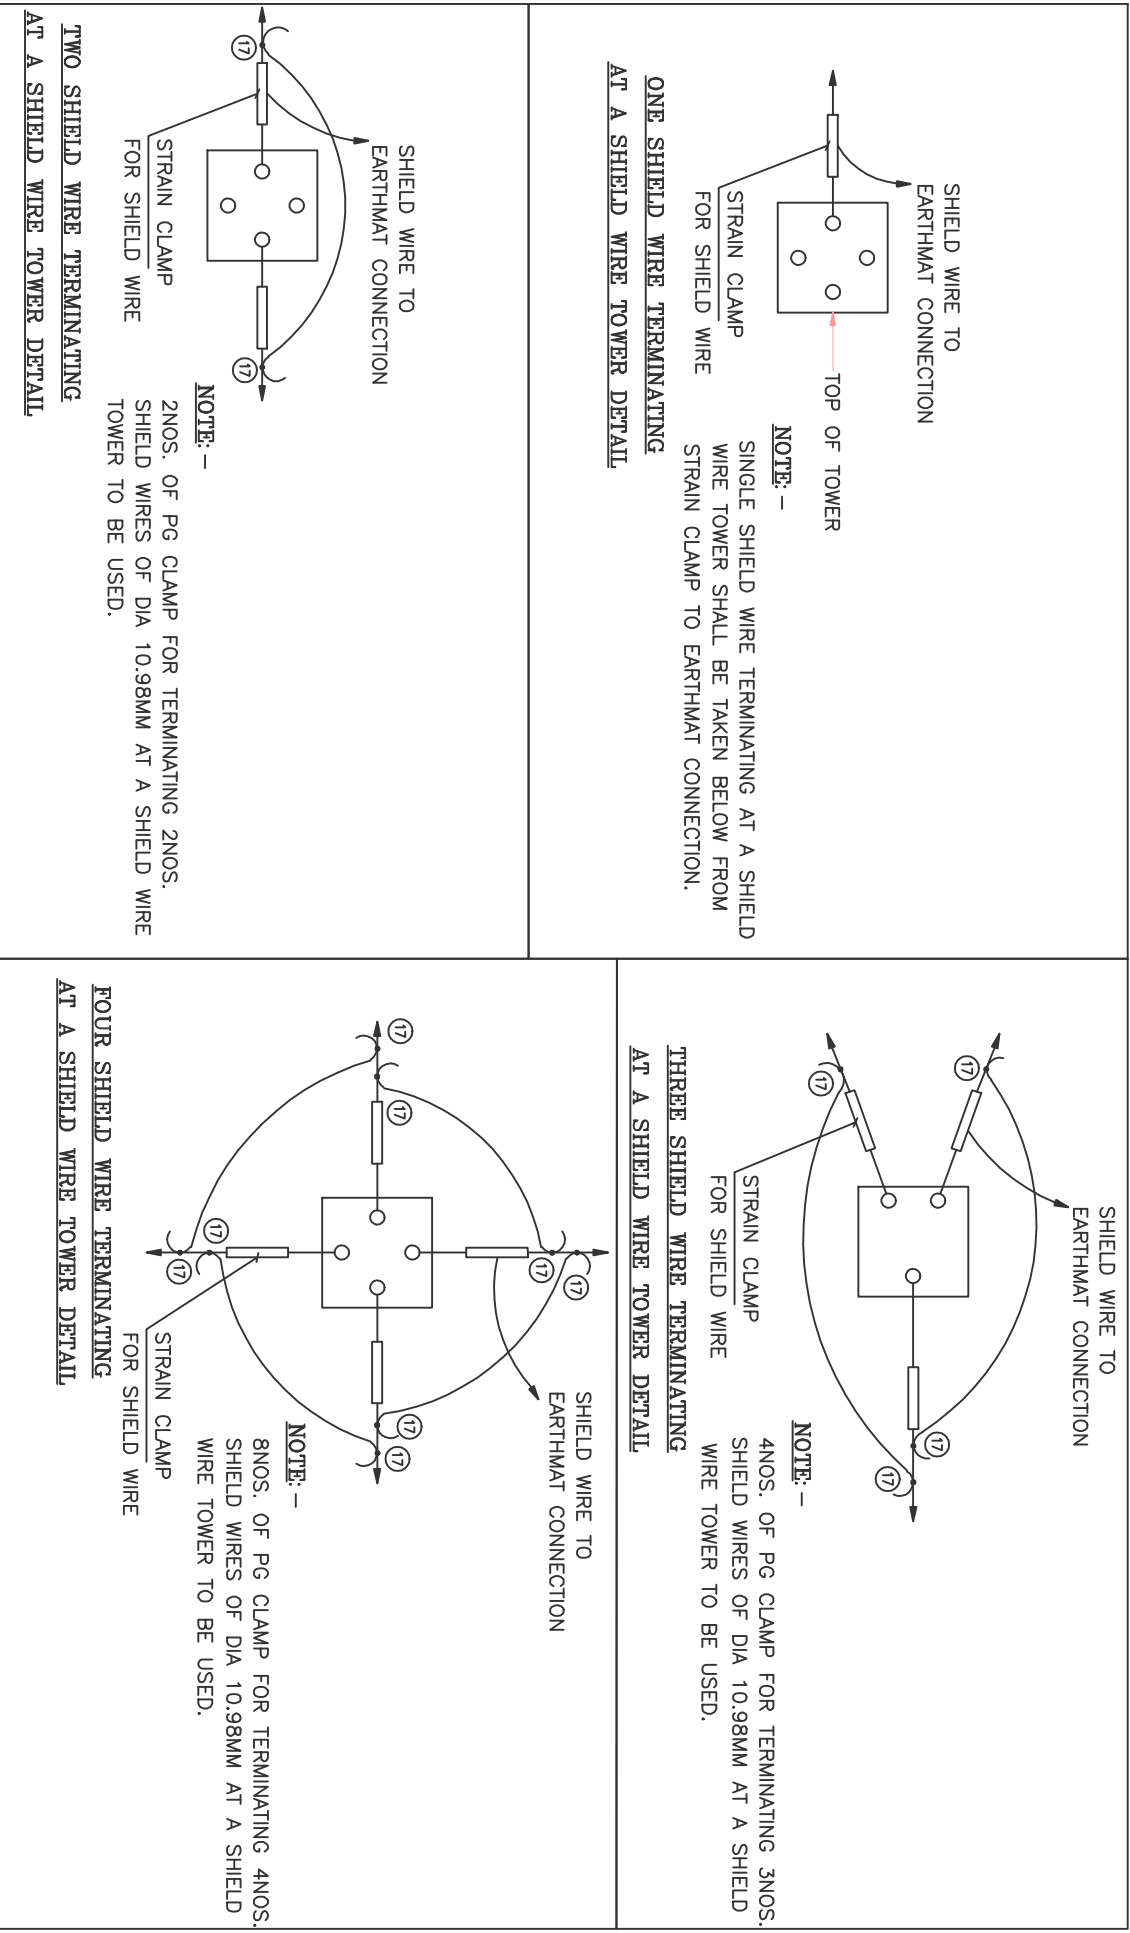

OWNER :		THE SINGARENI COLIERIES COMPANY LTD.	
CONSULTANT :		NTPC Limited (Consulting Wing)	
PROJECT :		SCCL COAL BASED THERMAL POWER PLANT (2 x 600MW)	
PACKAGE :		BOILER TURBINE GENERATOR PACKAGE	
TITLE :		ERECTION KEY DIAGRAM & BOQ	
DRAWING NO. :		TB-DG-0-353-316-005	
SHEET NO. :		01	
DATE :		07/11/12	
BY :		[Signature]	
CHECKED BY :		[Signature]	
APPROVED BY :		[Signature]	
DATE :		07/11/12	
BY :		[Signature]	
CHECKED BY :		[Signature]	
APPROVED BY :		[Signature]	
DATE :		07/11/12	