



FIRST ANGLE PROJECTION ( ALL DIMENSIONS ARE IN MM. )


DRAWING No. TB-1-309-316-002

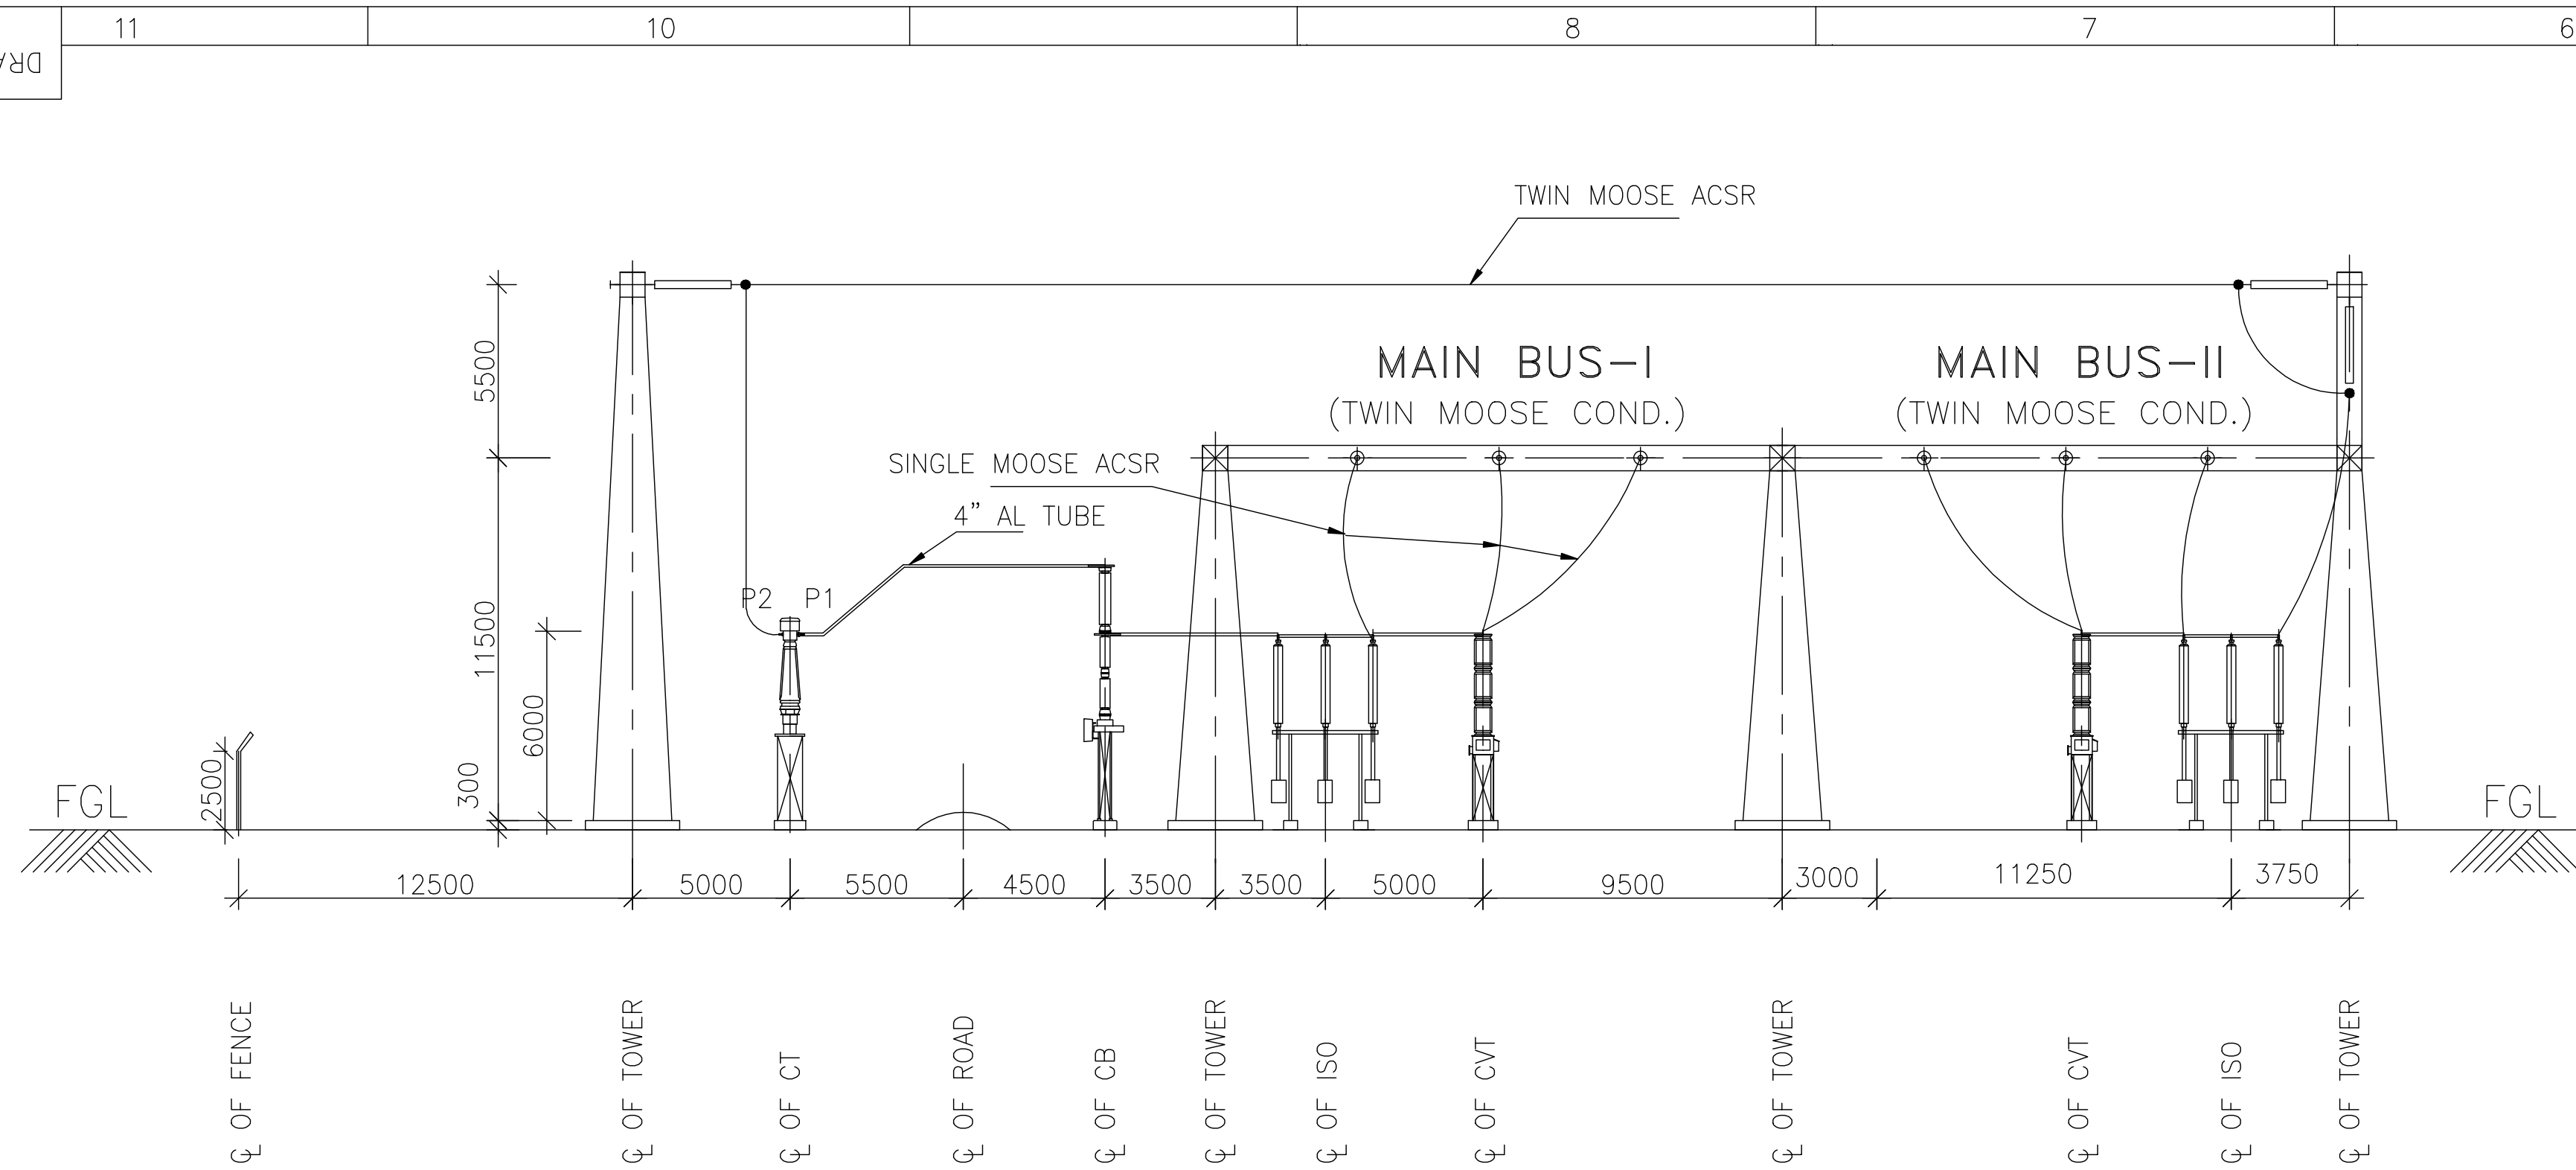


SECTION D-D  
(220kV B/C & TRANSFER BAY)

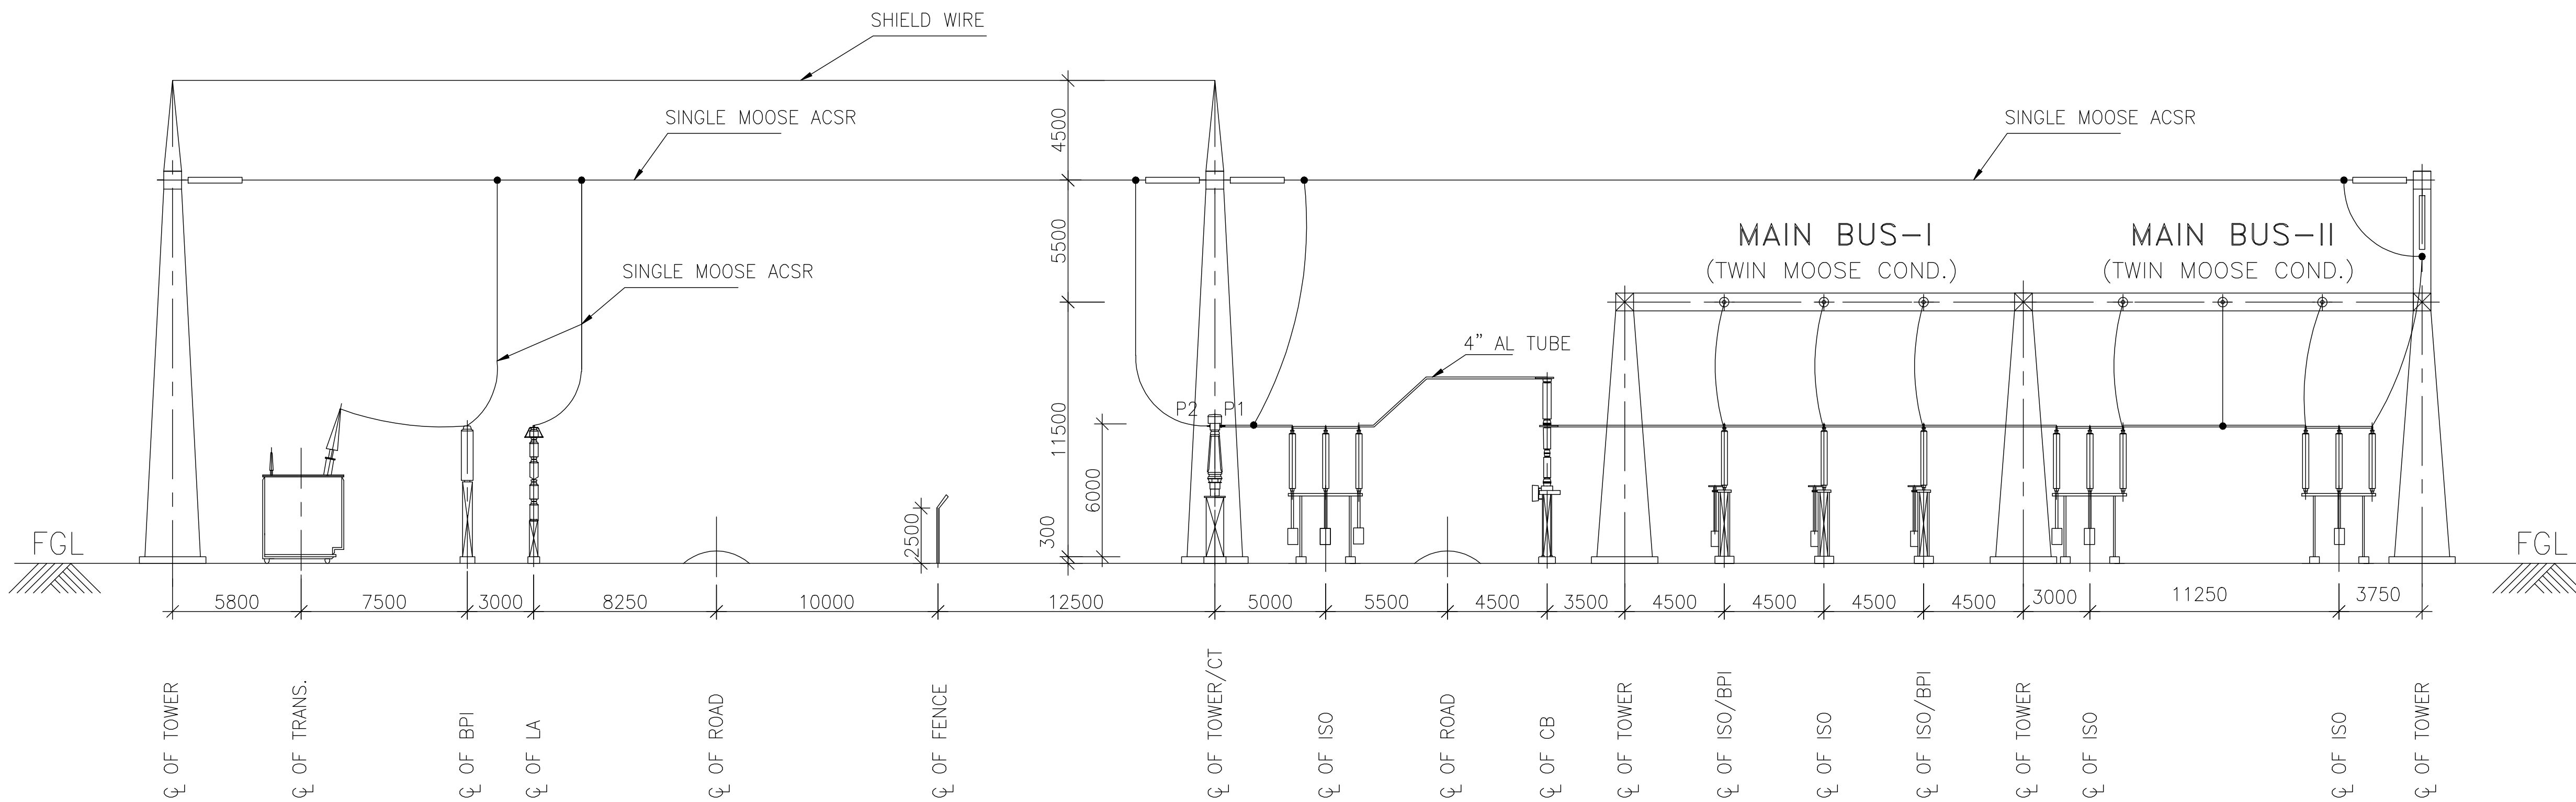


SECTION B-B  
(220kV GT BAY)

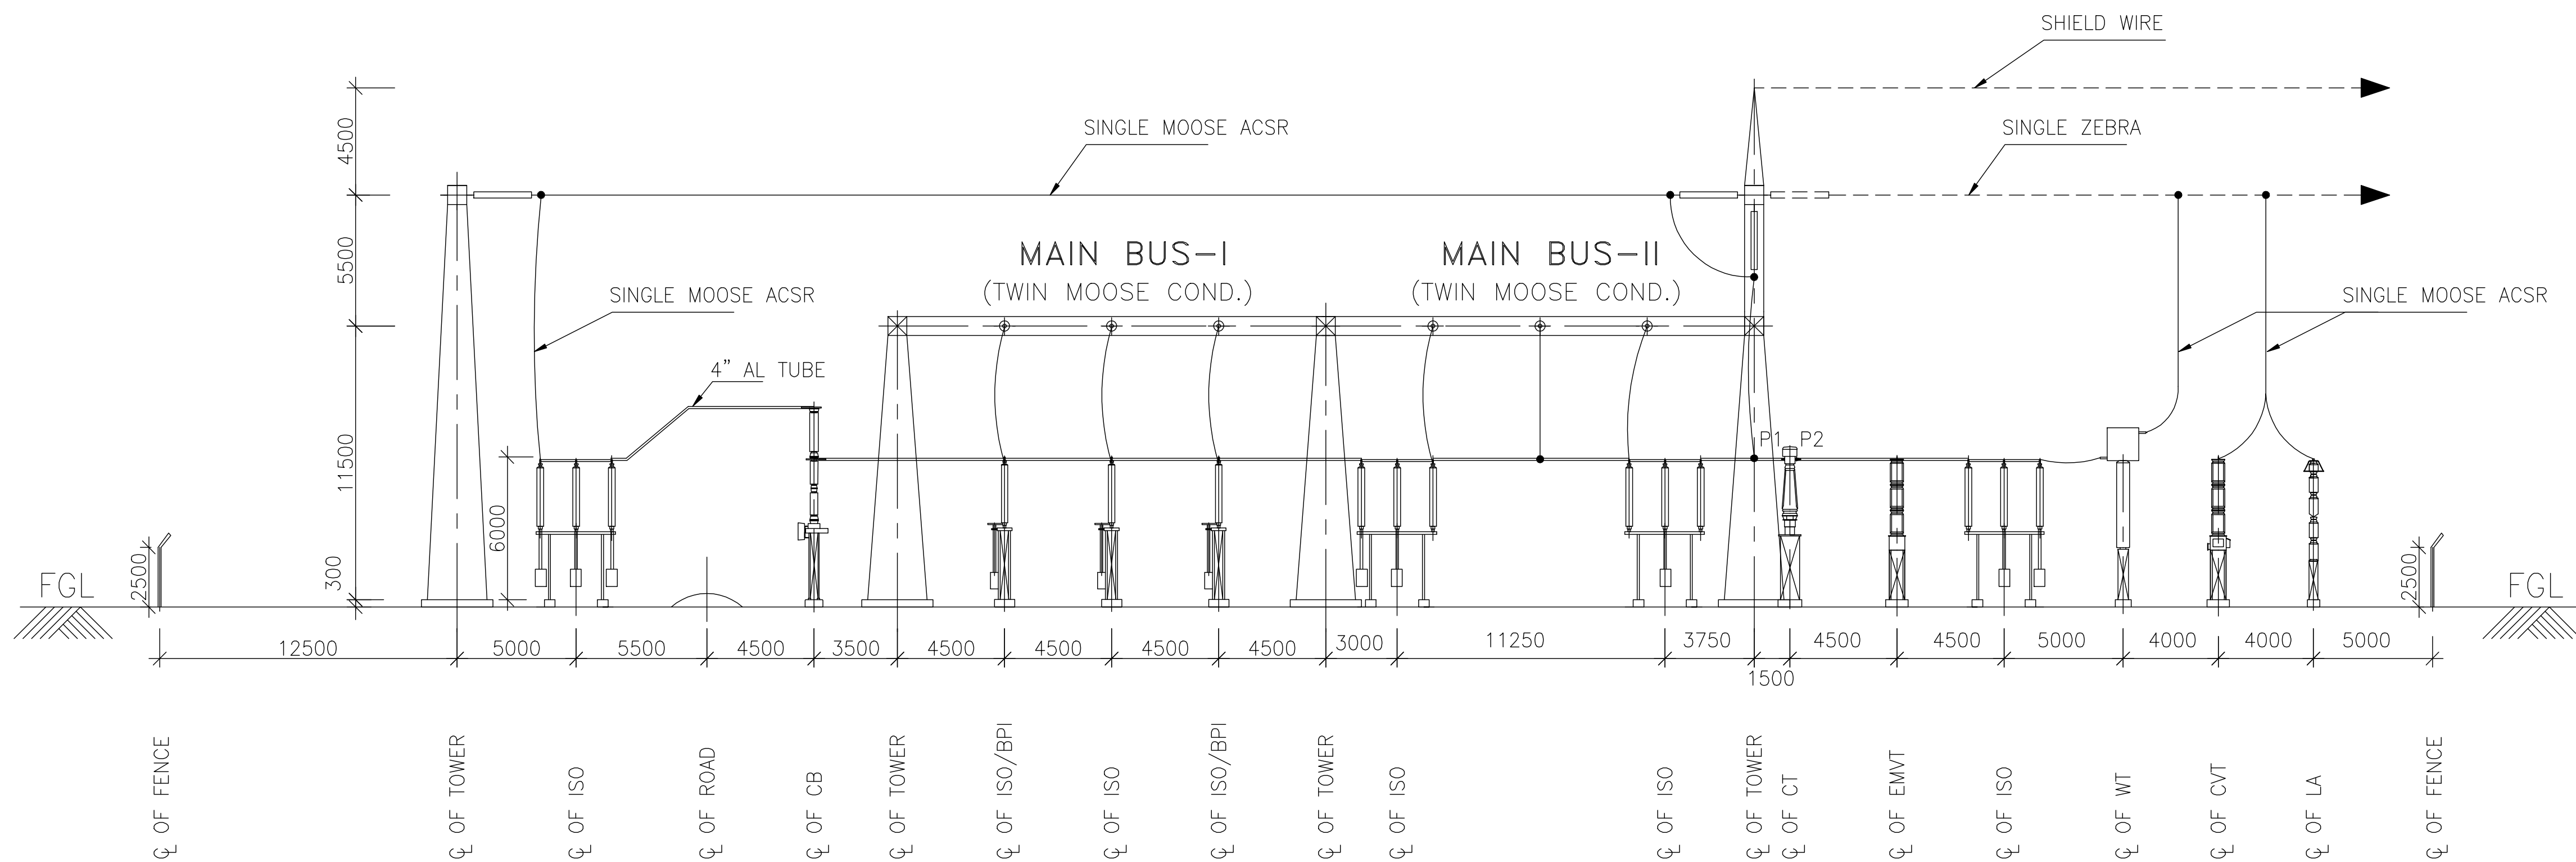

SECTION C-C  
(220kV LINE BAY)

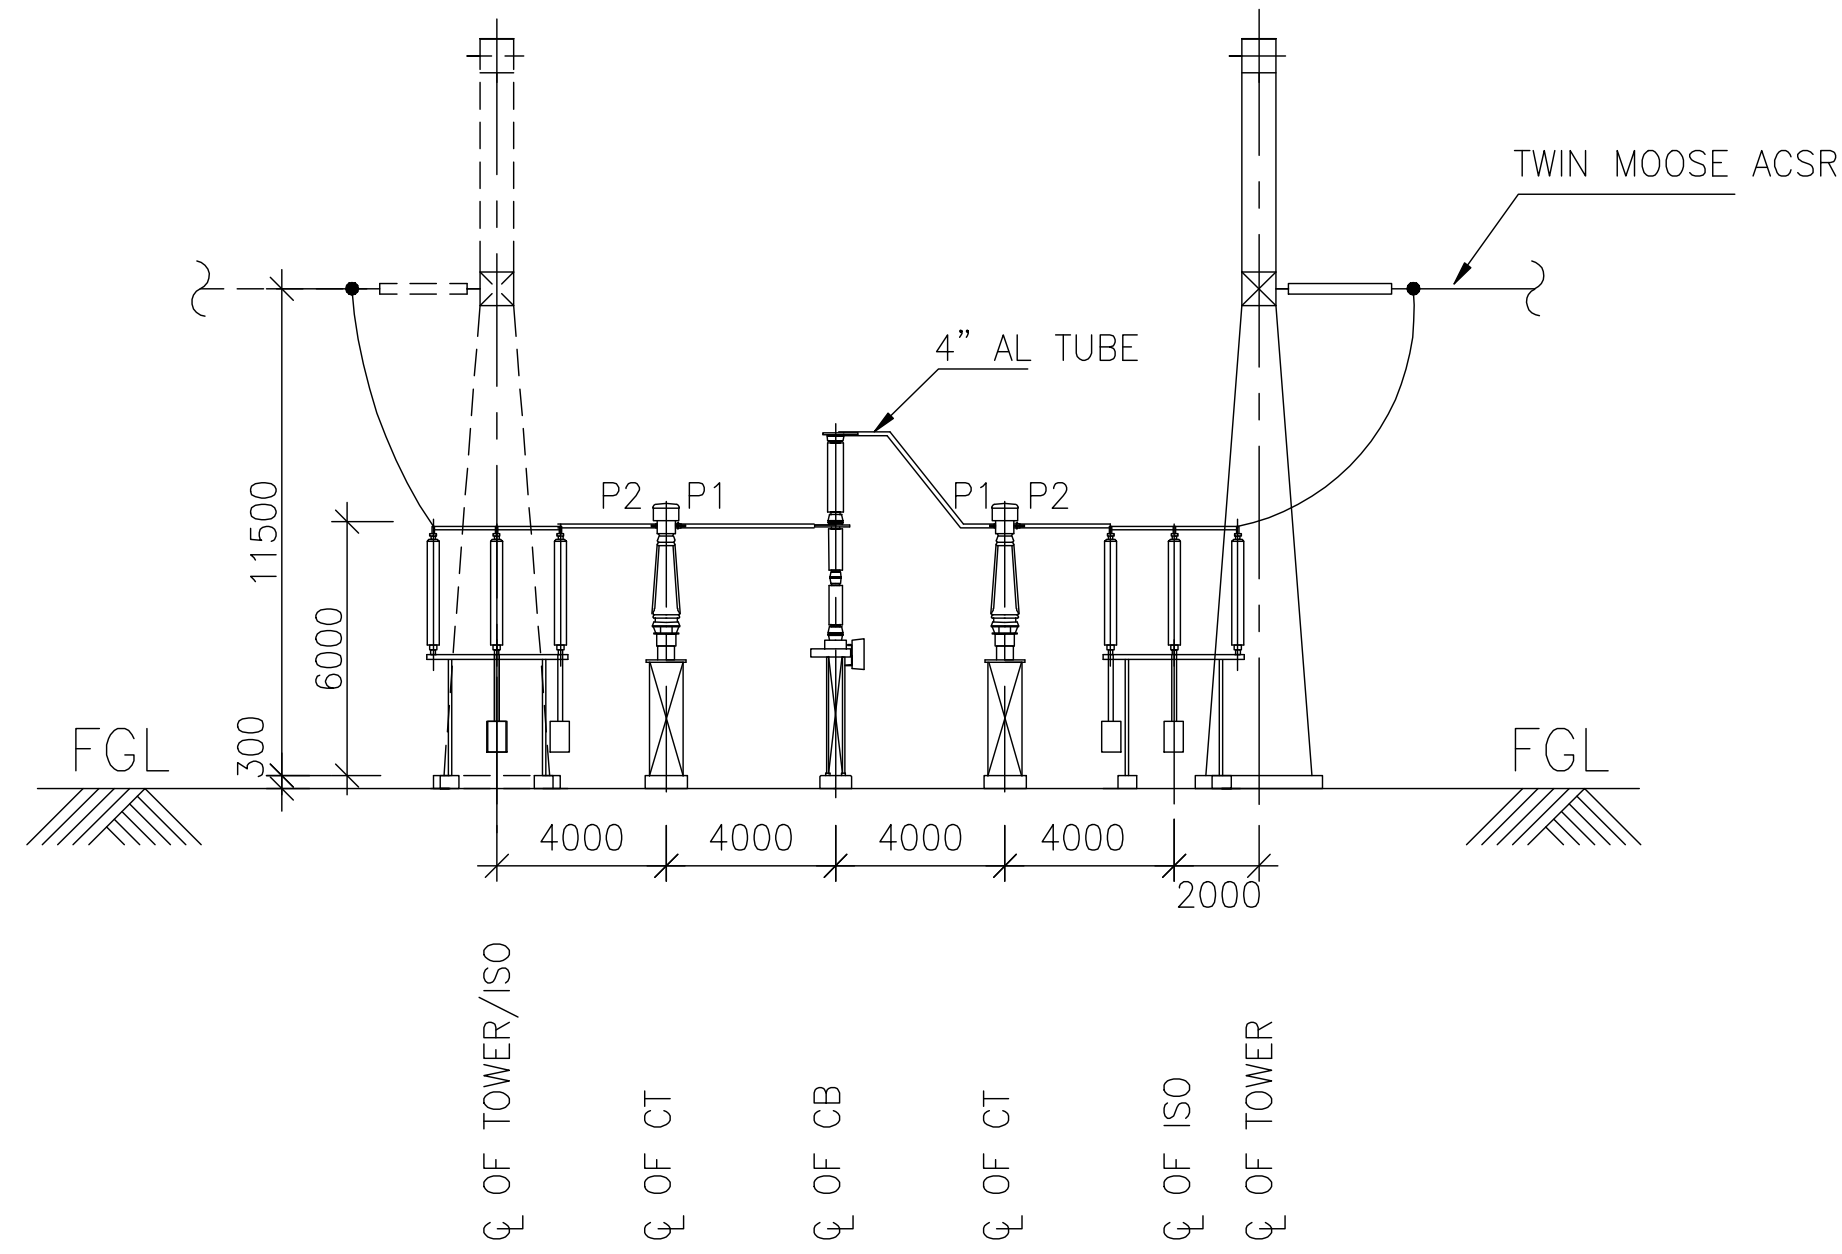

SECTION A-A  
(220kV BUS SECTION)

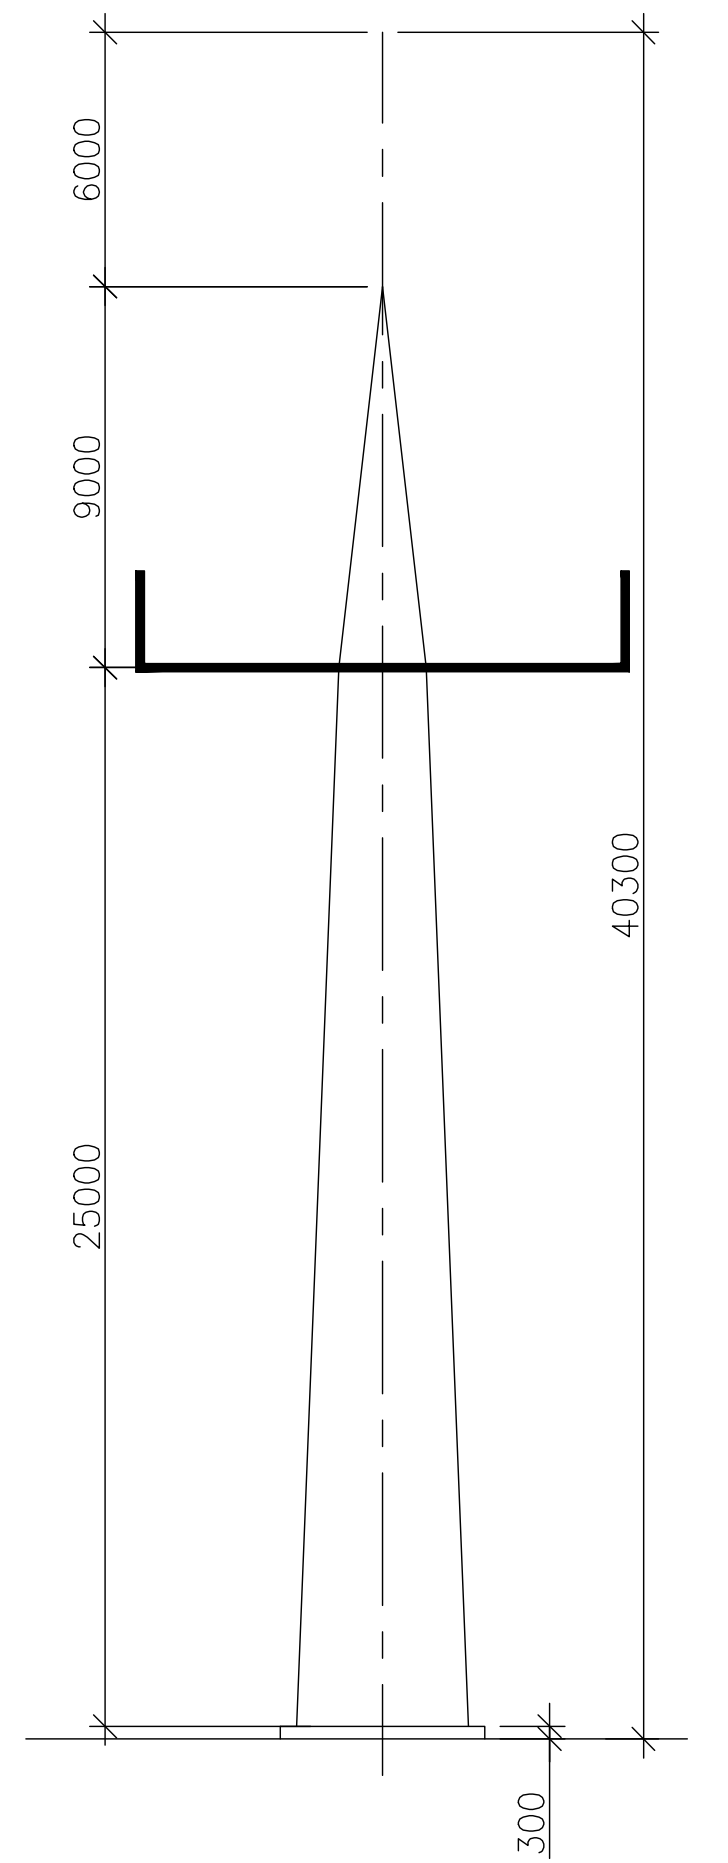

LIGHTNING MAST

PE-DG-293-100-E001	LAYOUT OF TRANSFORMER YARD
PE-DG-293-100-M001	PLOT PLAN
TDP K 493 E 201	220KV SWITCHYARD-SECTION LAYOUT (EXISTING PH.-I)
TB-3-309-510-101	SINGLE LINE DIAGRAM OF 220kV SWITCHYARD
REFERENCE DRG. NO.	TITLE
NAME OF CUSTOMER	GUJARAT STATE ENERGY GENERATION LIMITED
NAME OF CONSULTANT	FICHTNER CONSULTING ENGINEERS (I) LTD, CHENNAI
ADDITIONAL INFORMATION W.O.No. 87015	આણંદ/પરિવહનના કક્ષા નામ 350 MW COMBINED CYCLE POWER PLANT AT HAZIRA, GUJARAT
STATUS OF DRAWING	NAME OF CUSTOMER/PROJECT
DISTRIBUTION OF PRINTS	<div>ભારત હેવી ઇલેક્ટ્રિકલ્સ લિમિટેડ Bharat Heavy Electricals Ltd. TRANSMISSION PROJECTS DIVISION</div> <div>જામ /NAME KAPIL BA/RS GC</div> <div>દસ્તા /SIGN. --sd-- --sd-- --sd--</div> <div>દિ./DATE 30.05.08 30.05.08 30.05.08</div>
REV. DATE ALTERED CHECKED KAPIL BA/RS GC	સંશોધન / TITLE
01 16.08.08	જનુપાત / SCALE 1 : 250
ZONE	કાર્ડ કોડ CARD CODE
DRAWING MODIFIED AS PER CUSTOMER COMMENTS GSEG/HAZ/BHEL/HDR/3000/2008 DATED 19.06.2008 & 05.08.08	ડ્રોઇંગ.ક્ર./DRAWING NO. TB-1-309-316-002
	પૃષ્ઠ નં./SHEET No. 01
	ક્રમાંક પૃષ્ઠ /NEXT SHEET

COPY RIGHT AND CONFIDENTIAL  
The information on this document is the property of BHARAT HEAVY ELECTRICALS LIMITED  
It must not be used directly or indirectly in anyway detrimental to the interest of the company.

COMPUTER DRG. PATH NAME :

REF. DRG. No.

SIGN. & DATE

INVENTORY No.

12

11

10

9

8

7

6

5

01