

BOQ_ANNEXURE_2
PROJECT SPECIFIC DRAWING & DOCUMENT LIST

Sl. No.	DRAWING / DOCUMENT NUMBER	DRAWING / DOCUMENT TITLE
1	TB-1-424-510-001-REV 07	BIKANER III NEW S/S- SINGLE LINE DIAGRAM
2	TB-0-424-316-001-REV 08	BIKANER III NEW S/S- ELECTRICAL LAYOUT PLAN & SECTIONAL ELEVATION OF BIKANER (III) S/S
3	TB-0-424-316-003-REV 01	BIKANER III NEW S/S- STRUCTURE LAYOUT PLAN & SECTION
4	TB-0-424-316-004-REV 01	BIKANER III NEW S/S- DSLP LAYOUT
5	TB-0-424-316-008-REV 01, TB-424-316-008-BOQ -REV 01	BIKANER III NEW S/S- ERECTION KEY DIAGRAM LAYOUT PLAN & SECTION & BOQ
6	TB-0-424-316-007-REV 03	BIKANER III NEW S/S-CABLE TRENCH LAYOUT
7	TB-0-424-316-005-REV 03	BIKANER III NEW S/S- EARTHMAT LAYOUT DRGS
8	TB-2-424-316-009-REV 01	BIKANER III NEW S/S- CONTROL ROOM BUILDING CABLE TRENCH LAYOUT
9	C/ENGG/NRI/BIKANER-III/SS01/IND CAB TRENCH/01-REV 01	RCC DETAILS OF GRADE SLAB AND INDOOR CABLE TRENCHES FOR AUXILIARY BUILDING
10	USL/PGCIL/BHEL/2024-2025/1241A	BIKANER III NEW S/S- LT SWITCHGEAR - DRGS
11	Annexure-Aluminium_Welding	PROCEDURE FOR WELDING OF ALUMINIUM BUSES
12	TB-XXX-618-002a	TECHNICAL SPECIFICATION FOR EQUIPMENT FIXING HARDWARE
13	Annexure-TRF	N2 FILLING/ VACCUMING/ PURGING AND HEATING (IF REQUIRED) AS PER BHEL BHOPAL PROCEDURE FOR TRANSFORMERS/ REACTORS
14	TB-XXX-316-041-REV 02	TECHNICAL SPECIFICATION-PVC PIPES & BENDS
15	TB-XXX-316-040-REV 02	TECHNICAL SPECIFICATION-GI PIPES & BENDS

Note:

- 1 Above drawings are given for reference purpose. Latest revision of above drawings will be shared with successful bidder, which is to be followed, during contract execution stage.
- 2 Any other drawing/document related to BOQ line item will be shared with successful bidder during detailed engineering stage.

BOQ_ANNEXURE_3
STANDARD DRAWING & DOCUMENT LIST

Sl.No	DRAWING / DOCUMENT NUMBER	DRAWING / DOCUMENT TITLE
1	SECTION-PROJECT-REV.00	SECTION-PROJECT. (REV.00): SUBSTATION PACKAGE SS01 A) CONSTRUCTION OF 765/400/220KV BIKANER-III (NEW) PS B) EXTENSION OF 765 KV NEEMRANA-II S/S C) EXTENSION OF 400KV BIKANER-III S/S UNDER TRANSMISSION SYSTEM FOR EVACUATION OF POWER FROM REZ IN RAJASTHAN (7.7 GW) UNDER PHASE IV-PART I,
2	C/ENGG/SPEC/GTR (Rev.15)	SECTION-GENERAL TECHNICAL REQUIREMENTS (REV.15)
3	C / ENGG / SPEC / ERC REV. NO: 10	SECTION-SE (SWITCHYARD ERECTION (REV.10))
4	D-2-01-03-01-04	PRE COMMISSIONING PROCEDURE & FORMAT FOR SWITCHYARD ERECTION
5	Annexure-III	SPECIFIC REQUIREMENT_REV 07 WITH ANNEXURES
6	PG-C-ENGG-SPEC-SWGR-CB-REV.11	SECTION- SWITCHGEAR- CB (REV 11)
7	PG-C-ENGG-SPEC-SWGR-ISO-REV.R11B	SECTION- SWITCHGEAR- ISO (REV 11B)
8	PG-C-ENGG-SPEC-SWGR-INT-REV.R11	SECTION- SWITCHGEAR-INST (INSTRUMENT TRANSFORMER) (REV 11)
9	C/ENGG/SPEC/SWGR/SA/R12	SECTION- SWITCHGEAR- SURGE ARRESTER (REV 12)
10	PG-C-ENGG-SPEC-CAB-REV.06	SECTION-POWER AND CONTROL CABLES (REV.06)
11	C/ENGG/MODEL-SPEC/RT Rev. 11	TECHNICAL SPECIFICATION, UPTO 400KV SHUNT REACTOR
12	C/ENGG/SPEC/LT-TRF Rev. No. 5	TECHNICAL SPECIFICATION, SECTION: LT TRANSFORMER
13	C/ENGG/SPEC/STR (REV 06)	SECTION: STRUCTURE

Note:

- 1 Any other drawing/document related to BOQ line item will be shared with successful bidder during detailed engineering stage.

BOQ_ANNEXURE_2
PROJECT SPECIFIC DRAWING & DOCUMENT LIST

Sl. No.	DRAWING / DOCUMENT NUMBER	DRAWING / DOCUMENT TITLE
1	TB-1-424-510-101-REV 01	Bikaner II- SINGLE LINE DIAGRAM
2	TB-0-424-316-102-REV 02	Bikaner II- ELECTRICAL LAYOUT PLAN & SECTION
3	TB-0-424-316-104-REV 00/ TB202359-1002269-SI3480-DSLP-LAYOUT	Bikaner II- DSLP LAYOUT
4	TB-2-424-316-105-REV 00	Bikaner II- ERECTION KEY DIAGRAM LAYOUT PLAN & SECTION
5	TB-0-424-316-104-REV 00/ TB202359-1002269-SI3480-CABTR-LAYOUT-REV 00	Bikaner II-CABLE TRENCH LAYOUT
6	TB-0-424-316-103-REV 01	Bikaner II- EARTHMAT LAYOUT DRGS
7	Annexure-Aluminium_Welding	PROCEDURE FOR WELDING OF ALUMINIUM BUSES
8	TB-XXX-618-002a	TECHNICAL SPECIFICATION FOR EQUIPMENT FIXING HARDWARE
9	TB-XXX-316-041-REV 02	TECHNICAL SPECIFICATION-PVC PIPES & BENDS
10	TB-XXX-316-040-REV 02	TECHNICAL SPECIFICATION-GI PIPES & BENDS

Note:

- 1 Above drawings are given for reference purpose. Latest revision of above drawings will be shared with successful bidder, which is to be followed, during contract execution stage.
- 2 Any other drawing/document related to BOQ line item will be shared with successful bidder during detailed engineering stage.

BOQ_ANNEXURE_3
STANDARD DRAWING & DOCUMENT LIST

Sl.No	DRAWING / DOCUMENT NUMBER	DRAWING / DOCUMENT TITLE
1	SECTION-PROJECT-REV.00	SECTION-PROJECT. (REV.00): SUBSTATION PACKAGE SS01 A) CONSTRUCTION OF 765/400/220KV BIKANER-III (NEW) PS B) EXTENSION OF 765 KV NEEMRANA-II S/S C) EXTENSION OF 400KV BIKANER-III S/S UNDER TRANSMISSION SYSTEM FOR EVACUATION OF POWER FROM REZ IN RAJASTHAN (7.7 GW) UNDER PHASE IV-PART I,
2	C/ENGG/SPEC/GTR (Rev.15)	SECTION-GENERAL TECHNICAL REQUIREMENTS (REV.15)
3	C / ENGG / SPEC / ERC REV. NO: 10	SECTION-SE (SWITCHYARD ERECTION (REV.10))
4	D-2-01-03-01-04	PRE COMMISSIONING PROCEDURE & FORMAT FOR SWITCHYARD ERECTION
5	Annexure-III	SPECIFIC REQUIREMENT_REV 07 WITH ANNEXURES
6	PG-C-ENGG-SPEC-SWGR-CB-REV.11	SECTION- SWITCHGEAR- CB (REV 11)
7	PG-C-ENGG-SPEC-SWGR-ISO-REV.R11B	SECTION- SWITCHGEAR- ISO (REV 11B)
8	PG-C-ENGG-SPEC-SWGR-INT-REV.R11	SECTION- SWITCHGEAR-INST (INSTRUMENT TRANSFORMER) (REV 11)
9	C/ENGG/SPEC/SWGR/SA/R12	SECTION- SWITCHGEAR- SURGE ARRESTER (REV 12)
10	PG-C-ENGG-SPEC-CAB-REV.06	SECTION-POWER AND CONTROL CABLES (REV.06)
11	C/ENGG/SPEC/STR (REV 06)	SECTION: STRUCTURE

Note:

- 1 Any other drawing/document related to BOQ line item will be shared with successful bidder during detailed engineering stage.

संदर्भ/Ref : CC-ENGG-TB202359-1002269-BS3480-SS-SLD

Date : 28/12/2024

From : Somiran Das
Senior GM

To : Bharat Heavy Electricals Limited
Plot No.-7, Sector-142 Noida 201305
201305


Cc :

Subject : Substation Package SS-01 for (i) Establishment of 765/400/220kV Bikaner-III (New) Pooling Station including 400kV class Bus Reactor at Bikaner-III S/s; (ii) Extension of 765kV Neemrana-II S/s for termination of 765 kV D/c line Neemrana-II-Bikaner-III T/L and (iii) Extension of 400kV Bikaner-II S/s for termination of 400kV Bikaner-II Bikaner-III T/L under "Transmission system for evacuation of power from Rajasthan REZ Ph-IV (Part-1) (Bikaner Complex): PART-A"

LOA Ref : CC/T/W-AIS/DOM/A10/23/01956/NOA-1/24-102643/01 & 02 Dated 23/02/2024

Please find enclosed following drawings/ documents for necessary action at your end.

Vendor Drg. No. : TB-1-424-510-001
Orgn. Drg. No. : TB202359-1002269-BS3480-SS-SLD
Revision No. : 07
Drg. Title : BIKANER III NEW S/S- SINGLE LINE DIAGRAM
App. Category : CAT-I
Release Date : 28/12/2024

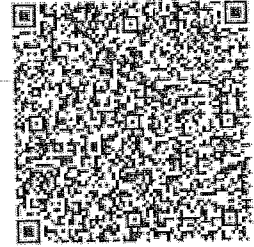

Scan to verify

Comments : Generally in order.

अनुमोदित श्रेणी/App. Category:

- I. फेब्रिकेशन/निर्माण/टाइप टेस्टिंग हेतु जारी।
Approved/released for fabrication/construction.
 - II. फेब्रिकेशन/निर्माण/टाइप टेस्टिंग हेतु अनुमोदित/जारी बशर्ते दिए गए टिप्पणियाँ एवं आशोधनों की सम्मिलित किया जाये। कृपया रिवाइज्ड दस्तावेज अनुमोदनार्थ प्रस्तुत करें।
Approved/released for fabrication/ construction subject to incorporation of comments and modification as noted. Revised drawing required for approval.
 - III. टिप्पणियाँ सम्मिलित करने के उपरांत दस्तावेज को अनुमोदनार्थ प्रस्तुत करें।
To be resubmitted for approval after incorporating the comments.
 - IV. सूचनार्थ एवं रिकार्ड हेतु।
For information and record.
- CATREL/ निर्माण हेतु जारी।
REL-CON Released for construction.

नोट/Note:

1. Approval/Comments conveyed herein neither relieve the contractor of his contractual obligations and his responsibilities, weights, quantities, design details assemble fits, performance particulars and conformity of the supplies with the Indian Statutory Laws as may be applicable, nor does it limits the purchaser's right under the contract.
2. The approval conveyed vide this letter does not cover the approval of make for sub-vendor items.

केन्द्रीय कार्यालय: "सौदामिनी", प्लॉट नंबर 2, सेक्टर -29, गुरुग्राम -122001, (हरियाणा), दूरभाष: 0124-2571700-719

Corporate Office: "Saudamini", Plot No. 2, Sector-29, Gurugram-122001, (Haryana) Tel.: 0124-2571700-719

पंजीकृत कार्यालय: बी -9, कुतुब इंस्टीट्यूशनल एरिया, कटवारिया सराय, नई दिल्ली -110016. दूरभाष: 011-26560112, 26560121, 26564812, 26564892, सीआईएन: L40101DL1989GOI038121

Registered Office: B-9, Qutab Institutional Area, Katwaria Sarai, New Delhi-110016. Tel: 011-26560112, 26560121, 26564812, 26564892, CIN : L40101DL1989GOI038121

Website: www.powergridindia.com

FIRST ANGLE PROJECTION (ALL DIMENSIONS ARE IN MM.)

DRG. NO. TB-1424-510-001

BILL OF QTY. FOR 765KV MAIN EQUIPMENTS:

SL.NO.	DESCRIPTION	RATING	S.D. QTY. (NO.)	SCOPE OF SUPPLY	MAKE
1	500 MVA (1-PH) AUTOTRANSFORMER	765/400/230KV	19	19	BHEL
2a.	110MVAR LINE REACTOR (1-PH)	765KV	6	6	GE
2b.	110MVAR BUS REACTOR (1-PH)	765KV	7	7	GE
3	NGR(600 Ohm) FOR REACTOR	765KV	2	2	GE
4	SF6 CIRCUIT BREAKER WITH CR WITH GSD (G-PH)	3150A	4	4	TBD
5	SF6 CIRCUIT BREAKER WITH CR WITHOUT GSD (S-PH)	3150A	2	2	TBD
6	SF6 CIRCUIT BREAKER WITHOUT CR WITH GSD (S-PH)	3150A	12	12	TBD
7	SF6 CIRCUIT BREAKER WITHOUT CR WITH GSD (1-PH) PROVISION	3150A	1	1	TBD
8	ISOLATOR WITH ONE E/S (3 PH) VERTICAL KNEE TYPE	3150A	22	20	8989E
9	ISOLATOR WITH TWO E/S (3 PH) VERTICAL KNEE TYPE	3150A	12	14	8989E1/8989E2
10	ISOLATOR WITH ONE E/S (1 PH) VERTICAL KNEE TYPE	3150A	32	32	8989E1
11	ISOLATOR WITHOUT E/S (1 PH) VERTICAL KNEE TYPE	3150A	58	58	89
12	CURRENT TRANSFORMER FOR EXTENDED CURRENT RATING.	3000A	48	48	CT
13	CVT (1 PH)	8800V	12	12	BHEL
14	SURGE ARRESTER (1 PH)	624 kV	38	38	LA
15	WAVE TRAP (1 PH) PEDESTAL TYPE	1mH, 3150A	04	04	WT

BILL OF QTY. FOR 132 & 33KV MAIN EQUIPMENTS:

SL.NO.	DESCRIPTION	RATING	S.D. QTY. (NO.)	SCOPE OF SUPPLY	LEGEND
1	SURGE ARRESTER (1 PH)	125 kV, 10 KA	2	2	POWERGRID
2	CT (1 PH) FOR TRANSFORMER NEUTRAL	33KV	6	6	BHEL
3	CT (1 PH) FOR REACTOR NEUTRAL	33KV	2	2	BHEL
4	14KV CIRCUIT BREAKER (1-PH) FOR NOB BY-PASSING ARRANGEMENT	14KV, 1250A, 31.5KA	2	2	LANGER

TBD: TO BE DECIDED

800KV CVT DETAILS

RATIO	CLASS-0.5/3P, 50VA	CLASS-0.5/3P, 50VA	CLASS-0.2, 50VA
SEC-I			
SEC-II			
SEC-III			

800KV CT DETAILS

CT RATIO	CLASS-0.5/3P, 50VA	CLASS-0.5/3P, 50VA	CLASS-0.2, 50VA
SEC-I			
SEC-II			
SEC-III			


- NOTES:-
- SYSTEM 50KA FOR 1 SEC., 50%, 3PH. SOUDLY EARTHED
 - 765KV 50KA FOR 1 SEC., 50%, 3PH. SOUDLY EARTHED
 - PHASE LOCATION OF WAVE TRAPS TO BE DECIDED DURING DETAILED ENGINEERING
 - 765KV EQUIPMENTS FOR ICT AND REACTOR SWITCHING ARE ALSO INCLUDED IN THE BOQ OF QTY. FOR 765KV MAIN EQUIPMENTS.

IT MUST NOT BE USED DIRECTLY OR INDIRECTLY IN ANY WAY DETRIMENTAL TO THE INTEREST OF THE COMPANY

INVENTRY NO. SIGN AND DATE REF. DRG. NO. COMPUTER DRG. PATH NAME :

COPY RIGHT AND CONFIDENTIAL

1 2 3 4 5 6 7 8

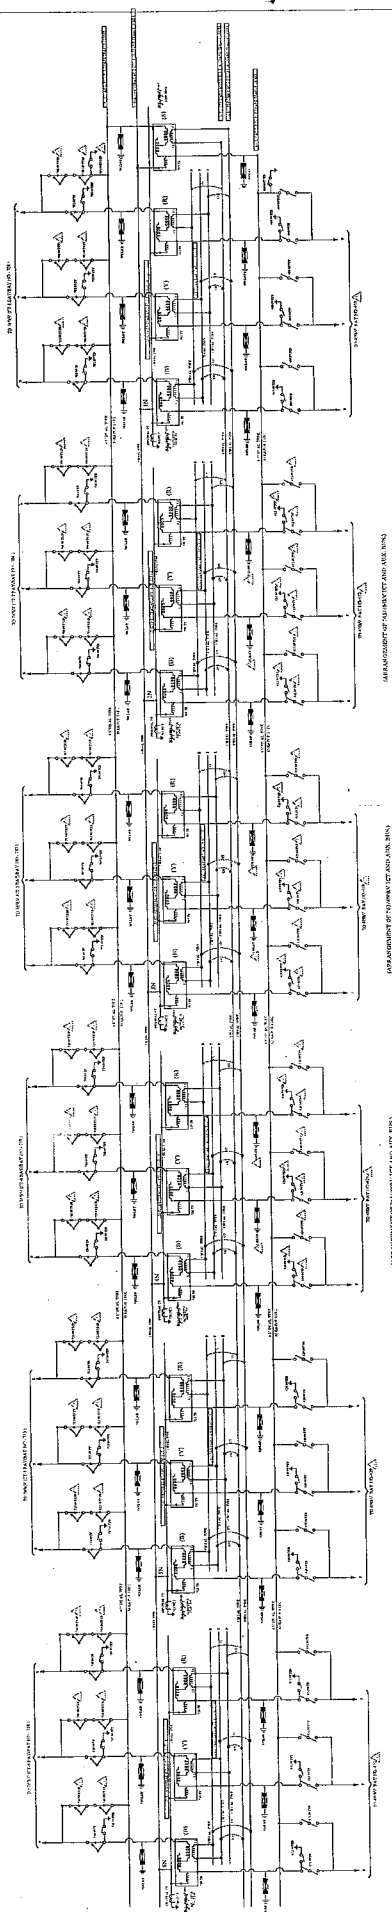
$$\sum_{i=1}^n \frac{1}{i} \log \frac{1}{i} = -\log n$$

ARRANGEMENT OF TELLURIDES AND ALX, 2018)

ARRANGEMENT OF INJURY VICT AND AID. BIRMINGHAM

APPARENTLY OF $^{\circ}\text{C}/\text{MMV}^{\circ}\text{C}$ AND AUX. MIN.

ARRANGEMENT OF SUBJECTS AND AGE. NINO

ΔΙΟΙΚΗΤΙΚΟ ΜΕΡΟΣ

MANUAL JUMPING NEED TO BE DONE BETWEEN TERTIARY BUS AND AUXILIARY BUS TO CONNECT THE SPARE TRANSFORMER IN PLACE OF FAULTY TRANSFORMER, WITH RESPECT TO PHASE

MANUAL JUMPING NEED TO BE DONE BETWEEN NEUTRAL BUS AND AUX. NEUTRAL BUS. WHILE TAKING OUT REAR DELTA TO TRANSFER MER FOR MAINTENANCE. ONLY ONE CONNECTION TO BE MADE AT A TIME.

[illegible]

SL NO	AUTO TRANSFORMER-6 ANY PHASE OUT OF SERVICE	AUTO TRANSFORMER-5 ANY PHASE OUT OF SERVICE	AUTO TRANSFORMER-4 ANY PHASE OUT OF SERVICE	AUTO TRANSFORMER-3 ANY PHASE OUT OF SERVICE	AUTO TRANSFORMER-2 ANY PHASE OUT OF SERVICE	AUTO TRANSFORMER-1 ANY PHASE OUT OF SERVICE	CONNECTIONS TO BE MADE
1						✓	IN
2					✓		2N
3							3N
4			✓				4N
5		✓					5N
6	✓						6N

NOTE: EQUIPMENTS SHOWN IN THIS SWITCHING SCHEME IS INCLUDED IN THE BILL OF QTY. OF RESPECTIVE 765KV AND 400KV SLD.




NOA NO.: COT/M-ABSD/MVA/102001889/HQA-124-10284301 NAME OF CUSTOMER: NAME OF CONTRACTOR: NAME OF PROJECT:		BIKANER HV TRANSMISSION TRANSMISSION LIMITED POWERSHED CORPORATION OF INDIA LIMITED Establishment of 6x3 500 MVA, 765/400 KV & 5x500 MVA 400/220 KV Bikaner-III Pooling Station (including 400KV, 2x125MVAR, reactor at Bikaner-II) DATE: 22.12.23 TIME: 12.12.23 PAGE: 22.12.23 REVISION: SY CHECK: NK APPROVED: SCS PROJECT: SCD DATE: 22.12.23 TIME: 12.12.23 PAGE: 22.12.23														
ADDITIONAL INFORMATION STATUS OF DRAWING		REVISION: SY CHECK: NK APPROVED: SCS PROJECT: SCD DATE: 22.12.23 TIME: 12.12.23 PAGE: 22.12.23														
DISTRIBUTION OF PRINTS		REVISION: SY CHECK: NK APPROVED: SCS PROJECT: SCD DATE: 22.12.23 TIME: 12.12.23 PAGE: 22.12.23														

FIRST ANGLE PROJECTION (ALL DIMENSIONS ARE IN MM.)

DRG. NO. TB-1-424510-001

STATCOM STATION-II

STATCOM STATION-I

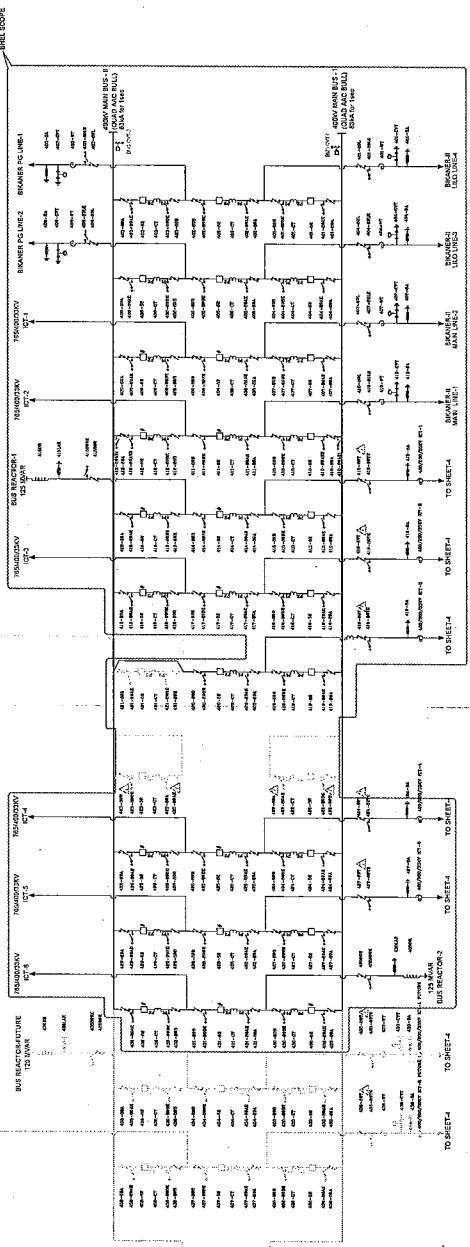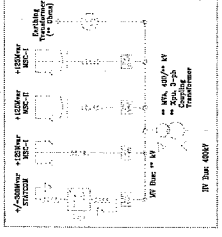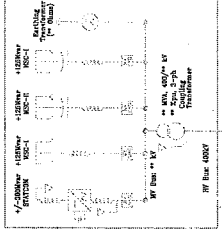


BILL OF QTY. FOR 400KV MAIN EQUIPMENTS. (BHEL'S SCOPE)

SL.NO.	DESCRIPTION	RATING	S. C. RATING	S.D. QTY. (NO.)	SYMBOL	LEGEND	MAKE
21	BREAKER	400 KV	63 KA FOR 1 S.	2	BR	BR	BHEL
22	DISCONNECTOR (D-PH)	3150A	63 KA FOR 1 S.	15	DS	DS	BHEL
23	SW CIRCUIT BREAKER WITHOUT CT WITH CSO (3-PH)	3150A	63 KA FOR 1 S.	14	CB	CB	BHEL
24	ISOLATOR WITH ONE E/S (3 PH) DOUBLE BREAK TYPE	3150A	63 KA FOR 1 S.	69	IS	IS	BHEL
25	ISOLATOR WITH TWO E/S (3 PH) DOUBLE BREAK TYPE	3150A	63 KA FOR 1 S.	2	IS	IS	BHEL
26	ISOLATOR WITH ONE E/S (1 PH) DOUBLE BREAK TYPE	3150A	63 KA FOR 1 S.	19	IS	IS	BHEL
27	ISOLATOR WITHOUT E/S (1 PH) DOUBLE BREAK TYPE	3150A	63 KA FOR 1 S.	17	IS	IS	BHEL
28	CURRENT TRANSFORMER	3000A	63 KA FOR 1 S.	87	CT	CT	BHEL
29	CTV (1 PHL)	4400V		24	CTV	CTV	BHEL
30	LINE TRAP (1 PHL)	400KV	63 KA FOR 1 S.	12	WT	WT	TED
31	SURGE ARRESTER (1 PHL)	338 KV		56	LA	LA	T&R
31	SOONVA 400/250/33KV ICT	400KV		5	ICT	ICT	T&R

NOTES:-
1. SUPPLY & INSTALLATION OF 400KV MAIN EQUIPMENTS.
2. PRESENT LOCATION OF MAIN TRAPS TO BE DECIDED DURING DETAILED ENGINEERING.
3. FUTURE LOCATION OF MAIN TRAPS TO BE DECIDED DURING DETAILED ENGINEERING.
4. 400KV EQUIPMENTS FOR 765/400/230KV ICT SWITCHING ARE ALSO INCLUDED IN THE BOQ OF QTY. FOR 400KV MAIN EQUIPMENTS.

BILL OF QTY. FOR LT SUPPLY (BHEL'S SCOPE)

SL.NO.	RATING	DESCRIPTION	SYMBOL	S.D. QTY. (NO.)	NOA QTY. (NO.)
1	72.5KV, 1250A, 25KA FOR 1 SEC. 3PH CIRCUIT BREAKER	72.5KV, 1250A, 25KA FOR 1 SEC. 3PH CIRCUIT BREAKER	CB	2	2
2	72.5KV, 1250A, 25KA FOR 1 SEC. 3PH DOUBLE BREAK DISCONNECTOR W/O IS	72.5KV, 1250A, 25KA FOR 1 SEC. 3PH DOUBLE BREAK DISCONNECTOR W/O IS	DS	2	2
3	72.5KV, 1250A, 25KA FOR 1 SEC. 3PH DOUBLE BREAK DISCONNECTOR W/ IS	72.5KV, 1250A, 25KA FOR 1 SEC. 3PH DOUBLE BREAK DISCONNECTOR W/ IS	DS	2	2
4	72.5KV, 1250A, 25KA FOR 1 SEC. 3PH DOUBLE BREAK DISCONNECTOR W/ IS	72.5KV, 1250A, 25KA FOR 1 SEC. 3PH DOUBLE BREAK DISCONNECTOR W/ IS	DS	2	2
5	72.5KV, 1250A, 25KA FOR 1 SEC. 3PH DOUBLE BREAK DISCONNECTOR W/ IS	72.5KV, 1250A, 25KA FOR 1 SEC. 3PH DOUBLE BREAK DISCONNECTOR W/ IS	DS	2	2

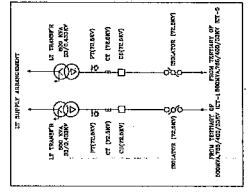

CODE	CURRENT RATIO	ACCURACY CLASS	OUTER BUS	INR. RPT. (V)	MAX. IN. AT RPT. (V)	PURPOSE
1	2000/500/1	0.5	RE	2000-500-500	15-10-2.5	RE
2	2000/500/1	0.5	RE	2000-500-500	15-10-2.5	RE
3	2000/500/1	0.5	RE	2000-500-500	15-10-2.5	RE
4	2000/500/1	0.5	RE	2000-500-500	15-10-2.5	RE
5	2000/500/1	0.5	RE	2000-500-500	15-10-2.5	RE
6	2000/500/1	0.5	RE	2000-500-500	15-10-2.5	RE

RATIO	CLASS	CLASS	CLASS
SEC-I	CLASS-0.5/0.5	CLASS-0.5/0.5	CLASS-0.5/0.5
SEC-II	CLASS-0.5/0.5	CLASS-0.5/0.5	CLASS-0.5/0.5
SEC-III	CLASS-0.5/0.5	CLASS-0.5/0.5	CLASS-0.5/0.5

BIKARNER III NEEMRAMA TRANSMISSION LIMITED
POWERGRID CORPORATION OF INDIA LIMITED
Establishment of 6x150 MVA, 765/400 KV & 5000 MVA
NEEMRAMA TRANSMISSION PROJECT (including 400KV,
2x1320 MVA Reactor at Bikaner-III)

NAME OF CONTRACTOR: BIKARNER III NEEMRAMA TRANSMISSION PROJECT
NAME OF PROJECT: BIKARNER III NEEMRAMA TRANSMISSION PROJECT
STATE OF DRAWING: BIKARNER III NEEMRAMA TRANSMISSION PROJECT
DISTRIBUTION OF PRINTS: BIKARNER III NEEMRAMA TRANSMISSION PROJECT
DATE: 15/12/2023
BY: [Signature]
CHECKED: [Signature]
APPROVED: [Signature]

REVISIONS:
REV. NO. 1: DATE 15/12/2023, BY [Signature], DESCRIPTION: [Description]
REV. NO. 2: DATE 15/12/2023, BY [Signature], DESCRIPTION: [Description]
REV. NO. 3: DATE 15/12/2023, BY [Signature], DESCRIPTION: [Description]
REV. NO. 4: DATE 15/12/2023, BY [Signature], DESCRIPTION: [Description]
REV. NO. 5: DATE 15/12/2023, BY [Signature], DESCRIPTION: [Description]
REV. NO. 6: DATE 15/12/2023, BY [Signature], DESCRIPTION: [Description]
REV. NO. 7: DATE 15/12/2023, BY [Signature], DESCRIPTION: [Description]
REV. NO. 8: DATE 15/12/2023, BY [Signature], DESCRIPTION: [Description]

PROJECT NO. TB-1-424510-001
SHEET NO. 07
TOTAL SHEETS: 07

संदर्भ/Ref : CC-ENGG-TB202359-1002269-BS3480-ELECT-LAYOUT

Date : 27/12/2024

From : Somiran Das
Senior GM

To : Bharat Heavy Electricals Limited
Plot No.-7, Sector-142 Noida 201305
201305

Cc :

Subject : Substation Package SS-01 for (i) Establishment of 765/400/220kV Bikaner-III (New) Pooling Station including 400kV class Bus Reactor at Bikaner-III S/s; (ii) Extension of 765kV Neemrana-II S/s for termination of 765 kV D/c line Neemrana-II-Bikaner-III T/L and (iii) Extension of 400kV Bikaner-II S/s for termination of 400kV Bikaner-II Bikaner-III T/L under "Transmission system for evacuation of power from Rajasthan REZ Ph-IV (Part-1) (Bikaner Complex): PART-A"

LOA Ref : CC/T/W-AIS/DOM/A10/23/01956/NOA-1/24-102643/01 & 02 Dated 23/02/2024

Please find enclosed following drawings/ documents for necessary action at your end.

Vendor Drg. No. : TB-0-424-316-001


Orgn. Drg. No. : TB202359-1002269-BS3480-ELECT-LAYOUT

Revision No. : 08

Drg. Title : BIKANER III NEW S/S- ELECTRICAL LAYOUT PLAN & SECTION

App. Category : CAT-I

Release Date : 27/12/2024

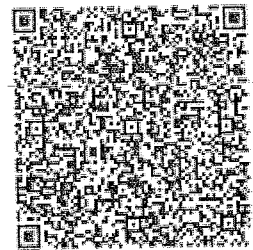

Scan to verify

Comments : Generally in order

अनुमोदित श्रेणी/App. Category:

- I. फेब्रिकेशन/निर्माण/टाइप टेस्टिंग हेतु जारी।
Approved/released for fabrication/construction.
- II. फेब्रिकेशन/निर्माण/टाइप टेस्टिंग हेतु अनुमोदित/जारी बशर्ते दिए गए टिप्पणियाँ एवं आशोधनों की सम्मिलित किया जाये। कृपया रिवाइज्ड दस्तावेज अनुमोदनार्थ प्रस्तुत करें।
Approved/released for fabrication/ construction subject to incorporation of comments and modification as noted. Revised drawing required for approval.
- III. टिप्पणियाँ सम्मिलित करने के उपरांत दस्तावेज को अनुमोदनार्थ प्रस्तुत करें।
To be resubmitted for approval after incorporating the comments.
- IV. सूचनार्थ एवं रिकार्ड हेतु।
For information and record.
- CATREL/ निर्माण हेतु जारी।
REL-CON Released for construction.

नोट/Note:

1. Approval/Comments conveyed herein neither relieve the contractor of his contractual obligations and his responsibilities, weights, quantities, design details assemble fits, performance particulars and conformity of the supplies with the Indian Statutory Laws as may be applicable, nor does it limits the purchaser's right under the contract.
2. The approval conveyed vide this letter does not cover the approval of make for sub-vendor items.

केन्द्रीय कार्यालय: "सौदामिनी", प्लॉट नंबर 2, सेक्टर -29, गुरुग्राम -122001, (हरियाणा), दूरभाष: 0124-2571700-719

Corporate Office: "Saudamini", Plot No. 2, Sector-29, Gurugram-122001, (Haryana) Tel.: 0124-2571700-719

पंजीकृत कार्यालय: बी -9, कुतुब इंस्टीट्यूशनल एरिया, कटवारिया सराय, नई दिल्ली -110016. दूरभाष: 011-26560112, 26560121, 26564812, 26564892, सीआईएन: L40101DL1989GOI038121

Registered Office: B-9, Qutab Institutional Area, Katwaria Sarai, New Delhi-110016. Tel: 011-26560112, 26560121, 26564812, 26564892, CIN : L40101DL1989GOI038121
Website: www.powergridindia.com

COPY RIGHT AND CONFIDENTIAL
THE INFORMATION ON THIS DOCUMENT IS THE PROPERTY OF BHARAT HEAVY ELECTRICALS LIMITED.
IT MUST NOT BE USED DIRECTLY OR INDIRECTLY IN ANY WAY DETRIMENTAL TO THE INTEREST OF THE COMPANY

COMPUTER DRG: PATH NAME :


ON

ATE

ON

NOTES:

- [illegible]

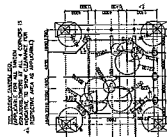[illegible][illegible]

FIRST ANGLE PROJECTION (ALL DIMENSIONS ARE IN MM)

DRG. NO. TB-0-424-316-003

[illegible]

THE INFORMATION ON THIS DOCUMENT IS THE PROPERTY OF BHARAT HEAVY ELECTRICALS LIMITED.
COPY RIGHT AND CONFIDENTIAL
IT MUST NOT BE USED DIRECTLY OR INDIRECTLY IN ANY WAY DETRIMENTAL TO THE INTEREST OF THE COMPANY

COMPUTER ORG. PATH NAME :

'ON'

SIGN AND DATE

ON

ACCORDANCE DETAILS				
UNITED DESCRIPTION	STL HEIGHT MEAS FROM POINT (m)	CONCRETE BRN (+)	TYPE	CURBET (M/S)
AB-02	1.88	21/08	DB	12
AB-03	21.8/24/25/25.5	21/07/11	DB	23
AB-04	21.8/24/25/25.5	24/07	WALL	12
AB-05	18.8/24/25/25.5	21/07	CONCRETE	12
NO. OF POINTS				50

ALLOY BEAM SERIES				
BEAM TYPE	NO. OF POINTS	BEAM LENGTH (in)	CONDUCTIVE SPAN (in)	NO. OF BEAMS
40-01	10.5	30	30/70	30
40-02	10	30	32/68 (70)	30
40-03	10.5	30	30/70 (70)	30

DRIFT TOWER DETAILS				
TOWER IDENTIFICATION	SPR. HEIGHT (METER) ABOVE PILETOP (m)	CONCRETE SPAN (m)	TYPE	PILE (m)
OTB	12.24(39.83)X12.24	42	MOBILE	
OTD	15.24	48	FIXD	
OTC	12.24(39.83)X15.24	48	GRNCL	
OTG	15.24	42	MOBILE	
OTF	15.24	42	MOBILE	
OTK	12.24(39.83)X12.24	33	MOBILE/GRNCL	

2000 BEAM DETAILS				
BEAM TYPE	SPAN	BEAM LENGTH (ft)	CONCRETE STRENGTH	QUALITY (PSS)
B1	N/S	13	200	B ✓
B2	N/S/E/W	17	52	11/75 ✓
NO. OF BEAMS				4 ✓

[illegible]

TYPE	SERIAL NAME	STATUS
SY		-SGD-
SS		-SGD-
SXS		-SGD-

POWERED DRAWING NO.

TB202359-1002268-BSS480-ST

5/6/21 PM / DRAWING NO.
TB-0424-316-003

DRAWN BY / SHEET NO. 01 TOTAL SHEETS

ESTABL. NO. / DRAWING NO.
TB-0424-316-003

100

PLAN & SECTION

ON A

संदर्भ/Ref : CC-ENGG-TB202359-1002269-BS3480-EKD-LAYOUT

Date : 27/01/2025

From : Somiran Das
Senior GM

To : Bharat Heavy Electricals Limited
Plot No.-7, Sector-142 Noida 201305
201305

Cc :

Subject : Substation Package SS-01 for (i) Establishment of 765/400/220kV Bikaner-III (New) Pooling Station including 400kV class Bus Reactor at Bikaner-III S/s; (ii) Extension of 765kV Neemrana-II S/s for termination of 765 kV D/c line Neemrana-II-Bikaner-III T/L and (iii) Extension of 400kV Bikaner-II S/s for termination of 400kV Bikaner-II Bikaner-III T/L under "Transmission system for evacuation of power from Rajasthan REZ Ph-IV (Part-1) (Bikaner Complex): PART-A"

LOA Ref : CC/T/W-AIS/DOM/A10/23/01956/NOA-1/24-102643/01 & 02 Dated 23/02/2024

Please find enclosed following drawings/ documents for necessary action at your end.

Vendor Drg. No. : TB-0-424-316-008


Orgn. Drg. No. : TB202359-1002269-BS3480-EKD-LAYOUT

Revision No. : 01

Drg. Title : BIKANER III NEW S/S- ERECTION KEY DIAGRAM LAYOUT PLAN & SECTION

App. Category : CAT-II

Release Date : 27/01/2025

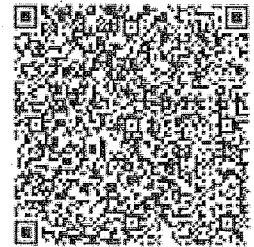

Scan to verify

Comments : Comments marked

अनुमोदित श्रेणी/App. Category:

- I. फेब्रिकेशन/निर्माण/टाइप टेस्टिंग हेतु जारी।
Approved/released for fabrication/construction.
 - II. फेब्रिकेशन/निर्माण/टाइप टेस्टिंग हेतु अनुमोदित/जारी बशर्ते दिए गए टिप्पणियाँ एवं आशोधनों की सम्मिलित किया जाये। कृपया रिवाइज्ड दस्तावेज अनुमोदनार्थ प्रस्तुत करें।
Approved/released for fabrication/ construction subject to incorporation of comments and modification as noted. Revised drawing required for approval.
 - III. टिप्पणियाँ सम्मिलित करने के उपरांत दस्तावेज को अनुमोदनार्थ प्रस्तुत करें।
To be resubmitted for approval after incorporating the comments.
 - IV. सूचनार्थ एवं रिकार्ड हेतु।
For information and record.
- CATREL/ निर्माण हेतु जारी।
REL-CON Released for construction.

नोट/Note:

1. Approval/Comments conveyed herein neither relieve the contractor of his contractual obligations and his responsibilities, weights, quantities, design details assemble fits, performance particulars and conformity of the supplies with the Indian Statutory Laws as may be applicable, nor does it limits the purchaser's right under the contract.
2. The approval conveyed vide this letter does not cover the approval of make for sub-vendor items.

केन्द्रीय कार्यालय: "सौदामिनी", प्लॉट नंबर 2, सेक्टर -29, गुरुग्राम -122001, (हरियाणा), दूरभाष: 0124-2571700-719

Corporate Office: "Saudamini", Plot No. 2, Sector-29, Gurugram-122001, (Haryana) Tel.: 0124-2571700-719

पंजीकृत कार्यालय: बी -9, कुतुब इंस्टीट्यूशनल एरिया, कटवारीया सराय, नई दिल्ली -110016. दूरभाष: 011-26560112, 26560121, 26564812, 26564892, सीआईएन: L40101DL1989GOI038121

Registered Office: B-9, Qutab Institutional Area, Katwaria Sarai, New Delhi-110016. Tel: 011-26560112, 26560121, 26564812, 26564892, CIN : L40101DL1989GOI038121

Website: www.powergridindia.com

THE INFORMATION ON THIS DOCUMENT IS THE PROPERTY OF BHARAT HEAVY ELECTRICALS LIMITED.
IT MUST NOT BE USED DIRECTLY OR INDIRECTLY IN ANY WAY DETRIMENTAL TO THE INTEREST OF THE COMPANY


COMPUTER DRG. PATH NAME :

NO.

DATE _____

ON 12

REFER ENCLOSED DOCUMENT TB-424-318-80Q FOR ITEM DESCRIPTION & QUANTITY OF CLAMPS, CONNECTOR & STRINGING HARDWARES

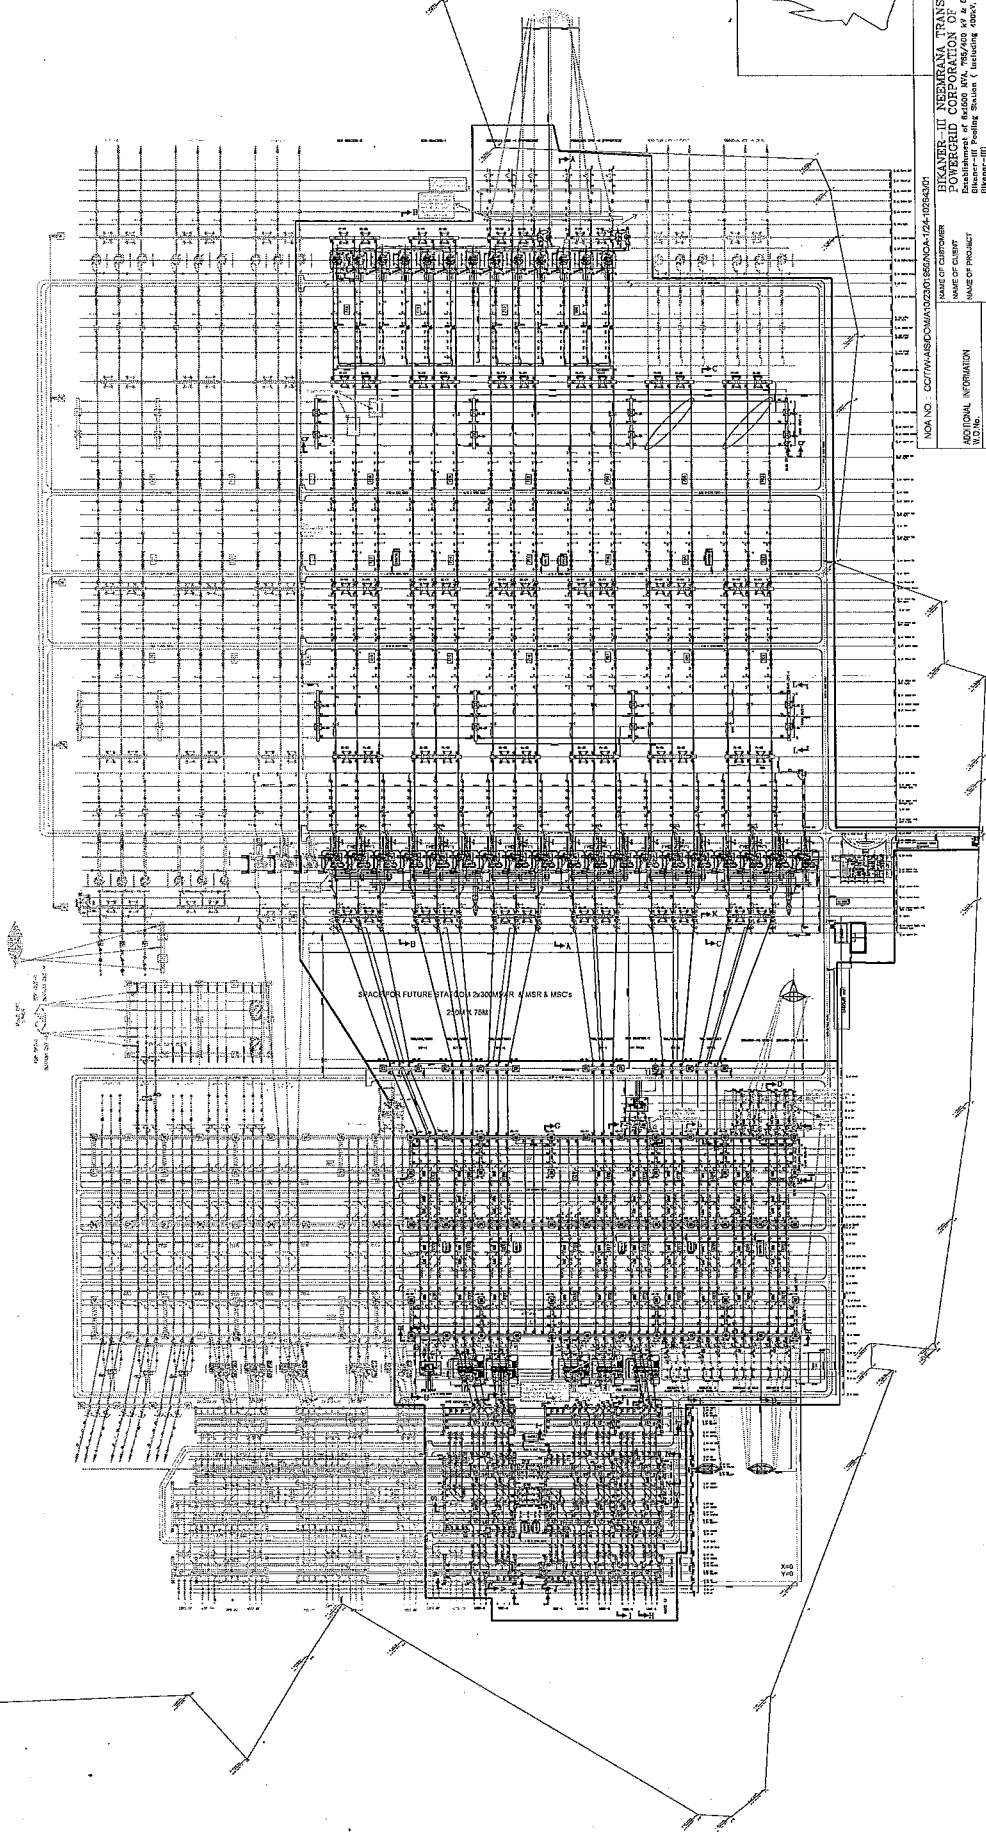[illegible]

THE INFORMATION ON THIS DOCUMENT IS THE PROPERTY OF BHARAT HEAVY ELECTRONS LIMITED.
IT MUST NOT BE USED DIRECTLY OR INDIRECTLY IN ANY WAY DETRIMENTAL TO THE INTEREST OF THE COMPANY


NO.	COMPUTER ORG. PATH NAME :
-----	---------------------------

23

25

25


NO.	QTY	UNIT	DESCRIPTION & QUANTITY OF CLAPS, CONNECTOR & STRINGING HARDWARE
1	1	EA	1" x 1" x 1/4" CLAP
2	1	EA	1" x 1" x 1/4" CLAP
3	1	EA	1" x 1" x 1/4" CLAP
82	1	EA	1" x 1" x 1/4" CLAP
83	1		

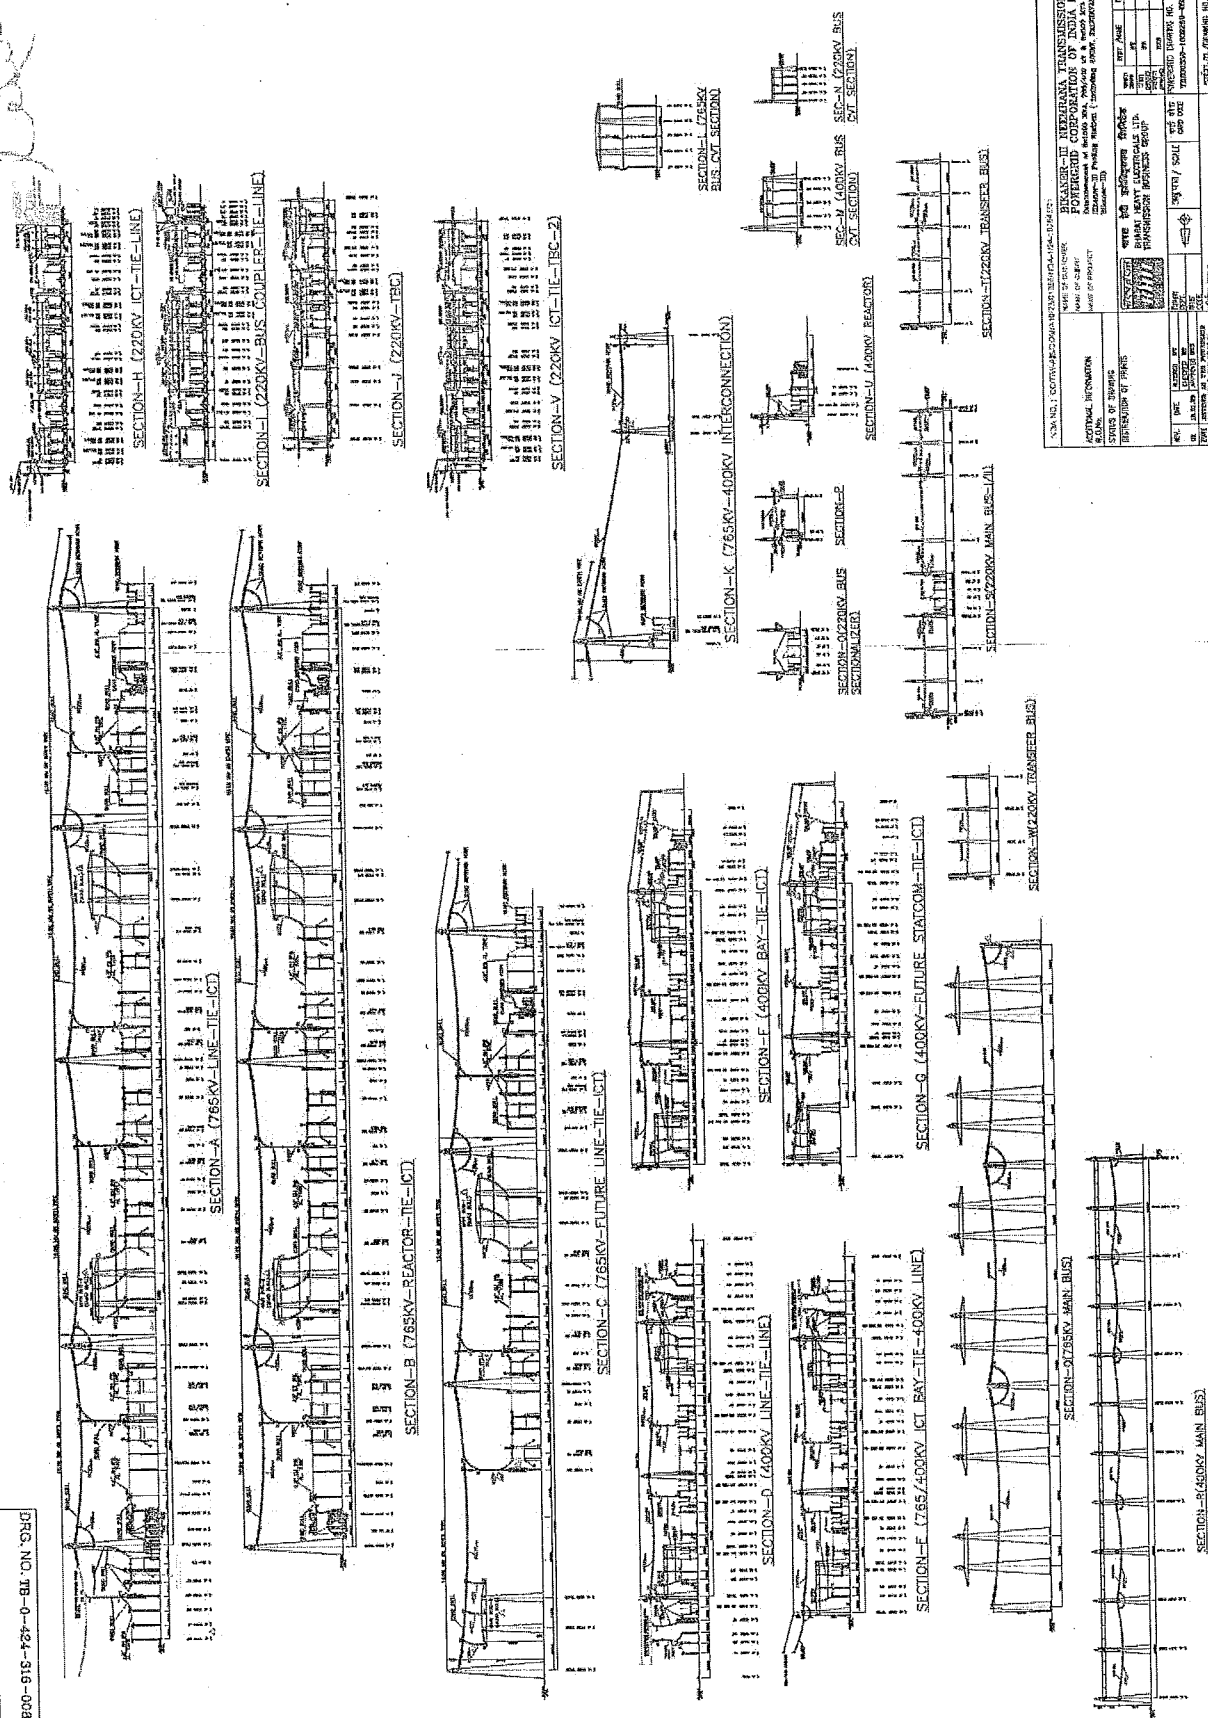[illegible]

FIRST ANGLE PROJECTION (ALL DIMENSIONS ARE IN MM.)

DRG. NO. TB-0-424-516-006





REL OF CITY OF BIG POST INSULATORS FOR 25KV
SINGLE 101 CONNECTION ARRANGEMENT

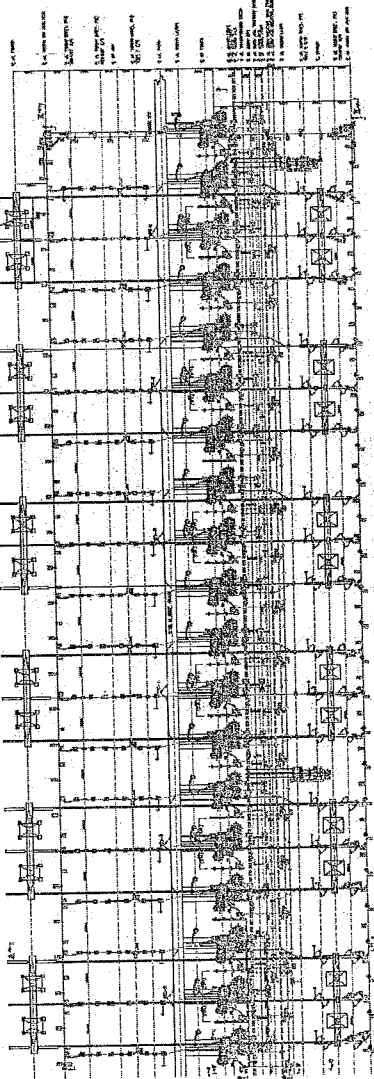

ITEM	DESCRIPTION	QTY	UNIT	REMARKS
1	25KV 101 POST INSULATOR FOR 25KV 101	20	PCS	
2	25KV 101 POST INSULATOR FOR 25KV 101	20	PCS	
3	25KV 101 POST INSULATOR FOR 25KV 101	20	PCS	
4	25KV 101 POST INSULATOR FOR 25KV 101	20	PCS	

REL OF CITY OF BIG POST INSULATORS

ITEM	DESCRIPTION	QTY	UNIT	REMARKS
1	25KV 101 POST INSULATOR FOR 25KV 101	20	PCS	
2	25KV 101 POST INSULATOR FOR 25KV 101	20	PCS	
3	25KV 101 POST INSULATOR FOR 25KV 101	20	PCS	
4	25KV 101 POST INSULATOR FOR 25KV 101	20	PCS	

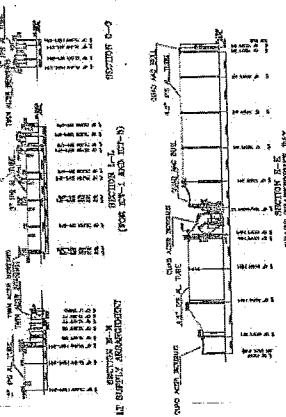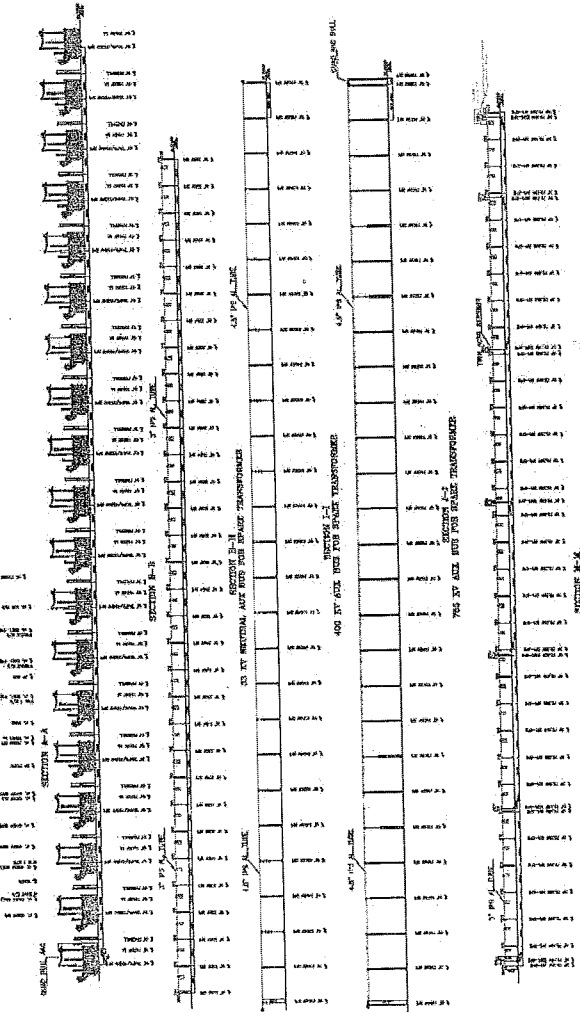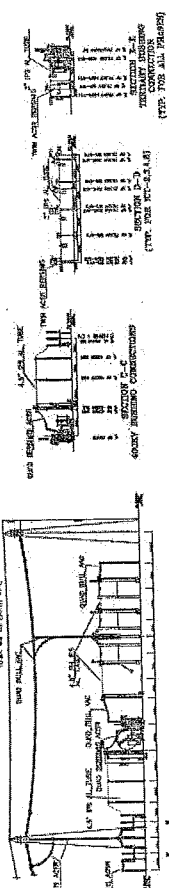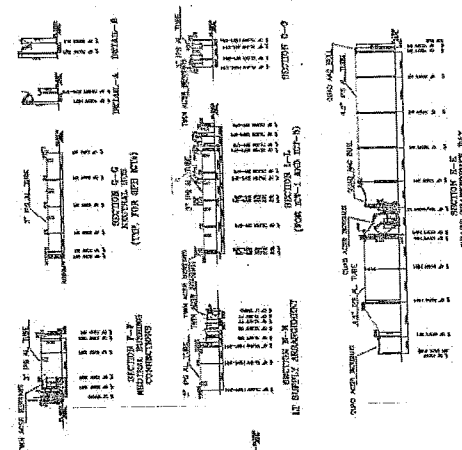

GENERAL INFORMATION		SPECIFICATIONS		REMARKS	
PROJECT NO.	TE202359-100269-B524-04-EKO-LAYOUT OF THE PLANT	DATE	10/10/2023	BY	10/10/2023
PROJECT NAME	25KV 101 POST INSULATOR FOR 25KV 101	DATE	10/10/2023	BY	10/10/2023
PROJECT LOCATION	25KV 101 POST INSULATOR FOR 25KV 101	DATE	10/10/2023	BY	10/10/2023
PROJECT DESCRIPTION	25KV 101 POST INSULATOR FOR 25KV 101	DATE	10/10/2023	BY	10/10/2023
PROJECT DRAWING NO.	TE202359-100269-B524-04-EKO-LAYOUT OF THE PLANT	DATE	10/10/2023	BY	10/10/2023
PROJECT DRAWING NAME	25KV 101 POST INSULATOR FOR 25KV 101	DATE	10/10/2023	BY	10/10/2023
PROJECT DRAWING LOCATION	25KV 101 POST INSULATOR FOR 25KV 101	DATE	10/10/2023	BY	10/10/2023
PROJECT DRAWING DESCRIPTION	25KV 101 POST INSULATOR FOR 25KV 101	DATE	10/10/2023	BY	10/10/2023
PROJECT DRAWING NO.	TE202359-100269-B524-04-EKO-LAYOUT OF THE PLANT	DATE	10/10/2023	BY	10/10/2023
PROJECT DRAWING NAME	25KV 101 POST INSULATOR FOR 25KV 101	DATE	10/10/2023	BY	10/10/2023
PROJECT DRAWING LOCATION	25KV 101 POST INSULATOR FOR 25KV 101	DATE	10/10/2023	BY	10/10/2023
PROJECT DRAWING DESCRIPTION	25KV 101 POST INSULATOR FOR 25KV 101	DATE	10/10/2023	BY	10/10/2023

GENERAL INFORMATION		SPECIFICATIONS		REMARKS	
PROJECT NO.	TE202359-100269-B524-04-EKO-LAYOUT OF THE PLANT	DATE	10/10/2023	BY	10/10/2023
PROJECT NAME	25KV 101 POST INSULATOR FOR 25KV 101	DATE	10/10/2023	BY	10/10/2023
PROJECT LOCATION	25KV 101 POST INSULATOR FOR 25KV 101	DATE	10/10/2023	BY	10/10/2023
PROJECT DESCRIPTION	25KV 101 POST INSULATOR FOR 25KV 101	DATE	10/10/2023	BY	10/10/2023
PROJECT DRAWING NO.	TE202359-100269-B524-04-EKO-LAYOUT OF THE PLANT	DATE	10/10/2023	BY	10/10/2023
PROJECT DRAWING NAME	25KV 101 POST INSULATOR FOR 25KV 101	DATE	10/10/2023	BY	10/10/2023
PROJECT DRAWING LOCATION	25KV 101 POST INSULATOR FOR 25KV 101	DATE	10/10/2023	BY	10/10/2023
PROJECT DRAWING DESCRIPTION	25KV 101 POST INSULATOR FOR 25KV 101	DATE	10/10/2023	BY	10/10/2023

COPY RIGHT AND CONFIDENTIAL
THE INFORMATION ON THIS DOCUMENT IS THE PROPERTY OF BHARAT HEAVY ELECTRICALS LIMITED
IT MUST NOT BE USED DIRECTLY OR INDIRECTLY IN ANY WAY DETRIMENTAL TO THE INTEREST OF THE COMPANY


COMPILED BY: P. V. R. RAO

REV. NO. 1


DATE: 10/10/2023

BY: P. V. R. RAO

SECTION-R1(765KV REACTOR AREA- 709.712).

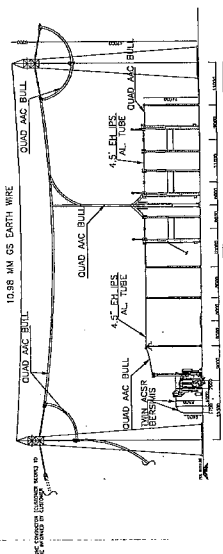


SECTION--R6(765KV REACTOR AREA-715,718)

 

SECTION-R7(76.5KV SPARE REACTOR)

S/L NO.	DESCRIPTION	S/LD QTY.	NO. OF QTY.	SYMBOL	SCOPE OF SUPPLY
1	785KV BIN BUS POST INSULATOR FOR 785KV SPARE RECTOR CONNECTION ARRANGEMENT	21 NO.	01 LOT	◆	BHEL
2	145KV 6BN BUS POST INSULATOR FOR 785KV SPARE RECTOR NEUTRAL FORMATION (2650MM HIGH)	33 NO.	04 LOT	○	BHEL
3	145KV BIN BUS POST INSULATOR FOR 785KV RECTOR AUX NEUTRAL BUS (4000MM HIGH)	14 NO.			


BILL OF QTY. OF BUS POST INSULATORS FOR 765KV
SPARE REACTOR CONNECTION ARRANGEMENT

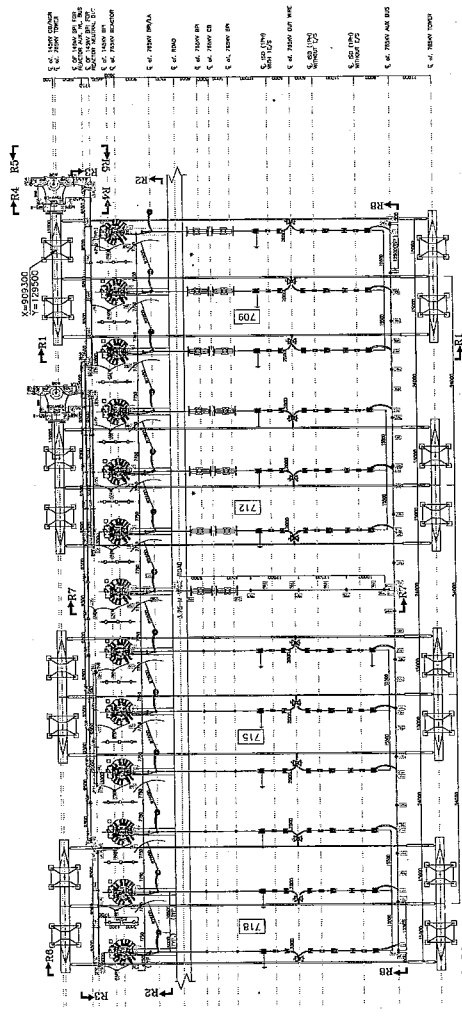[illegible]

PLAN VIEW



 SECTION--R2/765KV REACTOR TO 624KV LA CONNECTION)



SECTION-R3(765KV REACTOR NEUTRAL & NEUTRAL AUXILIARY BUS)



SECTION-R8(765KV AUXILIARY BUS)

TB-2023-315-008-BOQ-REV 01

BILL OF QUANTITIES FOR CLAMPS AND CONNECTORS-BIKANER-III-765KV

BAY WISE QUANTITY																							TOTAL QUANTITY
S.NO.	ITEM DESCRIPTION	CLAMP NO.	UNIT	SPARE REACTOR	SPARE ICT	SPARE BAY-1 OF HALF DIA.	SPARE BAY-2 OF HALF DIA.	BUS REACTOR BAY -1	BUS REACTOR BAY -2	TRANSFO RMER BAY-1	TRANSFO RMER BAY-2	TRANSFO RMER BAY-3	TRANSFO RMER BAY-4	TRANSFO RMER BAY-5	TRANSFO RMER BAY-6	LINE REACTOR S BAY-1 (WITH NGR BYPASS)	LINE REACTOR S BAY-2 (WITH NGR BYPASS)	NEEMRANA LINE BAY-1	NEEMRANA LINE BAY-2	765 KV MAIN BUS	765 KV	TOTAL	
				BPS NO. 62 (4 LOT)	BPS NO. 63 (6 LOT)	BPS NO. 64 (2 set)		BPS NO. 65 (2 set)		BPS NO. 66 (6 set)						BPS NO. 67 (2 set)		BPS NO. 68 (2 set)		BPS NO. 69 (2 set)			
1	765KV /3150 A, CIRCUIT BREAKER, EXPANSION TYPE CONNECTOR SUITABLE FOR 4.5" IPS ALUMINIUM TUBE WITH HORIZONTAL APPROACH	701	No.	2	0	3	3	9	9	9	9	9	9	9	9	9	6	6	9	9	0	0	110
2	765KV / 3150A, VERTICAL KNEE ISOLATOR, RIGID TYPE CONNECTOR SUITABLE FOR 4.5" IPS ALUMINIUM TUBE	702	No.	0	0	6	6	12	12	9	9	9	9	9	9	9	6	6	6	6	0	0	108
3	765KV / 3150A, VERTICAL KNEE ISOLATOR, EXPANSION TYPE CONNECTOR SUITABLE FOR 4.5" IPS ALUMINIUM TUBE	703	No.	0	0	0	0	8	8	11	11	11	11	11	11	11	3	3	5	5	0	0	98
4	765KV / 3150A, VERTICAL KNEE ISOLATOR, CONNECTOR SUITABLE FOR QUAD BULL AAC CONDUCTOR (UA)	704	No.	0	0	3	3	16	16	16	16	16	16	16	16	16	9	9	13	13	0	0	178
5	765KV / 3150A, CURRENT TRANSFORMER, RIGID TYPE CONNECTOR SUITABLE FOR 4.5" IPS ALUMINIUM TUBE	705	No.	0	0	0	0	6	6	12	12	12	12	12	12	12	0	0	6	6	0	0	96
6	765KV / BUS POST INSULATOR, RIGID/SLIDING TYPE CONNECTOR SUITABLE FOR 4.5" IPS AL TUBE	706	No.	4	4	0	0	5	5	5	5	5	5	5	5	5	3	3	5	5	0	0	64
7	765KV / 3150A, BUS POST INSULATOR, RIGID-EXPANSION TYPE CONNECTOR SUITABLE FOR 4.5" IPS AL TUBE, TUBE CUT	707	No.	17	28	0	0	7	7	1	1	1	1	1	1	1	0	0	1	1	0	0	67
8	765KV, CVT CONNECTOR SUITABLE FOR AL TUBE 4.5 INCH IPS, RIGID/SLIDING TYPE	708	No.	0	0	0	0	0	0	0	0	0	0	0	0	0	0	0	3	3	0	0	6
9	765KV / CAPACITOR VOLTAGE TRANSFORMER, SUITABLE FOR QUAD BULL AAC CONDUCTOR (UNIVERSAL TAKEOFF)	709	No.	0	0	0	0	0	0	0	0	0	0	0	0	0	0	0	0	0	3	3	6


BILL OF QUANTITIES FOR CLAMPS AND CONNECTORS-BIKANER-II-765KV

S.NO.	ITEM DESCRIPTION	CLAMP NO.	UNIT	BAY WISE QUANTITY																		TOTAL QUANTITY	
				SPARE REACTOR	SPARE ICT	SPARE BAY-1 OF HALF DIA.	SPARE BAY-2 OF HALF DIA.	BUS REACTOR BAY -1	BUS REACTOR BAY -2	TRANSFO RMER BAY-1	TRANSFO RMER BAY-2	TRANSFO RMER BAY-3	TRANSFO RMER BAY-4	TRANSFO RMER BAY-5	TRANSFO RMER BAY-6	LINE REACTOR S BAY-1 (WITH NGR BYPASS)	LINE REACTOR S BAY-2 (WITH NGR BYPASS)	NEEMRANA LINE BAY-1	NEEMRANA LINE BAY-2	765 KV MAIN BUS	765 KV		
																							COMMON
				BPS NO. 62 (4 LOT)	BPS NO. 63 (6 LOT)	BPS NO. 64 (2 set)		BPS NO. 65 (2 set)		BPS NO. 66 (6 set)						BPS NO. 67 (2 set)		BPS NO. 68 (2 set)		BPS NO. 69 (2 set)			
10	624KV, LIGHTNING ARRESTER, RIGID/SLIDING TYPE CONNECTOR SUITABLE FOR 4.5" IPS AL TUBE	710	No.	0	0	0	0	0	0	0	0	0	0	0	0	0	0	3	3	0	0	0	6
11	624KV, LIGHTNING ARRESTER, CONNECTOR SUITABLE FOR QUAD BULL AAC CONDUCTOR	711*	No.	1	1	0	0	3	3	3	3	3	3	3	3	3	3	0	0	0	0	0	32
12	765KV, 3150A, WAVE TRAP, RIGID TYPE CONNECTOR SUITABLE FOR QUAD BULL AAC CONDUCTOR WITH HORIZONTAL APPROACH	712*	No.	0	0	0	0	0	0	0	0	0	0	0	0	0	0	4	4	0	0	0	8
13	765KV, 500MVA (1 PHASE) ICT HV BUSHING, 3150A, CONNECTOR SUITABLE FOR QUAD BULL AAC CONDUCTOR WITH HORIZONTAL APPROACH	713	No.	0	1	0	0	0	0	3	3	3	3	3	3	0	0	0	0	0	0	0	19
14	765KV, 110MVAR (1 PHASE) LINE/BUS REACTOR HV BUSHING, 3150A, CONNECTOR SUITABLE FOR QUAD BULL AAC CONDUCTOR WITH HORIZONTAL APPROACH	714	No.	1	0	0	0	3	3	0	0	0	0	0	0	3	3	0	0	0	0	0	13
15	765KV, 3150A, TEE CONNECTOR SUITABLE FOR 4.5" AL TUBE RUN AND QUAD BULL AAC TAP (UNIVERSAL TAKEOFF)	715	No.	1	1	0	0	3	3	3	3	3	3	3	3	6	6	5	5	0	0	0	120
16	765KV, 3150A, TEE CONNECTOR SUITABLE FOR QUAD BULL AAC CONDUCTOR (RUN) AND QUAD BULL AAC CONDUCTOR (TAP)	716	No.	0	0	9	9	12	12	12	12	12	12	12	12	3	3	9	9	6	6	0	150

BILL OF QUANTITIES FOR CLAMPS AND CONNECTORS-BIKANER-III-765KV

S.NO.	ITEM DESCRIPTION	CLAMP NO.	UNIT	BAY WISE QUANTITY																				TOTAL QUANTITY
				SPARE REACTOR	SPARE ICT	SPARE BAY-1 OF HALF DIA.	SPARE BAY-2 OF HALF DIA.	BUS REACTOR BAY -1	BUS REACTOR BAY -2	TRANSFO RMER BAY-1	TRANSFO RMER BAY-2	TRANSFO RMER BAY-3	TRANSFO RMER BAY-4	TRANSFO RMER BAY-5	TRANSFO RMER BAY-6	LINE REACTOR S BAY-1 (WITH BYPASS)	LINE REACTOR S BAY-2 (WITH NGR BYPASS)	NEEMRANA LINE BAY-1	NEEMRANA LINE BAY-2	765 KV MAIN BUS 1	765 KV MAIN BUS 2			
				BPS NO. 62 (4 LOT)	BPS NO. 63 (6 LOT)	BPS NO. 64 (2 set)				BPS NO. 65 (2 set)				BPS NO. 66 (6 set)						BPS NO. 67 (2 set)		BPS NO. 68 (2 set)		
17	PG CLAMP SUITABLE FOR QUAD BULL AAC CONDUCTOR (RUN) AND QUAD BULL AAC CONDUCTOR (TAP)	717	No.	0	0	6	6	24	24		24	24	24	24	24	24	24	21	21	0	0	0	0	270
18	765KV TEE CONNECTOR SUITABLE FOR HEXA ZEBRA ACSR CONDUCTOR (RUN) AND QUAD BULL AAC CONDUCTOR (TAP)	718	No.	0	0	0	0	0	0		0	0	0	0	0	0	0	3	3	0	0	0	0	6
19	PG CLAMP SUITABLE FOR HEXA ZEBRA ACSR CONDUCTOR (RUN) AND QUAD BULL AAC CONDUCTOR (TAP)	719	No.	0	0	0	0	0	0		0	0	0	0	0	0	0	3	3	0	0	0	0	6
20	765KV FLEXIBLE SPACERS FOR QUAD BULL AAC CONDUCTOR	720	No.	0	0	57	57	108	102	102	102	102	102	102	102	102	102	114	114	174	174	0	0	1518
21	765KV RIGID SPACERS FOR QUAD BULL AAC CONDUCTOR	721	No.	0	0	21	21	48	48	48	48	48	48	48	48	48	24	24	542	36	0	0	588	
22	765KV CORONA END BELL FOR 4.5" IPS AL TUBE	7CB	No.	4	4	0	0	5	5	5	5	5	5	5	5	5	3	3	5	0	0	0	64	
23	ALUMINIUM WELDING SLEEVES FOR 4.5" IPS AL TUBE	W51	No.	0	0	0	0	0	0	0	0	0	0	0	0	0	0	0	0	0	0	0	129	
24	TWO WAY PG CLAMPS FOR 7/9 SWG (10.98MM DIA) GS WIRE	E1	No.	0	0	0	0	0	0	0	0	0	0	0	0	0	0	0	0	0	0	0	132	
25	TENSION CLAMPS FOR 7/9 SWG(10.98MM DIA) GS WIRE BOLTED TYPE	E2	No.	0	0	0	0	0	0	0	0	0	0	0	0	0	0	0	0	0	0	0	88	
26	STRUCTURE CLAMPS FOR 7/9 SWG(10.98MM DIA) GS WIRE ON LATTICE TYPE STRUCTURE	E3	No.	0	0	0	0	0	0	0	0	0	0	0	0	0	0	0	0	0	0	0	1456	
27	PAD TYPE CLAMP FOR CONNECTING 7/9 SWG(10.98MM DIA) GS WIRE ON ONE SIDE AND 75X 12 MM GS STRIP ON OTHER SIDE	E4	No.	0	0	0	0	0	0		0	0	0	0	0	0	0	0	0	0	0	0	56	
28	STRUCTURE CLAMPS FOR 75X 12 MM GS STRIPS ON LATTICE TYPE STRUCTURE	E5	No.	0	0	0	0	0	0	0	0	0	0	0	0	0	0	0	0	0	0	0	11300	

 * connector being supplied by OEM



BILL OF QUANTITIES FOR CLAMPS AND CONNECTORS-BIKANER-III-400KV

S.NO.	ITEM DESCRIPTION	CLAMP NO.	UNIT	BAY WISE QUANTITY																							TOTAL QUANTITY
				75KV SPARE ICT	SPARE BAY-1 OF HALF DIA.	BUS REACTOR BAY-1	BUS REACTOR BAY-2	75/400KV ICT- TRANSFORMER BAY-1	75/400KV ICT- TRANSFORMER BAY-2	75/400KV ICT- TRANSFORMER BAY-3	75/400KV ICT- TRANSFORMER BAY-4	75/400KV ICT- TRANSFORMER BAY-5	400/220KV ICT- TRANSFORMER BAY-1	400/220KV ICT- TRANSFORMER BAY-2	400/220KV ICT- TRANSFORMER BAY-3	400/220KV ICT- TRANSFORMER BAY-4	400/220KV ICT- TRANSFORMER BAY-5	BIKANER II LIO LINE-1	BIKANER II LIO LINE-2	BIKANER II LIO LINE-3	BIKANER II LIO LINE-4	BIKANER II LIO LINE-5	400KV MAIN BUS-1	400KV MAIN BUS-2	400KV MAIN BUS-3	400KV MAIN BUS-4	

BAY WISE QUANTITY,

Erection Hardware
for 400kV type
layout-Bus Work (For
Three diameter) as
per technical
specification: 1 SET
(NEW ITEM
ADDITION TO BE
AMENDED BY PG)

TB-124-115-008-BQQ-REV 01

BILL OF QUANTITIES FOR CLAMPS AND CONNECTORS-BIKANER-III-400KV

S.NO.	ITEM DESCRIPTION	CLAMP NO.	UNIT	BAY WISE QUANTITY																								TOTAL QUANTITY																																																																																																																																																																																																																																																																																																																																																																																																																																																																																																																																																																																																																																																																																																																																																																																																																																																																																																																																																																																																																																																																																																																																																																																																																																																																																					
				75KV SPARE ICT	SPARE BAY-1 OF HALF DIA.	BUS REACTOR BAY-1	BUS REACTOR BAY-2	75/400KV TRANSFER ICT. MER BAY-1	75/400KV TRANSFER ICT. MER BAY-2	75/400KV TRANSFER ICT. MER BAY-3	75/400KV TRANSFER ICT. MER BAY-4	75/400KV TRANSFER ICT. MER BAY-5	400/220KV TRANSFER ICT. MER BAY-1	400/220KV TRANSFER ICT. MER BAY-2	400/220KV TRANSFER ICT. MER BAY-3	400/220KV TRANSFER ICT. MER BAY-4	400/220KV TRANSFER ICT. MER BAY-5	BIKANER PG LINE-1	BIKANER PG LINE-2	BIKANER II LJO LINE-3	BIKANER II LJO LINE-4	BIKANER II LINE-1	BIKANER II LINE-2	400KV MAIN BUS-1	400KV MAIN BUS-2	400KV MAIN BUS-1	400KV MAIN BUS-2	COMMON	TOTAL QUANTITY																																																																																																																																																																																																																																																																																																																																																																																																																																																																																																																																																																																																																																																																																																																																																																																																																																																																																																																																																																																																																																																																																																																																																																																																																																																																																				

* connector being supplied by OEM

how??

TB 224-316-008-BQO-REV 01

BILL OF QUANTITIES FOR CLAMPS AND CONNECTORS-BIKANER-III-220KV

S.NO.	ITEM DESCRIPTION	CLAMP NO.	UNIT	400/220KV TRANSFORMER BAY-1	400/220KV TRANSFORMER BAY-2	400/220KV TRANSFORMER BAY-3	400/220KV TRANSFORMER BAY-4	400/220KV TRANSFORMER BAY-5	LINE BAY-1	LINE BAY-2	LINE BAY-3	LINE BAY-4	LINE BAY-5	BUS COUPLER-1	BUS COUPLER-2	TBC-1	TBC-2	220KV MAIN BUS TRANSFER 1	220KV MAIN BUS TRANSFER 2	220KV BUS SECTION USER-1	220KV BUS SECTION USER-2	TOTAL QUANTITY
				BPS NO. 87 (5 SET)					BPS NO. 86 (6 SET)					BPS NO. 88 (2 SET)		BPS NO. 89 (2 SET)		BPS NO. 84 (6 SET) & 85 (4 SET)		BPS NO. 90 (2 SET)		
1	220KV, 50KA FOR 15, 1600A, CB CONNECTOR SUITABLE FOR AL TUBE 4 INCH IPS, EXPANSION TYPE	201	No.	6	6	6	6	6	6	6	6	6	6	0	0	6	6	0	0	0	0	72
	220KV, 50KA FOR 15, 3150A, CB CONNECTOR SUITABLE FOR AL TUBE 4 INCH IPS, EXPANSION TYPE	202	No.	0	0	0	0	0	0	0	0	0	0	6	5	0	0	0	0	6	6	24
2	220KV, 50KA FOR 15, 1600A, CT CONNECTOR SUITABLE FOR AL TUBE 4 INCH IPS, RIGID TYPE	203	No.	3	3	3	3	3	3	3	3	3	3	0	0	6	6	0	0	0	0	42
3	220KV, 50KA FOR 15, 1600A, CT CONNECTOR SUITABLE FOR TWIN BERSIMIS	204	No.	3	3	3	3	3	3	3	3	3	3	0	0	0	0	0	0	0	0	30
4	220KV, 50KA FOR 15, 2500A, CT CONNECTOR SUITABLE FOR AL TUBE 4 INCH IPS, RIGID TYPE	205	No.	0	0	0	0	0	0	0	0	0	0	6	6	0	0	0	0	6	6	24
6	220KV, 50KA FOR 15, 1600A, ISOLATOR (TANDEM) CONNECTOR SUITABLE FOR AL TUBE 4 INCH IPS	206	No.	6	6	6	6	6	6	6	6	6	6	0	0	3	3	0	0	0	0	66
7	220KV, 50KA FOR 15, 1600A, ISOLATOR (TANDEM) CONNECTOR SUITABLE FOR TWIN BERSIMIS	207	No.	6	6	6	6	6	6	6	6	6	6	0	0	3	3	0	0	0	0	72
8	220KV, 50KA FOR 15, 1600A, ISOLATOR (HDB) CONNECTOR SUITABLE FOR AL TUBE 4 INCH IPS, RIGID TYPE	208	No.	6	6	6	6	6	6	6	6	6	6	0	0	5	7	0	0	0	0	87
9	220KV, 50KA FOR 15, 1600A, ISOLATOR (HDB) CONNECTOR SUITABLE FOR AL TUBE 4 INCH IPS, EXPANSION TYPE	209	No.	6	6	6	6	6	6	6	6	6	6	0	0	3	3	0	0	0	0	51
10	220KV, 50KA FOR 15, 1600A, ISOLATOR (HDB) CONNECTOR SUITABLE FOR TWIN BERSIMIS	210	No.	0	0	0	0	0	0	0	0	0	0	0	0	4	2	0	0	0	0	6

BILL OF QUANTITIES FOR CLAMPS AND CONNECTORS-BIKANER-III-220KV

S.NO.	ITEM DESCRIPTION	CLAMP NO.	UNIT	400/220KV V ICT- TRANSFO RMER BAY-1	400/220KV V ICT- TRANSFO RMER BAY-2	400/220KV V ICT- TRANSFO RMER BAY-3	400/220KV V ICT- TRANSFO RMER BAY-4	400/220KV V ICT- TRANSFO RMER BAY-5	LINE BAY- 1	LINE BAY- 2	LINE BAY- 3	LINE BAY- 4	LINE BAY- 5	BUS COUPLER- 1	BUS COUPLER- 2	TBC-1	TBC-2	220KV MAIN BUS TRANSFER 1	220KV MAIN BUS TRANSFER 2	220KV BUS SECTIONA USER-1	220KV BUS SECTIONA USER-2	TOTAL QUANTIT Y
				BPS NO. 87 (5 SET)					BPS NO. 86 (5 SET)					BPS NO. 88 (2 SET)		BPS NO. 89 (2 SET)		BPS NO. 84 (6 SET) & 85 (4 SET)		BPS NO. 90 (2 SET)		
11	220KV, 50KA FOR 15, 3150A, ISOLATOR (HDB) CONNECTOR SUITABLE FOR AL TUBE 4 INCH IPS, RIGID TYPE	211	No.	0	0	0	0	0	0	0	0	0	0	9	9	0	0	0	0	6	6	30
12	220KV, 50KA FOR 15, 3150A, ISOLATOR (HDB) CONNECTOR SUITABLE FOR QUAD BERSIMIS	212	No.	0	0	0	0	0	0	0	0	0	0	3	3	0	0	0	0	6	6	18
13	220KV, 50KA FOR 15, 1600A, WAVE TRAP CONNECTOR SUITABLE FOR TWIN BERSIMIS	213*	No.	0	0	0	0	0	2	2	2	2	2	0	0	0	0	0	0	0	0	10
14	220KV, 50KA FOR 15, BPI CONNECTOR SUITABLE FOR AL TUBE 4 INCH IPS, RIGID/SLIDING THROUGH TYPE	214	No.	9	9	9	9	9	9	9	9	9	9	6	7	8	7	0	0	0	0	118
15	220KV, 50KA FOR 15, BPI CONNECTOR SUITABLE FOR TWIN BERSIMIS (THROUGH)	215	No.	3	3	3	3	3	0	0	0	0	0	0	0	0	0	0	0	0	0	15
16	216KV, 50KA FOR 15, LIGHTNING ARRESTER CONNECTOR SUITABLE FOR TWIN BERSIMIS	216*	No.	3	3	3	3	3	3	3	3	3	3	0	0	0	0	0	0	0	0	30
17	220KV, 50KA FOR 15, 2000A, CVT CONNECTOR SUITABLE FOR TWIN BERSIMIS	217	No.	0	0	0	0	0	3	3	3	3	3	0	0	0	0	6	6	0	0	27
18	220KV, 50KA FOR 15, 2000A, ICT BUSHING CONNECTOR SUITABLE FOR TWIN BERSIMIS	218	No.	3	3	3	3	3	0	0	0	0	0	0	0	0	0	0	0	0	0	15
19	220KV, 50KA FOR 15, FLEXIBLE SPACER SUITABLE FOR QUAD AAC BULL	219	No.	0	0	0	0	0	0	0	0	0	0	0	0	0	0	168	336	12	12	528
20	220KV, 50KA FOR 15, RIGID SPACER SUITABLE FOR QUAD AAC BULL	220	No.	0	0	0	0	0	0	0	0	0	0	0	0	0	0	0	0	6	6	12

BILL OF QUANTITIES FOR CLAMPS AND CONNECTORS-BIKANER-III-220KV

S.NO.	ITEM DESCRIPTION	CLAMP NO.	UNIT	400/220KV V ICT- TRANSFO RMER BAY-1	400/220KV V ICT- TRANSFO RMER BAY-2	400/220KV V ICT- TRANSFO RMER BAY-3	400/220KV V ICT- TRANSFO RMER BAY-4	400/220KV V ICT- TRANSFO RMER BAY-5	LINE BAY- 1	LINE BAY- 2	LINE BAY- 3	LINE BAY- 4	LINE BAY- 5	BUS COUPLER- 1	BUS COUPLER- 2	TBC-1	TBC-2	220KV MAIN BUS-1	220KV MAIN BUS- 2	220KV TRANSFER BUS	BUS SECTION 1 LUSER-1	BUS SECTION 2 LUSER-2			TOTAL QUANTIT Y	
				BPS NO. 87 (5 SET)					BPS NO. 86 (5 SET)					BPS NO. 88 (2 SET)		BPS NO. 89 (2 SET)		BPS NO. 84 (6 SET) & 85 (4 SET)					BPS NO. 90 (2 SET)			
21	220KV, 50KA FOR 1S, FLEXIBLE SPACER SUITABLE FOR QUAD ACSR BERSIMIS	221	No.	0	0	0	0	0	0	0	0	0	0	111	111	162	162	0	0	369	0	0	0	0	915	
22	220KV, 50KA FOR 1S, RIGID SPACER SUITABLE FOR QUAD ACSR BERSIMIS	222	No.	0	0	0	0	0	0	0	0	0	0	30	30	0	0	0	0	0	0	0	0	60		
23	220KV, 50KA FOR 1S, FLEXIBLE SPACER SUITABLE FOR TWIN ACSR BERSIMIS	223	No.	6	6	6	6	6	6	6	6	6	6	0	0	0	0	12	24	6	0	0	0	102		
24	220KV, 50KA FOR 1S, RIGID SPACER SUITABLE FOR TWIN ACSR BERSIMIS	224	No.	30	30	30	30	30	46	37	46	46	46	0	0	31	31	6	12	9	0	0	0	460		
25	220KV, 50KA FOR 1S,TEE CONNECTOR SUITABLE FOR QUAD AAC BULL TO QUAD ACSR BERSIMIS	225	No.	0	0	0	0	0	0	0	0	0	0	9	9	0	0	0	0	0	0	0	0	18		
26	220KV, 50KA FOR 1S,TEE CONNECTOR SUITABLE FOR QUAD AAC BULL TO TWIN ACSR BERSIMIS	226	No.	4	4	4	4	4	5	3	5	5	5	0	0	6	6	6	12	0	0	0	0	73		
27	220KV, 50KA FOR 1S,TEE CONNECTOR SUITABLE FOR QUAD ACSR BERSIMIS TO QUAD ACSR BERSIMIS	227	No.	0	0	0	0	0	0	0	0	0	0	9	9	6	6	0	0	0	0	0	0	30		
28	220KV, 50KA FOR 1S,TEE CONNECTOR SUITABLE FOR QUAD ACSR BERSIMIS TO TWIN ACSR BERSIMIS	228	No.	6	6	6	6	6	3	3	3	3	3	0	0	12	12	0	0	9	0	0	0	78		
29	220KV, 50KA FOR 1S,TEE CONNECTOR SUITABLE FOR TWIN ACSR BERSIMIS TO TWIN ACSR BERSIMIS	229	No.	0	0	0	0	0	3	3	3	3	3	0	0	0	0	0	0	0	0	0	0	15		
30	220KV, 50KA FOR 1S,TEE CONNECTOR SUITABLE FOR SINGLE ALSO MOOSE (TO BE CONFIRMED BY POWERGRID) TO SINGLE ACSR BERSIMIS	230	No.	0	0	0	0	0	6	6	6	6	6	0	0	0	0	0	0	0	0	0	0	30		

BILL OF QUANTITIES FOR CLAMPS AND CONNECTORS-BIKANER-III-220KV

S.NO.	ITEM DESCRIPTION	CLAMP NO.	UNIT	400/220K V ICT- TRANSFO RMER BAY-1	400/220K V ICT- TRANSFO RMER BAY-2	400/220K V ICT- TRANSFO RMER BAY-3	400/220K V ICT- TRANSFO RMER BAY-4	400/220K V ICT- TRANSFO RMER BAY-5	LINE BAY- 1	LINE BAY- 2	LINE BAY- 3	LINE BAY- 4	LINE BAY- 5	BUS COUPLER- 1	BUS COUPLER- 2	TBC-1	TBC-2	220KV MAIN BUS TRANSFER BUS 1	220KV MAIN BUS TRANSFER BUS 2	BUS SECTIONA USER-1	BUS SECTIONA USER-2	TOTAL QUANTIT Y
				BPS NO. 87 (5 SET)					BPS NO. 86 (5 SET)					BPS NO. 88 (2 SET)		BPS NO. 89 (2 SET)		BPS NO. 84 (6 SET) & 85 (4 SET)		BPS NO. 90 (2 SET)		
31	220KV, 50KA FOR 15, 4000A, TEE CONNECTOR SUITABLE FOR AL TUBE 4 INCH IPS TO QUAD ACSR BERSIMIS	231	No.	0	0	0	0	0	0	0	0	0	0	3	3	0	0	0	0	0	0	6
32	220KV, 50KA FOR 15, 4000A, TEE CONNECTOR SUITABLE FOR AL TUBE 4 INCH IPS TO TWIN ACSR BERSIMIS	232	No.	7	7	7	7	7	8	6	8	8	8	0	0	8	8	0	0	0	0	89
33	220KV, 50KA FOR 15, TEE CONNECTOR SUITABLE FOR QUAD AAC BULL TO QUAD AAC BULL	233	No.	0	0	0	0	0	0	0	0	0	0	0	0	0	0	0	0	0	0	0
34	220KV CORONA END BELL FOR 4" IPS AL TUBE	ZCB	No.	0	0	0	0	0	0	0	0	0	0	0	0	2	1	0	0	0	0	10
35	ALUMINIUM WELDING SLEEVES FOR 4" IPS AL TUBE	W52	No.	0	0	0	0	0	0	0	0	0	0	0	0	0	0	0	0	0	0	133
36	TWO WAY PG CLAMPS FOR 7/9 SWG (10.98MM DIA) GS WIRE	E1	No.	0	0	0	0	0	0	0	0	0	0	0	0	0	0	0	0	0	0	58
37	TENSION CLAMPS FOR 7/9 SWG(10.98MM DIA) GS WIRE BOLTED TYPE	E2	No.	0	0	0	0	0	0	0	0	0	0	0	0	0	0	0	0	0	0	38
38	STRUCTURE CLAMPS FOR 7/9 SWG(10.98MM DIA) GS WIRE ON LATTICE TYPE STRUCTURE	E3	No.	0	0	0	0	0	0	0	0	0	0	0	0	0	0	0	0	0	0	216
39	PAD TYPE CLAMP FOR CONNECTING 7/9 SWG(10.98MM DIA) GS WIRE ON ONE SIDE AND 75X 42 MM GS STRIP ON OTHER SIDE	E4	No.	0	0	0	0	0	0	0	0	0	0	0	0	0	0	0	0	0	0	18
40	STRUCTURE CLAMPS FOR 75X 42 MM GS STRIPS ON LATTICE TYPE STRUCTURE	E5	No.	0	0	0	0	0	0	0	0	0	0	0	0	0	0	0	0	0	0	3900

* connector being supplied by OEM

TB-424-316-008-BOQ-REV.01

BILL OF QUANTITIES FOR CLAMPS AND CONNECTORS-BIKANER-III-145KV

S.NO.	ITEM DESCRIPTION	CLAMP NO.	UNIT	BAY WISE QUANTITY		TOTAL QUANTITY
				BPS NO. 62 (4 LOT)	BPS NO. 67 (2 SET)	
1	145KV, 25KA FOR 1S, 1250A, CB CONNECTOR SUITABLE FOR TWIN BERSIMIS	101	NO.	0	4	4
2	145KV, 25KA FOR 1S, NGR CONNECTOR SUITABLE FOR TWIN BERSIMIS	102	NO.	0	4	4
3	132KV, 25KA FOR 1S, SURGE ARRESTER CONNECTOR SUITABLE FOR TWIN BERSIMIS THROUGH TYPE	103	NO.	0	2	2
4	145KV, 25KA FOR 1S, BPI CONNECTOR SUITABLE FOR AL TUBE 3 INCH IPS, RIGID-SLIDING THROUGH TYPE	104	NO.	9	0	9
5	145KV, 25KA FOR 1S, BPI CONNECTOR SUITABLE FOR AL TUBE 3 INCH IPS, TUBE CUT	105	NO.	23	0	23
6	145KV, 25KA FOR 1S, BPI CONNECTOR SUITABLE FOR TWIN BERSIMIS CONDUCTOR THROUGH	106	NO.	14	4	18
7	TEE CONNECTOR/PG CLAMP SUITABLE FOR TWIN ACSR BERSIMIS CUNDOCTOR (RUN) AND TWIN ACSR BERSIMIS CONDUCTOR (TAP)	107	NO.	0	8	8
8	145KV, 25KA FOR 1S, 1250A, TEE CONNECTOR/PG CONNECTOR SUITABLE FOR 3" IPS AL TUBE TO TWIN BERSIMIS	108	NO.	23	0	23
9	145KV, REACTOR NEUTRAL BUSHING, 1250A, CONNECTOR SUITABLE FOR TWIN BERSIMIS CONDUCTOR WITH HORIZONTAL APPROACH	109	NO.	13	0	13
10	WELDING SLEEVE SUITABLE FOR 3 INCH IPS AL TUBE	WS3	NO.	28	0	28
11	END CAP SUITABLE FOR 3 INCH IPS AL TUBE	3CB	NO.	10	0	10

Kindly include bus post and associated structure quantities under this item.

TB-424-316-003-BQ-REV 01

BILL OF QUANTITIES FOR CLAMPS AND CONNECTORS-BIKANER-III-72.5KV

S.NO.	ITEM DESCRIPTION	CLAMP NO.	UNIT	BAY WISE QUANTITY		TOTAL QUANTITY
				BPS NO. 63 (6 LOT)	BPS NO. 98 (2 SET)	
1	72.5KV, 25KA FOR 1S, 1250A, CB CONNECTOR SUITABLE FOR TWIN BERSIMIS	501	NO.	0	12	12
2	72.5KV, 25KA FOR 1S, CT CONNECTOR SUITABLE FOR TWIN BERSIMIS	502	NO.	0	12	12
3	72.5KV, 25KA FOR 1S, 1250A, ISOLATOR (HDB) CONNECTOR SUITABLE FOR TWIN BERSIMIS	503	NO.	0	12	12
4	66KV, 25KA FOR 1S, PT CONNECTOR SUITABLE FOR TWIN BERSIMIS	504	NO.	0	6	6
5	72.5KV, 25KA FOR 1S, 1250A, BPI CONNECTOR SUITABLE FOR AL TUBE 3 INCH IPS, SLIDING THROUGH TYPE	505	NO.	146	0	146
6	72.5KV, 25KA FOR 1S, 1250A, BPI RIGID-EXPANSION TYPE CONNECTOR SUITABLE FOR 3" IPS AL TUBE, TUBE CUT	506	NO.	164	0	164
7	72.5KV, 25KA FOR 1S, 1250A, ICT BUSHING CONNECTOR SUITABLE FOR TWIN BERSIMIS (THROUGH TYPE)	507	NO.	38	0	38
8	72.5KV, 25KA FOR 1S, 1250A, TEE CONNECTOR/PG CONNECTOR SUITABLE FOR 3" IPS AL TUBE TO TWIN BERSIMIS	508	NO.	364	0	364
9	72.5KV, 25KA FOR 1S, 1250A, LT TRANSFORMER BUSHING CONNECTOR SUITABLE FOR TWIN BERSIMIS	509	NO.	0	6	6
10	WELDING SLEEVE SUITABLE FOR 3 INCH IPS AL TUBE	WS3	NO.	196	0	196
11	END CAP SUITABLE FOR 3 INCH IPS AL TUBE	3CB	NO.	146	0	146

TB-424-316-008-BQ-REV.01

BILL OF QUANTITIES FOR CLAMPS AND CONNECTORS-BIKANER-III-33KV

S.NO.	ITEM DESCRIPTION	CLAMP NO.	UNIT	QUANTITY
				BPS NO. 63 (6 LOT)
1	33KV, 25KA FOR 1S, BPI CONNECTOR SUITABLE FOR AL TUBE 3 INCH IPS, RIGID-SLIDING THROUGH TYPE	301	NO.	52
2	33KV, 25KA FOR 1S, BPI CONNECTOR SUITABLE FOR AL TUBE 3 INCH IPS, RIGID-EXPANSION TYPE CONNECTOR, TUBE CUT	302	NO.	67
3	33KV, 25KA FOR 1S, BPI CONNECTOR SUITABLE FOR TWIN BERSIMIS CONDUCTOR THROUGH	303	NO.	19
4	33KV, 25KA FOR 1S, 2000A, BUSHING CONNECTOR SUITABLE FOR TWIN BERSIMIS	304	NO.	19
5	33KV, 25KA FOR 1S, 1250A, TEE CONNECTOR/PG CONNECTOR SUITABLE FOR 3" IPS AL tube TO TWIN BERSIMIS	305	NO.	69
6	33KV, 25KA FOR 1S, CURRENT TRANSFORMER CONNECTOR SUITABLE FOR AL TUBE 3 INCH IPS, RIGID TYPE	306	NO.	6
7	33KV, 25KA FOR 1S, CURRENT TRANSFORMER CONNECTOR SUITABLE FOR 75X12 MM FLAT	307	NO.	6
8	WELDING SLEEVE SUITABLE FOR 3 INCH IPS AL TUBE	WS3	NO.	68
9	END CAP SUITABLE FOR 3 INCH IPS AL TUBE	3CB	NO.	46

BPI quantities to be included.

Bill of Quantity - String Insulators Hardware - Bikaner-III Station (765KV)																
S.No	Engineering Description	Nomenclature	S.No. as per BPS	Description as per BPS	ICT-1 TIE FUTURE	ICT-2 TIE FUTURE	ICT-3 TIE NEEMRAN A LINE-2 WITH REACTOR	ICT-4 TIE NEEMRAN A LINE-1 WITH REACTOR	ICT-5 TIE BUS REACTO R-1	ICT-6 TIE BUS REACTO R-2	MAIN BUS-1	MAIN BUS-2	Engineered Quantity Total (Nos)	Quantity as per BPS (Nos)	UNIT	REMARKS
Tension Hardware																
A1	765 KV Double Tension Hardware without Turnbuckle suitable for Quad Bull AAC Conductor	7H1	72	765KV TENSION INSULATOR STRING AND ASSOCIATED HARDWARE FITTINGS WITHOUT TURN BUCKLE SUITABLE FOR QUAD CONDUCTOR	9	9	12	12	12	12	9	9	84	84	/	Nos
A2	765 KV Double Tension Hardware with Turnbuckle suitable for Quad Bull AAC Conductor	7H2	74	765KV TENSION INSULATOR STRING AND ASSOCIATED HARDWARE FITTINGS WITH TURN BUCKLE SUITABLE FOR QUAD CONDUCTOR	9	9	12	12	12	12	9	9	84	84	/	Nos
A3	765 KV Double Tension Hardware with Turnbuckle suitable for Hexa Jebra Conductor	7H5	75	765KV TENSION INSULATOR STRING AND ASSOCIATED HARDWARE FITTINGS WITH TURN BUCKLE SUITABLE FOR HEXA CONDUCTOR	9	9	15	15	12	12	9	9	6	6	/	Nos
A4	765KV GUY arrangement hardware with Turnbuckle suitable for Quad Bull AAC Conductor	7H5	76	765KV TENSION INSULATOR STRING AND ASSOCIATED HARDWARE FITTINGS WITHOUT TURN BUCKLE SUITABLE FOR QUAD CONDUCTOR	9	9	15	15	12	12	9	9	72	72	---	Nos
A5	765 KV Single Suspension Hardware with Drop Clamp suitable for Quad Bull AAC Conductor	7H3	70	765KV SUSPENSION INSULATOR STRING AND ASSOCIATED HARDWARE FITTINGS WITH DROP CLAMP SUITABLE FOR QUAD CONDUCTOR	3	3	6	6	6	6	6	6	12	12	/	Nos
A6	765 KV Single Suspension Hardware with Through Clamps suitable for Quad Bull AAC Conductor	7H4	71	765KV SUSPENSION INSULATOR STRING AND ASSOCIATED HARDWARE FITTINGS WITH THROUGH CLAMP SUITABLE FOR QUAD CONDUCTOR	3	3	6	6	6	6	6	6	42	42	/	Nos
COMPOSITE LONG ROD POLYMER INSULATOR-765KV																
B1	765KV COMPOSITE LONG ROD POLYMER INSULATOR STRING - 31mm/AV. 210KN - For Tension Insulators	---	---	---	---	---	---	---	---	---	---	---	696	---	---	Nos
B2	765KV COMPOSITE LONG ROD POLYMER INSULATOR STRING - 31mm/AV. 210KN - For Suspension Insulators	---	---	---	---	---	---	---	---	---	---	---	215	---	---	Nos
B3	765KV COMPOSITE LONG ROD POLYMER INSULATOR STRING - 31mm/AV. 210KN - For guy wire arrangement	---	---	---	---	---	---	---	---	---	---	---	288	---	---	Nos

These are part of LS item under erection hardware, not payable additionally

TB-424 315-008-BQ03REV/04

Bill of Quantity - String Insulators Hardware - Bikaner-III Station (220kV)																			
S.No	Engineering Description	Nomenclature	Sl.No. as per BPS	Description as per BPS	220KV SIDE OF ICT 1-TIE- LINE-1	BUS COUPLER R-TIE- LINE-2	220KV SIDE OF ICT 2-TIE- LINE-3	220KV SIDE OF ICT 3-TIE- LINE-4	FUTURE- TIE-TBC-1	220KV SIDE OF ICT 4-TIE- TBC-2	220KV SIDE OF ICT 5-TIE- LINE-5	BUS COUPLER 2	220KV MAIN BUS 1	220KV MAIN BUS 2	220KV TRANSFER BUS	Engineered Quantity/Total (Nos)	Quantity as per BPS (Nos)	UNIT	REMARKS
Tension Hardware																			
A1	220 kV Double Tension Hardware without Turnbuckle suitable for Quad ACSR Bersimis Conductor	2H1	94	220KV TENSION INSULATOR STRING AND ASSOCIATED HARDWARE FITTINGS WITHOUT TURN BUCKLE SUITABLE FOR QUAD CONDUCTOR	3	6	3	3	9	12	3	6	-	-	21	66 /	63 /	Nos	Amendment required for 30 no. additional quantity
A2	220 kV Double Tension Hardware without Turnbuckle suitable for Quad AAC Bull Conductor	2H3		220KV TENSION INSULATOR STRING AND ASSOCIATED HARDWARE FITTINGS WITHOUT TURN BUCKLE SUITABLE FOR QUAD CONDUCTOR	-	-	-	-	-	-	-	-	-	9	18	-	27 /	-	Nos
A3	220 kV Double Tension Hardware with Turnbuckle suitable for Quad ACSR Bersimis Conductor	2H2	92	220KV TENSION INSULATOR STRING AND ASSOCIATED HARDWARE FITTINGS WITH TURN BUCKLE SUITABLE FOR QUAD CONDUCTOR	3	6	3	3	9	12	3	6	-	-	21	66 /	63 /	Nos	Amendment required for 30 no. additional quantity
A4	220 kV Double Tension Hardware with Turnbuckle suitable for Quad AAC Bull Conductor	2H4		220KV TENSION INSULATOR STRING AND ASSOCIATED HARDWARE FITTINGS WITH TURN BUCKLE SUITABLE FOR QUAD CONDUCTOR	-	-	-	-	-	-	-	-	-	9	18	-	27 /	-	Nos
A5	220 kV Double Tension Hardware with Turnbuckle suitable for Single/twin AL59 Moose Conductor - Line Side	2H7	91	220KV TENSION INSULATOR STRING AND ASSOCIATED HARDWARE FITTINGS WITH TURN BUCKLE SUITABLE FOR TWIN CONDUCTOR	3	3	3	3	-	-	3	-	-	-	-	15 /	60 /	Nos	These quantities shall be finalised after receipt of type of conductor from POWERGRID
Suspension Hardware																			
A6	220 kV Single Suspension Hardware with Drop Clamp suitable for Twin ACSR Bersimis Conductor	2H5	95	220KV SUSPENSION INSULATOR STRING AND ASSOCIATED HARDWARE FITTINGS WITH DROP CLAMP SUITABLE FOR TWIN CONDUCTOR	5	2	5	5	-	3	5	-	6	6	3	35 / 40	33 /	Nos	Amendment required for 2 no. additional quantity
A7	220 kV Single Suspension Hardware with Drop Clamp suitable for Quad AAC Bull Conductor	2H6	97	220KV SUSPENSION INSULATOR STRING AND ASSOCIATED HARDWARE FITTINGS WITH DROP CLAMP SUITABLE FOR QUAD CONDUCTOR	-	-	-	-	-	-	-	-	6	6	-	12	12 /	Nos	
COMPOSITE LONG ROD POLYMER INSULATOR-220KV																			
B1	220KV COMPOSITE LONG ROD POLYMER INSULATOR - 31mm/kV, 120kN - For Tension Insulators	-	-	-	-	-	-	-	-	-	-	-	-	-	-	372	-	Nos	
B2	220KV COMPOSITE LONG ROD POLYMER INSULATOR - 31mm/kV, 120kN - For suspension Insulators	-	-	-	-	-	-	-	-	-	-	-	-	-	-	47	-	Nos	

संदर्भ/Ref : CC-ENGG-TB202359-1002269-BS3480-CABTR-LAYOUT

Date : 28/01/2025

From : Somiran Das
Senior GM

To : Bharat Heavy Electricals Limited
Plot No.-7, Sector-142 Noida 201305
201305

Cc :

Subject : Substation Package SS-01 for (i) Establishment of 765/400/220kV Bikaner-III (New) Pooling Station including 400kV class Bus Reactor at Bikaner-III S/s; (ii) Extension of 765kV Neemrana-II S/s for termination of 765 kV D/c line Neemrana-II-Bikaner-III T/L and (iii) Extension of 400kV Bikaner-II S/s for termination of 400kV Bikaner-II Bikaner-III T/L under "Transmission system for evacuation of power from Rajasthan REZ Ph-IV (Part-1) (Bikaner Complex): PART-A"

LOA Ref : CC/T/W-AIS/DOM/A10/23/01956/NOA-1/24-102643/01 & 02 Dated 23/02/2024

Please find enclosed following drawings/ documents for necessary action at your end.

Vendor Drg. No. : TB-0-424-316-007


Orgn. Drg. No. : TB202359-1002269-BS3480-CABTR-LAYOUT

Revision No. : 03

Drg. Title : BIKANER III NEW S/S-CABLE TRENCH LAYOUT

App. Category : CAT-I

Release Date : 28/01/2025

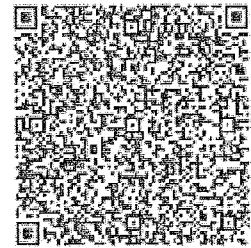

Scan to verify

Comments : Generally in order.

अनुमोदित श्रेणी/App. Category:

- I. फेब्रिकेशन/निर्माण/टाइप टेस्टिंग हेतु जारी।
Approved/released for fabrication/construction.
 - II. फेब्रिकेशन/निर्माण/टाइप टेस्टिंग हेतु अनुमोदित/जारी बशर्ते दिए गए टिप्पणियाँ एवं आशोधनों की सम्मिलित किया जाये। कृपया रिवाइज्ड दस्तावेज अनुमोदनार्थ प्रस्तुत करें।
Approved/released for fabrication/ construction subject to incorporation of comments and modification as noted. Revised drawing required for approval.
 - III. टिप्पणियाँ सम्मिलित करने के उपरान्त दस्तावेज को अनुमोदनार्थ प्रस्तुत करें।
To be resubmitted for approval after incorporating the comments.
 - IV. सूचनार्थ एवं रिकार्ड हेतु।
For information and record.
- CATREL/ निर्माण हेतु जारी।
REL-CON Released for construction.

नोट/Note:

1. Approval/Comments conveyed herein neither relieve the contractor of his contractual obligations and his responsibilities, weights, quantities, design details assemble fits, performance particulars and conformity of the supplies with the Indian Statutory Laws as may be applicable, nor does it limits the purchaser's right under the contract.
2. The approval conveyed vide this letter does not cover the approval of make for sub-vendor items.

केन्द्रीय कार्यालय: "सौदामिनी", प्लॉट नंबर 2, सेक्टर -29, गुरुग्राम -122001, (हरियाणा), दूरभाष: 0124-2571700-719

Corporate Office: "Saudamini", Plot No. 2, Sector-29, Gurugram-122001, (Haryana) Tel.: 0124-2571700-719


पंजीकृत कार्यालय: बी -9, कुतुब इंस्टीट्यूशनल एरिया, कटवारिया सराय, नई दिल्ली -110016. दूरभाष: 011-26560112, 26560121, 26564812, 26564892, सीआईएन: L40101DL1989GOI038121

Registered Office: B-9, Qutab Institutional Area, Katwaria Sarai, New Delhi-110016. Tel: 011-26560112, 26560121, 26564812, 26564892, CIN : L40101DL1989GOI038121

Website: www.powergridindia.com

DRG. NO. TB-0-424-316-007


765KV EQUIPMENTS TYPICAL CABLE TRENCH DETAILS

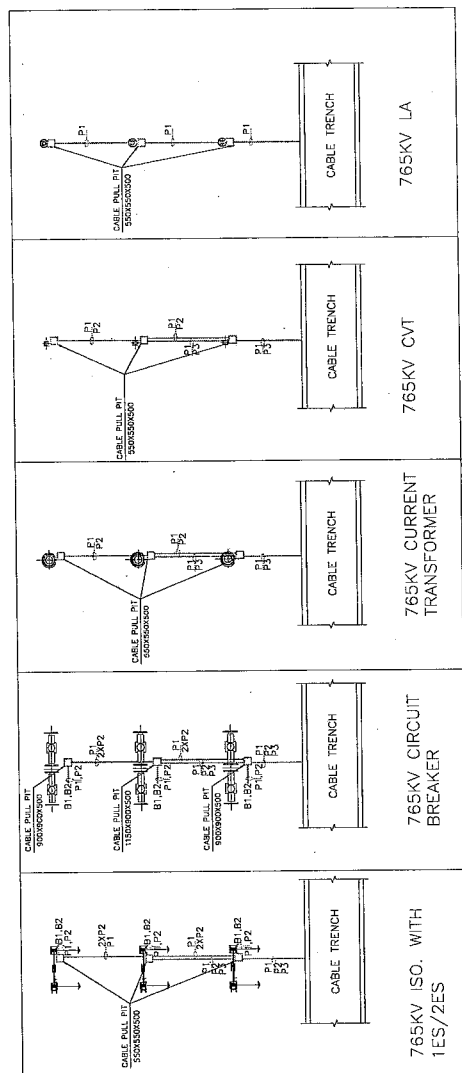

LEGENDS

- | | |
|---|---|
|  | PVC PIPE ROUTING |
|  2x3 | ø PVC PIPE FOR REACTOR AND ICT MOM BOX. |
|  | ... PULL CHAMBER |
|  | ROAD/PIT CROSSING THROUGH CABLE CULVERT |
| P1 | 1X50 MM ø PVC PIPE FOR POWER CABLE |
| P2 | 1X110 MM ø PVC PIPE FOR CONTROL CABLE |
| P3 | 1X200 MM ø PVC PIPE FOR CONTROL CABLE |
|  | BAY MARSHALLING KIOSK |


PVC PIPE DETAILS OF 400/220KV EQUIPMENTS

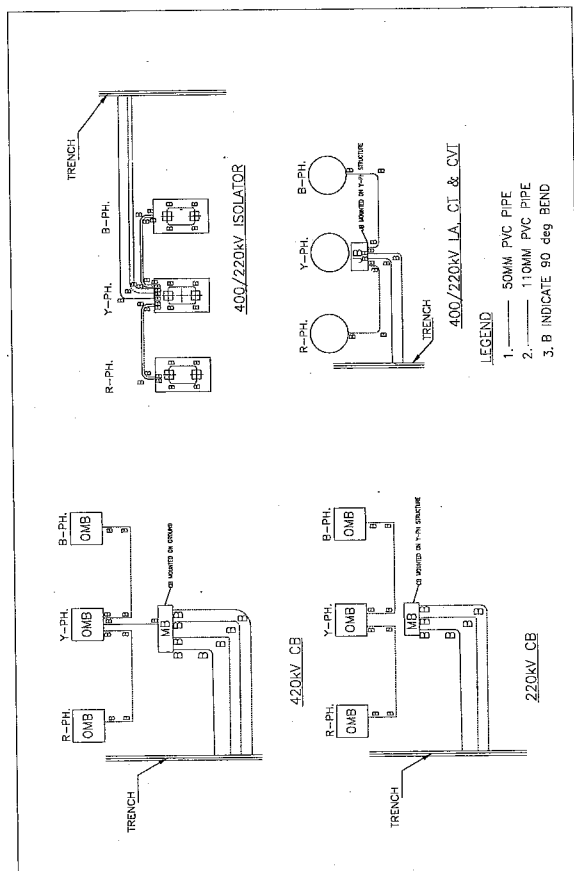[illegible]

REV.	DATE	AUTUMN	SPR	REV.	DATE	AUTUMN	SPR
003	17.01.2024	CHECKED	SIS	002	17.12.2024	CHECKED	SIS
		APPROVED	SIS			APPROVED	SIS
ZONE	REVISED AS PER CUSTOMER COMMENTS DATED-10.01.2025						
	ZONE REVISED AS PER CUSTOMER COMMENTS DATED-01.12.2024						


PROJECT TITLE	Establishment of 6X1500 MVA, 765/400 kV & 5X500 MVA 400/220 kV Bikaner-III Pooling Station (including 400kV, 2x125MVAR, reactor at Bikaner-III)	
CUSTOMER	BIKANER III NEEMRANA TRANSMISSION LIMITED	
CONSULTANT	POWERGRID CORPORATION OF INDIA LIMITED	
EPC CONTRACTOR	BHARAT HEAVY ELECTRICALS LIMITED (BHEL)	
REVIEW OF	BIKANER III NEW S/S- CONTROL ROOM BUILDING CABLE TRENCH LAYOUT	
SI. NO.	POWERGRID Comments dated 29/01/2025	BHEL reply dated 14/02/2025
1	This portion to be shifted on edge of wall and space to be kept between two Section for coridor, Section 1-1	incorporated
2	Pipe opening to be shown for buried cable trench	Cable will be crossing through cable transit system as per section-B, hence pipe opening not required.
3	MLDB is kept outside the cable trench, please align the same	incorporated
4	Section 3-3	incorporated
5	200 NB	incorporated

DRG. NO. TB-2-424-316-009

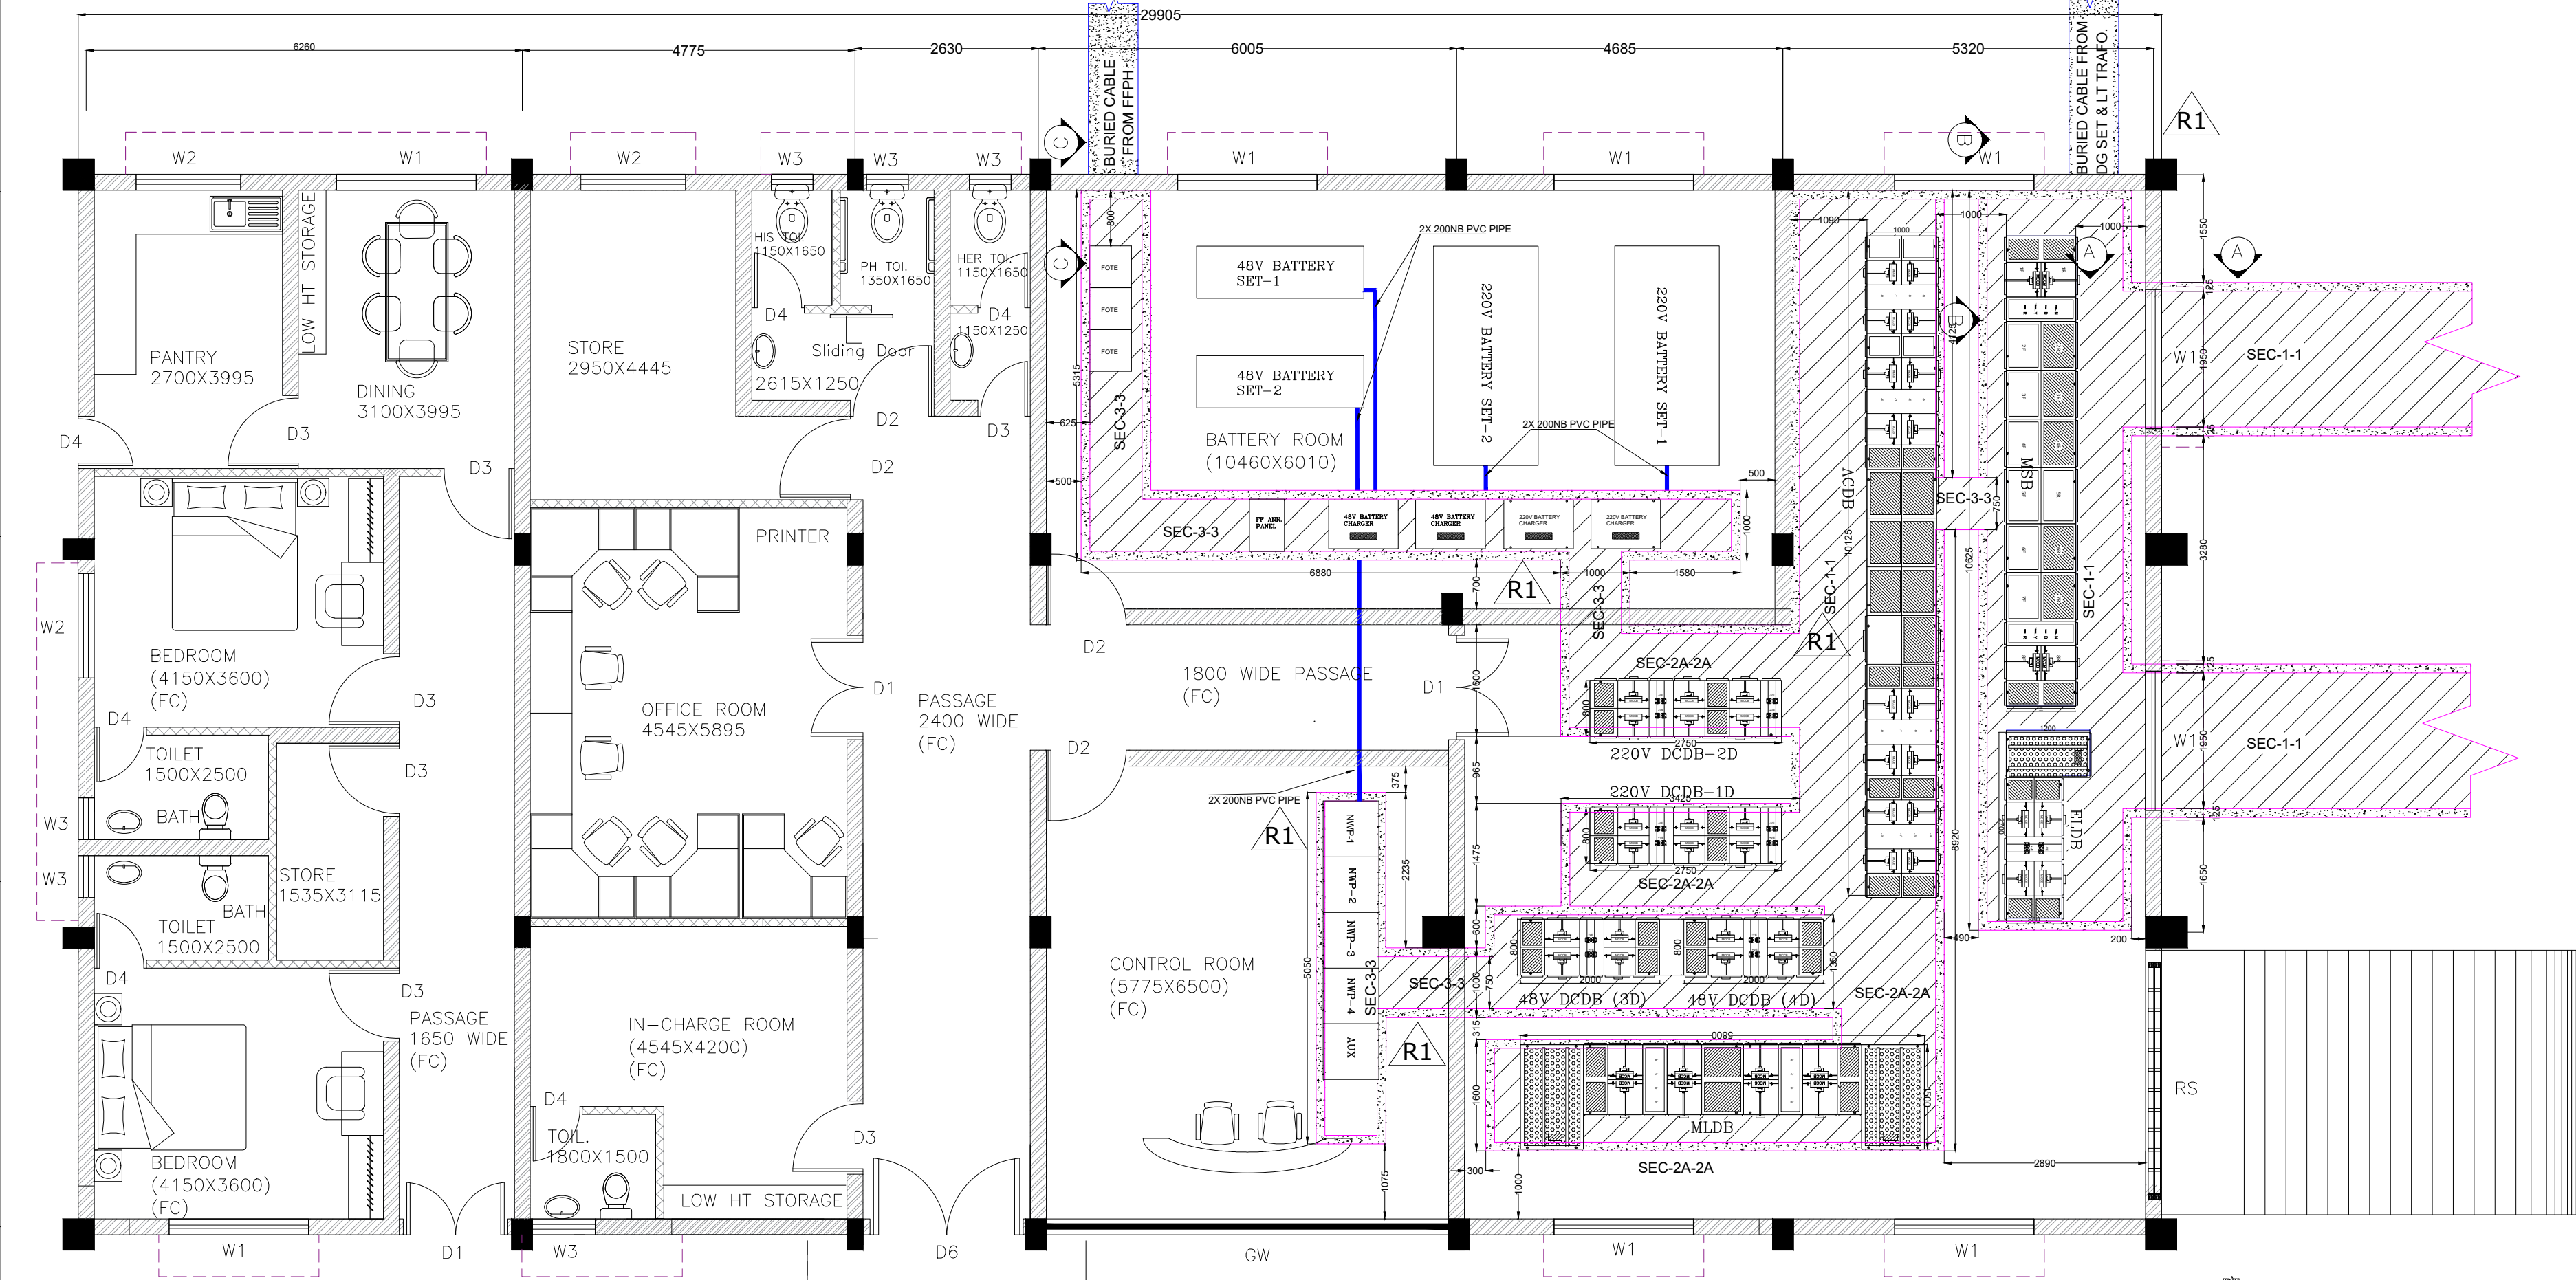


REFERENCE DRAWINGS:

- TB-2-424-316-105-CRB Rev.02 :- BIKANER III NEW S/S- CONTROL ROOM BUILDING PANEL ARRANGEMENT LAYOUT.
- TB-0-424-316-007 Rev.02 :- BIKANER III NEW S/S-CABLE TRENCH LAYOUT

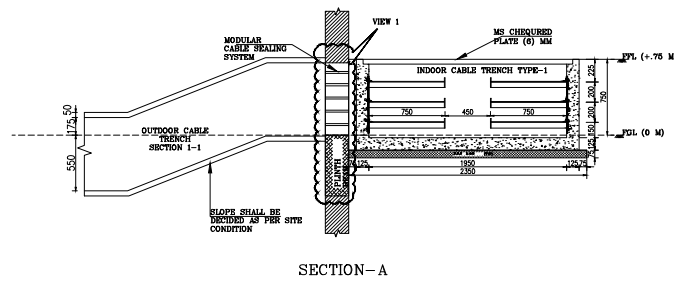


SECTION-A


LEGENDS:
- PVC PIPE
- INDOOR TRENCH

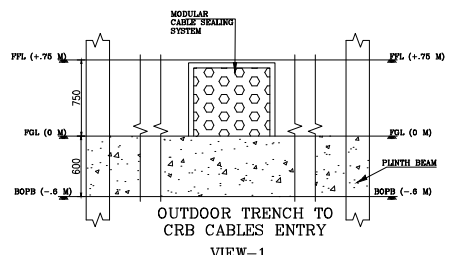


VIEW-1

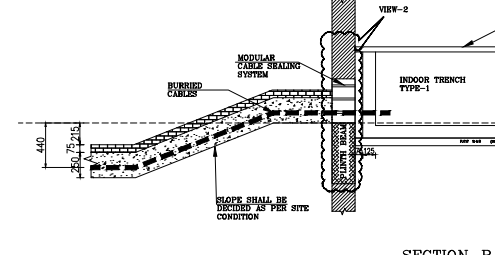

SECTION-B

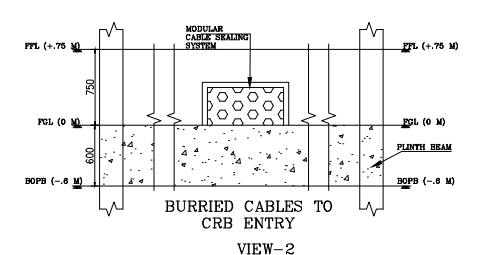

VIEW-2

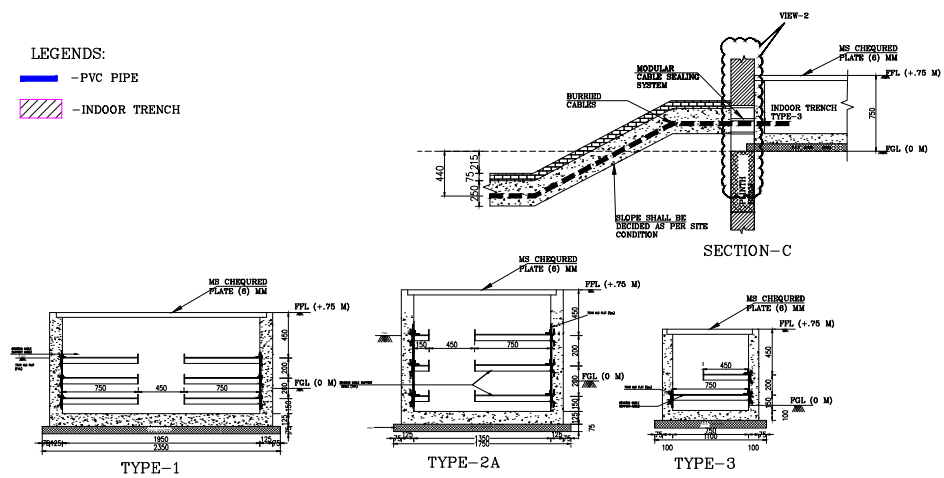


TYPE-1


TYPE-2A

TYPE-3


NOA NO. : CC/TW-AIS/DOM/A10/23/01956/NOA-1/24-102643/01		NAME OF CUSTOMER BIKANER-III NEEMRANA TRANSMISSION LIMITED	
NAME OF CLIENT POWERGRID CORPORATION OF INDIA LIMITED		NAME OF PROJECT Establishment of 6x1500 MVA, 765/400 kV & 5x500 MVA 400/220 kV Bikaner-III Pooling Station (including 400kV, 2x125MVAR, reactor at Bikaner-III)	
ADDITIONAL INFORMATION W.O.No.		STATUS OF DRAWING	
DISTRIBUTION OF PRINTS		POWERGRID DRAWING NO. T9202359-1002289-SS3480-CRB CABLE TRENCH LAYOUT	
REV. 01	DATE 14.02.25	ALTERED BY CHECKED BY APPROVED BY	SY SS SKS
ZONE		REVISD AS PER POWERGRID COMMENTS	
SIGNATURE/TITLE BIKANER III NEW S/S- CONTROL ROOM BUILDING CABLE TRENCH LAYOUT		DRAWING NO. TB-2-424-316-009	
PLOT NO./SHEET No.		PLOT NO./NEXT SHEET	

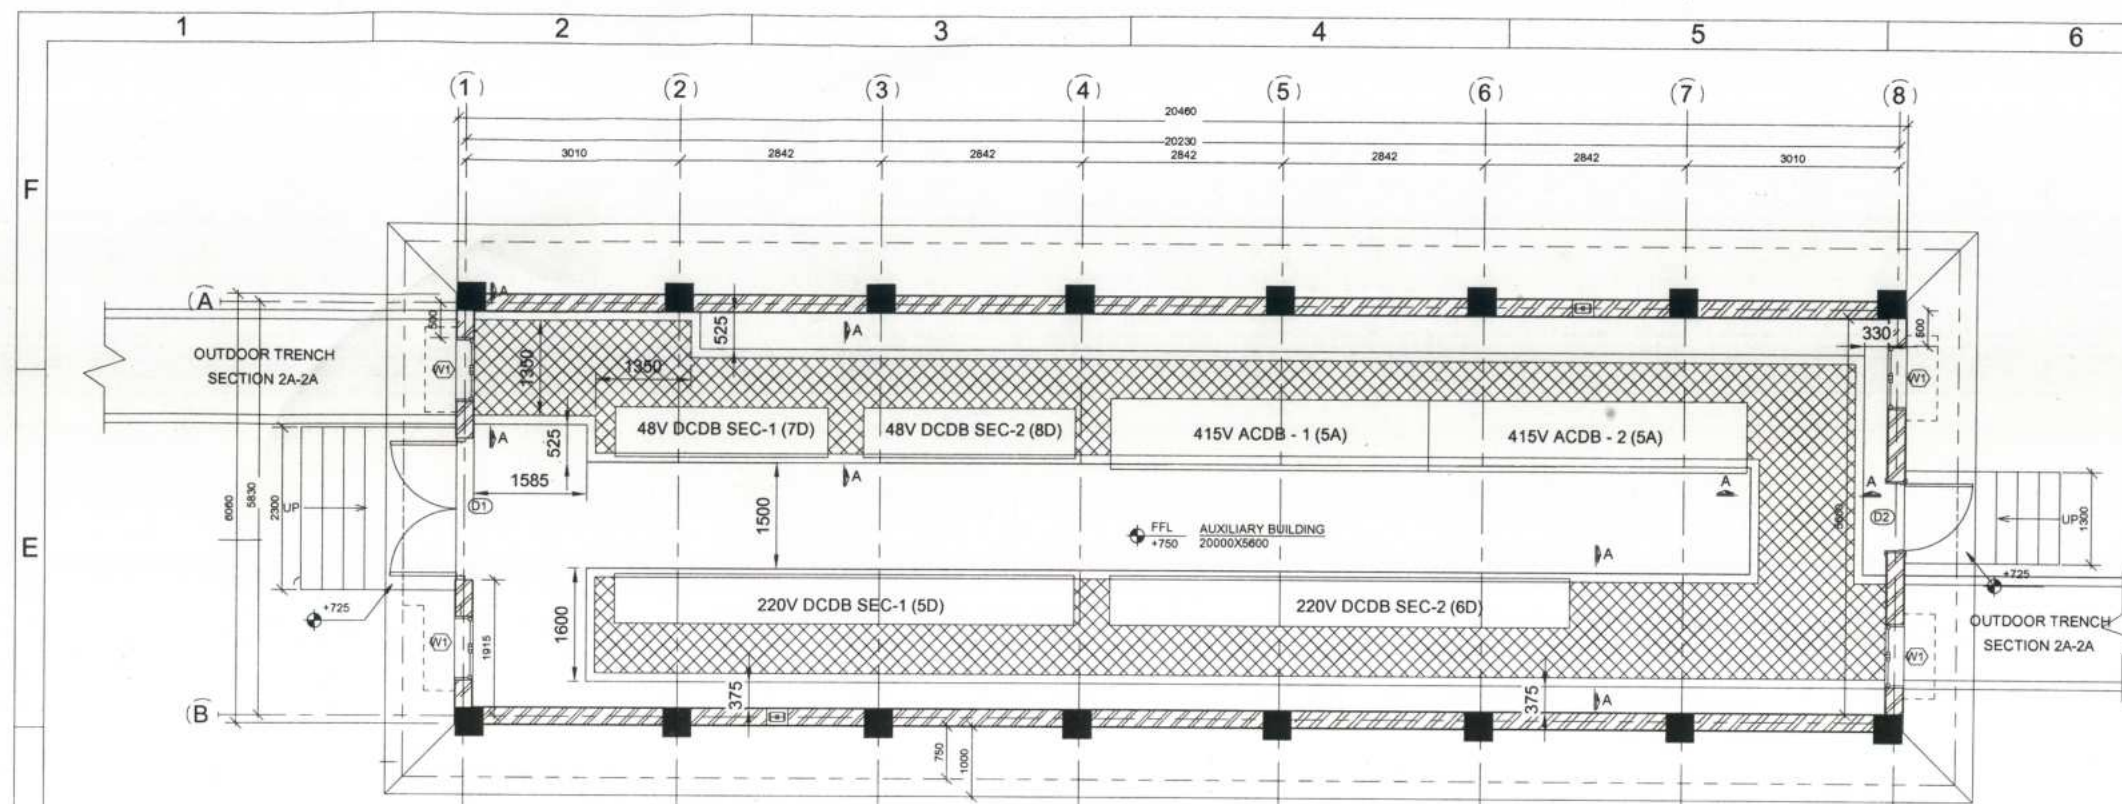


LAYOUT AND DETAILS OF GRADE SLAB,
INDOOR CABLE TRENCH FOR AUX. BUILDING
(SCALE 1:80)

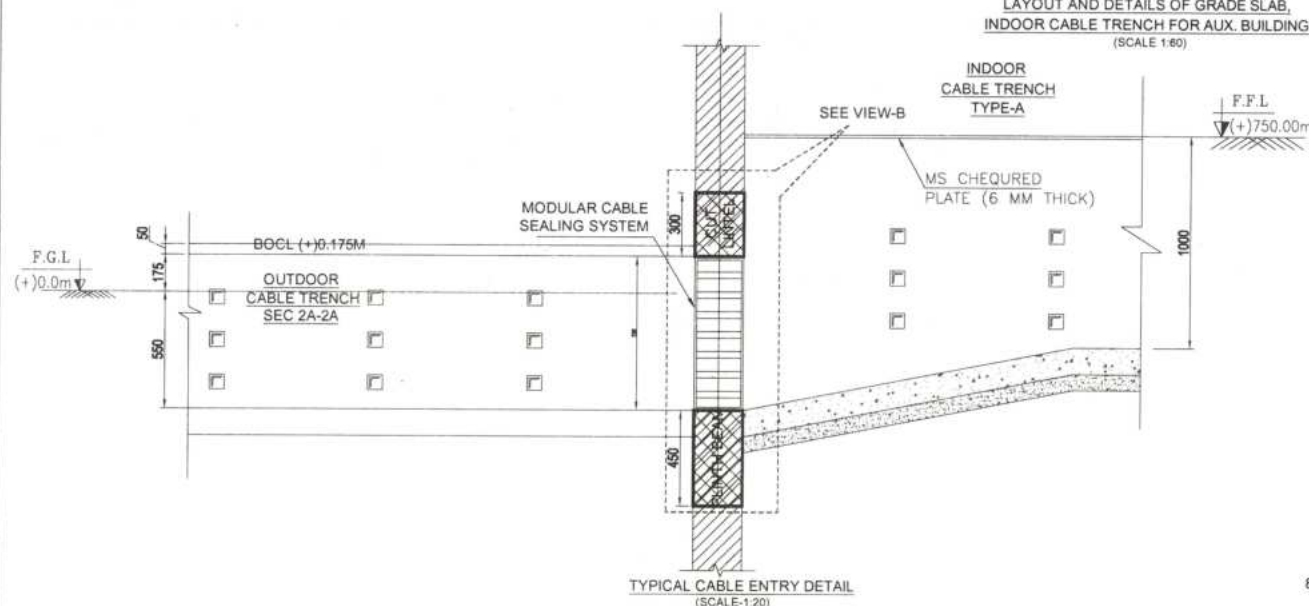


TYPICAL CABLE ENTRY DETAIL
(SCALE 1:20)

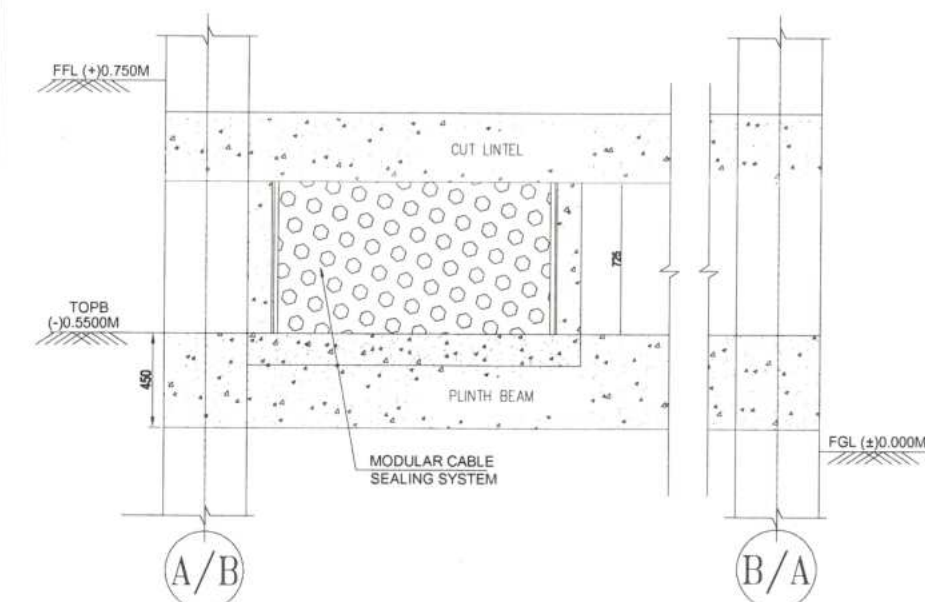


TYP. DETAIL OF FLOORING 150MM THK. GRADE SLAB
(SCALE 1:20)

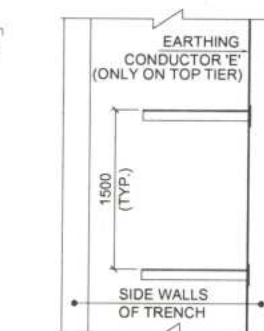


PLAN OF CABLE TRAY SUPPORT
FOR CABLE TRENCH SECTION 2-2 & 3-3
(COVER NOT SHOWN FOR CLARITY)
(SCALE 1:20)

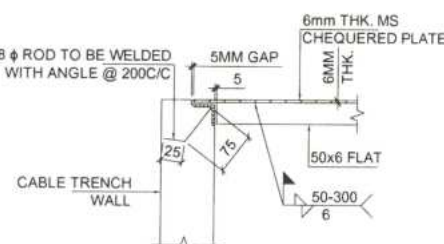


(#) DETAIL-Z' TYPICAL DETAIL OF
CHEQUERED PLATE SUPPORT
NOT COVERED BY PANELS
(SCALE 1:10)

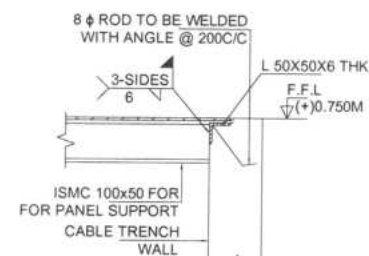


(#) TYPICAL ARRANGEMENT OF
TRENCH COVER
(FOR PORTION OF TRENCH COVERED BY PANELS)
(SCALE 1:10)

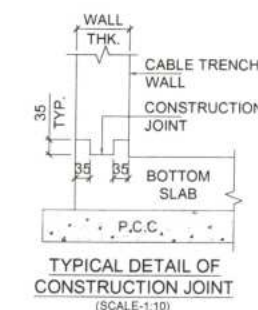

TYPICAL DETAIL OF
CONSTRUCTION JOINT
(SCALE 1:10)

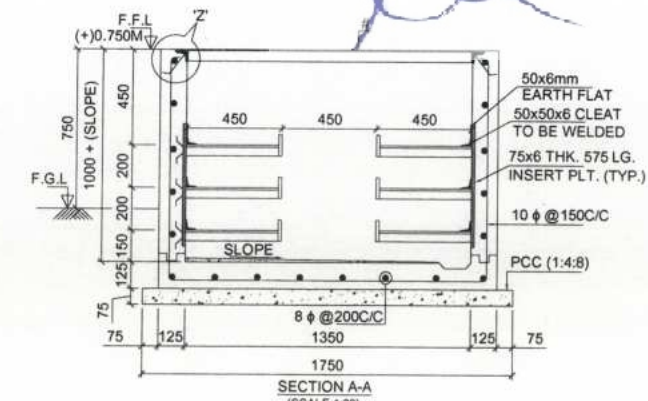

SECTION A-A
(SCALE 1:20)

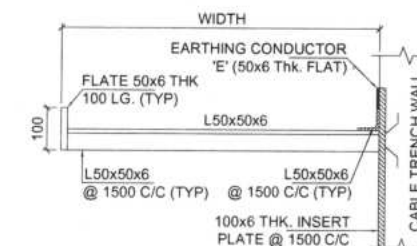

TYPICAL CABLE SUPPORT
(FOR ONE SIDE WALL)
(SCALE 1:10)

NOTES:-

- ALL DIMENSIONS ARE IN MM UNLESS OTHERWISE SPECIFIED.
- 50x6mm MS FLAT SHALL RUN ALONG THE TRENCH ROUTE FOR CABLE SUPPORT EARTHING.
- CABLE SEALING DETAILS SHALL BE SUBMITTED SEPARATELY.

LEGENDS:-

INDOOR CABLE TRENCH

PVC PIPE

REFERENCE DRAWINGS:-

- AUXILIARY BUILDING ARCHITECTURE DRAWING-
C/ENGG/NR1/BIKANER-III/SS01/ARCH/GF & ROOF PLAN/01
C/ENGG/NR1/BIKANER-III/SS01/ARCH/ELEV & SECTION/01
- AUXILIARY BUILDING STRUCTURE DRAWING-
C/ENGG/NR-1/BIK-III/SS-01/AUX BLDG/FDN-COL/01
C/ENGG/NR-1/BIK-III/SS-01/AUX BLDG/PB/01
C/ENGG/NR-1/BIK-III/SS-01/AUX BLDG/LB/01
C/ENGG/NR-1/BIK-III/SS-01/AUX BLDG/RB/01
C/ENGG/NR-1/BIK-III/SS-01/AUX BLDG/SLB/01

POWER GRID CORPORATION
OF INDIA LIMITED
(A Government of India Enterprise)



PROJECT:

SUBSTATION PACKAGE SS-01 FOR (I) ESTABLISHMENT OF 765/400/220KV BIKANER-III (NEW) POOLING STATION INCLUDING 400KV CLASS BUS REACTOR AT BIKANER-III S/S; (II) EXTENSION OF 765KV NEEMRANA-II S/S FOR TERMINATION OF 765 KV D/C LINE NEEMRANA-II-BIKANER-III T/L AND (III) EXTENSION OF 400KV BIKANER-II S/S FOR TERMINATION OF 400KV BIKANER-II BIKANER-III T/L UNDER 'TRANSMISSION SYSTEM FOR EVACUATION OF POWER FROM RAJASTHAN REZ PH-IV (PART-1) (BIKANER COMPLEX): PART-A'

TITLE:
RCC DETAILS OF GRADE SLAB AND INDOOR CABLE TRENCHES
FOR AUXILIARY BUILDING

DRAWING NO.
C/ENGG/NR1/BIKANER-III/SS01/IND CAB TRENCH/01

SCALE
NTS

SIZE
A1

REV.
1

REV.D.	REV.D. (ELEC.)	REV.D.	APPD.	DATE

संदर्भ/Ref : CC-ENGG-TB202359-1002269-SS3480-LTSWR-DRG

Date : 18/02/2025

From : Somiran Das
Senior GM**To :** Bharat Heavy Electricals Limited
Plot No.-7, Sector-142 Noida 201305
201305**Cc :****Subject :** Substation Package SS-01 for (i) Establishment of 765/400/220kV Bikaner-III (New) Pooling Station including 400kV class Bus Reactor at Bikaner-III S/s; (ii) Extension of 765kV Neemrana-II S/s for termination of 765 kV D/c line Neemrana-II-Bikaner-III T/L and (iii) Extension of 400kV Bikaner-II S/s for termination of 400kV Bikaner-II Bikaner-III T/L under "Transmission system for evacuation of power from Rajasthan REZ Ph-IV (Part-1) (Bikaner Complex): PART-A"**LOA Ref :** CC/T/W-AIS/DOM/A10/23/01956/NOA-1/24-102643/01 & 02 Dated 23/02/2024

Please find enclosed following drawings/ documents for necessary action at your end.

Vendor Drg. No. : USL/PGCIL/BHEL/2024-2025/1241A
Orgn. Drg. No. : TB202359-1002269-SS3480-LTSWR-DRG
Revision No. : 00
Drg. Title : BIKANER III NEW S/S- LT SWITCHGEAR - DRGS
App. Category : CAT-I
Release Date : 18/02/2025

Scan to verify

Comments : Generally in order with minor comments**अनुमोदित श्रेणी/App. Category:**

- I. फेब्रिकेशन/निर्माण/टाइप टेस्टिंग हेतु जारी।
Approved/released for fabrication/construction.
- II. फेब्रिकेशन/निर्माण/टाइप टेस्टिंग हेतु अनुमोदित/जारी बशर्ते दिए गए टिप्पणियाँ एवं आशोधनों की सम्मिलित किया जाये। कृपया रिवाइज्ड दस्तावेज अनुमोदनार्थ प्रस्तुत करें।
Approved/released for fabrication/ construction subject to incorporation of comments and modification as noted. Revised drawing required for approval.
- III. टिप्पणियाँ सम्मिलित करने के उपरांत दस्तावेज को अनुमोदनार्थ प्रस्तुत करें।
To be resubmitted for approval after incorporating the comments.
- IV. सूचनार्थ एवं रिकार्ड हेतु।
For information and record.
- CATREL/ निर्माण हेतु जारी।
REL-CON **Released for construction.**

नोट/Note:

1. Approval/Comments conveyed herein neither relieve the contractor of his contractual obligations and his responsibilities, weights, quantities, design details assemble fits, performance particulars and conformity of the supplies with the Indian Statutory Laws as may be applicable, nor does it limits the purchaser's right under the contract.
2. The approval conveyed vide this letter does not cover the approval of make for sub-vendor items.


CLIENT	POWER GRID CORPORATION OF INDIA LIMITED.					
CONTRACTOR	BHARAT HEAVY ELECTRICAL LIMITED (BHEL) TRANSMISSION PROJECTS DIVISION					
PROJECT NAME	765/400/220KV BIKANER-III POOLING STATION					
CA NO.	CC/T/W-AIS/DOM/A10/23/01956/NOA-1/24-102643/01 & 02 DATED 23.02.2024					
VENDOR NAME	ULTIMA SWITCHGEARS LTD.					
DOC NAME	DRG - ANNEXURE					
DOC NO	USL/PGCIL/BHEL/2024-2025/1241A					
S.NO.	DRG NO.	ITEM DESCRIPTION	NO. OF SHEET	REV.	PGCIL Approval Reference	REMARKS
DRAWINGS DETAILS FOR 415V MAIN SWITCH BOARD (1A) (MCRB)						
1	USL/PGCIL/BHEL/2024-2025/1241A-001	COVER SHEET	1	0	PROJECT SPECIFIC	Submitted for Project Specific approval for this Project
2	USL/PGCIL/BHEL/2024-2025/1241A-101	GENERAL ARRANGEMENT DRAWING	3	0		
3	USL/PGCIL/BHEL/2024-2025/1241A-201	SINGLE LINE DIAGRAM	4	0		
4	USL/PGCIL/BHEL/2024-2025/1241A-501	SCHEMATIC DRAWING OF ACB OUTGOING FEEDER	1	0		
5	USL/PGCIL/BHEL/2024-2025/1241A-701	BILL OF MATERIAL	6	0		
6		GENERAL TECHNICAL SPECIFICATIONFOR ALL PANEL	25	3	ALREADY APPROVED VIDE LETTER NO. CC-ENGG-TB202313-1001964-SS3420-LTSWR-DRG DATED 05.05.2024	Submitted for Extension of Approval for this Project
7		ELECTRICAL SYMBOL FOR ALL PANEL				
8		KEY LINE DIAGRAM FOR MSB & ACDB				
9		SCHEMATIC DRAWING FOR 415V MAIN SWITCH BOARD (MSB)				
DRAWINGS DETAILS FOR 415V AC DISTRIBUTION BOARD (2A) (MCRB)						
1	USL/PGCIL/BHEL/2024-2025/1241A-002	COVER SHEET	1	0	PROJECT SPECIFIC	Submitted for Project Specific approval for this Project
2	USL/PGCIL/BHEL/2024-2025/1241A-102	GENERAL ARRANGEMENT DRAWING	5	0		
3	USL/PGCIL/BHEL/2024-2025/1241A-202	SINGLE LINE DIAGRAM	12	0		
4	USL/PGCIL/BHEL/2024-2025/1241A-702	BILL OF MATERIAL	6	0		
5		GENERAL TECHNICAL SPECIFICATIONFOR ALL PANEL	26	3	ALREADY APPROVED VIDE LETTER NO. CC-ENGG-TB202313-1001964-SS3420-LTSWR-DRG DATED 05.05.2024	Submitted for Extension of Approval for this Project
6		ELECTRICAL SYMBOL FOR ALL PANEL				
7		KEY LINE DIAGRAM FOR MSB & ACDB				
8		SCHEMATIC DRAWING FOR 415V AC DISTRIBUTION BOARD (ACDB)				

S.NO.	DRG NO.	ITEM DESCRIPTION	NO. OF SHEET	REV.	PGCIL Approval Reference	REMARKS
DRAWINGS DETAILS FOR 415V MAIN LIGHTING DISTRIBUTION BOARD (3A) (MCRB)						Submitted for Project Specific approval for this Project
1	USL/PGCIL/BHEL/2024-2025/1241A-003	COVER SHEET	1	0	PROJECT SPECIFIC	
2	USL/PGCIL/BHEL/2024-2025/1241A-103	GENERAL ARRANGEMENT DRAWING	3	0		
3	USL/PGCIL/BHEL/2024-2025/1241A-203	SINGLE LINE DIAGRAM	7	0		
4	USL/PGCIL/BHEL/2024-2025/1241A-703	BILL OF MATERIAL	3	0	ALREADY APPROVED VIDE LETTER NO. CC-ENGG-TB202313-1001964-SS3420-LTSWR-DRG DATED 05.05.2024	Submitted for Extension of Approval for this Project
5		GENERAL TECHNICAL SPECIFICATIONFOR ALL PANEL	12	3		
6		ELECTRICAL SYMBOL FOR ALL PANEL				
7		SCHEMATIC DRAWING FOR 415V MAIN LIGHTING DISTRIBUTION BOARD				
DRAWINGS DETAILS FOR 415V EMERGENCY LIGHTING DISTRIBUTION BOARD (4A) (MCRB)						
1	USL/PGCIL/BHEL/2024-2025/1241A-004	COVER SHEET	1	0	PROJECT SPECIFIC	Submitted for Project Specific approval for this Project
2	USL/PGCIL/BHEL/2024-2025/1241A-104	GENERAL ARRANGEMENT DRAWING	3	0		
3	USL/PGCIL/BHEL/2024-2025/1241A-204	SINGLE LINE DIAGRAM	3	0		
4	USL/PGCIL/BHEL/2024-2025/1241A-704	BILL OF MATERIAL	2	0		
5		GENERAL TECHNICAL SPECIFICATIONFOR ALL PANEL	11	3	ALREADY APPROVED VIDE LETTER NO. CC-ENGG-TB202313-1001964-SS3420-LTSWR-DRG DATED 05.05.2024	Submitted for Extension of Approval for this Project
6		ELECTRICAL SYMBOL FOR ALL PANEL				
7		SCHEMATIC DRAWING FOR 415V EMERGENCY LIGHTING DISTRIBUTION BOARD				
DRAWINGS DETAILS FOR 220V DC DISTRIBUTION BOARD-1(1D)(MCRB)						
1	USL/PGCIL/BHEL/2024-2025/1241A-005	COVER SHEET	1	0	PROJECT SPECIFIC	Submitted for Project Specific approval for this Project
2	USL/PGCIL/BHEL/2024-2025/1241A-105	GENERAL ARRANGEMENT DRAWING	2	0		
3	USL/PGCIL/BHEL/2024-2025/1241A-205	SINGLE LINE DIAGRAM	5	0		
3	USL/PGCIL/BHEL/2024-2025/1241A-505	SCHEMATIC DRAWING	3	0		
4	USL/PGCIL/BHEL/2024-2025/1241A-705	BILL OF MATERIAL	2	0		
5		GENERAL TECHNICAL SPECIFICATIONFOR ALL PANEL	5	3	ALREADY APPROVED VIDE LETTER NO. CC-ENGG-TB202313-1001964-SS3420-LTSWR-DRG DATED 05.05.2024	Submitted for Extension of Approval for this Project
6		ELECTRICAL SYMBOL FOR ALL PANEL				

S.NO.	DRG NO.	ITEM DESCRIPTION	NO. OF SHEET	REV.	PGCIL Approval Reference	REMARKS	
DRAWINGS DETAILS FOR 220V DC DISTRIBUTION BOARD-2(2D)(MCRB)							
1	USL/PGCIL/BHEL/2024-2025/1241A-006	COVER SHEET	1	0	PROJECT SPECIFIC		Submitted for Project Specific approval for this Project
2	USL/PGCIL/BHEL/2024-2025/1241A-106	GENERAL ARRANGEMENT DRAWING	2	0			
3	USL/PGCIL/BHEL/2024-2025/1241A-206	SINGLE LINE DIAGRAM	5	0			
3	USL/PGCIL/BHEL/2024-2025/1241A-506	SCHEMATIC DRAWING	3	0			
4	USL/PGCIL/BHEL/2024-2025/1241A-706	BILL OF MATERIAL	2	0			
5		GENERAL TECHNICAL SPECIFICATIONFOR ALL PANEL	5	3	ALREADY APPROVED VIDE LETTER NO. CC-ENGG-TB202313-1001964-SS3420-LTSWR-DRG DATED 05.05.2024	Submitted for Extension of Approval for this Project	
6		ELECTRICAL SYMBOL FOR ALL PANEL					
DRAWINGS DETAILS FOR 48V DC DISTRIBUTION BOARD-1(3D)(MCRB)							
1	USL/PGCIL/BHEL/2024-2025/1241A-007	COVER SHEET	1	0	PROJECT SPECIFIC	Submitted for Project Specific approval for this Project	
2	USL/PGCIL/BHEL/2024-2025/1241A-107	GENERAL ARRANGEMENT DRAWING	1	0			
	USL/PGCIL/BHEL/2024-2025/1241A-207	SINGLE LINE DIAGRAM	3	0			
3	USL/PGCIL/BHEL/2024-2025/1241A-507	SCHEMATIC DRAWING	3	0			
4	USL/PGCIL/BHEL/2024-2025/1241A-707	BILL OF MATERIAL	2	0			
5		GENERAL TECHNICAL SPECIFICATIONFOR ALL PANEL	5	3	ALREADY APPROVED VIDE LETTER NO. CC-ENGG-TB202313-1001964-SS3420-LTSWR-DRG DATED 05.05.2024	Submitted for Extension of Approval for this Project	
6		ELECTRICAL SYMBOL FOR ALL PANEL					
DRAWINGS DETAILS FOR 48V DC DISTRIBUTION BOARD-2(4D)(MCRB)							
1	USL/PGCIL/BHEL/2024-2025/1241A-008	COVER SHEET	1	0	PROJECT SPECIFIC	Submitted for Project Specific approval for this Project	
2	USL/PGCIL/BHEL/2024-2025/1241A-108	GENERAL ARRANGEMENT DRAWING	1	0			
	USL/PGCIL/BHEL/2024-2025/1241A-208	SINGLE LINE DIAGRAM	3	0			
3	USL/PGCIL/BHEL/2024-2025/1241A-508	SCHEMATIC DRAWING	3	0			
4	USL/PGCIL/BHEL/2024-2025/1241A-708	BILL OF MATERIAL	2	0			
5		GENERAL TECHNICAL SPECIFICATIONFOR ALL PANEL	5	3	ALREADY APPROVED VIDE LETTER NO. CC-ENGG-TB202313-1001964-SS3420-LTSWR-DRG DATED 05.05.2024	Submitted for Extension of Approval for this Project	
6		ELECTRICAL SYMBOL FOR ALL PANEL					

S.NO.	DRG NO.	ITEM DESCRIPTION	NO. OF SHEET	REV.	PGCIL Approval Reference	REMARKS
DRAWINGS DETAILS FOR 415V AC DISTRIBUTION BOARD (5A) (AB)						Submitted for Project Specific approval for this Project
1	USL/PGCIL/BHEL/2024-2025/1241A-009	COVER SHEET	1	0	PROJECT SPECIFIC	
2	USL/PGCIL/BHEL/2024-2025/1241A-900	GENERAL TECHNICAL SPECIFICATION	1	0		
3	USL/PGCIL/BHEL/2024-2025/1241A-000-09	ELECTRICAL SYMBOL FOR ALL PANEL	1	0		
4	USL/PGCIL/BHEL/2024-2025/1241A-109	GENERAL ARRANGEMENT DRAWING	3	0		
5	USL/PGCIL/BHEL/2024-2025/1241A-209	SINGLE LINE DIAGRAM	13	0		
6	USL/PGCIL/BHEL/2024-2025/1241A-509-00	KEY LINE DIAGRAM	1	0		
7	USL/PGCIL/BHEL/2024-2025/1241A-509	SCHEMATIC DIAGRAM	3	0		
8	USL/PGCIL/BHEL/2024-2025/1241A-709	BILL OF MATERIAL	1	0		
DRAWINGS DETAILS FOR 220V DC DISTRIBUTION BOARD-1(5D) & 2(6D) (AB)						Submitted for Project Specific approval for this Project
1	USL/PGCIL/BHEL/2024-2025/1241A-010	COVER SHEET	1	0	PROJECT SPECIFIC	
2	USL/PGCIL/BHEL/2024-2025/1241A-1000	GENERAL TECHNICAL SPECIFICATION	1	0		
3	USL/PGCIL/BHEL/2024-2025/1241A-000-10	ELECTRICAL SYMBOL FOR ALL PANEL	1	0		
4	USL/PGCIL/BHEL/2024-2025/1241A-110	GENERAL ARRANGEMENT DRAWING	2	0		
5	USL/PGCIL/BHEL/2024-2025/1241A-210	SINGLE LINE DIAGRAM	10	0		
6	USL/PGCIL/BHEL/2024-2025/1241A-510	SCHEMATIC DIAGRAM	1	0		
7	USL/PGCIL/BHEL/2024-2025/1241A-710	BILL OF MATERIAL	1	0		
DRAWINGS DETAILS FOR 48V DC DISTRIBUTION BOARD-1(7D) & 2(8D) (AB)						Submitted for Project Specific approval for this Project
1	USL/PGCIL/BHEL/2024-2025/1241A-011	COVER SHEET	1	0	PROJECT SPECIFIC	
2	USL/PGCIL/BHEL/2024-2025/1241A-1100	GENERAL TECHNICAL SPECIFICATION	1	0		
3	USL/PGCIL/BHEL/2024-2025/1241A-000-11	ELECTRICAL SYMBOL FOR ALL PANEL	1	0		
4	USL/PGCIL/BHEL/2024-2025/1241A-111	GENERAL ARRANGEMENT DRAWING	2	0		
5	USL/PGCIL/BHEL/2024-2025/1241A-211	SINGLE LINE DIAGRAM	4	0		
6	USL/PGCIL/BHEL/2024-2025/1241A-511	SCHEMATIC DIAGRAM	1	0		
7	USL/PGCIL/BHEL/2024-2025/1241A-711	BILL OF MATERIAL	1	0		

This Drawing & information or descriptive matter set out hereon are the confidential property of **ULTIMA SWITCHGEARS LIMITED** & must not be disclosed, copied, loaned or used for manufacturing, tendering or for any other purpose without their permission.

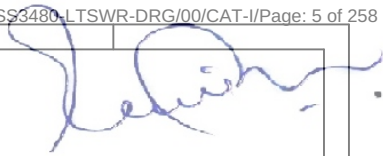

ENGINEERING DRAWING DETAILS FOR
415V MAIN SWITCH BOARD (1A) (MCRB)

PROJECT :- 765/400/220kV BIKANER-III POOLING STATION
CLIENT :- POWER GRID CORPORATION OF INDIA LIMITED
CONTRACTOR :- BHARAT HEAVY ELECTRICAL LIMITED (BHEL)
TRANSMISSION PROJECTS DIVISION



	04.	-	DRAWN	MP	
	03.	-	CHKD.	VDP	
	02.	-	APPD.	--	
	01.		ALL DIMENSIONS IN mm.		SIGN.
29.01.2025	00.	FIRST SUBMISSION FOR APPROVAL	TOLERANCE 5%		
DATE	No.	REVISIONS DESCRIPTION	REVISIONS : 00		

**MANUFACTURER**
ULTIMA[®] SWITCHGEARS LTD.

UNIT-I KHASRA NO. 215, IND. AREA, VILLAGE RAIPUR (BHAGWANPUR),
TEHSIL - ROORKEE, DISTRICT HARIDWAR (UTTRAKHAND) -
247667, INDIA, TEL : 01332-235043 FAX : 01332-235042
UNIT-II F-6 & F-7, SITE-C, UPSIDC, SURAJPUR INDUSTRIAL AREA,
GREATER NOIDA - 201306 G. B. NAGAR (U.P.) INDIA
E-mail : info@ultimaswitchgear.com

DRAWING	COVER PAGE	JOB NO.
TITLE	415V MAIN SWITCH BOARD (1A) (MCRB)	1241A
CA NO.	CC/T/W-AIS/DOM/A10/23/01956/NOA-1/24-102643/01 & 02 DATED 23.02.2024	
PROJECT	765/400/220kV BIKANER-III POOLING STATION	
CLIENT  POWER GRID CORPORATION OF INDIA LIMITED		CONTRACTOR:-  BHARAT HEAVY ELECTRICAL LIMITED (BHEL) TRANSMISSION PROJECTS DIVISION
DRG. NO.	USL/PGCIL/BHEL/2024-2025/1241A-001	SH. NO. 01 OF 01

This Drawing & information or descriptive matter set out hereon are the confidential property of **ULTIMA SWITCHGEARS LIMITED** & must not be disclosed, copied,loaned or used for manufacturing,tendering or for any other purpose without their permission.

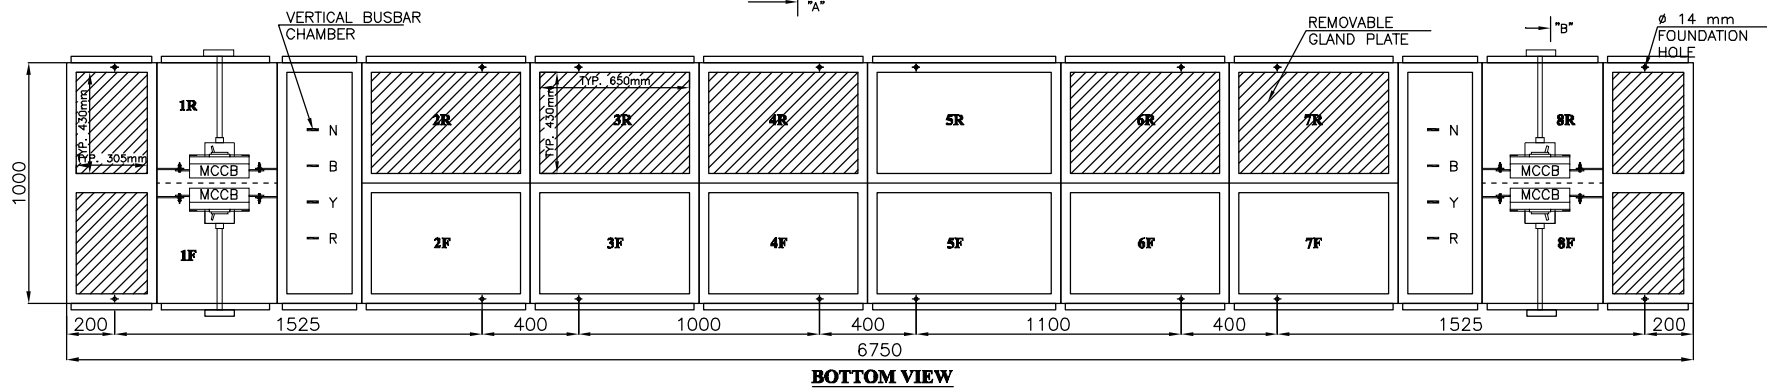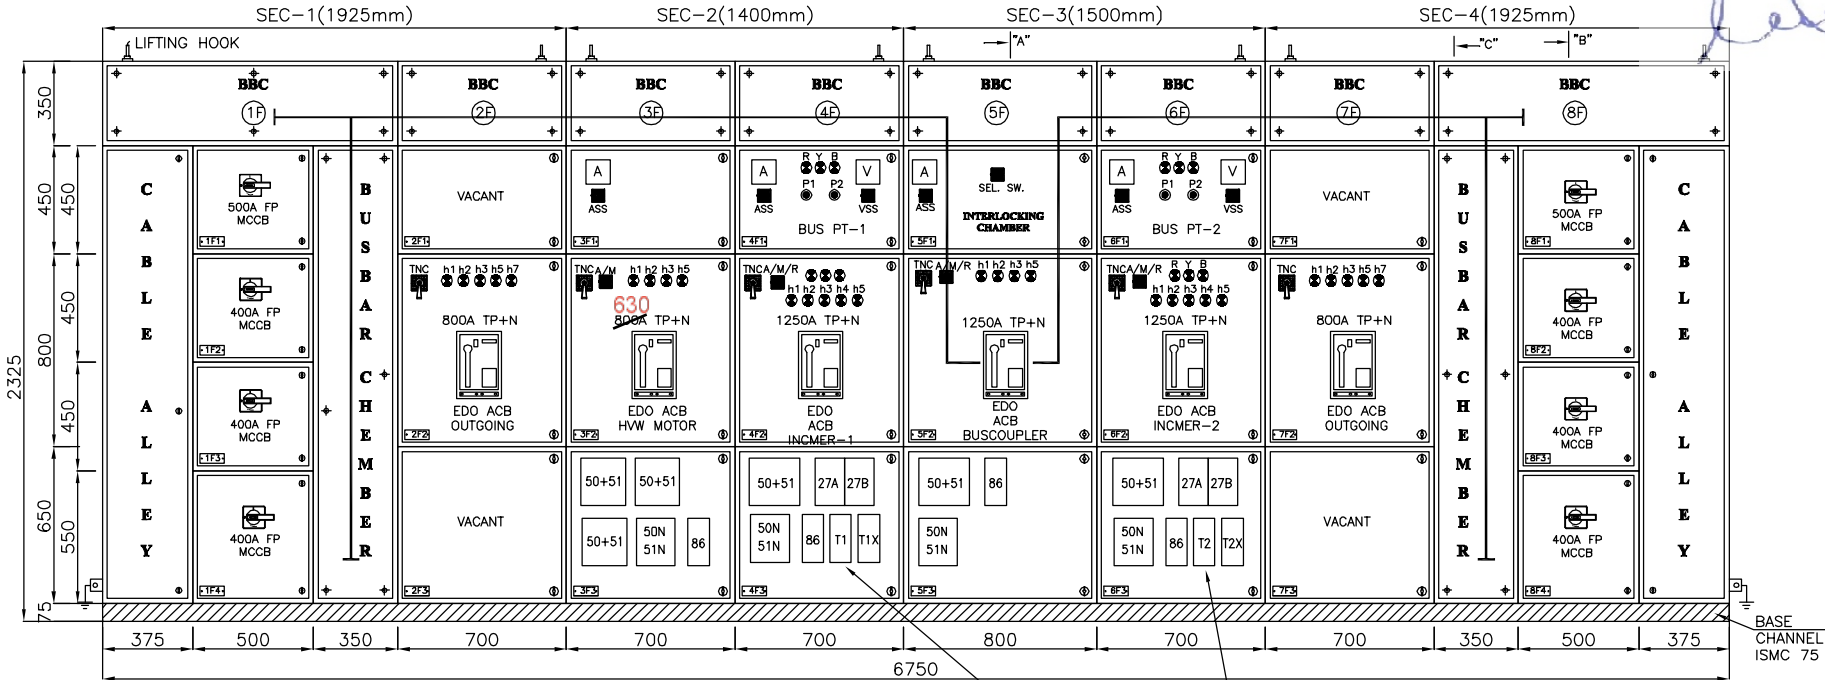

04.	—	DRAWN	MP	
03.	—	CHKD.	VDP	
02.	—	APPD.	—	
01.	—	ALL DIMENSIONS IN mm.	SIGN.	
29.01.2025	00.	FIRST SUBMISSION FOR APPROVAL	TOLERANCE 5%	
DATE	No.	REVISIONS DESCRIPTION	REVISIONS : 00	

MANUFACTURER


ULTIMA SWITCHGEARS LTD.

UNIT-I KHASRA NO. 215, IND. AREA, VILLAGE RAIPUR (BHAGWANPUR), TEHSIL - ROORKEE, DISTRICT HARIDWAR (UTTRAKHAND) - 247687, INDIA, TEL : 01332-235043 FAX : 01332-235042

UNIT-II F-6 & F-7, SITE-C, UPSIDC, SURAJPUR INDUSTRIAL AREA, GREATER NOIDA - 201306 G. B. NAGAR (U.P.) INDIA

E-mail : info@ultimaswitchgear.com

DRAWING	GENERAL ARRANGEMENT DRAWING	JOB NO.
TITLE	415V MAIN SWITCH BOARD (1A) (MCRB)	1241A
CA NO.	CC/T/W-AIS/DOM/A10/23/01956/NOA-1/24-102643/01 & 02 DATED 23.02.2024	
PROJECT	765/400/220KV BIKANER-III POOLING STATION	
CLIENT	POWER GRID CORPORATION OF INDIA LIMITED	CONTRACTOR:-
		BHARAT HEAVY ELECTRICAL LIMITED (BHEL) TRANSMISSION PROJECTS DIVISION
DRG. NO.	USL/PGCIL/BHEL/2024-2025/1241A-101	SH. NO. 01 OF 03

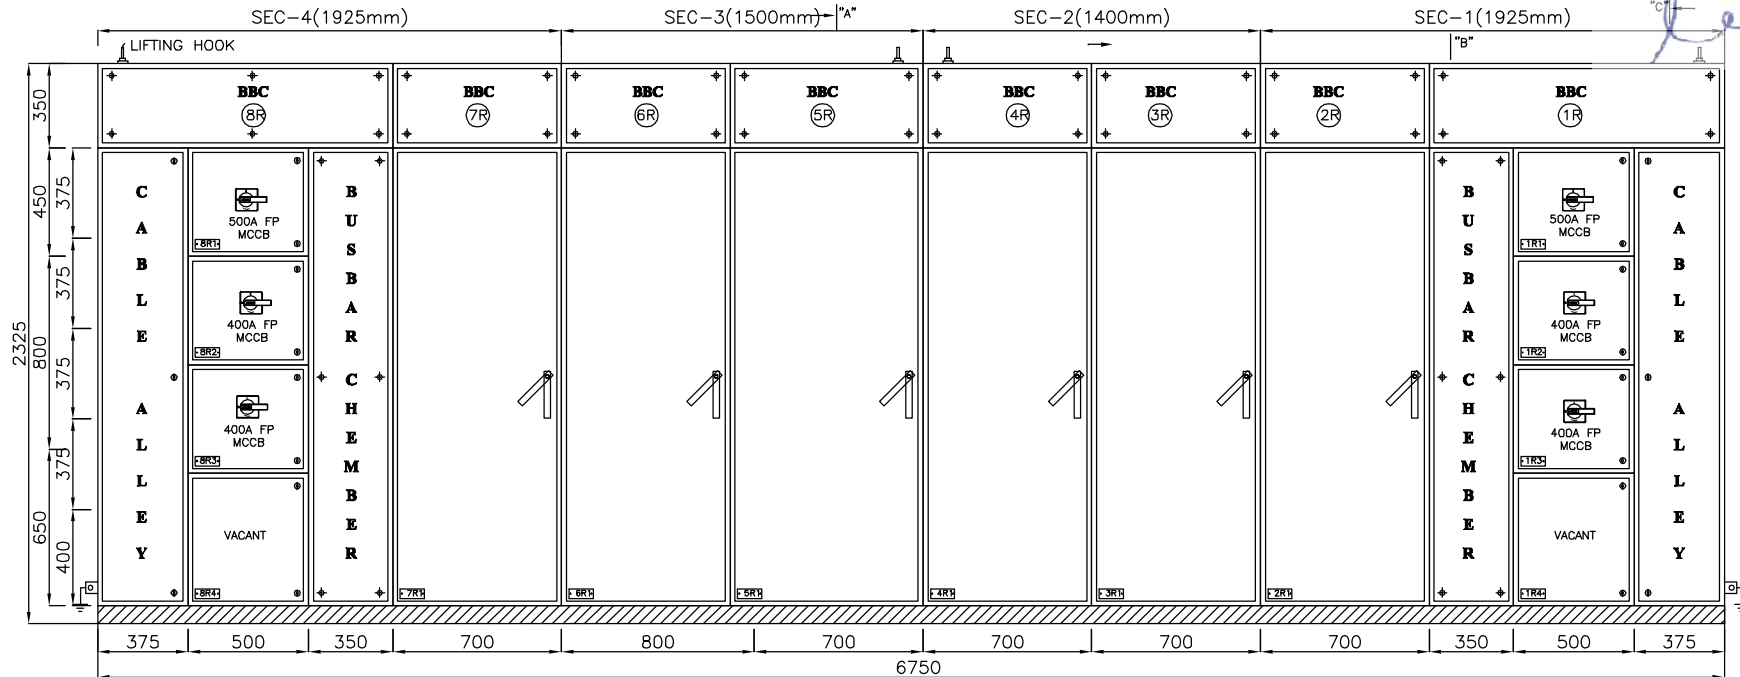

LEGEND DETAILS

R	=	'R' PHASE
Y	=	'Y' PHASE
B	=	'B' PHASE
h1	=	ACB ON INDICATION RED
h2	=	ACB OFF INDICATION GREEN
h3	=	ACB TRIP INDICATION AMBER
h4	=	TRANSFORMER FAULT INDICATION WHITE
h5	=	ACB SPRING CHARGE INDICATION BLUE
h6	=	DC HEALTHY INDICATION BLUE
h7	=	ILLUMINATION PUSH BUTTON FOR TCS WHITE
P1	=	TRF TRIP FAULT RESET PUSH BUTTON SPRING RETURN TYPE BLACK
P2	=	TRF N-TRIP FAULT RESET PUSH BUTTON SPRING RETURN TYPE BLACK
A	=	ANALOG AMMETER
V	=	ANALOG VOLT METER
ASS	=	AMPERE SELECTOR SWITCH
VSS	=	VOLTMETER SELECTOR SWITCH

BCS/TNC=	BREAKER CONTROL SWITCH
27A&27B=	UNDER VOLTAGE RELAY
86	MASTER TRIP RELAY (HAND RESET)
50+51	3POLE CURRENT EARTH FAULT RELAY
50N+51N	= EARTH FAULT RELAY
VMR	VOLTAGE MONITORING RELAY
A/M	AUTO/MANUAL SELECTOR SWITCH

HORIZONTAL BUS BAR SIZE:-

PHASE	: 1x150X10 Sq. mm AL. OR Eqv.
NEUTRAL	: 1x150X06 Sq. mm AL. OR Eqv.
EARTH	: 1X50X05 Sq. mm GS. OR Eqv.

VERTICAL BUS BAR SIZE:-

PHASE	: 2X75X10 SQ. MM AL. OR Eqv.
NEUTRAL	: 1X75X10 SQ. MM AL. OR Eqv.

PANEL DIMENSIONS

HEIGHT	: 2325 mm.
WIDTH	: 6750 mm.
DEPTH	: 1000 mm.

CABLE ENTRY


BOTTOM ENTRY

	04.	-	DRAWN	MP	
	03.	-	CHKD.	VDP	
	02.	-	APPD.	--	
	01.	-	ALL DIMENSIONS IN mm.	SIGN.	
29.01.2025	00.	FIRST SUBMISSION FOR APPROVAL	TOLERANCE 5%		
DATE	No.	REVISIONS DESCRIPTION	REVISIONS : 00		


MANUFACTURER
ULTIMA SWITCHGEARS LTD.
UNIT-I KHASRA NO. 215, IND. AREA, VILLAGE RAIPUR (BHAGWANPUR),
TEHSIL - ROORKEE, DISTRICT HARIDWAR (UTTRAKHAND) -
247687, INDIA, TEL : 01332-235043 FAX : 01332-235042
UNIT-II F-6 & F-7, SITE-C, UPSIDC, SURAJPUR INDUSTRIAL AREA,
GREATER NOIDA - 201306 G. B. NAGAR (U.P.) INDIA
E-mail : info@ultimaswitchgear.com

DRAWING	GENERAL ARRANGEMENT DRAWING	JOB NO.	1241A
TITLE	415V MAIN SWITCH BOARD (1A) (MCRB)		
CA NO.	CC/T/W-AIS/DOM/A10/23/01956/NOA-1/24-102643/01 & 02 DATED 23.02.2024		
PROJECT	765/400/220KV BIKANER-III POOLING STATION		
CLIENT	POWER GRID CORPORATION OF INDIA LIMITED	CONTRACTOR:-	BHARAT HEAVY ELECTRICAL LIMITED (BHEL) TRANSMISSION PROJECTS DIVISION
DRG. NO.	USL/PGCIL/BHEL/2024-2025/1241A-101	SH. NO.	02 OF 03


This Drawing & information or descriptive matter set out hereon are the confidential property of **ULTIMA SWITCHGEARS LIMITED** & must not be disclosed, copied, loaned or used for manufacturing, tendering or for any other purpose without their permission.

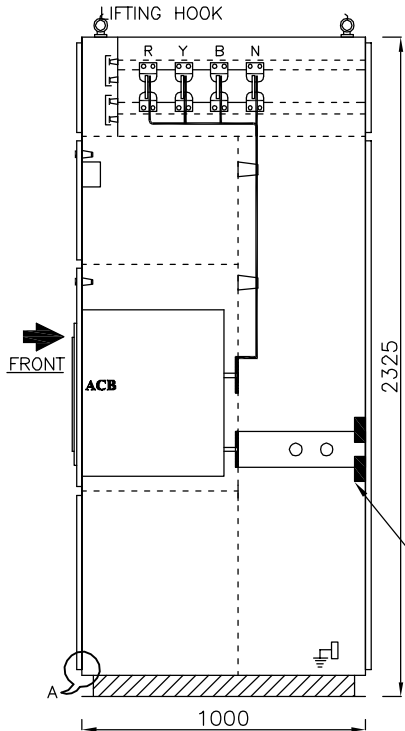


**SECTIONAL VIEW
AT "A"-"A"**

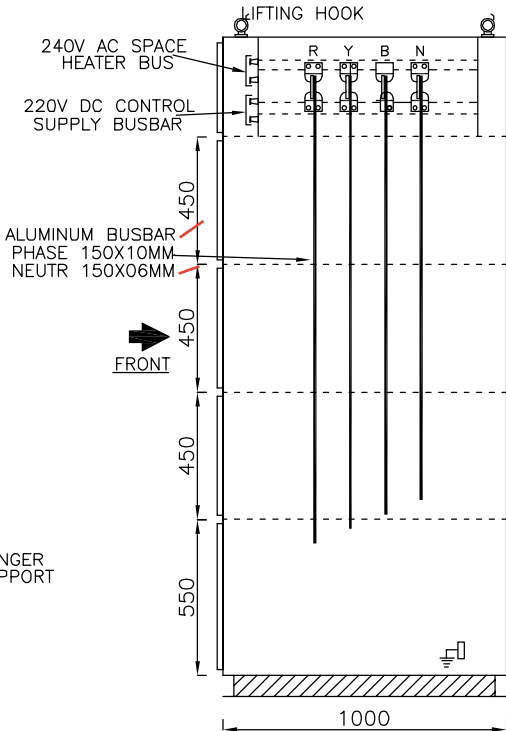


**SECTIONAL VIEW
AT "B"-"B"**

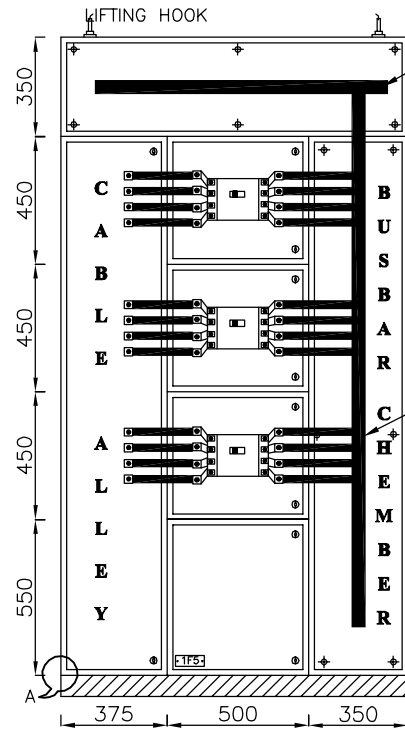


**TYP. DETAIL OF PANEL NO-1
(FRONT VIEW W/O DOOR & COVER)**

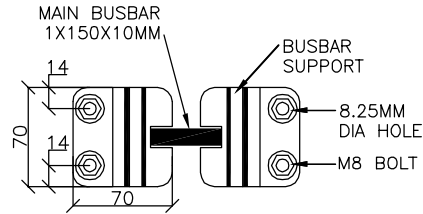


**DETAIL OF PHASE
BUSBAR SUPPORT**

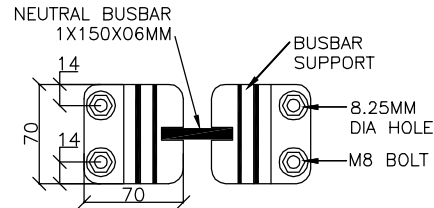

**DETAIL OF NEUTRAL
BUSBAR SUPPORT**

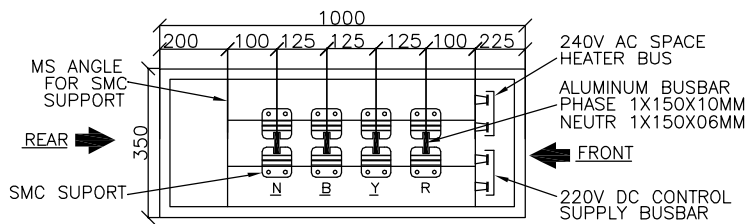

**SECTIONAL VIEW AT "C"-"C"
FOR HORIZONTAL BUSBAR
TOLERANCE AS PER IS**

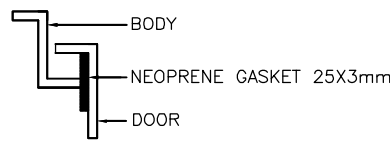

DETAIL-'A'

04.	—	DRAWN	MP	
03.	—	CHKD.	VDP	
02.	—	APPD.	—	
01.	—	ALL DIMENSIONS IN mm.	SIGN.	
29.01.2025	00.	FIRST SUBMISSION FOR APPROVAL	TOLERANCE 5%	
DATE	No.	REVISIONS DESCRIPTION	REVISIONS : 00	

MANUFACTURER


ULTIMA SWITCHGEARS LTD.

UNIT-I KHASRA NO. 215, IND. AREA, VILLAGE RAIPUR (BHAGWANPUR), TEHSIL - ROORKEE, DISTRICT HARIDWAR (UTTARAKHAND) - 247687, INDIA, TEL : 01332-235043 FAX : 01332-235042


UNIT-II F-6 & F-7, SITE-C, UPSIDC, SURAJPUR INDUSTRIAL AREA, GREATER NOIDA - 201306 G. B. NAGAR (U.P.) INDIA

E-mail : info@ultimaswitchgear.com

DRAWING	GENERAL ARRANGEMENT DRAWING	JOB NO.
TITLE	415V MAIN SWITCH BOARD (1A) (MCRB)	1241A
CA NO.	CC/T/W-AIS/DOM/A10/23/01956/NOA-1/24-102643/01 & 02 DATED 23.02.2024	
PROJECT	765/400/220KV BIKANER-III POOLING STATION	
CLIENT	POWER GRID CORPORATION OF INDIA LIMITED	CONTRACTOR:-
		BHARAT HEAVY ELECTRICAL LIMITED (BHEL) TRANSMISSION PROJECTS DIVISION
DRG. NO.	USL/PGCIL/BHEL/2024-2025/1241A-101	SH. NO. 03 OF 03

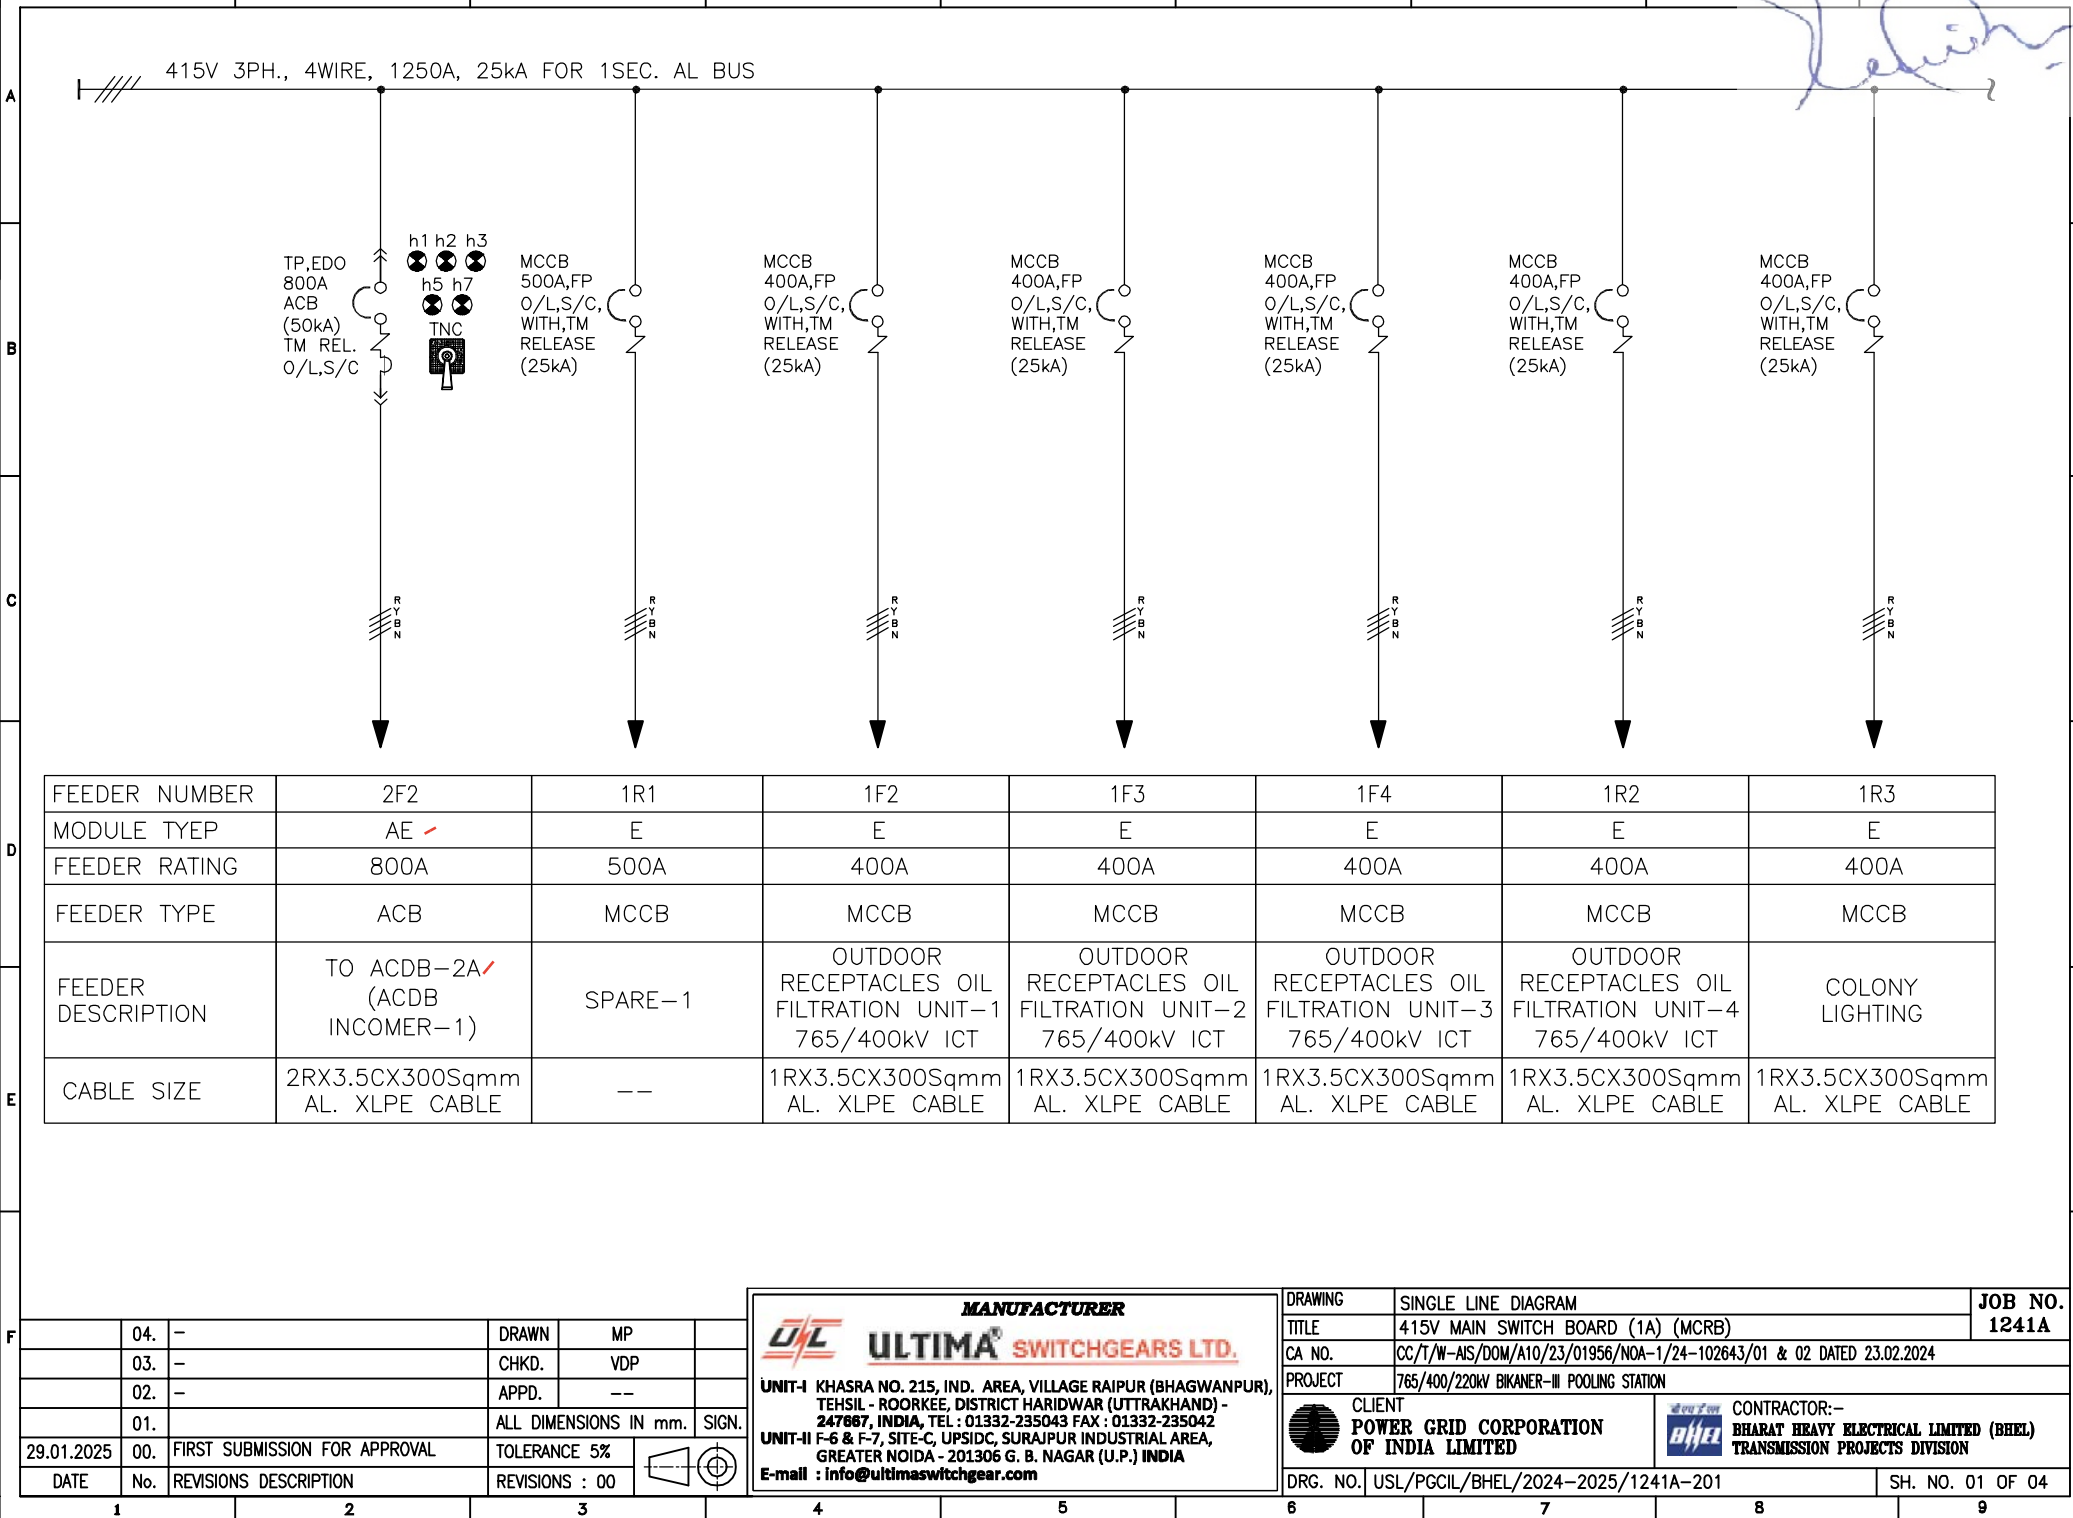


This Drawing & information or descriptive matter set out hereon are the confidential property of **ULTIMA SWITCHGEARS LIMITED** & must not be disclosed, copied,loaned or used for manufacturing,tendering or for any other purpose without their permission.

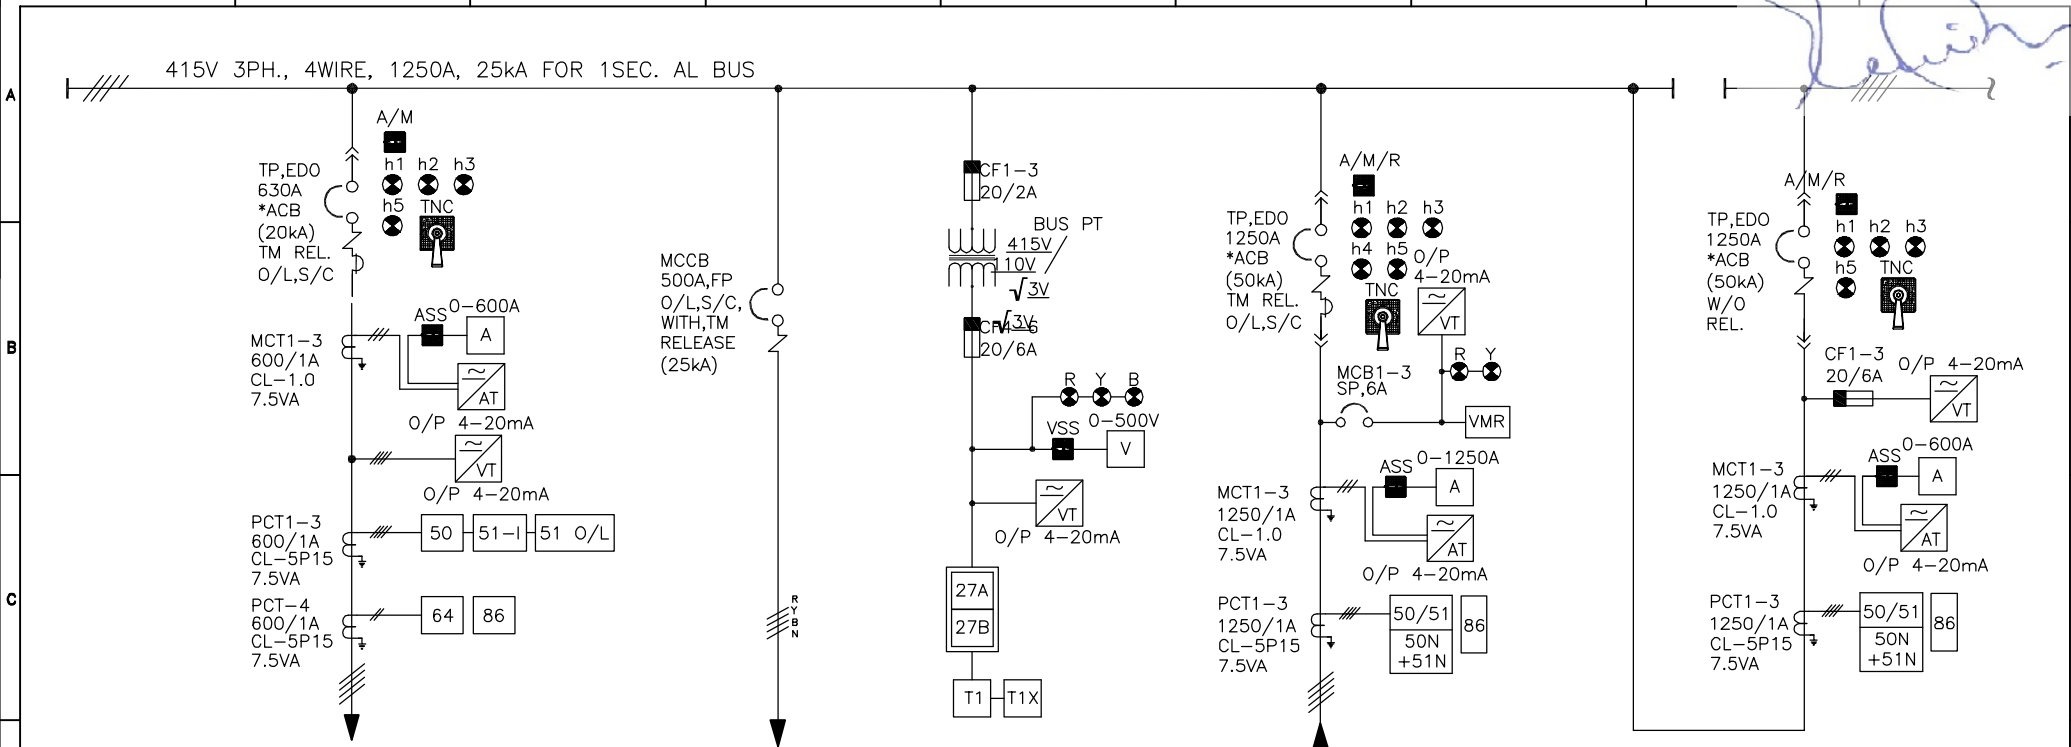

FEEDER NUMBER	3F1+3F2+3F3	1F1	4F1+4F3	4F1+4F2+4F3	5F1+5F2+5F3
MODULE TYEP	M	E	G1	AE	AE
FEEDER RATING	630A	500A	--	1250A	1250A
FEEDER TYPE	ACB	MCCB	BUS PT	ACB	ACB
FEEDER DESCRIPTION	HVW MOTOR	300KVA, LIGHTING TRANSFORMER-1	VT MODULE-1	INCOMER-1 FROM LT TRANSFORMER-1	BUSCOUPLER
CABLE SIZE	1RX3.5CX300Sqmm AL. XLPE CABLE	2RX3.5CX300Sqmm AL. XLPE CABLE	--	2Rx1Cx630Sqmm. AL XLPE FOR PHASE 1Rx1Cx630Sqmm. AL XLPE FOR NEUTRAL	--

04. — 03. — 02. — 01. — 29.01.2025 00. FIRST SUBMISSION FOR APPROVAL				DRAWN MP CHKD. VDP APPD. — ALL DIMENSIONS IN mm. SIGN. TOLERANCE 5% REVISIONS : 00				MANUFACTURER ULTIMA SWITCHGEARS LTD. UNIT-I KHASRA NO. 215, IND. AREA, VILLAGE RAIPUR (BHAGWANPUR), TEHSIL - ROORKEE, DISTRICT HARIDWAR (UTTRAKHAND) - 247667, INDIA, TEL : 01332-235043 FAX : 01332-235042 UNIT-II F-6 & F-7, SITE-C, UPSIDC, SURAJPUR INDUSTRIAL AREA, GREATER NOIDA - 201306 G. B. NAGAR (U.P.) INDIA E-mail : info@ultimaswitchgear.com DRAWING SINGLE LINE DIAGRAM TITLE 415V MAIN SWITCH BOARD (1A) (MCRB) CA NO. CC/T/W-AIS/DOM/A10/23/01956/NOA-1/24-102643/01 & 02 DATED 23.02.2024 PROJECT 765/400/220KV BIKANER-III POOLING STATION CLIENT POWER GRID CORPORATION OF INDIA LIMITED CONTRACTOR:- BHARAT HEAVY ELECTRICAL LIMITED (BHEL) TRANSMISSION PROJECTS DIVISION DRG. NO. USL/PGCIL/BHEL/2024-2025/1241A-201 JOB NO. 1241A SH. NO. 02 OF 04			
1	2	3	4	5	6	7	8	9			

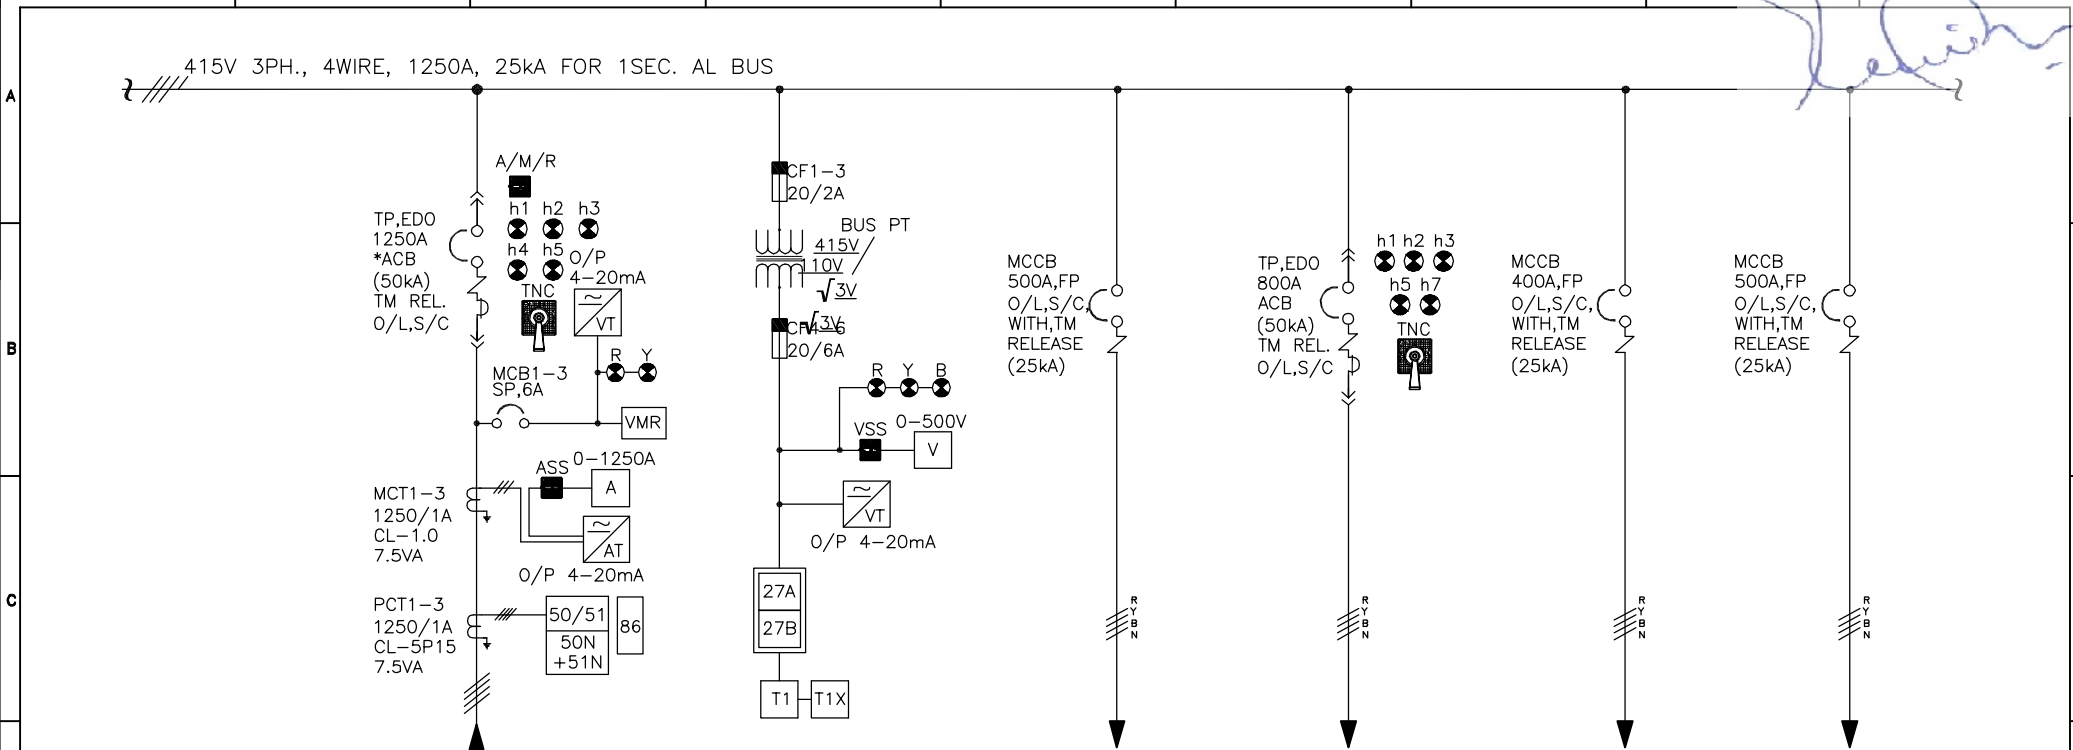

FEEDER NUMBER	6F1+6F2+6F3	6F1+6F3	8F1	7F2	8F2	8R1
MODULE TYEP	AE	G1	E	AE	E	E
FEEDER RATING	1250A	--	500A	800A	400A	500A
FEEDER TYPE	ACB	BUS PT	MCCB	ACB	MCCB	MCCB
FEEDER DESCRIPTION	INCOMER-2 FROM LT TRANSFORMER-2	VT MODULE-2	300kVA, LIGHTING TRANSFORMER-2	TO ACDB-2A (ACDB INCOMER-2)	COLONY LIGHTING	SPARE-2
CABLE SIZE	2Rx1Cx630Sqmm. AL XLPE FOR PHASE 1Rx1Cx630Sqmm. AL XLPE FOR NEUTRAL	--	2RX3.5CX300Sqmm AL. XLPE CABLE	2RX3.5CX300Sqmm AL. XLPE CABLE	1RX3.5CX300Sqmm AL. XLPE CABLE	--

F	04.	-	DRAWN	MP	
	03.	-	CHKD.	VDP	
	02.	-	APPD.	--	
	01.	-	ALL DIMENSIONS IN mm. SIGN.		
	29.01.2025	00.	FIRST SUBMISSION FOR APPROVAL		
DATE		No.	REVISIONS DESCRIPTION		REVISIONS : 00


MANUFACTURER
ULTIMA SWITCHGEARS LTD.

UNIT-I KHASRA NO. 215, IND. AREA, VILLAGE RAIPUR (BHAGWANPUR),
TEHSIL - ROORKEE, DISTRICT HARIDWAR (UTTARAKHAND) -
247687, INDIA, TEL : 01332-235043 FAX : 01332-235042
UNIT-II F-6 & F-7, SITE-C, UPSIDC, SURAJPUR INDUSTRIAL AREA,
GREATER NOIDA - 201306 G. B. NAGAR (U.P.) INDIA
E-mail : info@ultimaswitchgear.com

DRAWING	SINGLE LINE DIAGRAM		JOB NO.
TITLE	415V MAIN SWITCH BOARD (1A) (MCRB)		1241A
CA NO.	CC/T/W-AIS/DOM/A10/23/01956/NOA-1/24-102643/01 & 02 DATED 23.02.2024		
PROJECT	765/400/220KV BIKANER-III POOLING STATION		
	CLIENT POWER GRID CORPORATION OF INDIA LIMITED		CONTRACTOR:- BHARAT HEAVY ELECTRICAL LIMITED (BHEL) TRANSMISSION PROJECTS DIVISION
DRG. NO.	USL/PGCIL/BHEL/2024-2025/1241A-201		SH. NO. 03 OF 04

This Drawing & information or descriptive matter set out hereon are the confidential property of **ULTIMA SWITCHGEARS LIMITED** & must not be disclosed, copied,loaned or used for manufacturing,tendering or for any other purpose without their permission.

[Handwritten Signature]

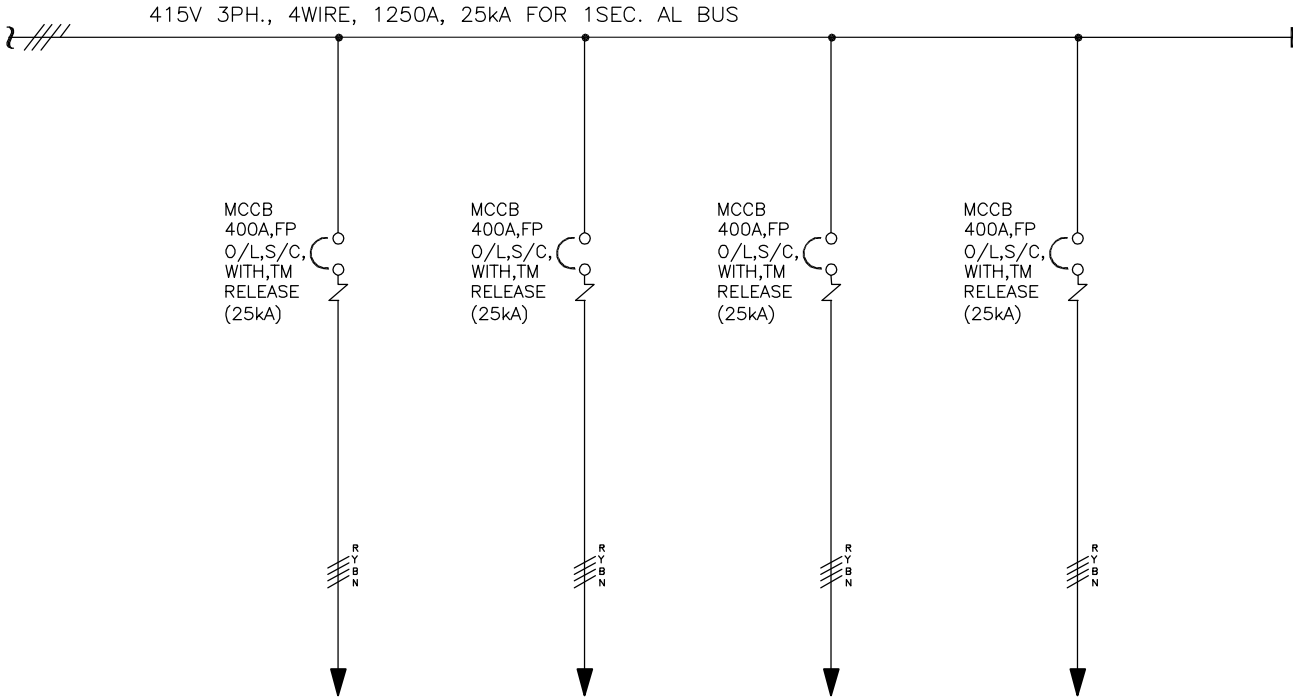

FEEDER NUMBER	8F3	8F4	8R2	8R3
MODULE TYEP	E	E	E	E
FEEDER RATING	400A	400A	400A	400A
FEEDER TYPE	MCCB	MCCB	MCCB	MCCB
FEEDER DESCRIPTION	OUTDOOR RECEPTACLES OIL FILTRATION UNIT-5 765/400kv ICT	OUTDOOR RECEPTACLES OIL FILTRATION UNIT-6 765/400kv ICT	OUTDOOR RECEPTACLES OIL FILTRATION UNIT-7 765/400kv ICT	OUTDOOR RECEPTACLES OIL FILTRATION UNIT-8 765/400kv ICT
CABLE SIZE	1RX3.5CX300Sqmm AL. XLPE CABLE	1RX3.5CX300Sqmm AL. XLPE CABLE	1RX3.5CX300Sqmm AL. XLPE CABLE	1RX3.5CX300Sqmm AL. XLPE CABLE


	04.	-	DRAWN	MP	
	03.	-	CHKD.	VDP	
	02.	-	APPD.	--	
	01.	-	ALL DIMENSIONS IN mm. SIGN.		
29.01.2025	00.	FIRST SUBMISSION FOR APPROVAL	TOLERANCE 5%		
DATE	No.	REVISIONS DESCRIPTION	REVISIONS : 00		

MANUFACTURER
ULTIMA® SWITCHGEARS LTD.

UNIT-I KHASRA NO. 215, IND. AREA, VILLAGE RAIPUR (BHAGWANPUR), TEHSIL - ROORKEE, DISTRICT HARIDWAR (UTTRAKHAND) - 247667, INDIA, TEL : 01332-235043 FAX : 01332-235042
UNIT-II F-6 & F-7, SITE-C, UPSIDC, SURAJPUR INDUSTRIAL AREA, GREATER NOIDA - 201306 G. B. NAGAR (U.P.) INDIA
E-mail : info@ultimaswitchgear.com

DRAWING	SINGLE LINE DIAGRAM		JOB NO.
TITLE	415V MAIN SWITCH BOARD (1A) (MCRB)		1241A
CA NO.	CC/T/W-AIS/DOM/A10/23/01956/NOA-1/24-102643/01 & 02 DATED 23.02.2024		
PROJECT	765/400/220KV BIKANER-III POOLING STATION		
	CLIENT POWER GRID CORPORATION OF INDIA LIMITED		CONTRACTOR:- BHARAT HEAVY ELECTRICAL LIMITED (BHEL) TRANSMISSION PROJECTS DIVISION
DRG. NO.	USL/PGCIL/BHEL/2024-2025/1241A-201		SH. NO. 04 OF 04

This Drawing & information or descriptive matter set out hereon are the confidential property of **ULTIMA SWITCHGEARS LIMITED** & must not be disclosed, copied, loaned or used for manufacturing, tendering or for any other purpose without their permission.

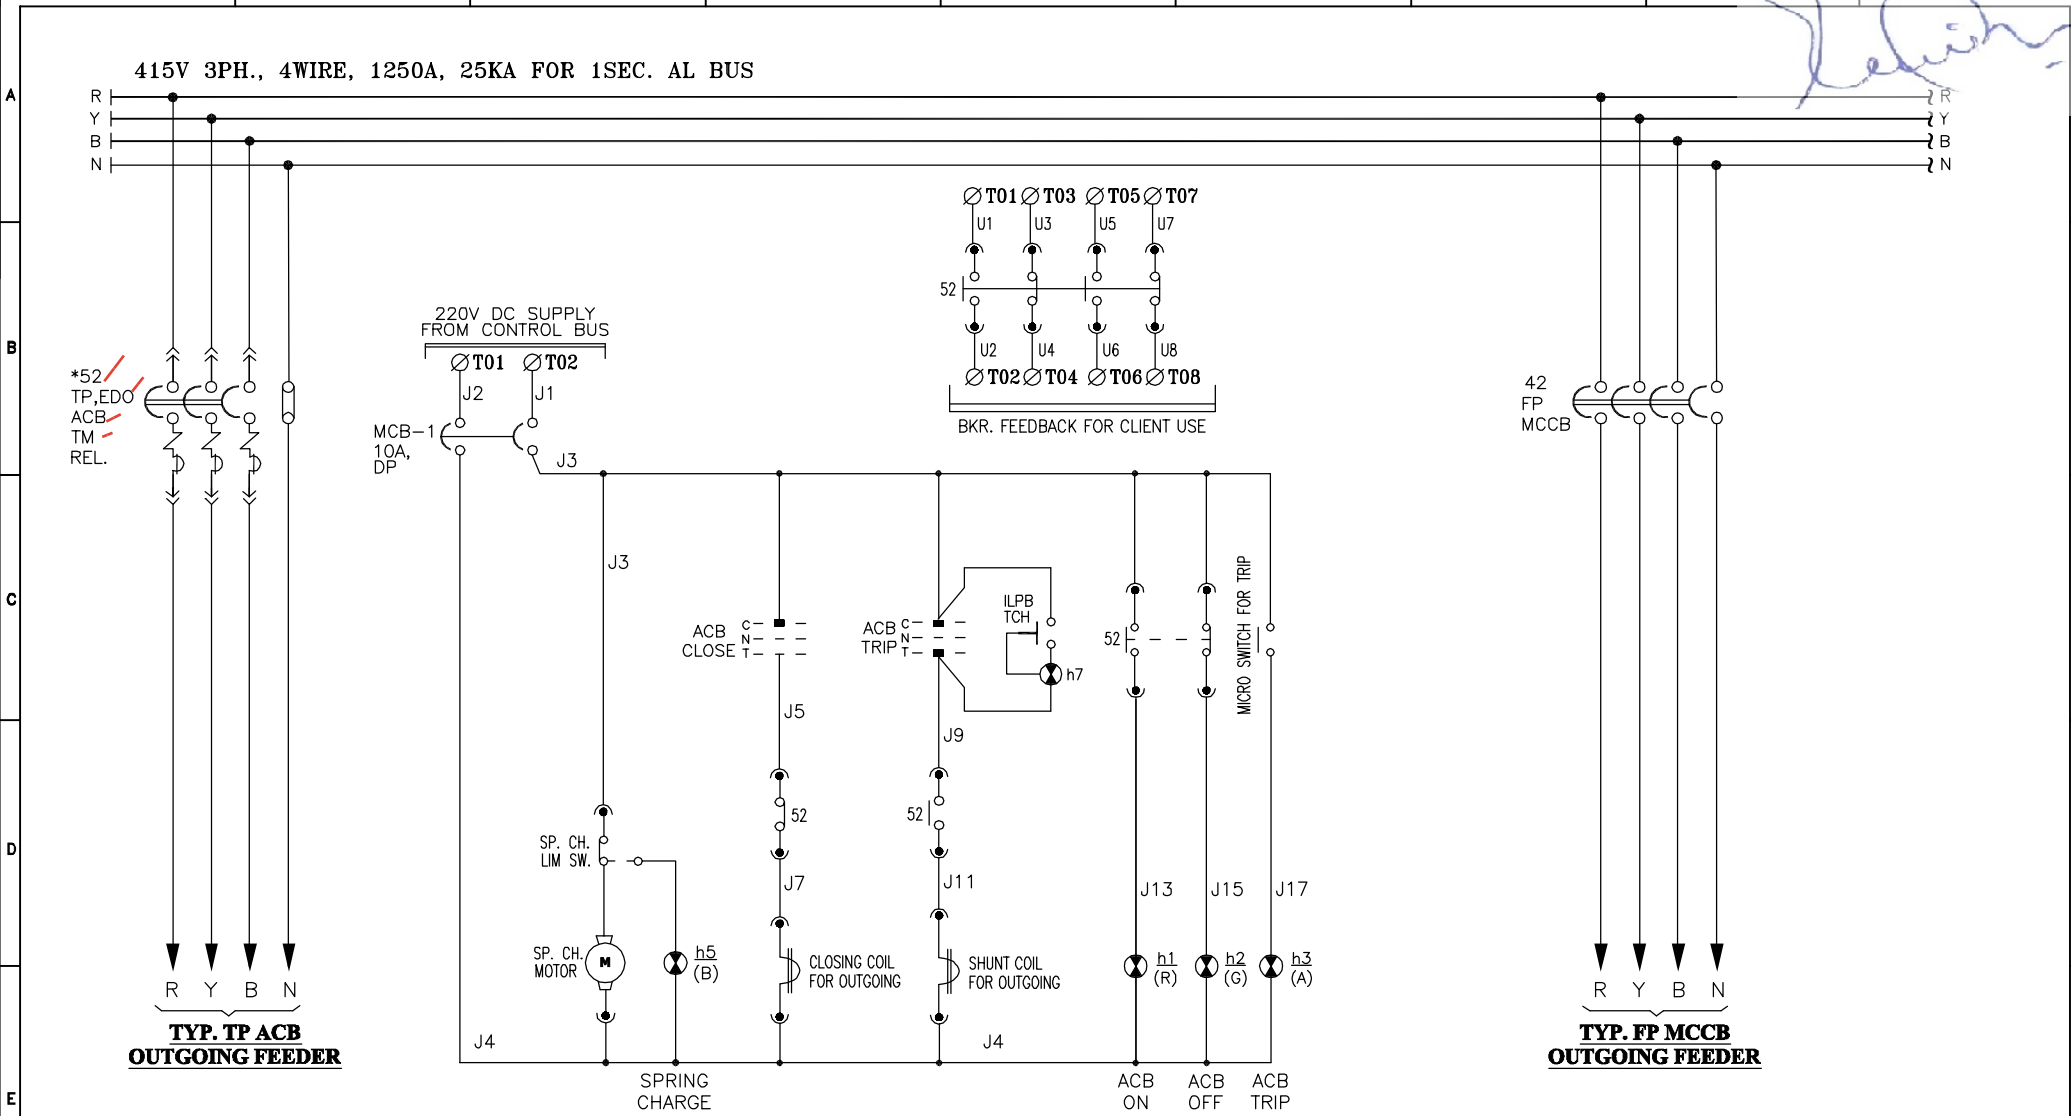

SCHEMATIC DRAWING FOR ACB OUTGOING FEEDER (AE) CIRCUIT BREAKER

F		04.	—	DRAWN	MP		ULTIMA[®] SWITCHGEARS LTD. UNIT-I KHASRA NO. 215, IND. AREA, VILLAGE RAIPUR (BHAGWANPUR), TEHSIL - ROORKEE, DISTRICT HARIDWAR (UTTRAKHAND) - 247667, INDIA, TEL : 01332-235043 FAX : 01332-235042 UNIT-II F-6 & F-7, SITE-C, UPSIDC, SURAJPUR INDUSTRIAL AREA, GREATER NOIDA - 201306 G. B. NAGAR (U.P.) INDIA E-mail : info@ultimaswitchgear.com	6	DRAWING	SCHEMATIC DRAWING			JOB NO. 1241A
	TITLE	415V MAIN SWITCH BOARD (1A) (MCRB)											
	CA NO.	CC/T/W-AIS/DOM/A10/23/01956/NOA-1/24-102643/01 & 02 DATED 23.02.2024											
	PROJECT	765/400/220kV BIKANER-III POOLING STATION											
		01.		ALL DIMENSIONS IN mm.	SIGN.	POWER GRID CORPORATION OF INDIA LIMITED CONTRACTOR:- BHARAT HEAVY ELECTRICAL LIMITED (BHEL) TRANSMISSION PROJECTS DIVISION							
	29.01.2025	00.	FIRST SUBMISSION FOR APPROVAL	TOLERANCE 5%									
	DATE	No.	REVISIONS DESCRIPTION	REVISIONS : 00									
1	2	3	4	5	7	8	9						

BILL OF MATERIAL FOR 415V MAIN SWITCH BOARD (1A) (MCRB)

S.NO.	ITEM CODE	DESCRIPTION	MAKE	RATING	QTY.
A	BILL OF MATERIAL FOR MODULE - (AE) INCOMER 1&2				2NOs
1	52A & 52B	TP ACB, EDO, WITH THERMAL MAGNETIC BASED RELEASE FOR O/L/S/C PROTECTION, 1. SPRING CHARGE MOTOR 220V DC WITH SPRING CHARGE SWITCH 2. CLOSING COIL 220V DC 3. SHUNT COIL 220V DC 4. LIMIT SWITCH FOR TEST/ISOLATE/SERVICE POSITION 5. 4NO + 4NC POTENTIAL FREE CONTACT.	L&T/C&S/HAVELLS	1250A, 50kA	01
2	CF7-13	HRC FUSE BASE	L&T/C&S/HAVELLS	20A	07
3	CF7-13	HRC FUSE LINK	L&T/C&S/HAVELLS	6A	07
4	94,SX,1TX,52AX	AUX. CONTACTOR RELAY, COIL VOLTAGE 220V DC WITH 2NO+2NC AUX. CONTACT	L&T/C&S/HAVELLS	--	04
5	T1X	AUX. CONTACTOR RELAY, COIL VOLTAGE 220V DC WITH 3NO+1NC AUX. CONTACT	L&T/C&S/HAVELLS		01
6	BZ,WT,OT	AUX. CONTACTOR RELAY, COIL VOLTAGE 220V DC WITH 4NO AUX. CONTACT	L&T/C&S/HAVELLS	--	06
7	52AX	2NO+2NC ADD ON BLOCK	L&T/C&S/HAVELLS	--	01
8	MCB	DP MINIATURE CIRCUIT BREAKER, DC TYPE	L&T/C&S/HAVELLS	10A, DP	01
9	MCB	DP MINIATURE CIRCUIT BREAKER, DC TYPE	L&T/C&S/HAVELLS	6A, DP	01
10	MCB	SP MINIATURE CIRCUIT BREAKER, 'C' CURVE	L&T/C&S/HAVELLS	6A, SP	03
11	MCTs	CURRENT TRANSFORMER, RESIN CAST TYPE	NEWTEK/AE/PRECISE/ PROCOM/ASHMOR	1250/1A, CL-1, 7.5VA	03
12	PCTs	CURRENT TRANSFORMER, RESIN CAST TYPE		1250/1A, CL-5P15, 7.5VA	04
13	A	ANALOG AMMETER, SINGLE PHASE, SIZE-96X96 Sq. mm, CL-1.0, CTR-/1A	AE/RISHAB/NEWTEK/SECURE	0-1250A	01
14	ASS	AMMETER SELECTOR SWITCH, ROTARY TYPE	SALZER/KAYCEE/TELERGON	6A	01
15	A/M/R	AUTO/MANUAL/REMOTE SELECTOR SWITCH WITH OFF, 3POLE 3WAY, ROTARY TYPE	SALZER/KAYCEE/TELERGON	6A	01
16	TNC	BREAKER CONTROL SWITCH, ROTARY TYPE	SALZER/KAYCEE/TELERGON	16A	01
17	86	HIGH SPEED TRIPPING RELAY (AUTO RESET)	L&T/JVS/C&S	NOMINAL VOLTAGE 220V DC	01
18	50 + 51	TRIPLE POLE INSTANTANEOUS OVER-CURRENT RELAY HAVING THE SETTING RANGE OF 200-800% OR 500-2000% OF CT SECONDARY AND ADJUSTABLE DEFINITE MINIMUM TIME, AUX. SUPPLY 220V DC .	L&T/JVS/C&S	-/1A	01
19	50N + 51N	INSTANTANEOUS EARTH FAULT RELAY HAVING AN ADJUSTABLE SETTING RANGE OF 10-40% OR 20 - 80% OF CT SECONDARY CURRENT AND ADJUSTABLE DEFINITE MINIMUM TIME. THE EARTH FAULT RELAY SHALL BE PROVIDED WITH A STABILISING RESISTOR, AUX. SUPPLY 220V DC.	L&T/JVS/C&S	-/1A	01

NOTE:- ALL COMPONENTS SHALL BE POWER GRID (QA&I) APPROVED MAKE

	04.	-	DRAWN	MP	
	03.	-	CHKD.	VDP	
	02.	-	APPD.	--	
	01.		ALL DIMENSIONS IN mm. SIGN.		
29.01.2025	00.	FIRST SUBMISSION FOR APPROVAL	TOLERANCE 5%		
DATE	No.	REVISIONS DESCRIPTION	REVISIONS : 00		

MANUFACTURER

 **ULTIMA SWITCHGEARS LTD.**

UNIT-I KHASRA NO. 215, IND. AREA, VILLAGE RAIPUR (BHAGWANPUR),
TEHSIL - ROORKEE, DISTRICT HARIDWAR (UTTRAKHAND) -
247687, INDIA, TEL : 01332-235043 FAX : 01332-235042
UNIT-II F-6 & F-7, SITE-C, UPSIDC, SURAJPUR INDUSTRIAL AREA,
GREATER NOIDA - 201306 G. B. NAGAR (U.P.) INDIA
E-mail : info@ultimaswitchgear.com

DRAWING	BILL OF MATERIAL	JOB NO.
TITLE	415V MAIN SWITCH BOARD (1A) (MCRB)	1241A
CA NO.	CC/T/W-AIS/DOM/A10/23/01956/NOA-1/24-102643/01 & 02 DATED 23.02.2024	
PROJECT	765/400/220KV BIKANER-III POOLING STATION	
CLIENT	CONTRACTOR:-	
 POWER GRID CORPORATION OF INDIA LIMITED	 BHARAT HEAVY ELECTRICAL LIMITED (BHEL) TRANSMISSION PROJECTS DIVISION	
DRG. NO.	USL/PGCIL/BHEL/2024-2025/1241A-701	SH. NO. 01 OF 06

1 2 3 4 5 6 7 8 9

[Handwritten signature]

BILL OF MATERIAL FOR 415V MAIN SWITCH BOARD (1A) (MCRB)

S.NO.	ITEM CODE	DESCRIPTION	MAKE	RATING	QTY.
A	BILL OF MATERIAL FOR MODULE - (AE) INCOMER 1&2				2NOs
20	VMR-1, VMR-2	415V AC, THREE PHASE, 3WIRE, VOLTAGE MONITORING RELAY	MINILEC/PGCIL APPROVED MAKE	--	01
21	Ct	AC CURRENT TRANSDUCER, SINGLE OUTPUT- 4-20mA, CT RATIO-1250/1A, AUX. SUPPLY 220V DC	AE/RISHAB/SECURE/PGCIL APPROVED	--	03
22	Vt	AC VOLTAGE TRANSDUCER, SINGLE OUTPUT- 4-20mA, PTR-415V AC, AUX. SUPPLY 220V DC	AE/RISHAB/SECURE	--	03
23	R-PHASE	'R' INDICATION LAMP, 22.5 Sq. mm. DIA ,LED TYPE, RED	ESBEE/VAISHNO/C&S	240V AC	01
24	Y-PHASE	'Y' INDICATION LAMP, 22.5 Sq. mm. DIA ,LED TYPE, YELLOW	ESBEE/VAISHNO/C&S	240V AC	01
25	B-PHASE	'B' INDICATION LAMP, 22.5 Sq. mm. DIA ,LED TYPE, BLUE	ESBEE/VAISHNO/C&S	240V AC	01
26	h1	'ON' INDICATION LAMP, 22.5 Sq. mm. DIA ,LED TYPE, RED	ESBEE/VAISHNO/C&S	220V DC	01
27	h2	'OFF' INDICATION LAMP, 22.5 Sq. mm. DIA ,LED TYPE, GREEN	ESBEE/VAISHNO/C&S	220V DC	01
28	h3	'TRIP' INDICATION LAMP, 22.5 Sq. mm. DIA ,LED TYPE, AMBER	ESBEE/VAISHNO/C&S	220V DC	01
29	h4	TRANSFORMER FAULT INDICATION LAMP, 22.5 Sq. mm. DIA ,LED TYPE, WHITE	ESBEE/VAISHNO/C&S	220V DC	01
30	h5	'SPRING CHARGE' INDICATION LAMP, 22.5 Sq. mm. DIA ,LED TYPE, BLUE	ESBEE/VAISHNO/C&S	220V DC	01
31	P1, P2	TRIP & NON-TRIP FAULT RESET PUSH BUTTON, 22.5 Sq. mm. DIA, SPRING RETURN TYPE, BLACK WITH 4NC CONTACT	ESBEE/VAISHNO/C&S	--	02
32	1T, 2T	ON DELAY TIMER WITH 1C/O AUXILIARY SWITCH, 0-60 SEC.	GIC/PGCIL APPROVED MAKE	220V DC	01
33	T1A, T2A	ON DELAY TIMER WITH 1C/O AUXILIARY SWITCH, 0-60 SEC.	GIC/PGCIL APPROVED MAKE	220V DC	01
0					
B	BILL OF MATERIAL FOR MODULE - (E) FOR OUTGOINGS				
1	MCCB	FP MCCB 415V, WITH THERMAL MAGNETIC BASED RELEASE FOR O/L,S/C PROTECTION WITH SPREADER LINK & EXTENDED ROM, Ics = 100% Icu	L&T/C&S/HAVELLS	500A, 25kA	04
2	MCCB	FP MCCB 415V, WITH THERMAL MAGNETIC BASED RELEASE FOR O/L,S/C PROTECTION WITH SPREADER LINK & EXTENDED ROM, Ics = 100% Icu	L&T/C&S/HAVELLS	400A, 25kA	10

NOTE:- ALL COMPONENTS SHALL BE POWER GRID (QA&I) APPROVED MAKE

	04.	-	DRAWN	MP	
	03.	-	CHKD.	VDP	
	02.	-	APPD.	--	
	01.		ALL DIMENSIONS IN mm.		SIGN.
29.01.2025	00.	FIRST SUBMISSION FOR APPROVAL	TOLERANCE 5%		
DATE	No.	REVISIONS DESCRIPTION	REVISIONS : 00		

MANUFACTURER

 **ULTIMA[®] SWITCHGEARS LTD.**

UNIT-I KHASRA NO. 215, IND. AREA, VILLAGE RAIPUR (BHAGWANPUR), TEHSIL - ROORKEE, DISTRICT HARIDWAR (UTTRAKHAND) - 247887, INDIA, TEL : 01332-235043 FAX : 01332-235042

UNIT-II F-6 & F-7, SITE-C, UPSIDC, SURAJPUR INDUSTRIAL AREA, GREATER NOIDA - 201306 G. B. NAGAR (U.P.) INDIA

E-mail : info@ultimaswitchgear.com

DRAWING	BILL OF MATERIAL	JOB NO.
TITLE	415V MAIN SWITCH BOARD (1A) (MCRB)	1241A
CA NO.	CC/T/W-AIS/DOM/A10/23/01956/NOA-1/24-102643/01 & 02 DATED 23.02.2024	
PROJECT	765/400/220KV BIKANER-III POOLING STATION	
CLIENT  POWER GRID CORPORATION OF INDIA LIMITED		CONTRACTOR:-  BHARAT HEAVY ELECTRICAL LIMITED (BHEL) TRANSMISSION PROJECTS DIVISION
DRG. NO.	USL/PGCIL/BHEL/2024-2025/1241A-701	SH. NO. 02 OF 06

This Drawing & information or descriptive matter set out hereon are the confidential property of **ULTIMA SWITCHGEARS LIMITED** & must not be disclosed, copied, loaned or used for manufacturing, tendering or for any other purpose without their permission.

BILL OF MATERIAL FOR 415V MAIN SWITCH BOARD (1A) (MCRB)

S.NO.	ITEM CODE	DESCRIPTION	MAKE	RATING	QTY.
C	BILL OF MATERIAL FOR MODULE - (M1) CIRCUIT BREAKER CONTROLLED MOTOR FEEDER				1NO
1	52	TP ACB, EDO, WITH THERMAL MAGNETIC BASED RELEASE FOR O/L,S/C PROTECTION, 1. SPRING CHARGE MOTOR 220V DC WITH SPRING CHARGE SWITCH 2. CLOSING COIL 220V DC 3. SHUNT COIL 220V DC 4. LIMIT SWITCH FOR TEST/ISOLATE/SERVICE POSITION 5. 4NO + 4NC POTENTIAL FREE CONTACT.	L&T/C&S/HAVELLS	630A, 20kA	01
2	CF1-7	HRC FUSE BASE	L&T/C&S/HAVELLS	20A	7
3	CF1-7	HRC FUSE LINK	L&T/C&S/HAVELLS	6A	7
4	MCB	DP MINIATURE CIRCUIT BREAKER, DC TYPE	L&T/C&S/HAVELLS	10A, DP	01
5	MCB	DP MINIATURE CIRCUIT BREAKER, DC TYPE	L&T/C&S/HAVELLS	6A, DP	01
6	MCB	SP MINIATURE CIRCUIT BREAKER, 'C' CURVE	L&T/C&S/HAVELLS	6A, SP	03
7	94, 52X	AUX. CONTACTOR RELAY, COIL VOLTAGE 220V DC WITH 2NO+2NC AUX. CONTACT	L&T/C&S/HAVELLS	2NO+2NC, 220V DC	02
8		2NO+2NC ADD ON BLOCK	L&T/C&S/HAVELLS	2NO+2NC	01
9	MCTs	CURRENT TRANSFORMER, RESIN CAST TYPE	NEWTEK/AE/PRECISE/ PROCOM/ASHMOR	600/1A, CL-1, 7.5VA	03
10	PCTs	CURRENT TRANSFORMER, RESIN CAST TYPE		600/1A, CL-5P15, 7.5VA	04
11	A	ANALOG AMMETER, SINGLE PHASE, SIZE-96X96 Sq. mm, CL-1.0, CTR-/1A	AE/RISHAB/NEWTEK/SECURE	0-600A	01
12	ASS	AMMETER SELECTOR SWITCH, ROTARY TYPE	SALZER/KAYCEE/TELERGON	6A	01
13	A/M	AUTO/MANUAL SELECTOR SWITCH WITH OFF, 6POLE 3WAY, ROTARY TYPE	SALZER/KAYCEE/TELERGON	6A	01
14	TNC	BREAKER CONTROL SWITCH, ROTARY TYPE	SALZER/KAYCEE/TELERGON	16A	01
15	86	HIGH SPEED TRIPPING RELAY (AUTO RESET)	L&T/JVS/C&S	NOMINAL VOLTAGE-220V DC	01
16	50 + 51	TRIPLE POLE INSTANTANEOUS OVER-CURRENT RELAY FOR PROVIDING POSITIVE SEQUENCE CURRENT PROTECTION IN ALL THE THREE PHASES. THE RELAY SETTING RANGE SHALL BE CONTINUOUSLY ADJUSTABLE BETWEEN 200-800% OR 400-1600% OF CT SECONDARY RATED CURRENT AS REQUIRED., AUX. SUPPLY 220V DC .	L&T/JVS/C&S	600/1A	01
17	50 + 51	DOUBLE POLE INVERSE DEFINITE MINIMUM TIME OVER CURRENT RELAYS CONNECTED IN R & B PHASES FOR OVER CURRENT PROTECTION OF MOTOR RATED 110 KW - 200 KW. THE RELAY SHALL HAVE AN ADJUSTABLE SETTING RANGE OF 50% - 200% OF CT SECONDARY CURRENT AND TIME SETTING RANGE OF 0-30 SECOND. THE RELAY SHALL BE CDGM-22 OF EE OR EQUIVALENT. AUX. SUPPLY 220V DC .	L&T/JVS/C&S	600/1A	01
18	50 + 51	SINGLE POLE ADJUSTABLE DEFINITE TIME DELAY RELAY FOR MOTOR OVERLOAD ALARM CONNECTED IN Y-PHASE ONLY. THE RELAY SHALL HAVE RESETING RATIO OF NOT LESS THAN 90%. THE RELAY SHALL HAVE CONTINUOUSLY ADJUSTABLE TIME DELAY RANGE OF 2.5 TO 25 SEC., AUX. SUPPLY 220V DC .	L&T/JVS/C&S	600/1A	01
19	50N + 51N	INSTANTANEOUS EARTH FAULT RELAY HAVING AN ADJUSTABLE SETTING RANGE OF 10-40% OR 20 - 80% OF CT SECONDARY CURRENT. THE EARTH FAULT RELAY SHALL BE PROVIDED WITH A STABILISING RESISTOR, AUX. SUPPLY 220V DC.	L&T/JVS/C&S	600/1A	01
20	h1	'ON' INDICATION LAMP, 22.5 Sq. mm. DIA ,LED TYPE, RED	ESBEE/VAISHNO/C&S	220V DC	01
21	h2	'OFF' INDICATION LAMP, 22.5 Sq. mm. DIA ,LED TYPE, GREEN	ESBEE/VAISHNO/C&S	220V DC	01
22	h3	'TRIP' INDICATION LAMP, 22.5 Sq. mm. DIA ,LED TYPE, AMBER	ESBEE/VAISHNO/C&S	220V DC	01
23	h5	'SPRING CHARGE' INDICATION LAMP, 22.5 Sq. mm. DIA ,LED TYPE, BLUE	ESBEE/VAISHNO/C&S	220V DC	01
24	Vt	AC VOLTAGE TRANSDUCER, SINGLE OUTPUT- 4-20mA, PT RATIO-415V, AUX. SUPPLY 220V DC	AE/RISHAB/SECURE	--	03
25	Ct	AC CURRENT TRANSDUCER, SINGLE OUTPUT- 4-20mA, CT RATIO-600/1A, AUX. SUPPLY 220V DC	AE/RISHAB/SECURE	--	03

NOTE:- ALL COMPONENTS SHALL BE POWER GRID (QA&I) APPROVED MAKE

	04.	-	DRAWN	MP	
	03.	-	CHKD.	VDP	
	02.	-	APPD.	--	
	01.	-	ALL DIMENSIONS IN mm.	SIGN.	
29.01.2025	00.	FIRST SUBMISSION FOR APPROVAL	TOLERANCE 5%		
DATE	No.	REVISIONS DESCRIPTION	REVISIONS : 00		

MANUFACTURER

ULTIMA SWITCHGEARS LTD.

UNIT-I KHASRA NO. 215, IND. AREA, VILLAGE RAIPUR (BHAGWANPUR),
TEHSIL - ROORKEE, DISTRICT HARIDWAR (UTTRAKHAND) -
247687, INDIA, TEL : 01332-235043 FAX : 01332-235042

UNIT-II F-6 & F-7, SITE-C, UPSIDC, SURAJPUR INDUSTRIAL AREA,
GREATER NOIDA - 201306 G. B. NAGAR (U.P.) INDIA

E-mail : info@ultimaswitchgear.com

DRAWING	BILL OF MATERIAL	JOB NO.
TITLE	415V MAIN SWITCH BOARD (1A) (MCRB)	1241A
CA NO.	CC/T/W-AIS/DOM/A10/23/01956/NOA-1/24-102643/01 & 02 DATED 23.02.2024	
PROJECT	765/400/220KV BIKANER-III POOLING STATION	
CLIENT	CONTRACTOR:-	
POWER GRID CORPORATION OF INDIA LIMITED	BHARAT HEAVY ELECTRICAL LIMITED (BHEL) TRANSMISSION PROJECTS DIVISION	
DRG. NO.	USL/PGCIL/BHEL/2024-2025/1241A-701	SH. NO. 03 OF 06

BILL OF MATERIAL FOR 415V MAIN SWITCH BOARD (1A) (MCRB)

S.NO.	ITEM CODE	DESCRIPTION	MAKE	RATING	QTY.
D	BILL OF MATERIAL FOR MODULE - (AE) BUS-COUPLER				INO
1	52C	TP ACB 415V, EDO, WITH OUT RELEASE , 1. SPRING CHARGE MOTOR 220V DC WITH SPRING CHARGE SWITCH 2. CLOSING RELEASE 220V DC 3. SHUNT RELEASE 220V DC 4. UNDER VOLTAGE RELEASE 415V AC 5. LIMIT SWITCH FOR TEST/ISOLATE/SERVICE POSITION 6. 4NO + 4NC POTENTIAL FREE CONTACT.	L&T/C&S/HAVELLS	1250A, 50kA	01
2	CF1-12	HRC FUSE BASE	L&T/C&S/HAVELLS	20A	12
3	CF1-12	HRC FUSE LINK	L&T/C&S/HAVELLS	6A	12
4	MCB	DP MINIATURE CIRCUIT BREAKER, DC TYPE	L&T/C&S/HAVELLS	10A	01
5	94, CO, 52CX, SX,	AUX. CONTACTOR RELAY, COIL VOLTAGE 220V DC WITH 2NO+2NC AUX. CONTACT	L&T/C&S/HAVELLS	--	04
6	T3X	AUX. CONTACTOR RELAY, COIL VOLTAGE 220V DC WITH 3NO+1NC AUX. CONTACT	L&T/C&S/HAVELLS	--	01
7	52CX	2NO+2NC ADD ON BLOCK	L&T/C&S/HAVELLS	--	01
8	MCT₁	CURRENT TRANSFORMER, RESIN CAST TYPE	NEWTEK/AE/PRECISE/PROCOM/AS HMOR	1250/1A, CL-1, 7.5VA	03
9	PCT₁	CURRENT TRANSFORMER, RESIN CAST TYPE	NEWTEK/AE/PRECISE/PROCOM/AS HMOR	1250/1A, CL-5P15, 7.5VA	04
10	A	ANALOG AMMETER, SINGLE PHASE, SIZE-96X96 Sq. mm, CL-1.0, CTR-/1A	AE/RISHAB/NEWTEK/SECURE	0-1250A	01
11	ASS	AMMETER SELECTOR SWITCH, ROTARY TYPE	SALZER/KAYCEE/TELERGON	6A	01
12	A/M/R	AUTO/MANUAL/REMOTE SELECTOR SWITCH WITH OFF, 3POLE 3WAY, ROTARY TYPE	SALZER/KAYCEE/TELERGON	6A	01
13	TNC	BREAKER CONTROL SWITCH, ROTARY TYPE	SALZER/KAYCEE/TELERGON	16A	01
14	86	HIGH SPEED TRIPPING RELAY (AUTO RESET)	L&T/JVS/C&S	NOMINAL VOLTAGE 220V DC	01
15	50 + 51	TRIPLE POLE INSTANTANEOUS OVER-CURRENT RELAY HAVING THE SETTING RANGE OF 200-800% OR 500-2000% OF CT SECONDARY AND ADJUSTABLE DEFINITE MINIMUM TIME, AUX. SUPPLY 220V DC .	L&T/JVS/C&S	-/1A	01
16	50N + 51N	INSTANTANEOUS EARTH FAULT RELAY HAVING AN ADJUSTABLE SETTING RANGE OF 10-40% OR 20 - 80% OF CT SECONDARY CURRENT AND ADJUSTABLE DEFINITE MINIMUM TIME. THE EARTH FAULT RELAY SHALL BE PROVIDED WITH A STABILISING RESISTOR, AUX. SUPPLY 220V DC.	L&T/JVS/C&S	-/1A	01
17	h1	'ON' INDICATION LAMP, 22.5 Sq. mm. DIA ,LED TYPE, RED	ESBEE/VAISHNO/C&S	220V DC	01
18	h2	'OFF' INDICATION LAMP, 22.5 Sq. mm. DIA ,LED TYPE, GREEN	ESBEE/VAISHNO/C&S	220V DC	01
19	h3	'TRIP' INDICATION LAMP, 22.5 Sq. mm. DIA ,LED TYPE, AMBER	ESBEE/VAISHNO/C&S	220V DC	01
20	h5	'SPRING CHARGE' INDICATION LAMP, 22.5 Sq. mm. DIA ,LED TYPE, BLUE	ESBEE/VAISHNO/C&S	220V DC	01
21	T3	ON DELAY TIMER WITH 1C/O AUXILIARY SWITCH, 0-60 SEC.	GIC/PGCIL APPROVED MAKE	220V DC	01
22	Vt	AC VOLTAGE TRANSDUCER, SINGLE OUTPUT- 4-20mA, PTR-415V AC, AUX. SUPPLY 220V DC	AE/RISHAB/SECURE	--	03
23	Ct	AC CURRENT TRANSDUCER, OUTPUT- 4-20mA, WITH SINGLE OUTPUT, AUX. SUPPLY 220V DC	AE/RISHAB/SECURE	1250/1A	03

NOTE:- ALL COMPONENTS SHALL BE POWER GRID (QA&I) APPROVED MAKE

	04.	-	DRAWN	MP	
	03.	-	CHKD.	VDP	
	02.	-	APPD.	--	
	01.	-	ALL DIMENSIONS IN mm.	SIGN.	
29.01.2025	00.	FIRST SUBMISSION FOR APPROVAL	TOLERANCE 5%		
DATE	No.	REVISIONS DESCRIPTION	REVISIONS : 00		

MANUFACTURER

ULTIMA SWITCHGEARS LTD.

UNIT-I KHASRA NO. 215, IND. AREA, VILLAGE RAIPUR (BHAGWANPUR),
TEHSIL - ROORKEE, DISTRICT HARIDWAR (UTTRAKHAND) -
247687, INDIA, TEL : 01332-235043 FAX : 01332-235042
UNIT-II F-6 & F-7, SITE-C, UPSIDC, SURAJPUR INDUSTRIAL AREA,
GREATER NOIDA - 201306 G. B. NAGAR (U.P.) INDIA
E-mail : info@ultimaswitchgear.com

DRAWING	BILL OF MATERIAL	JOB NO.
TITLE	415V MAIN SWITCH BOARD (1A) (MCRB)	1241A
CA NO.	CC/T/W-AIS/DOA/A10/23/01956/NOA-1/24-102643/01 & 02 DATED 23.02.2024	
PROJECT	765/400/220KV BIKANER-III POOLING STATION	
CLIENT	POWER GRID CORPORATION OF INDIA LIMITED	CONTRACTOR:- BHARAT HEAVY ELECTRICAL LIMITED (BHEL) TRANSMISSION PROJECTS DIVISION
DRG. NO.	USL/PGCIL/BHEL/2024-2025/1241A-701	SH. NO. 04 OF 06

TB202359-1002269-SS3480-LTSWR-DRG/00/CAT-I/Page: 18 of 258

NOTE:- ALL COMPONENTS SHALL BE POWER GRID (QA&I) APPROVED MAKE

MANUFACTURER
 **ULTIMA® SWITCHGEARS LTD.**
 UNIT-I KHASRA NO. 215, IND. AREA, VILLAGE RAIPUR (BHAGWANPUR TEHSIL - ROORKEE, DISTRICT HARIDWAR (UTTRAKHAND) - 247867, INDIA, TEL : 01332-235043 FAX : 01332-235042
 UNIT-II F-6 & F-7, SITE-C, UPSIDC, SURAJPUR INDUSTRIAL AREA, GREATER NOIDA - 201306 G. B. NAGAR (U.P.) INDIA
 E-mail : info@ultimaswitchgear.com

DRAWING	BILL OF MATERIAL	JOB NO. 1241A
TITLE	415V MAIN SWITCH BOARD (1A) (MCRB)	
CA NO.	CC/T/W-AIS/DOM/A10/23/01956/NOA-1/24-102643/01 & 02 DATED 23.02.2024	
PROJECT	765/400/220KV BIKANER-III POOLING STATION	
 CLIENT POWER GRID CORPORATION OF INDIA LIMITED	 CONTRACTOR:- BHARAT HEAVY ELECTRICAL LIMITED (BHEL) TRANSMISSION PROJECTS DIVISION	
DRG. NO.	USL/PGCIL/BHEL/2024-2025/1241A-701	SH. NO. 05 OF 06

BILL OF MATERIAL FOR 415V MAIN SWITCH BOARD (1A) (MCRB)

S.NO.	ITEM CODE	DESCRIPTION	MAKE	RATING	QTY.
G	BILL OF MATERIAL FOR MODULE - (AE) FOR ACB OUTGOINGS				2NOs
1	52	TP ACB, EDO, WITH TM BASED RELEASE FOR O/L,S/C PROTECTION, 1. SPRING CHARGE MOTOR 220V DC WITH SPRING CHARGE SWITCH 2. CLOSING COIL 220V DC 3. SHUNT COIL 220V DC 4. LIMIT SWITCH FOR TRIP POSITION 5. 4NO + 4NC POTENTIAL FREE CONTACT.	L&T/C&S/HAVELLS	800A, 50kA	01
2	TNC	BREAKER CONTROL SWITCH, ROTARY TYPE	SALZER/KAYCEE/TELERGON	16A	01
3	MCB	DP MINIATURE CIRCUIT BREAKER, DC TYPE	L&T/C&S/HAVELLS	10A, DP	01
4	h1	'ON' INDICATION LAMP, 22.5 Sq. mm. DIA ,LED TYPE, RED	ESBEE/VAISHNO/C&S	220V DC	01
5	h2	'OFF' INDICATION LAMP, 22.5 Sq. mm. DIA ,LED TYPE, GREEN	ESBEE/VAISHNO/C&S	220V DC	01
6	h3	'TRIP' INDICATION LAMP, 22.5 Sq. mm. DIA ,LED TYPE, AMBER	ESBEE/VAISHNO/C&S	220V DC	01
7	h5	'SPRING CHARGE' INDICATION LAMP, 22.5 Sq. mm. DIA ,LED TYPE, BLUE	ESBEE/VAISHNO/C&S	220V DC	01
8	h7	ILLUMINATION PUSH BUITTON, 22.5 Sq. mm. DIA ,LED TYPE, WHITE	ESBEE/VAISHNO/C&S	220V DC	01

NOTE:- ALL COMPONENTS SHALL BE POWER GRID (QA&I) APPROVED MAKE

	04.	—	DRAWN	MP	
	03.	—	CHKD.	VDP	
	02.	—	APPD.	—	
	01.		ALL DIMENSIONS IN mm.	SIGN.	
29.01.2025	00.	FIRST SUBMISSION FOR APPROVAL	TOLERANCE 5%		
DATE	No.	REVISIONS DESCRIPTION	REVISIONS : 00		

MANUFACTURER

 **ULTIMA[®] SWITCHGEARS LTD.**

UNIT-I KHASRA NO. 215, IND. AREA, VILLAGE RAIPUR (BHAGWANPUR),
TEHSIL - ROORKEE, DISTRICT HARIDWAR (UTTRAKHAND) -
247667, INDIA, TEL : 01332-235043 FAX : 01332-235042

UNIT-II F-6 & F-7, SITE-C, UPSIDC, SURAJPUR INDUSTRIAL AREA,
GREATER NOIDA - 201306 G. B. NAGAR (U.P.) INDIA

E-mail : info@ultimaswitchgear.com

DRAWING	BILL OF MATERIAL	JOB NO.
TITLE	415V MAIN SWITCH BOARD (1A) (MCRB)	1241A
CA NO.	CC/T/W-AIS/DOM/A10/23/01956/NOA-1/24-102643/01 & 02 DATED 23.02.2024	
PROJECT	765/400/220KV BIKANER-III POOLING STATION	
CLIENT	CONTRACTOR:-	
 POWER GRID CORPORATION OF INDIA LIMITED	 BHARAT HEAVY ELECTRICAL LIMITED (BHEL) TRANSMISSION PROJECTS DIVISION	
DRG. NO.	USL/PGCIL/BHEL/2024-2025/1241A-701	SH. NO. 06 OF 06

1 2 3 4 5 6 7 8 9

This Drawing & information or descriptive matter set out hereon are the confidential property of **ULTIMA SWITCHGEARS LIMITED** & must not be disclosed, copied, loaned or used for manufacturing, tendering or for any other purpose without their permission.

[Handwritten Signature]

ENGINEERING DRAWING DETAILS FOR
415V AC DISTRIBUTION BOARD (2A) (MCRB)

PROJECT :- 765/400/220kV BIKANER-III POOLING STATION
CLIENT :- POWER GRID CORPORATION OF INDIA LIMITED
CONTRACTOR :- BHARAT HEAVY ELECTRICAL LIMITED (BHEL)
TRANSMISSION PROJECTS DIVISION

	04.	-	DRAWN	MP	
	03.	-	CHKD.	VDP	
	02.	-	APPD.	--	
	01.		ALL DIMENSIONS IN mm.		SIGN.
29.01.2025	00.	FIRST SUBMISSION FOR APPROVAL	TOLERANCE	5%	
DATE	No.	REVISIONS DESCRIPTION	REVISIONS	: 00	


ULTIMA[®] SWITCHGEARS LTD.

MANUFACTURER

UNIT-I KHASRA NO. 215, IND. AREA, VILLAGE RAIPUR (BHAGWANPUR),
TEHSIL - ROORKEE, DISTRICT HARIDWAR (UTTRAKHAND) -
247667, INDIA, TEL : 01332-235043 FAX : 01332-235042
UNIT-II F-6 & F-7, SITE-C, UPSIDC, SURAJPUR INDUSTRIAL AREA,
GREATER NOIDA - 201306 G. B. NAGAR (U.P.) INDIA
E-mail : info@ultimaswitchgear.com

DRAWING	COVER PAGE	JOB NO.
TITLE	415V AC DISTRIBUTION BOARD (2A) (MCRB)	1241A
CA NO.	CC/T/W-AIS/DOM/A10/23/01956/NOA-1/24-102643/01 & 02 DATED 23.02.2024	
PROJECT	765/400/220KV BIKANER-III POOLING STATION	
CLIENT POWER GRID CORPORATION OF INDIA LIMITED		CONTRACTOR:- BHARAT HEAVY ELECTRICAL LIMITED (BHEL) TRANSMISSION PROJECTS DIVISION
DRG. NO.	USL/PGCIL/BHEL/2024-2025/1241A-002	SH. NO. 01 OF 01

Handwritten signature

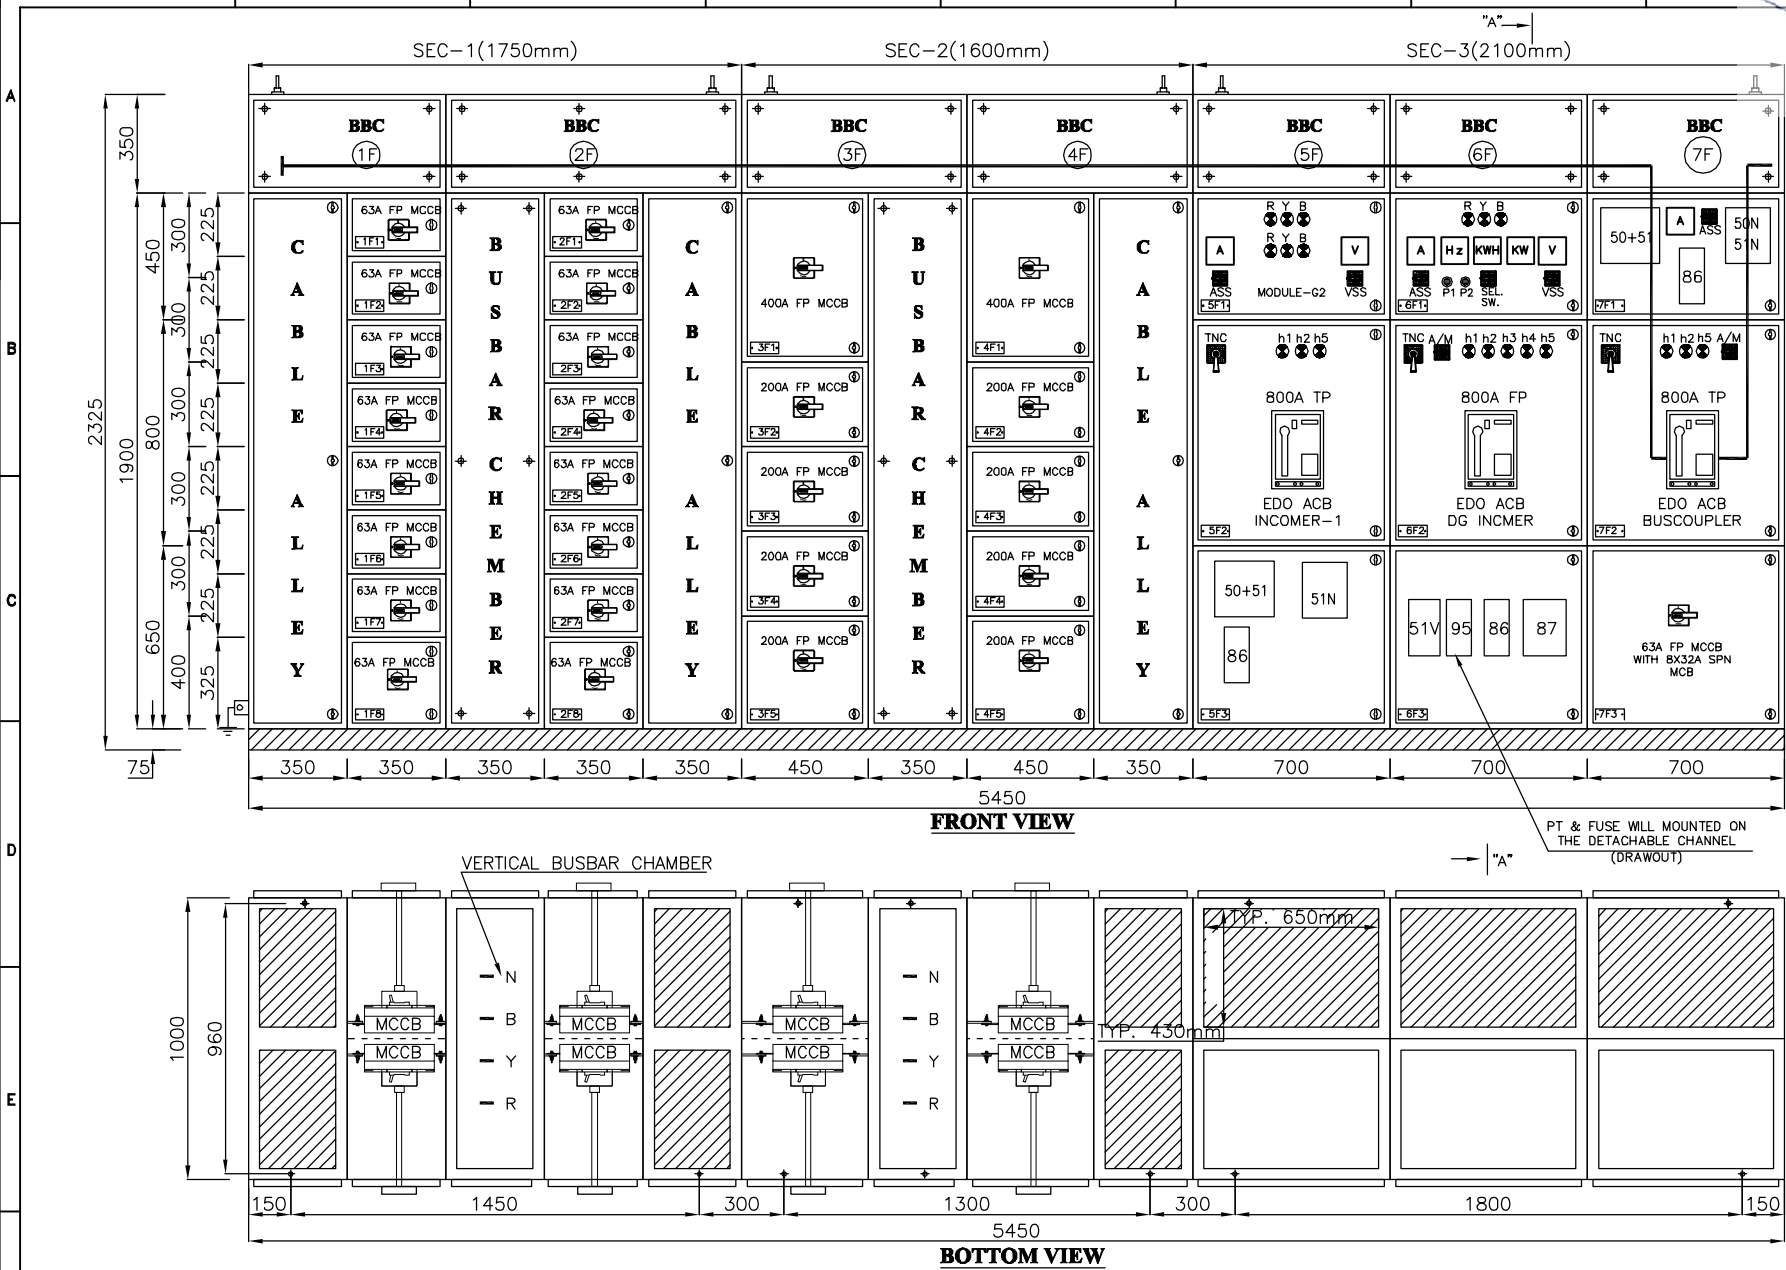

F		04.	—		DRAWN	MP		 ULTIMA[®] SWITCHGEARS LTD. UNIT-I KHASRA NO. 215, IND. AREA, VILLAGE RAIPUR (BHAGWANPUR), TEHSIL - ROORKEE, DISTRICT HARIDWAR (UTTRAKHAND) - 247667, INDIA, TEL : 01332-235043 FAX : 01332-235042 UNIT-II F-6 & F-7, SITE-C, UPSIDC, SURAJPUR INDUSTRIAL AREA, GREATER NOIDA - 201306 G. B. NAGAR (U.P.) INDIA E-mail : info@ultimaswitchgear.com	DRAWING	GENERAL ARRANGEMENT DRAWING		JOB NO.					
		03.	—		CHKD.	VDP			TITLE	415V AC DISTRIBUTION BOARD (2A) (MCRB)		1241A					
		02.	—		APPD.	--			CA NO.	CC/T/W-AIS/DOM/A10/23/01956/NOA-1/24-102643/01 & 02 DATED 23.02.2024							
		01.			ALL DIMENSIONS IN mm.		SIGN.		PROJECT	765/400/220kV BIKANER-III POOLING STATION							
	29.01.2025	00.	FIRST SUBMISSION FOR APPROVAL		TOLERANCE 5%				 CLIENT POWER GRID CORPORATION OF INDIA LIMITED	 CONTRACTOR:- BHARAT HEAVY ELECTRICAL LIMITED (BHEL) TRANSMISSION PROJECTS DIVISION							
	DATE	No.	REVISIONS DESCRIPTION		REVISIONS : 00						DRG. NO.	USL/PGCIL/BHEL/2024-2025/1241A-102		SH. NO. 01 OF 05			
		1		2		3			4		5		6		7		8



ULTIMA SWITCHGEARS LTD.

UNIT-I KHASRA NO. 215, IND. AREA, VILLAGE RAIPUR (BHAGWANPUR), TEHSIL - ROORKEE, DISTRICT HARIDWAR (UTTRAKHAND) - 247687, INDIA, TEL : 01332-235043 FAX : 01332-235042

UNIT-II F-6 & F-7, SITE-C, UPSIDC, SURAJPUR INDUSTRIAL AREA, GREATER NOIDA - 201306 G. B. NAGAR (U.P.) INDIA

E-mail : info@ultimaswitchgear.com

This Drawing & information or descriptive matter set out hereon are the confidential property of **ULTIMA SWITCHGEARS LIMITED** & must not be disclosed, copied,loaned or used for manufacturing,tendering or for any other purpose without their permission.

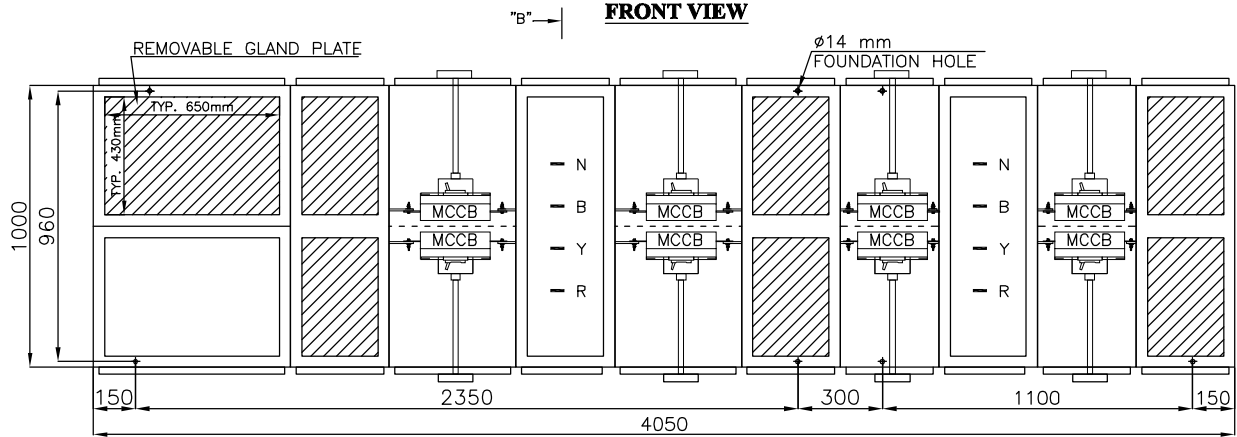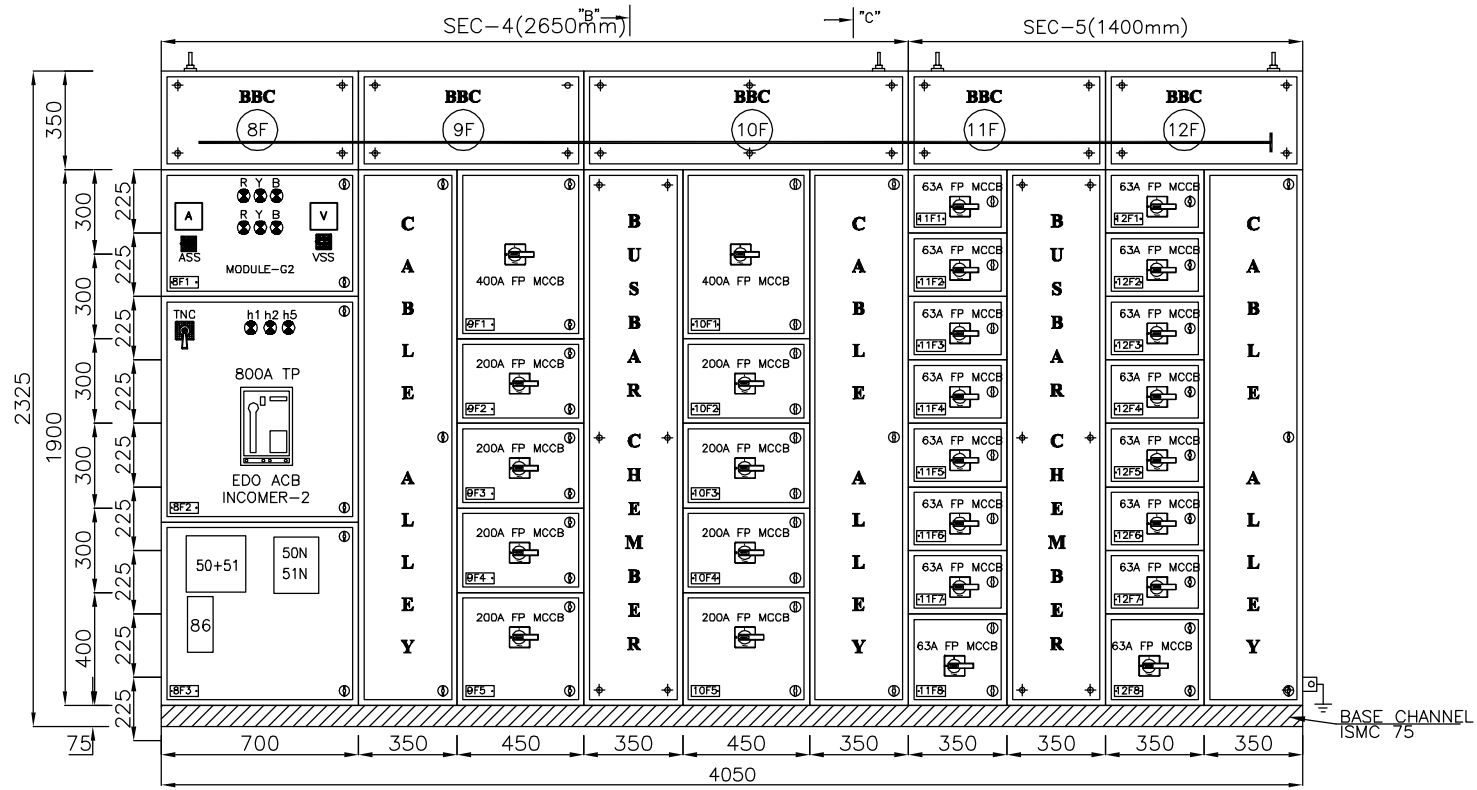


F	04.	—	DRAWN	MP	
	03.	—	CHKD.	VDP	
	02.	—	APPD.	—	
	01.	—	ALL DIMENSIONS IN mm. SIGN.		
	29.01.2025	00.	FIRST SUBMISSION FOR APPROVAL		
	DATE	No.	REVISIONS DESCRIPTION		
			REVISIONS : 00		

MANUFACTURER

ULTIMA SWITCHGEARS LTD.
UNIT-I KHASRA NO. 215, IND. AREA, VILLAGE RAIPUR (BHAGWANPUR),
TEHSIL - ROORKEE, DISTRICT HARIDWAR (UTTRAKHAND) -
247687, INDIA, TEL : 01332-235043 FAX : 01332-235042
UNIT-II F-6 & F-7, SITE-C, UPSIDC, SURAJPUR INDUSTRIAL AREA,
GREATER NOIDA - 201306 G. B. NAGAR (U.P.) INDIA
E-mail : info@ultimaswitchgear.com

DRAWING	GENERAL ARRANGEMENT DRAWING		JOB NO.
TITLE	415V AC DISTRIBUTION BOARD (2A) (MCRB)		1241A
CA NO.	CC/T/W-AIS/DOM/A10/23/01956/NOA-1/24-102643/01 & 02 DATED 23.02.2024		
PROJECT	765/400/220KV BIKANER-III POOLING STATION		
	CLIENT		 CONTRACTOR:- BHARAT HEAVY ELECTRICAL LIMITED (BHEL) TRANSMISSION PROJECTS DIVISION
	POWER GRID CORPORATION OF INDIA LIMITED		
DRG. NO.	USL/PGCIL/BHEL/2024-2025/1241A-102		SH. NO. 02 OF 05

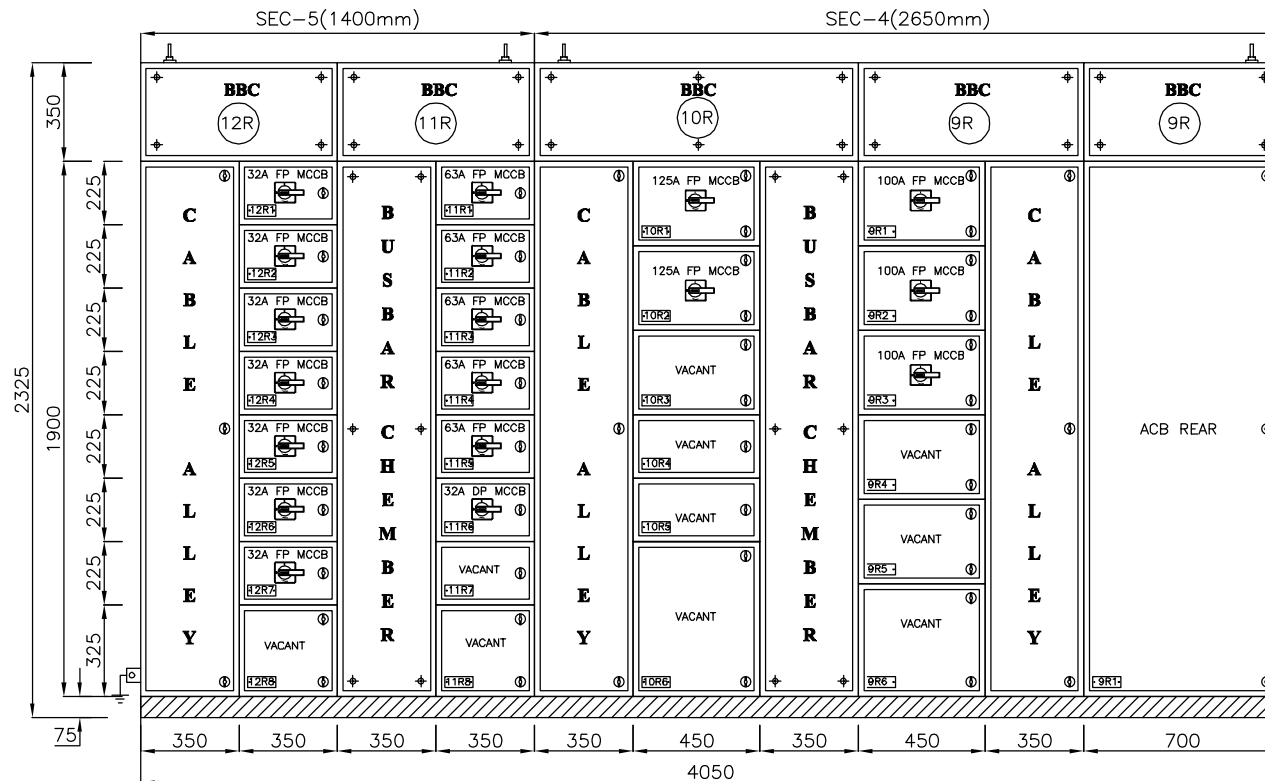**LEGEND DETAILS**

R	= 'R' PHASE
Y	= 'Y' PHASE
B	= 'B' PHASE
h1	= ACB/MCCB OFF INDICATION GREEN
h2	= ACB/MCCB ON INDICATION RED
h3	= ACB TRIP INDICATION AMBER
h5	= ACB SPRING CHARGE INDICATION BLUE
V	= ANALOG VOLTMETER
A	= ANALOG AMMETER
Hz	= FREQUENCY METER
KW	= KILOWATT METER
KWH	= KILOWATT HOUR METER
P1	= MCCB OFF PUSH BUTTON (RED)
P2	= MCCB ON PUSH BUTTON (GREEN)
87	= DIFFERENTIAL PROTECTION RELAY
51V	= VOLTAGE CONTROLLED DEFINITE DELAY RELAY
95	= SINGLE POLE DEFINITE TIME OVER CURRENT RELAY
VMR	= VOLTAGE MONITORING RELAY
86	= MASTER TRIP RELAY (HAND RESET)
VSS	= VOLTMETER SELECTOR SWITCH
ASS	= AMMETER SELECTOR SWITCH
A/M	= AUTO/MANUAL SELECTOR SWITCH

PANEL DIMENSIONS

HEIGHT : 2325 mm.
 WIDTH : 9500 mm. (5450+4050)
 DEPTH : 1000 mm.

HORIZONTAL MAIN BUS BAR SIZE

PHASE : 1x80X10/Sq. mm AL.
 NEUTRAL : 1x80X06/Sq. mm AL.
 EARTH : 1X50X06/Sq. mm AL.

VERTICAL MAIN BUS BAR SIZE FOR BAY#1&2 , BAY#3&4, BAY#9&10 AND BAY#11&12

PHASE : 1X80X10/SQ. MM AL.
 NEUTRAL : 1X80X06 SQ. MM AL.


MANUFACTURER**ULTIMA SWITCHGEARS LTD.**

UNIT-I KHASRA NO. 215, IND. AREA, VILLAGE RAIPUR (BHAGWANPUR),
 TEHSIL - ROORKEE, DISTRICT HARIDWAR (UTTRAKHAND) -
 247667, INDIA, TEL : 01332-235043 FAX : 01332-235042
 UNIT-II F-6 & F-7, SITE-C, UPSIDC, SURAJPUR INDUSTRIAL AREA,
 GREATER NOIDA - 201306 G. B. NAGAR (U.P.) INDIA
 E-mail : info@ultimaswitchgear.com

DRAWING	GENERAL ARRANGEMENT DRAWING	JOB NO.
TITLE	415V AC DISTRIBUTION BOARD (2A) (MCRB)	1241A
CA NO.	CC/T/W-AIS/DOM/A10/23/01956/NOA-1/24-102643/01 & 02 DATED 23.02.2024	
PROJECT	765/400/220KV BIKANER-III POOLING STATION	
CLIENT	POWER GRID CORPORATION OF INDIA LIMITED	CONTRACTOR:- BHARAT HEAVY ELECTRICAL LIMITED (BHEL) TRANSMISSION PROJECTS DIVISION
DRG. NO.	USL/PGCIL/BHEL/2024-2025/1241A-102	SH. NO. 03 OF 05

04.	-	DRAWN	MP	
03.	-	CHKD.	VDP	
02.	-	APPD.	--	
01.	-	ALL DIMENSIONS IN mm. SIGN.		
29.01.2025	00.	FIRST SUBMISSION FOR APPROVAL	TOLERANCE 5%	
DATE	No.	REVISIONS DESCRIPTION	REVISIONS : 00	

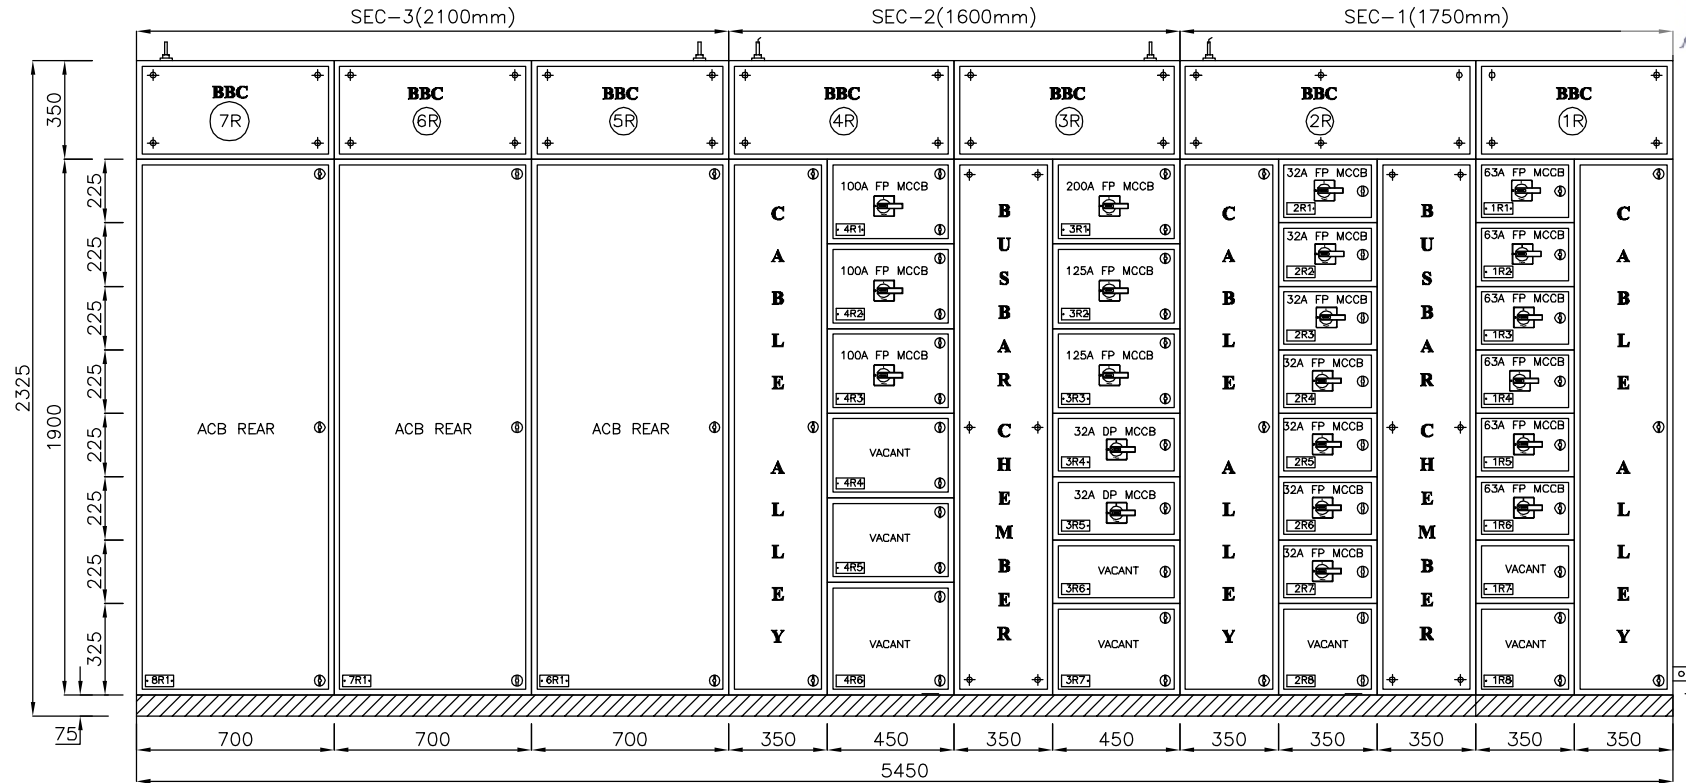

**REAR VIEW**

04.	—	DRAWN	MP	
03.	—	CHKD.	VDP	
02.	—	APPD.	—	
01.	—	ALL DIMENSIONS IN mm.	SIGN.	
29.01.2025	00.	FIRST SUBMISSION FOR APPROVAL	TOLERANCE 5%	
DATE	No.	REVISIONS DESCRIPTION	REVISIONS : 00	

MANUFACTURER

ULTIMA SWITCHGEARS LTD.


UNIT-I KHASRA NO. 215, IND. AREA, VILLAGE RAIPUR (BHAGWANPUR), TEHSIL - ROORKEE, DISTRICT HARIDWAR (UTTRAKHAND) - 247687, INDIA, TEL : 01332-235043 FAX : 01332-235042

UNIT-II F-6 & F-7, SITE-C, UPSIDC, SURAJPUR INDUSTRIAL AREA, GREATER NOIDA - 201306 G. B. NAGAR (U.P.) INDIA


E-mail : info@ultimaswitchgear.com

DRAWING	GENERAL ARRANGEMENT DRAWING	JOB NO.
TITLE	415V AC DISTRIBUTION BOARD (2A) (MCRB)	1241A
CA NO.	CC/T/W-AIS/DOM/A10/23/01956/NOA-1/24-102643/01 & 02 DATED 23.02.2024	
PROJECT	765/400/220KV BIKANER-III POOLING STATION	
CLIENT	POWER GRID CORPORATION OF INDIA LIMITED	CONTRACTOR:-
		BHARAT HEAVY ELECTRICAL LIMITED (BHEL) TRANSMISSION PROJECTS DIVISION
DRG. NO.	USL/PGCIL/BHEL/2024-2025/1241A-102	SH. NO. 04 OF 05


This Drawing & information or descriptive matter set out hereon are the confidential property of **ULTIMA SWITCHGEARS LIMITED** & must not be disclosed, copied,loaned or used for manufacturing,tendering or for any other purpose without their permission.

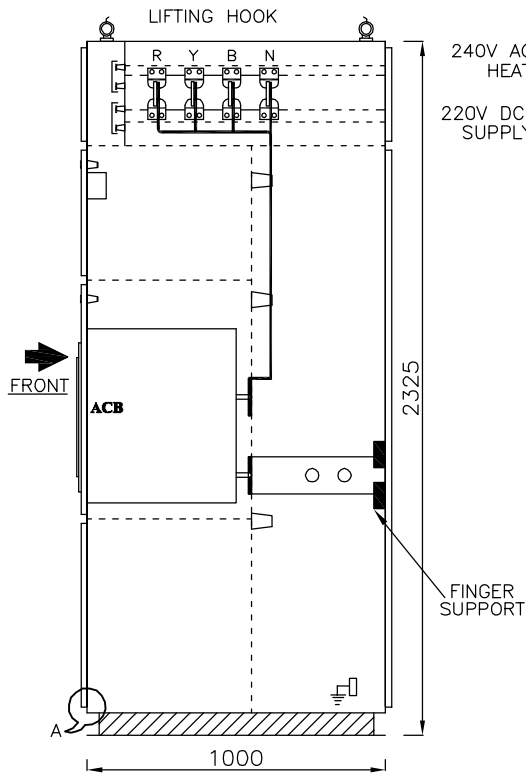


SECTIONAL VIEW
AT "A"-"A"

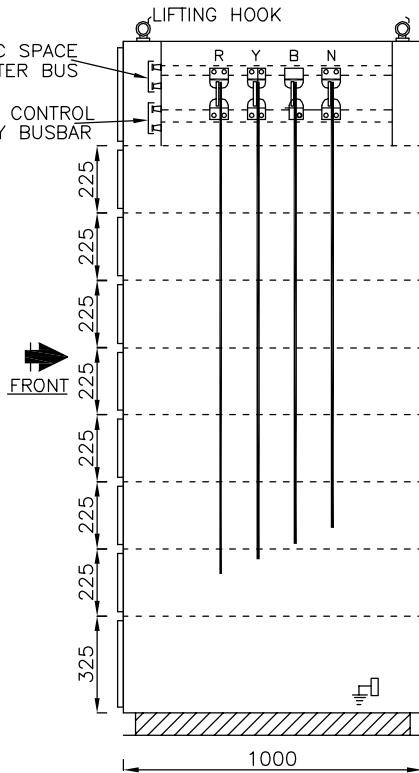




SECTIONAL VIEW
AT "B"-"B"

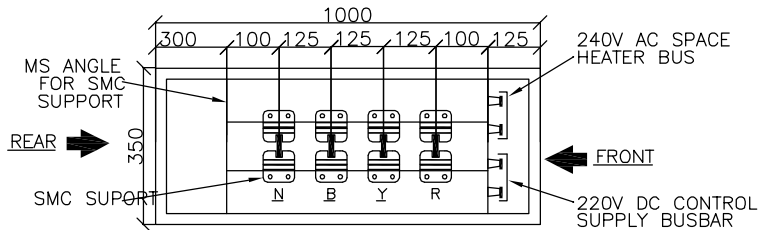

SECTIONAL VIEW AT "C"-"C"
FOR HORIZONTAL BUSBAR
TOLERANCE AS PER IS

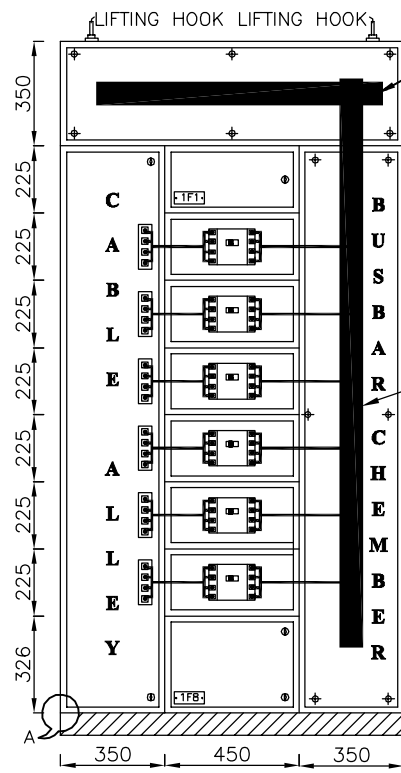

TYP. DETAIL OF PANEL NO-1
(FRONT VIEW W/O DOOR & COVER)

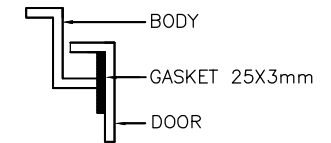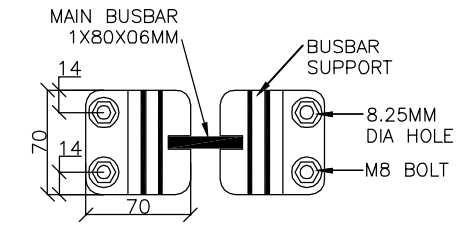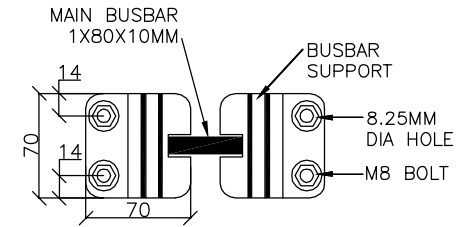

DETAIL-"A"

04.	—	DRAWN	MP	
03.	—	CHKD.	VDP	
02.	—	APPD.	—	
01.	—	ALL DIMENSIONS IN mm.	SIGN.	
29.01.2025	00.	FIRST SUBMISSION FOR APPROVAL	TOLERANCE 5%	
DATE	No.	REVISIONS DESCRIPTION	REVISIONS : 00	

MANUFACTURER

ULTIMA SWITCHGEARS LTD.


UNIT-I KHASRA NO. 215, IND. AREA, VILLAGE RAIPUR (BHAGWANPUR), TEHSIL - ROORKEE, DISTRICT HARIDWAR (UTTRAKHAND) - 247667, INDIA, TEL : 01332-235043 FAX : 01332-235042


UNIT-II F-6 & F-7, SITE-C, UPSIDC, SURAJPUR INDUSTRIAL AREA, GREATER NOIDA - 201306 G. B. NAGAR (U.P.) INDIA


E-mail : info@ultimaswitchgear.com

DRAWING	GENERAL ARRANGEMENT DRAWING	JOB NO.	1241A
TITLE	415V AC DISTRIBUTION BOARD (2A) (MCRB)	CA NO.	CC/T/W-AIS/DOM/A10/23/01956/NOA-1/24-102643/01 & 02 DATED 23.02.2024
PROJECT	765/400/220KV BIKANER-III POOLING STATION	CLIENT	POWER GRID CORPORATION OF INDIA LIMITED
		CONTRACTOR:-	BHARAT HEAVY ELECTRICAL LIMITED (BHEL) TRANSMISSION PROJECTS DIVISION
DRG. NO.	USL/PGCIL/BHEL/2024-2025/1241A-102	SH. NO.	05 OF 05

This Drawing & information or descriptive matter set out hereon are the confidential property of **ULTIMA SWITCHGEARS LIMITED** & must not be disclosed, copied,loaned or used for manufacturing,tendering or for any other purpose without their permission.

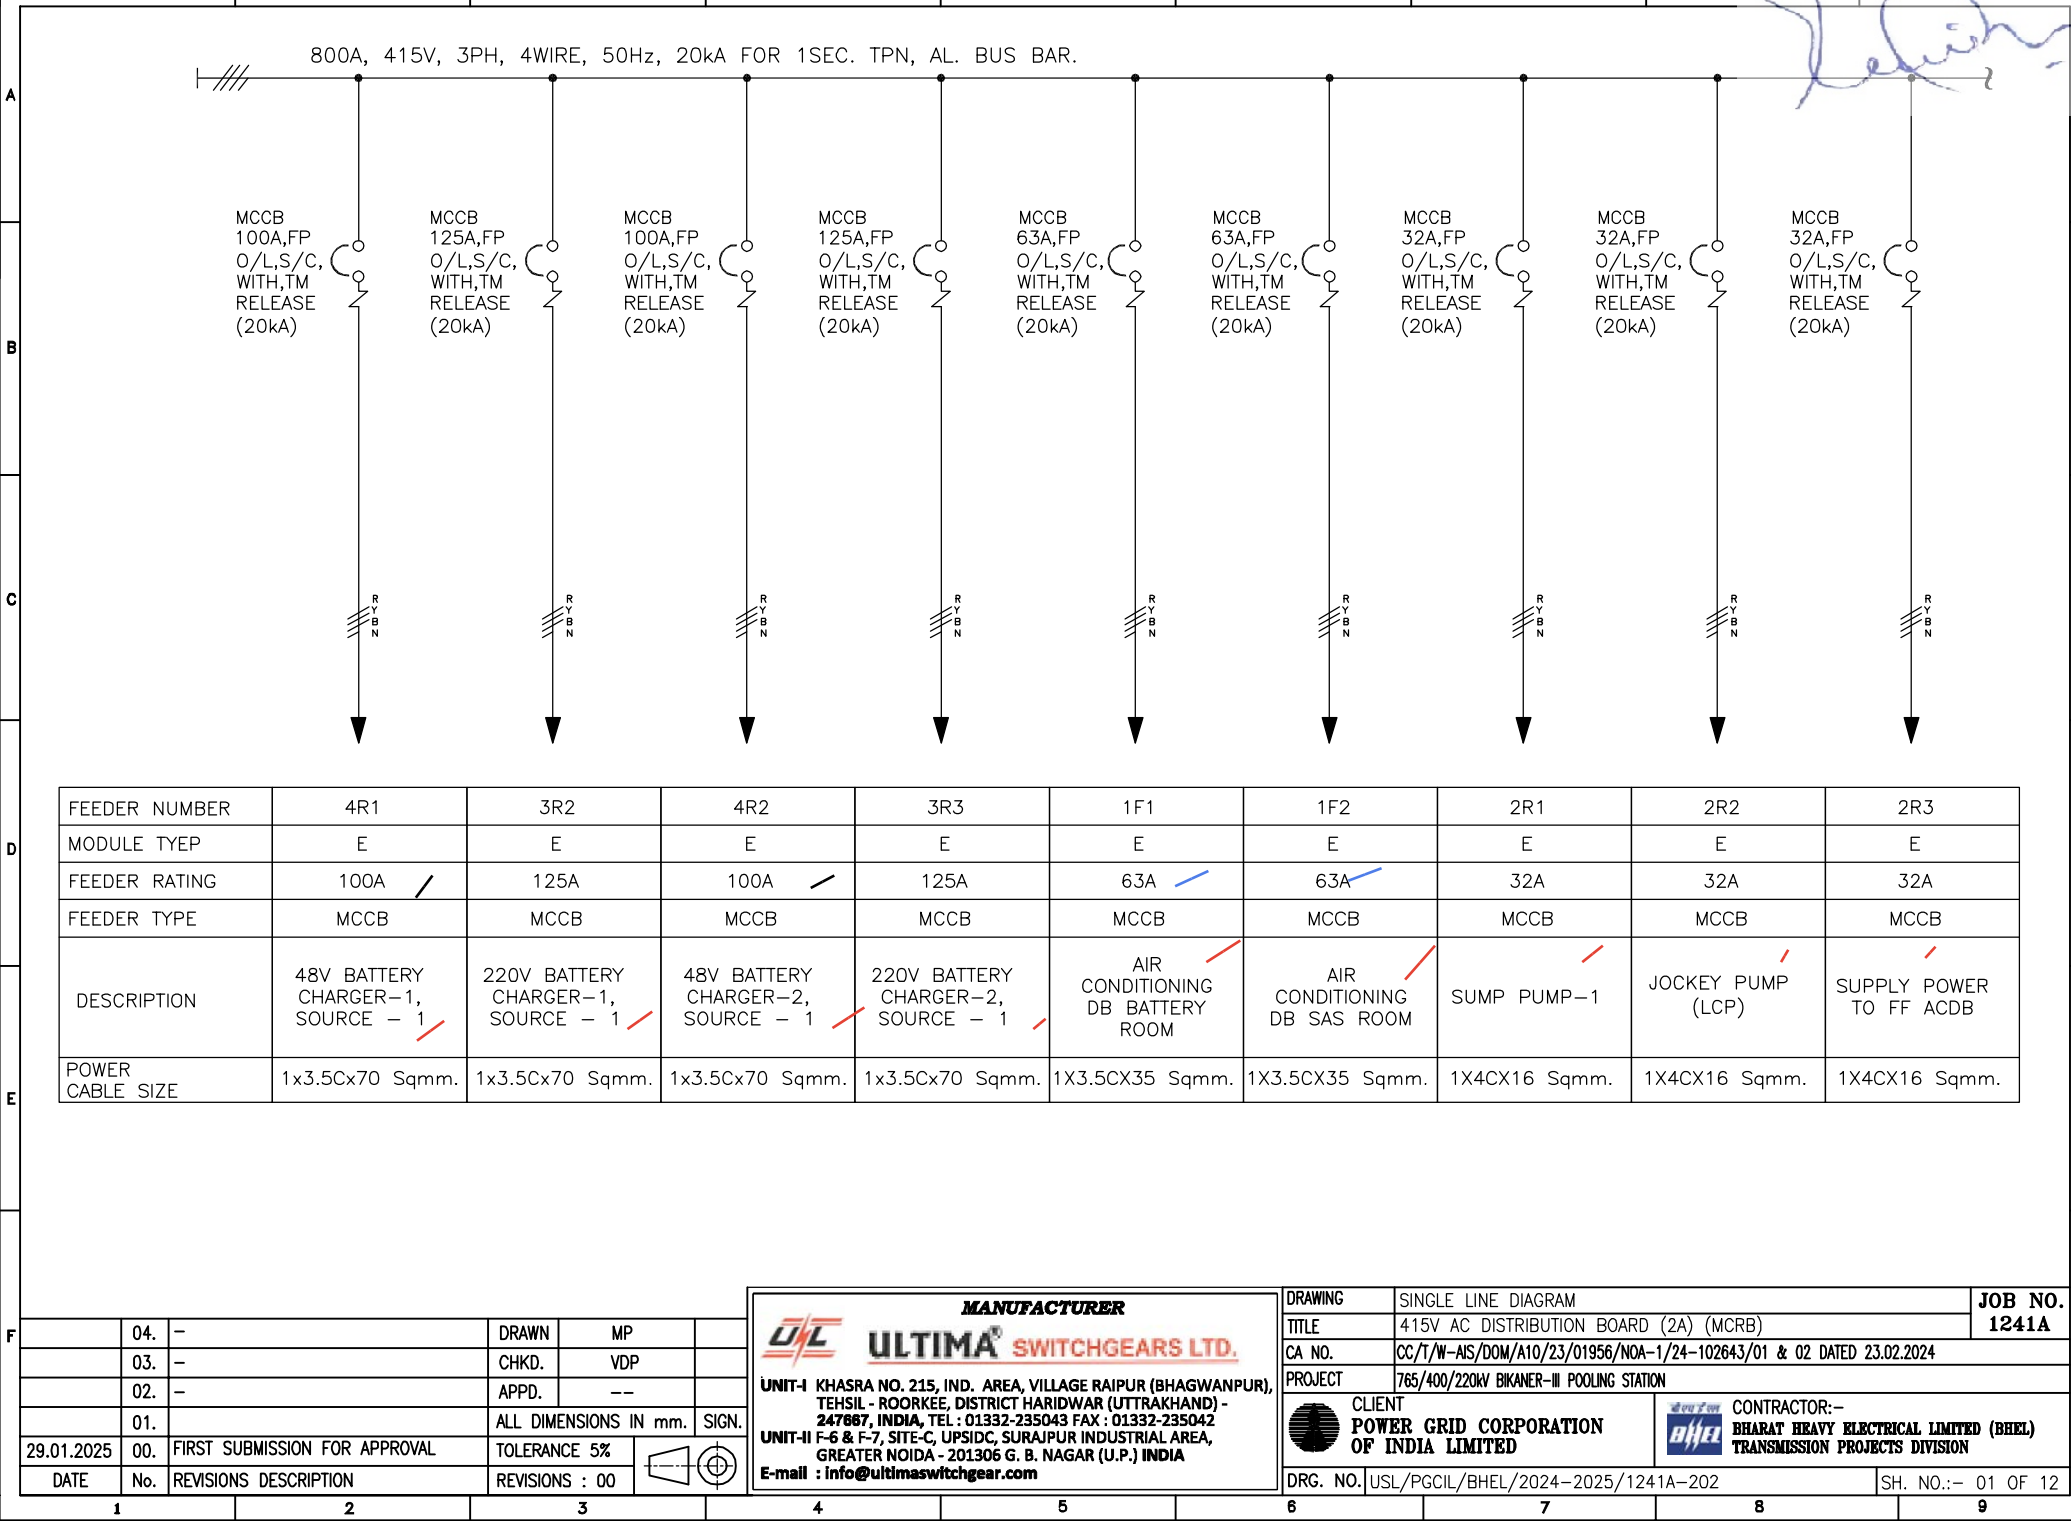


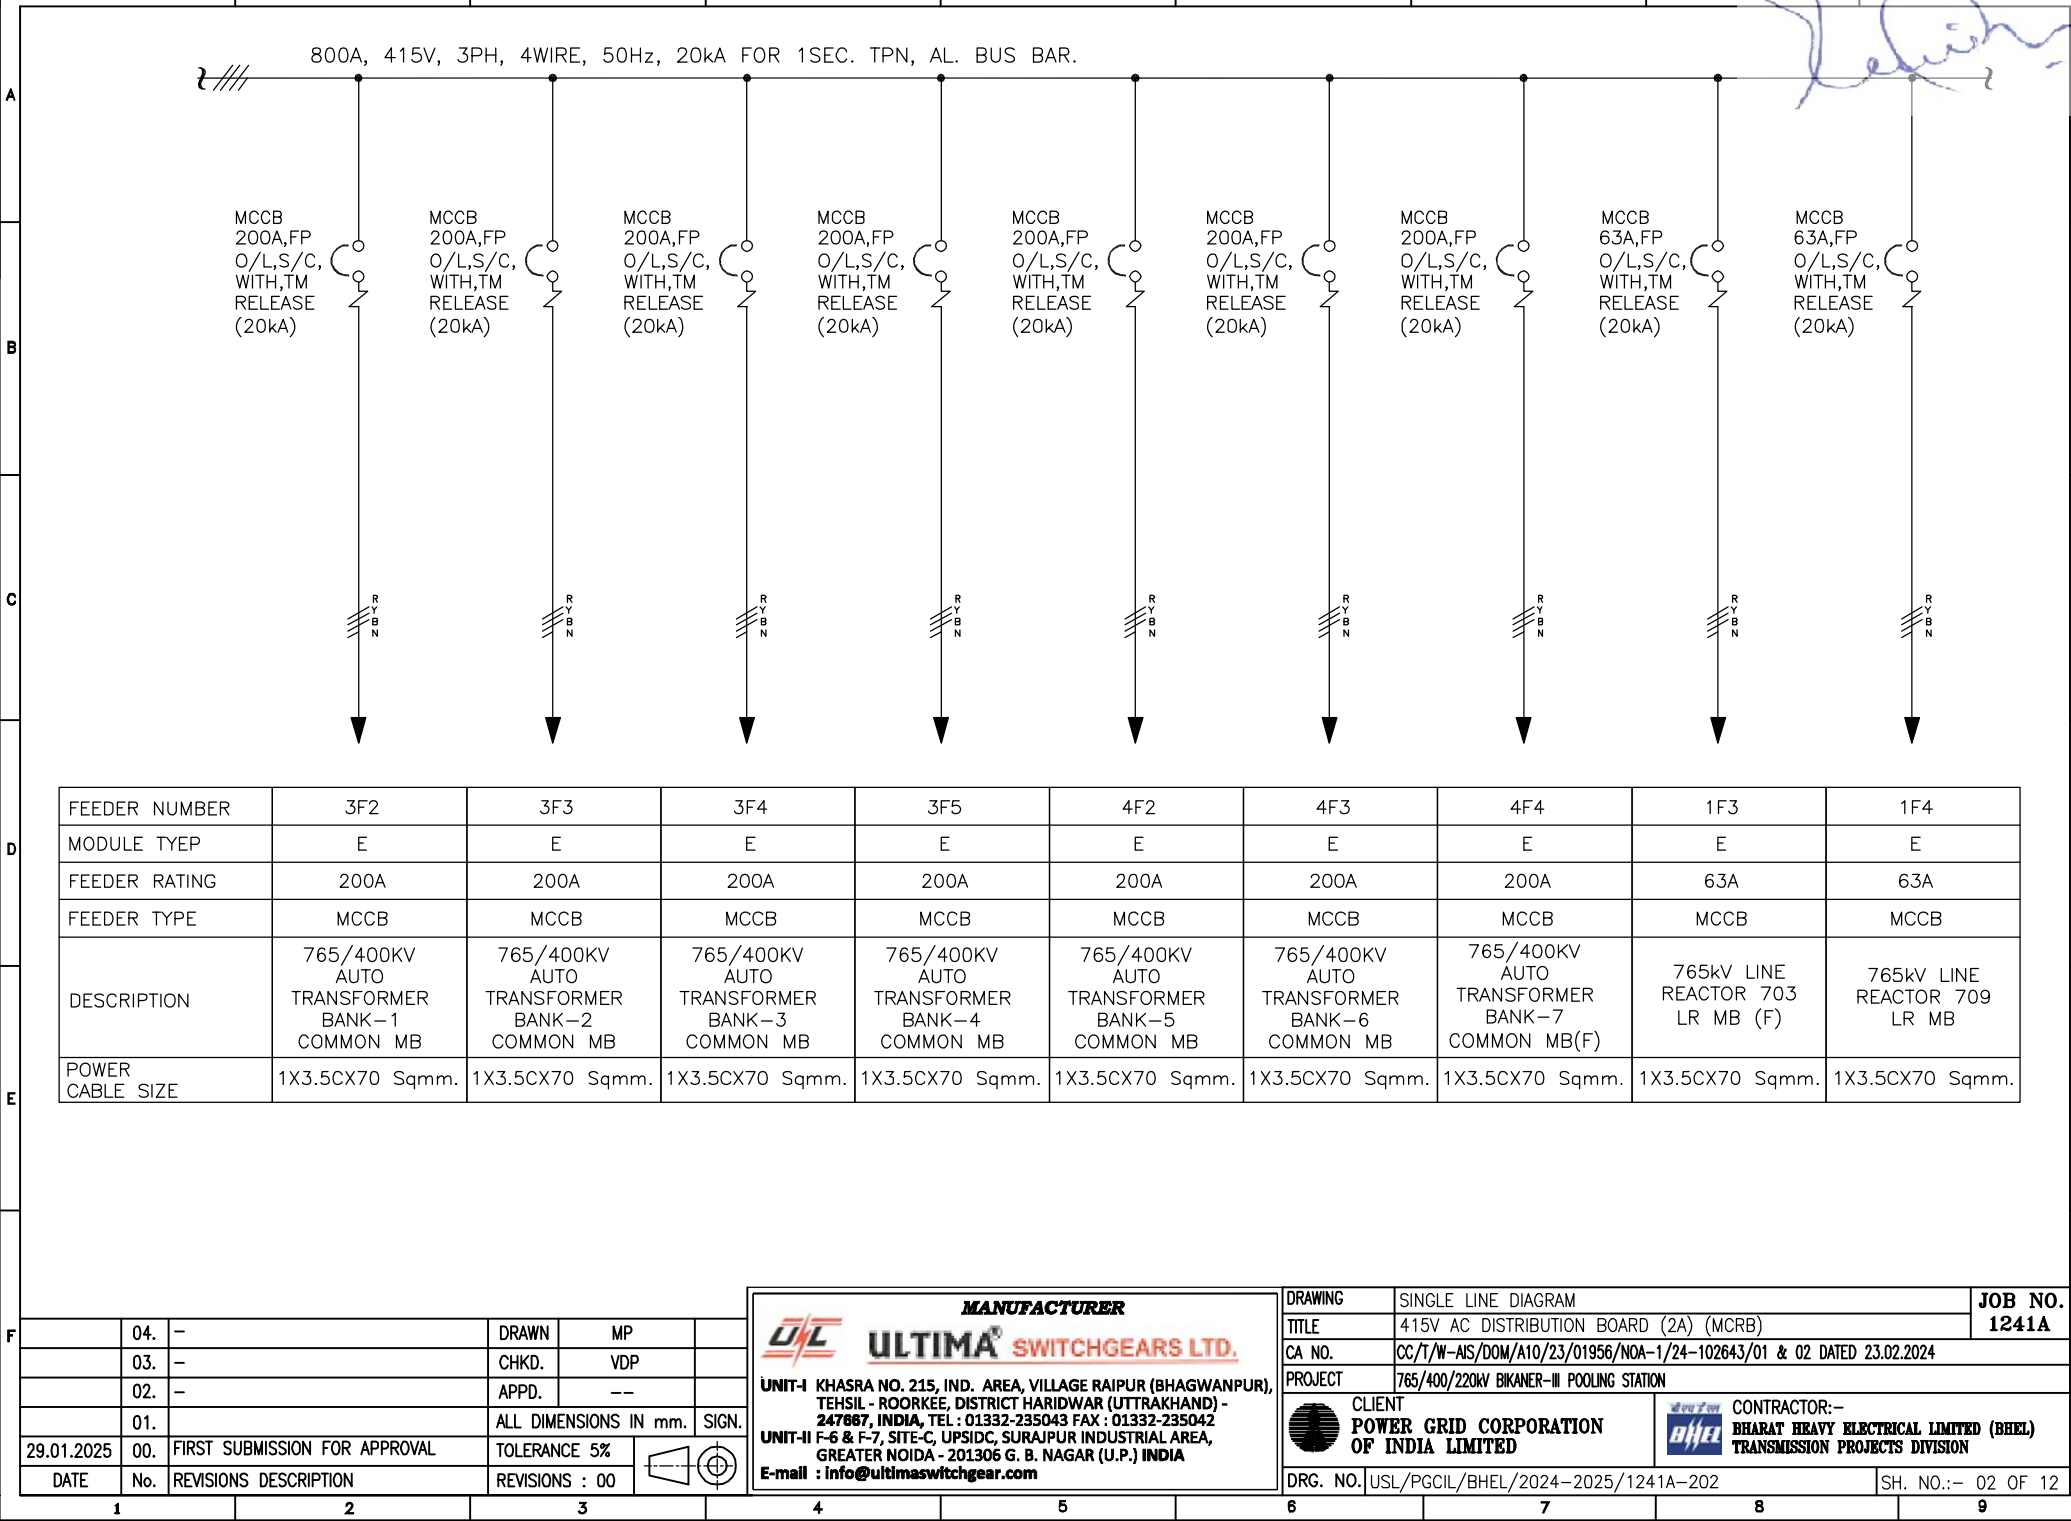

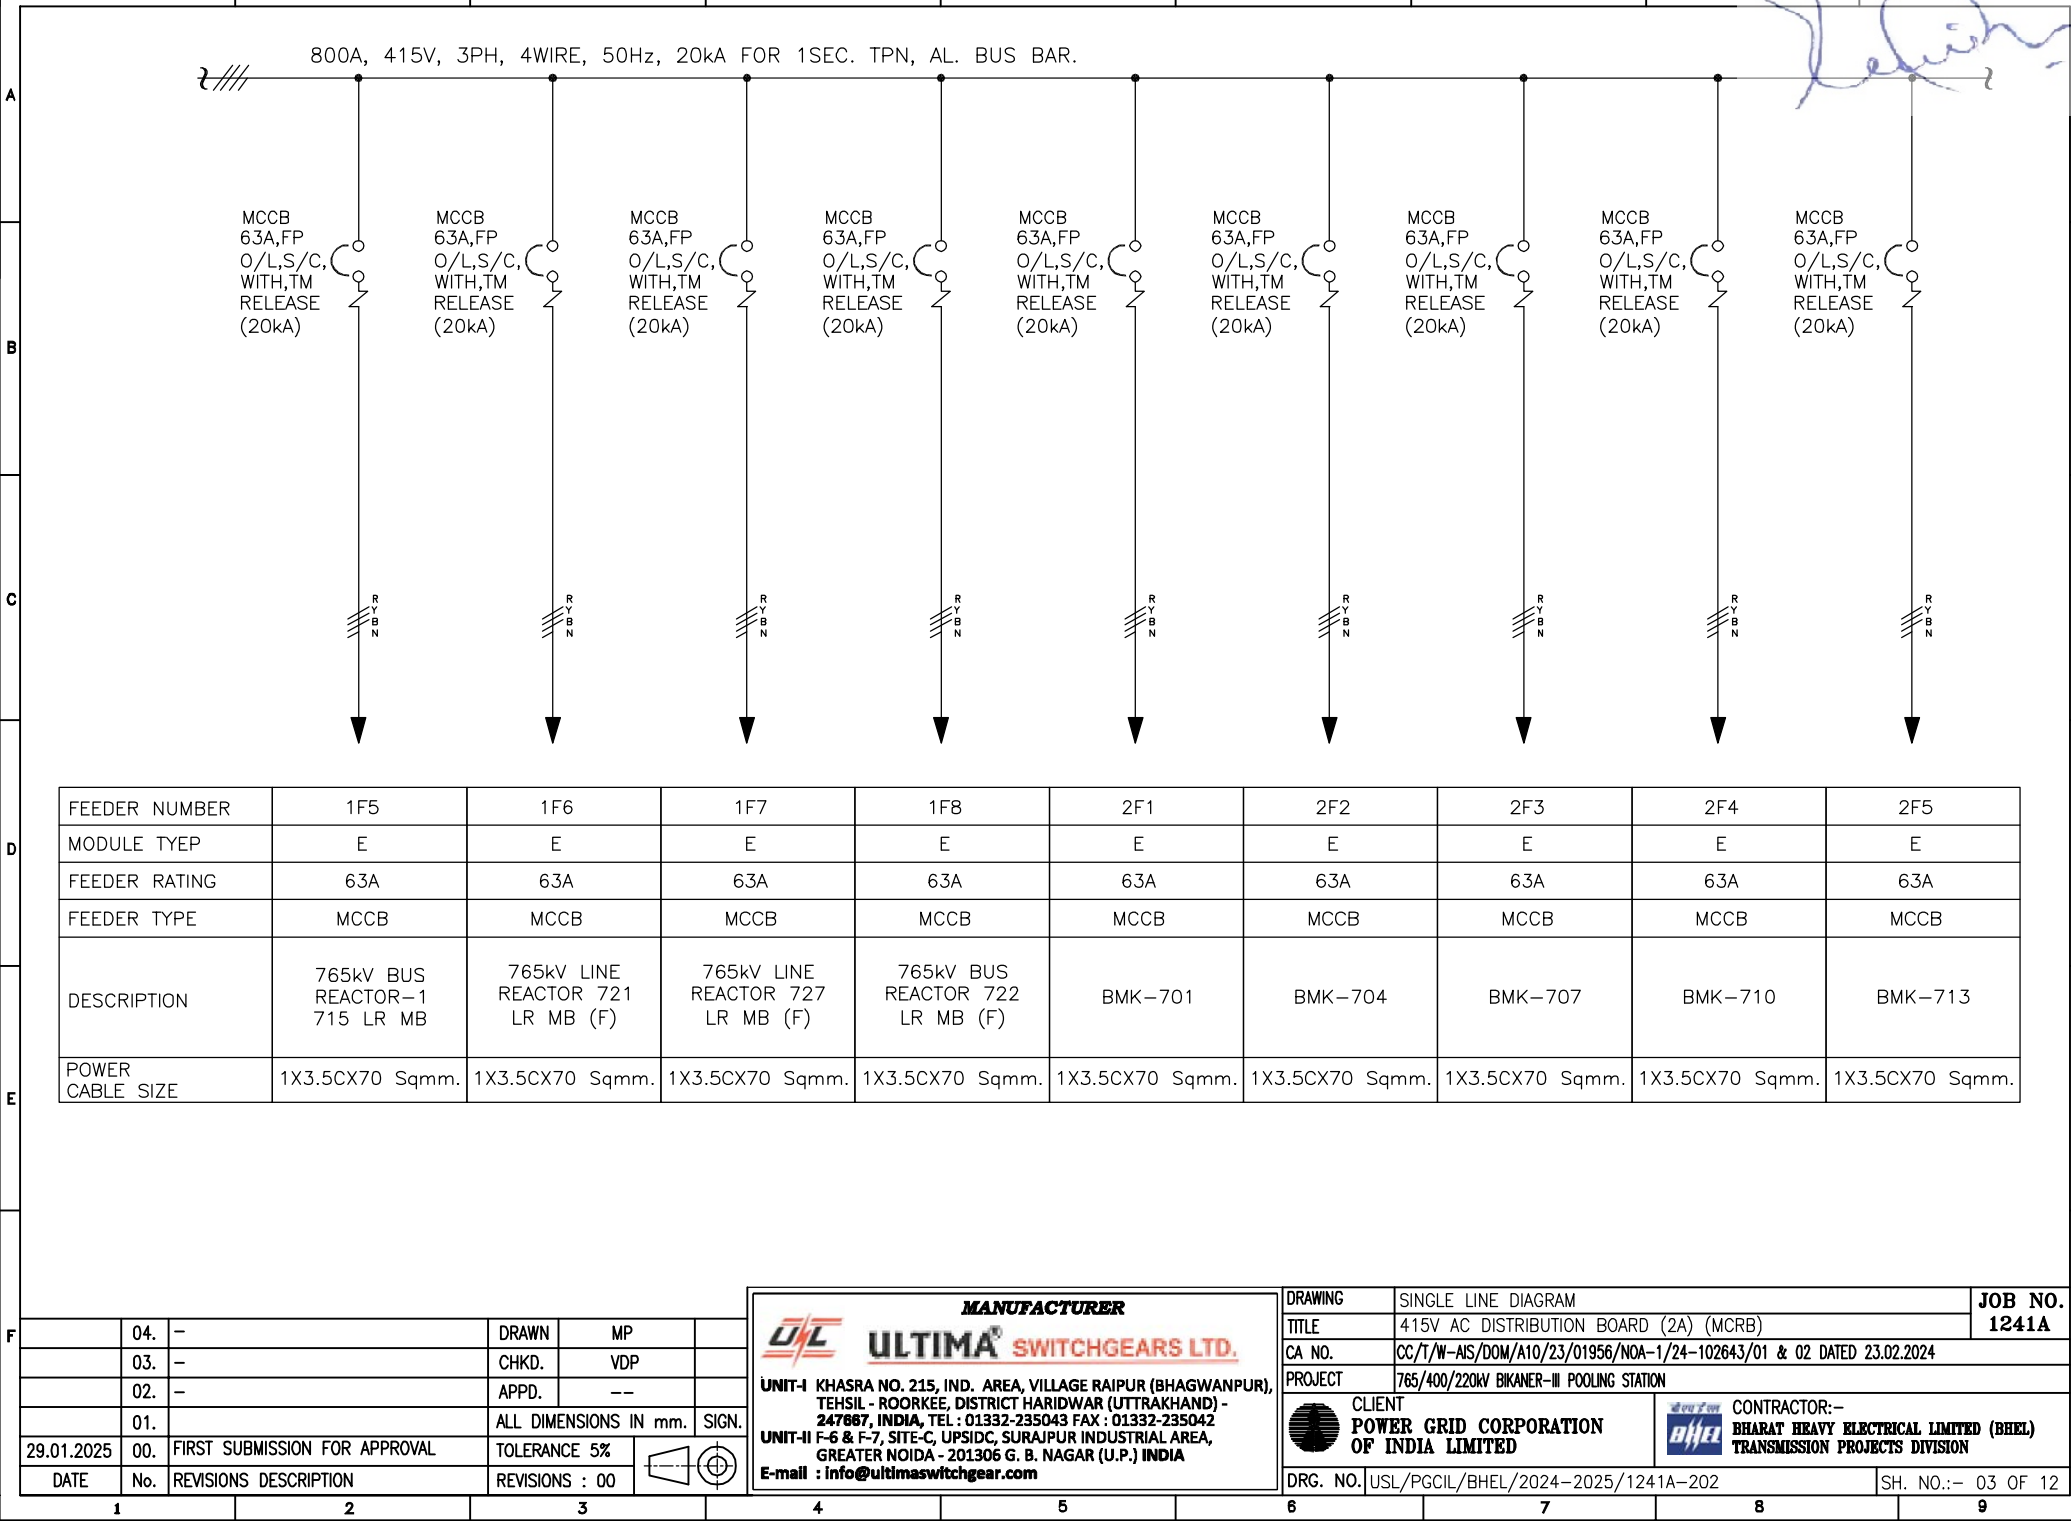


[Handwritten signature]

This Drawing & information or descriptive matter set out hereon are the confidential property of **ULTIMA SWITCHGEARS LIMITED** & must not be disclosed, copied,loaned or used for manufacturing,tendering or for any other purpose without their permission.

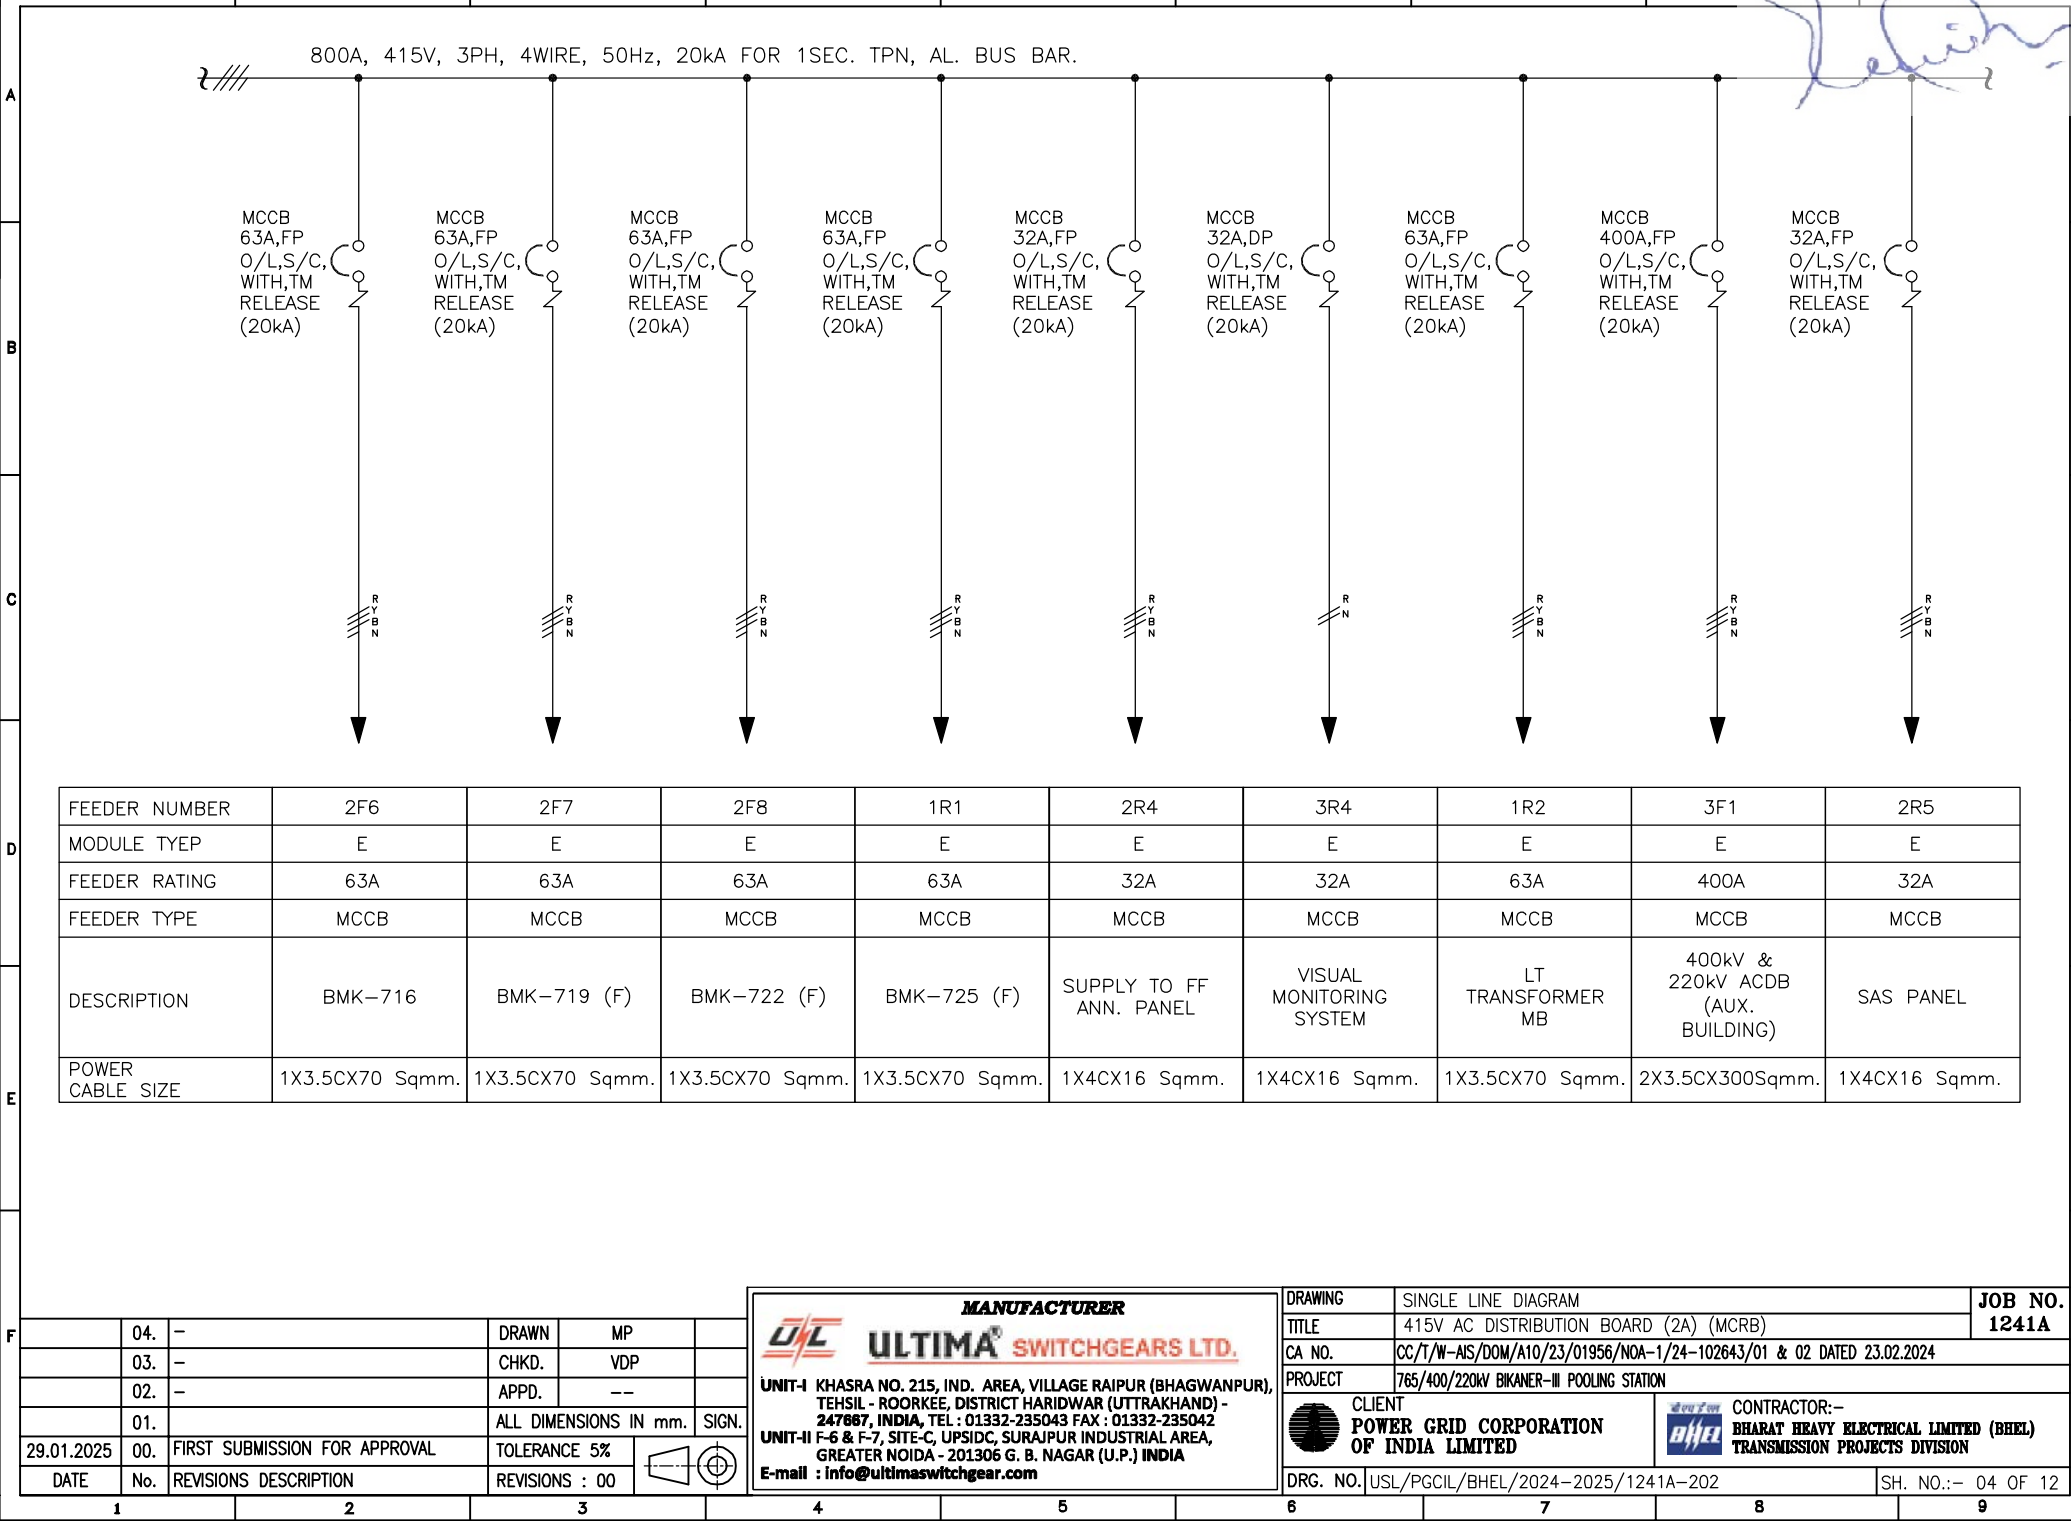


This Drawing & information or descriptive matter set out hereon are the confidential property of **ULTIMA SWITCHGEARS LIMITED** & must not be disclosed, copied,loaned or used for manufacturing,tendering or for any other purpose without their permission.

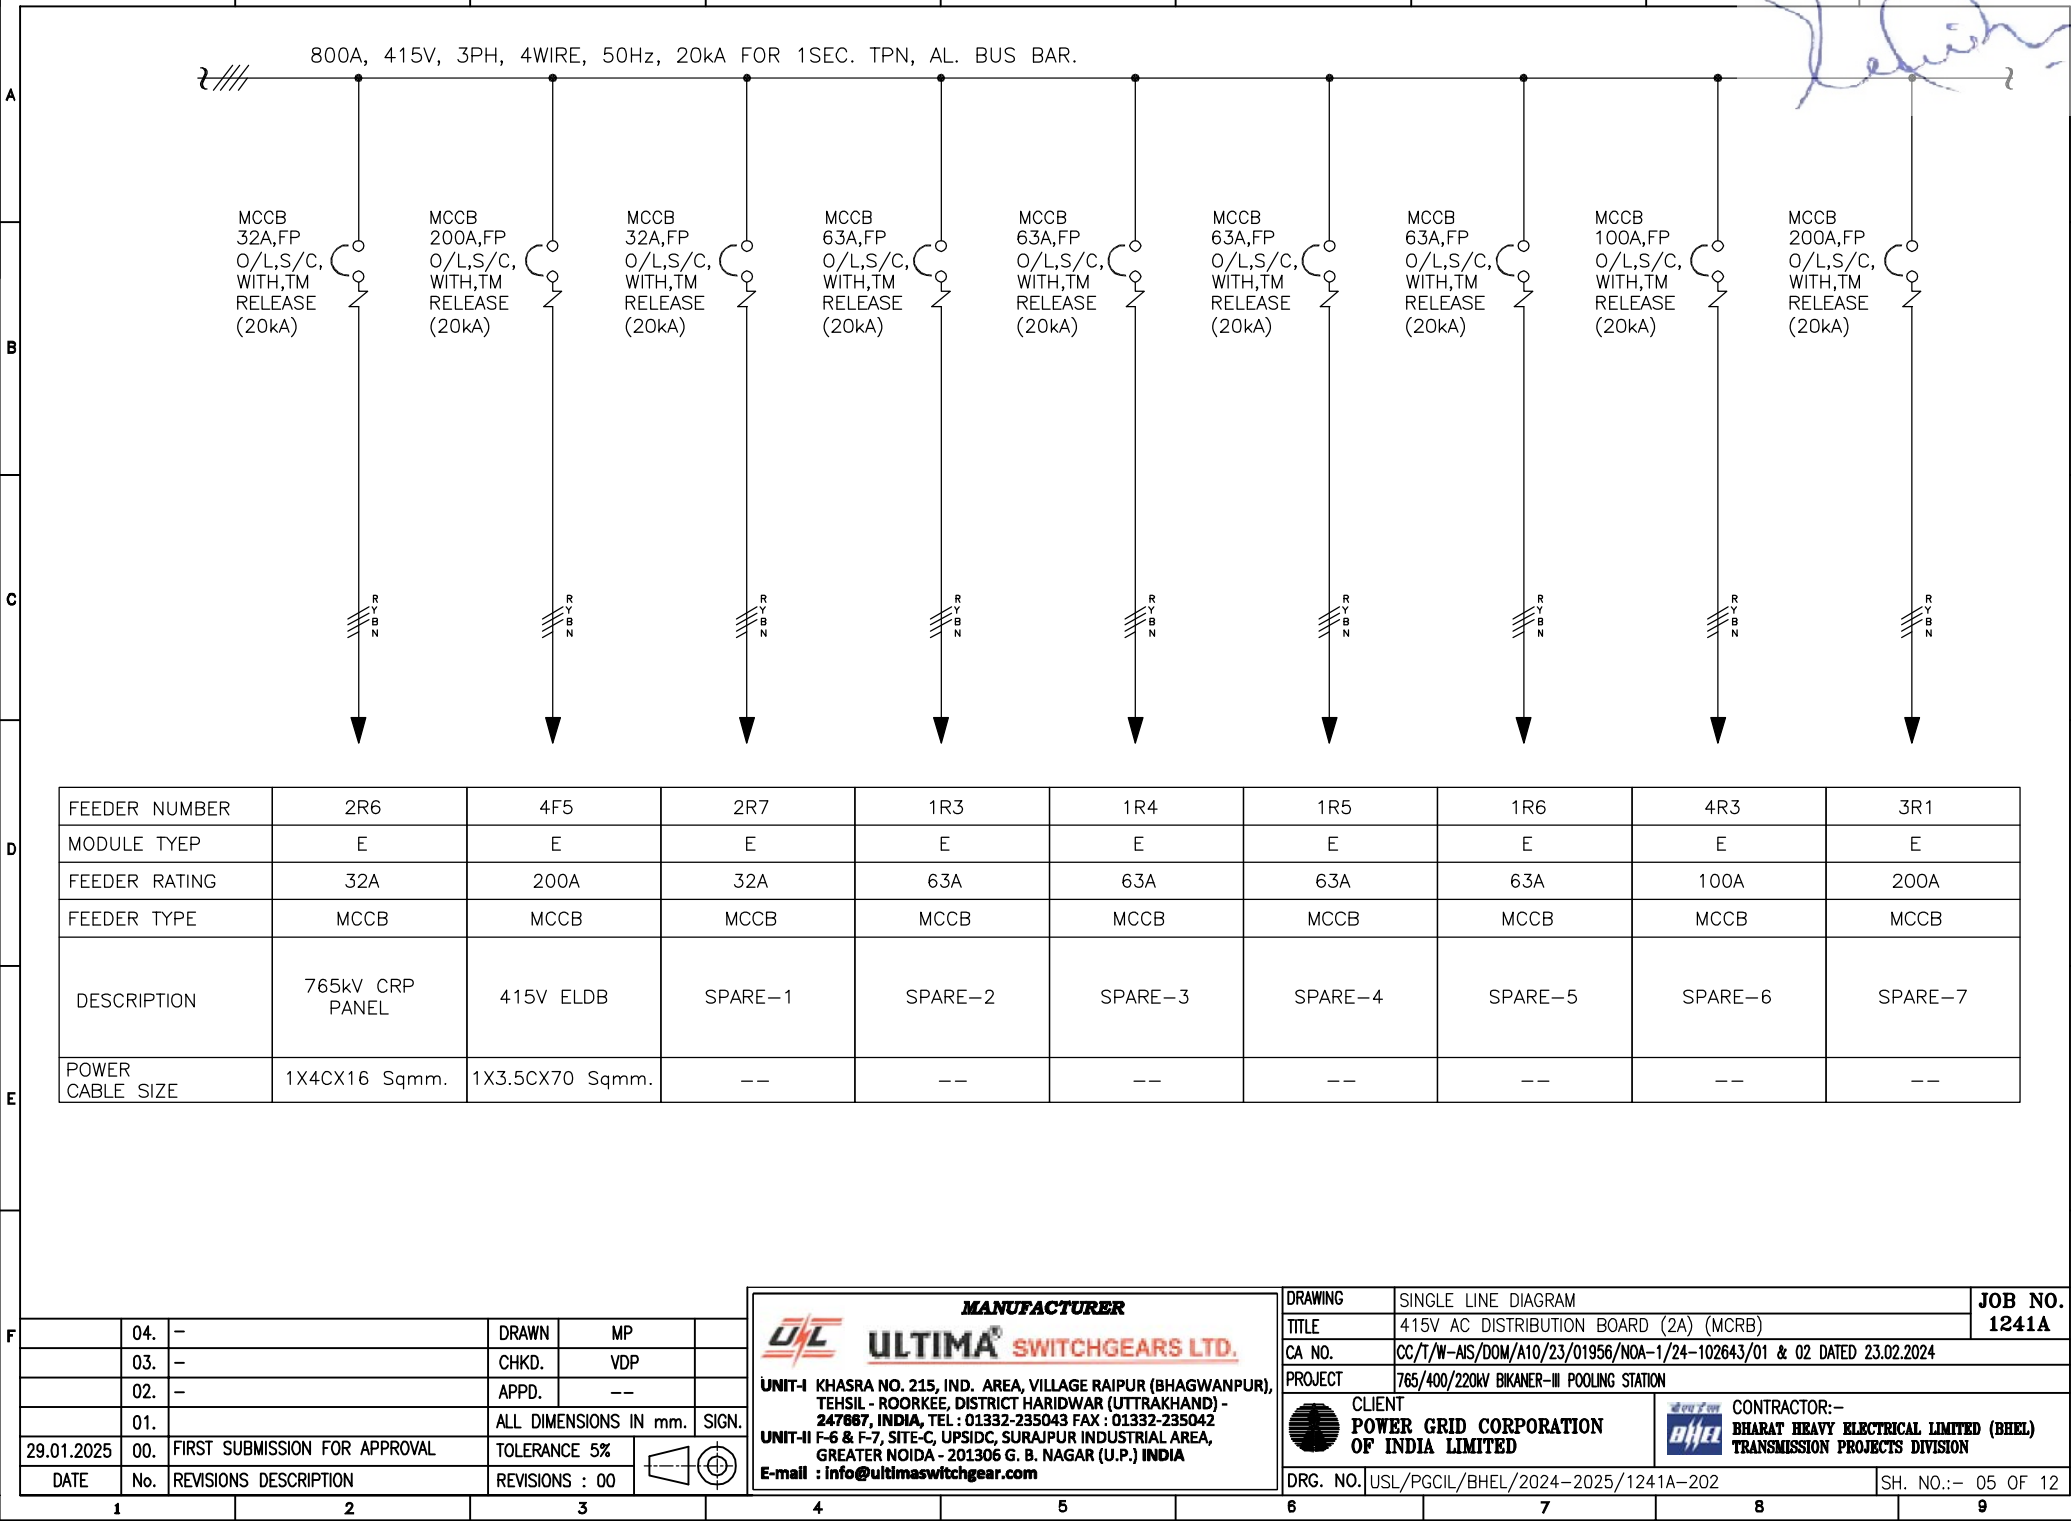

This Drawing & information or descriptive matter set out hereon are the confidential property of **ULTIMA SWITCHGEARS LIMITED** & must not be disclosed, copied,loaned or used for manufacturing,tendering or for any other purpose without their permission.

[Handwritten Signature]

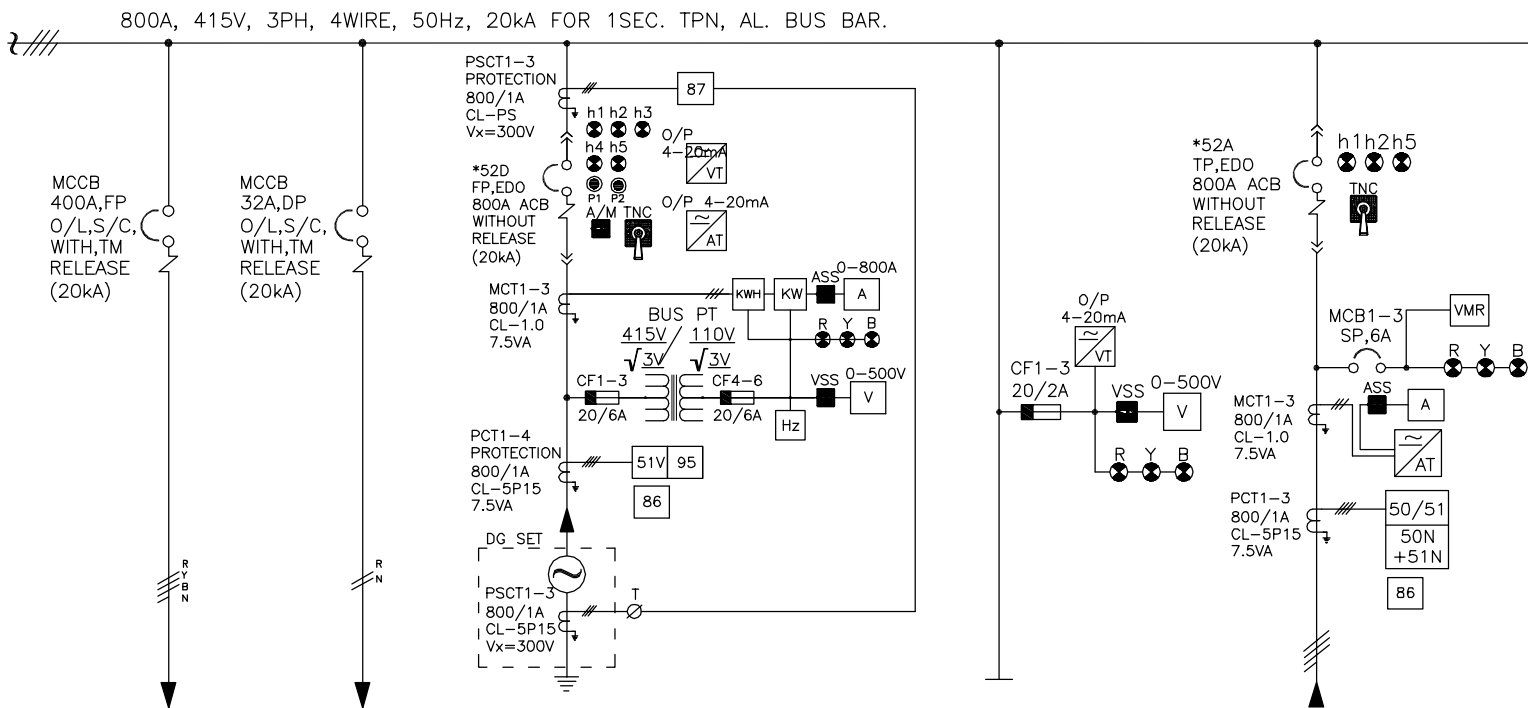


FEEDER NUMBER	4F1	3R5	6F1+6F2+6F3	5F1+5F2+5F3	
MODULE TYEP	E	E	DG	G2	AE
FEEDER RATING	400A	32A	800A	--	800A
FEEDER TYPE	MCCB	MCCB	ACB	METERING	ACB
DESCRIPTION	SPARE-8	SPARE-9	415V AC SUPPLY FROM 415V 500kVA DG SET	--	415V AC SUPPLY FROM 415V MAIN SWITCH BOARD (INCOMER-1)
POWER CABLE SIZE	--	--	2X3.5CX300 Sqmm.		2X3.5CX300 Sqmm.

	04.	-	DRAWN	MP	
	03.	-	CHKD.	VDP	
	02.	-	APPD.	--	
	01.	-	ALL DIMENSIONS IN mm.	SIGN.	
29.01.2025	00.	FIRST SUBMISSION FOR APPROVAL	TOLERANCE 5%		
DATE	No.	REVISIONS DESCRIPTION	REVISIONS : 00		

MANUFACTURER
ULTIMA SWITCHGEARS LTD.

UNIT-I KHASRA NO. 215, IND. AREA, VILLAGE RAIPUR (BHAGWANPUR),
TEHSIL - ROORKEE, DISTRICT HARIDWAR (UTTRAKHAND) -
247687, INDIA, TEL : 01332-235043 FAX : 01332-235042
UNIT-II F-6 & F-7, SITE-C, UPSIDC, SURAJPUR INDUSTRIAL AREA,
GREATER NOIDA - 201306 G. B. NAGAR (U.P.) INDIA
E-mail : info@ultimaswitchgear.com


DRAWING	SINGLE LINE DIAGRAM	JOB NO.	1241A
TITLE	415V AC DISTRIBUTION BOARD (2A) (MCRB)		
CA NO.	CC/T/W-AIS/DM/A10/23/01956/NOA-1/24-102643/01 & 02 DATED 23.02.2024		
PROJECT	765/400/220KV BIKANER-III POOLING STATION		
CLIENT	POWER GRID CORPORATION OF INDIA LIMITED	CONTRACTOR:-	BHARAT HEAVY ELECTRICAL LIMITED (BHEL) TRANSMISSION PROJECTS DIVISION
DRG. NO.	USL/PGCIL/BHEL/2024-2025/1241A-202	SH. NO.:-	06 OF 12

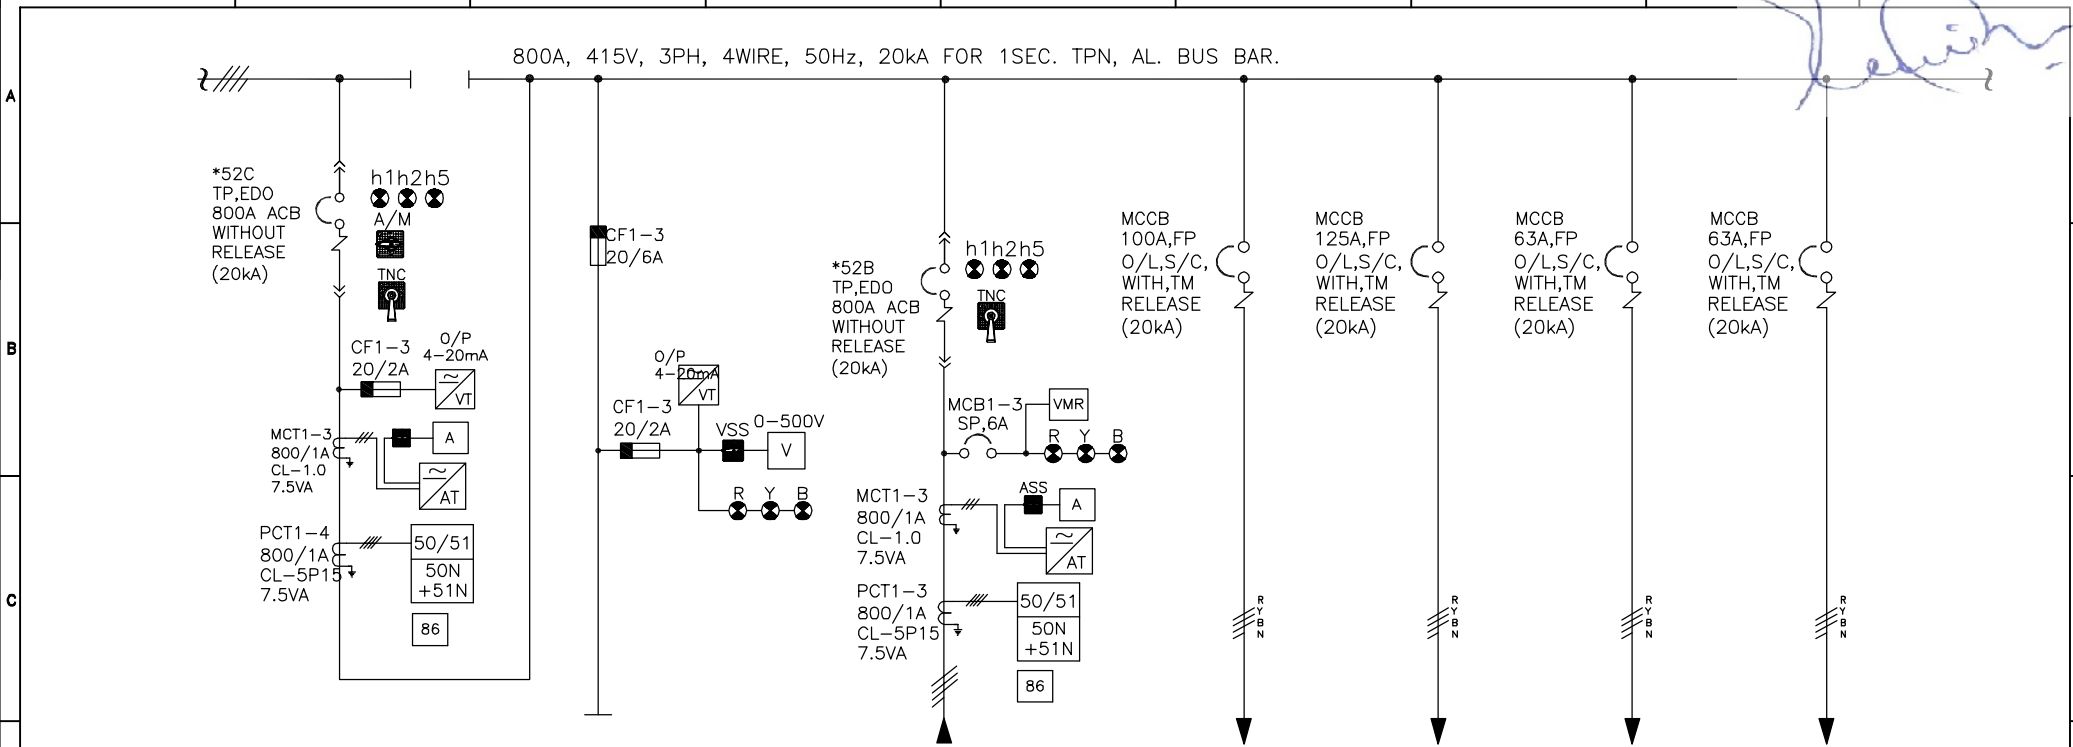

FEEDER NUMBER	7F1+7F2+7F3	8F1+8F3	8F1+8F2+8F3	9R1	10R1	11F1	11F2
MODULE TYEP	AE	G2	AE	E	E	E	E
FEEDER RATING	800A	--	800A	100A	125A	63A	63A
FEEDER TYPE	ACB	METERING	ACB	MCCB	MCCB	MCCB	MCCB
DESCRIPTION	BUS COUPLER	--	415V AC SUPPLY FROM 415V MAIN SWITCH BOARD (INCOMER-2)	48V BATTERY CHARGER-1, SOURCE - 2	220V BATTERY CHARGER-1, SOURCE - 2	AIR CONDITIONING DB INCHARGE OFFICE	AIR CONDITIONING DB TRASIT GUEST ROOM
POWER CABLE SIZE			2X3.5CX300 Sqmm.	1x3.5Cx70 Sqmm.	1x3.5Cx70 Sqmm.	1X3.5CX35 Sqmm.	1X3.5CX35 Sqmm.


F		04.	—	DRAWN	MP		MANUFACTURER ULTIMA[®] SWITCHGEARS LTD. UNIT-I KHASRA NO. 215, IND. AREA, VILLAGE RAIPUR (BHAGWANPUR), TEHSIL - ROORKEE, DISTRICT HARIDWAR (UTTRAKHAND) - 247667, INDIA, TEL : 01332-235043 FAX : 01332-235042 UNIT-II F-6 & F-7, SITE-C, UPSIDC, SURAIPUR INDUSTRIAL AREA, GREATER NOIDA - 201306 G. B. NAGAR (U.P.) INDIA E-mail : info@ultimaswitchgear.com	DRAWING	SINGLE LINE DIAGRAM		JOB NO. 1241A						
		03.	—	CHKD.	VDP			TITLE	415V AC DISTRIBUTION BOARD (2A) (MCRB)								
		02.	—	APPD.	—			CA NO.	CC/T/W-AIS/DOM/A10/23/01956/NOA-1/24-102643/01 & 02 DATED 23.02.2024								
		01.			ALL DIMENSIONS IN mm.	SIGN.		PROJECT	765/400/220KV BIKANER-III POOLING STATION								
	29.01.2025	00.	FIRST SUBMISSION FOR APPROVAL		TOLERANCE 5%			CLIENT POWER GRID CORPORATION OF INDIA LIMITED	UPC CONTRACTOR:- BHARAT HEAVY ELECTRICAL LIMITED (BHEL) TRANSMISSION PROJECTS DIVISION								
	DATE	No.	REVISIONS DESCRIPTION		REVISIONS : 00			DRG. NO.	USL/PGCIL/BHEL/2024-2025/1241A-202		SH. NO.:- 07 OF 12						
1		2		3		4		5		6		7		8		9	

This Drawing & information or descriptive matter set out hereon are the confidential property of **ULTIMA SWITCHGEARS LIMITED** & must not be disclosed, copied,loaned or used for manufacturing,tendering or for any other purpose without their permission.

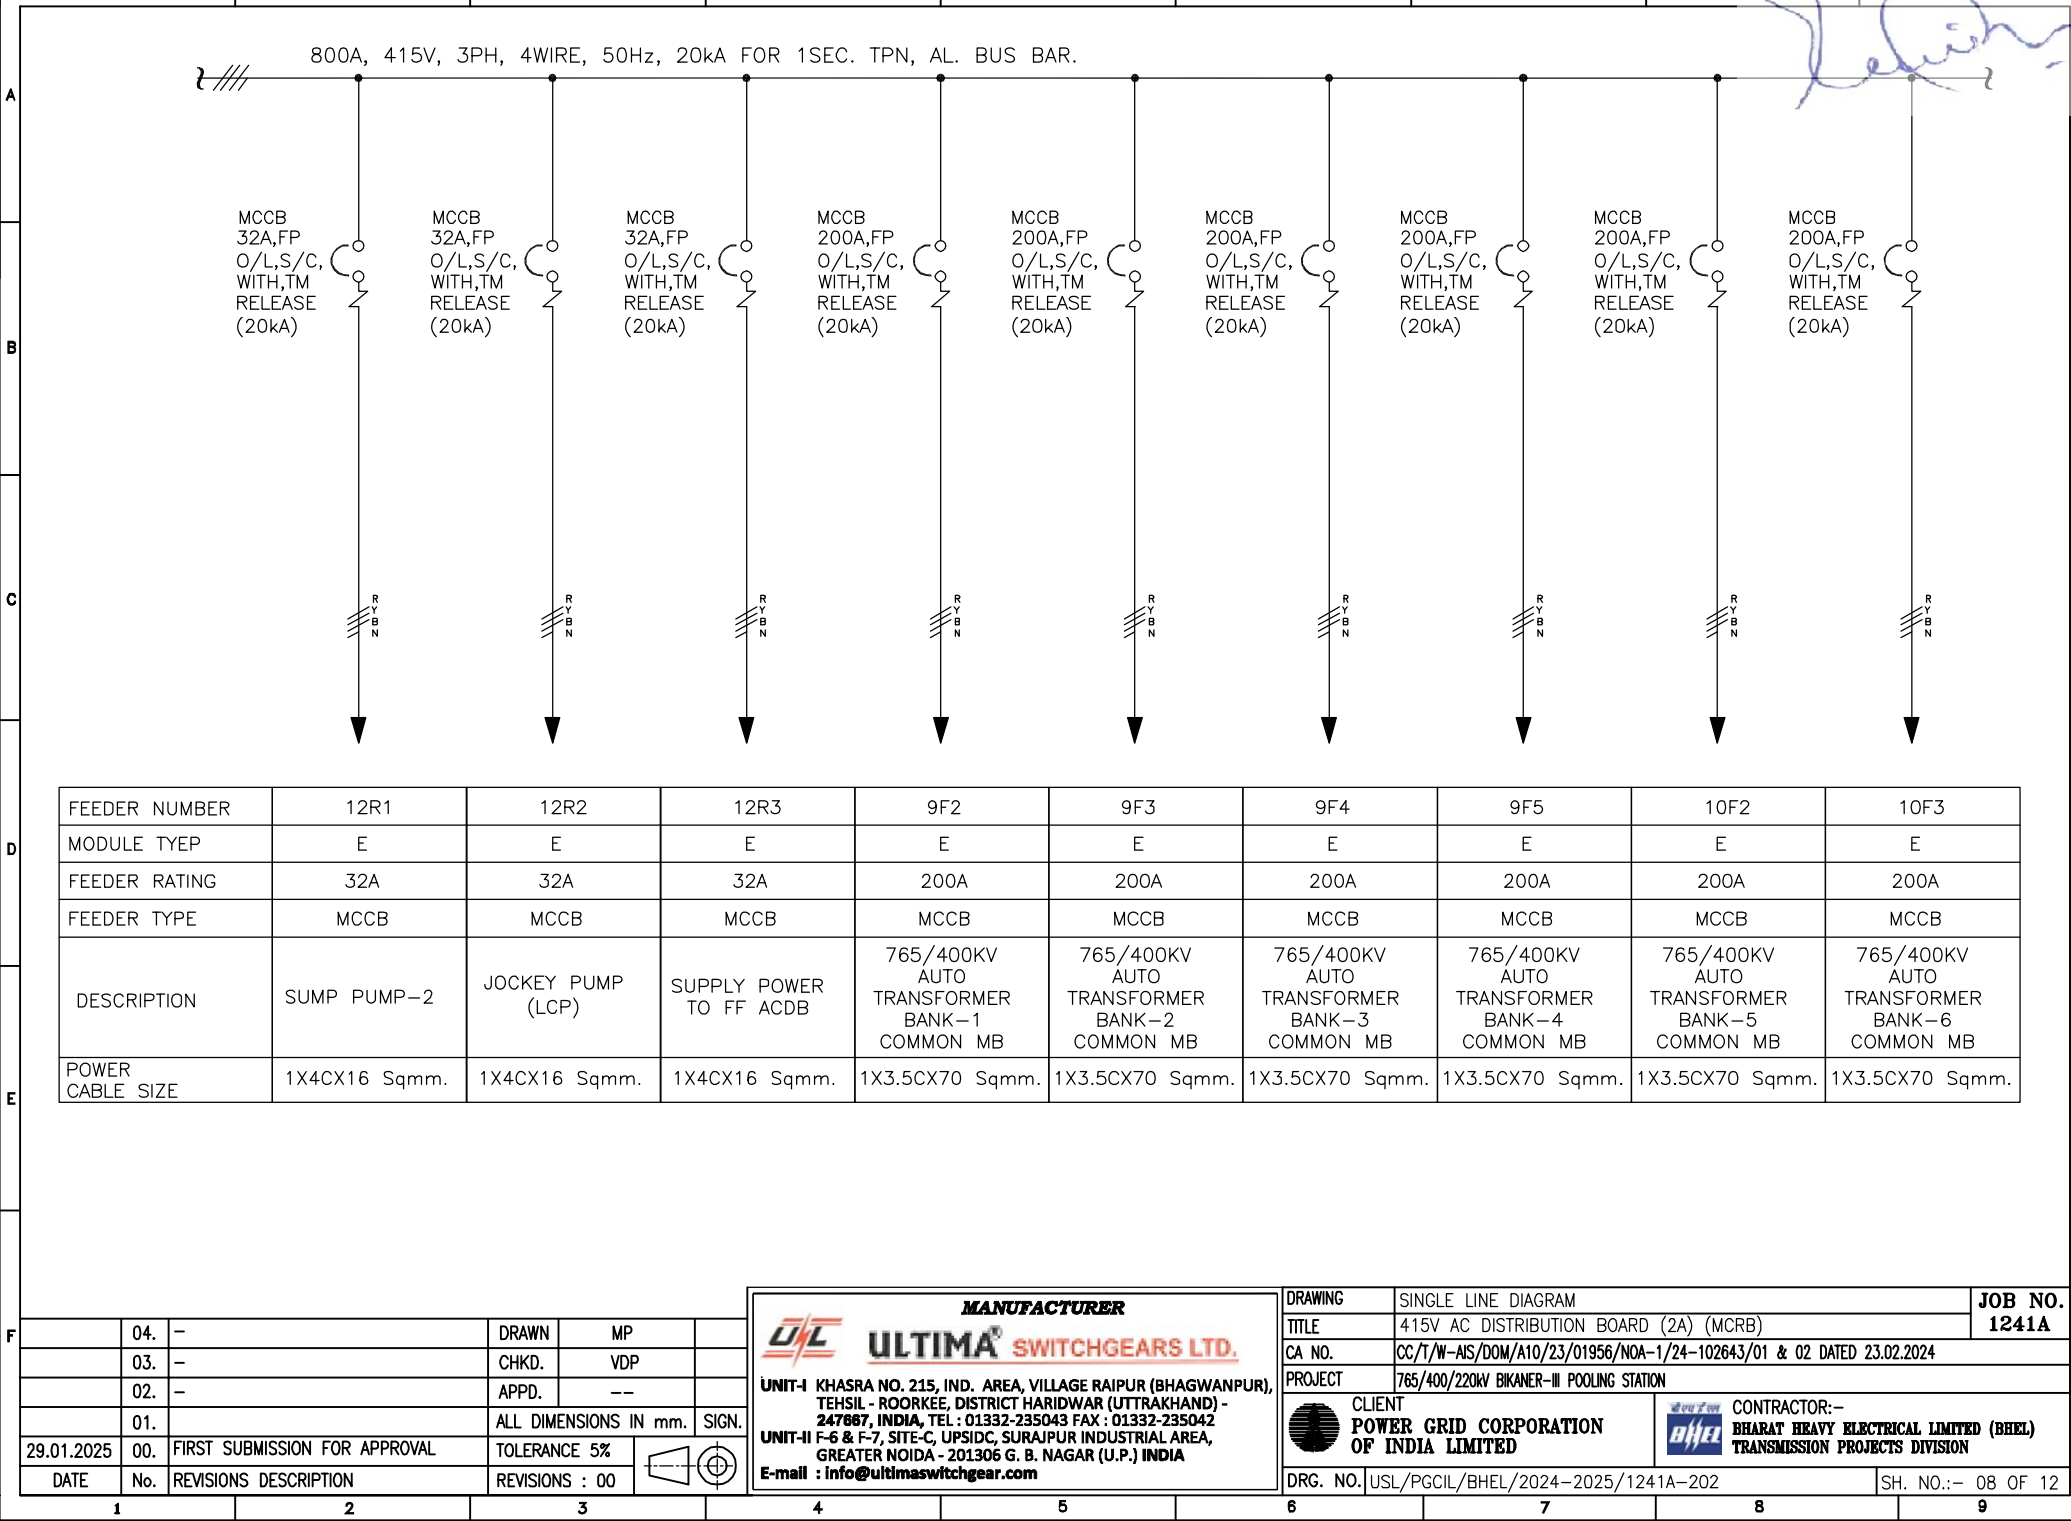


[Handwritten signature]


This Drawing & information or descriptive matter set out hereon are the confidential property of **ULTIMA SWITCHGEARS LIMITED** & must not be disclosed, copied,loaned or used for manufacturing,tendering or for any other purpose without their permission.

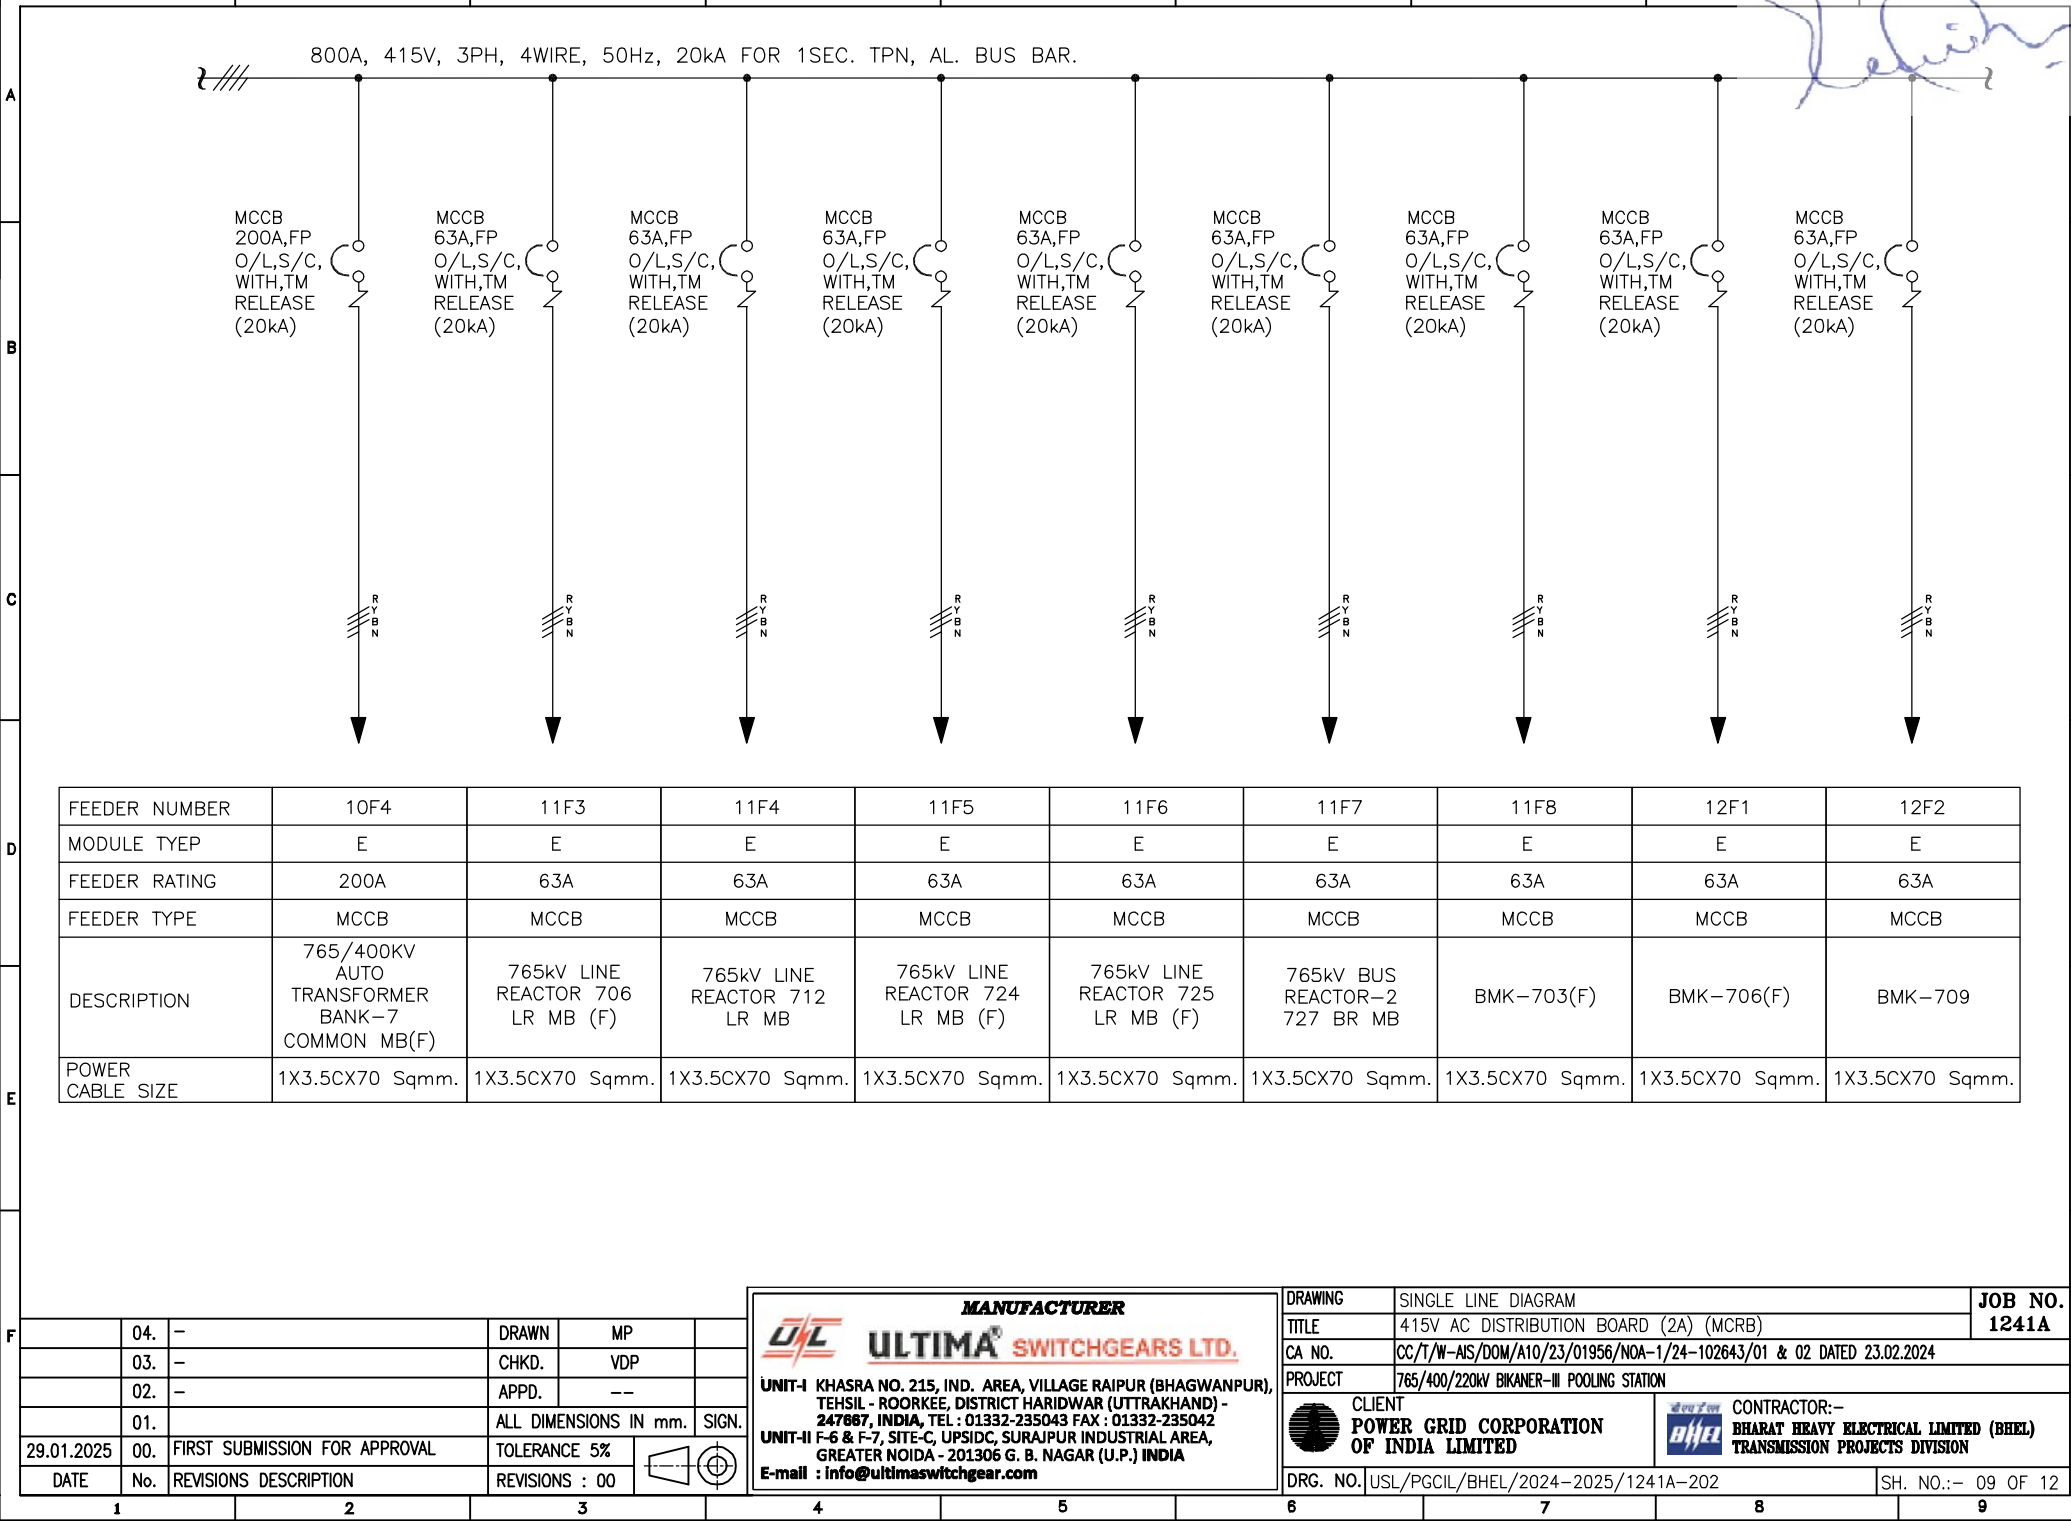

This Drawing & information or descriptive matter set out hereon are the confidential property of **ULTIMA SWITCHGEARS LIMITED** & must not be disclosed, copied,loaned or used for manufacturing,tendering or for any other purpose without their permission.

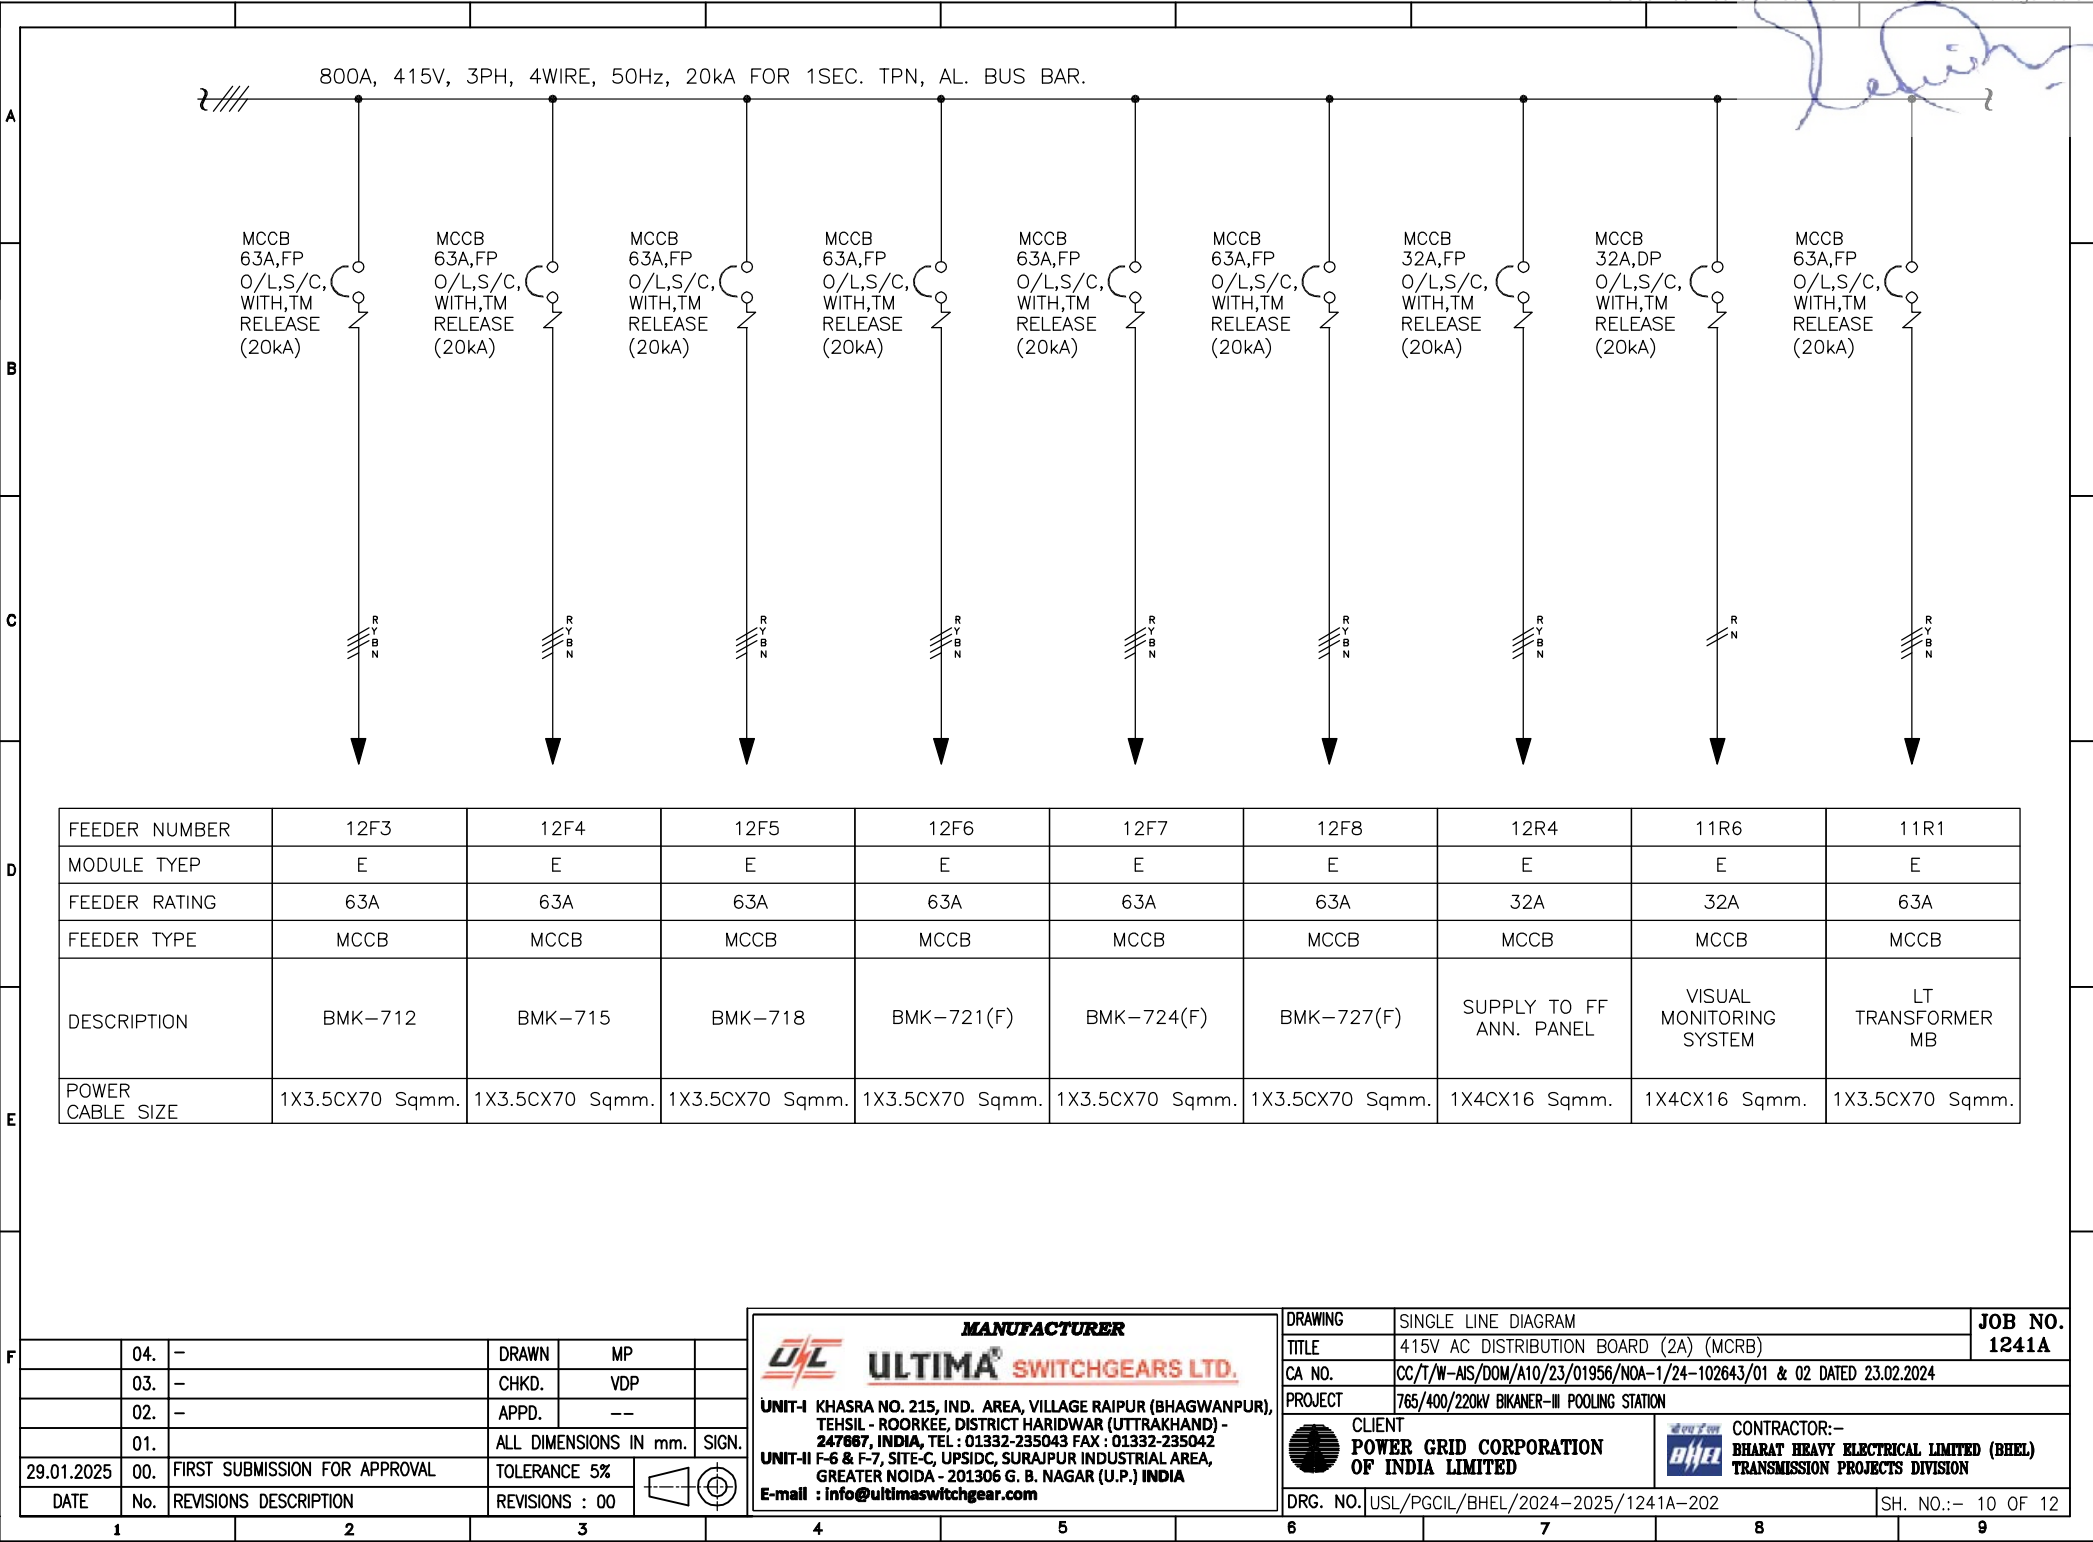


This Drawing & information or descriptive matter set out hereon are the confidential property of **ULTIMA SWITCHGEARS LIMITED** & must not be disclosed, copied,loaned or used for manufacturing,tendering or for any other purpose without their permission.

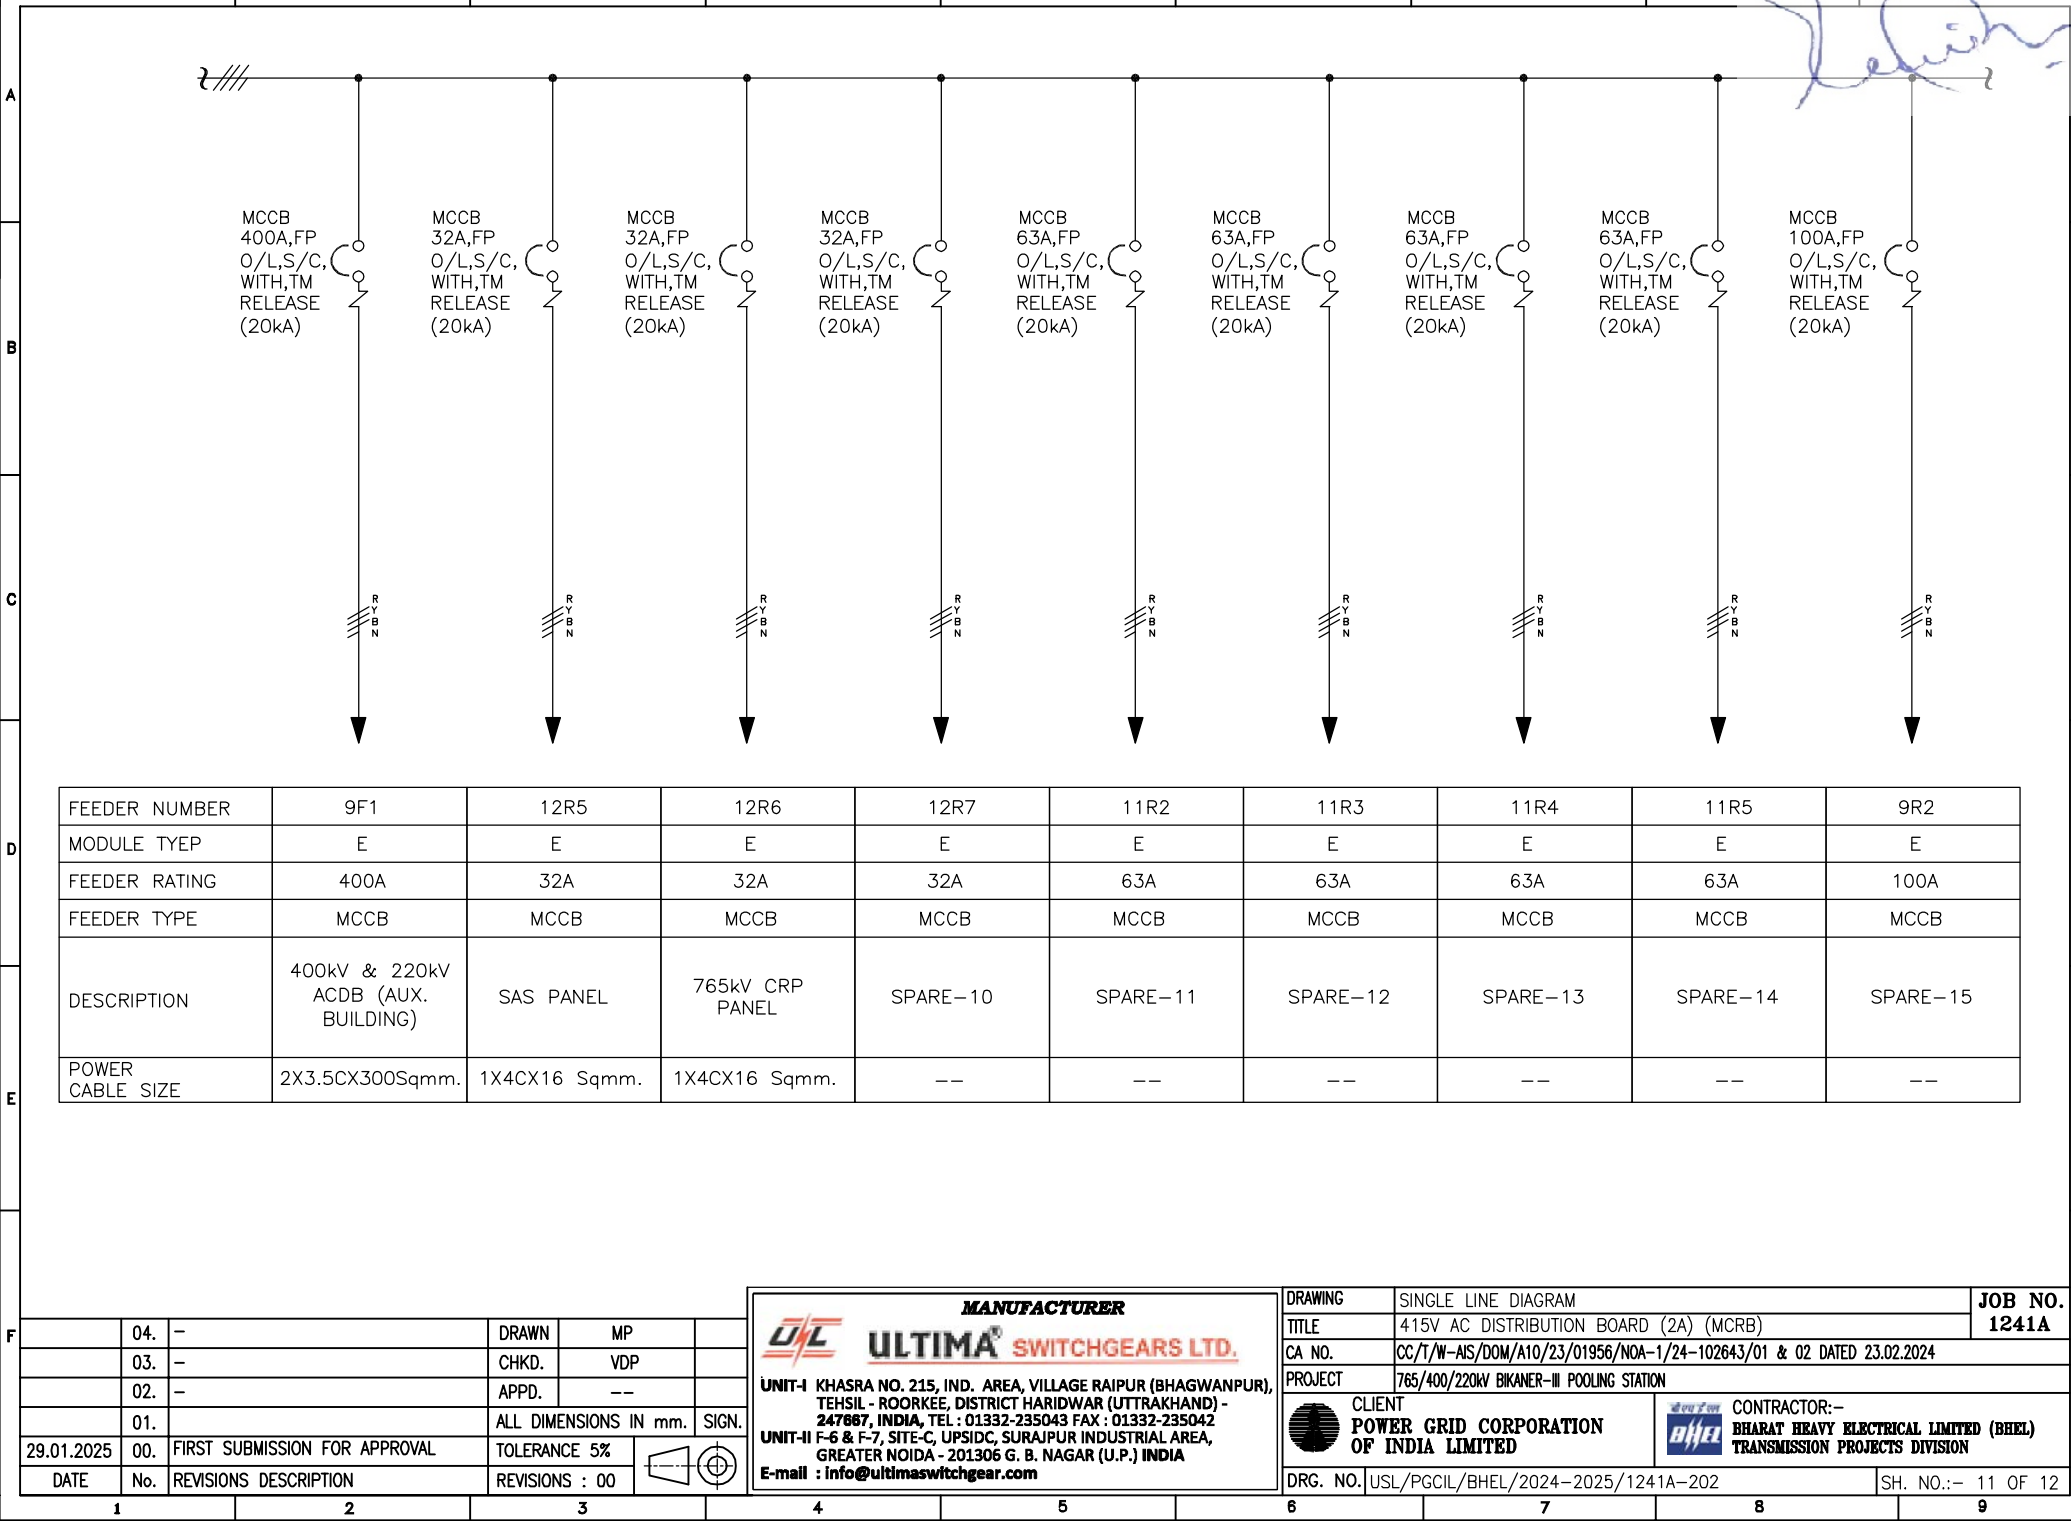

This Drawing & information or descriptive matter set out hereon are the confidential property of **ULTIMA SWITCHGEARS LIMITED** & must not be disclosed, copied,loaned or used for manufacturing,tendering or for any other purpose without their permission.

[Handwritten Signature]

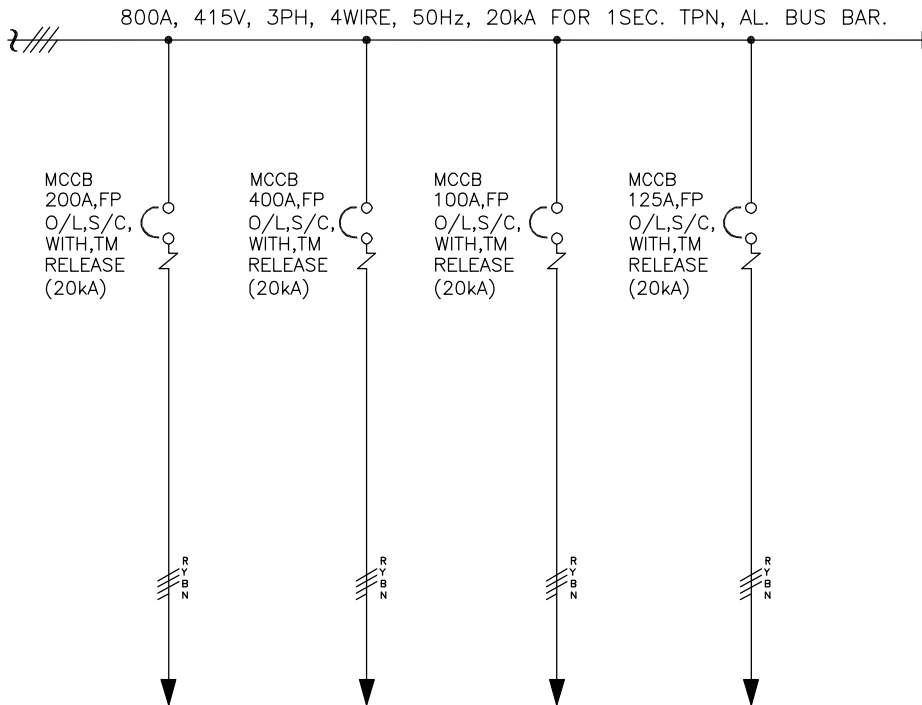

FEEDER NUMBER	10F5	10F1	9R3	10R2
MODULE TYEP	E	E	E	E
FEEDER RATING	200A	400A	100A	125A
FEEDER TYPE	MCCB	MCCB	MCCB	MCCB
DESCRIPTION	SPARE-16	SPARE-17	48V BATTERY CHARGER-2, SOURCE - 2	220V BATTERY CHARGER-2, SOURCE - 2
POWER CABLE SIZE	--	--	1x3.5Cx70 Sqmm.	1x3.5Cx70 Sqmm.

	04.	-	DRAWN	MP	
	03.	-	CHKD.	VDP	
	02.	-	APPD.	--	
	01.		ALL DIMENSIONS IN mm. SIGN.		
29.01.2025	00.	FIRST SUBMISSION FOR APPROVAL	TOLERANCE 5%		
DATE	No.	REVISIONS DESCRIPTION	REVISIONS : 00		

MANUFACTURER
ULTIMA® SWITCHGEARS LTD.

UNIT-I KHASRA NO. 215, IND. AREA, VILLAGE RAIPUR (BHAGWANPUR),
TEHSIL - ROORKEE, DISTRICT HARIDWAR (UTTRAKHAND) -
247667, INDIA, TEL : 01332-235043 FAX : 01332-235042
UNIT-II F-6 & F-7, SITE-C, UPSIDC, SURAJPUR INDUSTRIAL AREA,
GREATER NOIDA - 201306 G. B. NAGAR (U.P.) INDIA
E-mail : info@ultimaswitchgear.com

DRAWING	SINGLE LINE DIAGRAM		JOB NO.
TITLE	415V AC DISTRIBUTION BOARD (2A) (MCRB)		1241A
CA NO.	CC/T/W-AIS/DOM/A10/23/01956/NOA-1/24-102643/01 & 02 DATED 23.02.2024		
PROJECT	765/400/220KV BIKANER-III POOLING STATION		
	CLIENT POWER GRID CORPORATION OF INDIA LIMITED		CONTRACTOR:- BHARAT HEAVY ELECTRICAL LIMITED (BHEL) TRANSMISSION PROJECTS DIVISION
DRG. NO.	USL/PGCIL/BHEL/2024-2025/1241A-202		SH. NO.:- 12 OF 12

[Handwritten Signature]

BILL OF MATERIAL FOR 415V AC DISTRIBUTION BOARD (2A) (MCRB)

S.NO.	ITEM CODE	DESCRIPTION	MAKE	RATING	QTY.
A	BILL OF MATERIAL FOR MODULE - (AE) INCOMER 1&2				2 Nos.
1	52A & 52B	TP ACB 415V,EDO, WITHOUT RELEASE, 1. SPRING CHARGE MOTOR 220V DC WITH SPRING CHARGE SWITCH 2. CLOSING RELEASE 220V DC 3. SHUNT RELEASE 220V DC 4. LIMIT SWITCH FOR TEST/ISOLATE/SERVICE POSITION 5. 4NO + 4NC POTENTIAL FREE CONTACT.	L&T/C&S/HAVELLS	800A, 50kA	01
2	CF4-10	HRC FUSE BASE	L&T/C&S/HAVELLS	20A	07
3	CF4-10	HRC FUSE LINK	L&T/C&S/HAVELLS	6A	07
4		AUX. CONTACTOR RELAY, COIL VOLTAGE 220V DC WITH 2NO+2NC AUX. CONTACT	L&T/C&S/HAVELLS	--	03
5		AUX. CONTACTOR RELAY, COIL VOLTAGE 220V DC WITH 3NO+1NC AUX. CONTACT	L&T/C&S/HAVELLS	--	02
6		2NO+2NC ADD ON BLOCK	L&T/C&S/HAVELLS	--	01
7	MCB	DP MINIATURE CIRCUIT BREAKER, DC TYPE	L&T/C&S/HAVELLS	10A, 4kA	02
8	MCB	SP MINIATURE CIRCUIT BREAKER, 'C' CURVE	L&T/C&S/HAVELLS	6A, 10kA	03
9	VMR-1, VMR-2	415V AC, THREE PHASE, 3WIRE, VOLTAGE MONITORING RELAY	MINILEC/PGCIL APPROVED MAKE	--	01
10	TNC	BREAKER CONTROL SWITCH	SALZER/KAYCEE	16A	01
11	R-PHASE	'R' INDICATION LAMP, 22.5 Sq. mm. DIA ,LED TYPE, RED	ESBEE/VAISHNO/C&S	240V AC	01
12	Y-PHASE	'Y' INDICATION LAMP, 22.5 Sq. mm. DIA ,LED TYPE, YELLOW	ESBEE/VAISHNO/C&S	240V AC	01
13	B-PHASE	'B' INDICATION LAMP, 22.5 Sq. mm. DIA ,LED TYPE, BLUE	ESBEE/VAISHNO/C&S	240V AC	01
14	h1	'ON' INDICATION LAMP, 22.5 Sq. mm. DIA ,LED TYPE, RED	ESBEE/VAISHNO/C&S	220V DC	01
15	h2	'OFF' INDICATION LAMP, 22.5 Sq. mm. DIA ,LED TYPE, GREEN	ESBEE/VAISHNO/C&S	220V DC	01
16	h5	'SPRING CHARGE' INDICATION LAMP, 22.5 Sq. mm. DIA ,LED TYPE, BLUE	ESBEE/VAISHNO/C&S	220V DC	01
17	1T, 2T	ON DELAY TIMER WITH 1C/O AUXILIARY SWITCH, 0-60 SEC.	GIC/PGCIL APPROVED MAKE	220V DC	01
18	T1A, T2A	ON DELAY TIMER WITH 1C/O AUXILIARY SWITCH, 0-60 SEC.	GIC/PGCIL APPROVED MAKE	220V DC	01
19	MCTs	CURRENT TRANSFORMER, RESIN CAST TYPE	NEWTEK/AE/PRECISE/PROCOCOM/AS HMOR	800/1A, CL-1.0, 7.5VA	03
20	PCTs	CURRENT TRANSFORMER, RESIN CAST TYPE	NEWTEK/AE/PRECISE/PROCOCOM/AS HMOR	800/1A, CL-5P15, 7.5VA	04
21	A	ANALOG AMMETER, SINGLE PHASE, SIZE-96X96 Sq. mm, CL-1.0, CTR-/1A	AE/RISHAB/NEWTEK/SECURE /PGCIL APPROVED MAKE	0-800A	01
22	ASS	AMMETER SELECTOR SWITCH, ROTARY TYPE	SALZER/KAYCEE	6A	01

NOTE:- ALL COMPONENTS SHALL BE POWER GRID (QA&I) APPROVED MAKE

	04.	-	DRAWN	MP	
	03.	-	CHKD.	VDP	
	02.	-	APPD.	--	
	01.	-	ALL DIMENSIONS IN mm. SIGN.		
29.01.2025	00.	FIRST SUBMISSION FOR APPROVAL	TOLERANCE 5%		
DATE	No.	REVISIONS DESCRIPTION	REVISIONS : 00		

MANUFACTURER

ULTIMA SWITCHGEARS LTD.

UNIT-I KHASRA NO. 215, IND. AREA, VILLAGE RAIPUR (BHAGWANPUR), TEHSIL - ROORKEE, DISTRICT HARIDWAR (UTTRAKHAND) - 247687, INDIA, TEL : 01332-235043 FAX : 01332-235042
UNIT-II F-6 & F-7, SITE-C, UPSIDC, SURAJPUR INDUSTRIAL AREA, GREATER NOIDA - 201306 G. B. NAGAR (U.P.) INDIA
E-mail : info@ultimaswitchgear.com

DRAWING	BILL OF MATERIAL	JOB NO.
TITLE	415V AC DISTRIBUTION BOARD (2A) (MCRB)	1241A
CA NO.	CC/T/W-AIS/DOM/A10/23/01956/NOA-1/24-102643/01 & 02 DATED 23.02.2024	
PROJECT	765/400/220KV BIKANER-III POOLING STATION	
CLIENT POWER GRID CORPORATION OF INDIA LIMITED		CONTRACTOR:- BHARAT HEAVY ELECTRICAL LIMITED (BHEL) TRANSMISSION PROJECTS DIVISION
DRG. NO.	USL/PGCIL/BHEL/2024-2025/1241A-702	SH. NO. 01 OF 06

This Drawing & information or descriptive matter set out hereon are the confidential property of **ULTIMA SWITCHGEARS LIMITED** & must not be disclosed, copied, loaned or used for manufacturing, tendering or for any other purpose without their permission.

[Handwritten signature]

BILL OF MATERIAL FOR 415V AC DISTRIBUTION BOARD (2A) (MCRB)

S.NO.	ITEM CODE	DESCRIPTION	MAKE	RATING	QTY.
A	BILL OF MATERIAL FOR MODULE - (AE) INCOMER 1&2				2 Nos.
23	Vt	AC VOLTAGE TRANSDUCER, SINGLE OUTPUT- 4-20mA, PTR-415V AC, AUX. SUPPLY 220V DC	AE/RISHAB/SECURE	--	03
24	Ct	AC CURRENT TRANSDUCER, OUTPUT- 4-20mA, WITH SINGLE OUTPUT, AUX. SUPPLY 220V DC	AE/RISHAB/SECURE	800/1A	03
25	86	HIGH SPEED TRIPING RELAY WITH 3NO+1NC CONTACT (AUTO RESET HIGH SPEED), AUX. SUPPLY 220V DC	L&T/JVS/C&S	--	01
26	50 + 51	TRIPLE POLE INSTANTANEOUS OVER-CURRENT RELAY HAVING THE SETTING RANGE OF 200-800% OR 500-2000% OF CT SECONDARY AND ADJUSTABLE DEFINITE MINIMUM TIME, AUX. SUPPLY 220V DC .	L&T/JVS/C&S	-/1A	01
27	50N + 51N	INSTANTANEOUS EARTH FAULT RELAY HAVING AN ADJUSTABLE SETTING RANGE OF 10-40% OR 20 - 80% OF CT SECONDARY CURRENT AND ADJUSTABLE DEFINITE MINIMUM TIME. THE EARTH FAULT RELAY SHALL BE PROVIDED WITH A STABILISING RESISTOR, AUX. SUPPLY 220V DC.	L&T/JVS/C&S	-/1A	01

NOTE:- ALL COMPONENTS SHALL BE POWER GRID (QA&I) APPROVED MAKE

	04.	-	DRAWN	MP	
	03.	-	CHKD.	VDP	
	02.	-	APPD.	--	
	01.		ALL DIMENSIONS IN mm.	SIGN.	
29.01.2025	00.	FIRST SUBMISSION FOR APPROVAL	TOLERANCE 5%		
DATE	No.	REVISIONS DESCRIPTION	REVISIONS : 00		

MANUFACTURER
ULTIMA SWITCHGEARS LTD.

UNIT-I KHASRA NO. 215, IND. AREA, VILLAGE RAIPUR (BHAGWANPUR), TEHSIL - ROORKEE, DISTRICT HARIDWAR (UTTRAKHAND) - 247667, INDIA, TEL : 01332-235043 FAX : 01332-235042
UNIT-II F-6 & F-7, SITE-C, UPSIDC, SURAJPUR INDUSTRIAL AREA, GREATER NOIDA - 201306 G. B. NAGAR (U.P.) INDIA
E-mail : info@ultimaswitchgear.com

DRAWING	BILL OF MATERIAL	JOB NO.
TITLE	415V AC DISTRIBUTION BOARD (2A) (MCRB)	1241A
CA NO.	CC/T/W-AIS/DOM/A10/23/01956/NOA-1/24-102643/01 & 02 DATED 23.02.2024	
PROJECT	765/400/220KV BIKANER-III POOLING STATION	
CLIENT	POWER GRID CORPORATION OF INDIA LIMITED	CONTRACTOR:- BHARAT HEAVY ELECTRICAL LIMITED (BHEL) TRANSMISSION PROJECTS DIVISION
DRG. NO.	USL/PGCIL/BHEL/2024-2025/1241A-702	SH. NO. 02 OF 06

BILL OF MATERIAL FOR 415V AC DISTRIBUTION BOARD (2A) (MCRB)

S.NO.	ITEM CODE	DESCRIPTION	MAKE	RATING	QTY.
B	BILL OF MATERIAL FOR MODULE - (AE-BC) BUS-COUPLER				1 No.
1	52D	TP ACB 415V,EDO, WITHOUT RELEASE, 1. SPRING CHARGE MOTOR 220V DC WITH SPRING CHARGE SWITCH 2. CLOSING RELEASE 220V DC 3. SHUNT RELEASE 220V DC 4. LIMIT SWITCH FOR TEST/ISOLATE/SERVICE POSITION 5. 4NO + 4NC POTENTIAL FREE CONTACT.	L&T/C&S/HAVELLS	800A, 50kA	01
2	CF1-10	HRC FUSE BASE	L&T/C&S/HAVELLS	20A	10
3	CF1-10	HRC FUSE LINK	L&T/C&S/HAVELLS	6A	10
4		AUX. CONTACTOR RELAY, COIL VOLTAGE 220V DC WITH 2NO+2NC AUX. CONTACT	L&T/C&S/HAVELLS	--	04
5		AUX. CONTACTOR RELAY, COIL VOLTAGE 220V DC WITH 4NO AUX. CONTACT	L&T/C&S/HAVELLS	--	02
6		2NO+2NC ADD ON BLOCK	L&T/C&S/HAVELLS	--	01
7		4NO ADD ON BLOCK	L&T/C&S/HAVELLS	--	01
8	MCB	DP MINIATURE CIRCUIT BREAKER, DC TYPE	L&T/C&S/HAVELLS	10A, 4kA	01
9	MCT₃	CURRENT TRANSFORMER, RESIN CAST TYPE	NEWTEK/AE/PRECISE/PROCOM/AS HMOR	800/1A, CL-1.0, 7.5VA	03
10	PCT₃	CURRENT TRANSFORMER, RESIN CAST TYPE	NEWTEK/AE/PRECISE/PROCOM/AS HMOR	800/1A, CL-5P15, 7.5VA	04
11	A	ANALOG AMMETER, SINGLE PHASE, SIZE-96X96 Sq. mm, CL-1.0, CTR-/1A	AE/RISHAB/NEWTEK/SECURE	0-800A	01
12	ASS	AMMETER SELECTOR SWITCH, ROTARY TYPE	SALZER/KAYCEE	6A	01
13	Vt	AC VOLTAGE TRANSDUCER, SINGLE OUTPUT- 4-20mA, PTR-415V AC, AUX. SUPPLY 220V DC	AE/RISHAB/SECURE	--	03
14	Ct	AC CURRENT TRANSDUCER, OUTPUT- 4-20mA, WITH SINGLE OUTPUT, AUX. SUPPLY 220V DC	AE/RISHAB/SECURE	800/1A	03
15	TNC	BREAKER CONTROL SWITCH	SALZER/KAYCEE	16A	01
16	A/M	AUTO/MANUAL SELECTOR SWITCH WITH OFF, 3POLE 2WAY, ROTARY TYPE	SALZER/KAYCEE	6A	01
17	h1	'ON' INDICATION LAMP, 22.5 Sq. mm. DIA ,LED TYPE, RED	ESBEE/VAISHNO/C&S	220V DC	01
18	h2	'OFF' INDICATION LAMP, 22.5 Sq. mm. DIA ,LED TYPE, GREEN	ESBEE/VAISHNO/C&S	220V DC	01
19	h5	'SPRING CHARGE' INDICATION LAMP, 22.5 Sq. mm. DIA ,LED TYPE, BLUE	ESBEE/VAISHNO/C&S	220V DC	01
20	T3	'ON' INDICATION LAMP, 22.5 Sq. mm. DIA ,LED TYPE, RED	GIC/PGCIL APPROVED MAKE	220V DC	01
21	86	HIGH SPEED TRIPING RELAY WITH 3NO+1NC CONTACT (AUTO RESET HIGH SPEED), AUX. SUPPLY 220V DC	L&T/JVS/C&S	--	01
22	50 + 51	TRIPLE POLE INSTANTANEOUS OVER-CURRENT RELAY HAVING THE SETTING RANGE OF 200-800% OR 500-2000% OF CT SECONDARY AND ADJUSTABLE DEFINITE MINIMUM TIME, AUX. SUPPLY 220V DC .	L&T/JVS/C&S	-/1A	01
23	50N + 51N	INSTANTANEOUS EARTH FAULT RELAY HAVING AN ADJUSTABLE SETTING RANGE OF 10-40% OR 20 - 80% OF CT SECONDARY CURRENT AND ADJUSTABLE DEFINITE MINIMUM TIME. THE EARTH FAULT RELAY SHALL BE PROVIDED WITH A STABILISING RESISTOR, AUX. SUPPLY 220V DC.	L&T/JVS/C&S	-/1A	01
C	BILL OF MATERIAL FOR MODULE - (G2)				2 Nos.
1	CF1-3	HRC FUSE BASE	L&T/C&S/HAVELLS	20A	03
2	CF1-3	HRC FUSE LINK	L&T/C&S/HAVELLS	2A	03
3	V	ANALOG VOLTMETER, SINGLE PHASE, SIZE-96X96 Sq. mm, CL-1.0, PTR-415AC	AE/RISHAB/NEWTEK/SECURE	0-500V	01
4	VSS	FOUR POSITION VOLTMETER SELECTOR SWITCH, ROTARY TYPE	SALZER/KAYCEE	6A	01
5	R-PHASE	'R' INDICATION LAMP, 22.5 Sq. mm. DIA ,LED TYPE, RED	ESBEE/VAISHNO/C&S	240V AC	01
6	Y-PHASE	'Y' INDICATION LAMP, 22.5 Sq. mm. DIA ,LED TYPE, YELLOW	ESBEE/VAISHNO/C&S	240V AC	01
7	B-PHASE	'B' INDICATION LAMP, 22.5 Sq. mm. DIA ,LED TYPE, BLUE	ESBEE/VAISHNO/C&S	240V AC	01

NOTE:- ALL COMPONENTS SHALL BE POWER GRID (QA&I) APPROVED MAKE

	04.	-	DRAWN	MP	
	03.	-	CHKD.	VDP	
	02.	-	APPD.	--	
	01.	-	ALL DIMENSIONS IN mm. SIGN.		
29.01.2025	00.	FIRST SUBMISSION FOR APPROVAL	TOLERANCE 5%		
DATE	No.	REVISIONS DESCRIPTION	REVISIONS : 00		

MANUFACTURER

 **ULTIMA SWITCHGEARS LTD.**

UNIT-I KHASRA NO. 215, IND. AREA, VILLAGE RAIPUR (BHAGWANPUR),
TEHSIL - ROORKEE, DISTRICT HARIDWAR (UTTRAKHAND) -
247687, INDIA, TEL : 01332-235043 FAX : 01332-235042
UNIT-II F-6 & F-7, SITE-C, UPSIDC, SURAJPUR INDUSTRIAL AREA,
GREATER NOIDA - 201306 G. B. NAGAR (U.P.) INDIA
E-mail : info@ultimaswitchgear.com

DRAWING	BILL OF MATERIAL	JOB NO.
TITLE	415V AC DISTRIBUTION BOARD (2A) (MCRB)	1241A
CAT NO.	CC/T/W-AIS/DOA/A10/23/01956/NOA-1/24-102643/01 & 02 DATED 23.02.2024	
PROJECT	765/400/220KV BIKANER-III POOLING STATION	
CLIENT	CONTRACTOR:-	
 POWER GRID CORPORATION OF INDIA LIMITED	 BHARAT HEAVY ELECTRICAL LIMITED (BHEL)	TRANSMISSION PROJECTS DIVISION
DRG. NO.	USL/PGCIL/BHEL/2024-2025/1241A-702	SH. NO. 03 OF 06

[Handwritten Signature]

BILL OF MATERIAL FOR 415V AC DISTRIBUTION BOARD (2A) (MCRB)

S.NO.	ITEM CODE	DESCRIPTION	MAKE	RATING	QTY.
D	BILL OF MATERIAL FOR MODULE - (DG1)				1 No.
1	52C	FP ACB 415V AC, EDO, WITHOUT RELEASE, 1. SPRING CHARGE MOTOR 220V DC WITH SPRING CHARGE SWITCH 2. CLOSING RELEASE 220V DC 3. SHUNT RELEASE 220V DC 4. LIMIT SWITCH FOR TEST/ISOLATE/SERVICE POSITION 5. 4NO + 4NC POTENTIAL FREE CONTACT.	L&T/C&S/HAVELLS	800A, 50kA	01
2	CF1-13	HRC FUSE BASE	L&T/C&S/HAVELLS	20A	13
3	CF1-13	HRC FUSE LINK	L&T/C&S/HAVELLS	6A	13
4		AUX. CONTACTOR RELAY, COIL VOLTAGE 220V DC WITH 2NO+2NC AUX. CONTACT	L&T/C&S/HAVELLS	--	03
5		2NO+2NC ADD ON BLOCK	L&T/C&S/HAVELLS	--	01
6	MCB	DP MINIATURE CIRCUIT BREAKER, DC TYPE	L&T/C&S/HAVELLS	10A	02
7	MCT₁	CURRENT TRANSFORMER, RESIN CAST TYPE	NEWTEK/AE/PRECISE/PROCOM/ASHMOR	800/1A, CL-1, 7.5VA	03
8	PCT₁	CURRENT TRANSFORMER, RESIN CAST TYPE	NEWTEK/AE/PRECISE/PROCOM/ASHMOR	800/1A, CL-5P15, 7.5VA	03
9	PSCT₁	CURRENT TRANSFORMER, RESIN CAST TYPE	NEWTEK/AE/PRECISE/PROCOM/ASHMOR	800/1A, CL-PS, 7.5VA, V _x =300V	06*
10	Hz	FREQUENCY METER (Hz), 110V AC	NEWTEK/AE/PRECISE/PROCOM/ASHMOR	45Hz-55Hz	01
11	KWH	DIGITAL KILO WATT HOUR METER WITH SIX DIGITS AND MINIMUM COUNT OF ONE KWH, 110V AC 3Ph 4 WIRE, SIZE - 96 X 96 Sq.mm., AUX. SUPPLY 240V AC	AE/RISHAB/NEWTEK/SECURE	800/1A	01
12	KW	DIGITAL KILO WATT METER, 110V AC 3Ph 4 WIRE, 0-300KW RANGE, AUX. SUPPLY 240V AC	AE/RISHAB/NEWTEK/SECURE	800/1A	01
13	A	ANALOG AMMETER, SINGLE PHASE, SIZE-96X96 Sq. mm, CL-1.0, CTR-/1A	AE/RISHAB/NEWTEK/SECURE /PGCIL APPROVED MAKE	0-800A	01
14	V	ANALOG VOLTMETER, SINGLE PHASE, SIZE-96X96 Sq. mm, CL-1.0, PTR-(415/√3 V)/(110/√3V) AC		0-500V	01
15	A/M	AUTO/MANUAL SELECTOR SWITCH, 3POLE 2WAY WITH OFF, ROTARY TYPE	SALZER/KAYCEE	6A	01
16	ASS	AMMETER SELECTOR SWITCH, ROTARY TYPE	SALZER/KAYCEE	6A	01
17	VSS	FOUR POSITION VOLTMETER SELECTOR SWITCH, ROTARY TYPE	SALZER/KAYCEE	6A	01
18	TNC	BREAKER CONTROL SWITCH, ROTARY TYPE	SALZER/KAYCEE	16A	01
19	51V	THREE POLE VOLTAGE CONTROLLED DEFINITE TIME OVER CURRENT RELAY, SETTING 50-200% OF CT SECONDARY CURRENT. A TIME DELAY 2.5-3SEC. CONNECTED IN CT OF Y PHASE FOR OVERLOAD ALARM, AUX. SUPPLY 220V DC, PTR-(415/√3 V)/(110/√3V) AC	L&T/JVS/C&S	800/1A	01
20	95	SINGLE POLE NON DIRECTIONAL DEFINITE TIME OVER CURRENT RELAY WITH INBUILT TIMER SETTING RANGE 50-200% IN STEP OF 10% TIME DELAY RANGE 0-25 SEC IN STEP OF 0.1 SEC, AUX. SUPPLY 220V DC, SETTING RATIO OF NOT LESS THAN 90%.	L&T/JVS/C&S	800/1A	01

*PROTECTION CT 3 NOS. WILL BE SUPPLIED LOOSE FOR MOUNTING IN DG SET PANEL

	04.	-	DRAWN	MP	
	03.	-	CHKD.	VDP	
	02.	-	APPD.	--	
	01.		ALL DIMENSIONS IN mm.	SIGN.	
29.01.2025	00.	FIRST SUBMISSION FOR APPROVAL	TOLERANCE 5%		
DATE	No.	REVISIONS DESCRIPTION	REVISIONS : 00		

MANUFACTURER

 **ULTIMA SWITCHGEARS LTD.**

UNIT-I KHASRA NO. 215, IND. AREA, VILLAGE RAIPUR (BHAGWANPUR), TEHSIL - ROORKEE, DISTRICT HARIDWAR (UTTRAKHAND) - 247687, INDIA, TEL : 01332-235043 FAX : 01332-235042

UNIT-II F-6 & F-7, SITE-C, UPSIDC, SURAJPUR INDUSTRIAL AREA, GREATER NOIDA - 201306 G. B. NAGAR (U.P.) INDIA

E-mail : info@ultimaswitchgear.com

DRAWING	BILL OF MATERIAL	JOB NO.
TITLE	415V AC DISTRIBUTION BOARD (2A) (MCRB)	1241A
CA NO.	CC/T/W-AIS/DOM/A10/23/01956/NOA-1/24-102643/01 & 02 DATED 23.02.2024	
PROJECT	765/400/220KV BIKANER-III POOLING STATION	
CLIENT	POWER GRID CORPORATION OF INDIA LIMITED	CONTRACTOR:- BHARAT HEAVY ELECTRICAL LIMITED (BHEL) TRANSMISSION PROJECTS DIVISION
DRG. NO.	USL/PGCIL/BHEL/2024-2025/1241A-702	SH. NO. 04 OF 06

[Handwritten Signature]

BILL OF MATERIAL FOR 415V AC DISTRIBUTION BOARD (2A) (MCRB)

S.NO.	ITEM CODE	DESCRIPTION	MAKE	RATING	QTY.
D	BILL OF MATERIAL FOR MODULE - (DG1)				1 No.
21	86	HIGH SPEED TRIPING RELAY WITH 3NO+1NC CONTACT (AUTO RESET HIGH SPEED), AUX. SUPPLY 220V DC	L&T/JVS/C&S	--	01
22	87	THREE POLE DIFFERENTIAL PROTECTION RELAY HAVING AN OPERATING CURRENT SETTING RANGE OF 10-40% OF GENERATOR FULL LOAD CURRENT. THE RELAY SHALL BE OF HIGH IMPEDANCE TYPE, WITH NECESSARY STABILIZING RESISTORS., AUX. SUPPLY 220V DC	L&T/JVS/C&S	800/1A	01
23	Vt	AC VOLTAGE TRANSDUCER, SINGLE OUTPUT- 4-20mA, PTR-(415/ $\sqrt{3}$ V)/(110/ $\sqrt{3}$ V) AC, AUX. SUPPLY 220V DC	AE/RISHAB/SECURE	--	03
24	Ct	AC CURRENT TRANSDUCER, OUTPUT- 4-20mA, WITH SINGLE OUTPUT, AUX. SUPPLY 220V DC	AE/RISHAB/SECURE	800/1A	03
25	R-PHASE	'R' INDICATION LAMP, 22.5 Sq. mm. DIA ,LED TYPE, RED	ESBEE/VAISHNO/C&S	63.5V AC	01
26	Y-PHASE	'Y' INDICATION LAMP, 22.5 Sq. mm. DIA ,LED TYPE, YELLOW	ESBEE/VAISHNO/C&S	63.5V AC	01
27	B-PHASE	'B' INDICATION LAMP, 22.5 Sq. mm. DIA ,LED TYPE, BLUE	ESBEE/VAISHNO/C&S	63.5V AC	01
28	h1	'ON' INDICATION LAMP, 22.5 Sq. mm. DIA ,LED TYPE, RED	ESBEE/VAISHNO/C&S	220V DC	01
29	h2	'OFF' INDICATION LAMP, 22.5 Sq. mm. DIA ,LED TYPE, GREEN	ESBEE/VAISHNO/C&S	220V DC	01
30	h3	'TRIP' INDICATION LAMP, 22.5 Sq. mm. DIA ,LED TYPE, AMBER	ESBEE/VAISHNO/C&S	220V DC	01
31	h5	'SPRING CHARGE' INDICATION LAMP, 22.5 Sq. mm. DIA ,LED TYPE, BLUE	ESBEE/VAISHNO/C&S	220V DC	01
32	P1	'STOP' PUSH BUTTON, SPRING RETURN TYPE, 22.5 Sq. mm. DIA WITH 2NC CONTACT, RED	ESBEE/VAISHNO/C&S	220V DC	01
33	P2	'START' PUSH BUTTON, SPRING RETURN TYPE, 22.5 Sq. mm. DIA WITH 2NO CONTACT, GREEN	ESBEE/VAISHNO/C&S	220V DC	01
34	BUS-PT	(415/ $\sqrt{3}$ V)/(110/ $\sqrt{3}$ V)VOLTS SINGLE PHASE VOLTAGE TRANSFORMER STAR/STAR CONNECT WITH STAR POINT SOLIDLY EARTHED MOUNTED ON COMMON DRAW OUT CHASSIS. ACCURACY CLASS 0.5 FOR PROTECTION AND METERING WITH 50VA BURDEN.	NEWTEK/AE/PRECISE/PROCOM /ASHMOR	--	03
E	BILL OF MATERIAL FOR MISC.				
1	MCB	DP MINIATURE CIRCUIT BREAKER, 'C' CURVE	L&T/C&S/HAVELLS	25A, 10kA	01
2	MCB	DP MINIATURE CIRCUIT BREAKER, DC TYPE	L&T/C&S/HAVELLS	25A	02
3	MCB	SP MINIATURE CIRCUIT BREAKER, 'C' CURVE	L&T/C&S/HAVELLS	16A, 10kA	11
4	SW - SOCKET	SWITCH WITH SOCKET	ANCHOR/REPUTED	5/15A	03
5	SS	SELECTOR SWITCH, 2P, 2W WITH OFF	SALZER/KAYCEE	32A	01
6	DS	DOOR SWITCH	SURAJ/REPUTED	1 C/O	11
7	PL	PANEL ILLUMINATION LIGHT, 240V AC	COMPACT/REPUTED	5W	11
8	SH	SPACE HEATER, 240V AC	HOTWEL/REPUTED	60W	11
9	TH	THERMOSTATE	ELCON/REPUTED	30 - 85°C	11
10	TS	TOGGLE SWITCH	FTC/REPUTED	6A	11

NOTE:- ALL COMPONENTS SHALL BE POWER GRID (QA&I) APPROVED MAKE

	04.	-	DRAWN	MP	
	03.	-	CHKD.	VDP	
	02.	-	APPD.	--	
	01.		ALL DIMENSIONS IN mm. SIGN.		
29.01.2025	00.	FIRST SUBMISSION FOR APPROVAL	TOLERANCE 5%		
DATE	No.	REVISIONS DESCRIPTION	REVISIONS : 00		

MANUFACTURER

ULTIMA SWITCHGEARS LTD.

UNIT-I KHASRA NO. 215, IND. AREA, VILLAGE RAIPUR (BHAGWANPUR), TEHSIL - ROORKEE, DISTRICT HARIDWAR (UTTRAKHAND) - 247687, INDIA, TEL : 01332-235043 FAX : 01332-235042

UNIT-II F-6 & F-7, SITE-C, UPSIDC, SURAJPUR INDUSTRIAL AREA, GREATER NOIDA - 201306 G. B. NAGAR (U.P.) INDIA

E-mail : info@ultimaswitchgear.com

DRAWING	BILL OF MATERIAL	JOB NO.
TITLE	415V AC DISTRIBUTION BOARD (2A) (MCRB)	1241A
CA NO.	CC/T/W-AIS/DOM/A10/23/01956/NOA-1/24-102643/01 & 02 DATED 23.02.2024	
PROJECT	765/400/220KV BIKANER-III POOLING STATION	
CLIENT POWER GRID CORPORATION OF INDIA LIMITED		CONTRACTOR:- BHARAT HEAVY ELECTRICAL LIMITED (BHEL) TRANSMISSION PROJECTS DIVISION
DRG. NO.	USL/PGCIL/BHEL/2024-2025/1241A-702	SH. NO. 05 OF 06

This Drawing & information or descriptive matter set out hereon are the confidential property of **ULTIMA SWITCHGEARS LIMITED** & must not be disclosed, copied,loaned or used for manufacturing,tendering or for any other purpose without their permission.

[Handwritten Signature]

BILL OF MATERIAL FOR 415V AC DISTRIBUTION BOARD (2A) (MCRB)

S.NO.	ITEM CODE	DESCRIPTION	MAKE	RATING	QTY.
F	BILL OF MATERIAL FOR MODULE - (E) FOR OUTGOINGS				
1	MCCB	FP MCCB 415V, WITH THERMAL MAGNETIC BASED RELEASE FOR O/L,S/C PROTECTION WITH SPREADER & EXTENDED ROM, Ics = 100% Icu	L&T/C&S/HAVELLS	400A, 20kA	02
2	MCCB	FP MCCB 415V, WITH THERMAL MAGNETIC BASED RELEASE FOR O/L,S/C PROTECTION WITH SPREADER & EXTENDED ROM, Ics = 100% Icu	L&T/C&S/HAVELLS	200A, 20kA	03
3	MCCB	FP MCCB 415V, WITH THERMAL MAGNETIC BASED RELEASE FOR O/L,S/C PROTECTION WITH SPREADER & EXTENDED ROM, Ics = 100% Icu	L&T/C&S/HAVELLS	100A, 20kA	35
4	MCCB	FP MCCB 415V, WITH THERMAL MAGNETIC BASED RELEASE FOR O/L,S/C PROTECTION WITH EXTENDED ROM, Ics = 100% Icu	L&T/C&S/HAVELLS	63A, 20kA	91
5	MCCB	FP MCCB 415V, WITH THERMAL MAGNETIC BASED RELEASE FOR O/L,S/C PROTECTION WITH EXTENDED ROM, Ics = 100% Icu	L&T/C&S/HAVELLS	32A, 20kA	13
6	MCB	SPN MINIATURE CIRCUIT BREAKER, 'C' CURVE	L&T/C&S/HAVELLS	32A, 10kA	16

NOTE:- ALL COMPONENTS SHALL BE POWER GRID (QA&I) APPROVED MAKE

	04.	—	DRAWN	MP	
	03.	—	CHKD.	VDP	
	02.	—	APPD.	—	
	01.		ALL DIMENSIONS IN mm. SIGN.		
29.01.2025	00.	FIRST SUBMISSION FOR APPROVAL	TOLERANCE 5%		
DATE	No.	REVISIONS DESCRIPTION	REVISIONS : 00		

MANUFACTURER
ULTIMA® SWITCHGEARS LTD.

UNIT-I KHASRA NO. 215, IND. AREA, VILLAGE RAIPUR (BHAGWANPUR), TEHSIL - ROORKEE, DISTRICT HARIDWAR (UTTRAKHAND) - 247667, INDIA, TEL : 01332-235043 FAX : 01332-235042
UNIT-II F-6 & F-7, SITE-C, UPSIDC, SURAJPUR INDUSTRIAL AREA, GREATER NOIDA - 201306 G. B. NAGAR (U.P.) INDIA
E-mail : info@ultimaswitchgear.com

DRAWING	BILL OF MATERIAL	JOB NO.
TITLE	415V AC DISTRIBUTION BOARD (2A) (MCRB)	1241A
CA NO.	CC/T/W-AIS/DOM/A10/23/01956/NOA-1/24-102643/01 & 02 DATED 23.02.2024	
PROJECT	765/400/220KV BIKANER-III POOLING STATION	
CLIENT POWER GRID CORPORATION OF INDIA LIMITED		CONTRACTOR:- BHARAT HEAVY ELECTRICAL LIMITED (BHEL) TRANSMISSION PROJECTS DIVISION
DRG. NO.	USL/PGCIL/BHEL/2024-2025/1241A-702	SH. NO. 06 OF 06

This Drawing & information or descriptive matter set out hereon are the confidential property of **ULTIMA SWITCHGEARS LIMITED** & must not be disclosed, copied, loaned or used for manufacturing, tendering or for any other purpose without their permission.

[Handwritten Signature]

ENGINEERING DRAWING DETAILS FOR
415V MAIN LIGHTING DISTRIBUTION BOARD (3A) (MCRB)


PROJECT :- 765/400/220kV BIKANER-III POOLING STATION
CLIENT :- POWER GRID CORPORATION OF INDIA LIMITED
CONTRACTOR :- BHARAT HEAVY ELECTRICAL LIMITED (BHEL)
TRANSMISSION PROJECTS DIVISION

	04.	-	DRAWN	MP	
	03.	-	CHKD.	VDP	
	02.	-	APPD.	--	
	01.		ALL DIMENSIONS IN mm. SIGN.		
29.01.2025	00.	FIRST SUBMISSION FOR APPROVAL	TOLERANCE 5%		
DATE	No.	REVISIONS DESCRIPTION	REVISIONS : 00		


MANUFACTURER
ULTIMA[®] SWITCHGEARS LTD.

UNIT-I KHASRA NO. 215, IND. AREA, VILLAGE RAIPUR (BHAGWANPUR),
TEHSIL - ROORKEE, DISTRICT HARIDWAR (UTTRAKHAND) -
247667, INDIA, TEL : 01332-235043 FAX : 01332-235042
UNIT-II F-6 & F-7, SITE-C, UPSIDC, SURAJPUR INDUSTRIAL AREA,
GREATER NOIDA - 201306 G. B. NAGAR (U.P.) INDIA
E-mail : info@ultimaswitchgear.com

DRAWING	COVER PAGE	JOB NO.
TITLE	415V MAIN LIGHTING DISTRIBUTION BOARD (3A) (MCRB)	1241A
CA NO.	CC/T/W-AIS/DOM/A10/23/01956/NOA-1/24-102643/01 & 02 DATED 23.02.2024	
PROJECT	765/400/220KV BIKANER-III POOLING STATION	
CLIENT POWER GRID CORPORATION OF INDIA LIMITED		CONTRACTOR:- BHARAT HEAVY ELECTRICAL LIMITED (BHEL) TRANSMISSION PROJECTS DIVISION
DRG. NO.	USL/PGCIL/BHEL/2024-2025/1241A-003	SH. NO. 01 OF 01

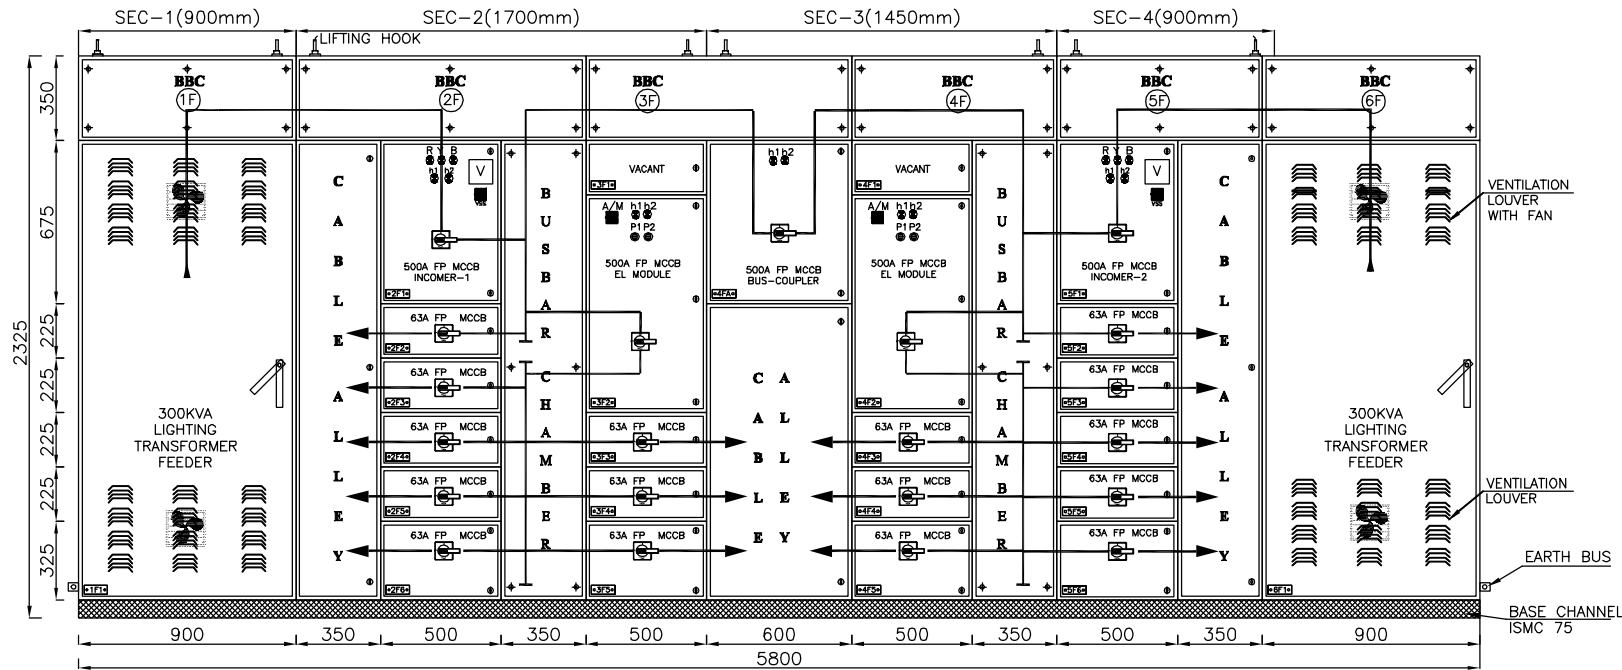

FRONT VIEW

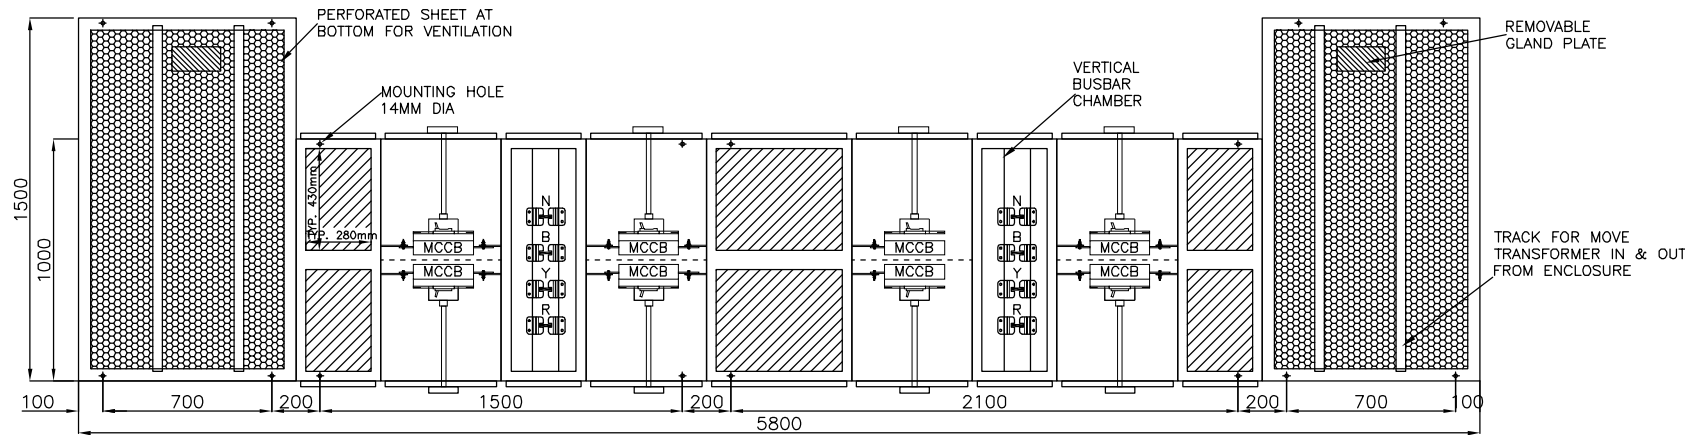

BOTTOM VIEW

04.	—	DRAWN	MP	
03.	—	CHKD.	VDP	
02.	—	APPD.	—	
01.	—	ALL DIMENSIONS IN mm.	SIGN.	
29.01.2025	00.	FIRST SUBMISSION FOR APPROVAL	TOLERANCE 5%	
DATE	No.	REVISIONS DESCRIPTION	REVISIONS : 00	

MANUFACTURER

ULTIMA SWITCHGEARS LTD.

UNIT-I KHASRA NO. 215, IND. AREA, VILLAGE RAIPUR (BHAGWANPUR), TEHSIL - ROORKEE, DISTRICT HARIDWAR (UTTRAKHAND) - 247687, INDIA, TEL : 01332-235043 FAX : 01332-235042


UNIT-II F-6 & F-7, SITE-C, UPSIDC, SURAJPUR INDUSTRIAL AREA, GREATER NOIDA - 201306 G. B. NAGAR (U.P.) INDIA

E-mail : info@ultimaswitchgear.com

DRAWING	GENERAL ARRANGEMENT DRAWING	JOB NO.
TITLE	415V MAIN LIGHTING DISTRIBUTION BOARD (3A) (MCRB)	1241A
CA NO.	CC/T/W-AIS/DOM/A10/23/01956/NOA-1/24-102643/01 & 02 DATED 23.02.2024	
PROJECT	765/400/220KV BIKANER-III POOLING STATION	
CLIENT	POWER GRID CORPORATION OF INDIA LIMITED	CONTRACTOR:-
		BHARAT HEAVY ELECTRICAL LIMITED (BHEL) TRANSMISSION PROJECTS DIVISION
DRG. NO.	USL/PGCIL/BHEL/2024-2025/1241A-103	SH. NO. 01 OF 03

This Drawing & information or descriptive matter set out hereon are the confidential property of **ULTIMA SWITCHGEARS LIMITED** & must not be disclosed, copied,loaned or used for manufacturing,tendering or for any other purpose without their permission.

Handwritten signature

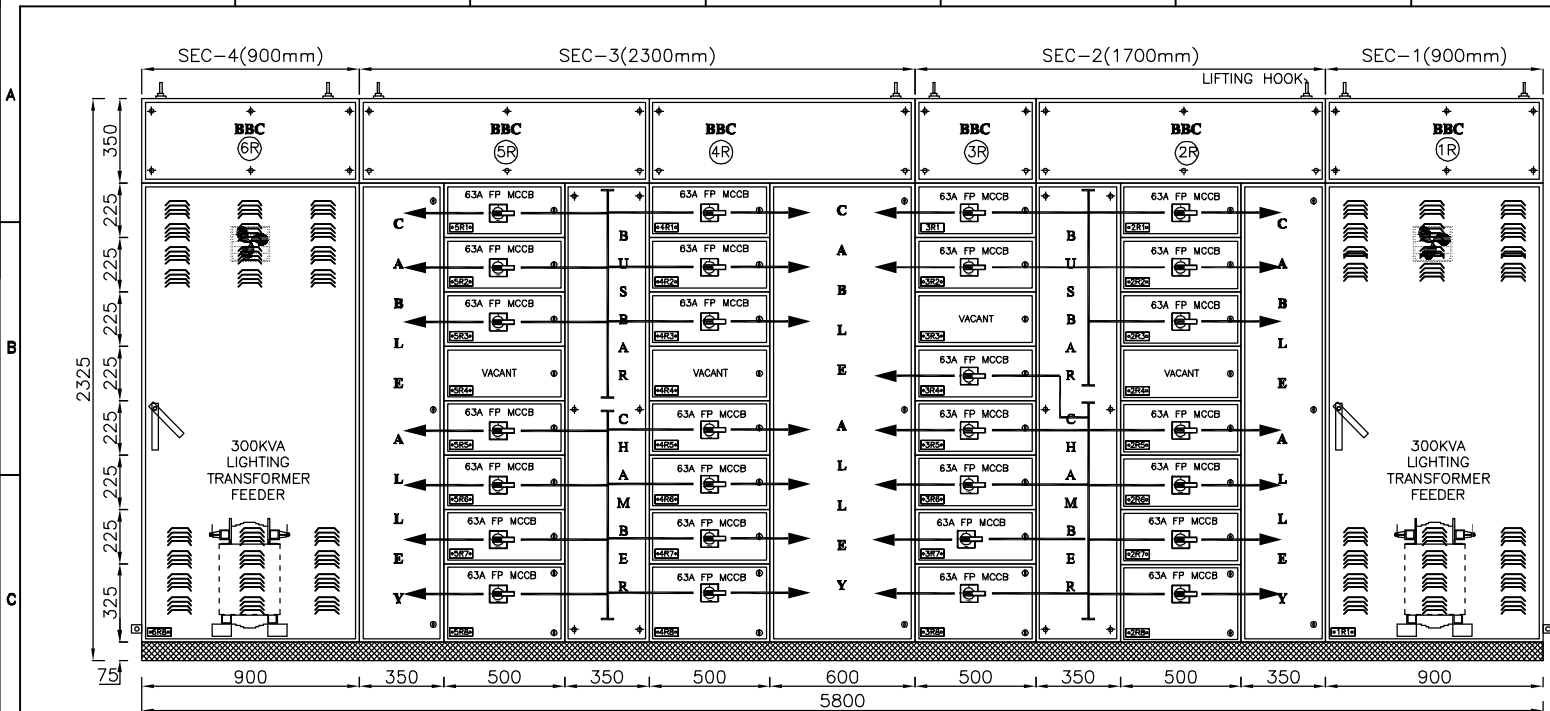

REAR VIEW

PANEL DIMENSIONS

HEIGHT 2325 mm.
WIDTH 5800 mm.
DEPTH 1500/1000 mm.

CABLE ENTRY

BOTTOM ENTRY

HORIZONTAL BUS BAR SIZE :-

PHASE : 1x50x10 Sq.mm AL.
NEUTRAL : 1x50x06 Sq.mm AL.
EARTH : 1x50x06 Sq.mm. GS.

VERTICAL BUS BAR SIZE :-

PHASE : 1X50X10 SQ.MM AL.
NEUTRAL : 1X50X06 SQ.MM AL.

LEGEND DESCRIPTION

- R = R-PHASE INDICATION (RED)
- Y = Y-PHASE INDICATION (YELLOW)
- B = B-PHASE INDICATION (BLUE)
- h1 = ON INDICATION RED
- h2 = OFF INDICATION GREEN
- A = DIGITAL AMMETER
- V = DIGITAL VOLT METER
- ASS = AMMETER SELECTOR SWITCH
- VSS = VOLTAGE SELECTOR SWITCH
- P1 = CONTACTOR OFF PUSH BUTTON
- P2 = CONTACTOR ON PUSH BUTTON
- A/M = AUTO/MANUAL SELECTOR SWITCH

	04.	—	DRAWN	MP	
	03.	—	CHKD.	VDP	
	02.	—	APPD.	—	
	01.		ALL DIMENSIONS IN mm. SIGN.		
29.01.2025	00.	FIRST SUBMISSION FOR APPROVAL	TOLERANCE 5%		
DATE	No.	REVISIONS DESCRIPTION	REVISIONS : 00		






MANUFACTURER

ULTIMA SWITCHGEARS LTD.

UNIT-I KHASRA NO. 215, IND. AREA, VILLAGE RAIPUR (BHAGWANPUR),
TEHSIL - ROORKEE, DISTRICT HARIDWAR (UTTRAKHAND) -
247667, INDIA, TEL : 01332-235043 FAX : 01332-235042
UNIT-II F-6 & F-7, SITE-C, UPSIDC, SURAJPUR INDUSTRIAL AREA,
GREATER NOIDA - 201306 G. B. NAGAR (U.P.) INDIA
E-mail : info@ultimaswitchgear.com

DRAWING	GENERAL ARRANGEMENT DRAWING	JOB NO.
TITLE	415V MAIN LIGHTING DISTRIBUTION BOARD (3A) (MCRB)	1241A
CA NO.	CC/T/W-AIS/DOM/A10/23/01956/NOA-1/24-102643/01 & 02 DATED 23.02.2024	
PROJECT	765/400/220KV BIKANER-III POOLING STATION	
CLIENT POWER GRID CORPORATION OF INDIA LIMITED		CONTRACTOR:- BHARAT HEAVY ELECTRICAL LIMITED (BHEL) TRANSMISSION PROJECTS DIVISION
DRG. NO.	USL/PGCIL/BHEL/2024-2025/1241A-103	SH. NO. 02 OF 03

This Drawing & information or descriptive matter set out hereon are the confidential property of **ULTIMA SWITCHGEARS LIMITED** & must not be disclosed, copied,loaned or used for manufacturing,tendering or for any other purpose without their permission.

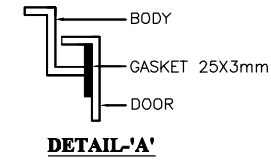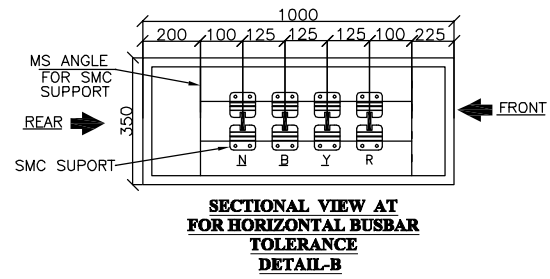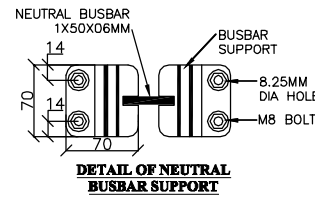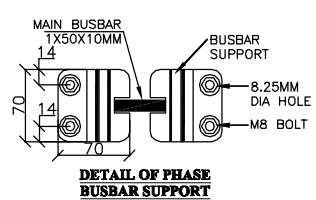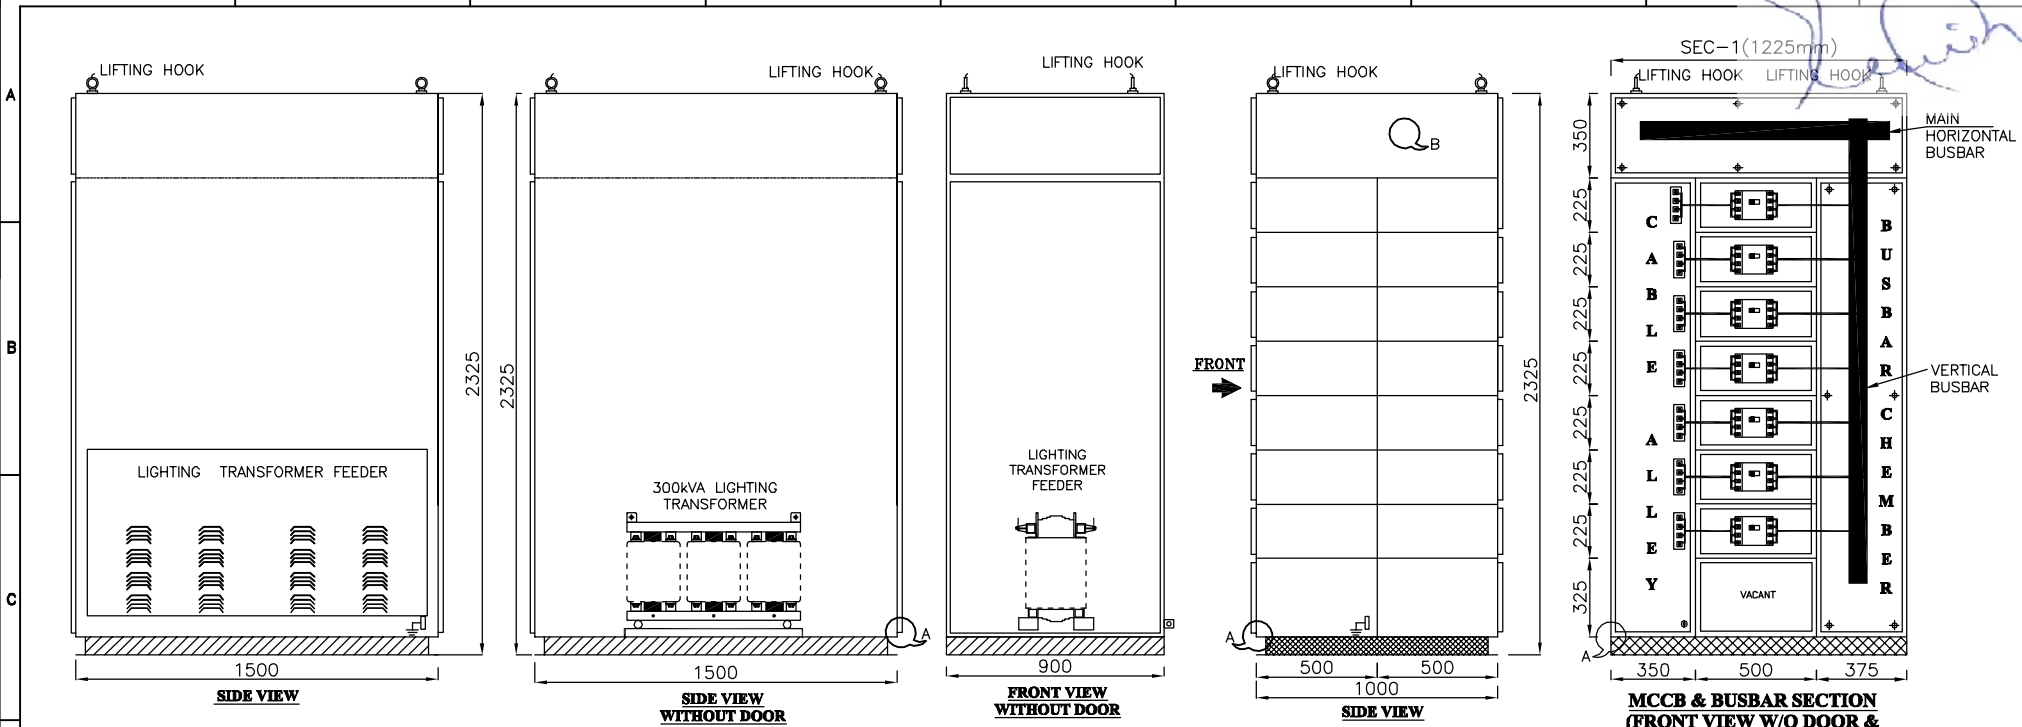


	04.	—	DRAWN	MP	
	03.	—	CHKD.	VDP	
	02.	—	APPD.	—	
	01.	—	ALL DIMENSIONS IN mm.	SIGN.	
29.01.2025	00.	FIRST SUBMISSION FOR APPROVAL	TOLERANCE 5%		
DATE	No.	REVISIONS DESCRIPTION	REVISIONS : 00		

MANUFACTURER
ULTIMA SWITCHGEARS LTD.
UNIT-I KHASRA NO. 215, IND. AREA, VILLAGE RAIPUR (BHAGWANPUR),
TEHSIL - ROORKEE, DISTRICT HARIDWAR (UTTRAKHAND) -
247687, INDIA, TEL : 01332-235043 FAX : 01332-235042
UNIT-II F-6 & F-7, SITE-C, UPSIDC, SURAJPUR INDUSTRIAL AREA,
GREATER NOIDA - 201306 G. B. NAGAR (U.P.) INDIA
E-mail : info@ultimaswitchgear.com

DRAWING	GENERAL ARRANGEMENT DRAWING	JOB NO.
TITLE	415V MAIN LIGHTING DISTRIBUTION BOARD (3A) (MCRB)	1241A
CA NO.	CC/T/W-AIS/DOM/A10/23/01956/NOA-1/24-102643/01 & 02 DATED 23.02.2024	
PROJECT	765/400/220KV BIKANER-III POOLING STATION	
CLIENT	POWER GRID CORPORATION OF INDIA LIMITED	CONTRACTOR:- BHARAT HEAVY ELECTRICAL LIMITED (BHEL) TRANSMISSION PROJECTS DIVISION
DRG. NO.	USL/PGCIL/BHEL/2024-2025/1241A-103	SH. NO. 03 OF 03

TB202359-1002269-SS3480-LTSWR-DRG/00/CAT-I/Page: 99 of 258

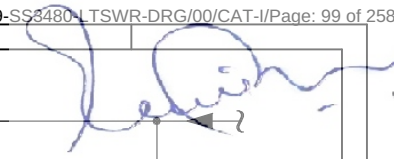D**F**

MANUFACTURER


 **ULTIMA® SWITCHGEARS LTD.**

UNIT-I KHASRA NO. 215, IND. AREA, VILLAGE RAIPUR (BHAGWANPUR
TEHSIL - ROORKEE, DISTRICT HARIDWAR (UTTRAKHAND) -
247867, INDIA, TEL: 01332-235043 FAX : 01332-235042

UNIT-II F-6 & F-7, SITE-C, UPSIDC, SURAJPUR INDUSTRIAL AREA,
GREATER NOIDA - 201306 G. B. NAGAR (U.P.) INDIA

E-mail : info@ultimaswitchgear.com

DRAWING	SINGLE LINE DIAGRAM	JOB NO.
TITLE	415V MAIN LIGHTING DISTRIBUTION BOARD (3A) (MCRB)	1241A
CA NO.	CC/T/W-AIS/DOM/A10/23/01956/NOA-1/24-102643/01 & 02 DATED 23.02.2024	
PROJECT	765/400/220KV BIKANER-III POOLING STATION	
 CLIENT POWER GRID CORPORATION OF INDIA LIMITED	 CONTRACTOR:- BHARAT HEAVY ELECTRICAL LIMITED (BHEL) TRANSMISSION PROJECTS DIVISION	
DOC. NO./REV./PAGE/DATE	001/001/001/2024	01.05.23

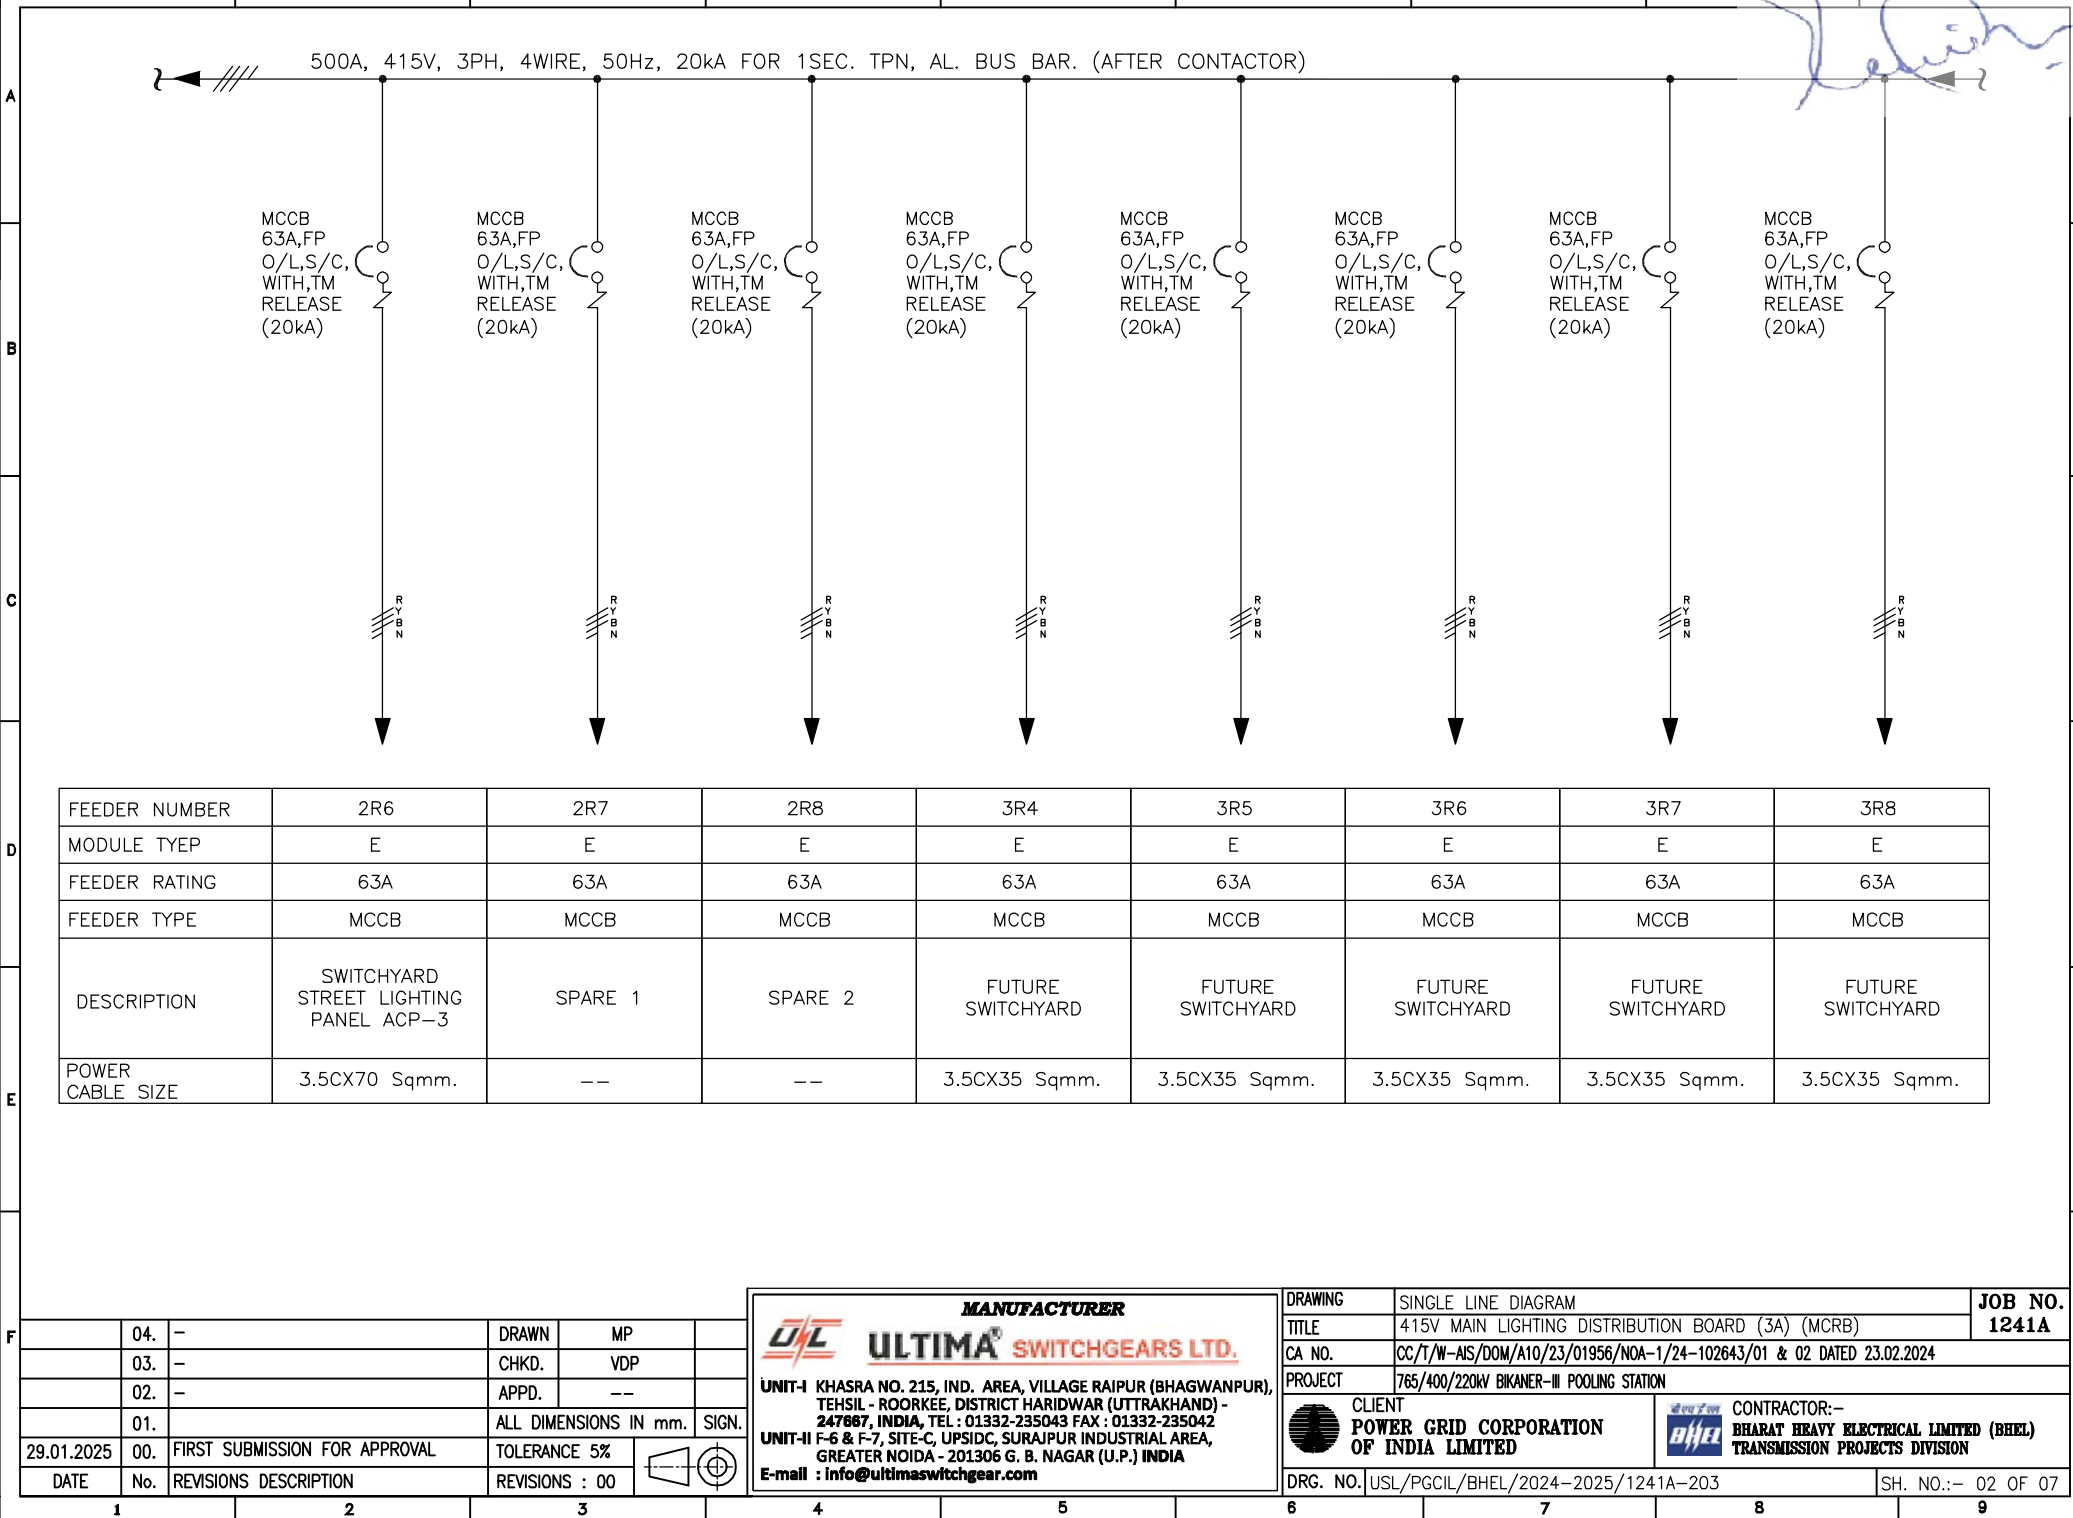




D	E
---	---

F	
---	--

DRAWING	SINGLE LINE DIAGRAM	JOB NO.
TITLE	415V MAIN LIGHTING DISTRIBUTION BOARD (3A) (MCRB)	1241A
CA NO.	CC/T/W-AIS/DOM/A10/23/01956/NOA-1/24-102643/01 & 02 DATED 23.02.2024	
PROJECT	765/400/220KV BIKANER-III POOLING STATION	
 CLIENT POWER GRID CORPORATION OF INDIA LIMITED	 CONTRACTOR:- BHARAT HEAVY ELECTRICAL LIMITED (BHEL) TRANSMISSION PROJECTS DIVISION	
DRG. NO.	LHS/DCCL/BHEL/2024-2025/1241A-202	SH. NO. 03.05.03

This Drawing & information or descriptive matter set out hereon are the confidential property of **ULTIMA SWITCHGEARS LIMITED** & must not be disclosed, copied,loaned or used for manufacturing,tendering or for any other purpose without their permission.

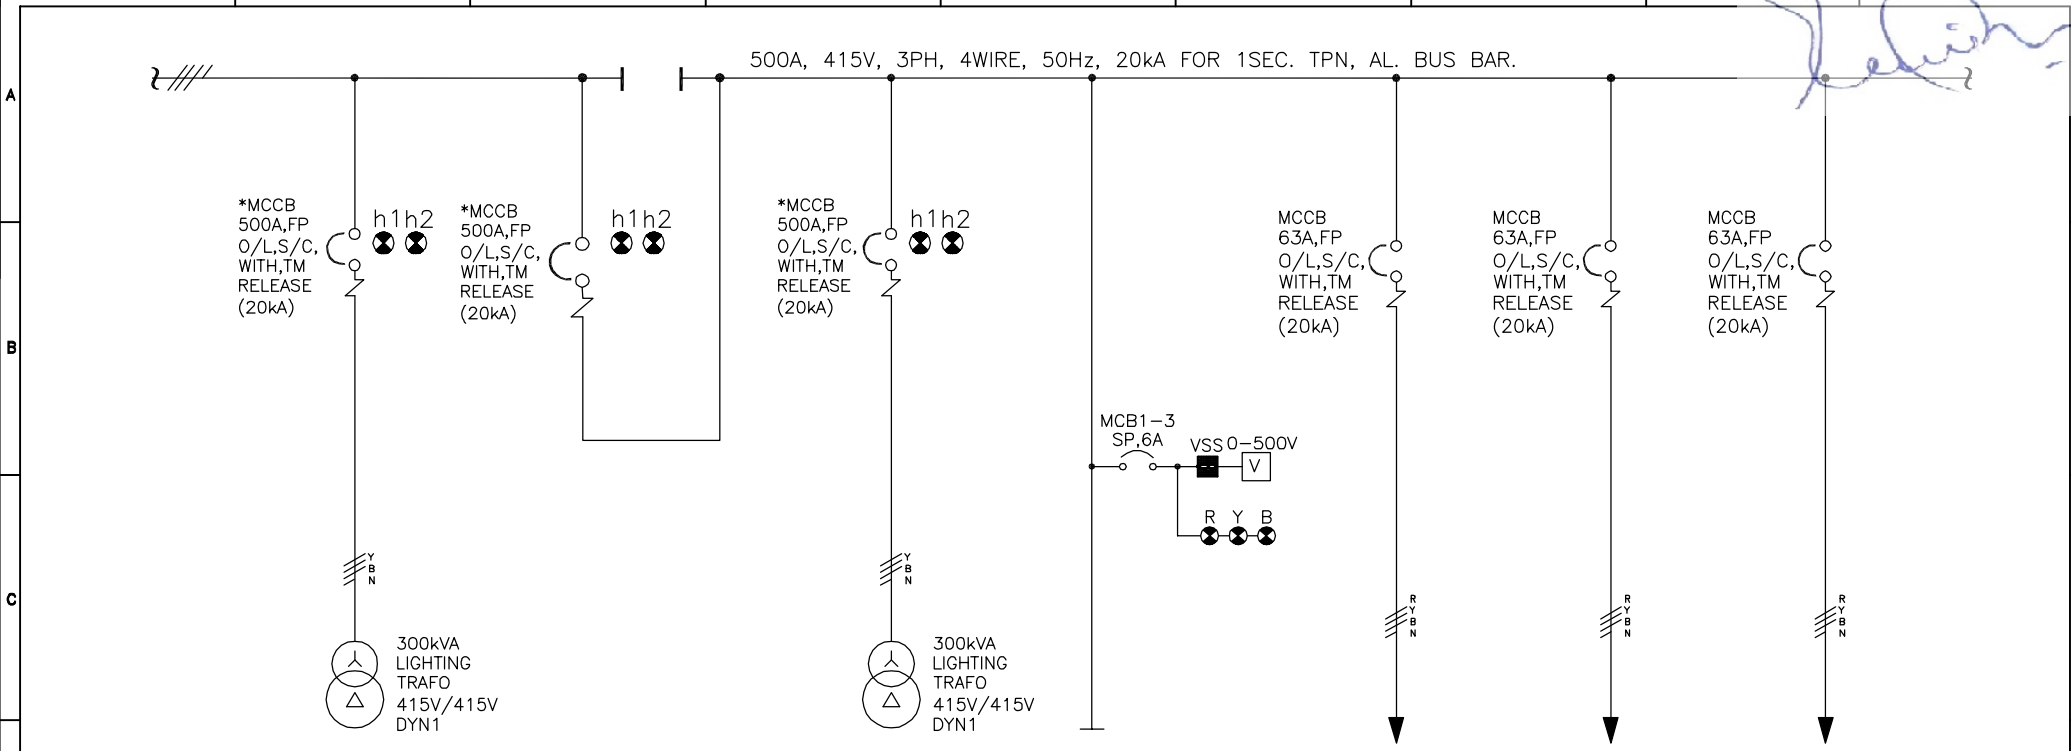

FEEDER NUMBER	1F1+2F1	4FA	5F1+6F1	5F1	5F2	4R1	4R2
MODULE TYEP	H	H (BC)	H	G2	E	E	E
FEEDER RATING	500A	500A	500A	--	63A	63A	63A
FEEDER TYPE	MCCB	MCCB	MCCB	METERING	MCCB	MCCB	MCCB
DESCRIPTION	415V AC SUPPLY INCOMER -1 FROM 300kVA TRANSFORMER	BUSCOUPLER	415V AC SUPPLY INCOMER -2 FROM 300kVA TRANSFORMER	--	RECEPTACLE-4	RECEPTACLE-5	RECEPTACLE-6
POWER CABLE SIZE	2RX3.5CX300 Sqmm. AL XLPE CABLE	--	2RX3.5CX300 Sqmm. AL XLPE CABLE	--	3.5CX35 Sqmm.	3.5CX35 Sqmm.	3.5CX35 Sqmm.


	04.	-	DRAWN	MP	
	03.	-	CHKD.	VDP	
	02.	-	APPD.	--	
	01.	-	ALL DIMENSIONS IN mm.	SIGN.	
29.01.2025	00.	FIRST SUBMISSION FOR APPROVAL	TOLERANCE 5%		
DATE	No.	REVISIONS DESCRIPTION	REVISIONS : 00		

MANUFACTURER
**ULTIMA® SWITCHGEARS LTD.**

UNIT-I KHASRA NO. 215, IND. AREA, VILLAGE RAIPUR (BHAGWANPUR), TEHSIL - ROORKEE, DISTRICT HARIDWAR (UTTRAKHAND) - 247687, INDIA, TEL : 01332-235043 FAX : 01332-235042
UNIT-II F-6 & F-7, SITE-C, UPSIDC, SURAJPUR INDUSTRIAL AREA, GREATER NOIDA - 201306 G. B. NAGAR (U.P.) INDIA
E-mail : info@ultimaswitchgear.com

DRAWING	SINGLE LINE DIAGRAM	JOB NO.	1241A
TITLE	415V MAIN LIGHTING DISTRIBUTION BOARD (3A) (MCRB)		
CA NO.	CC/T/W-AIS/DOM/A10/23/01956/NOA-1/24-102643/01 & 02 DATED 23.02.2024		
PROJECT	765/400/220KV BIKANER-III POOLING STATION		
CLIENT	POWER GRID CORPORATION OF INDIA LIMITED	CONTRACTOR:-	BHARAT HEAVY ELECTRICAL LIMITED (BHEL) TRANSMISSION PROJECTS DIVISION
DRG. NO.	USL/PGCIL/BHEL/2024-2025/1241A-203	SH. NO.:-	04 OF 07

[Handwritten Signature]

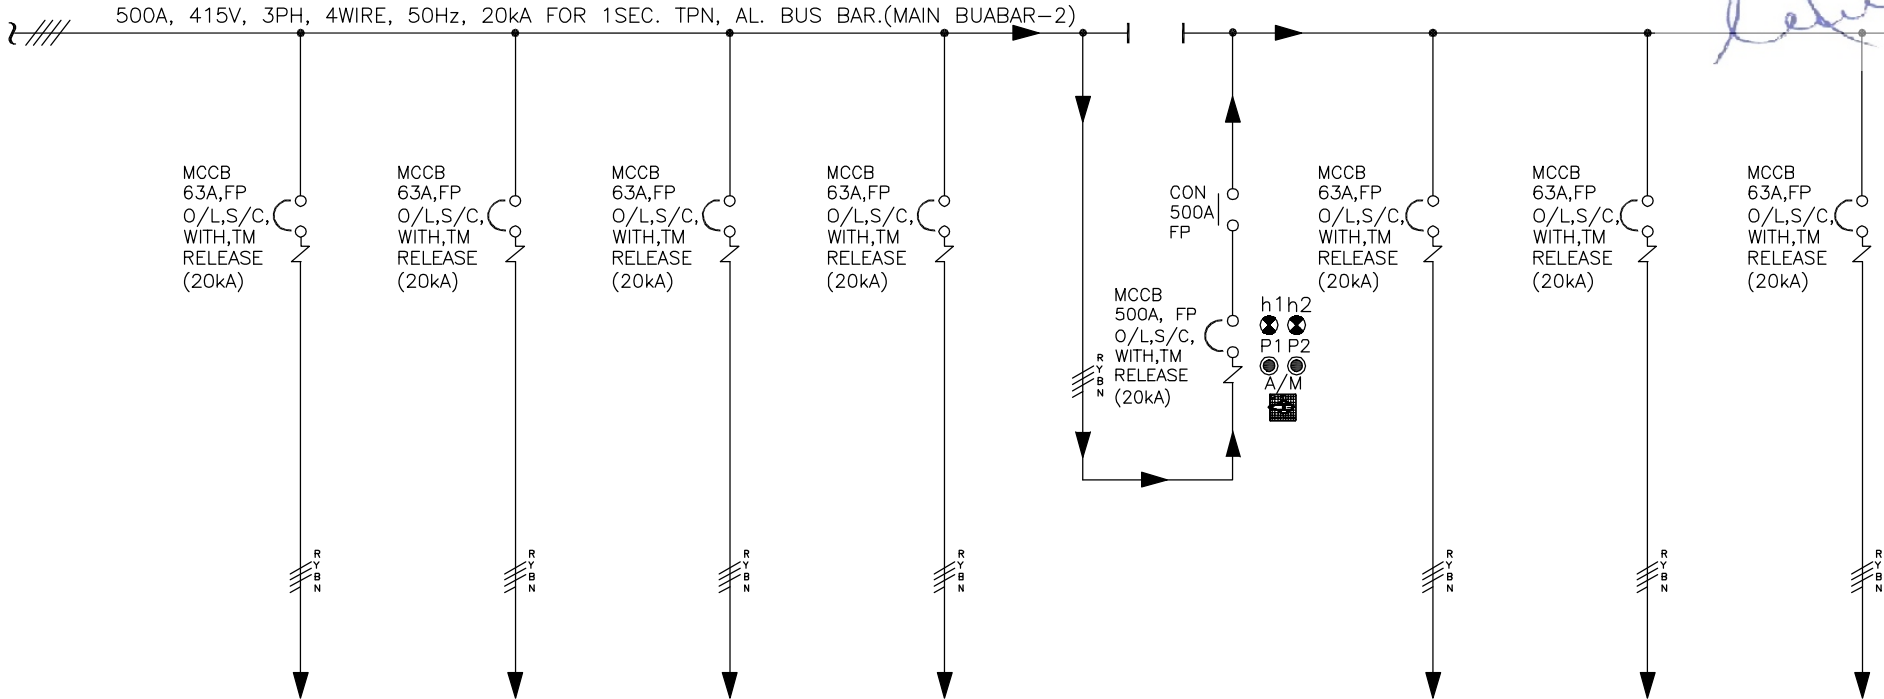


FEEDER NUMBER	4R3	5R1	5R2	5R3	4F2	4F3	4F4	4F5
MODULE TYEP	E	E	E	E	EL	E	E	E
FEEDER RATING	63A	63A	63A	63A	500A	63A	63A	63A
FEEDER TYPE	MCCB	MCCB	MCCB	MCCB	MCCB+CONT.	MCCB	MCCB	MCCB
DESCRIPTION	RECEPTACLE-7	RECEPTACLE-8	RECEPTACLE-9	RECEPTACLE-10	MODULE EL	FUTURE SWITCHYARD	FUTURE SWITCHYARD	FUTURE SWITCHYARD
POWER CABLE SIZE	3.5CX35 Sqmm.	3.5CX35 Sqmm.	3.5CX35 Sqmm.	3.5CX35 Sqmm.	--	3.5CX35 Sqmm.	3.5CX35 Sqmm.	3.5CX35 Sqmm.

	04.	-	DRAWN	MP	
	03.	-	CHKD.	VDP	
	02.	-	APPD.	--	
	01.	-	ALL DIMENSIONS IN mm. SIGN.		
29.01.2025	00.	FIRST SUBMISSION FOR APPROVAL	TOLERANCE 5%		
DATE	No.	REVISIONS DESCRIPTION	REVISIONS : 00		

MANUFACTURER
ULTIMA SWITCHGEARS LTD.
UNIT-I KHASRA NO. 215, IND. AREA, VILLAGE RAIPUR (BHAGWANPUR),
TEHSIL - ROORKEE, DISTRICT HARIDWAR (UTTRAKHAND) -
247687, INDIA, TEL : 01332-235043 FAX : 01332-235042
UNIT-II F-6 & F-7, SITE-C, UPSIDC, SURAJPUR INDUSTRIAL AREA,
GREATER NOIDA - 201306 G. B. NAGAR (U.P.) INDIA
E-mail : info@ultimaswitchgear.com

DRAWING	SINGLE LINE DIAGRAM	JOB NO.	1241A
TITLE	415V MAIN LIGHTING DISTRIBUTION BOARD (3A) (MCRB)		
CA NO.	CC/T/W-AIS/DOM/A10/23/01956/NOA-1/24-102643/01 & 02 DATED 23.02.2024		
PROJECT	765/400/220KV BIKANER-III POOLING STATION		
CLIENT	POWER GRID CORPORATION OF INDIA LIMITED	CONTRACTOR:-	BHARAT HEAVY ELECTRICAL LIMITED (BHEL) TRANSMISSION PROJECTS DIVISION
DRG. NO.	USL/PGCIL/BHEL/2024-2025/1241A-203	SH. NO.:-	05 OF 07

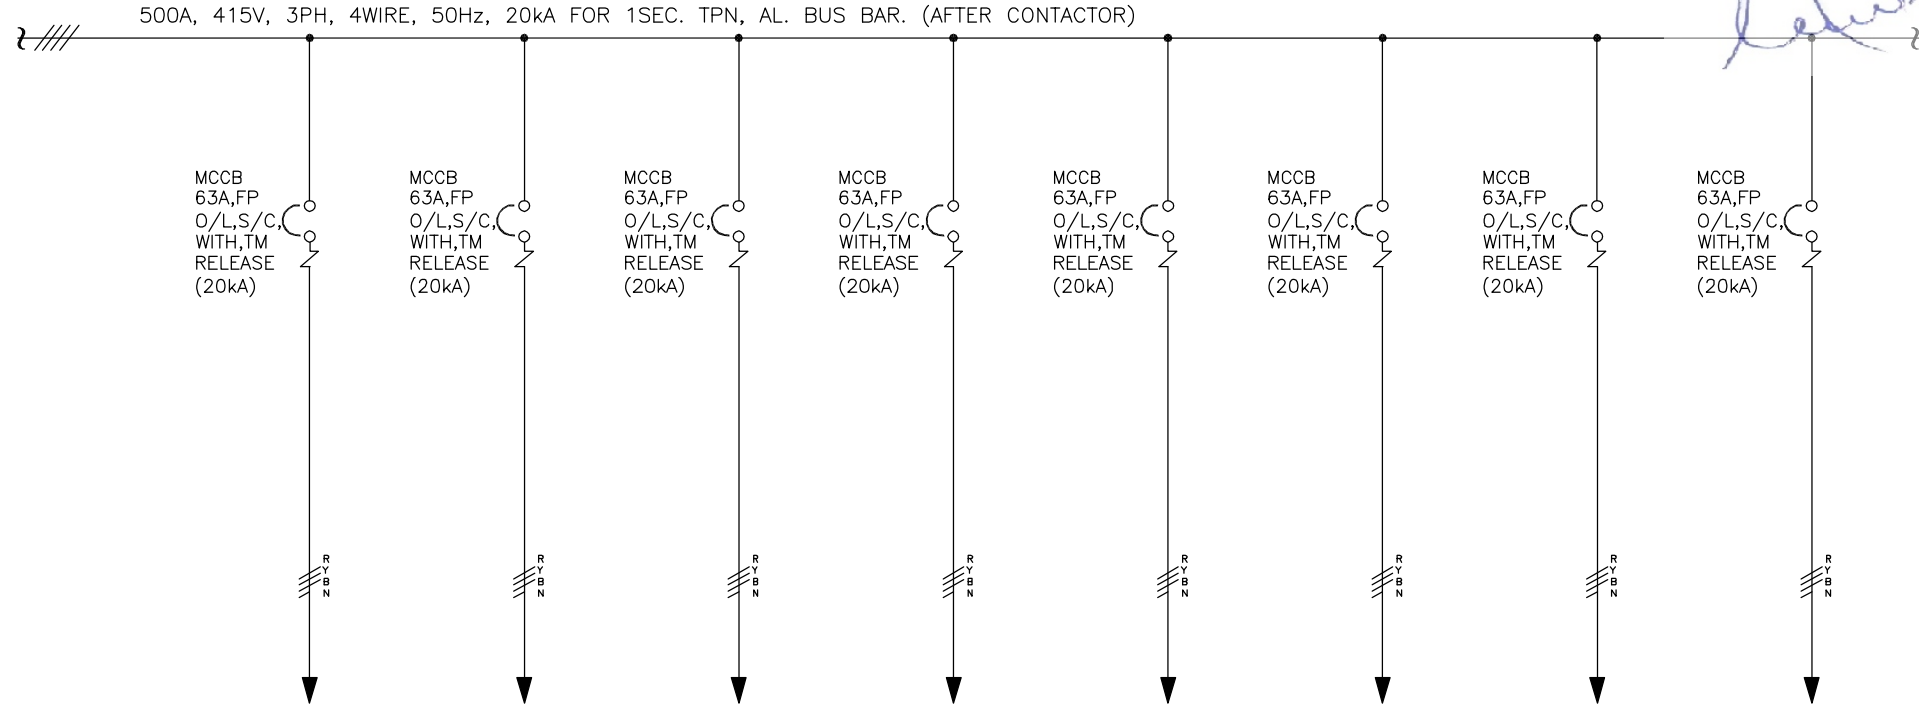

FEEDER NUMBER	5F3	5F4	5F5	5F6	4R5	4R6	4R7	4R8
MODULE TYEP	E	E	E	E	E	E	E	E
FEEDER RATING	63A	63A	63A	63A	63A	63A	63A	63A
FEEDER TYPE	MCCB	MCCB	MCCB	MCCB	MCCB	MCCB	MCCB	MCCB
DESCRIPTION	FUTURE SWITCHYARD	FUTURE SWITCHYARD	400kv SWITCHYARD LIGHTING PANEL (9) ACP-2	400kv SWITCHYARD LIGHTING PANEL (10) ACP-2	400kv SWITCHYARD LIGHTING PANEL (11) ACP-2	400kv SWITCHYARD LIGHTING PANEL (12) ACP-2	220kv SWITCHYARD LIGHTING PANEL (13) ACP-2	200kv SWITCHYARD LIGHTING PANEL (14) ACP-2
POWER CABLE SIZE	3.5CX35 Sqmm.	3.5CX35 Sqmm.	3.5CX70 Sqmm.	3.5CX70 Sqmm.	3.5CX70 Sqmm.	3.5CX70 Sqmm.	3.5CX70 Sqmm.	3.5CX70 Sqmm.

	04.	—	DRAWN	MP	
	03.	—	CHKD.	VDP	
	02.	—	APPD.	--	
	01.		ALL DIMENSIONS IN mm. SIGN.		
29.01.2025	00.	FIRST SUBMISSION FOR APPROVAL	TOLERANCE 5%		
DATE	No.	REVISIONS DESCRIPTION	REVISIONS : 00		


MANUFACTURER
ULTIMA[®] SWITCHGEARS LTD.

UNIT-I KHASRA NO. 215, IND. AREA, VILLAGE RAIPUR (BHAGWANPUR), TEHSIL - ROORKEE, DISTRICT HARIDWAR (UTTRAKHAND) - 247687, INDIA, TEL : 01332-235043 FAX : 01332-235042
UNIT-II F-6 & F-7, SITE-C, UPSIDC, SURAJPUR INDUSTRIAL AREA, GREATER NOIDA - 201306 G. B. NAGAR (U.P.) INDIA
E-mail : info@ultimaswitchgear.com

DRAWING	SINGLE LINE DIAGRAM		JOB NO. 1241A
TITLE	415V MAIN LIGHTING DISTRIBUTION BOARD (3A) (MCRB)		
CA NO.	CC/T/W-AIS/DOM/A10/23/01956/NOA-1/24-102643/01 & 02 DATED 23.02.2024		
PROJECT	765/400/220KV BIKANER-III POOLING STATION		
	CLIENT POWER GRID CORPORATION OF INDIA LIMITED		 CONTRACTOR:- BHARAT HEAVY ELECTRICAL LIMITED (BHEL) TRANSMISSION PROJECTS DIVISION
DRG. NO.	USL/PGCIL/BHEL/2024-2025/1241A-203		SH. NO.:- 06 OF 07

This Drawing & information or descriptive matter set out hereon are the confidential property of **ULTIMA SWITCHGEARS LIMITED** & must not be disclosed, copied,loaned or used for manufacturing,tendering or for any other purpose without their permission.

[Handwritten Signature]

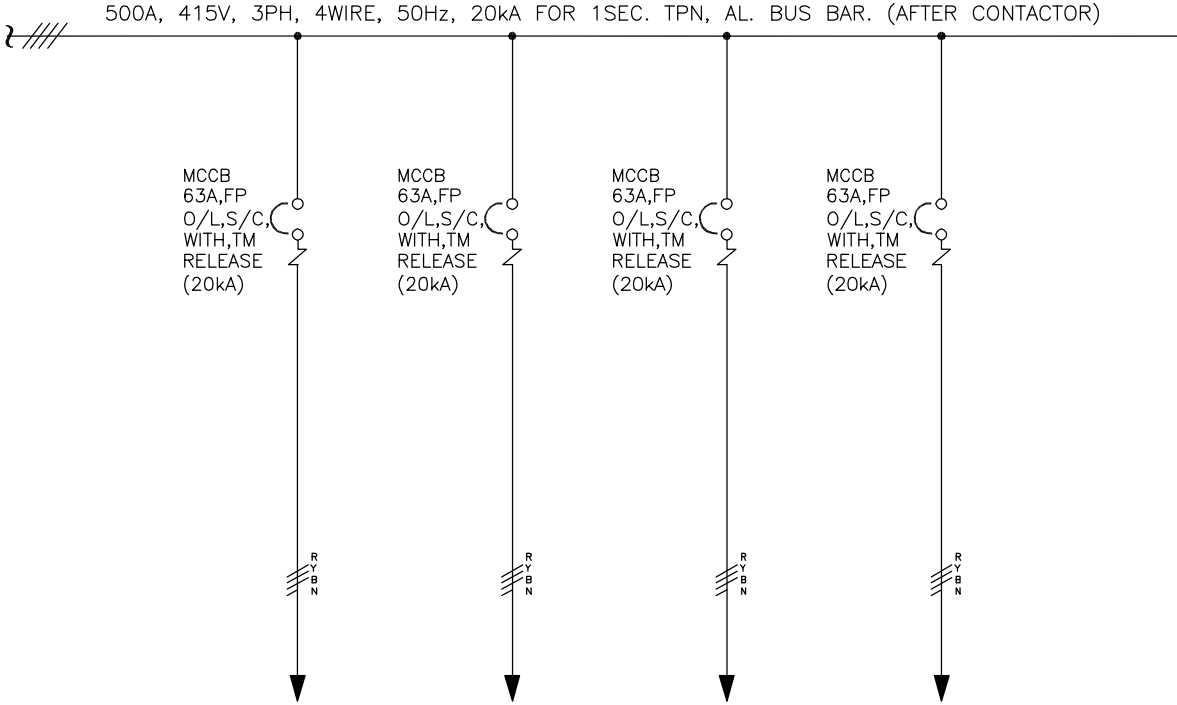

FEEDER NUMBER	5R5	5R6	5R7	5R8
MODULE TYEP	E	E	E	E
FEEDER RATING	63A	63A	63A	63A
FEEDER TYPE	MCCB	MCCB	MCCB	MCCB
DESCRIPTION	200kV SWITCHYARD LIGHTING PANEL (15) ACP-2	200kV SWITCHYARD LIGHTING PANEL (16) ACP-2	SPARE	SPARE
POWER CABLE SIZE	3.5CX70 Sqmm.	3.5CX70 Sqmm.	--	--

	04.	—	DRAWN	MP	
	03.	—	CHKD.	VDP	
	02.	—	APPD.	--	
	01.		ALL DIMENSIONS IN mm. SIGN.		
29.01.2025	00.	FIRST SUBMISSION FOR APPROVAL	TOLERANCE 5%		
DATE	No.	REVISIONS DESCRIPTION	REVISIONS : 00		

MANUFACTURER
ULTIMA® SWITCHGEARS LTD.

UNIT-I KHASRA NO. 215, IND. AREA, VILLAGE RAIPUR (BHAGWANPUR), TEHSIL - ROORKEE, DISTRICT HARIDWAR (UTTRAKHAND) - 247667, INDIA, TEL : 01332-235043 FAX : 01332-235042
UNIT-II F-6 & F-7, SITE-C, UPSIDC, SURAJPUR INDUSTRIAL AREA, GREATER NOIDA - 201306 G. B. NAGAR (U.P.) INDIA
E-mail : info@ultimaswitchgear.com

DRAWING	SINGLE LINE DIAGRAM	JOB NO.	1241A
TITLE	415V MAIN LIGHTING DISTRIBUTION BOARD (3A) (MCRB)		
CA NO.	CC/T/W-AIS/DOM/A10/23/01956/NOA-1/24-102643/01 & 02 DATED 23.02.2024		
PROJECT	765/400/220KV BIKANER-III POOLING STATION		
CLIENT POWER GRID CORPORATION OF INDIA LIMITED		CONTRACTOR:- BHARAT HEAVY ELECTRICAL LIMITED (BHEL) TRANSMISSION PROJECTS DIVISION	
DRG. NO.	USL/PGCIL/BHEL/2024-2025/1241A-203	SH. NO.:-	07 OF 07

[Handwritten Signature]

BILL OF MATERIAL FOR 415V MAIN LIGHTING DISTRIBUTION BOARD (3A) (MCRB)

S.NO.	ITEM CODE	DESCRIPTION	MAKE	RATING	QTY.
A	BILL OF MATERIAL FOR MODULE - (H)				02 Nos.
1	MCCB	FP MCCB, WITH THERMAL MAGNETIC BASED RELEASE FOR 80-100 % O/L, S/C PROTECTION WITH SPREADER LINK, ROTARY OPERATING MECHANISM (ROM) & 1C/O AUX. CONTACT, Ics=100% Icu	L&T/C&S/HAVELLS	500A, 20kA	01
2	MCB	SP MINIATURE CIRCUIT BREAKER, 'C' CURVE	L&T/C&S/HAVELLS	6A, 10kA	01
3	LIGHTING TRF	LIGHTING TRANSFORMER 415/415 Dyn1	PGCIL APPROVED	300kVA	01
4	h1	'ON' INDICATION LAMP, 22.5 Sq. mm. DIA ,LED TYPE, RED	ESBEE/VAISHNO/C&S	240V AC	01
5	h2	'OFF' INDICATION LAMP, 22.5 Sq. mm. DIA ,LED TYPE, GREEN	ESBEE/VAISHNO/C&S	240V AC	01
B	BILL OF MATERIAL FOR MODULE - (EL)				02 Nos.
1	MCCB	FP MCCB, WITH THERMAL MAGNETIC BASED RELEASE FOR 80-100 % O/L, S/C PROTECTION WITH SPREADER LINK & ROTARY OPERATING MECHANISM (ROM), Ics=100% Icu	L&T/C&S/HAVELLS	500A, 20kA	01
2	CM	FP POWER CONTACTOR, COIL VOLTAGE 240V AC, WITH 2NO+2NC AUX. CONTACT, AC-1 DUTY	L&T/C&S/HAVELLS	500A	01
3	MCB	SP MINIATURE CIRCUIT BREAKER, 'C' CURVE	L&T/C&S/HAVELLS	6A, 10kA	01
4	h1	'ON' INDICATION LAMP, 22.5 Sq. mm. DIA ,LED TYPE, RED	ESBEE/VAISHNO/C&S	240V AC	01
5	h2	'OFF' INDICATION LAMP, 22.5 Sq. mm. DIA ,LED TYPE, GREEN	ESBEE/VAISHNO/C&S	240V AC	01
6	P1	'STOP' PUSH BUTTON, SPRING RETURN TYPE, 22.5 Sq. mm. DIA WITH 2NC CONTACT, RED	ESBEE/VAISHNO/C&S	240VAC	01
7	P2	'START' PUSH BUTTON, SPRING RETURN TYPE, 22.5 Sq. mm. DIA WITH 2NO CONTACT, GREEN	ESBEE/VAISHNO/C&S	240V AC	01
8	T	24 HOURS TIMER SWITCH DIN RAIL MOUNTED , 1C/O AUX. CONTACT	GIC/EAPL	240V AC	01
9	A/M	AUTO/MANUAL SELECTOR SWITCH WITH OFF, 2POLE 2WAY, ROTARY TYPE	SALZER/KAYCEE	6A	01

NOTE:- ALL COMPONENTS SHALL BE POWER GRID (QA&I) APPROVED MAKE

	04.	-	DRAWN	MP	
	03.	-	CHKD.	VDP	
	02.	-	APPD.	--	
	01.		ALL DIMENSIONS IN mm. SIGN.		
29.01.2025	00.	FIRST SUBMISSION FOR APPROVAL	TOLERANCE 5%		
DATE	No.	REVISIONS DESCRIPTION	REVISIONS : 00		

MANUFACTURER

ULTIMA SWITCHGEARS LTD.

UNIT-I KHASRA NO. 215, IND. AREA, VILLAGE RAIPUR (BHAGWANPUR), TEHSIL - ROORKEE, DISTRICT HARIDWAR (UTTRAKHAND) - 247667, INDIA, TEL : 01332-235043 FAX : 01332-235042

UNIT-II F-6 & F-7, SITE-C, UPSIDC, SURAJPUR INDUSTRIAL AREA, GREATER NOIDA - 201306 G. B. NAGAR (U.P.) INDIA

E-mail : info@ultimaswitchgear.com

DRAWING	BILL OF MATERIAL	JOB NO.
TITLE	415V MAIN LIGHTING DISTRIBUTION BOARD (3A) (MCRB)	1241A
CA NO.	CC/T/W-AIS/DOM/A10/23/01956/NOA-1/24-102643/01 & 02 DATED 23.02.2024	
PROJECT	765/400/220KV BIKANER-III POOLING STATION	
CLIENT POWER GRID CORPORATION OF INDIA LIMITED		CONTRACTOR:- BHARAT HEAVY ELECTRICAL LIMITED (BHEL) TRANSMISSION PROJECTS DIVISION
DRG. NO.	USL/PGCIL/BHEL/2024-2025/1241A-703	SH. NO.:- 01 OF 03

[Handwritten Signature]

BILL OF MATERIAL FOR 415V MAIN LIGHTING DISTRIBUTION BOARD (3A) (MCRB)

S.NO.	ITEM CODE	DESCRIPTION	MAKE	RATING	QTY.
C	BILL OF MATERIAL FOR MODULE - (G2)				02 Nos.
1	MCB1-3	SP MINIATURE CIRCUIT BREAKER, 'C' CURVE	L&T/C&S/HAVELLS	6A, 10kA	03
2	V	AC ANALOG VOLTMETER, SINGLE PHASE, SIZE-96X96 Sq. mm, CL-1, PTR-415V	AE/RISHAB/NEWTEK/SECURE	0-500V	01
3	VSS	VOLTMETER SELECTOR SWITCH, ROTARY TYPE, 4 POSITION	SALZER/KAYCEE	6A	01
4	R-PHASE	'R' INDICATION LAMP, 22.5 Sq. mm. DIA ,LED TYPE, RED	ESBEE/VAISHNO/C&S	240V AC	01
5	Y-PHASE	'Y' INDICATION LAMP, 22.5 Sq. mm. DIA ,LED TYPE, YELLOW	ESBEE/VAISHNO/C&S	240V AC	01
6	B-PHASE	'B' INDICATION LAMP, 22.5 Sq. mm. DIA ,LED TYPE, BLUE	ESBEE/VAISHNO/C&S	240V AC	01
D	BILL OF MATERIAL FOR MODULE - (H-BC) BUS-COUPLER				01 No.
1	MCCB	FP MCCB, WITH THERMAL MAGNETIC BASED RELEASE FOR 80-100 % O/L, S/C PROTECTION WITH SPREADER LINK, ROTARY OPERATING MECHANISM (ROM) & 1C/O AUX. CONTACT, Ics=100% Icu	L&T/C&S/HAVELLS	500A FP, 20kA	01
2	MCB	SP MINIATURE CIRCUIT BREAKER, 'C' CURVE	L&T/C&S/HAVELLS	6A, 10kA	01
3	--	MECHANICAL LOCK 3 LOCK 2-KEY FOR 100A FP MCCB	PGCIL APPROVED	--	1-SET
4	h1	'ON' INDICATION LAMP, 22.5 Sq. mm. DIA ,LED TYPE, RED	ESBEE/VAISHNO/C&S	240V AC	01
5	h2	'OFF' INDICATION LAMP, 22.5 Sq. mm. DIA ,LED TYPE, GREEN	ESBEE/VAISHNO/C&S	240V AC	01
E	BILL OF MATERIAL FOR MODULE (E)				
1	MCCB	FP MCCB, WITH THERMAL MAGNETIC BASED RELEASE FOR 80-100 % O/L, S/C PROTECTION WITH ROTARY OPERATING MECHANISM (ROM), Ics=100% Icu	L&T/C&S/HAVELLS	63A, 20kA	44

NOTE:- ALL COMPONENTS SHALL BE POWER GRID (QA&I) APPROVED MAKE

	04.	-	DRAWN	MP	
	03.	-	CHKD.	VDP	
	02.	-	APPD.	--	
	01.		ALL DIMENSIONS IN mm. SIGN.		
29.01.2025	00.	FIRST SUBMISSION FOR APPROVAL	TOLERANCE 5%		
DATE	No.	REVISIONS DESCRIPTION	REVISIONS : 00		

MANUFACTURER

ULTIMA SWITCHGEARS LTD.

UNIT-I KHASRA NO. 215, IND. AREA, VILLAGE RAIPUR (BHAGWANPUR), TEHSIL - ROORKEE, DISTRICT HARIDWAR (UTTRAKHAND) - 247687, INDIA, TEL : 01332-235043 FAX : 01332-235042

UNIT-II F-6 & F-7, SITE-C, UPSIDC, SURAJPUR INDUSTRIAL AREA, GREATER NOIDA - 201306 G. B. NAGAR (U.P.) INDIA

E-mail : info@ultimaswitchgear.com

DRAWING	BILL OF MATERIAL	JOB NO.
TITLE	415V MAIN LIGHTING DISTRIBUTION BOARD (3A) (MCRB)	1241A
CA NO.	CC/T/W-AIS/DOM/A10/23/01956/NOA-1/24-102643/01 & 02 DATED 23.02.2024	
PROJECT	765/400/220KV BIKANER-III POOLING STATION	
CLIENT POWER GRID CORPORATION OF INDIA LIMITED		CONTRACTOR:- BHARAT HEAVY ELECTRICAL LIMITED (BHEL) TRANSMISSION PROJECTS DIVISION
DRG. NO.	USL/PGCIL/BHEL/2024-2025/1241A-703	SH. NO.:- 02 OF 03

This Drawing & information or descriptive matter set out hereon are the confidential property of **ULTIMA SWITCHGEARS LIMITED** & must not be disclosed, copied,loaned or used for manufacturing,tendering or for any other purpose without their permission.

[Handwritten Signature]

BILL OF MATERIAL FOR 415V MAIN LIGHTING DISTRIBUTION BOARD (3A) (MCRB)					
S.NO.	ITEM CODE	DESCRIPTION	MAKE	RATING	QTY.
F	BILL OF MATERIAL FOR MISC.				
1	MCB	SP MINIATURE CIRCUIT BREAKER, 'C' CURVE	L&T/C&S/HAVELLS	6A, 10kA	05
2	R-SW	ON/OFF ROTARY SWITCH	PGCIL APPROVED	6A	02
3	SW - SOCKET	5/15A SWITCH SOCKET	ANCHOR//PGCIL APPROVED MAKE	--	02
4	DS	DOOR SWITCH, 1C/O	KAYCEE/PGCIL APPROVED MAKE	--	03
5	PL	PANEL ILLUMINATION LIGHT, 240V AC	COMPACT/PGCIL APPROVED MAKE	5W	03
6	SH	SPACE HEATER, 240V AC	HOTWEL/PGCIL APPROVED MAKE	60W	03
7	TH	THERMOSTATE, 240V AC	ELCON/PGCIL APPROVED MAKE	30 - 85°C	05
8	T1	ON DELAY TIMER WITH 1C/O AUXILIARY SWITCH, 0-60 SEC., 240V AC	GIC/PGCIL APPROVED MAKE	--	02
9	T1X	AUX. CONTACTOR RELAY, COIL VOLTAGE 240V DC WITH 2NO+2NC AUX. CONTACT	L&T/C&S/HAVELLS	--	02
10	FAN 1-3	VANTILATION FAN (150MM), 240V AC	HIGH COOL/PGCIL APPROVED MAKE	--	06

NOTE:— ALL COMPONENTS SHALL BE POWER GRID (QA&!) APPROVED MAKE

	04.	—	DRAWN	MP	
	03.	—	CHKD.	VDP	
	02.	—	APPD.	--	
	01.		ALL DIMENSIONS IN mm. SIGN.		
29.01.2025	00.	FIRST SUBMISSION FOR APPROVAL	TOLERANCE 5%		
DATE	No.	REVISIONS DESCRIPTION	REVISIONS : 00		

MANUFACTURER
ULTIMA® SWITCHGEARS LTD.

UNIT-I KHASRA NO. 215, IND. AREA, VILLAGE RAIPUR (BHAGWANPUR), TEHSIL - ROORKEE, DISTRICT HARIDWAR (UTTRAKHAND) - 247667, INDIA, TEL : 01332-235043 FAX : 01332-235042

UNIT-II F-6 & F-7, SITE-C, UPSIDC, SURAJPUR INDUSTRIAL AREA, GREATER NOIDA - 201306 G. B. NAGAR (U.P.) INDIA

E-mail : info@ultimaswitchgear.com

DRAWING	BILL OF MATERIAL	JOB NO.
TITLE	415V MAIN LIGHTING DISTRIBUTION BOARD (3A) (MCRB)	1241A
CA NO.	CC/T/W-AIS/DOM/A10/23/01956/NOA-1/24-102643/01 & 02 DATED 23.02.2024	
PROJECT	765/400/220KV BIKANER-III POOLING STATION	
CLIENT POWER GRID CORPORATION OF INDIA LIMITED		CONTRACTOR:— BHARAT HEAVY ELECTRICAL LIMITED (BHEL) TRANSMISSION PROJECTS DIVISION
DRG. NO.	USL/PGCIL/BHEL/2024-2025/1241A-703	SH. NO.:— 03 OF 03

This Drawing & information or descriptive matter set out hereon are the confidential property of **ULTIMA SWITCHGEARS LIMITED** & must not be disclosed, copied, loaned or used for manufacturing, tendering or for any other purpose without their permission.

[Handwritten Signature]

ENGINEERING DRAWING DETAILS FOR
415V EMERGENCY LIGHTING DISTRIBUTION BOARD (4A) (MCRB)

PROJECT :- 765/400/220kV BIKANER-III POOLING STATION
CLIENT :- POWER GRID CORPORATION OF INDIA LIMITED
CONTRACTOR :- BHARAT HEAVY ELECTRICAL LIMITED (BHEL)
TRANSMISSION PROJECTS DIVISION


	04.	-	DRAWN	MP	
	03.	-	CHKD.	VDP	
	02.	-	APPD.	--	
	01.		ALL DIMENSIONS IN mm. SIGN.		
29.01.2025	00.	FIRST SUBMISSION FOR APPROVAL	TOLERANCE 5%		
DATE	No.	REVISIONS DESCRIPTION	REVISIONS : 00		





MANUFACTURER

 **ULTIMA[®] SWITCHGEARS LTD.**

UNIT-I KHASRA NO. 215, IND. AREA, VILLAGE RAIPUR (BHAGWANPUR),
TEHSIL - ROORKEE, DISTRICT HARIDWAR (UTTRAKHAND) -
247667, INDIA, TEL : 01332-235043 FAX : 01332-235042
UNIT-II F-6 & F-7, SITE-C, UPSIDC, SURAJPUR INDUSTRIAL AREA,
GREATER NOIDA - 201306 G. B. NAGAR (U.P.) INDIA
E-mail : info@ultimaswitchgear.com

DRAWING	COVER PAGE	JOB NO.
TITLE	415V EMERGENCY LIGHTING DISTRIBUTION BOARD (4A) (MCRB)	1241A
CA NO.	CC/T/W-AIS/DOM/A10/23/01956/NOA-1/24-102643/01 & 02 DATED 23.02.2024	
PROJECT	765/400/220KV BIKANER-III POOLING STATION	
CLIENT  POWER GRID CORPORATION OF INDIA LIMITED		CONTRACTOR:-  BHARAT HEAVY ELECTRICAL LIMITED (BHEL) TRANSMISSION PROJECTS DIVISION
DRG. NO.	USL/PGCIL/BHEL/2024-2025/1241A-004	SH. NO. 01 OF 01

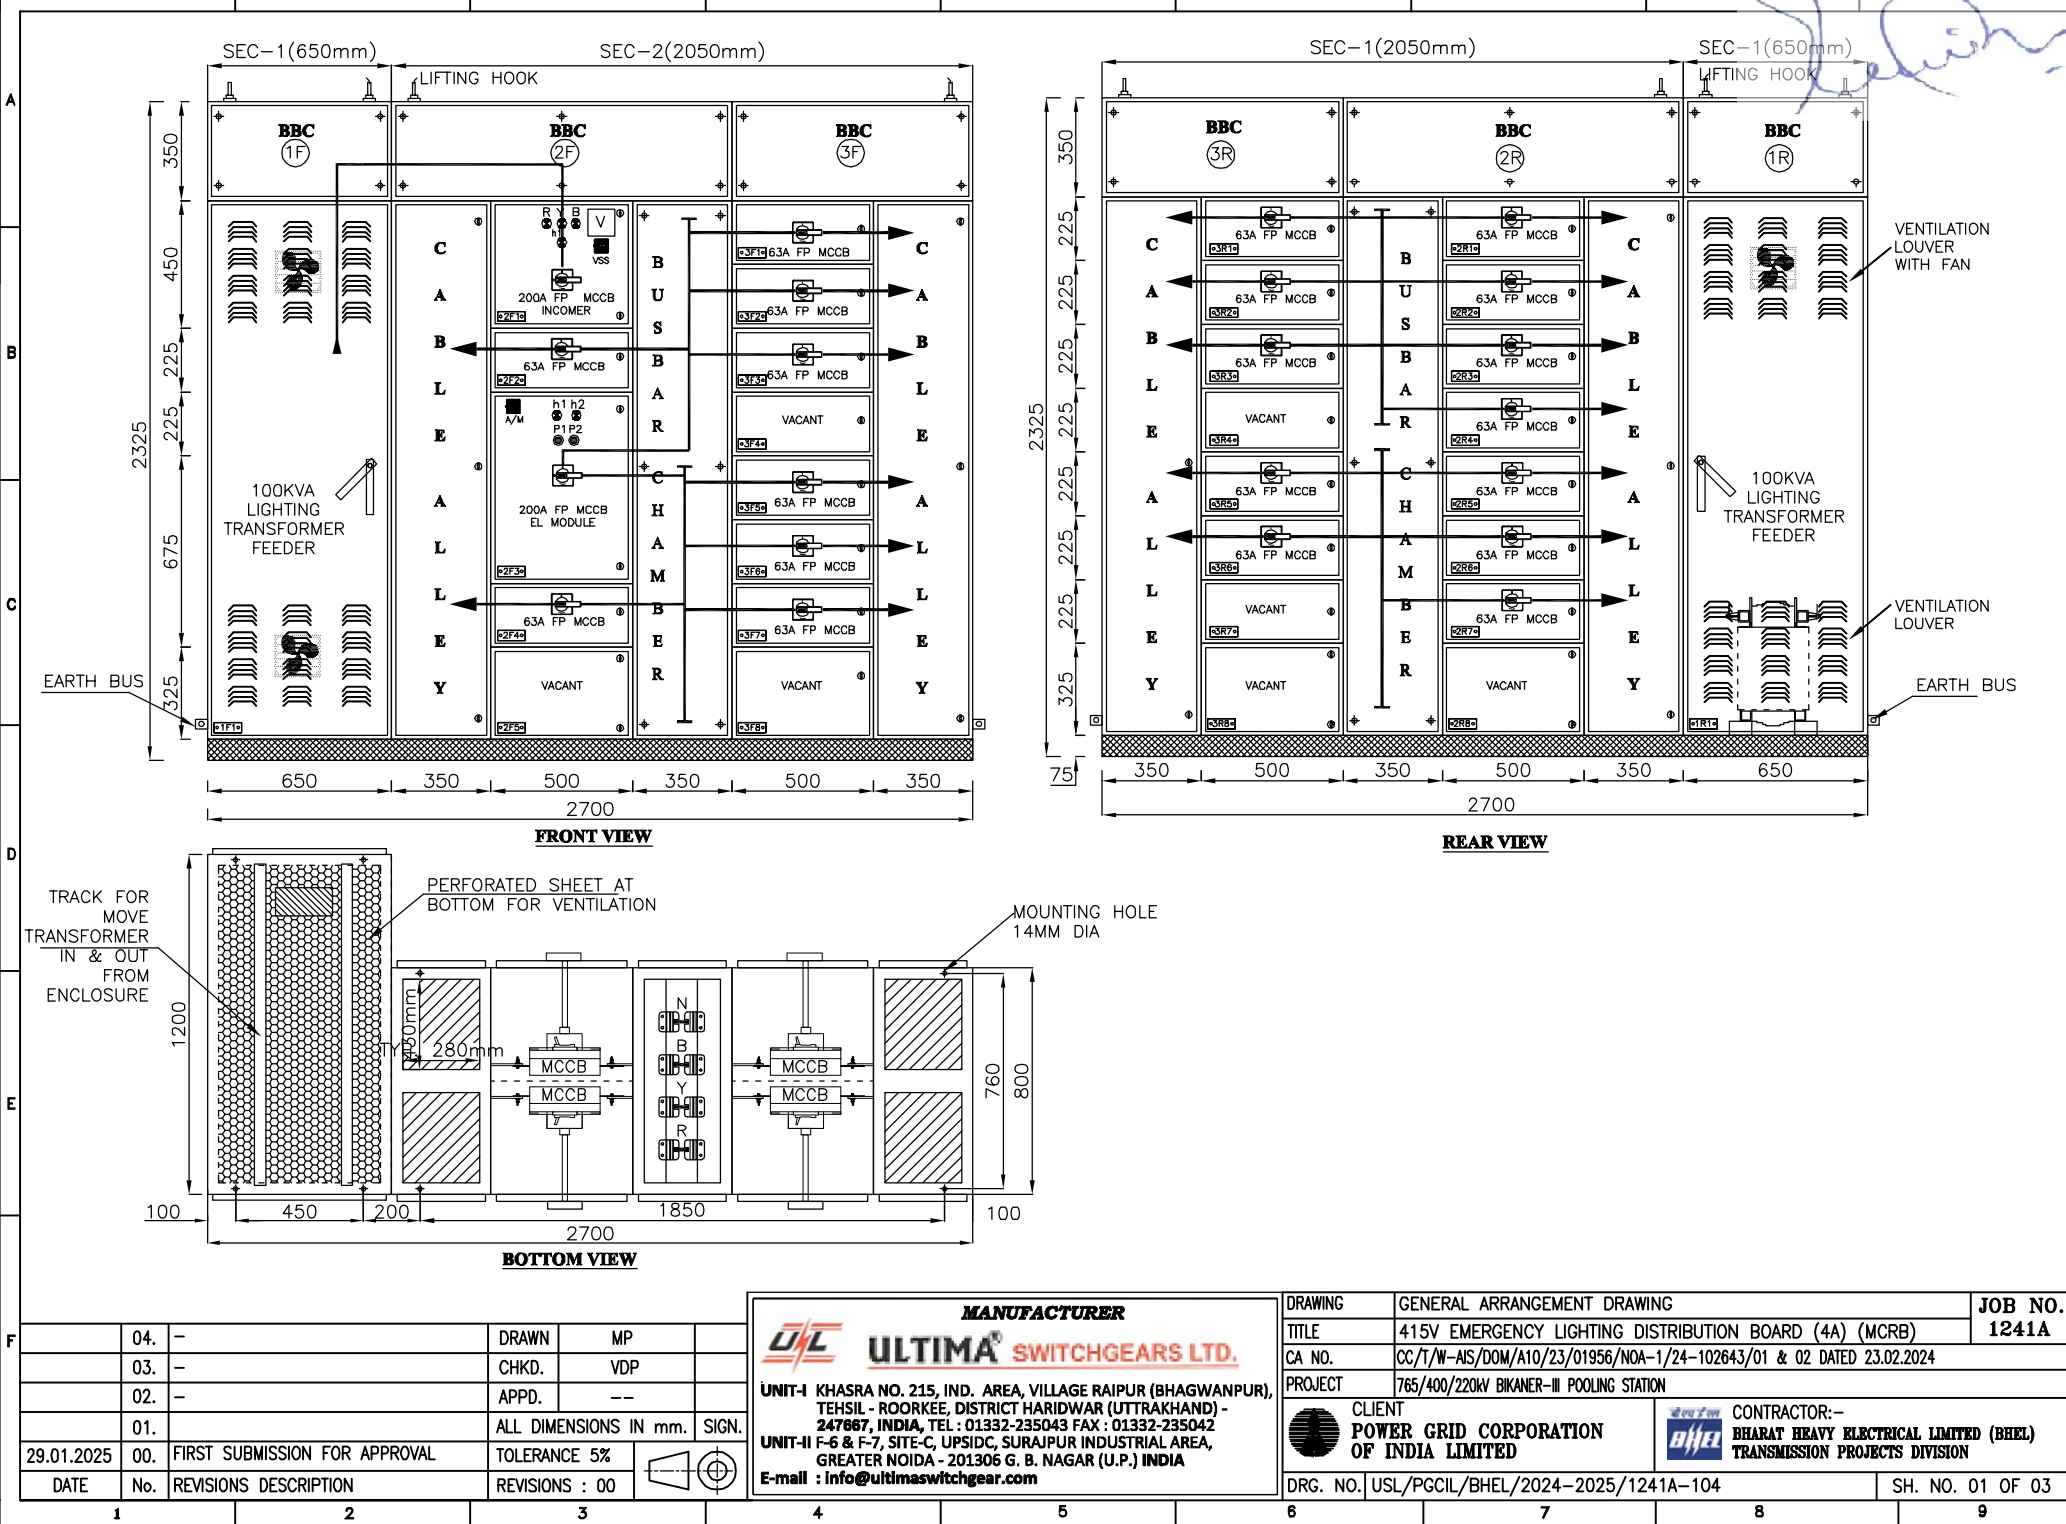

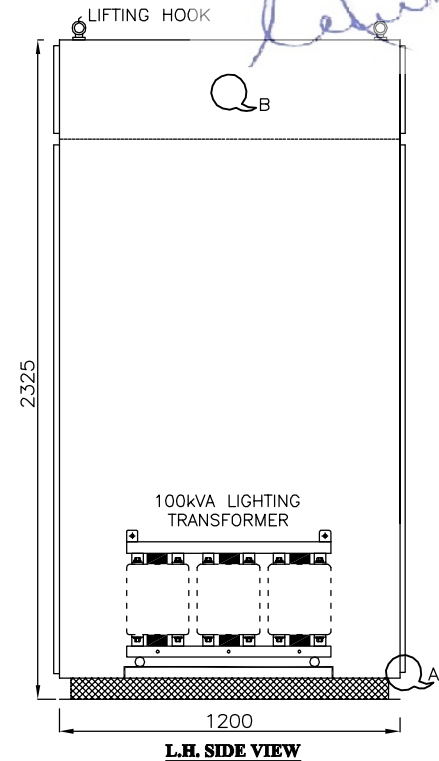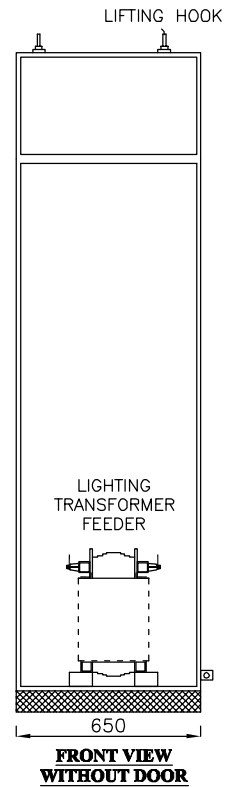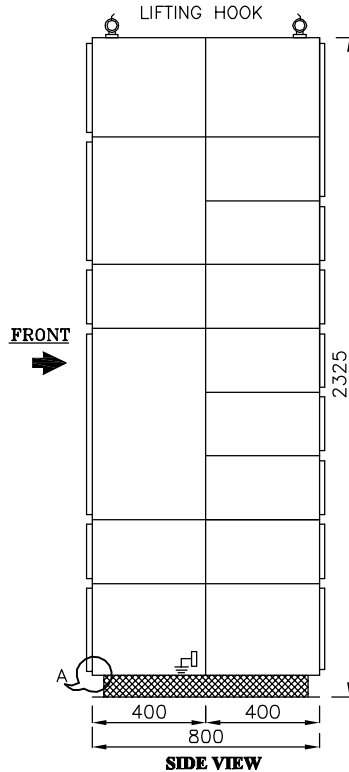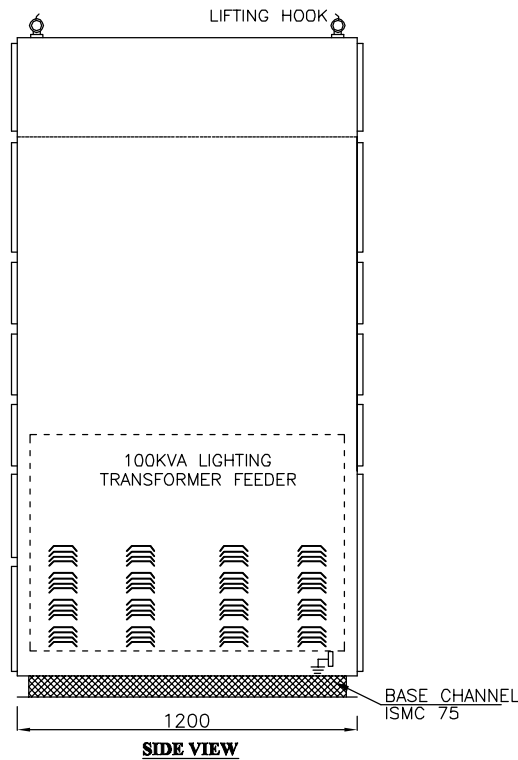

PANEL DIMENSIONS

HEIGHT 2325 mm.
WIDTH 2700 mm.
DEPTH 1200/800 mm.

CABLE ENTRY

BOTTOM ENTRY

HORIZONTAL BUS BAR SIZE:-


PHASE : 1x40x10 Sq.mm Al.
NEUTRAL : 1x40x05 Sq.mm Al.
EARTH : 1x40x05 Sq.mm. GS.

VERTICAL BUS BAR SIZE:-

PHASE :1X40X10 SQ.MM AL.
NEUTRAL :1X40X05 SQ.MM AL.

LEGEND DESCRIPTION

R = R-PHASE INDICATION (RED)
Y = Y-PHASE INDICATION (YELLOW)
B = B-PHASE INDICATION (BLUE)
h1 = ON INDICATION RED
h2 = OFF INDICATION GREEN
A = DIGITAL AMMETER
V = DIGITAL VOLT METER
ASS = AMMETER SELECTOR SWITCH
VSS = VOLTAGE SELECTOR SWITCH
P1 = CONTACTOR OFF PUSH BUTTON
P2 = CONTACTOR ON PUSH BUTTON
A/M = AUTO/MANUAL SELECTOR SWITCH

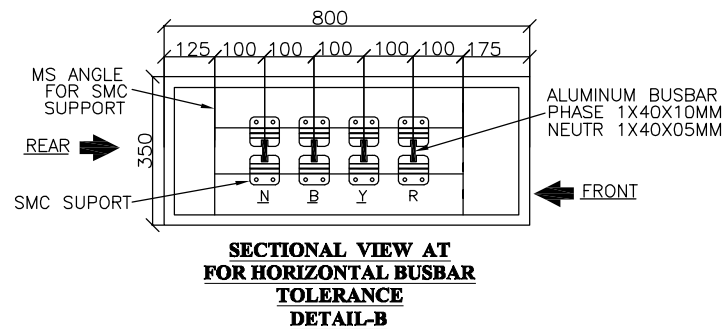

04.	-	DRAWN	MP	
03.	-	CHKD.	VDP	
02.	-	APPD.	--	
01.	-	ALL DIMENSIONS IN mm.	SIGN.	
29.01.2025	00.	FIRST SUBMISSION FOR APPROVAL	TOLERANCE 5%	
DATE	No.	REVISIONS DESCRIPTION	REVISIONS : 00	

MANUFACTURER

ULTIMA SWITCHGEARS LTD.






UNIT-I KHASRA NO. 215, IND. AREA, VILLAGE RAIPUR (BHAGWANPUR), TEHSIL - ROORKEE, DISTRICT HARIDWAR (UTTRAKHAND) - 247687, INDIA, TEL : 01332-235043 FAX : 01332-235042

UNIT-II F-6 & F-7, SITE-C, UPSIDC, SURAJPUR INDUSTRIAL AREA, GREATER NOIDA - 201306 G. B. NAGAR (U.P.) INDIA

E-mail : info@ultimaswitchgear.com

DRAWING	GENERAL ARRANGEMENT DRAWING	JOB NO.	1241A
TITLE	415V EMERGENCY LIGHTING DISTRIBUTION BOARD (4A) (MCRB)		
CA NO.	CC/T/W-AIS/DOM/A10/23/01956/NOA-1/24-102643/01 & 02 DATED 23.02.2024		
PROJECT	765/400/220KV BIKANER-III POOLING STATION		
CLIENT	POWER GRID CORPORATION OF INDIA LIMITED	CONTRACTOR:-	BHARAT HEAVY ELECTRICAL LIMITED (BHEL) TRANSMISSION PROJECTS DIVISION
DRG. NO.	USL/PGCIL/BHEL/2024-2025/1241A-104	SH. NO.	02 OF 03

This Drawing & information or descriptive matter set out hereon are the confidential property of **ULTIMA SWITCHGEARS LIMITED** & must not be disclosed, copied, loaned or used for manufacturing, tendering or for any other purpose without their permission.

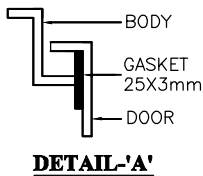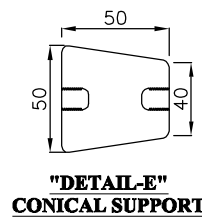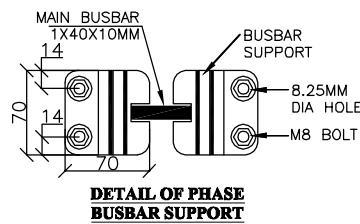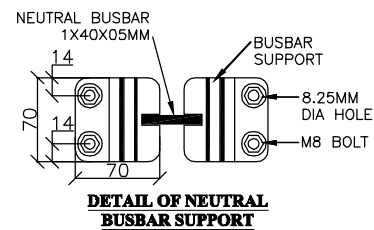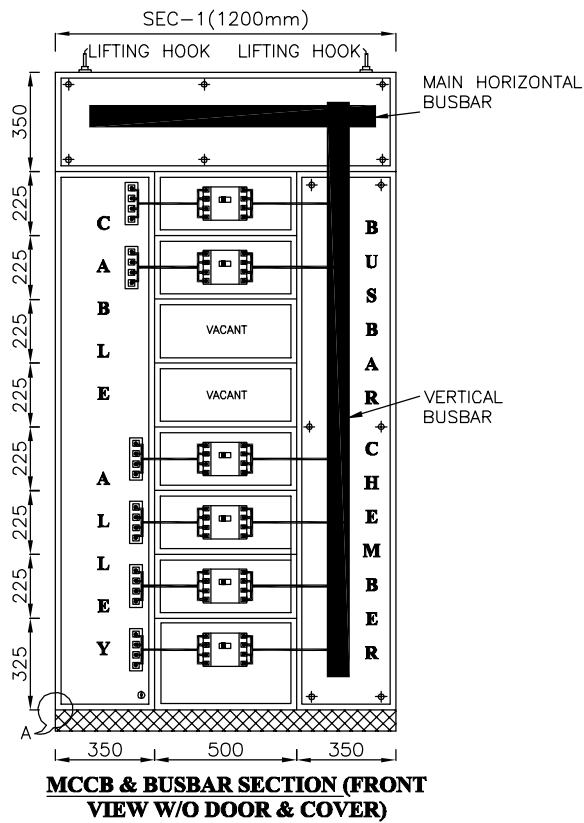


	04.	-	DRAWN	MP	
	03.	-	CHKD.	VDP	
	02.	-	APPD.	--	
	01.	-	ALL DIMENSIONS IN mm.	SIGN.	
29.01.2025	00.	FIRST SUBMISSION FOR APPROVAL	TOLERANCE 5%		
DATE	No.	REVISIONS DESCRIPTION	REVISIONS : 00		

MANUFACTURER

ULTIMA SWITCHGEARS LTD.
UNIT-I KHASRA NO. 215, IND. AREA, VILLAGE RAIPUR (BHAGWANPUR), TEHSIL - ROORKEE, DISTRICT HARIDWAR (UTTRAKHAND) - 247667, INDIA, TEL : 01332-235043 FAX : 01332-235042
UNIT-II F-6 & F-7, SITE-C, UPSIDC, SURAJPUR INDUSTRIAL AREA, GREATER NOIDA - 201306 G. B. NAGAR (U.P.) INDIA
E-mail : info@ultimaswitchgear.com

DRAWING	GENERAL ARRANGEMENT DRAWING	JOB NO.
TITLE	415V EMERGENCY LIGHTING DISTRIBUTION BOARD (4A) (MCRB)	1241A
CA NO.	CC/T/W-AIS/DOM/A10/23/01956/NOA-1/24-102643/01 & 02 DATED 23.02.2024	
PROJECT	765/400/220KV BIKANER-III POOLING STATION	
CLIENT	POWER GRID CORPORATION OF INDIA LIMITED	CONTRACTOR:-
		BHARAT HEAVY ELECTRICAL LIMITED (BHEL) TRANSMISSION PROJECTS DIVISION
DRG. NO.	USL/PGCIL/BHEL/2024-2025/1241A-104	SH. NO. 03 OF 03

TB202359-1002269-SS3480-LTSWR-DRG/00/CAT-I/Page: 125 of 258

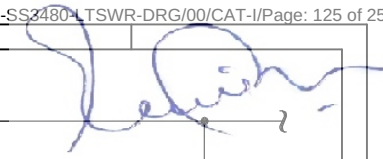D

F

U/L **ULTIMA® SWITCHGEARS LTD.**

UNIT-I KHASRA NO. 215, IND. AREA, VILLAGE RAIPUR (BHAGWANPUR TEHSIL - ROORKEE, DISTRICT HARIDWAR (UTTRAKHAND) - 247867, INDIA, TEL : 01332-235043 FAX : 01332-235042

UNIT-II F-6 & F-7, SITE-C, UPSIDC, SURAJPUR INDUSTRIAL AREA, GREATER NOIDA - 201306 G. B. NAGAR (U.P.) INDIA

E-mail : info@ultimaswitchgear.com

DRAWING	SINGLE LINE DIAGRAM	JOB NO.
TITLE	415V EMERGENCY LIGHTING DISTRIBUTION BOARD (4A) (MCRB)	1241A
CA NO.	CC/T/W-AIS/DOM/A10/23/01956/NOA-1/24-102643/01 & 02 DATED 23.02.2024	
PROJECT	765/400/220KV BIKANER-III POOLING STATION	
 CLIENT POWER GRID CORPORATION OF INDIA LIMITED		 CONTRACTOR:- BHARAT HEAVY ELECTRICAL LIMITED (BHEL) TRANSMISSION PROJECTS DIVISION
DRG. NO.	USL/PGCIL/BHEL/2024-2025/1241A-204	SH. NO.:- 01 OF 03

D

F

MANUFACTURER

 **ULTIMA® SWITCHGEARS LTD.**


UNIT-I KHASRA NO. 215, IND. AREA, VILLAGE RAIPUR (BHAGWANPUR
TEHSIL - ROORKEE, DISTRICT HARIDWAR (UTTRAKHAND) -
247667, INDIA, TEL : 01332-235043 FAX : 01332-235042

UNIT-II F-6 & F-7, SITE-C, UPSIDC, SURAJPUR INDUSTRIAL AREA,
GREATER NOIDA - 201306 G. B. NAGAR (U.P.) INDIA

E-mail : info@ultimaswitchgear.com

DRAWING	SINGLE LINE DIAGRAM	JOB NO.
TITLE	415V EMERGENCY LIGHTING DISTRIBUTION BOARD (4A) (MCRB)	1241A
CA NO.	CC/T/W-AIS/DOM/A10/23/01956/NDA-1/24-102643/01 & 02 DATED 23.02.2024	
PROJECT	765/400/220KV BIKANER-III POOLING STATION	
 CLIENT POWER GRID CORPORATION OF INDIA LIMITED		 CONTRACTOR:- BHARAT HEAVY ELECTRICAL LIMITED (BHEL) TRANSMISSION PROJECTS DIVISION
DRG. NO.	USL/PGCIL/BHEL/2024-2025/1241A-204	SH. NO.:- 02 OF 03

This Drawing & information or descriptive matter set out hereon are the confidential property of **ULTIMA SWITCHGEARS LIMITED** & must not be disclosed, copied,loaned or used for manufacturing,tendering or for any other purpose without their permission.

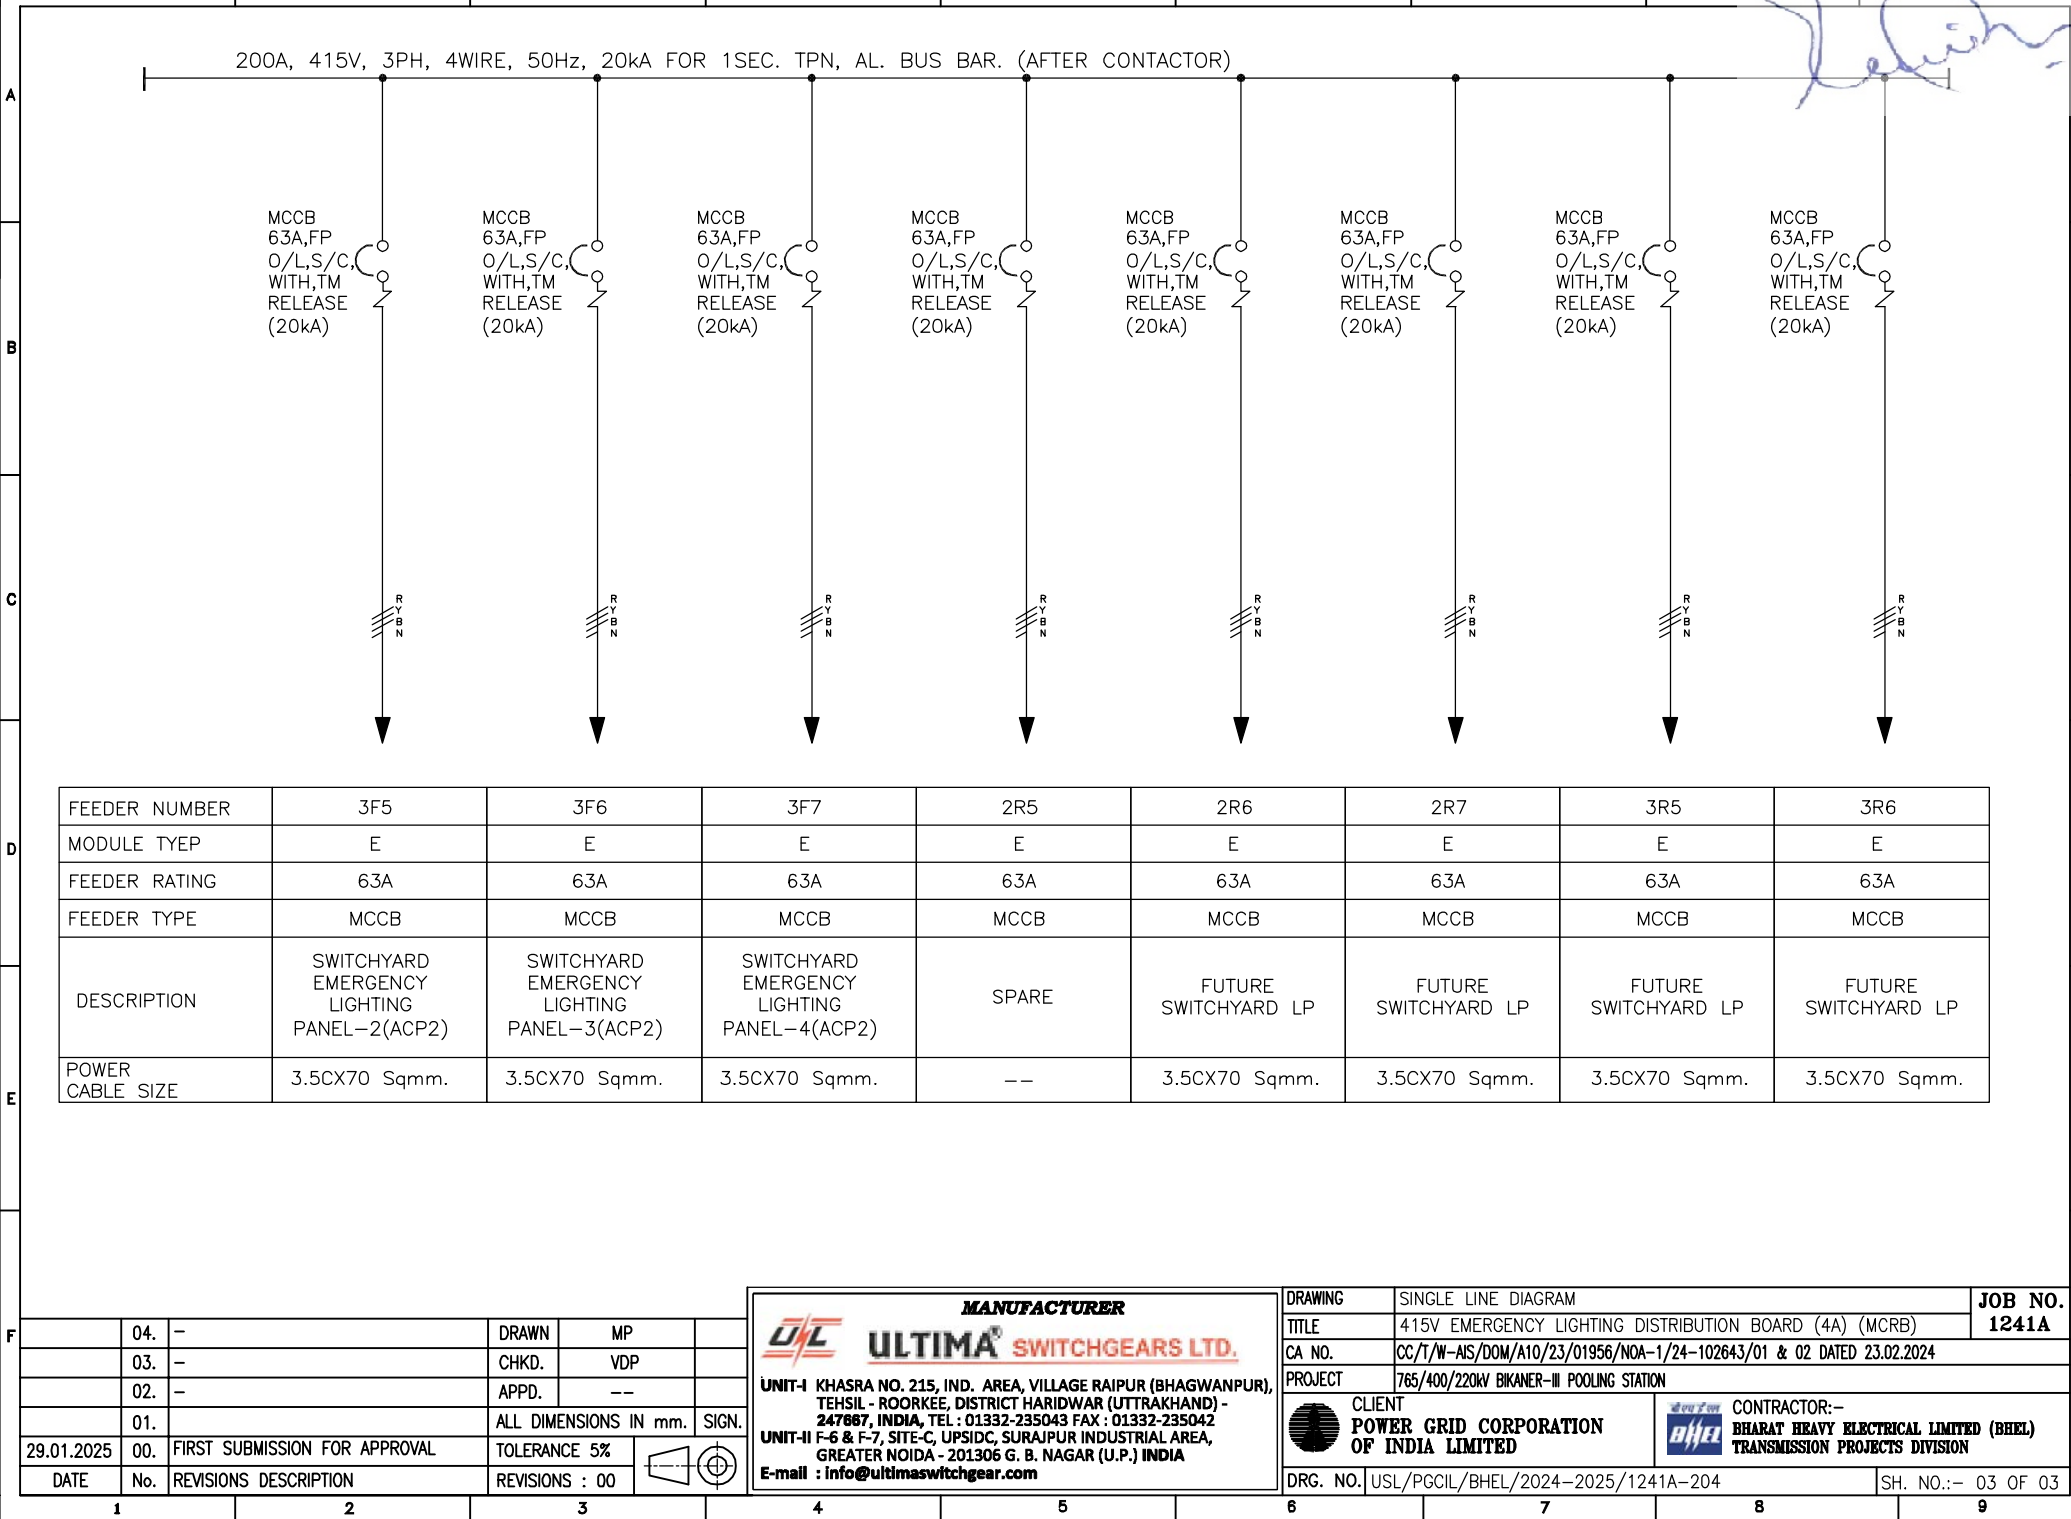

BILL OF MATERIAL FOR 415V EMERGENCY LIGHTING DISTRIBUTION BOARD (4A) (MCRB)

S.NO.	ITEM CODE	DESCRIPTION	MAKE	RATING	QTY.
A	BILL OF MATERIAL FOR MODULE - (H)				1 No.
1	MCCB	FP MCCB, WITH THERMAL MAGNETIC BASED RELEASE FOR 80–100 % O/L, S/C PROTECTION WITH SPREADER LINK, ROTARY OPERATING MECHANISM (ROM) & 1C/O AUX. CONTACT, Ics=100% Icu	L&T/C&S/HAVELLS	200A, 20kA	01
2	MCB	SP MINIATURE CIRCUIT BREAKER, 'C' CURVE	L&T/C&S/HAVELLS	6A, 10kA	01
3	LIGHTING TRF	LIGHTING TRANSFORMER 415/415 Dyn1	PGCIL APPROVED	100kVA	01
4	h1	'ON' INDICATION LAMP, 22.5 Sq. mm. DIA ,LED TYPE, RED, 240V AC	ESBEE/VAISHNO/C&S	--	01
B	BILL OF MATERIAL FOR MODULE - (EL)				1 No.
1	MCCB	FP MCCB, WITH THERMAL MAGNETIC BASED RELEASE FOR 80–100 % O/L, S/C PROTECTION WITH SPREADER LINK & ROTARY OPERATING MECHANISM (ROM), Ics = 100% Icu	L&T/C&S/HAVELLS	200A, 20kA	01
2	CM	FP POWER CONTACTOR, COIL VOLTAGE 240V AC, WITH 2NO+2NC AUX. CONTACT, AC-1 DUTY	L&T/C&S/HAVELLS	200A	01
3	MCB	SP MINIATURE CIRCUIT BREAKER, 'C' CURVE	L&T/C&S/HAVELLS	6A, 10kA	01
4	h1	'ON' INDICATION LAMP, 22.5 Sq. mm. DIA ,LED TYPE, RED, 240V AC	ESBEE/VAISHNO/C&S	--	01
5	h2	'OFF' INDICATION LAMP, 22.5 Sq. mm. DIA ,LED TYPE, GREEN, 240V AC	ESBEE/VAISHNO/C&S	--	01
6	P1	'STOP' PUSH BUTTON, SPRING RETURN TYPE, 22.5 Sq. mm. DIA WITH 2NC CONTACT, RED	ESBEE/VAISHNO/C&S	--	01
7	P2	'START' PUSH BUTTON, SPRING RETURN TYPE, 22.5 Sq. mm. DIA WITH 2NO CONTACT, GREEN	ESBEE/VAISHNO/C&S	--	01
8	T	24 HOURS TIMER SWITCH DIN RAIL MOUNTED , 1C/O AUX. CONTACT	GIC/EAPL	--	01
9	A/M	AUTO/MANUAL SELECTOR SWITCH WITH OFF, 3POLE 3WAY, ROTARY TYPE	SALZER/KAYCEE	--	01

NOTE:– ALL COMPONENTS SHALL BE POWER GRID (QA&I) APPROVED MAKE

	04.	–	DRAWN	MP	
	03.	–	CHKD.	VDP	
	02.	–	APPD.	--	
	01.		ALL DIMENSIONS IN mm. SIGN.		
29.01.2025	00.	FIRST SUBMISSION FOR APPROVAL	TOLERANCE 5%		
DATE	No.	REVISIONS DESCRIPTION	REVISIONS : 00		

MANUFACTURER

 **ULTIMA® SWITCHGEARS LTD.**

UNIT-I KHASRA NO. 215, IND. AREA, VILLAGE RAIPUR (BHAGWANPUR), TEHSIL - ROORKEE, DISTRICT HARIDWAR (UTTRAKHAND) - 247687, INDIA, TEL : 01332-235043 FAX : 01332-235042

UNIT-II F-6 & F-7, SITE-C, UPSIDC, SURAJPUR INDUSTRIAL AREA, GREATER NOIDA - 201306 G. B. NAGAR (U.P.) INDIA

E-mail : info@ultimaswitchgear.com

DRAWING	BILL OF MATERIAL	JOB NO.
TITLE	415V EMERGENCY LIGHTING DISTRIBUTION BOARD (4A) (MCRB)	1241A
CA NO.	CC/T/W-AIS/DOM/A10/23/01956/NOA-1/24-102643/01 & 02 DATED 23.02.2024	
PROJECT	765/400/220KV BIKANER-III POOLING STATION	
CLIENT	CONTRACTOR:–	
 POWER GRID CORPORATION OF INDIA LIMITED	 BHARAT HEAVY ELECTRICAL LIMITED (BHEL) TRANSMISSION PROJECTS DIVISION	
DRG. NO.	USL/PGCIL/BHEL/2024–2025/1241A–704	SH. NO.:– 01 OF 02

1 2 3 4 5 6 7 8 9

[Handwritten Signature]

BILL OF MATERIAL FOR 415V EMERGENCY LIGHTING DISTRIBUTION BOARD (4A) (MCRB)

S.NO.	ITEM CODE	DESCRIPTION	MAKE	RATING	QTY.
C	BILL OF MATERIAL FOR MODULE - (G2)				1 No.
1	MCB1-3	SP MINIATURE CIRCUIT BREAKER, 'C' CURVE	L&T/C&S/HAVELLS	6A, 10kA	03
2	V	ANALOG VOLTMETER, SINGLE PHASE, SIZE-96X96 Sq. mm, CL-1.0, PTR-415V	AE/RISHAB/NEWTEK/SECURE	0-500V	01
3	VSS	VOLTMETER SELECTOR SWITCH, ROTARY TYPE, 4 POSITION	SALZER/KAYCEE	6A	01
4	R-PHASE	'R' INDICATION LAMP, 22.5 Sq. mm. DIA ,LED TYPE, RED, 240V AC	ESBEE/VAISHNO/C&S	--	01
5	Y-PHASE	'Y' INDICATION LAMP, 22.5 Sq. mm. DIA ,LED TYPE, YELLOW	ESBEE/VAISHNO/C&S	--	01
6	B-PHASE	'B' INDICATION LAMP, 22.5 Sq. mm. DIA ,LED TYPE, BLUE	ESBEE/VAISHNO/C&S	--	01
D	BILL OF MATERIAL FOR MODULE (E)				
1	MCCB	FP MCCB 415V, WITH THERMAL MAGNETIC BASED RELEASE FOR O/L,S/C PROTECTION WITH EXTENDED ROM, Ics = 100% Icu	L&T/C&S/HAVELLS	63A, 20kA	20
E	BILL OF MATERIAL FOR MISC.				
1	MCB	SP MINIATURE CIRCUIT BREAKER, 'C' CURVE	L&T/C&S/HAVELLS	6A, 10kA	03
2	R-SW	ON/OFF ROTARY SWITCH	PGCIL APPROVED MAKE	6A	01
3	SW - SOCKET	5/15A SWITCH SOCKET	ANCHOR	--	01
4	DS	DOOR SWITCH, 1C/O	SURAJ/PGCIL APPROVED MAKE	--	02
5	PL	PANEL ILLUMINATION LIGHT, 240V AC	HAVELLS/PGCIL APPROVED MAKE	5W	02
6	SH	SPACE HEATER, 240V AC	HOTWEL/PGCIL APPROVED MAKE	60W	02
7	TH	THERMOSTATE, 240V AC	ELCON/PGCIL APPROVED MAKE	30 - 85°C	03
8	T1	ON DELAY TIMER WITH 1C/O AUXILIARY SWITCH, 0-60 SEC., 240V AC	GIC/EAPL/PGCIL APPROVED MAKE	--	01
9	T1X	AUX. CONTACTOR RELAY, COIL VOLTAGE 240V DC WITH 2NO+2NC AUX. CONTACT	L&T/C&S/HAVELLS	--	01
10	FAN 1-3	VANTILATION FAN (150MM), 240V AC	HIGH COOL/PGCIL APPROVED MAKE	--	03

NOTE:- ALL COMPONENTS SHALL BE POWER GRID (QA&I) APPROVED MAKE

	04.	-	DRAWN	MP	
	03.	-	CHKD.	VDP	
	02.	-	APPD.	--	
	01.		ALL DIMENSIONS IN mm. SIGN.		
29.01.2025	00.	FIRST SUBMISSION FOR APPROVAL	TOLERANCE 5%		
DATE	No.	REVISIONS DESCRIPTION	REVISIONS : 00		

MANUFACTURER
ULTIMA SWITCHGEARS LTD.

UNIT-I KHASRA NO. 215, IND. AREA, VILLAGE RAIPUR (BHAGWANPUR), TEHSIL - ROORKEE, DISTRICT HARIDWAR (UTTRAKHAND) - 247687, INDIA, TEL : 01332-235043 FAX : 01332-235042
UNIT-II F-6 & F-7, SITE-C, UPSIDC, SURAJPUR INDUSTRIAL AREA, GREATER NOIDA - 201306 G. B. NAGAR (U.P.) INDIA
E-mail : info@ultimaswitchgear.com

DRAWING	BILL OF MATERIAL	JOB NO.
TITLE	415V EMERGENCY LIGHTING DISTRIBUTION BOARD (4A) (MCRB)	1241A
CA NO.	CC/T/W-AIS/DOM/A10/23/01956/NOA-1/24-102643/01 & 02 DATED 23.02.2024	
PROJECT	765/400/220KV BIKANER-III POOLING STATION	
CLIENT POWER GRID CORPORATION OF INDIA LIMITED		CONTRACTOR:- BHARAT HEAVY ELECTRICAL LIMITED (BHEL) TRANSMISSION PROJECTS DIVISION
DRG. NO.	USL/PGCIL/BHEL/2024-2025/1241A-704	SH. NO.:- 02 OF 02

This Drawing & information or descriptive matter set out hereon are the confidential property of **ULTIMA SWITCHGEARS LIMITED** & must not be disclosed, copied, loaned or used for manufacturing, tendering or for any other purpose without their permission.

[Handwritten Signature]

ENGINEERING DRAWING DETAILS FOR
220V DC DISTRIBUTION BOARD-1(1D)(MCRB)

PROJECT :- 765/400/220kV BIKANER-III POOLING STATION
CLIENT :- POWER GRID CORPORATION OF INDIA LIMITED
CONTRACTOR :- BHARAT HEAVY ELECTRICAL LIMITED (BHEL)
TRANSMISSION PROJECTS DIVISION



	04.	-	DRAWN	MP	
	03.	-	CHKD.	VDP	
	02.	-	APPD.	--	
	01.		ALL DIMENSIONS IN mm.	SIGN.	
29.01.2025	00.	FIRST SUBMISSION FOR APPROVAL	TOLERANCE 5%		
DATE	No.	REVISIONS DESCRIPTION	REVISIONS : 00		

ULTIMA[®] SWITCHGEARS LTD.

MANUFACTURER
UNIT-I KHASRA NO. 215, IND. AREA, VILLAGE RAIPUR (BHAGWANPUR),
TEHSIL - ROORKEE, DISTRICT HARIDWAR (UTTRAKHAND) -
247667, INDIA, TEL : 01332-235043 FAX : 01332-235042
UNIT-II F-6 & F-7, SITE-C, UPSIDC, SURAJPUR INDUSTRIAL AREA,
GREATER NOIDA - 201306 G. B. NAGAR (U.P.) INDIA
E-mail : info@ultimaswitchgear.com

DRAWING	COVER PAGE	JOB NO.
TITLE	220V DC DISTRIBUTION BOARD-1(1D)(MCRB)	1241A
CA NO.	CC/T/W-AIS/DOM/A10/23/01956/NOA-1/24-102643/01 & 02 DATED 23.02.2024	
PROJECT	765/400/220kV BIKANER-III POOLING STATION	
CLIENT	POWER GRID CORPORATION OF INDIA LIMITED	CONTRACTOR:- BHARAT HEAVY ELECTRICAL LIMITED (BHEL) TRANSMISSION PROJECTS DIVISION
DRG. NO.	USL/PGCIL/BHEL/2024-2025/1241A-005	SH. NO. 01 OF 01


This Drawing & information or descriptive matter set out hereon are the confidential property of **ULTIMA SWITCHGEARS LIMITED** & must not be disclosed, copied,loaned or used for manufacturing,tendering or for any other purpose without their permission.

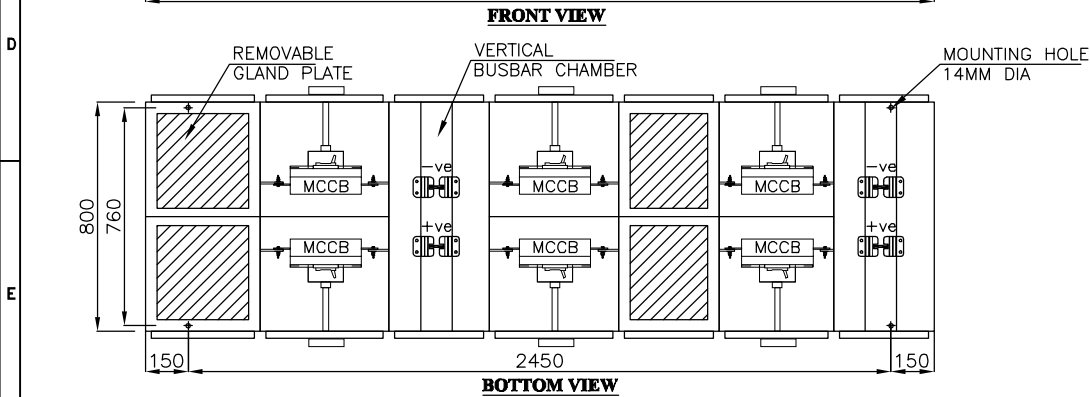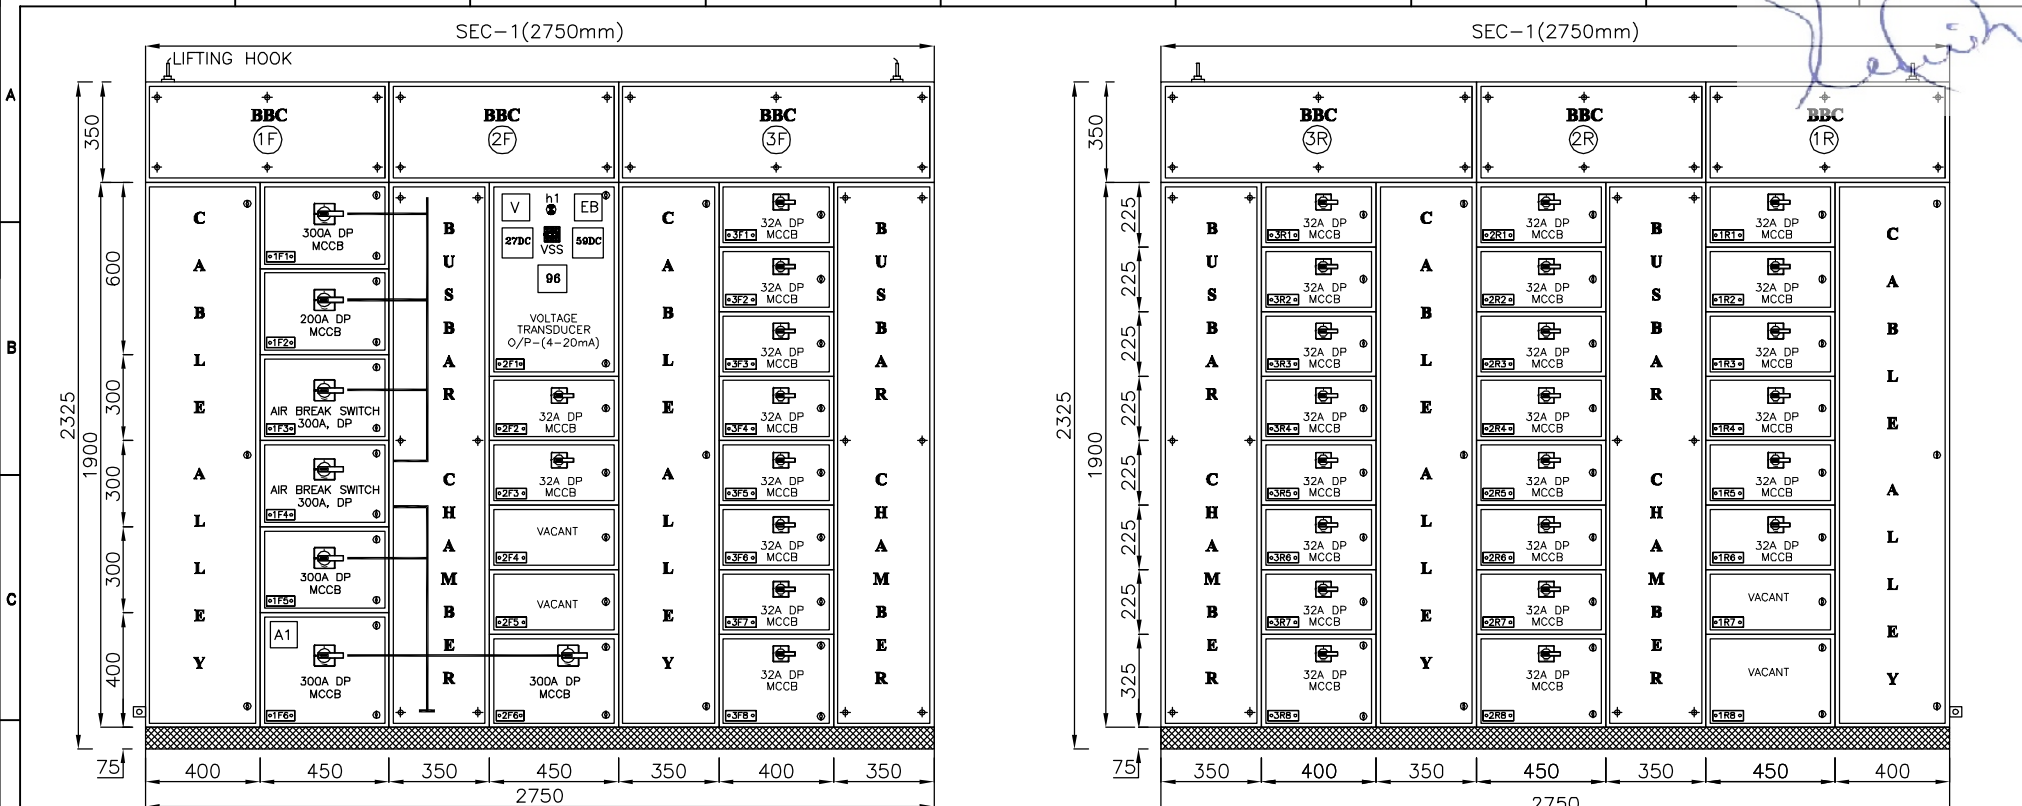

F		04.	—	DRAWN	MP		 ULTIMA[®] SWITCHGEARS LTD. UNIT-I KHASRA NO. 215, IND. AREA, VILLAGE RAIPUR (BHAGWANPUR), TEHSIL - ROORKEE, DISTRICT HARIDWAR (UTTRAKHAND) - 247687, INDIA, TEL : 01332-235043 FAX : 01332-235042 UNIT-II F-6 & F-7, SITE-C, UPSIDC, SURAJPUR INDUSTRIAL AREA, GREATER NOIDA - 201306 G. B. NAGAR (U.P.) INDIA E-mail : info@ultimaswitchgear.com	DRAWING	GENERAL ARRANGEMENT DRAWING		JOB 124						
		03.	—	CHKD.	VDP			TITLE	220V DC DISTRIBUTION BOARD—1(1D)(MCRB)								
		02.	—	APPD.	—			CA NO.	CC/T/W-AIS/DOM/A10/23/01956/NOA-1/24-102643/01 & 02 DATED 23.02.2024								
		01.	ALL DIMENSIONS IN mm.			SIGN.		PROJECT	765/400/220KV BIKANER-III POOLING STATION								
	29.01.2025	00.	FIRST SUBMISSION FOR APPROVAL		TOLERANCE 5%			 CLIENT POWER GRID CORPORATION OF INDIA LIMITED	 CONTRACTOR:— BHARAT HEAVY ELECTRICAL LIMITED (BHEL) TRANSMISSION PROJECTS DIVISION								
	DATE	No.	REVISIONS DESCRIPTION		REVISIONS : 00					DRG. NO.	USL/PGCIL/BHEL/2024-2025/1241A-105						
	1		2		3			4		5		6		7		8	

This Drawing & information or descriptive matter set out hereon are the confidential property of **ULTIMA SWITCHGEARS LIMITED** & must not be disclosed, copied,loaned or used for manufacturing,tendering or for any other purpose without their permission.

[Handwritten Signature]

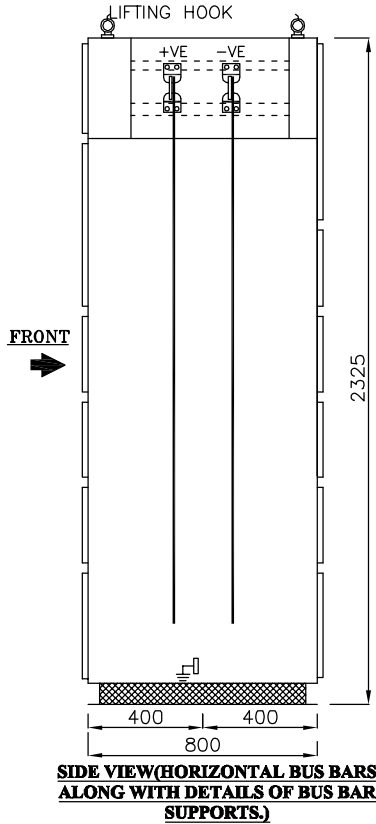

PANEL DIMENSIONS


HEIGHT : 2325 mm.
WIDTH : 2750 mm.
DEPTH : 800 mm.

BUS BAR SIZE :-

POSITIVE : 1x40x10 Sq.mm Alu.
NEGATIVE : 1x40x10 Sq.mm Alu.
EARTH : 1x40X05 Sq.mm GS.

LEGEND DETAILS

A1 = ANALOG DC AMMETER
V = ANALOG DC VOLT METER
96 = BATTERY EARTH FAULT RELAY
27DC = DC UNDER VOLTAGE RELAY
59DC = DC OVER VOLTAGE RELAY
EB = ELECTRONIC BUZZER

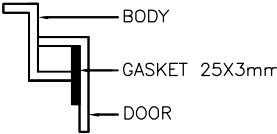

DETAIL-'A'

	04.	-	DRAWN	MP	
	03.	-	CHKD.	VDP	
	02.	-	APPD.	--	
	01.	-	ALL DIMENSIONS IN mm.	SIGN.	
29.01.2025	00.	FIRST SUBMISSION FOR APPROVAL	TOLERANCE 5%		
DATE	No.	REVISIONS DESCRIPTION	REVISIONS : 00		

MANUFACTURER

ULTIMA® SWITCHGEARS LTD.


UNIT-I KHASRA NO. 215, IND. AREA, VILLAGE RAIPUR (BHAGWANPUR), TEHSIL - ROORKEE, DISTRICT HARIDWAR (UTTRAKHAND) - 247667, INDIA, TEL : 01332-235043 FAX : 01332-235042

UNIT-II F-6 & F-7, SITE-C, UPSIDC, SURAJPUR INDUSTRIAL AREA, GREATER NOIDA - 201306 G. B. NAGAR (U.P.) INDIA

E-mail : info@ultimaswitchgear.com

DRAWING	GENERAL ARRANGEMENT DRAWING	JOB NO.	1241A
TITLE	220V DC DISTRIBUTION BOARD-1(1D)(MCRB)		
CA NO.	CC/T/W-AIS/DOM/A10/23/01956/NOA-1/24-102643/01 & 02 DATED 23.02.2024		
PROJECT	765/400/220KV BIKANER-III POOLING STATION		
CLIENT	POWER GRID CORPORATION OF INDIA LIMITED	CONTRACTOR:-	BHARAT HEAVY ELECTRICAL LIMITED (BHEL) TRANSMISSION PROJECTS DIVISION
DRG. NO.	USL/PGCIL/BHEL/2024-2025/1241A-105	SH. NO.	02 OF 02

This Drawing & information or descriptive matter set out hereon are the confidential property of **ULTIMA SWITCHGEARS LIMITED** & must not be disclosed, copied,loaned or used for manufacturing,tendering or for any other purpose without their permission.

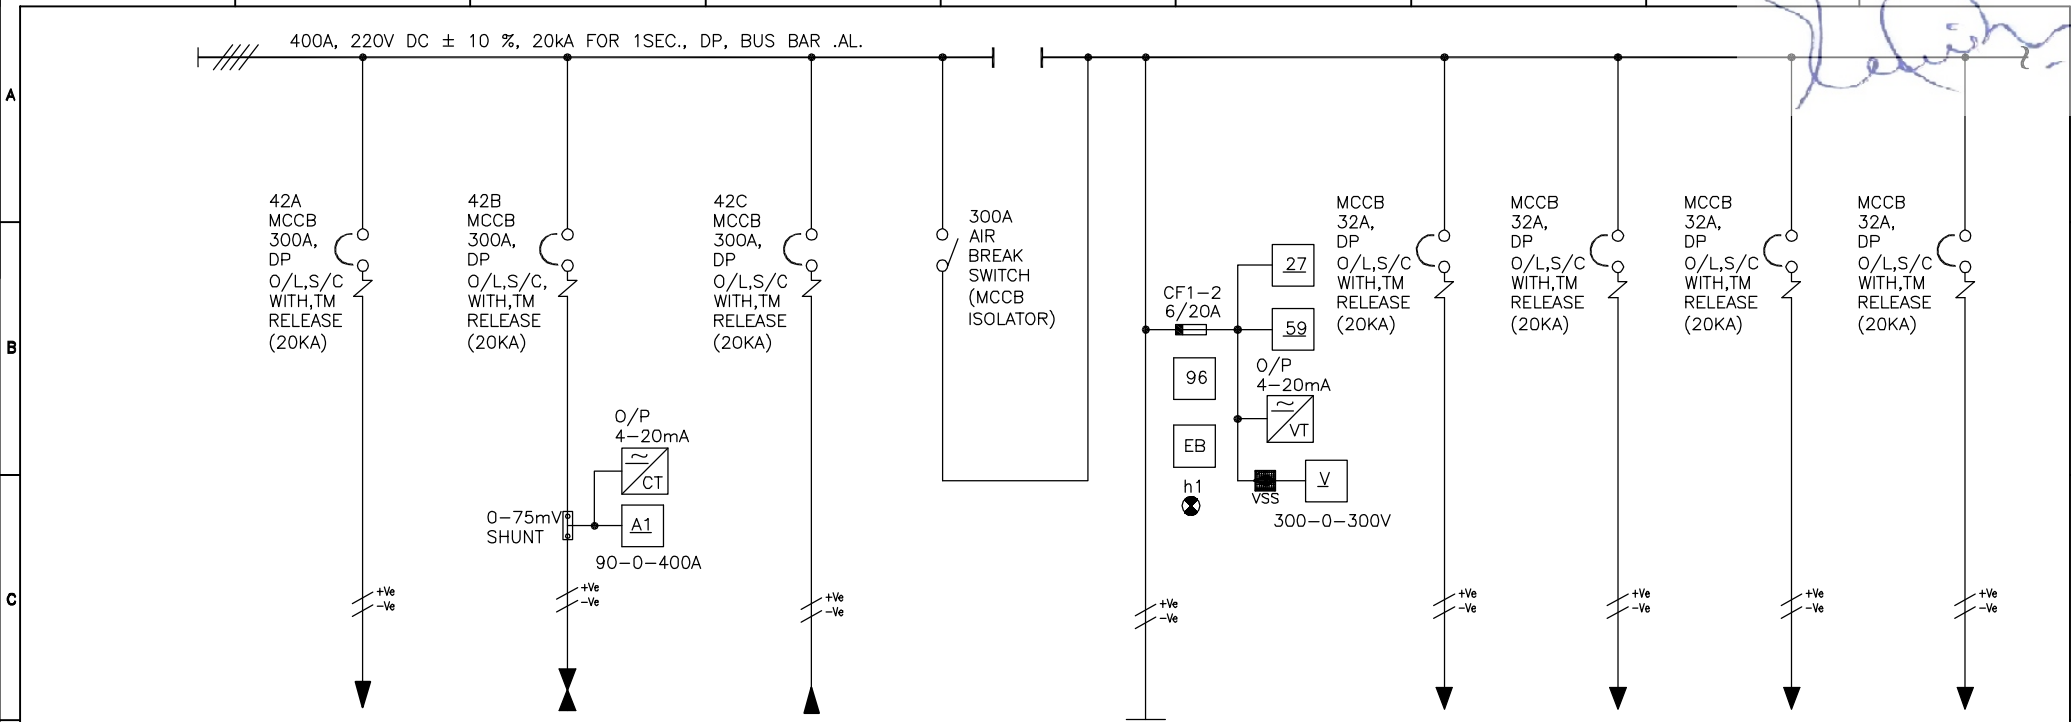

FEEDER NUMBER	2F6	1F6	1F5	1F4	2F1	2F2	2F3	3F1	3F2
MODULE TYEP	DC	DC	DC	H1	S1	X	X	X	X
FEEDER RATING	300A	300A	300A	300A	--	32A	32A	32A	32A
FEEDER TYPE	MCCB	MCCB	MCCB	ISOLATOR	METERING	MCCB	MCCB	MCCB	MCCB
DESCRIPTION	BATTERY CURATIVE DISCHARGE FEEDER	220V DC BATTERY BANK-1	220V DC INCOMER FROM BATTERY CHARGER-1	MAIN BUSBAR CONTROL FEEDER 220V DCDB-1	--	765kV RELAY PANEL 701	765kV RELAY PANEL 703	765kV RELAY PANEL 704	765kV RELAY PANEL 706
POWER CABLE SIZE (AL PVC)	2X1CX150 Sqmm.	2X1CX150 Sqmm.	2X1CX150 Sqmm.	--	--	1X4CX16 Sqmm.	1X4CX16 Sqmm.	1X4CX16 Sqmm.	1X4CX16 Sqmm.

F	04.	-	DRAWN	MP	
	03.	-	CHKD.	VDP	
	02.	-	APPD.	--	
	01.	-	ALL DIMENSIONS IN mm. SIGN.		
	29.01.2025	00.	FIRST SUBMISSION FOR APPROVAL		
DATE		No.	REVISIONS DESCRIPTION		REVISIONS : 00

MANUFACTURER


ULTIMA SWITCHGEARS LTD.


UNIT-I KHASRA NO. 215, IND. AREA, VILLAGE RAIPUR (BHAGWANPUR), TEHSIL - ROORKEE, DISTRICT HARIDWAR (UTTRAKHAND) - 247667, INDIA, TEL : 01332-235043 FAX : 01332-235042

UNIT-II F-6 & F-7, SITE-C, UPSIDC, SURAJPUR INDUSTRIAL AREA, GREATER NOIDA - 201306 G. B. NAGAR (U.P.) INDIA


E-mail : info@ultimaswitchgear.com

DRAWING	SINGLE LINE DIAGRAM		JOB NO.
TITLE	220V DC DISTRIBUTION BOARD-1(1D)(MCRB)		1241A
CA NO.	CC/T/W-AIS/DOM/A10/23/01956/NOA-1/24-102643/01 & 02 DATED 23.02.2024		
PROJECT	765/400/220KV BIKANER-III POOLING STATION		
	CLIENT		
	POWER GRID CORPORATION OF INDIA LIMITED		
		CONTRACTOR:-	
		BHARAT HEAVY ELECTRICAL LIMITED (BHEL) TRANSMISSION PROJECTS DIVISION	
DRG. NO.	USL/PGCIL/BHEL/2024-2025/1241A-205		SH. NO.:- 01 OF 05

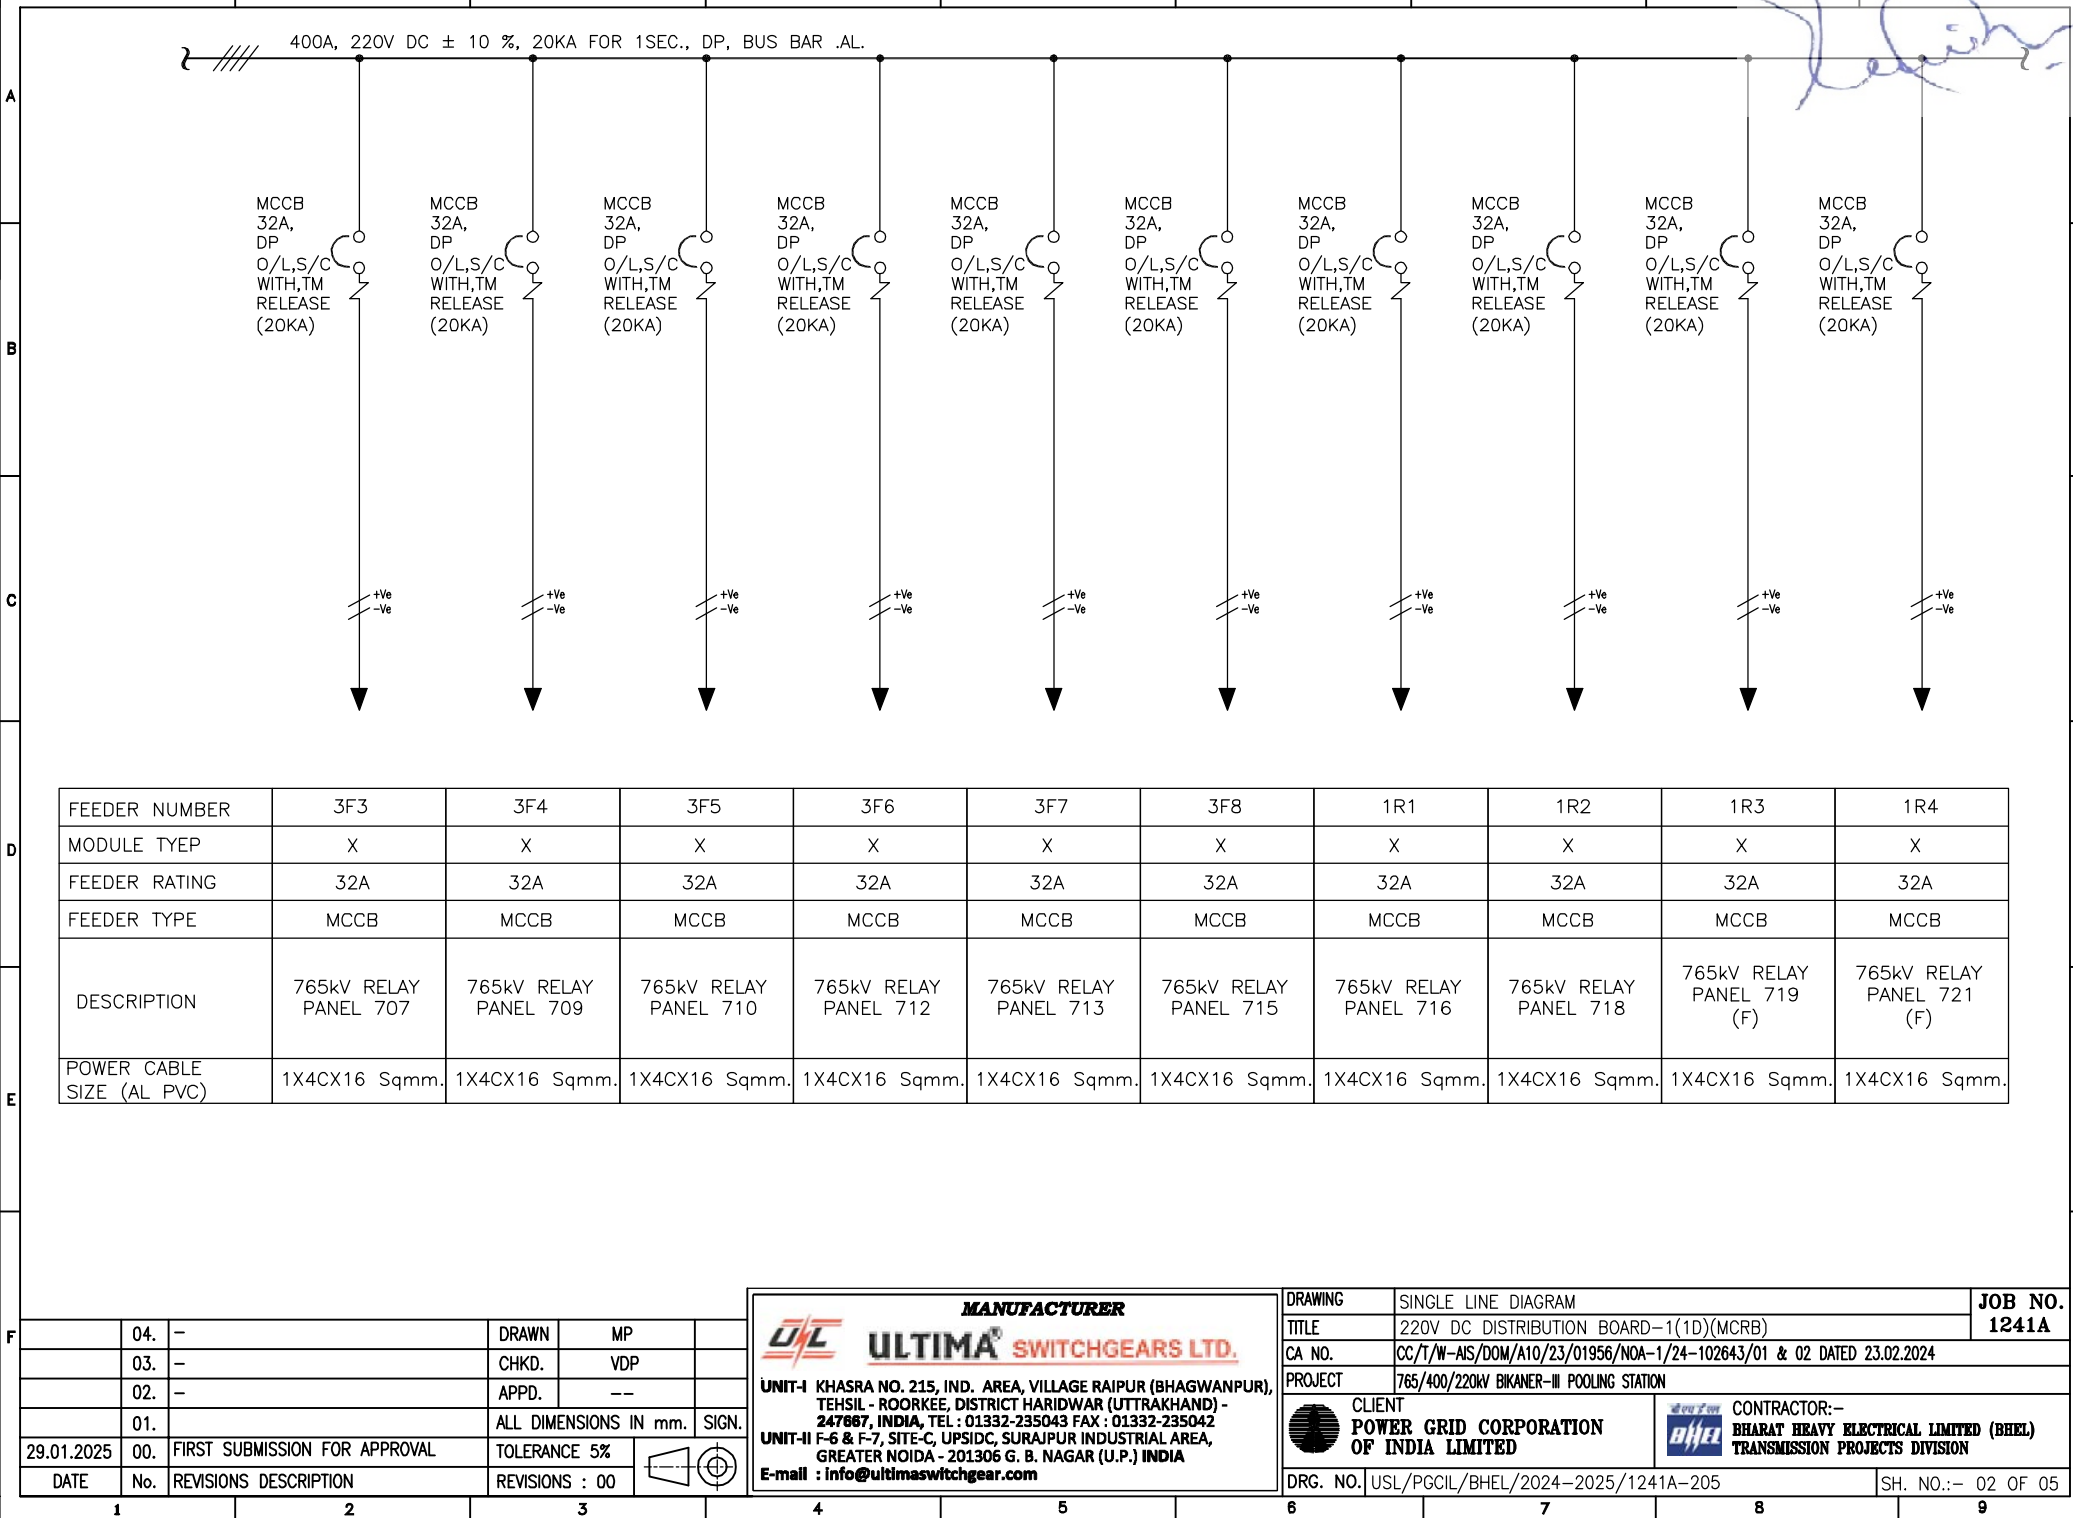

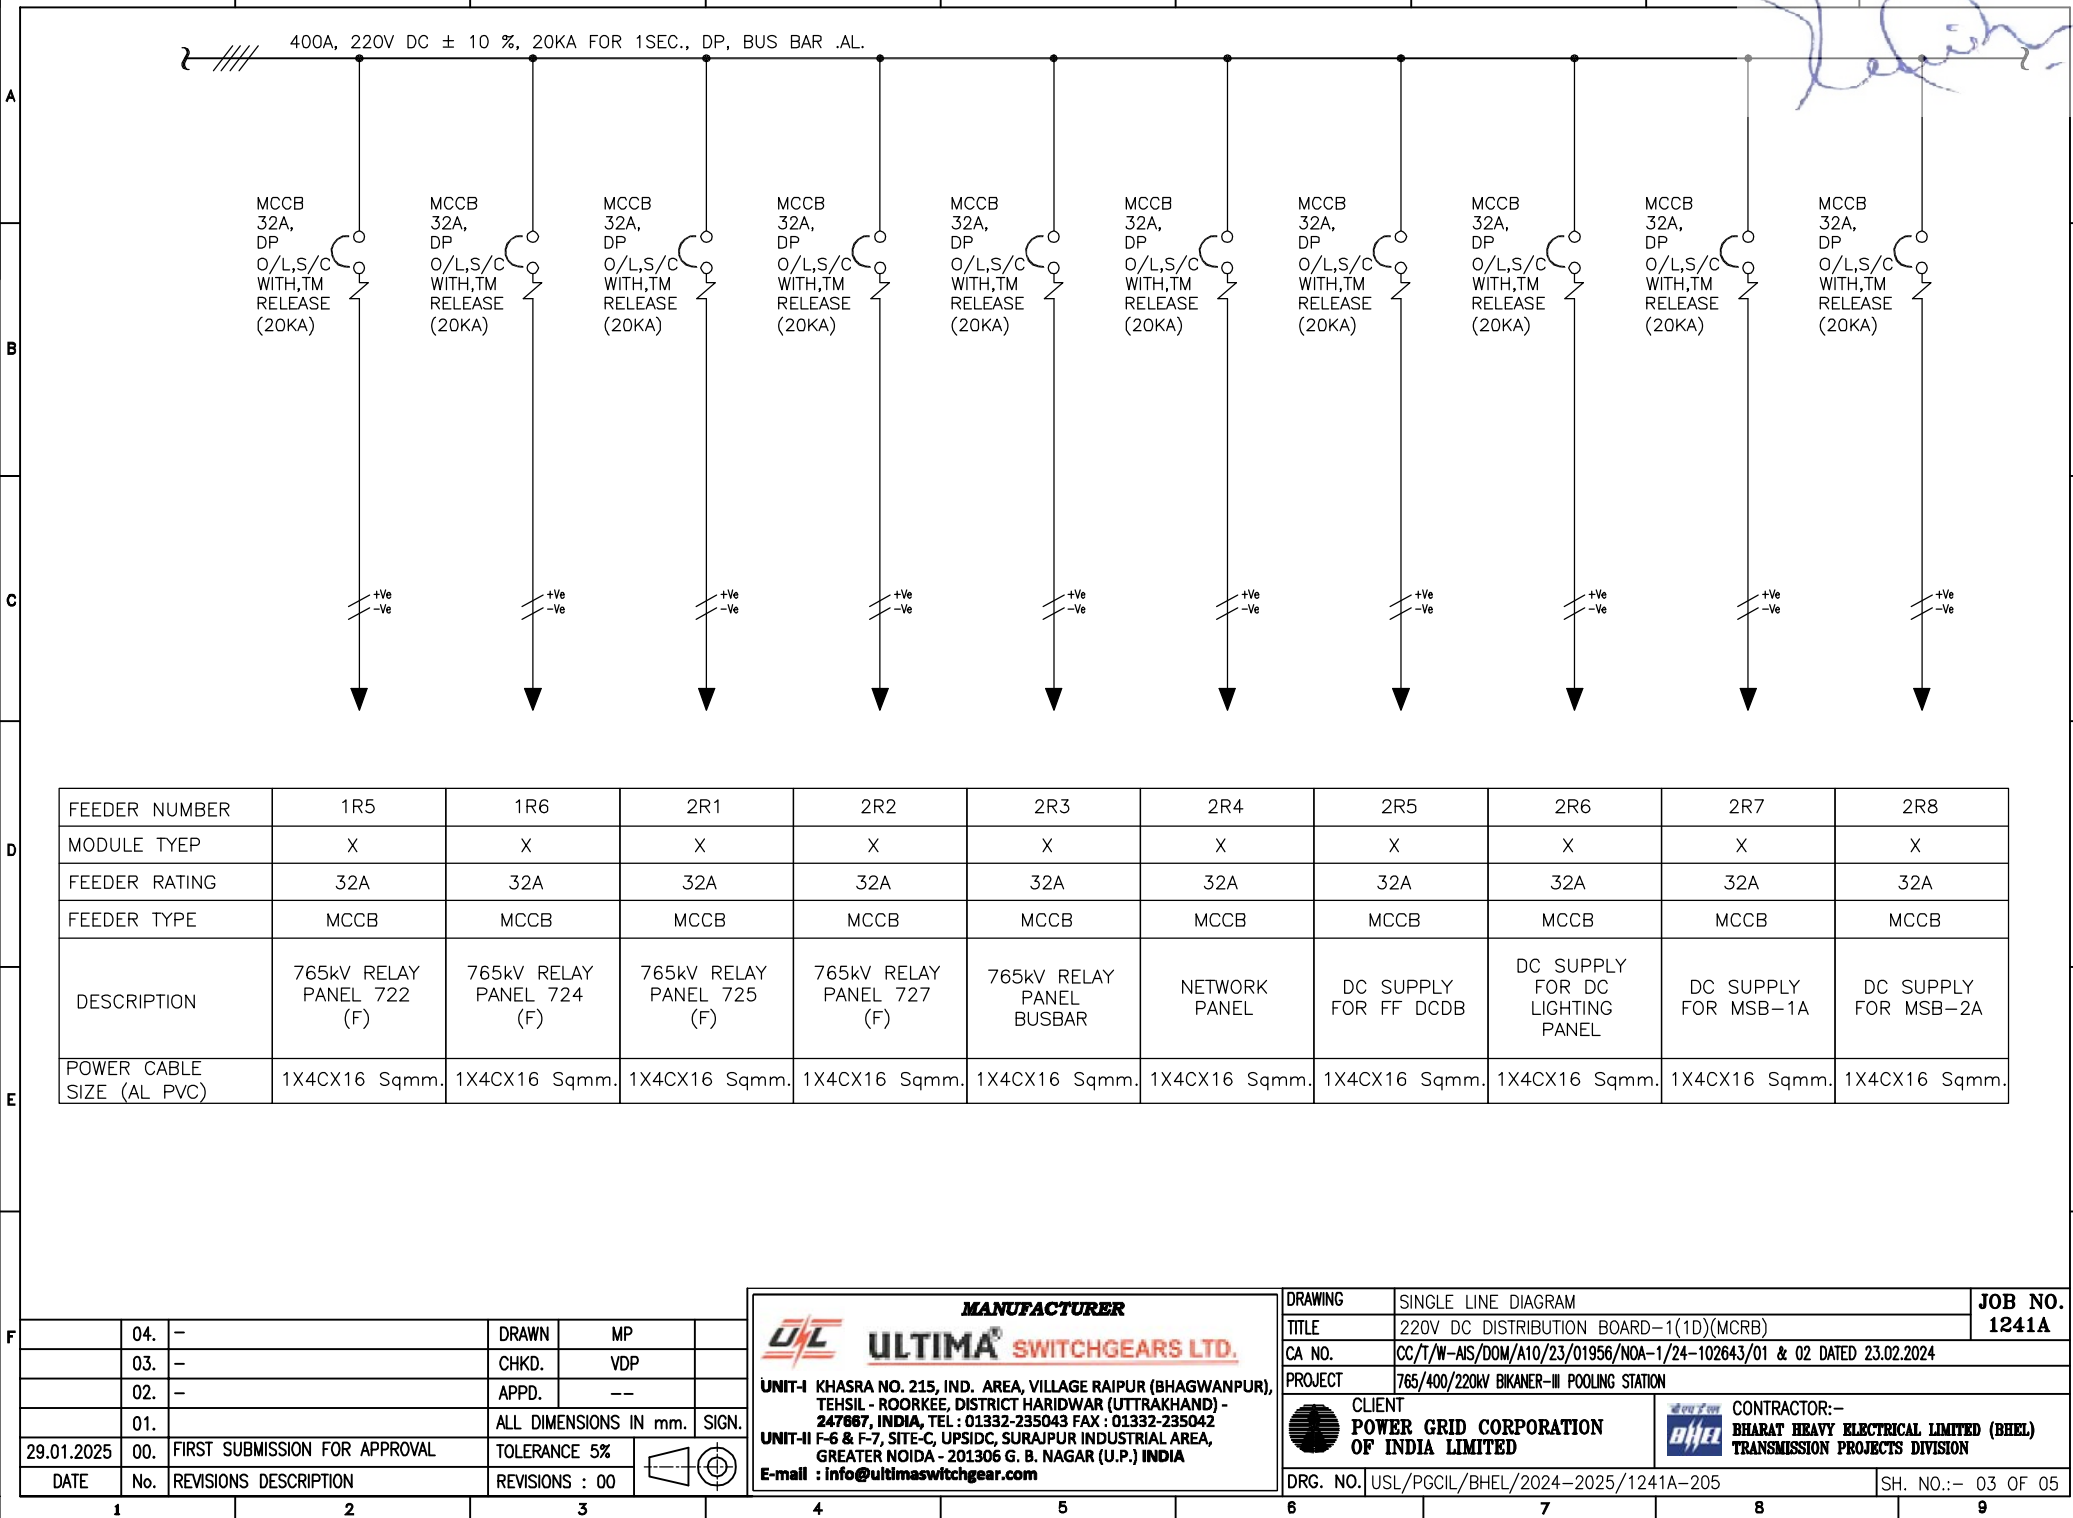

This Drawing & information or descriptive matter set out hereon are the confidential property of **ULTIMA SWITCHGEARS LIMITED** & must not be disclosed, copied,loaned or used for manufacturing,tendering or for any other purpose without their permission.

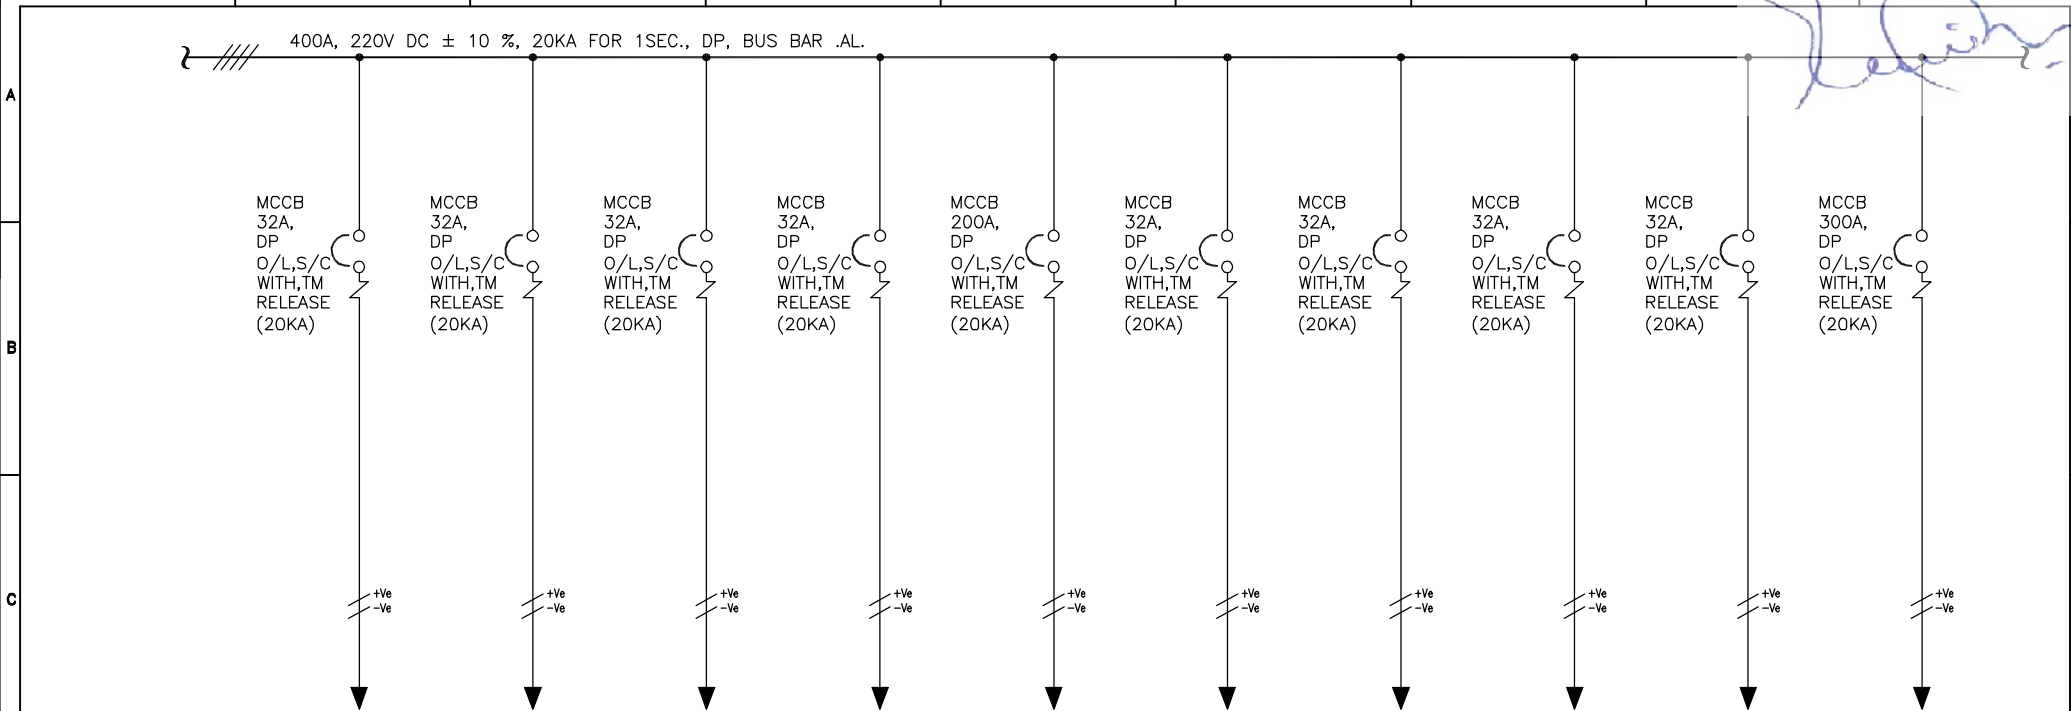

FEEDER NUMBER	3R1	3R2	3R3	3R4	1F2	3R5	3R6	3R7	3R8	1F1
MODULE TYEP	X	X	X	X	X	X	X	X	X	X
FEEDER RATING	32A	32A	32A	32A	200A	32A	32A	32A	32A	300A
FEEDER TYPE	MCCB	MCCB	MCCB	MCCB	MCCB	MCCB	MCCB	MCCB	MCCB	MCCB
DESCRIPTION	DC SUPPLY FOR INVERTER-1	DC SUPPLY FOR ELECTRONIC TEST LAB	DC SUPPLY FOR AUX. BCU PANEL	DC SUPPLY FOR MLDB	OUTGOING FEEDER TO 400&220kv DCDB	STATION HMI	SPARE-1	SPARE-2	SPARE-3	SPARE-4
POWER CABLE SIZE (AL PVC)	1X4CX16 Sqmm.	1X4CX16 Sqmm.	1X4CX16 Sqmm.	1X4CX16 Sqmm.	2X1CX150Sqmm.	1X4CX16 Sqmm.	--	--	--	--

	04.	-	DRAWN	MP	
	03.	-	CHKD.	VDP	
	02.	-	APPD.	--	
	01.	-	ALL DIMENSIONS IN mm. SIGN.		
29.01.2025	00.	FIRST SUBMISSION FOR APPROVAL	TOLERANCE 5%		
DATE	No.	REVISIONS DESCRIPTION	REVISIONS : 00		


MANUFACTURER
ULTIMA SWITCHGEARS LTD.

UNIT-I KHASRA NO. 215, IND. AREA, VILLAGE RAIPUR (BHAGWANPUR), TEHSIL - ROORKEE, DISTRICT HARIDWAR (UTTRAKHAND) - 247687, INDIA, TEL : 01332-235043 FAX : 01332-235042
UNIT-II F-6 & F-7, SITE-C, UPSIDC, SURAJPUR INDUSTRIAL AREA, GREATER NOIDA - 201306 G. B. NAGAR (U.P.) INDIA
E-mail : info@ultimaswitchgear.com

DRAWING	SINGLE LINE DIAGRAM		JOB NO.
TITLE	220V DC DISTRIBUTION BOARD-1(1D)(MCRB)		1241A
CA NO.	CC/T/W-AIS/DOM/A10/23/01956/NOA-1/24-102643/01 & 02 DATED 23.02.2024		
PROJECT	765/400/220KV BIKANER-III POOLING STATION		
	CLIENT POWER GRID CORPORATION OF INDIA LIMITED		CONTRACTOR:- BHARAT HEAVY ELECTRICAL LIMITED (BHEL) TRANSMISSION PROJECTS DIVISION
DRG. NO.	USL/PGCIL/BHEL/2024-2025/1241A-205		SH. NO.:- 04 OF 05

This Drawing & information or descriptive matter set out hereon are the confidential property of **ULTIMA SWITCHGEARS LIMITED** & must not be disclosed, copied,loaned or used for manufacturing,tendering or for any other purpose without their permission.

[Handwritten Signature]

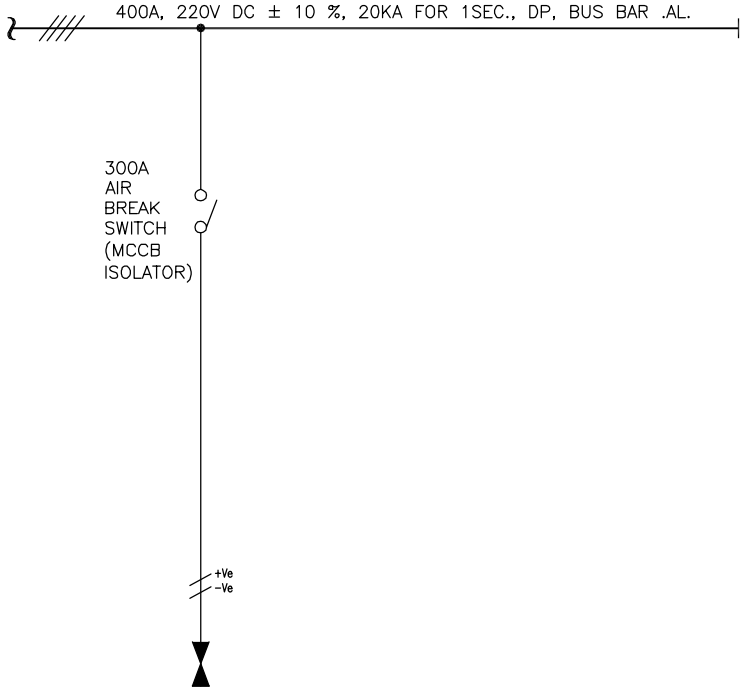

FEEDER NUMBER	1F3
MODULE TYEP	H1
FEEDER RATING	300A
FEEDER TYPE	ISOLATOR
DESCRIPTION	TO 220V DCDB-2
POWER CABLE SIZE (AL PVC)	2X1CX150 Sqmm.


	04.	—	DRAWN	MP	
	03.	—	CHKD.	VDP	
	02.	—	APPD.	--	
	01.		ALL DIMENSIONS IN mm. SIGN.		
29.01.2025	00.	FIRST SUBMISSION FOR APPROVAL	TOLERANCE 5%		
DATE	No.	REVISIONS DESCRIPTION	REVISIONS : 00		

MANUFACTURER
ULTIMA® SWITCHGEARS LTD.

UNIT-I KHASRA NO. 215, IND. AREA, VILLAGE RAIPUR (BHAGWANPUR), TEHSIL - ROORKEE, DISTRICT HARIDWAR (UTTRAKHAND) - 247667, INDIA, TEL : 01332-235043 FAX : 01332-235042
UNIT-II F-6 & F-7, SITE-C, UPSIDC, SURAJPUR INDUSTRIAL AREA, GREATER NOIDA - 201306 G. B. NAGAR (U.P.) INDIA
E-mail : info@ultimaswitchgear.com

DRAWING	SINGLE LINE DIAGRAM	JOB NO.	1241A
TITLE	220V DC DISTRIBUTION BOARD-1(1D)(MCRB)		
CA NO.	CC/T/W-AIS/DOM/A10/23/01956/NOA-1/24-102643/01 & 02 DATED 23.02.2024		
PROJECT	765/400/220KV BIKANER-III POOLING STATION		
	CLIENT		CONTRACTOR:-
	POWER GRID CORPORATION OF INDIA LIMITED		BHARAT HEAVY ELECTRICAL LIMITED (BHEL) TRANSMISSION PROJECTS DIVISION
DRG. NO.	USL/PGCIL/BHEL/2024-2025/1241A-205	SH. NO.:-	05 OF 05

This Drawing & information or descriptive matter set out hereon are the confidential property of **ULTIMA SWITCHGEARS LIMITED** & must not be disclosed, copied,loaned or used for manufacturing,tendering or for any other purpose without their permission.

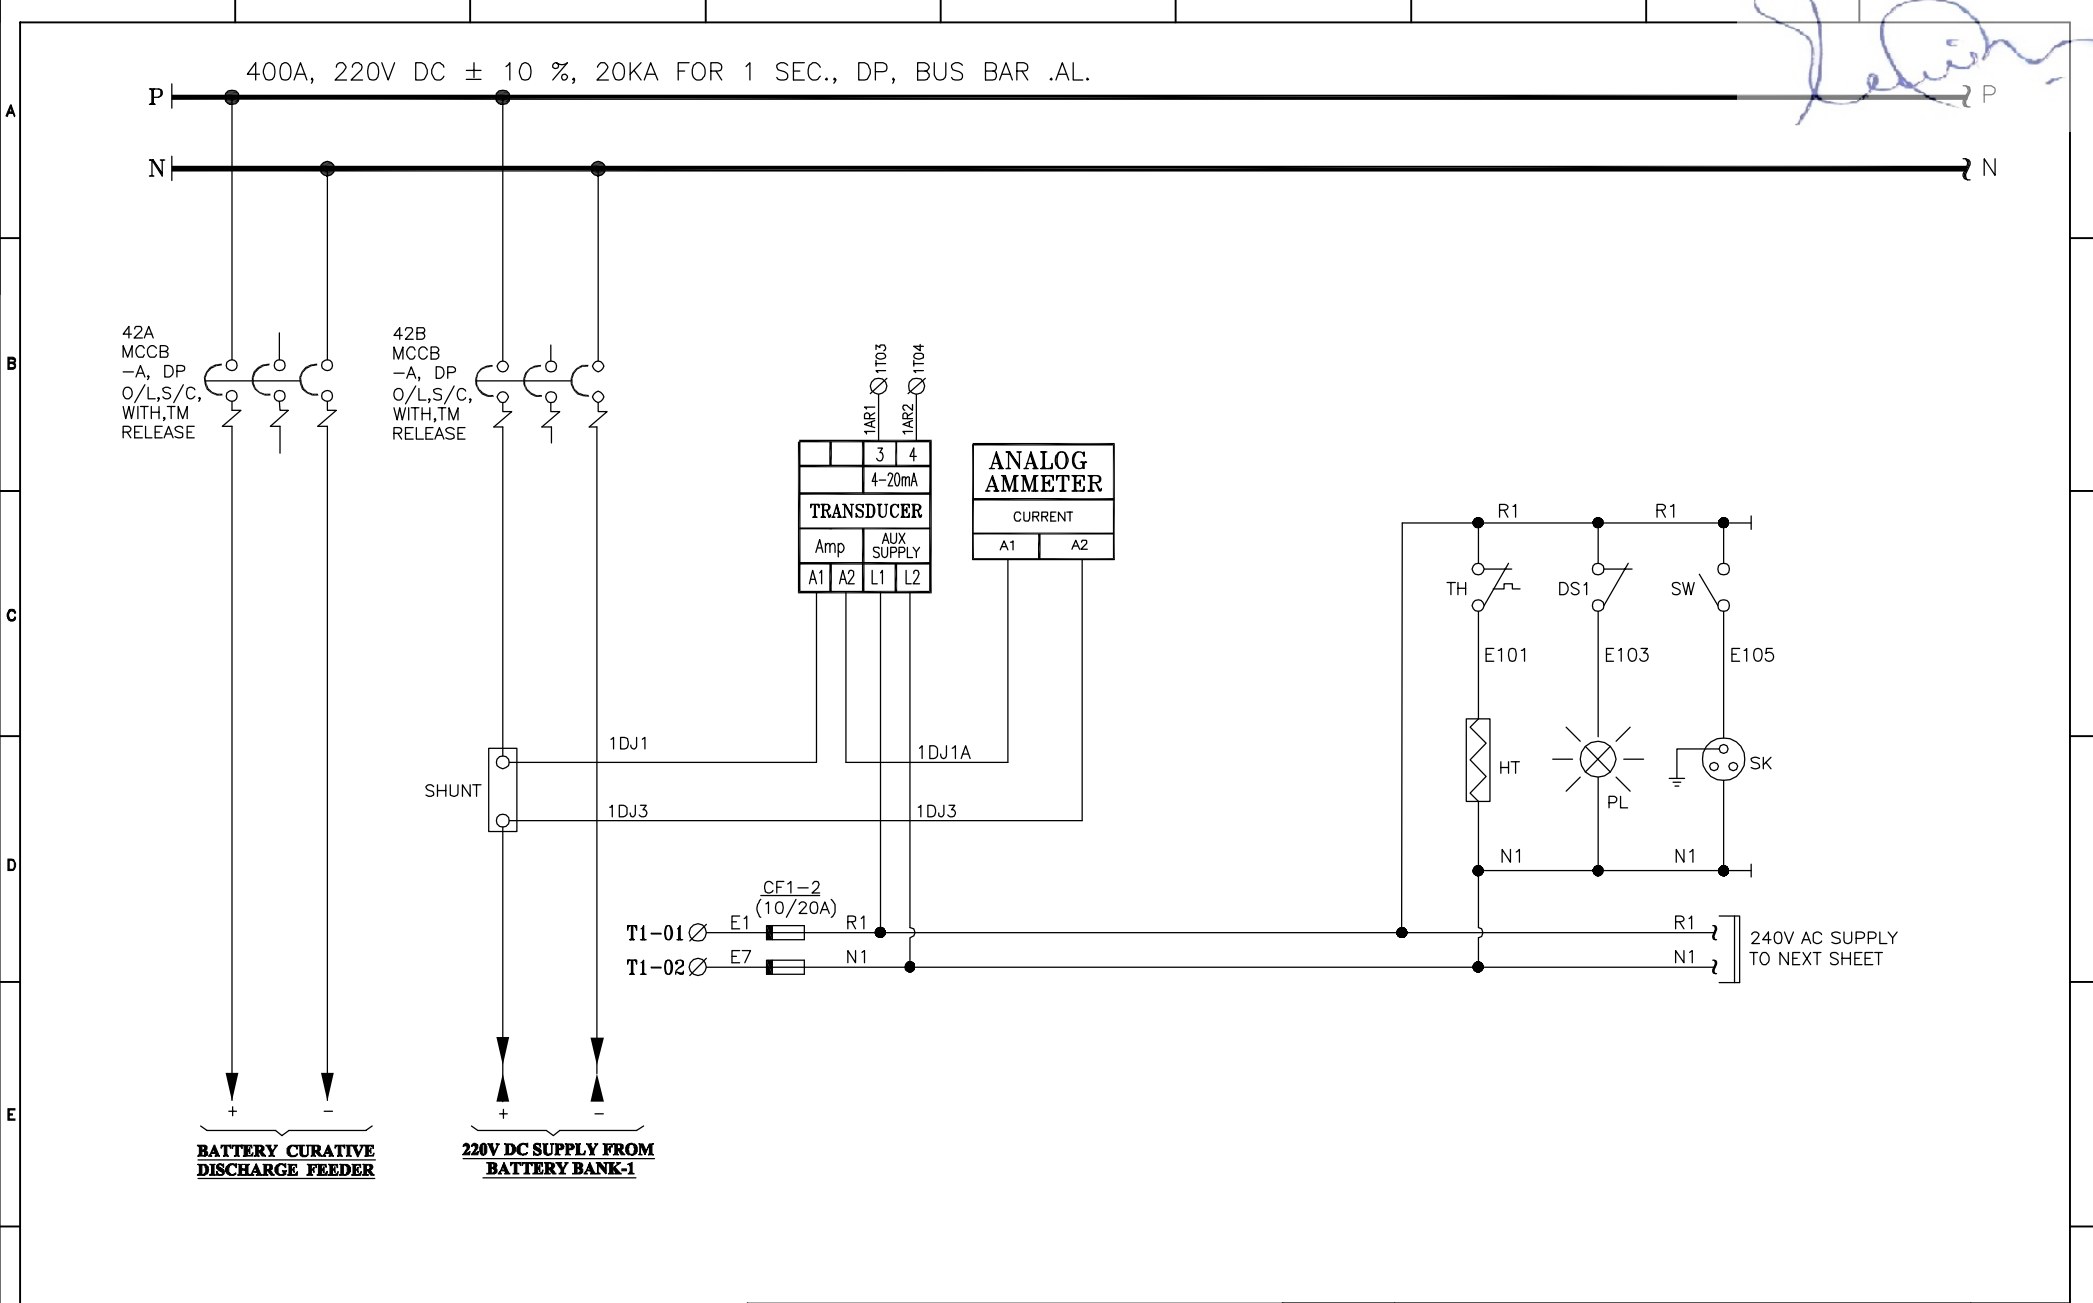

F	04.	-	DRAWN	MP	
	03.	-	CHKD.	VDP	
	02.	-	APPD.	--	
	01.	-	ALL DIMENSIONS IN mm. SIGN.		
	29.01.2025	00.	FIRST SUBMISSION FOR APPROVAL		
	DATE	No.	REVISIONS	DESCRIPTION	REVISIONS : 00

**ULTIMA[®] SWITCHGEARS LTD.**

MANUFACTURER


UNIT-I KHASRA NO. 215, IND. AREA, VILLAGE RAIPUR (BHAGWANPUR), TEHSIL - ROORKEE, DISTRICT HARIDWAR (UTTRAKHAND) - 247687, INDIA, TEL : 01332-235043 FAX : 01332-235042

UNIT-II F-6 & F-7, SITE-C, UPSIDC, SURAJPUR INDUSTRIAL AREA, GREATER NOIDA - 201306 G. B. NAGAR (U.P.) INDIA

E-mail : info@ultimaswitchgear.com

DRAWING	SCHMATIC DIAGRAM	JOB NO.	1241A
TITLE	220V DC DISTRIBUTION BOARD-1(1D)(MCRB)	CA NO.	CC/T/W-AIS/DOM/A10/23/01956/NOA-1/24-102643/01 & 02 DATED 23.02.2024
PROJECT	765/400/220KV BIKANER-III POOLING STATION	CLIENT	POWER GRID CORPORATION OF INDIA LIMITED
		CONTRACTOR:-	BHARAT HEAVY ELECTRICAL LIMITED (BHEL) TRANSMISSION PROJECTS DIVISION
DRG. NO.	USL/PGCIL/BHEL/2024-2025/1241A-505	SH. NO.:-	01 OF 03

This Drawing & information or descriptive matter set out hereon are the confidential property of **ULTIMA SWITCHGEARS LIMITED** & must not be disclosed, copied,loaned or used for manufacturing,tendering or for any other purpose without their permission.

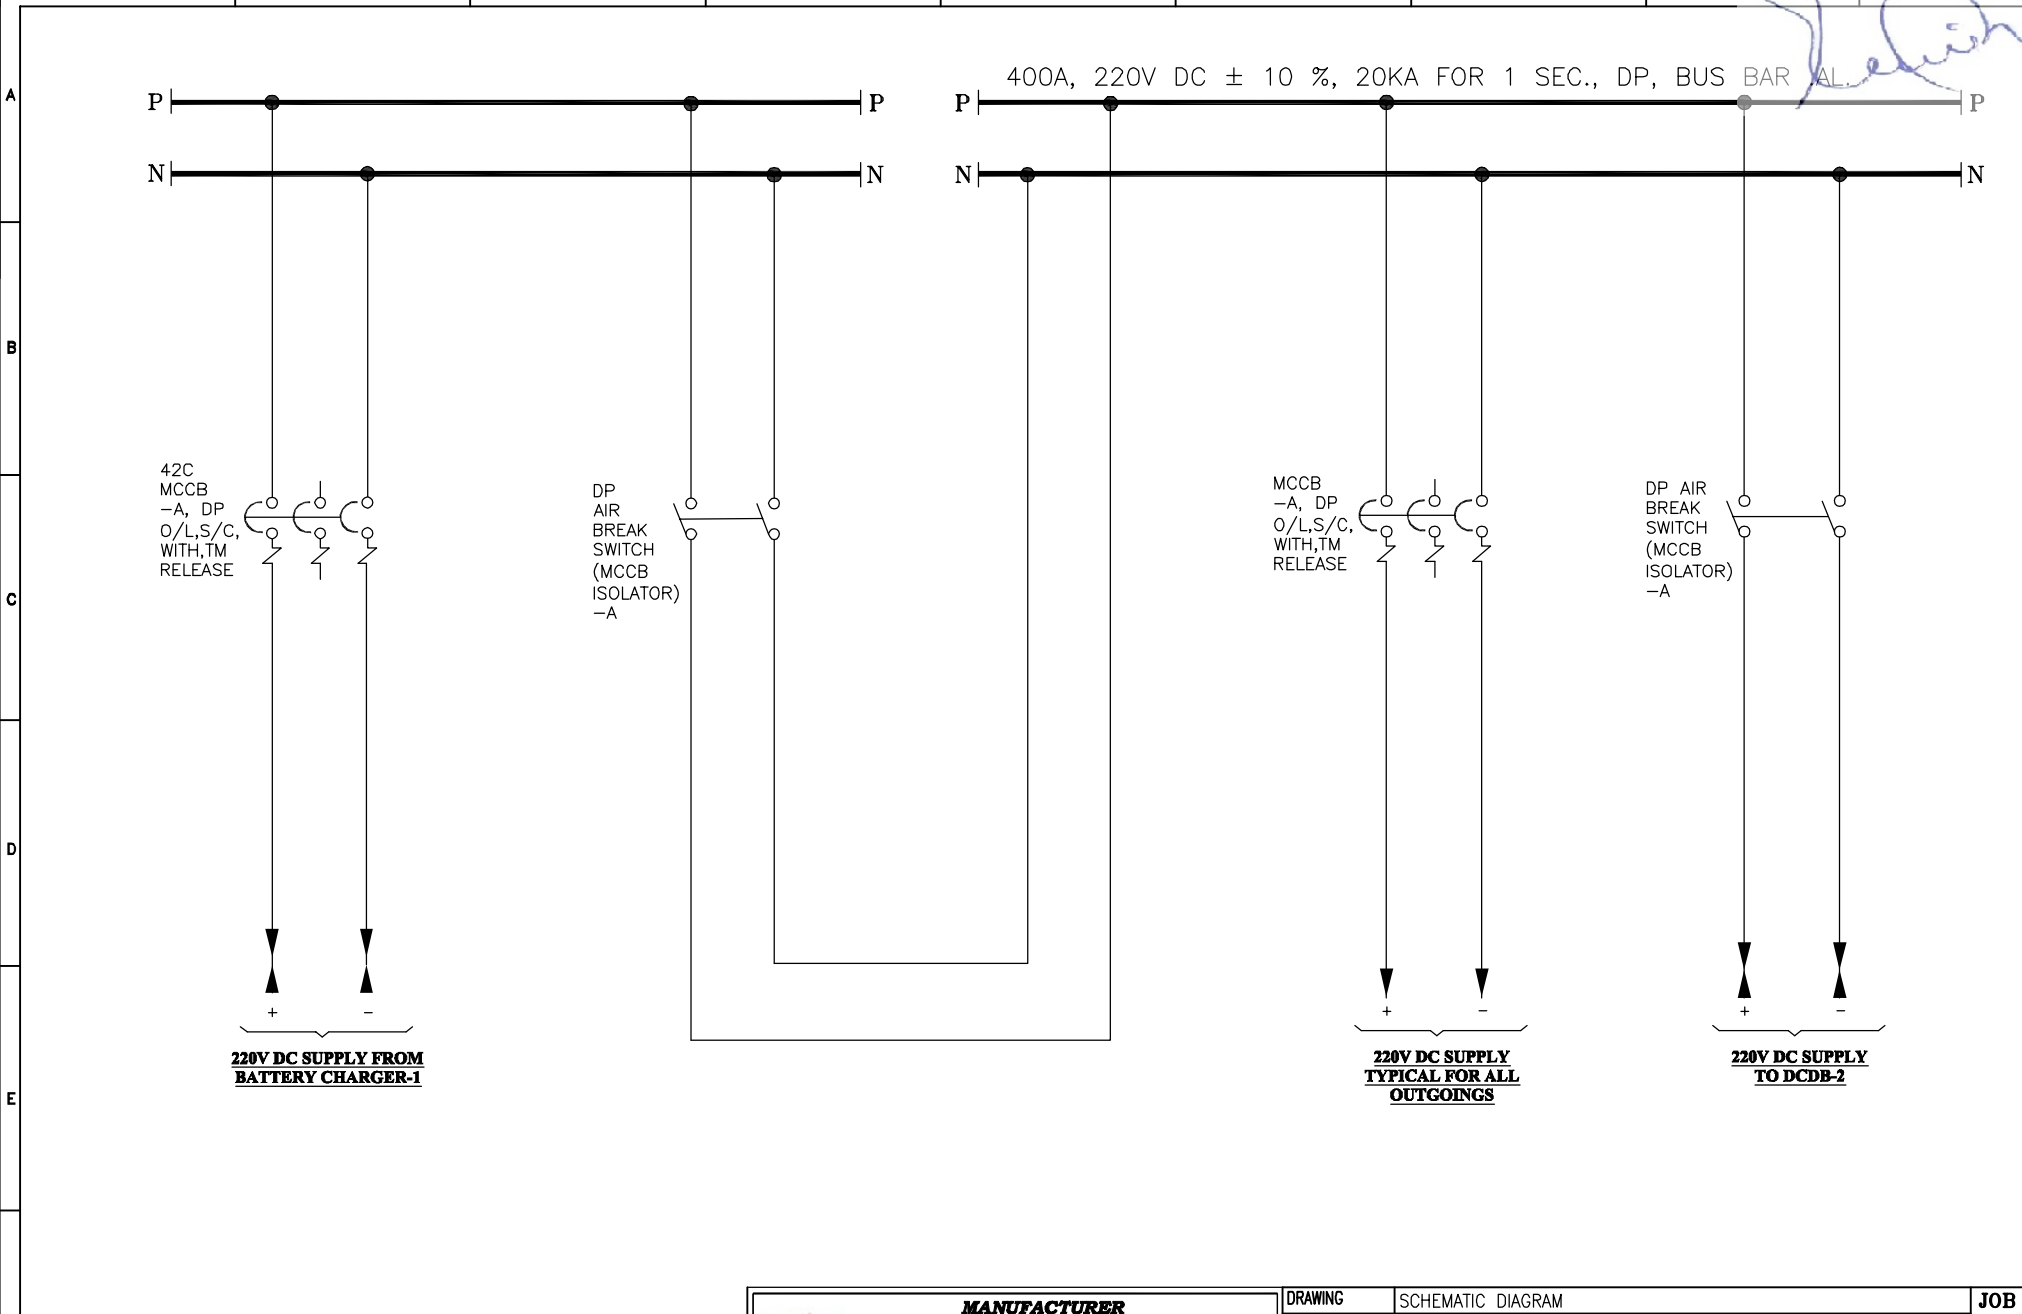

F	04.	—	DRAWN	MP		 ULTIMA® SWITCHGEARS LTD. UNIT-I KHASRA NO. 215, IND. AREA, VILLAGE RAIPUR (BHAGWANPUR), TEHSIL - ROORKEE, DISTRICT HARIDWAR (UTTRAKHAND) - 247867, INDIA, TEL : 01332-235043 FAX : 01332-235042 UNIT-II F-6 & F-7, SITE-C, UPSIDE, SURAJPUR INDUSTRIAL AREA, GREATER NOIDA - 201306 G. B. NAGAR (U.P.) INDIA E-mail : info@ultimaswitchgear.com	 POWER GRID CORPORATION OF INDIA LIMITED  CONTRACTOR:- BHARAT HEAVY ELECTRICAL LIMITED (BHEL) TRANSMISSION PROJECTS DIVISION	TITLE	220V DC DISTRIBUTION BOARD-1(1D)(MCRB)	1241A	
	03.	—	CHKD.	VDP				CA NO.	CC/T/W-AIS/DOM/A10/23/01956/NOA-1/24-102643/01 & 02 DATED 23.02.2024		
	02.	—	APPD.	--				PROJECT	765/400/220KV BIKANER-III POOLING STATION		
	01.		ALL DIMENSIONS IN mm.		SIGN.						
	29.01.2025	00.	FIRST SUBMISSION FOR APPROVAL	TOLERANCE 5%							
	DATE	No.	REVISIONS DESCRIPTION	REVISIONS : 00							
	1	2	3	4	5			6	7	8	9

**ULTIMA[®] SWITCHGEARS LTD.**

UNIT-I KHASRA NO. 215, IND. AREA, VILLAGE RAIPUR (BHAGWANPUR), TEHSIL - ROORKEE, DISTRICT HARIDWAR (UTTRAKHAND) - 247667, INDIA, TEL : 01332-235043 FAX : 01332-235042

UNIT-II F-6 & F-7, SITE-C, UPSIDC, SURAJPUR INDUSTRIAL AREA, GREATER NOIDA - 201306 G. B. NAGAR (U.P.) INDIA

E-mail : info@ultimaswitchgear.com

