


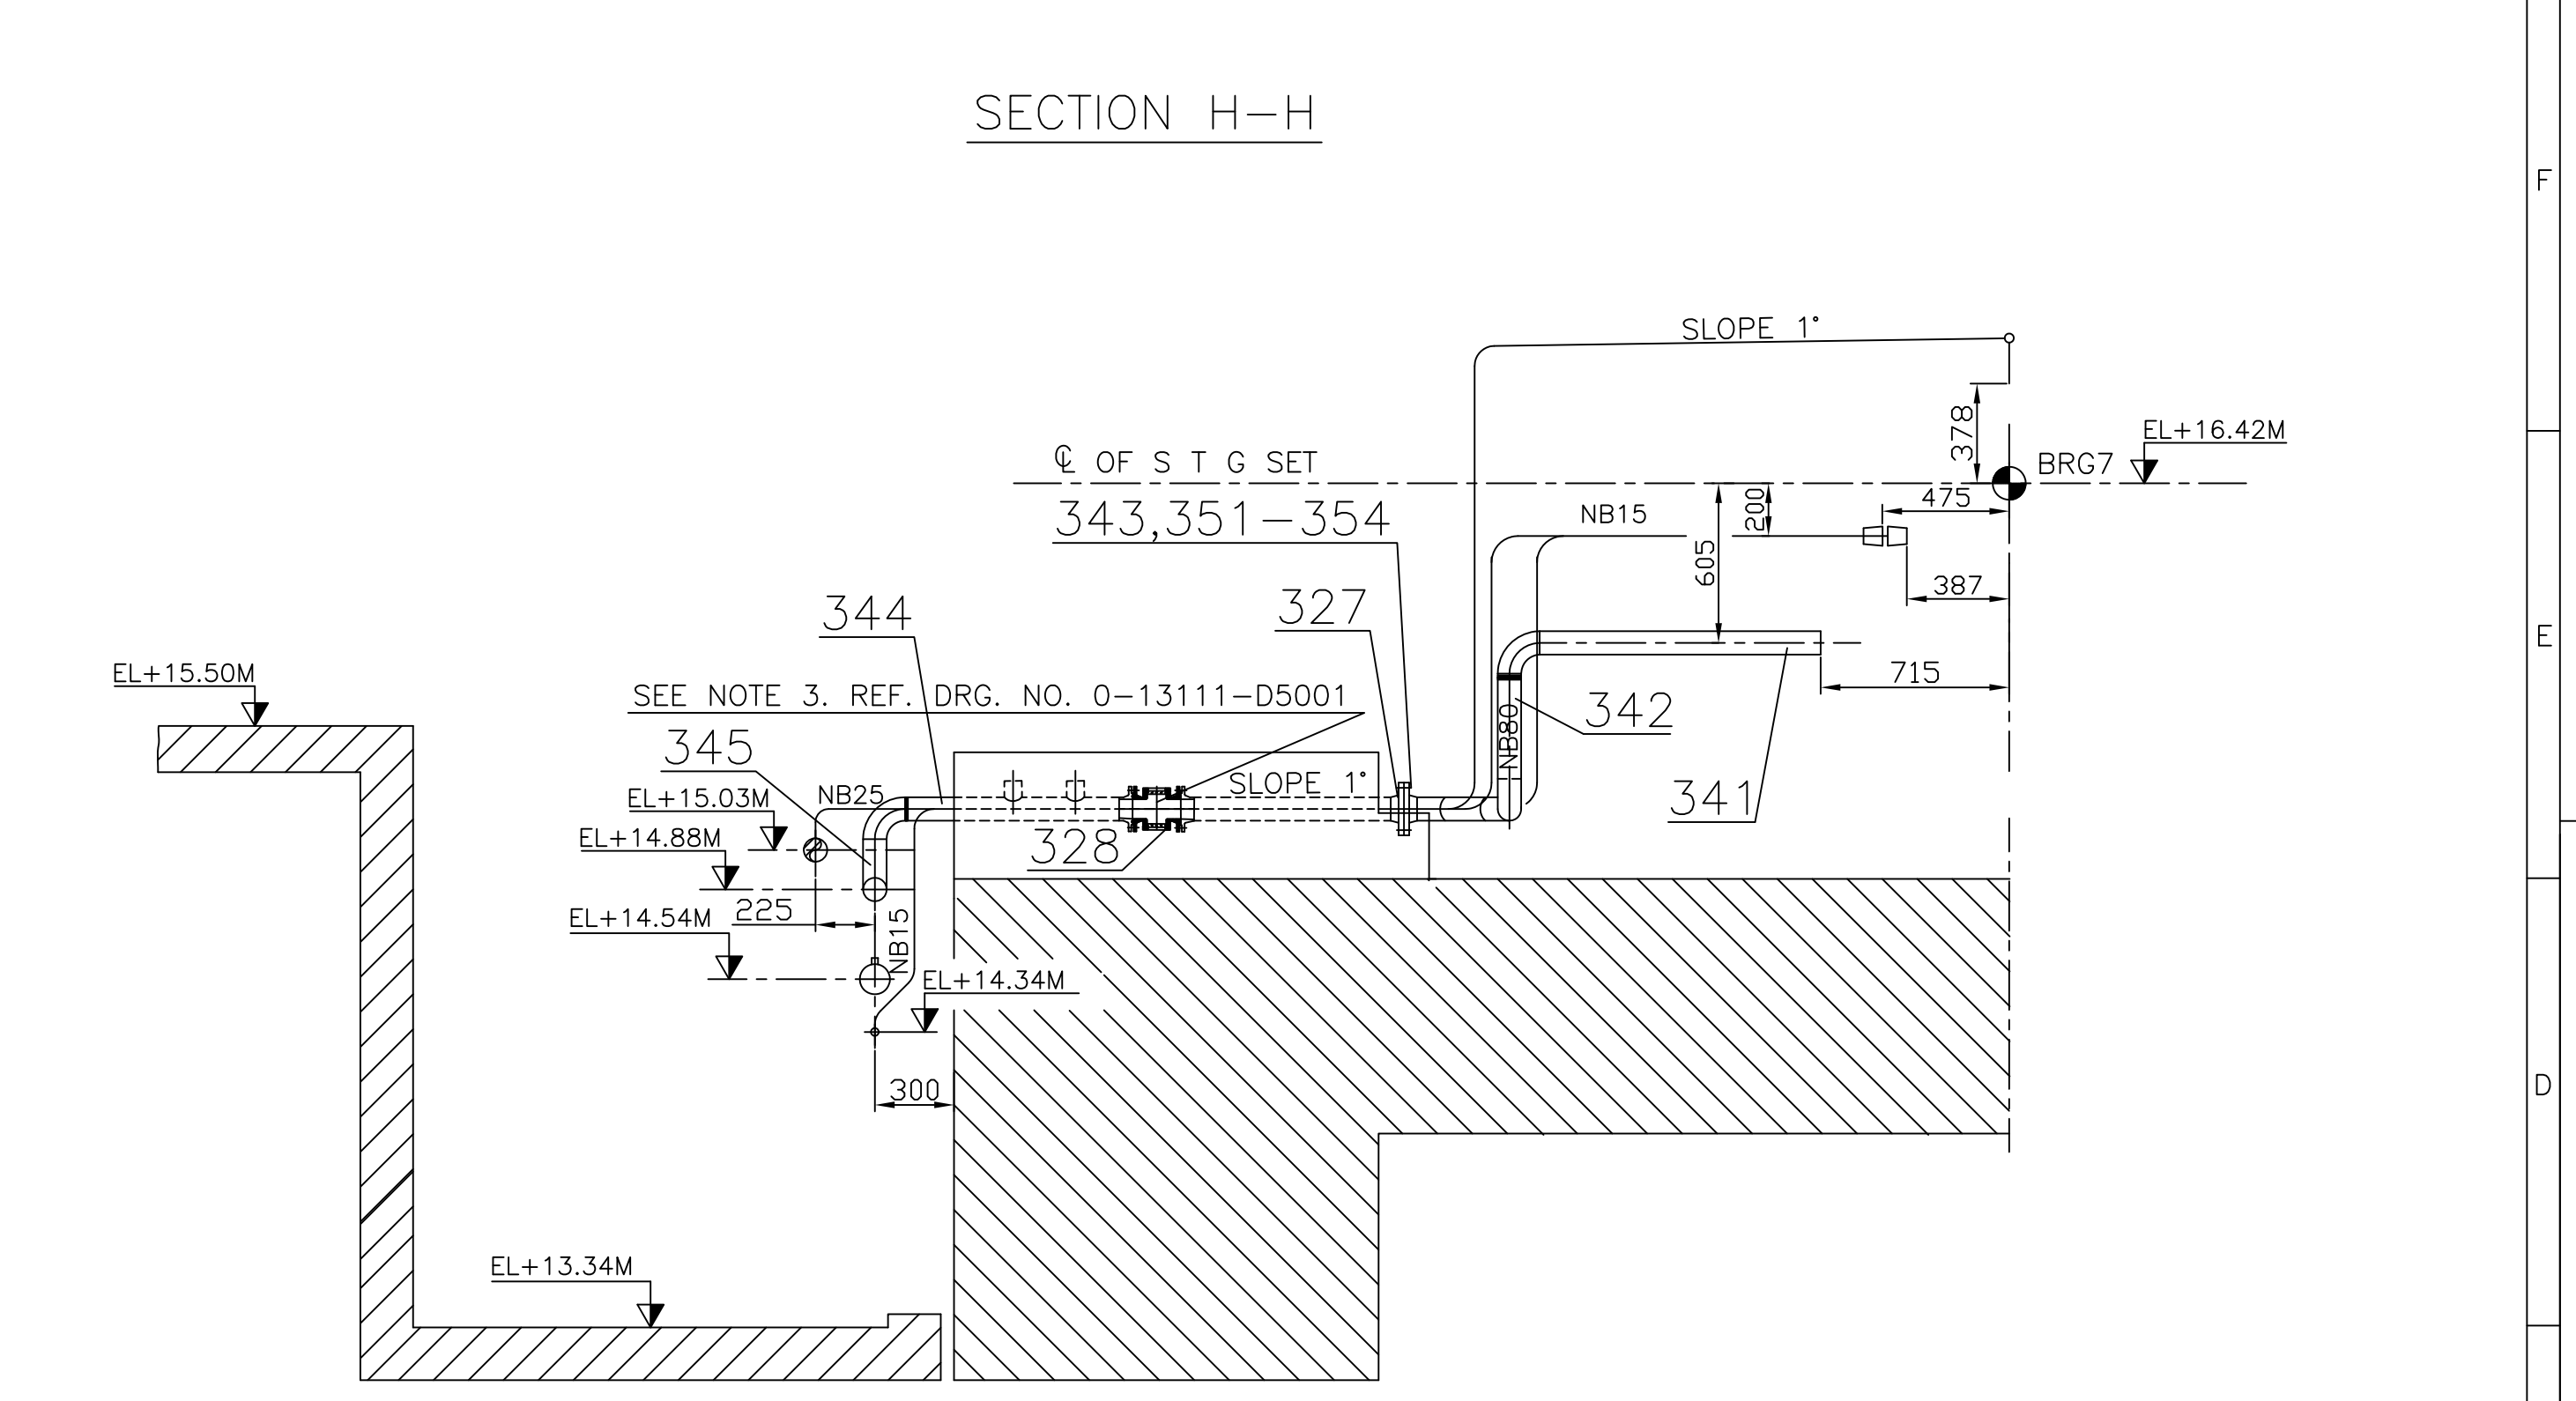

Client		NTPC-SAIL POWER COMPANY (P) LIMITED										
Consultant		(मेकॉन लिमिटेड) MECON LIMITED										
TYPE OF PRODUCT OR NAME OF CUSTOMER/PROJECT		STEAM TURBINE ROURKELA PP-II EXPANSION PROJECT (IX2550 MW)										
भारतीया 		BHARATIYA ELECTRICALS LTD. RANIPUR, HARDWAR										
DEPT	PED		SCALE	WEIGHT (KG)	REF. TO ASSY. DRG.	ITEM NO.	NO. OF ITEMS	DRN	NAME	SIGN	DATE	NO. OF VAR.
CODE	4066		1:25	-				03N	BRAHESH	-Sd-	04.03.2017	00
								APPD	A.S.RAJPUT	-Sd-	04.03.2017	00
TITLE :		LUB OIL SYSTEM PIPING LAYOUT				DRAWING NO.		0-13111-D5004		REV.		00
						SHEET		7		NO. OF SHEETS		01

[illegible]