




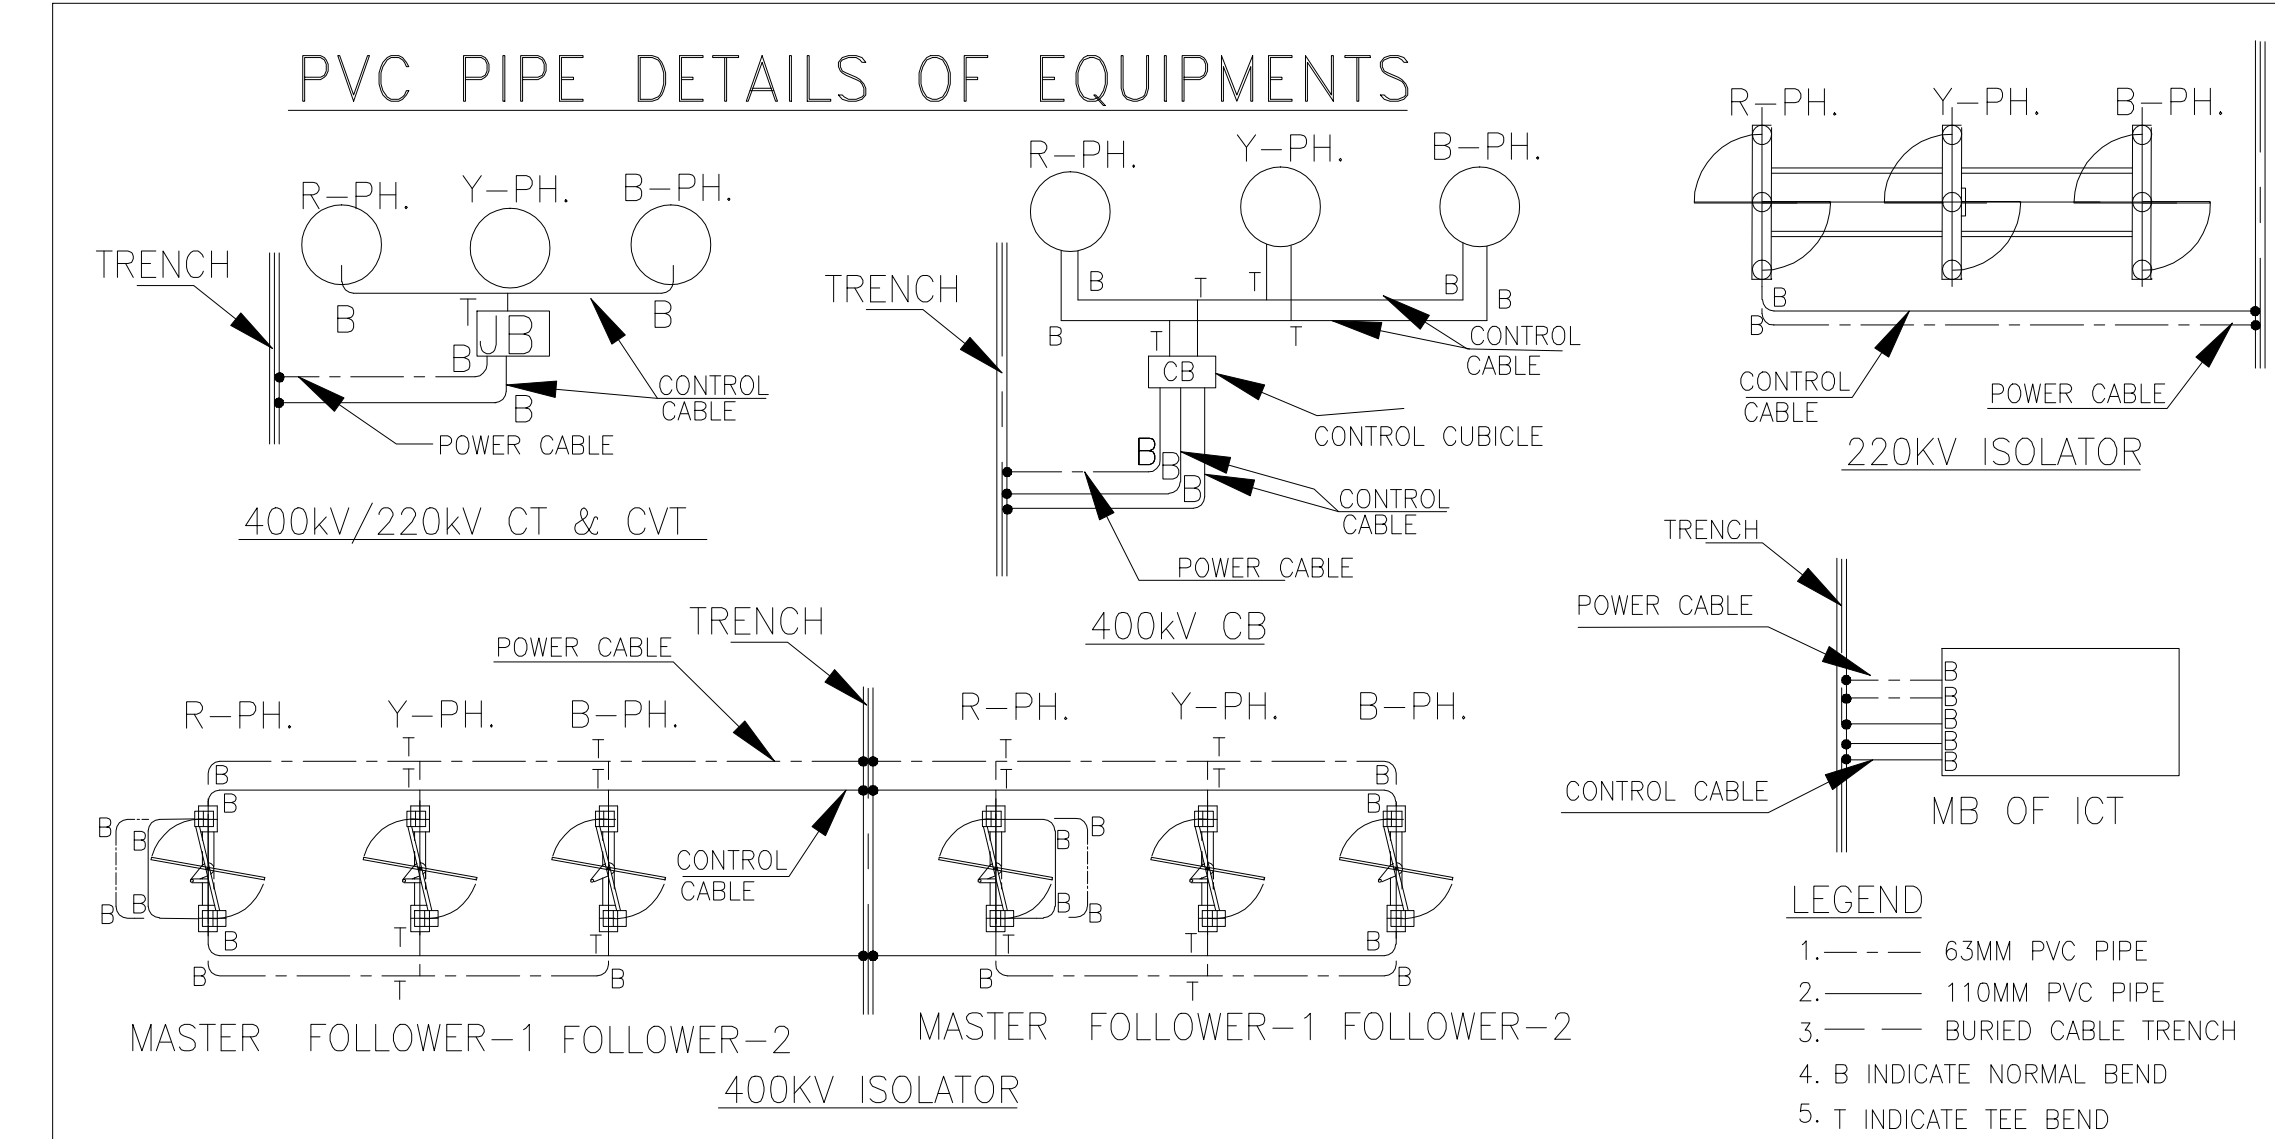


- REFERENCE:



1. PLAN AND SECTION OF 220KV AGRA S/S
- TB-1-343-316-02 REV-10
2. SINGLE LINE DIAGRAM
- 1JNL100122-185 REV-09



REF. DRG.													CA NO.		C-61901R-S056-8/CA-II/3660 DATED 22.12.2011 FOR ON-SHORE SUPPLIES & C-61901R-S056-8/CA-IV/3662 DATED 22.12.2011 FOR SERVICES																																																																																			
	SIGN. & DATE		A		ADDITIONAL INFORMATION W.O.No. 80014		POWER GRID CORPORATION OF INDIA LIMITED s/- 400 kv. 6600 MW HVDC MULTI TERMINAL SYSTEM STATUS OF DRAWING NAME OF CUSTOMER/PROJECT		ब्राह्मक/परियोजना का नाम PACKAGE ASSOCIATED WITH NE/BR-NR/WR INTERCONNECTOR-I																																																																																									
INVENTORY No.	<table><tr><th>REV.</th><th>DATE</th><th>ALTERED CHECKED APPROVED</th><th>REV.</th><th>DATE</th><th>ALTERED CHECKED APPROVED</th><th>REV.</th><th>DATE</th><th>ALTERED CHECKED APPROVED</th><th>REV.</th><th>DATE</th><th>ALTERED CHECKED APPROVED</th><th>REV.</th><th>DATE</th><th>ALTERED CHECKED APPROVED</th><th>REV.</th><th>DATE</th><th>ALTERED CHECKED APPROVED</th><th>REV.</th><th>DATE</th><th>ALTERED CHECKED APPROVED</th><th>REV.</th><th>DATE</th><th>ALTERED CHECKED APPROVED</th></tr><tr><td>12</td><td></td><td></td><td>11</td><td></td><td></td><td>10</td><td></td><td></td><td>9</td><td></td><td></td><td>8</td><td></td><td></td><td>7</td><td></td><td></td><td>6</td><td></td><td></td><td>5</td><td></td><td></td></tr></table>												REV.	DATE	ALTERED CHECKED APPROVED	REV.	DATE	ALTERED CHECKED APPROVED	REV.	DATE	ALTERED CHECKED APPROVED	REV.	DATE	ALTERED CHECKED APPROVED	REV.	DATE	ALTERED CHECKED APPROVED	REV.	DATE	ALTERED CHECKED APPROVED	REV.	DATE	ALTERED CHECKED APPROVED	REV.	DATE	ALTERED CHECKED APPROVED	12			11			10			9			8			7			6			5			DISTRIBUTION OF PRINTS		भारत हेवी इलेक्ट्रिकल्स लिमिटेड भारतीया भारी विद्युत कर्षण BHARAT HEAVY ELECTRICALS LTD. TRANSMISSION PROJECTS DIVISION		<table><tr><td>कर्षण/कर्म</td><td>नाम /NAME</td><td>हर्षण /SIGN.</td><td>दि./DATE</td></tr><tr><td>जर्षण/कर्म</td><td>ANNAMALAI</td><td>ANNAMALAI</td><td>01.03.12</td></tr><tr><td>नर्षण/कर्म</td><td>PRAMOD/MANOJ</td><td></td><td></td></tr><tr><td>अर्षण/कर्म</td><td>ARUNA</td><td></td><td></td></tr></table>		कर्षण/कर्म	नाम /NAME	हर्षण /SIGN.	दि./DATE	जर्षण/कर्म	ANNAMALAI	ANNAMALAI	01.03.12	नर्षण/कर्म	PRAMOD/MANOJ			अर्षण/कर्म	ARUNA			<table><tr><td>विभाग DEPT.</td><td>अनुपात / SCALE</td><td>कर्षण कोड CARD CODE</td></tr><tr><td>कोड CODE</td><td>1:375</td><td></td></tr></table>		विभाग DEPT.	अनुपात / SCALE	कर्षण कोड CARD CODE	कोड CODE	1:375		शीर्षक/TITLE 220kV TRENCH LAYOUT FOR AGRA		ड्राईंग.क्र./DRAWING NO. TB-1-343-316-114		पृष्ठ क्र./SHEET No. 01		जर्षण पृष्ठ/NEXT SHEET 02	
	REV.	DATE	ALTERED CHECKED APPROVED	REV.	DATE	ALTERED CHECKED APPROVED	REV.	DATE	ALTERED CHECKED APPROVED	REV.	DATE	ALTERED CHECKED APPROVED	REV.	DATE	ALTERED CHECKED APPROVED	REV.	DATE	ALTERED CHECKED APPROVED	REV.	DATE	ALTERED CHECKED APPROVED	REV.	DATE	ALTERED CHECKED APPROVED																																																																										
12			11			10			9			8			7			6			5																																																																													
कर्षण/कर्म	नाम /NAME	हर्षण /SIGN.	दि./DATE																																																																																															
जर्षण/कर्म	ANNAMALAI	ANNAMALAI	01.03.12																																																																																															
नर्षण/कर्म	PRAMOD/MANOJ																																																																																																	
अर्षण/कर्म	ARUNA																																																																																																	
विभाग DEPT.	अनुपात / SCALE	कर्षण कोड CARD CODE																																																																																																
कोड CODE	1:375																																																																																																	
												REVISED AS PER POWERGRID COMMENTS VIDE LETTER NO. C/ENGG/HVDC/NER-NR/ 257-AG/962 DATED 03/12/2012		REVISED AS PER POWERGRID COMMENTS VIDE LETTER NO. C/ENGG/HVDC/NER-NR/ 257-AG/690 DATED 23/8/2012		REVISED AS PER POWERGRID COMMENTS VIDE LETTER NO. C/ENGG/HVDC/NER-NR/ 257-AG/316 DATED 20/4/2012																																																																																		

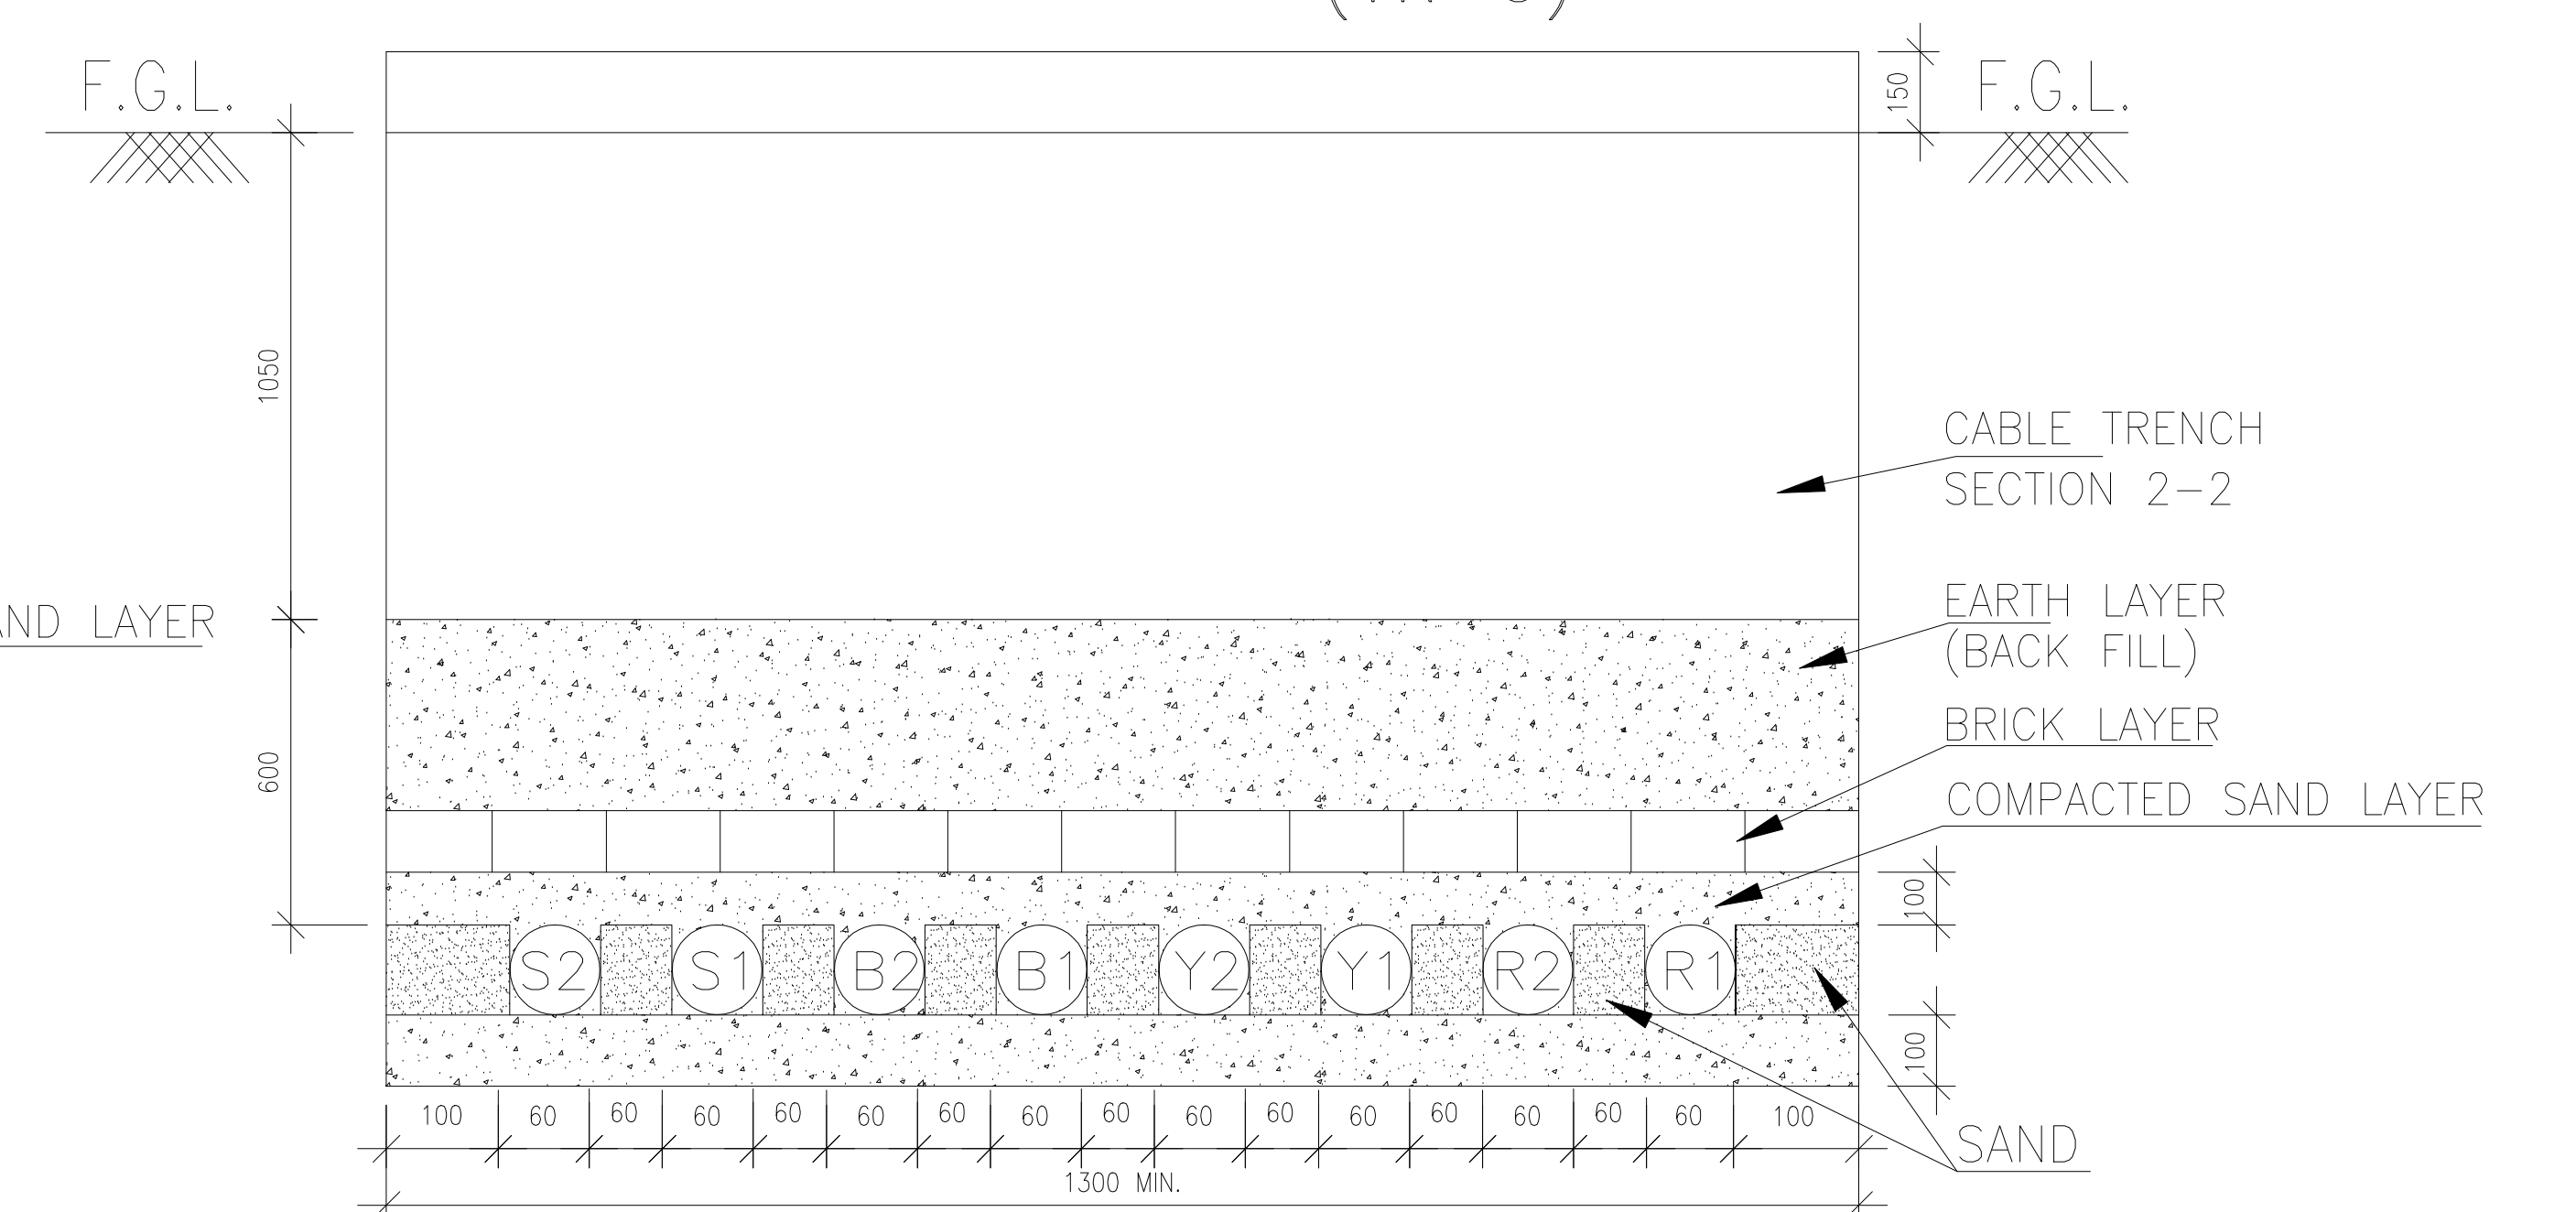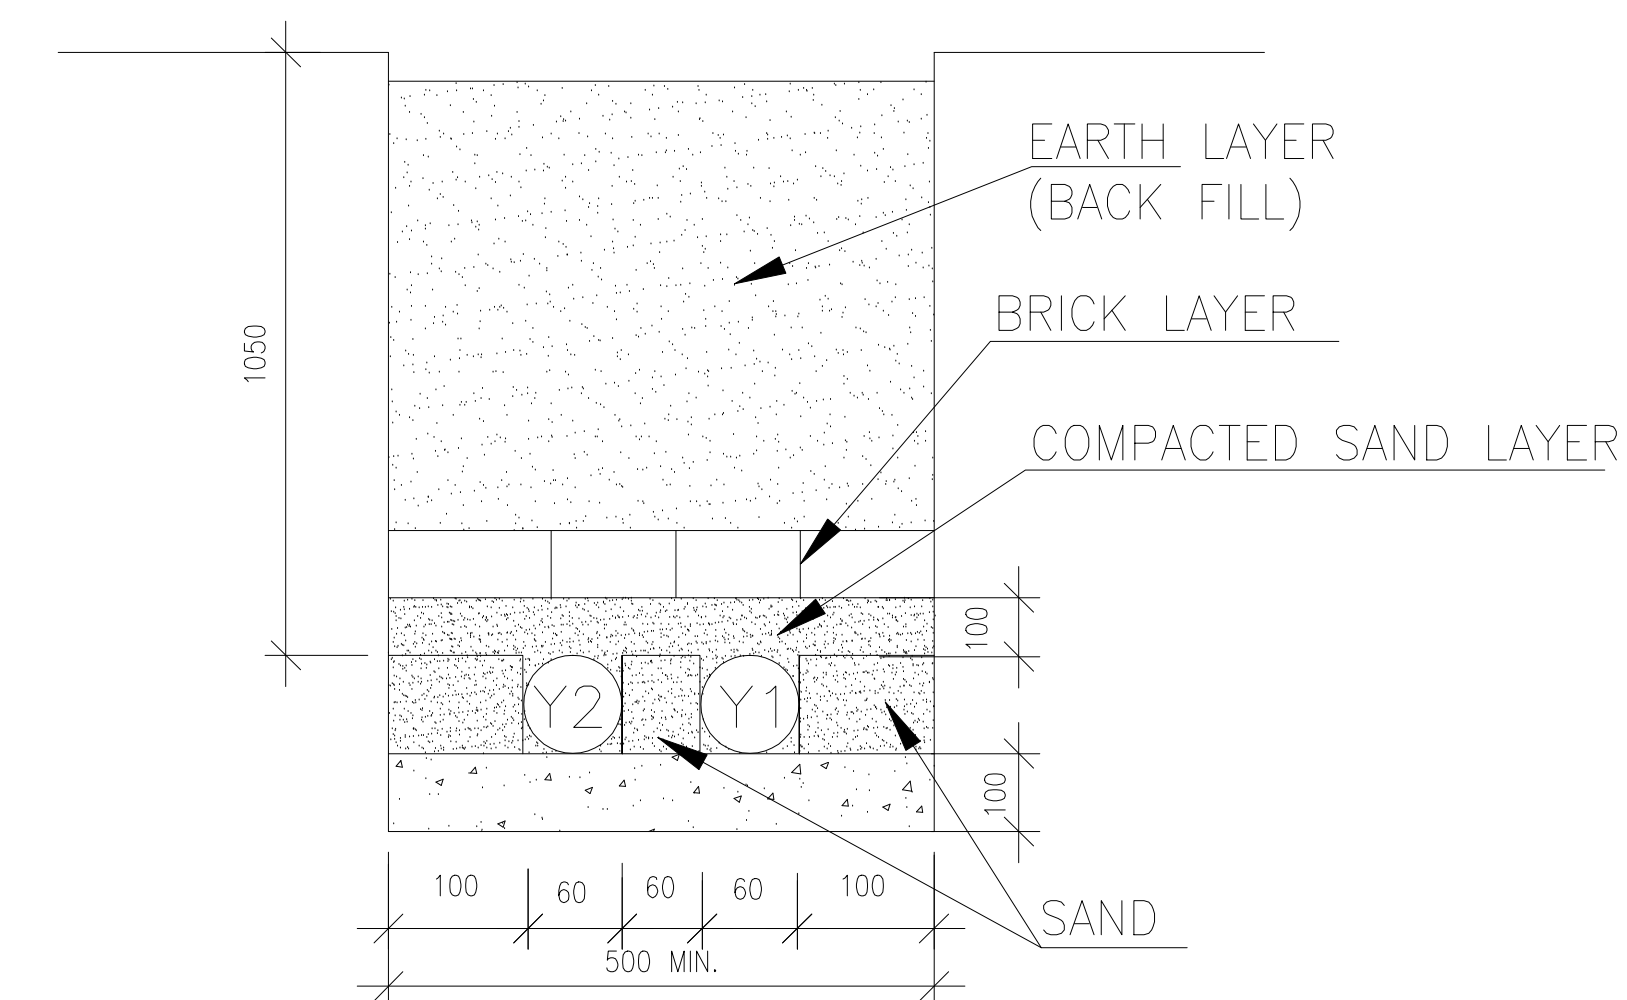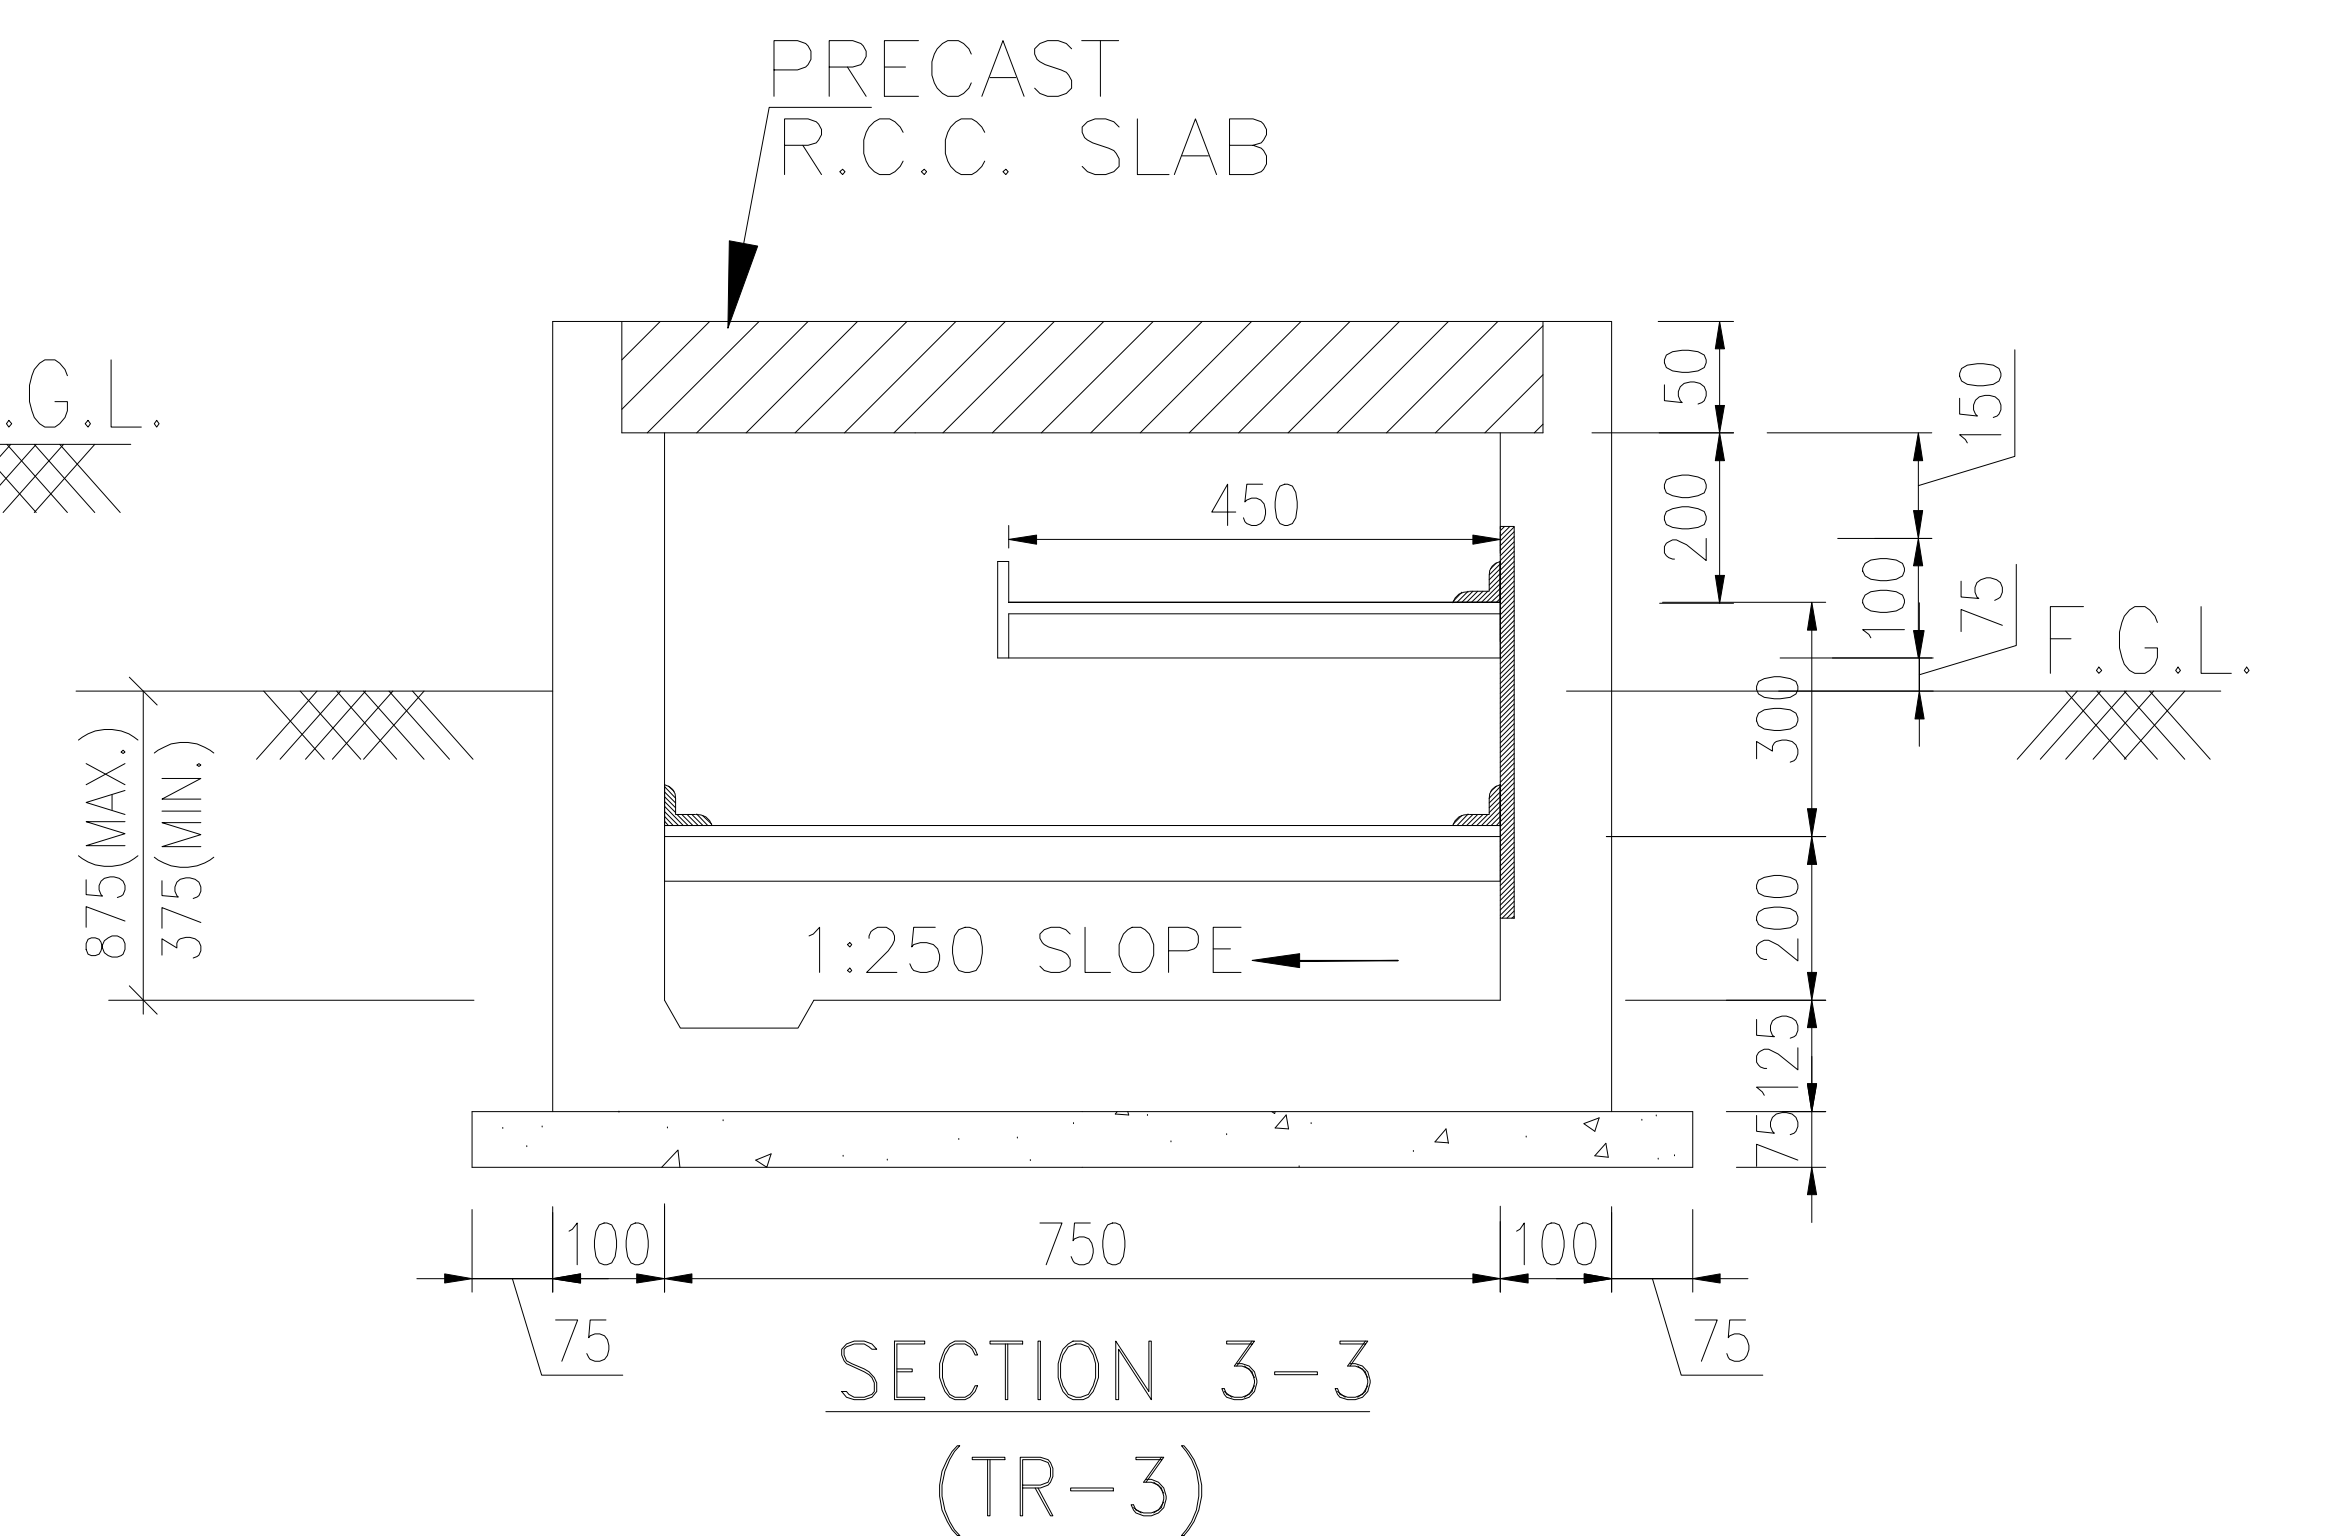

VIEW-C
TYPICAL CROSS - SECTION OF
BURIED TRENCH CROSSING CABLE TRENCH

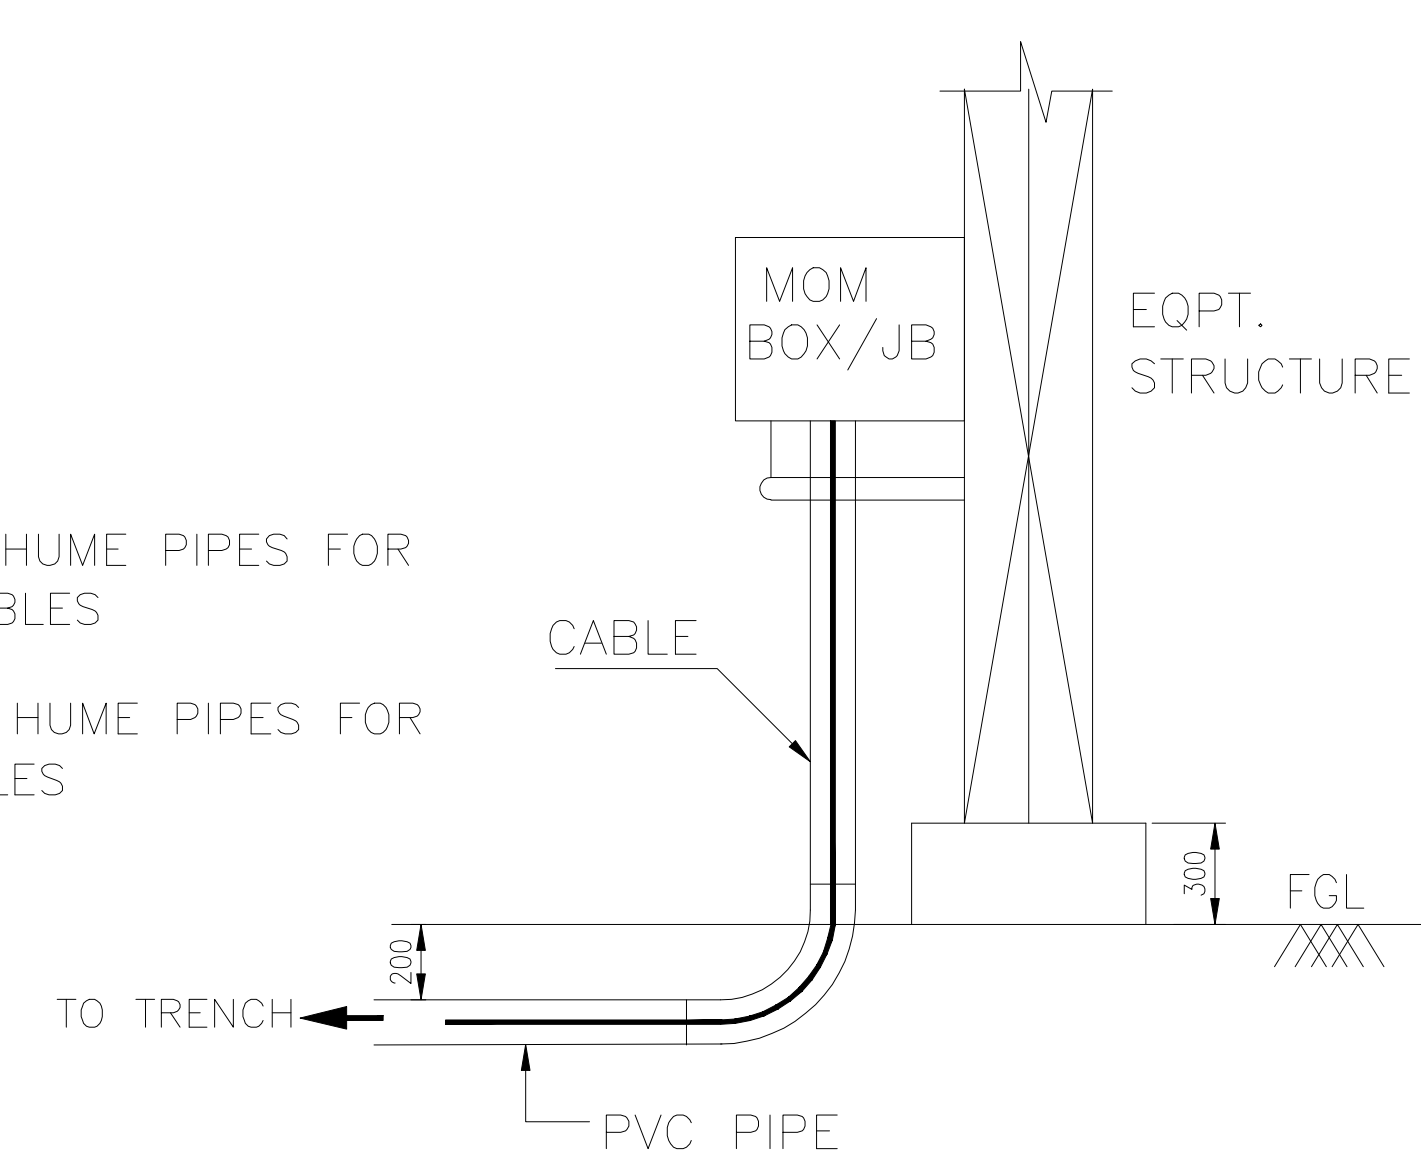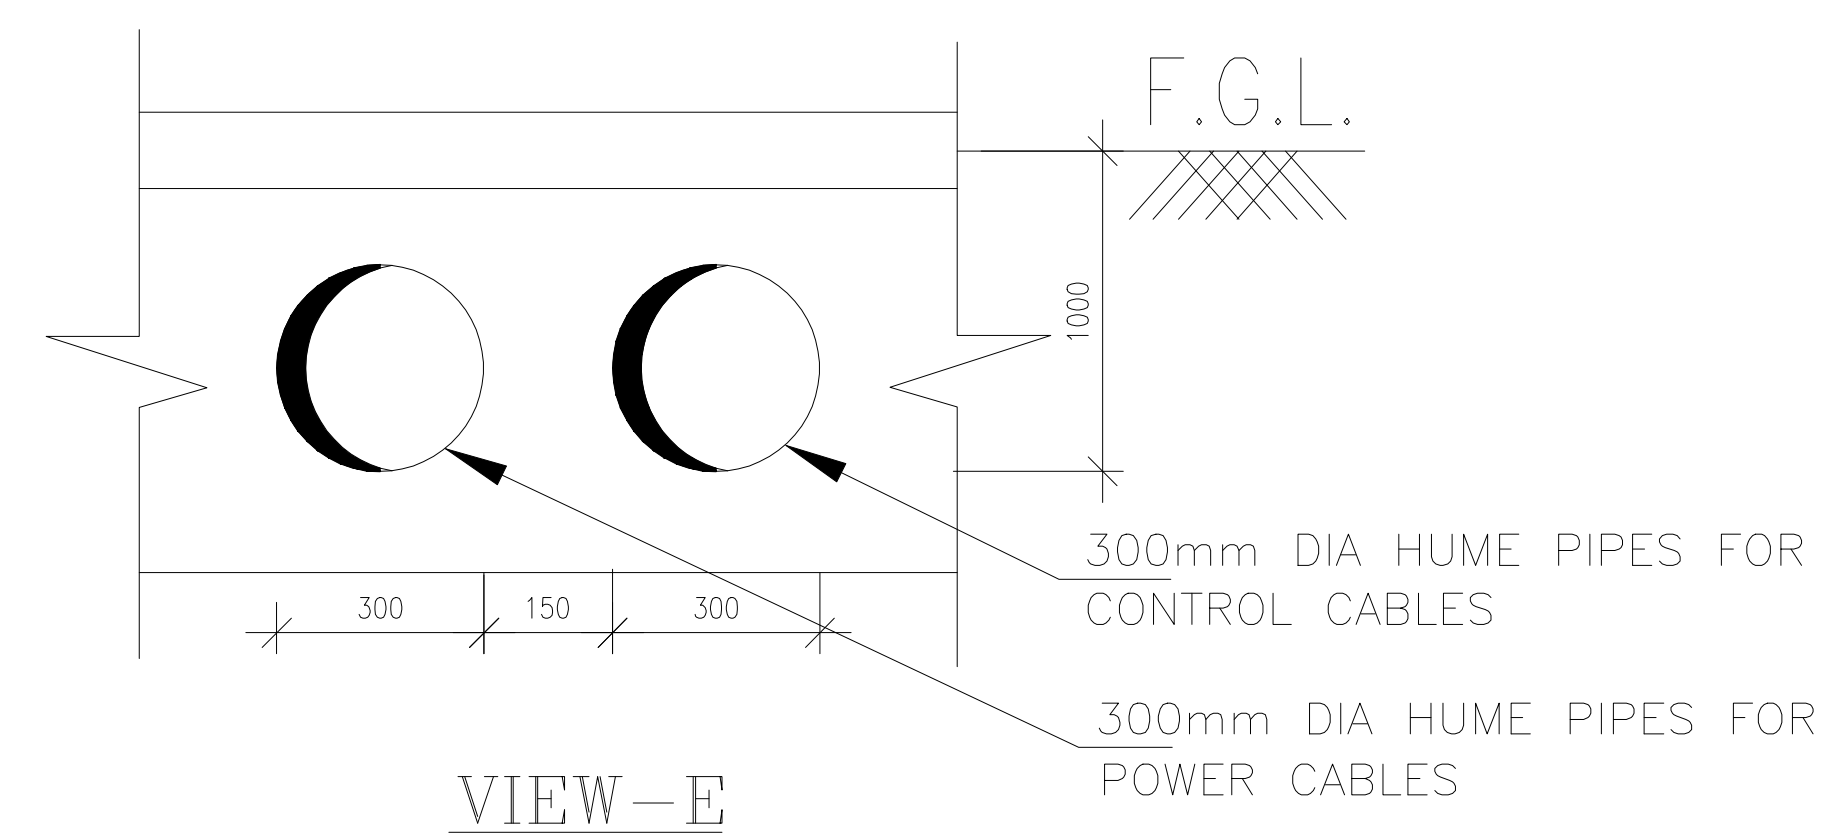

THIS IS A TANTATIVE REPRESENTATION OF CABLE TRECH SECTION. FOR CONSTRUCTION PURPOSE,
PLEASE REFER APPROVED CIVIL DRAWINGS NO: C/ENGG/STD/CT/O1, C/ENGG/STD/CT/O2 AND C/ENGG/STD/CT/O4,

DETAIL-A

[illegible]