


This drawing and the design it covers are the property of ENGINEERS INDIA LIMITED. They are merely loaned and on the borrower's express agreement that they will not be reproduced, copied, loaned, exhibited, nor used except in the limited way and private use permitted by any written consent given by lender to the borrower.

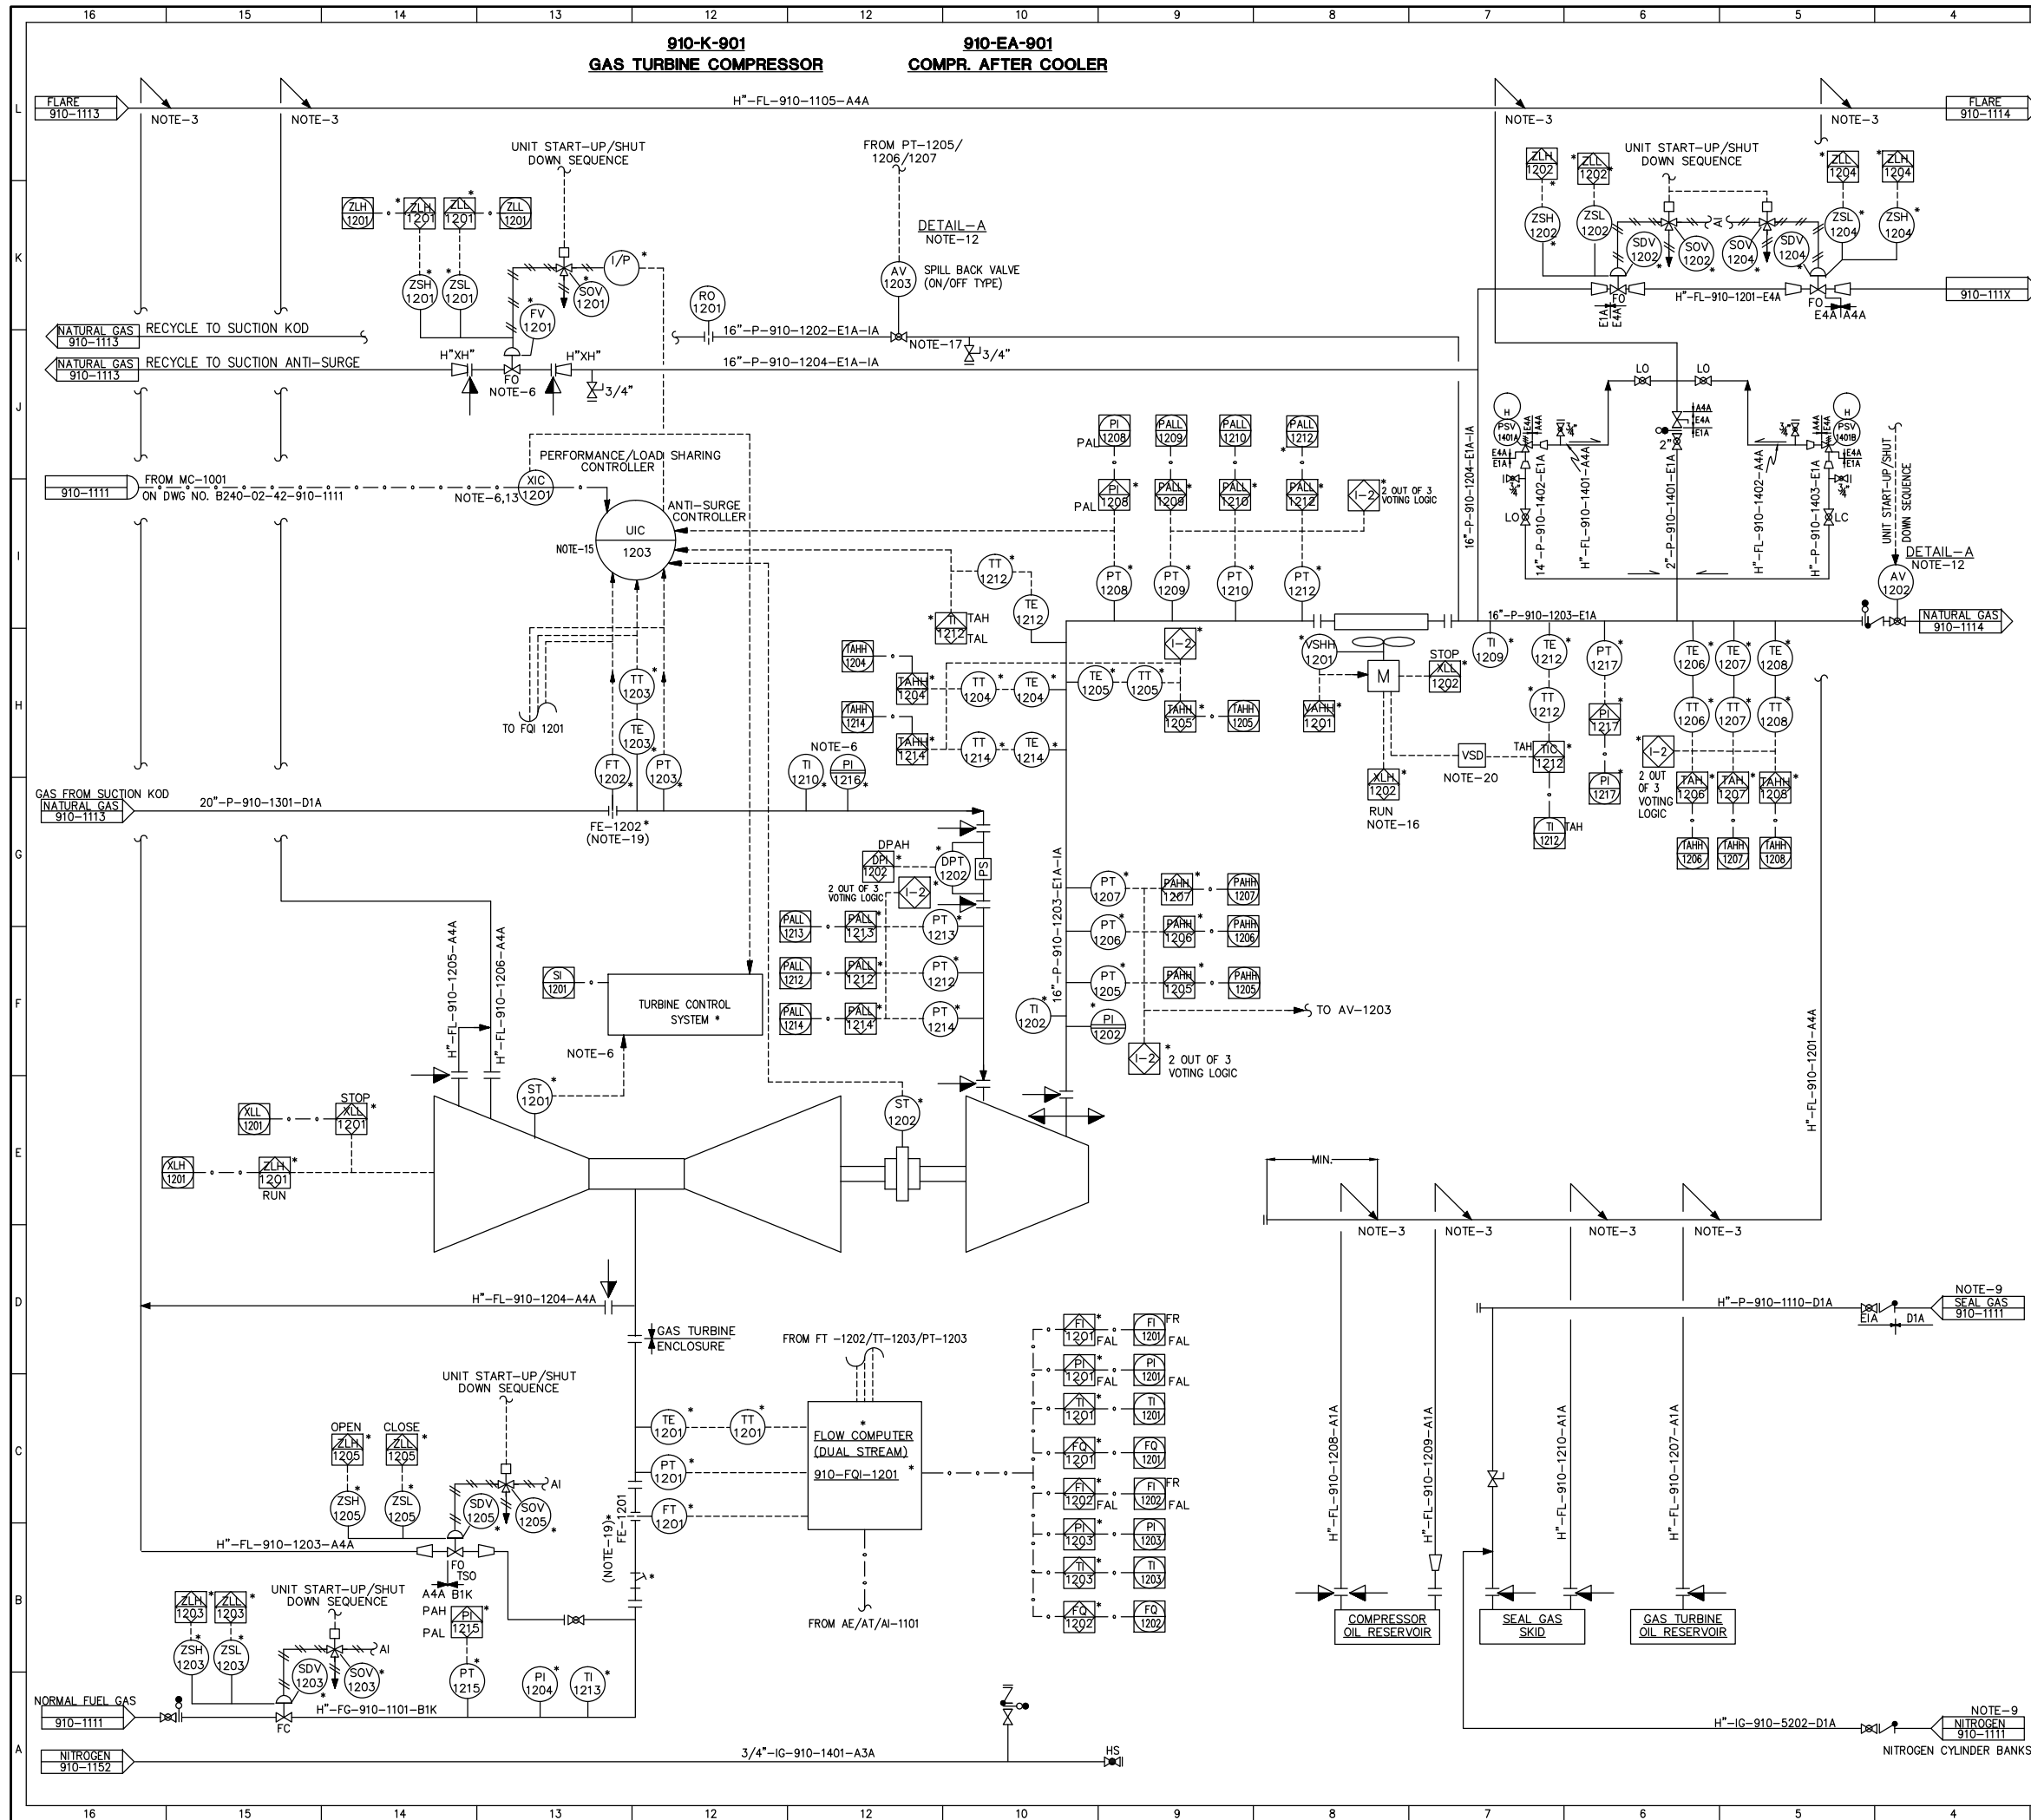

LEGEND:-

- GTC PACKAGE VENDOR
- EIL
- * GTC PACKAGE VENDOR'S SCOPE.
- EIL
- SEAL GAS VENDOR

LEGEND:-

- GTC PACKAGE VENDOR
- EIL
- * GTC PACKAGE VENDOR'S SCOPE.
- EIL
- SEAL GAS VENDOR

A	20.02.19	ISSUED FOR COMMENTS	Varun	GS	JKS	SS
संख्या	तिथि	संशोधन	ड्राफ्ट	ड्राफ्ट	जॉब	अनुमोदित
No.	DATE	REVISIONS	DRN	BY	CHKD	APPD.
इंजिनियर्स इंडिया लिमिटेड (A Govt. of India Undertaking) ENGINEERS INDIA LIMITED (A Govt. of India Undertaking) गैल (इंडिया) लिमिटेड गैल (इंडिया) लिमिटेड GT COMPRESSOR PROJECT, GANDHAR पाइपिंग एण्ड इंस्ट्रुमेंटेशन डायग्राम PIPING AND INSTRUMENTATION DIAGRAM GANDHAR NEW INSTALLATION TYPICAL COMPRESSOR DETAILS FOR COMPRESSOR TRAIN						
अनुमाप	कार्य संख्या	विभाग	अनुभाग	इकाई	आरेख संख्या	संशोध.
SCALE	JOB NO.	DEPT.	SECTN.	UNIT	DWG. No.	REV.
B240	02	42	910	1112	A	