
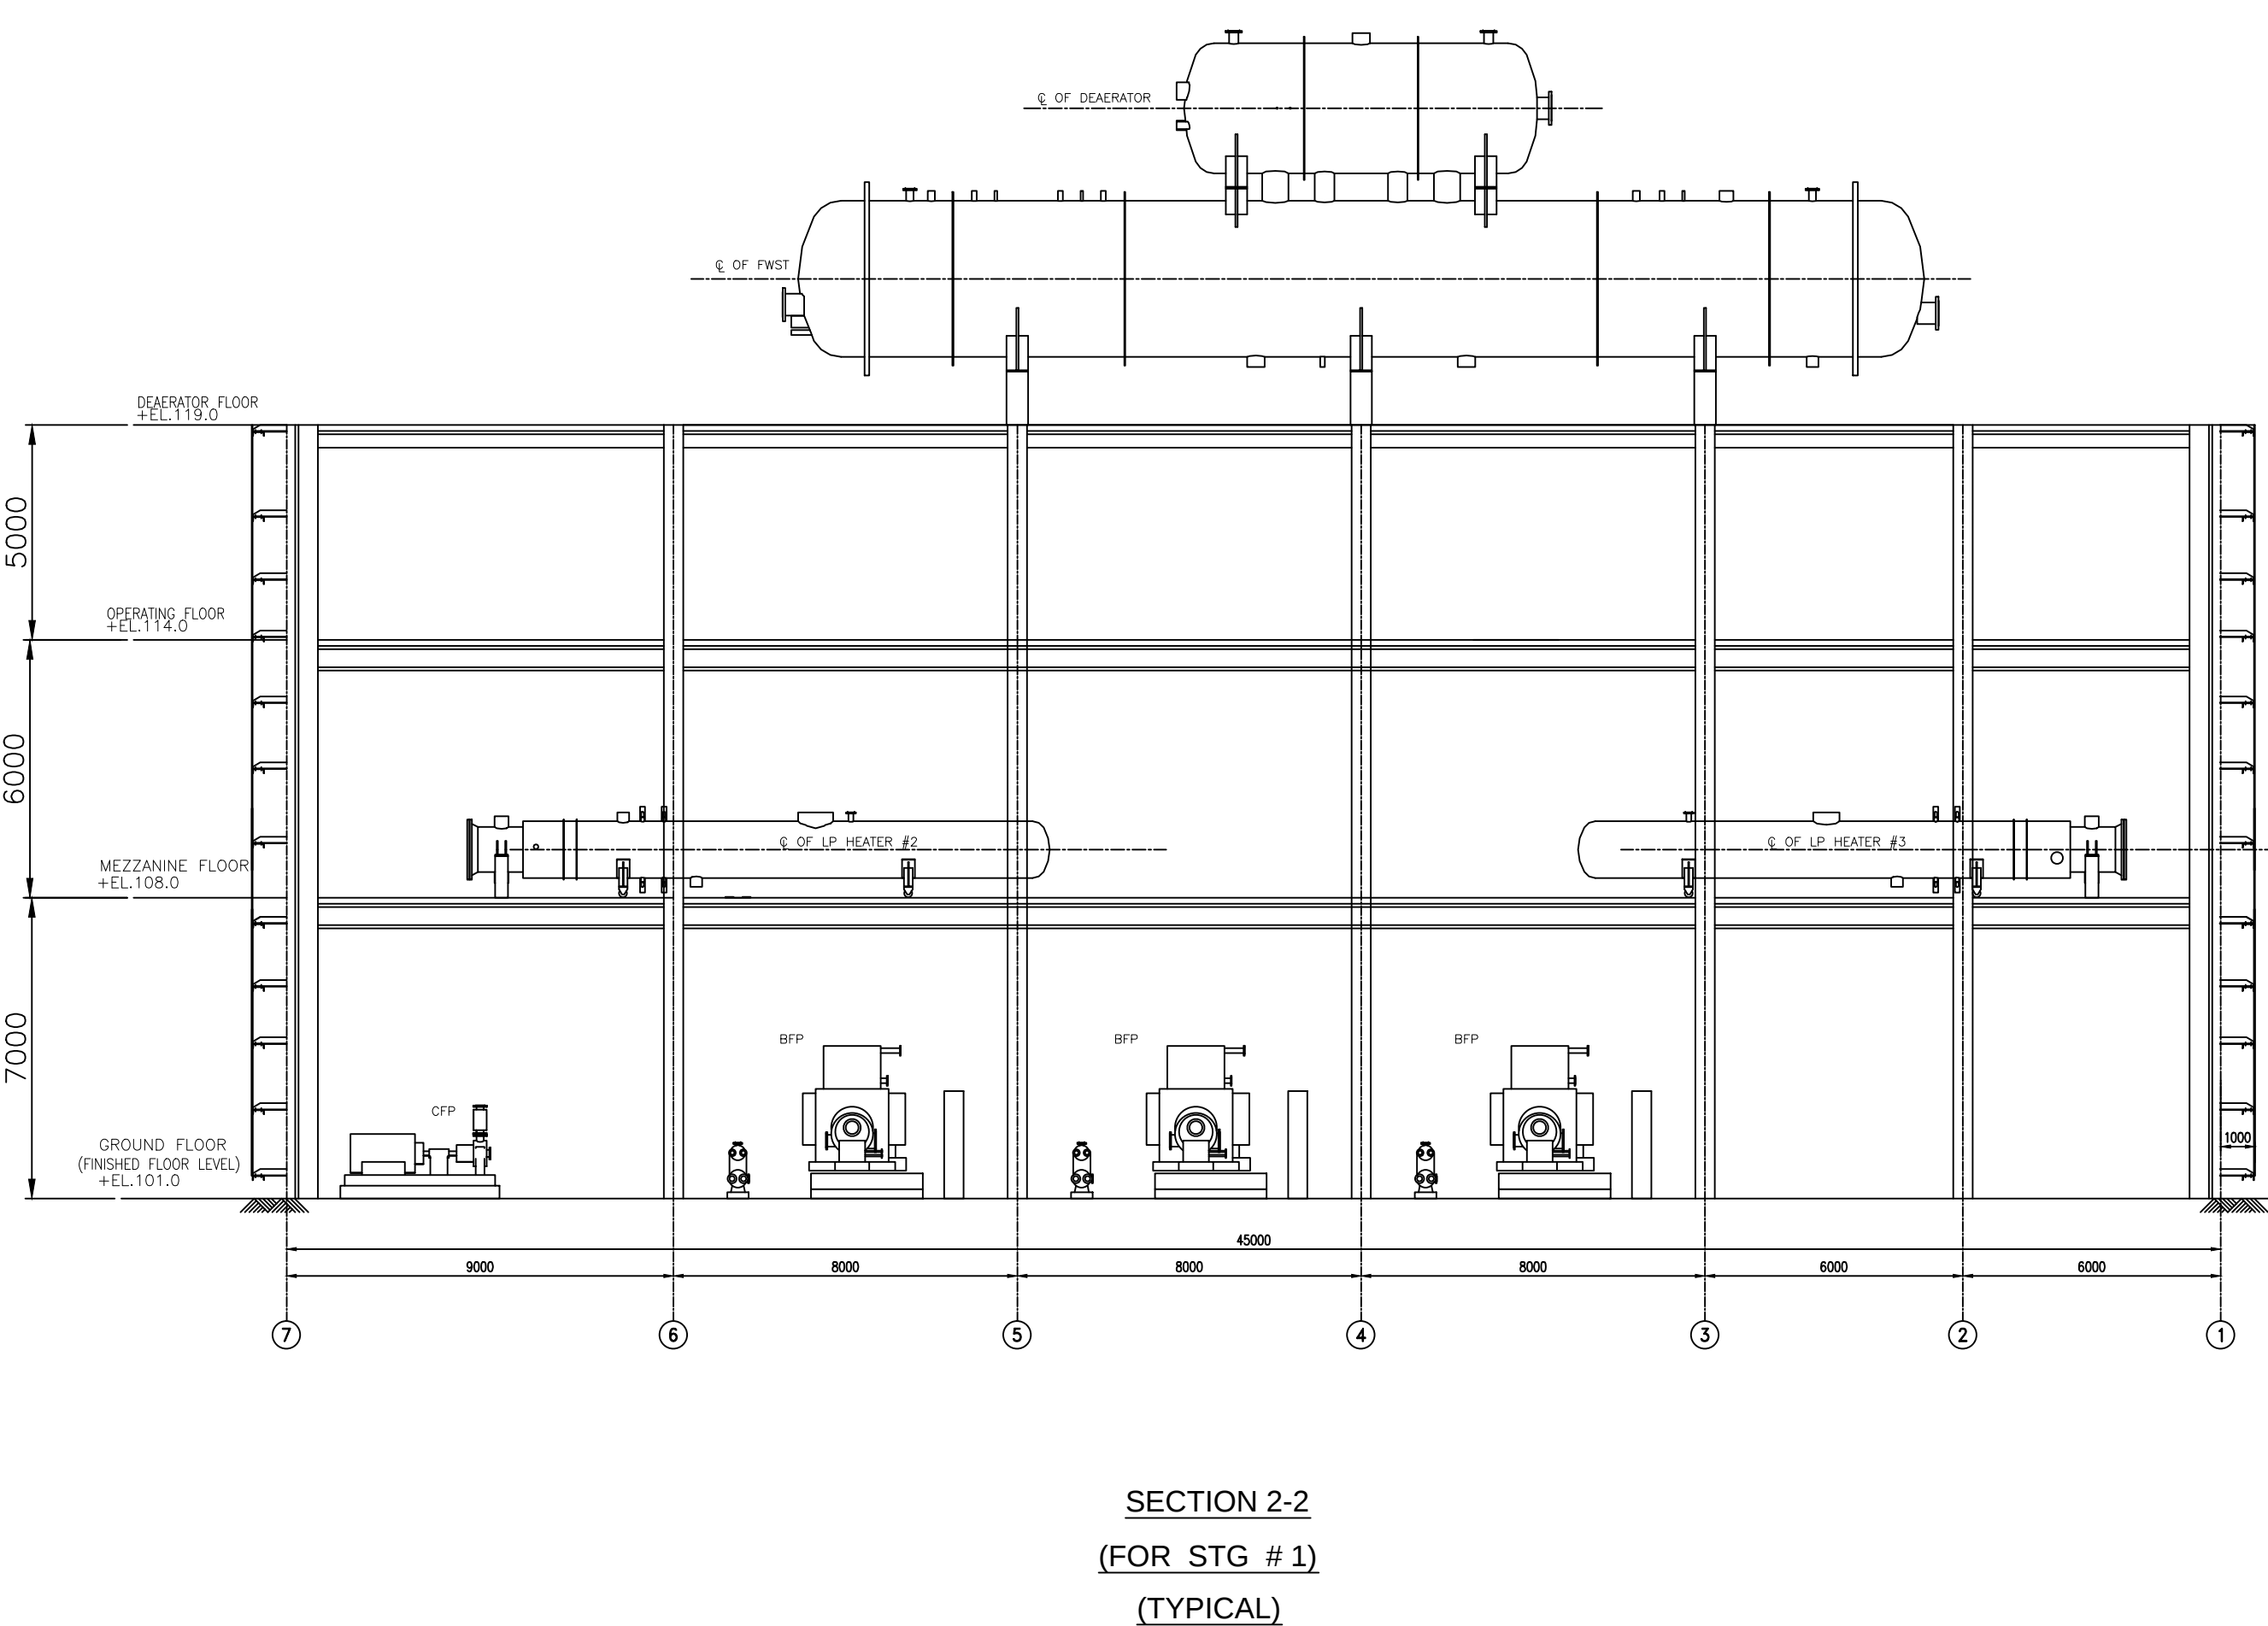


INVENTORY NO	SIGN. AND DATE	REF. DRG. NO.	COMPUTER FILE NAME
1381011528-591-0001.DWG			

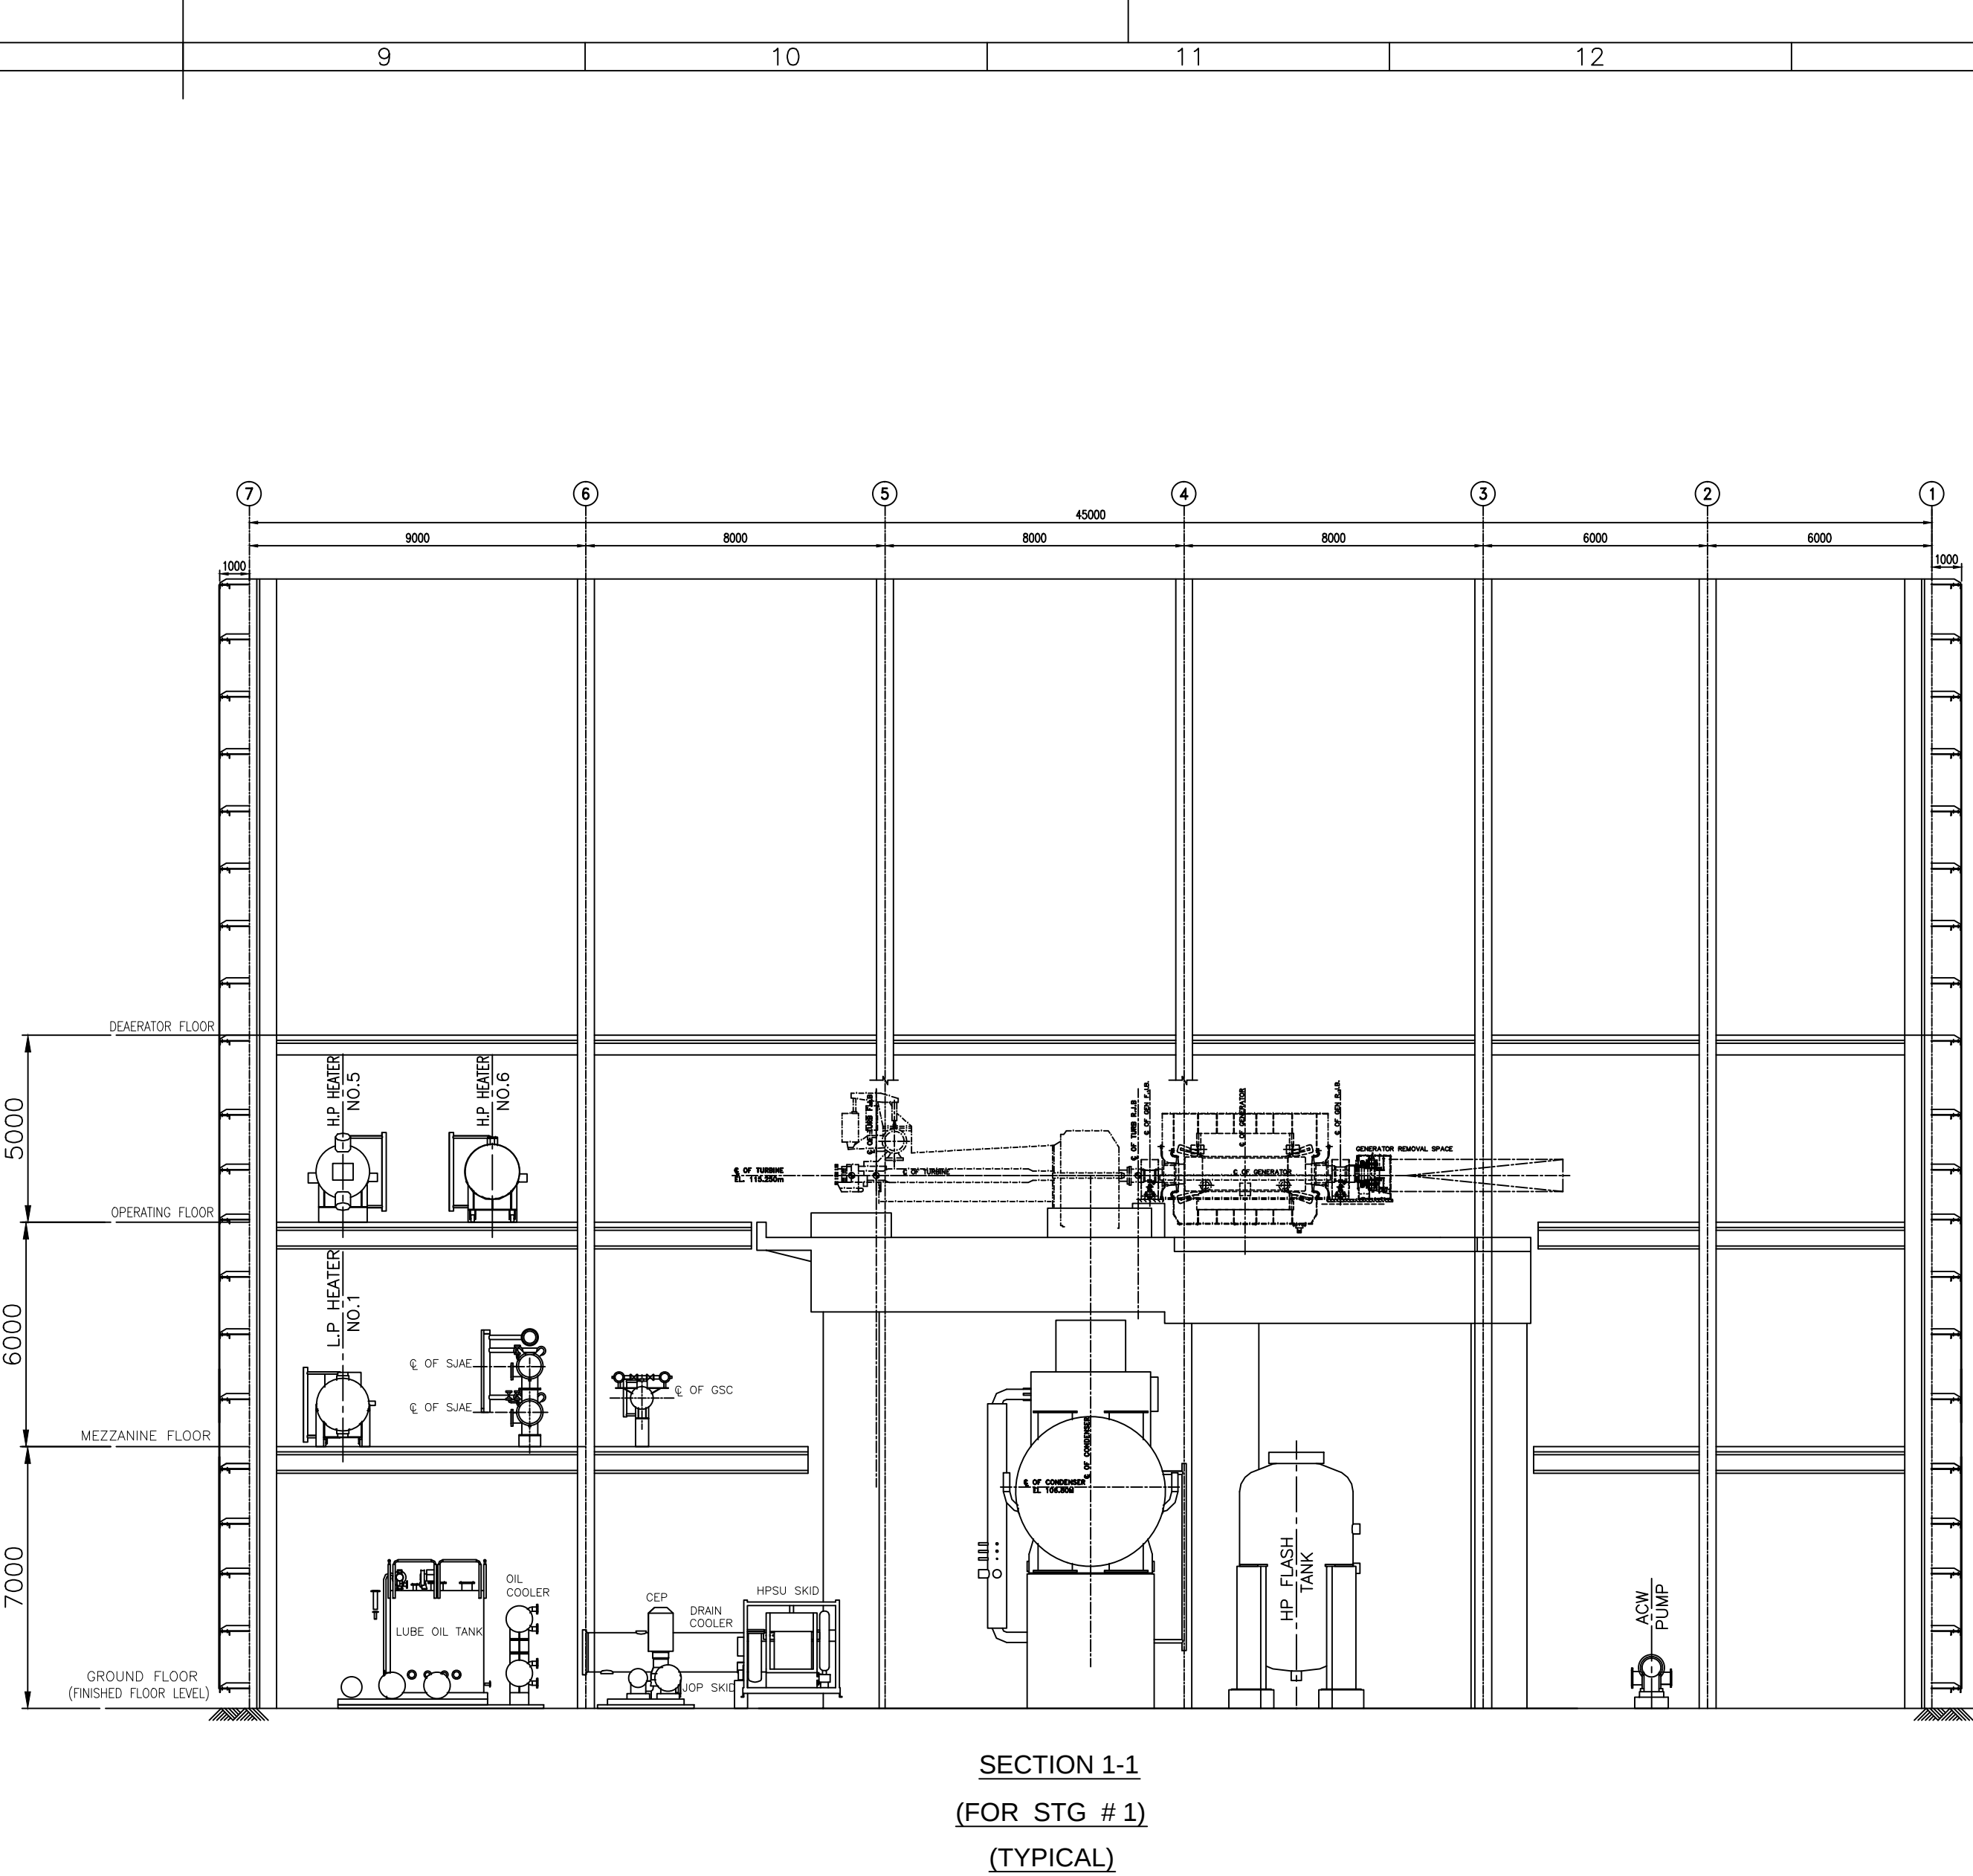

CONSULTANT: 		BECHTEL FREDERICK, MARYLAND, U.S.A											
PROJECT:		STG PACKAGE (3 X 90.3 MW STGs), CCPP DAHEJ MANUFACTURING DIVISION (DMD)											
CUSTOMER:		RELIANCE UTILITIES AND POWER PRIVATE LIMITED COAL BASED CAPTIVE POWER PLANT (CCPP)											
RUPPI DRG NUMBER DATE:		10091-P50-DAT000-BHB-0001											
		BHARAT HEAVY ELECTRICALS LTD. PROJECT ENG & SYSTEMS DIVISION HYDERABAD											
DEPT. NO.	UNITS DIM. G/S/1/F		SCALE	WEIGHT (KG)	REF. TO ASSY.	DRG.	ITEM NO.	NO OF ITEMS	NAME		SIGN.	DATE	NO.OF VAR.
			1:1		APPD.	V.V.S.S			JRN.	V.L.K	-SD-	08.09.13	NA
					CHD.	G.S				G.S	-SD-	08.09.13	NA
						V.V.S.S				V.V.S.S	-SD-	08.09.13	NA
TITLE		INPUT FOR STG LAL EQUIPMENT LAYOUT				CARD CODE		BHEL DRAWING NO: 0-381-01-01530				REV. 05	
						SHT. NO 04		NO. OF SHT. 04					