



|  |   |   |   |   |   |   |   |    |    |    |    |    |    |    |
|--|---|---|---|---|---|---|---|----|----|----|----|----|----|----|
|  | 3 | 4 | 5 | 6 | 7 | 8 | 9 | 10 | 11 | 12 | 13 | 14 | 15 | 16 |
|--|---|---|---|---|---|---|---|----|----|----|----|----|----|----|

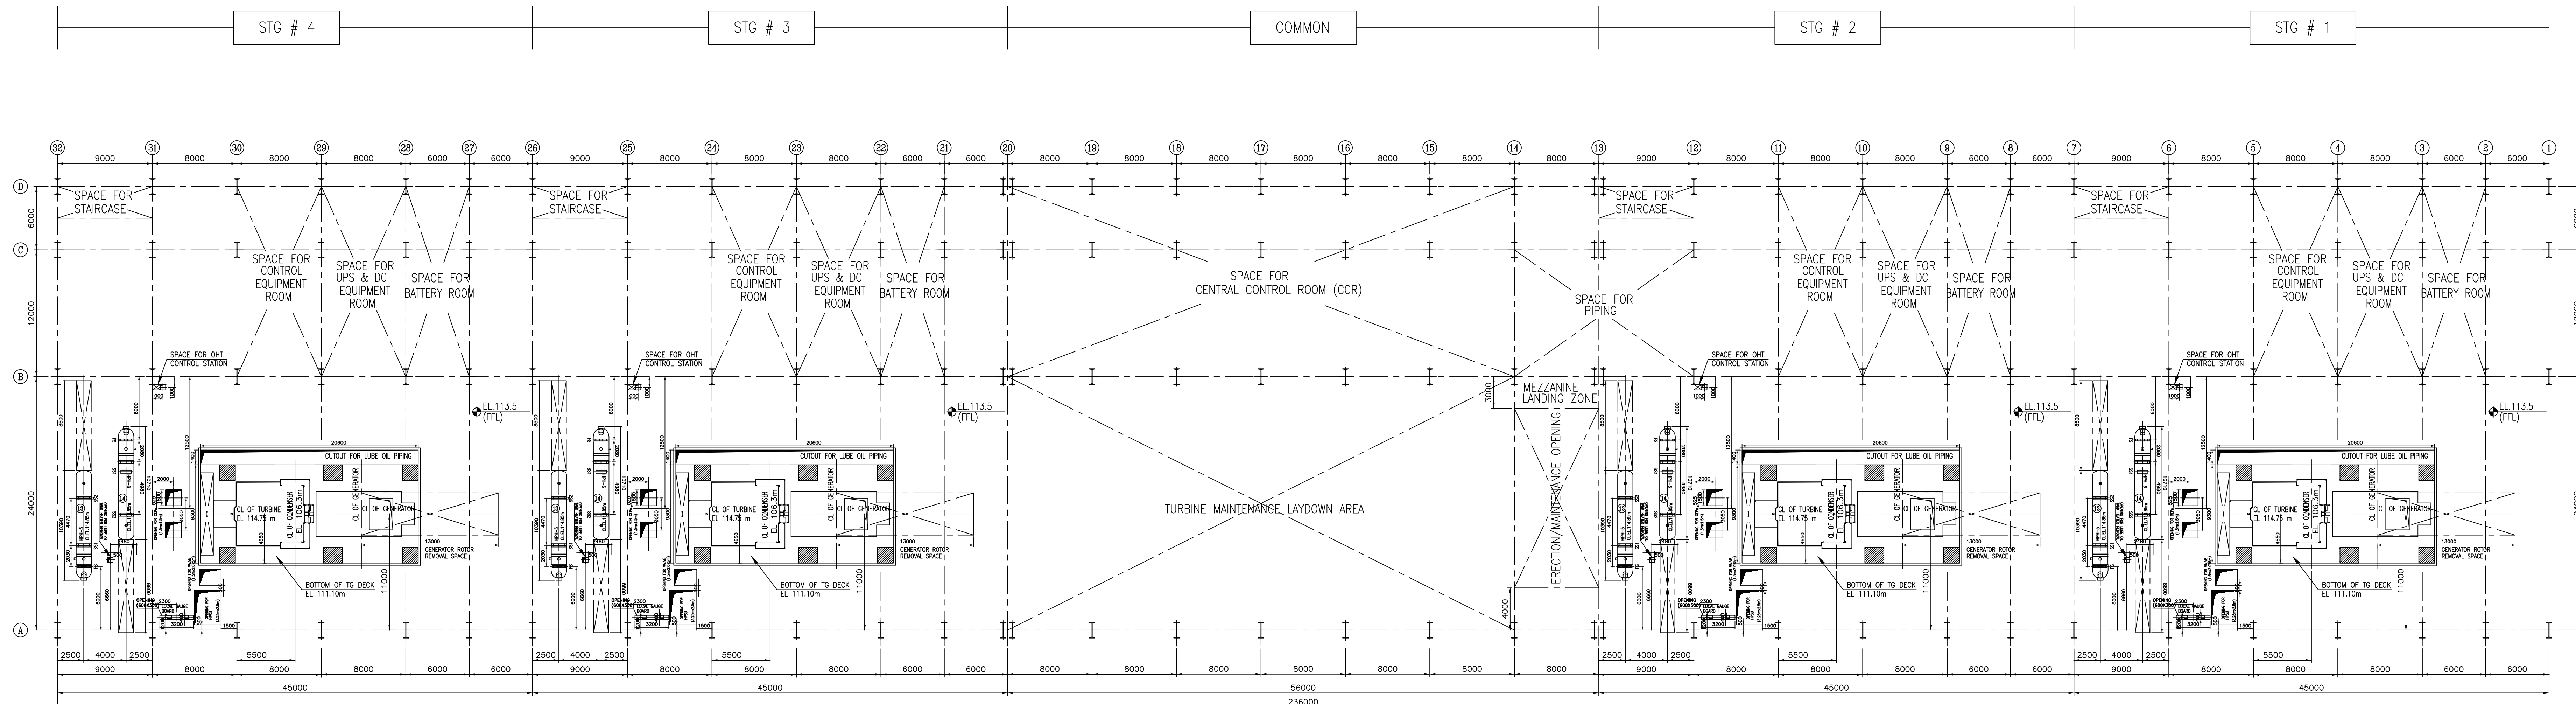

COOLING WATER SIDE | TRANSFORMER YARD

PLAN AT OPERATING FLOOR EL.113.5m (FFL)

BOILER SIDE

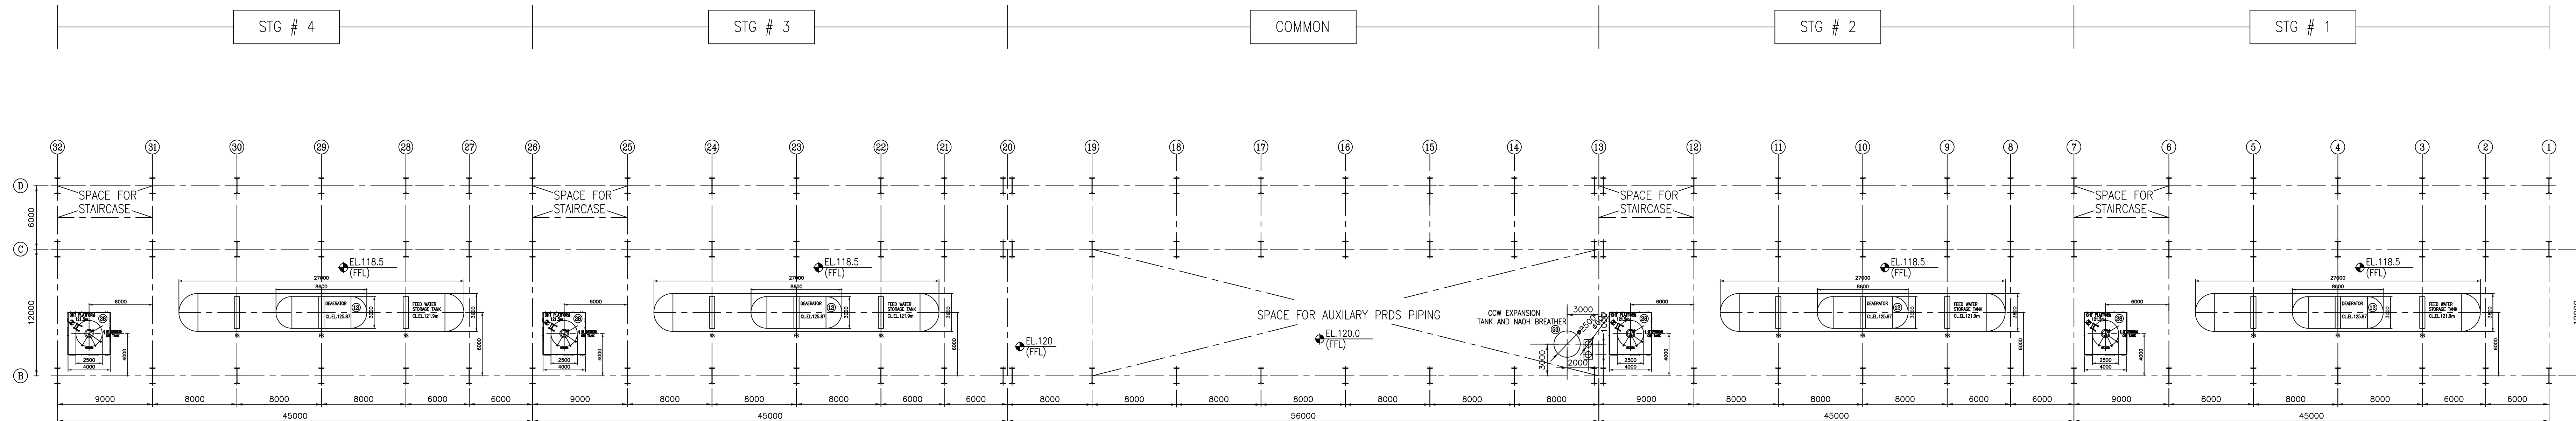

COOLING WATER SIDE | TRANSFORMER YARD

PLAN AT DEAERATOR FLOOR EL.118.5m (FFL)

PLAN AT COMMON BUILDING FLOOR EL.120m (FFL)

AND AT OHT PLATFORM EL.121.5m (TOS)

|                                                                                                      |                |                                                                                       |                |                                    |                     |
|------------------------------------------------------------------------------------------------------|----------------|---------------------------------------------------------------------------------------|----------------|------------------------------------|---------------------|
| CONSULTANT:<br> |                | BECHTEL<br>FREDERICK, MARYLAND, U.S.A                                                 |                |                                    |                     |
| PROJECT:                                                                                             |                | STG PACKAGE (4 X 93.1 MW STGs), CCPP<br>HAZIRA MANUFACTURING DIVISION (HMD)           |                |                                    |                     |
| CUSTOMER:<br>   |                | RELANCE UTILITIES AND POWER PRIVATE LIMITED<br>COAL BASED CAPTIVE POWER PLANT (CCPP)  |                |                                    |                     |
| RUPPL DRG.<br>NUMBER<br>HAZIRA:                                                                      |                | 10090-P50-HAT000-BHB-0001                                                             |                |                                    |                     |
|                 |                | BHARAT HEAVY ELECTRICALS LTD.<br>PROJECT ENGS & SYSTEMS DIVISION                      |                |                                    |                     |
|                                                                                                      |                | HYDERABAD                                                                             |                |                                    |                     |
| DEPT<br>PESD-ENG                                                                                     | UNTLG<br>G/W/Y |  | SCALE<br>1:250 | WEIGHT (KG)                        | NA                  |
| CODE<br>49                                                                                           |                |                                                                                       |                | REF. TO ASSY. DRG.                 | ITEM NO<br>ITEMS NA |
| TITLE<br>INPUT FOR STG HALL<br>EQUIPMENT LAYOUT                                                      |                | CARD<br>CODE                                                                          |                | BHEL DRAWING NO:<br>0-381-01-01529 |                     |
|                                                                                                      |                |                                                                                       |                | SHT. NO 03                         | NO. OF SHTS 09      |

[illegible]