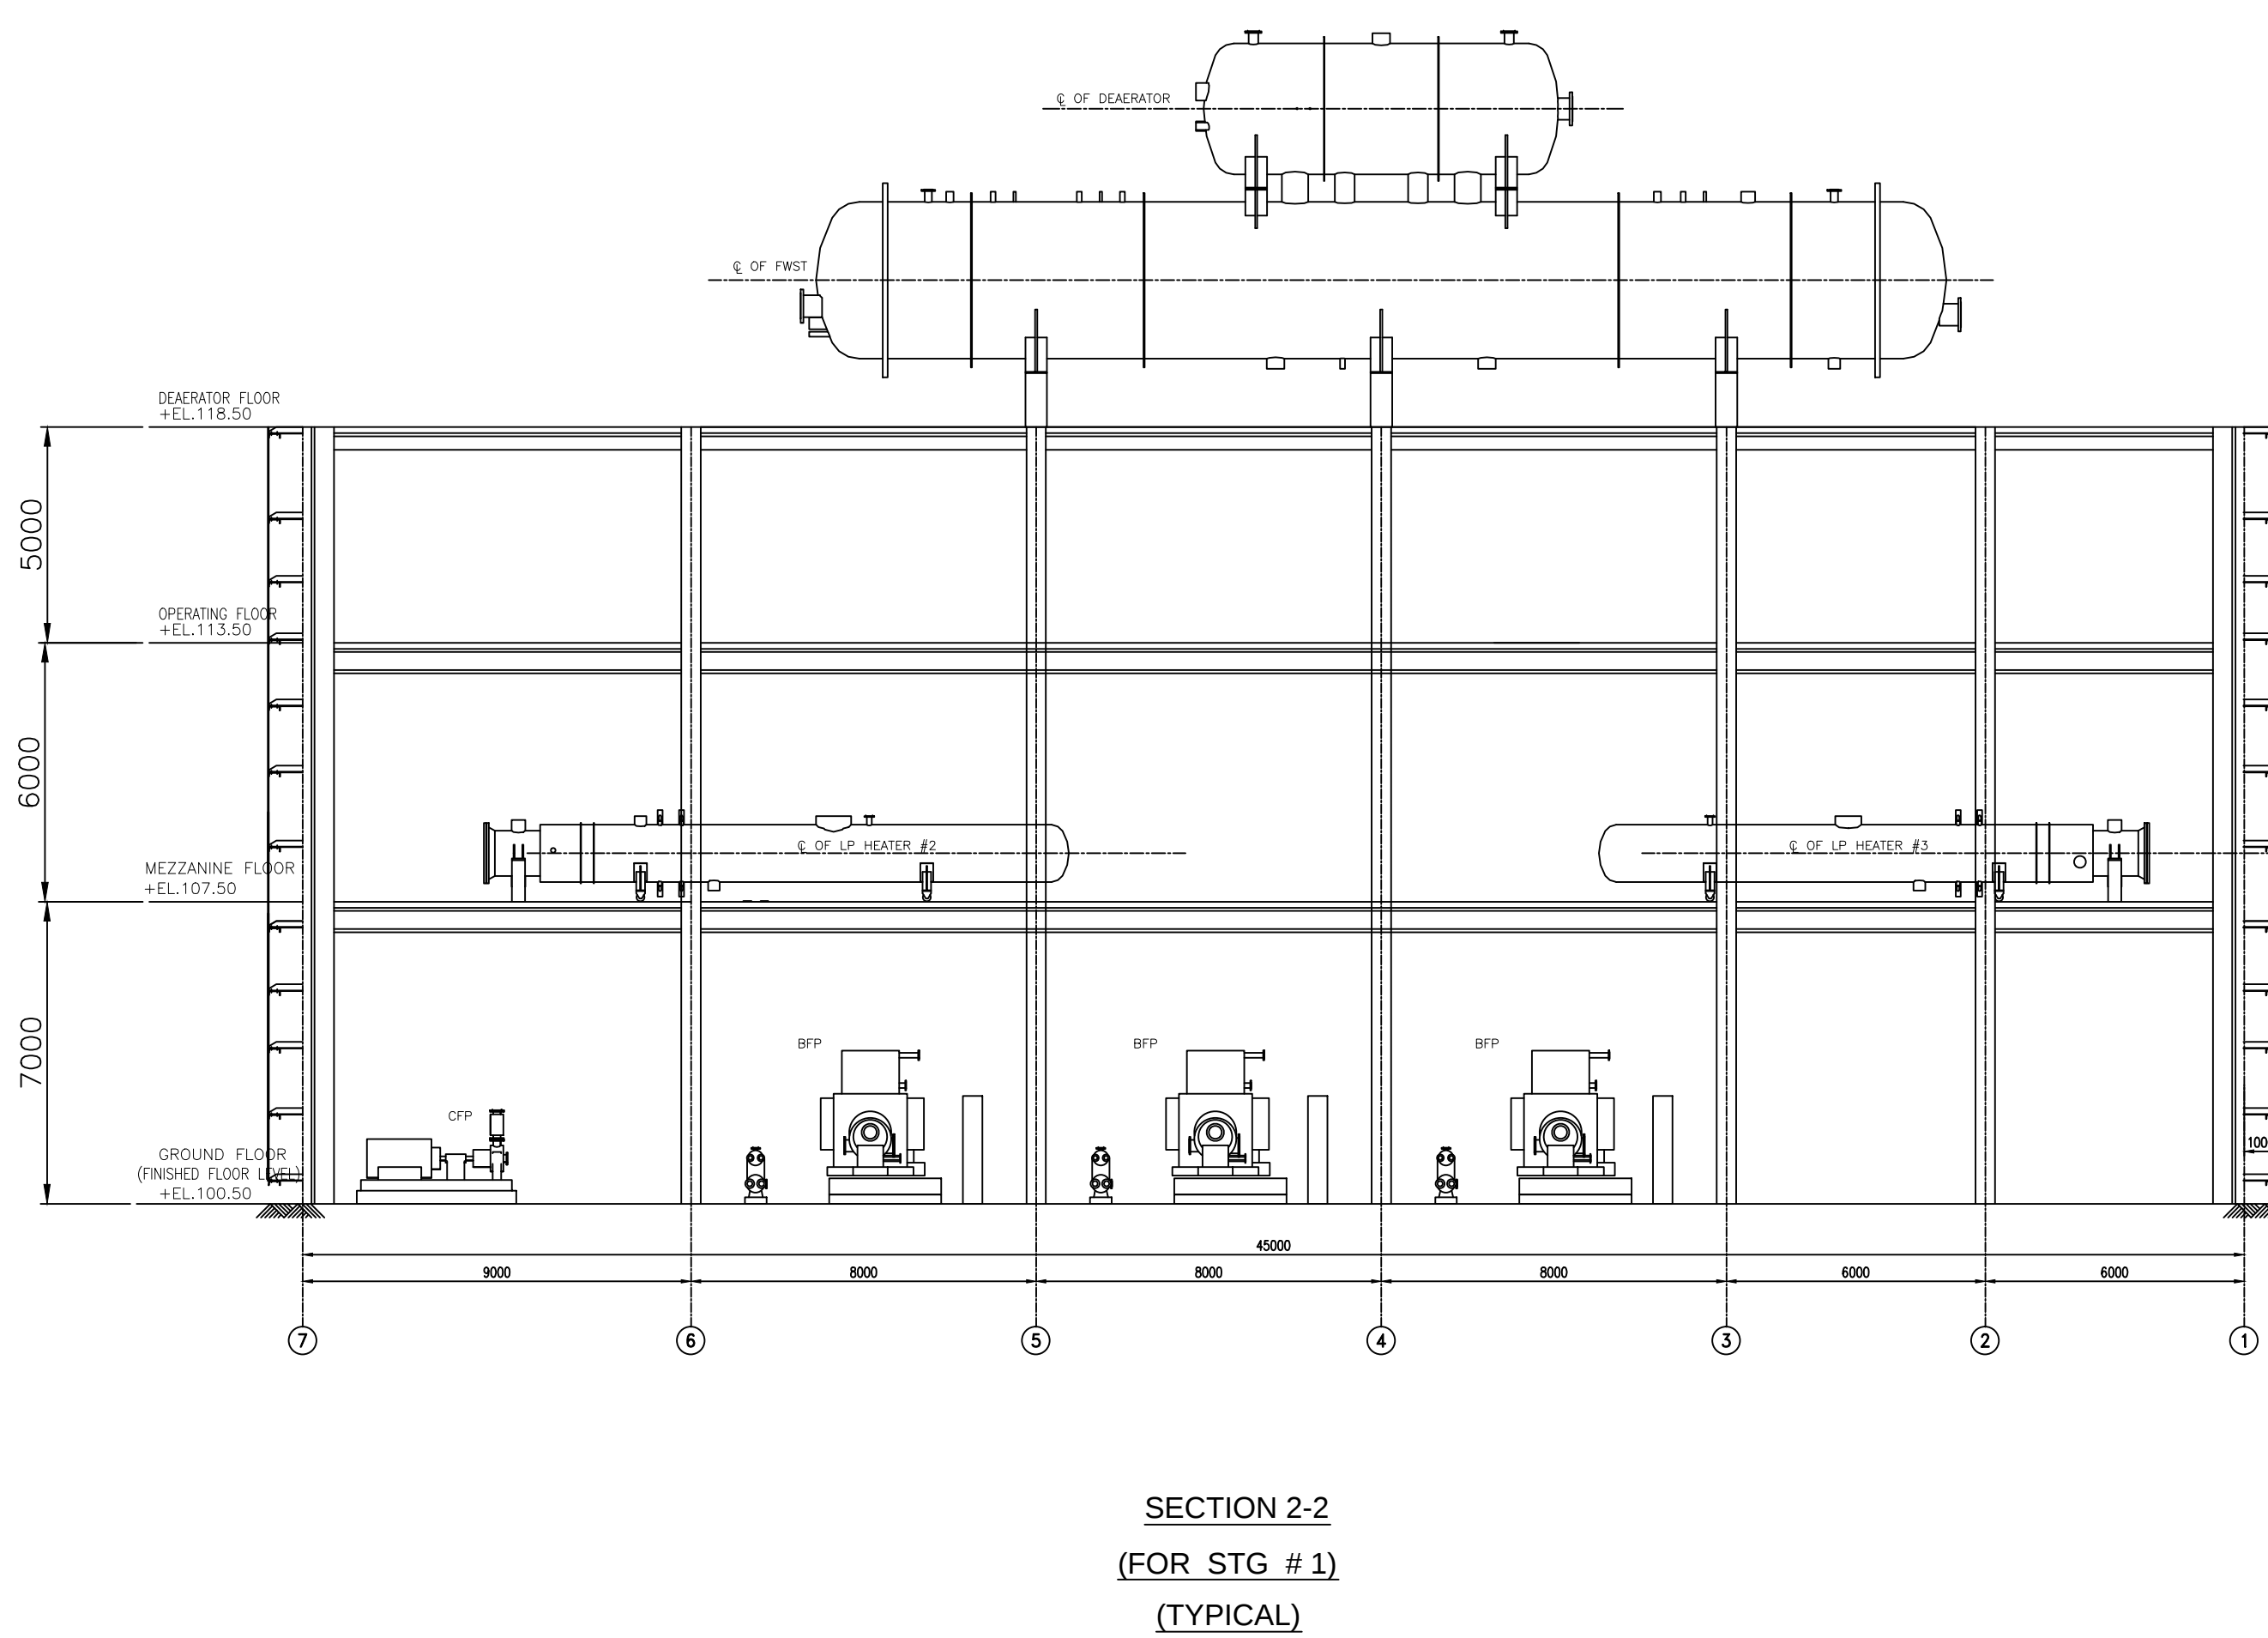
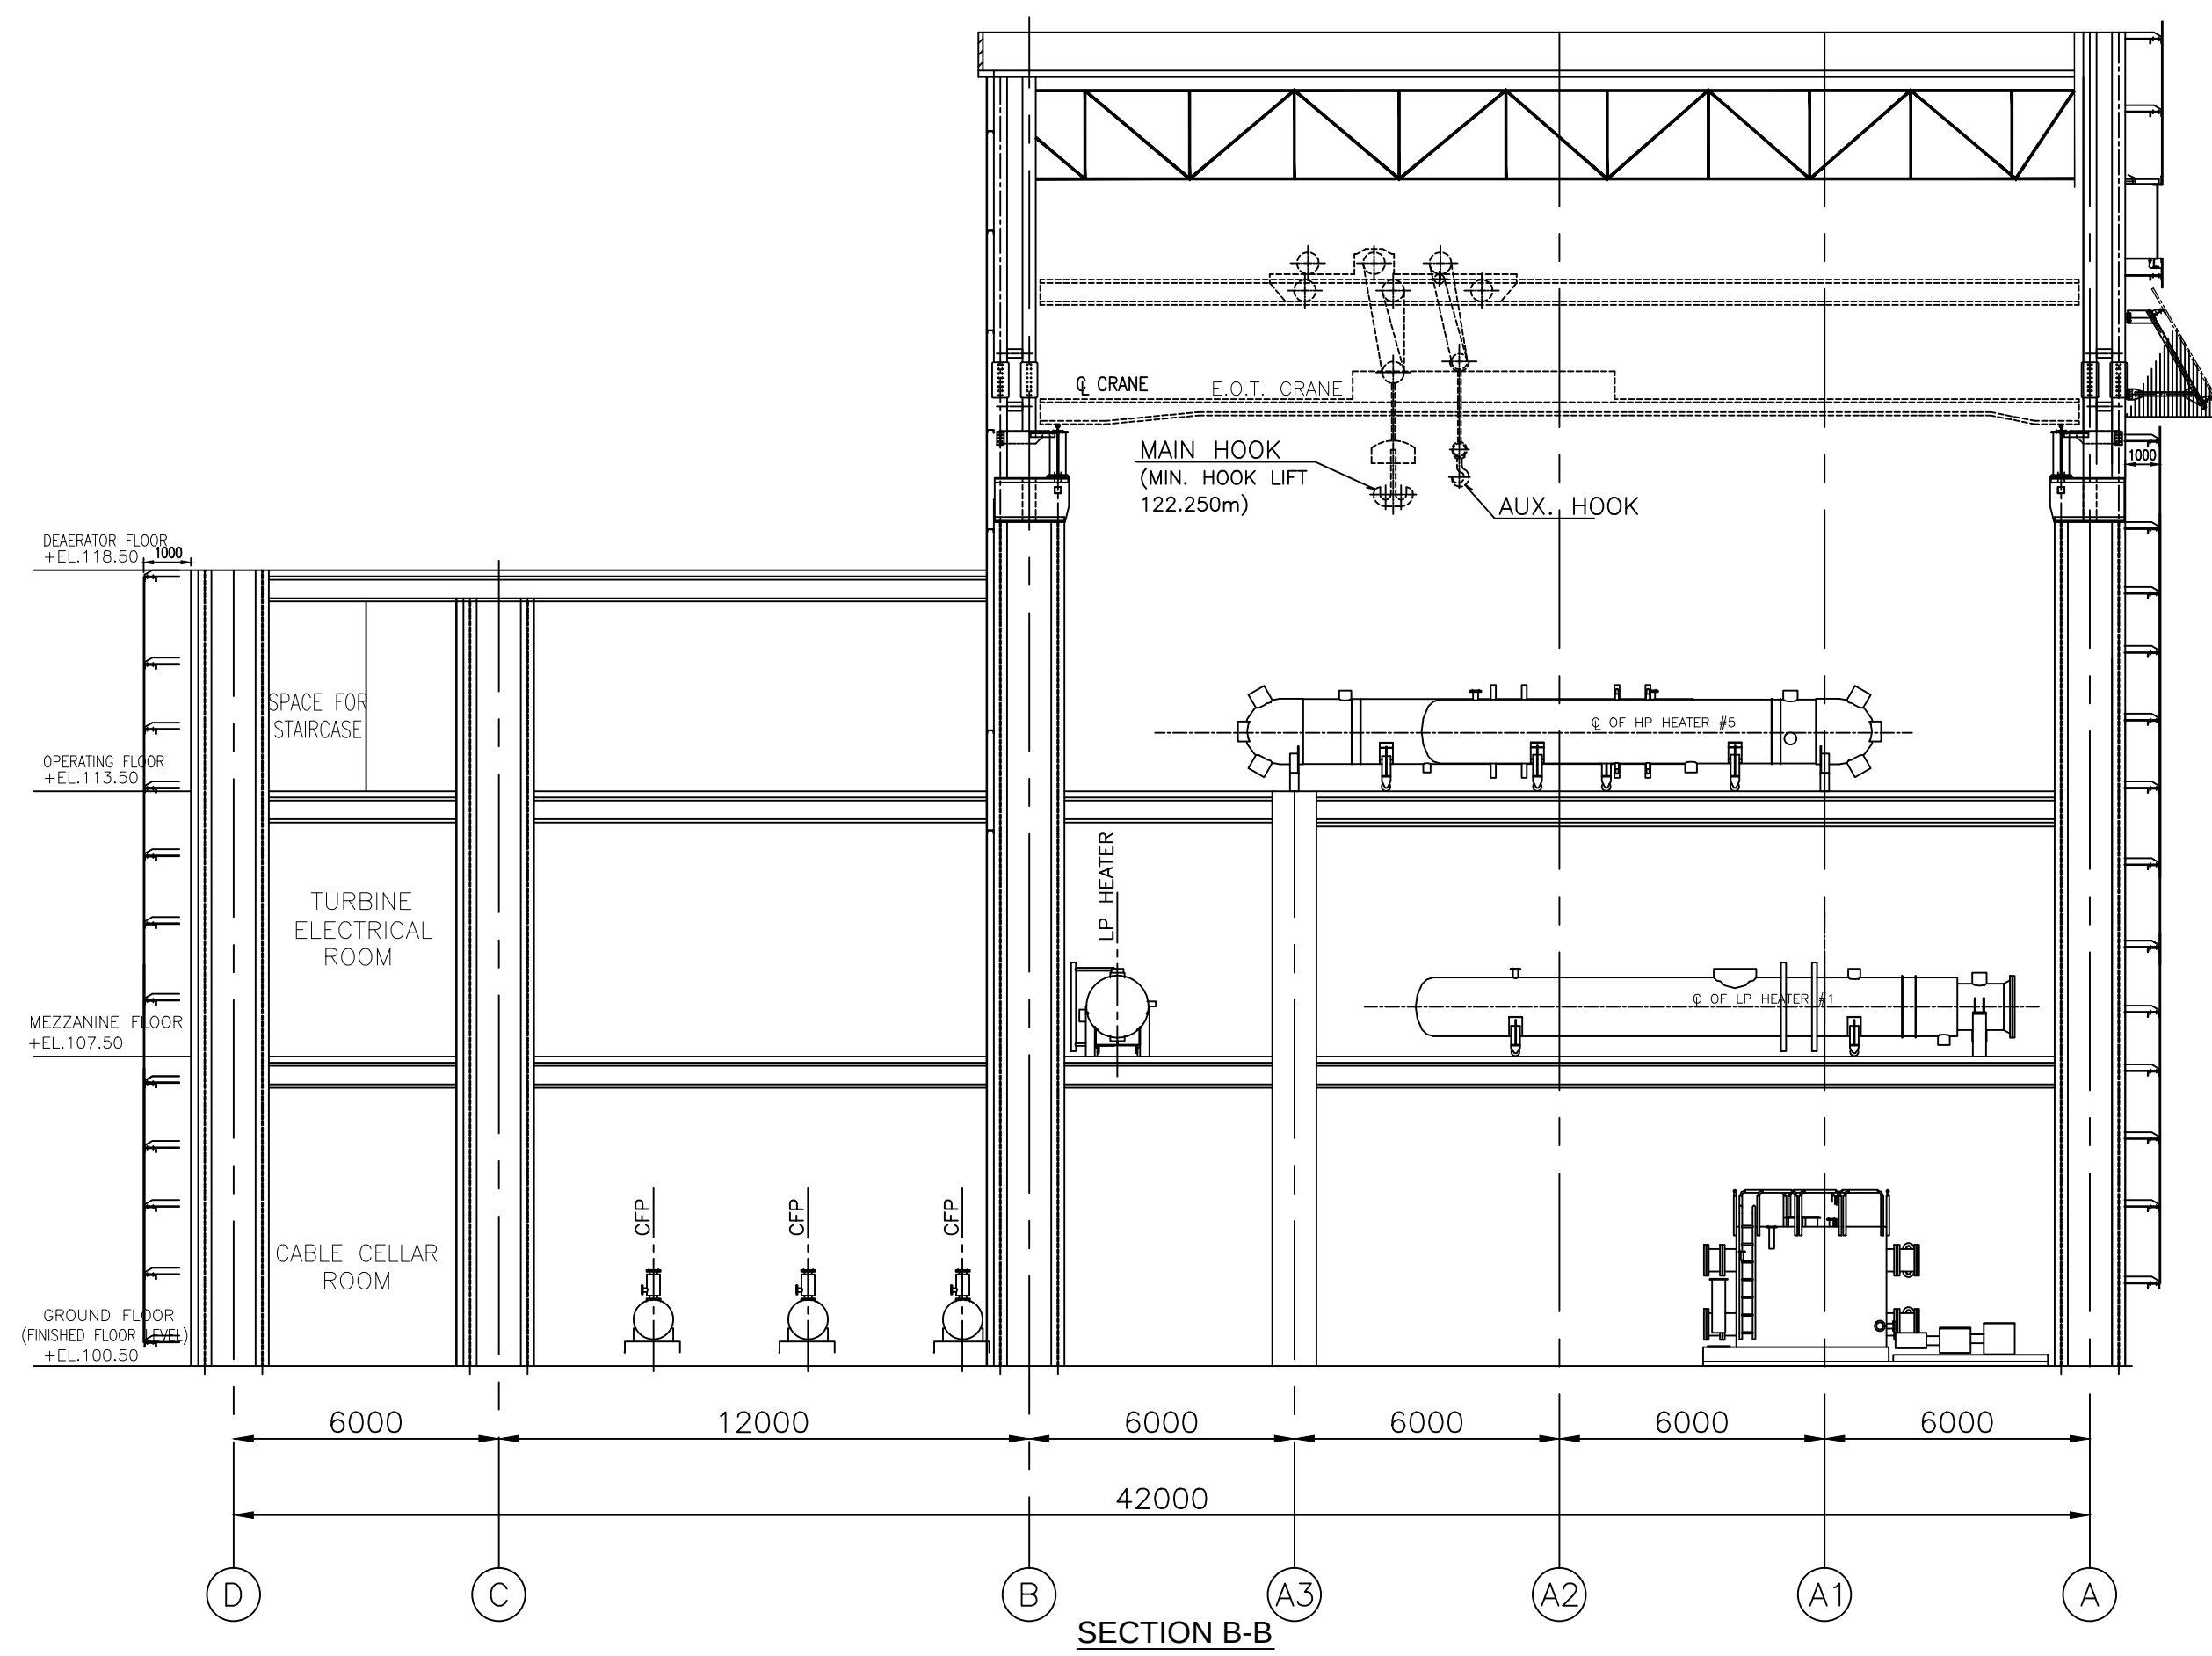


INVENTORY NO

[illegible]

CONSULTANT: 		BECHTEL FREDERICK, MARYLAND, U.S.A.									
PROJECT:		STG PACKAGE (4 X 93.1 MW STG's), CCPP HAZIRA MANUFACTURING DIVISION (HMD)									
CUSTOMER:		RELIANCE UTILITIES AND POWER PRIVATE LIMITED COAL BASED CAPTIVE POWER PLANT (CCPP)									
											
RUPPI DRG. NUMBER		10090-P50-HAT000-BHB-0001									
		BHARAT HEAVY ELECTRICALS LTD. PROJECT DRWG. & SYSTEMS DIVISION HYDERABAD									
DEPT.    UNITS, DIMS. &    450		SCALE 1:100		WEIGHT (KG)		REF. TO ASSY. DRG.		ITEM NO.		NO OF ITEMS	
TITLE		INPUT FOR STG HALL EQUIPMENT LAYOUT		CARD CODE		BHEL DRAWING NO: 0-381-01-01529		REV.		09	
						Sht. No.		No. of Sht.		04	