



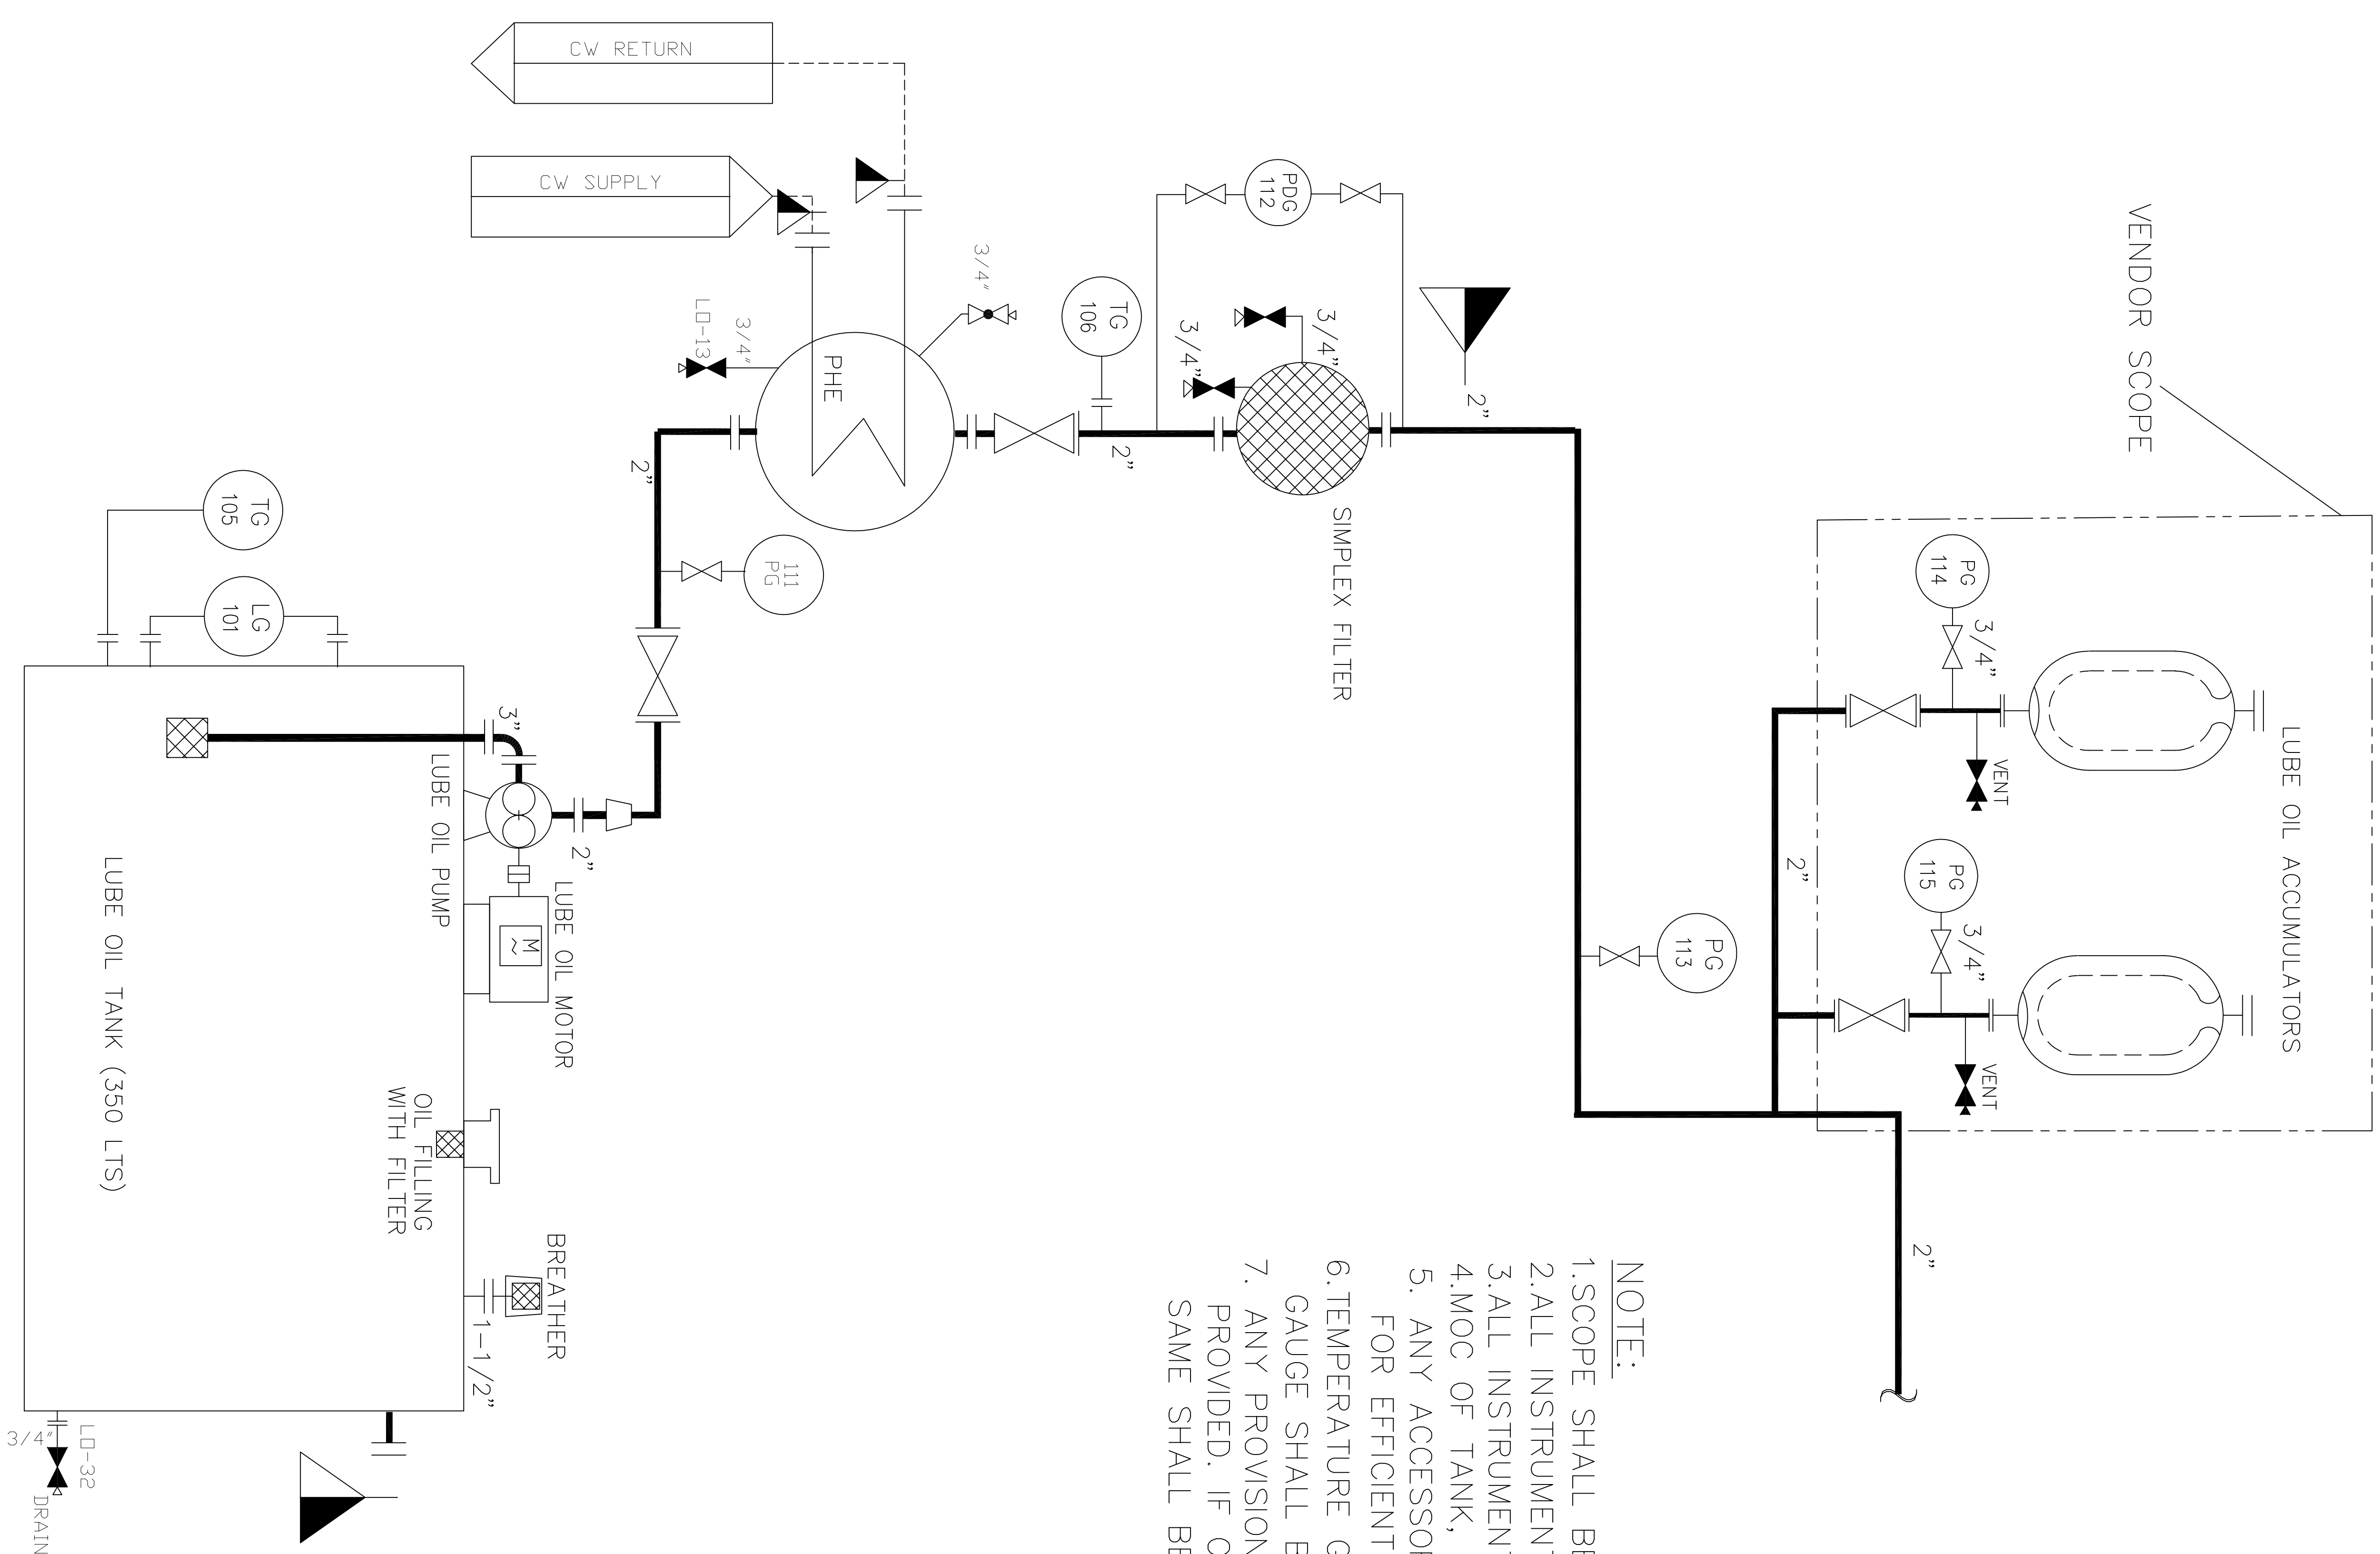

NOTE:

1. SCOPE SHALL BE AS MARKED.
2. ALL INSTRUMENTS, PIPING, FITTING SHALL BE PROVIDED.
3. ALL INSTRUMENTS SHALL BE FOR LOCAL DISPLAY.
4. MOC OF TANK, FILTER AND INTERCONNECTING PIPE SHALL BE CS.
5. ANY ACCESSORIES REQUIRED OTHER THAN THE P&ID REQUIRED FOR EFFICIENT OPERATION SHALL BE CLEARLY SPELT.
6. TEMPERATURE GAUGE SHALL BE TOP MOUNTED. IF POSSIBLE LEVEL GAUGE SHALL BE TOP MOUNTED.
7. ANY PROVISION REQUIRED FOR PRIMING OF PUMP SHALL BE PROVIDED. IF CHECK VALVE IS REQUIRED IN DISCHARGE OF PUMP SAME SHALL BE CONSIDERED.

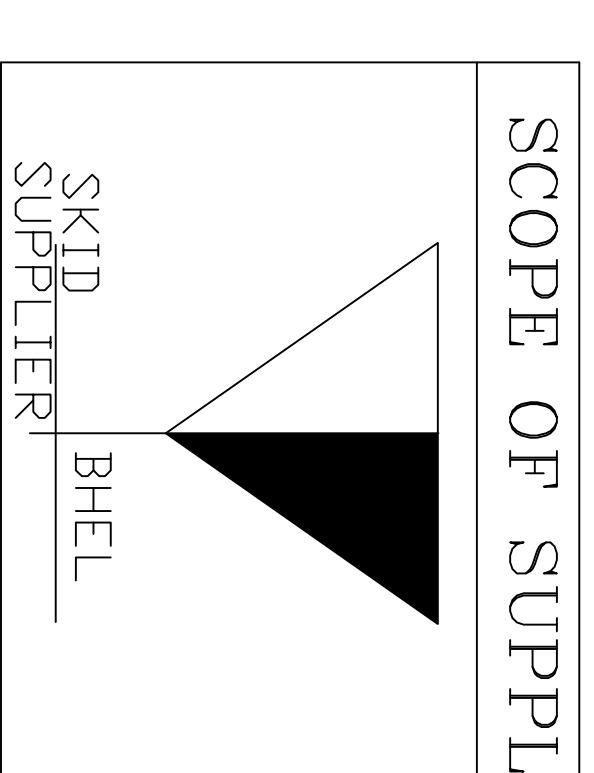

PROJECT: MAHAGENCO BHUSAWAL
LUBE OIL SCHEME FOR FGD BLOWER
DRG NO: 1-336-00-B00100