



# ANNEXURE-XIII


A/7-100-6-51-03100

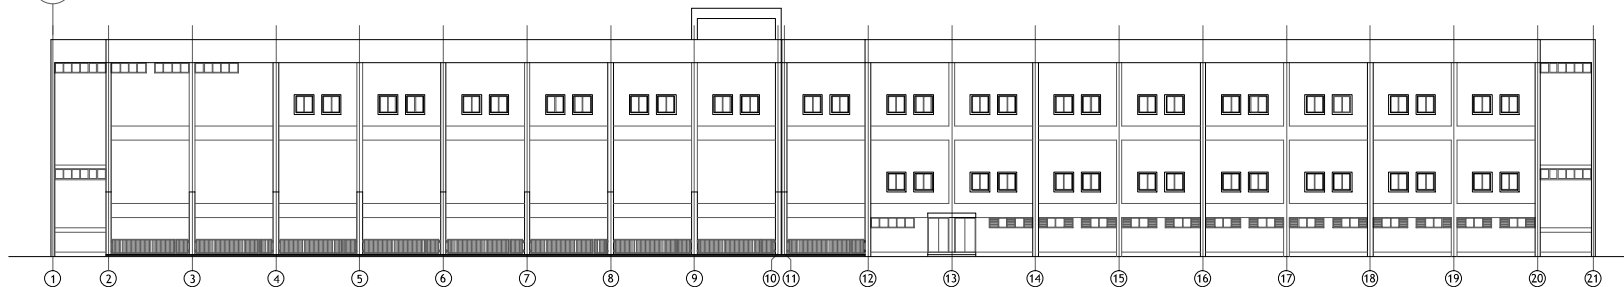

EAST ELEVATION

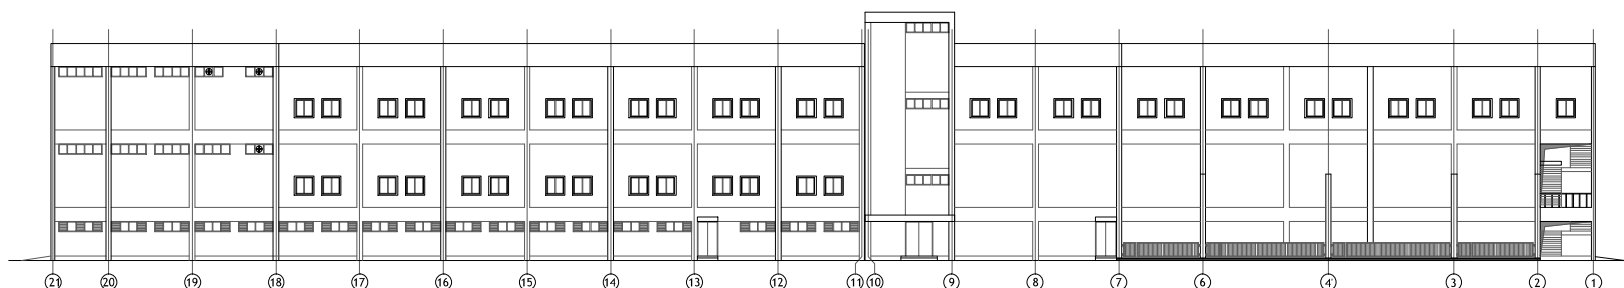

WEST ELEVATION

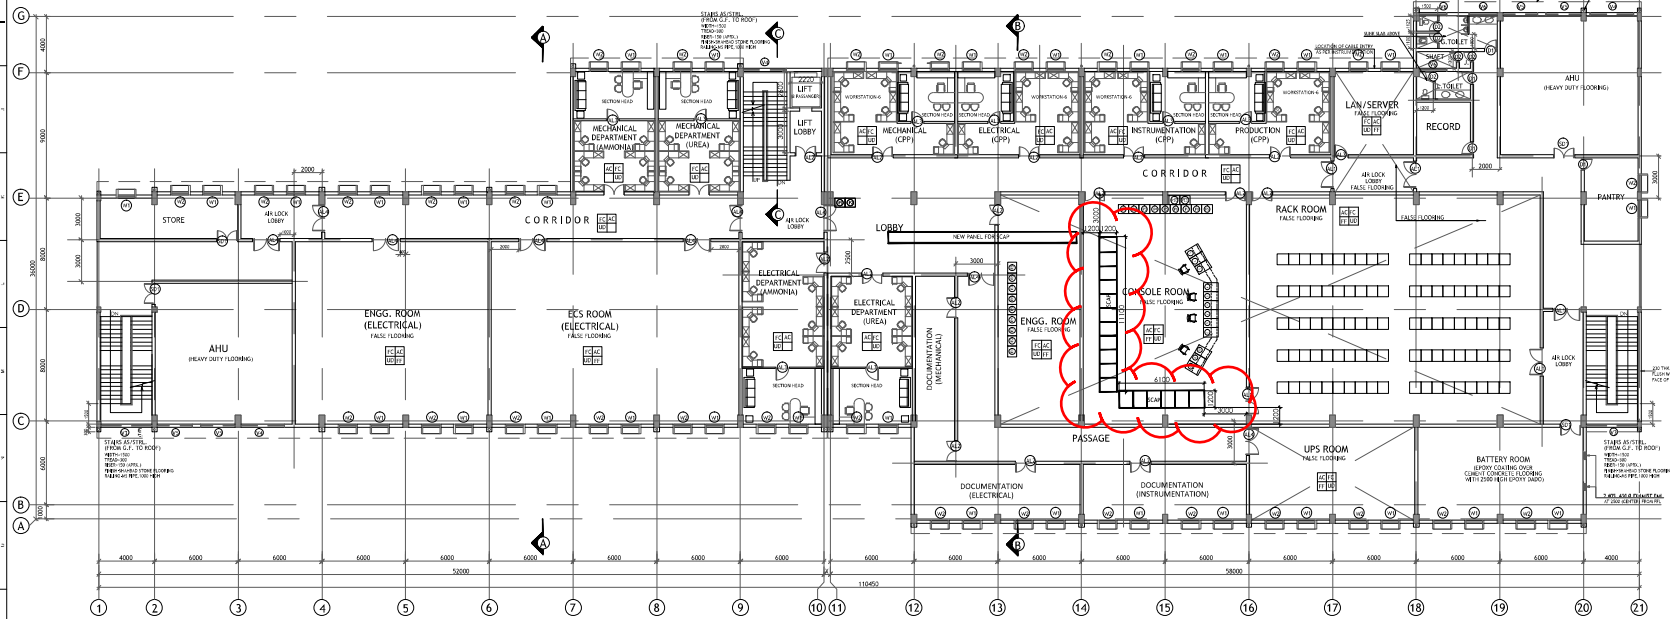

SECOND FLOOR PLAN

REF. DWG. NO. REFERENCE DRAWING TITLE  
GTG CONSOLE SECOND FLOOR PLAN & ELEVATIONS

NOTES :-  
1. ALL DIMENSIONS ARE IN MM & LEVELS IN METRES.  
2. FOR EXACT LOCATION LEVELS REFER TO ORL AREA DWG / PLOT PLAN.  
3. LEVEL 100.000 INDICATES FINISHED APPROACH ROAD LEVEL NEAR THE BUILDING.

## LEGEND FOR CONSOLE:

| S. No. | DESCRIPTION               |
|--------|---------------------------|
|        | POWER PLANT               |
| 1      | GTG CONSOLE # 1           |
| 2      | GTG CONSOLE # 2           |
| 3      | AUX. CONSOLE (PAS)        |
| 4      | DCS CONSOLE # 1 (RPP) # 1 |
| 5      | DCS CONSOLE # 2 (RPP) # 2 |
| 6      | HARD WIRED CONSOLE        |
| 7      | HRSG SMS                  |
| 8      | UB SMS                    |
| 9      | HARD WIRED CONSOLE        |
| 10     | AUX. CONSOLE              |
| 11     | ECG # 1                   |
| 12     | ECG # 2                   |
|        |                           |
|        |                           |
|        | ENGINEERING STATION       |
| 13     | GTG EWS # 1               |
| 14     | GTG EWS # 2               |
| 15     | GTG EWS # 3               |
| 16     | PLC EWS                   |
| 17     | UBS PC                    |
| 18     | HRSG SMS                  |
| 19     | UB SMS                    |
| 20     | HRSG SMS EWS              |
| 21     | DUMMY CONSOLE             |
|        |                           |
|        |                           |
|        | SOE PC WITH PRINTER       |
| 22     | HRSG SOE PC               |
| 23     | HRSG SOE PRINTER          |
| 24     | UB SOE PC                 |
| 25     | UB SOE PRINTER            |
| 26     | SOE PC BY DCS VENDOR      |
| 27     | SOE PRINTER BY DCS VENDOR |
| 28     | HARD COPIER               |
| 29     | MULTIPURPOSE PRINTER      |
| 30     | CONSOLE BACKUP PRINTER    |
| 31     | PCD PANEL (GTO)           |
| 32     | AUX. PANEL (GTO)          |