



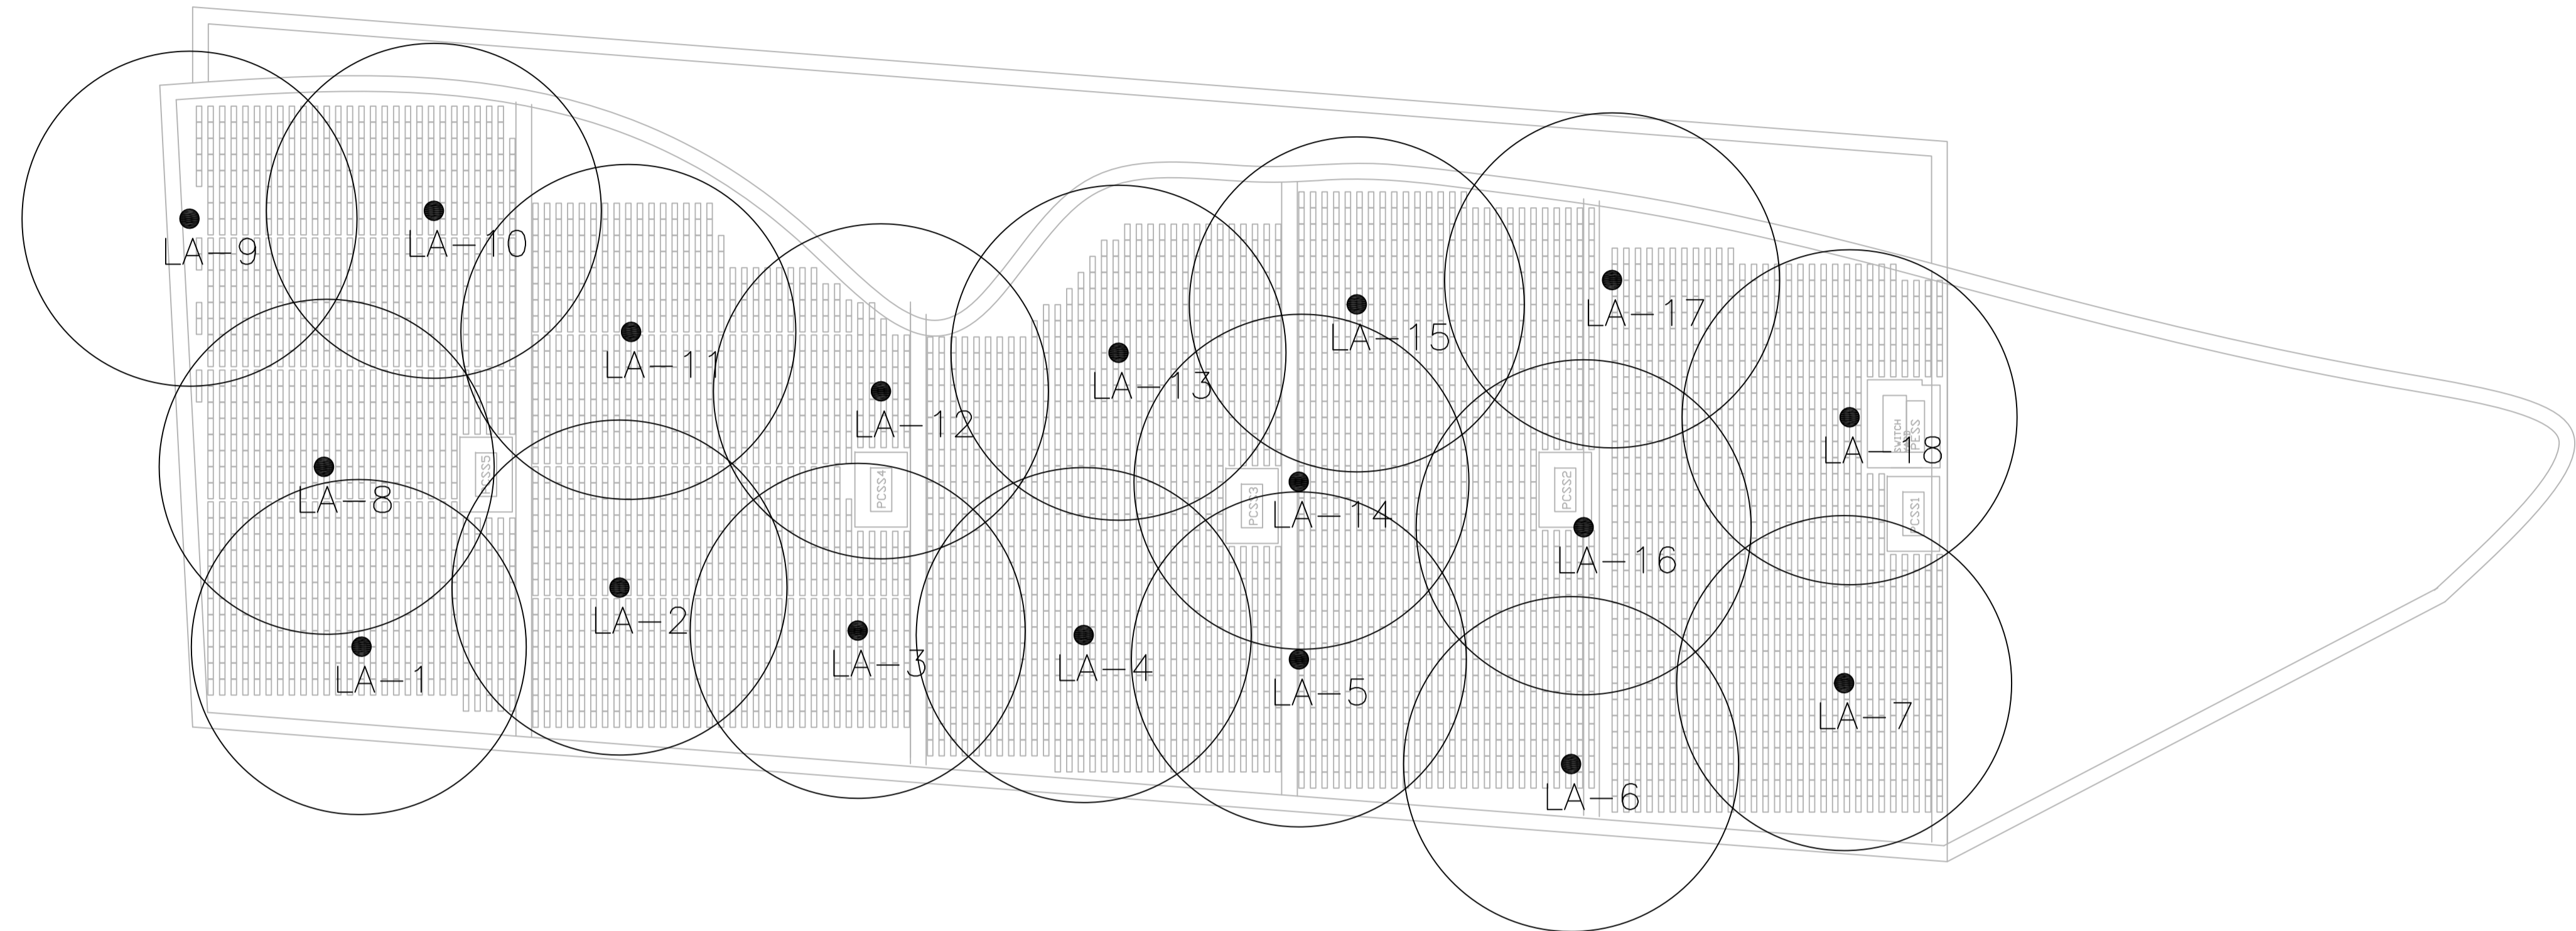

DRG. NO. PY-LL-1-M088-2001-01  
SHT. 05 OF 08

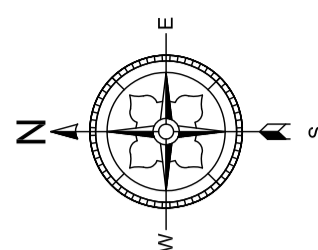

NOTE:  
1. ALLYTECH-90 MODEL OF ALLYWELL MAKE ESE TYPE LIGHTNING ARRESTOR WITH RADIUS OF PROTECTION OF 107M IS CONSIDERED FOR PREPARATION OF LAYOUT. REVISED LAYOUT SHALL BE SUBMITTED AFTER FINALIZATION OF ESE TYPE LIGHTNING ARRESTOR VENDOR.

THE INFORMATION ON THIS DOCUMENT IS THE PROPERTY OF BHARAT HEAVY ELECTRICALS LIMITED. IT MUST NOT BE USED DIRECTLY OR INDIRECTLY IN ANY WAY DETRIMENTAL TO THE INTEREST OF THE COMPANY.

GENERAL DIMENSIONAL LIMITS, FITS & TOLERANCES AS PER HY0230261

For Tender Purpose Only

ESE TYPE LIGHTNING ARRESTOR		
SL.NO.	MAKE	QUANTITY
1	ALLYTECH-90	18

REFERENCE DRAWING:  
25MW ARRAY LAYOUT

PROJECT : 65MW AC SOLAR POWER PLANT			
CUSTOMER : NEYVELI LIGNITE CORPORATION LTD. CONSULTANT : NEYVELI-TAMILNADU			
BHARAT HEAVY ELECTRICALS LTD. UNIT : PE&SD-HYDERABAD	NAME	SIGN.	DATE
	DRN.	S. RASTOGI	07.09.16
	CHD.	P SURESH	07.09.16
	APPD.	J K PATTANAIK	07.09.16
DEPT. PE&SD	UNTOL. DIMS. GR.	SCALE	WEIGHT (KG)
450	g/m/f	1:3000	N.A.
TITLE	CARD CODE	REF. TO ASSY. DRG.	ITEM NO.
OVERALL LIGHTNING PROTECTION LAYOUT	NA	N.A.	N.A.
DRAWING NO. PY-LL-1-M088-2001-01		REV.	NO. OF ITEMS
		00	N.A.
SHT. No 05	NO. OF SHT. 08		

REV.	DATE	ALTERED CHD/APPD	REV.	DATE	ALTERED CHD/APPD	REV.	DATE	ALTERED CHD/APPD	REV.	DATE	ALTERED CHD/APPD	REV.	DATE	ALTERED CHD/APPD	REV.	DATE	ALTERED CHD/APPD	REV.	DATE	ALTERED CHD/APPD	REV.	DATE	ALTERED CHD/APPD	REV.	DATE	ALTERED CHD/APPD	REV.	DATE	ALTERED CHD/APPD	REV.	DATE	ALTERED CHD/APPD			
ZONE			ZONE			ZONE			ZONE			ZONE			ZONE			ZONE			ZONE			ZONE			ZONE			ZONE			ZONE		

INVENTORY NO

H











10-1002-2001-1-M088-888W-1-TI-d  
DRG. NO. SHT. 08 OF 08

NOTES:-


1. DETAILS INDICATED ON THIS SHEET ARE TYPICAL. ACTUAL DETAILS SHALL BE AS PER FINALIZED VENDOR.

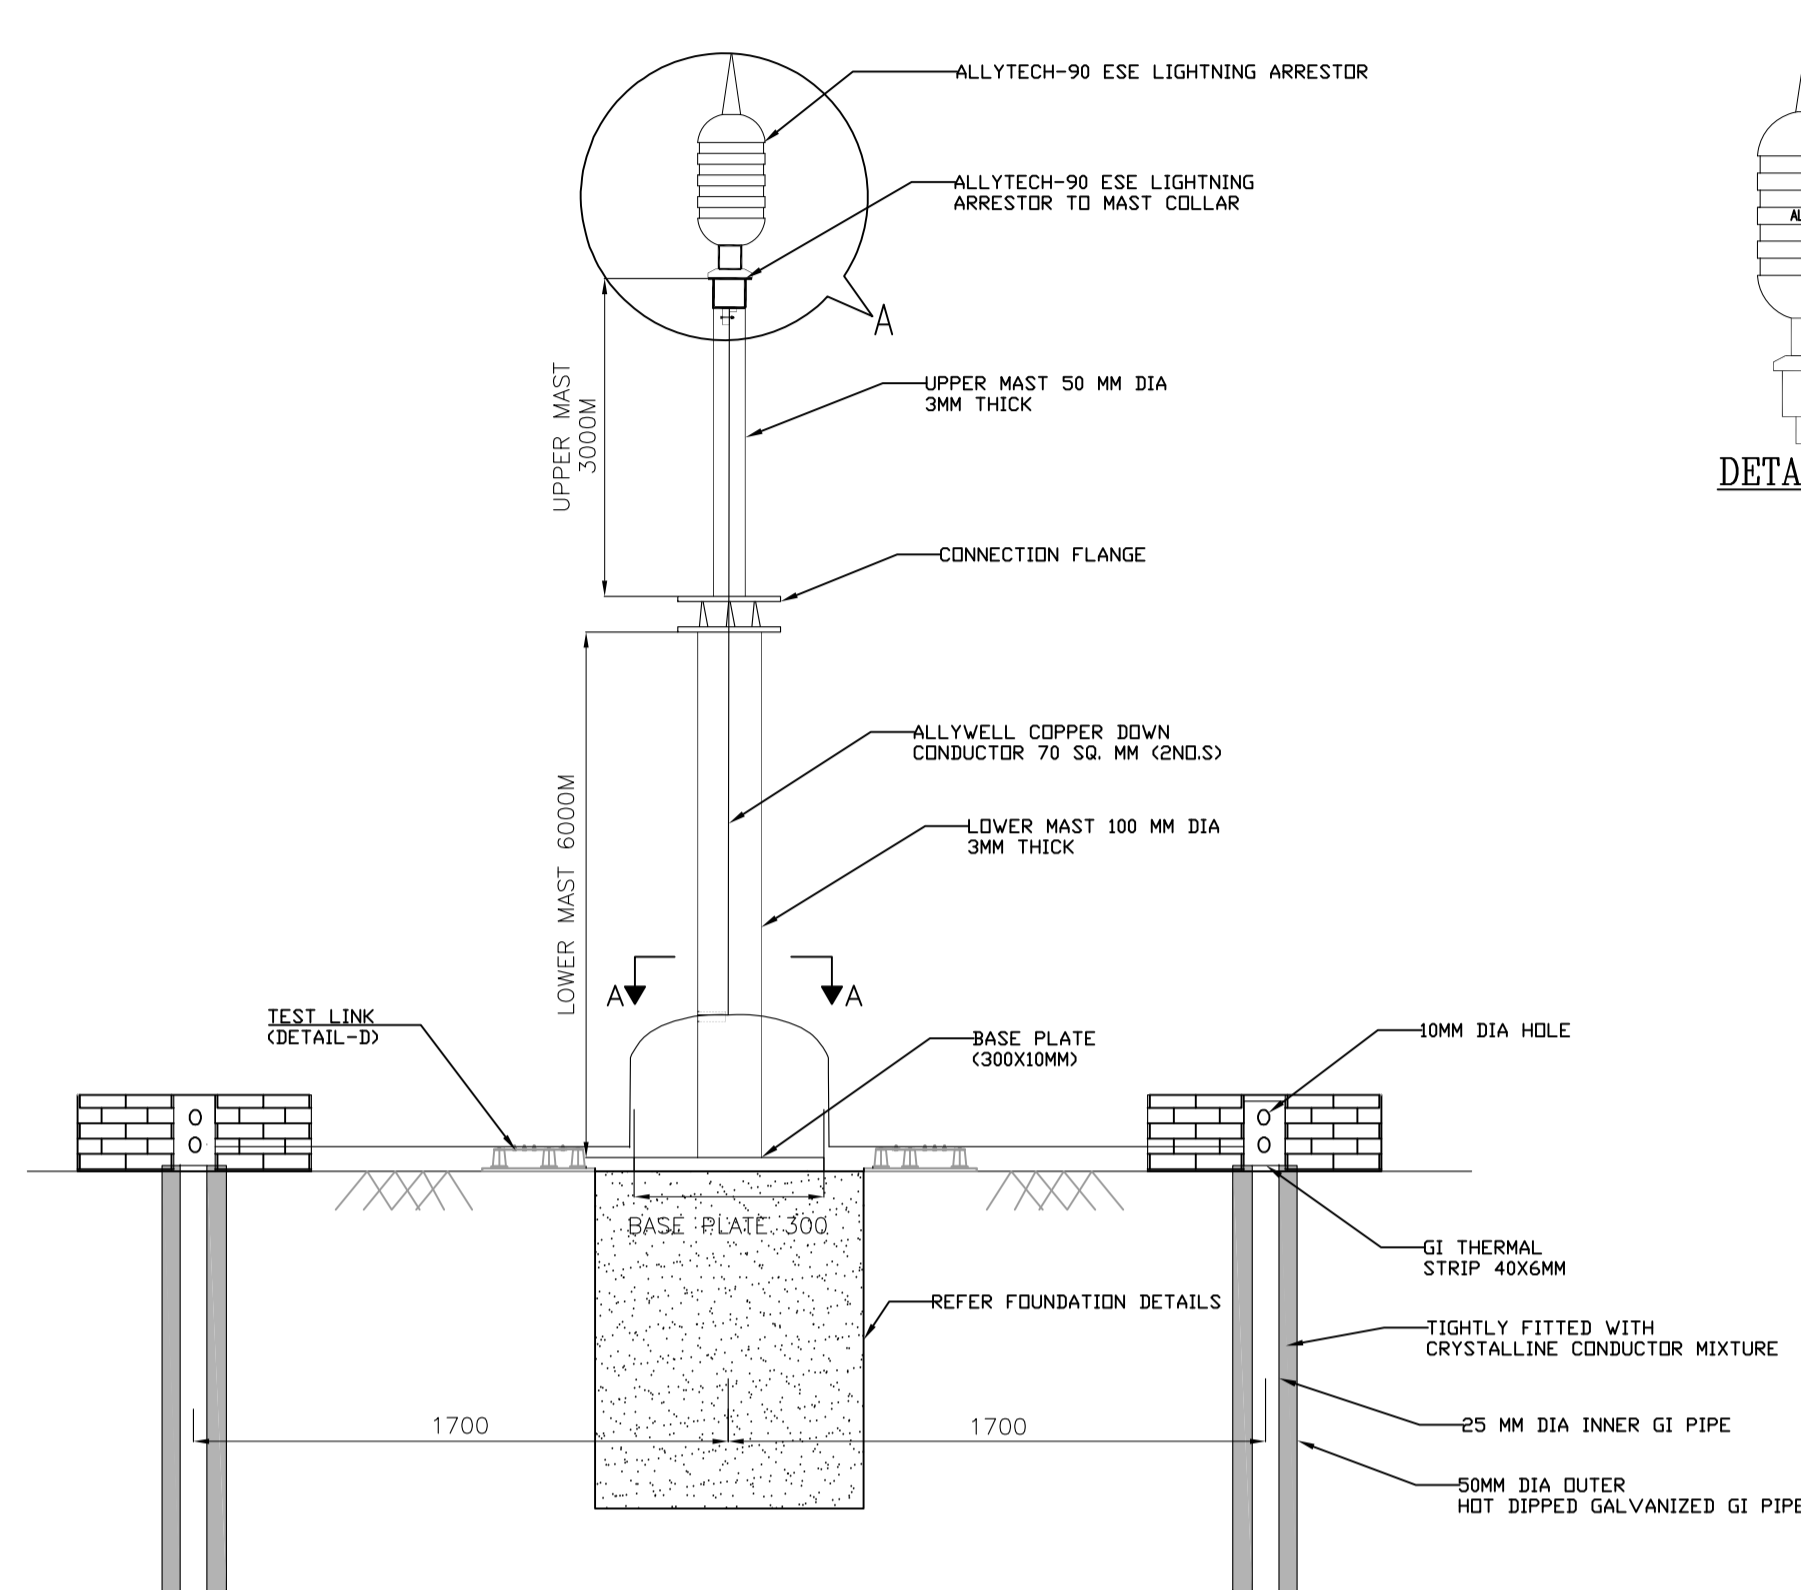


(TYPICAL)

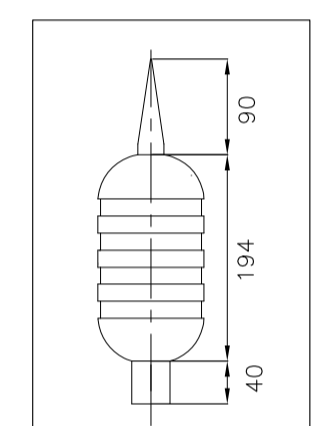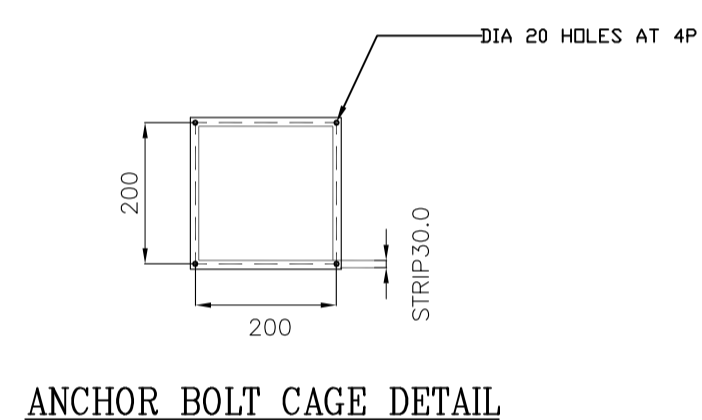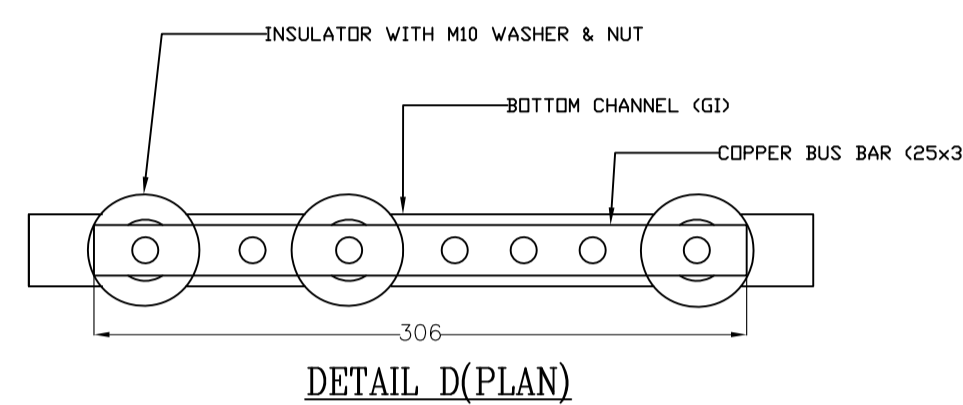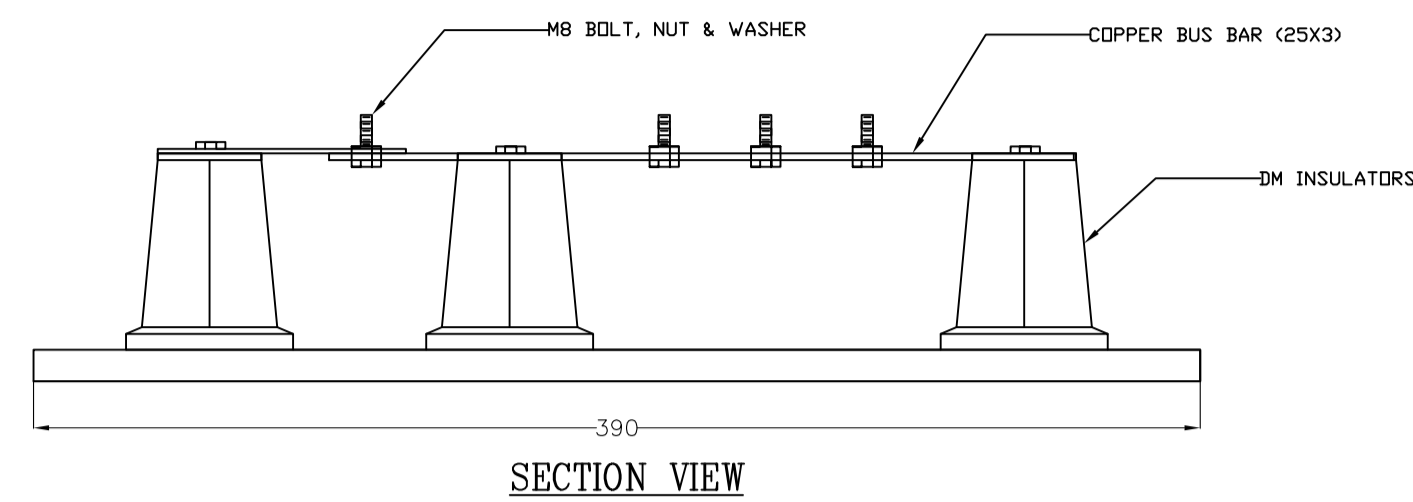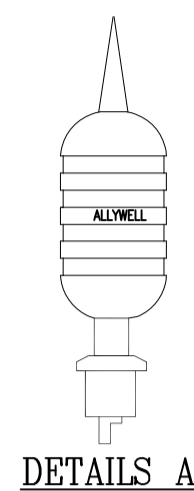






ALLYTECH 90 ESE LIGHTNING ARRESTOR

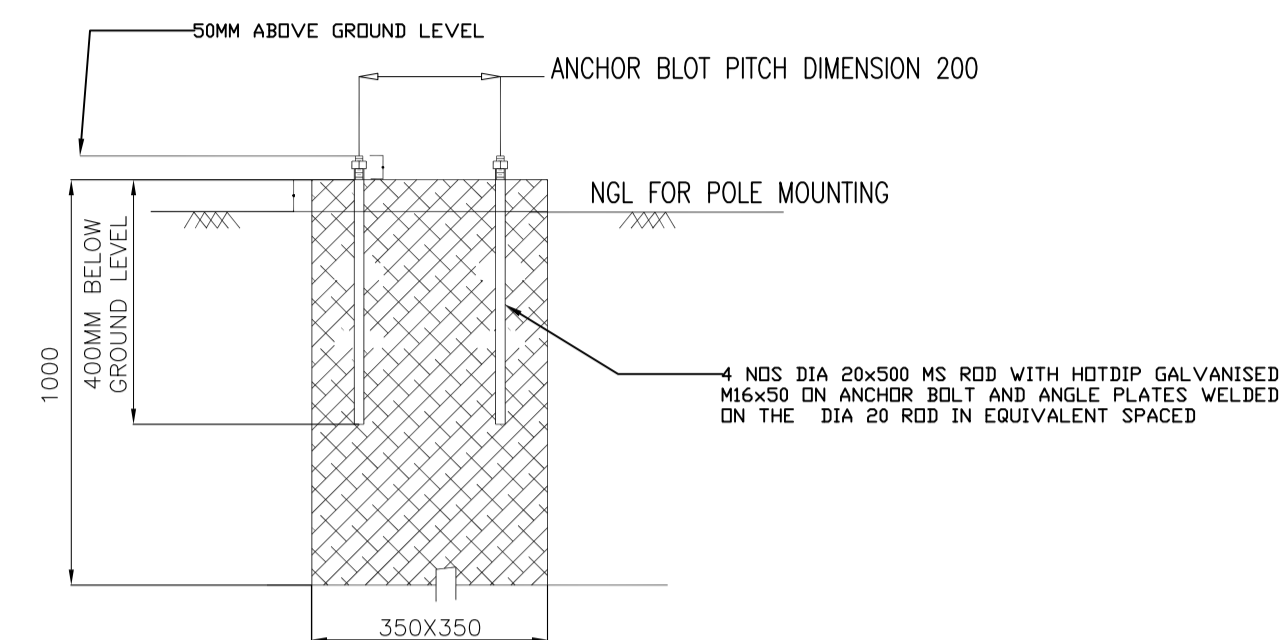

FOUNDATION DRAWING

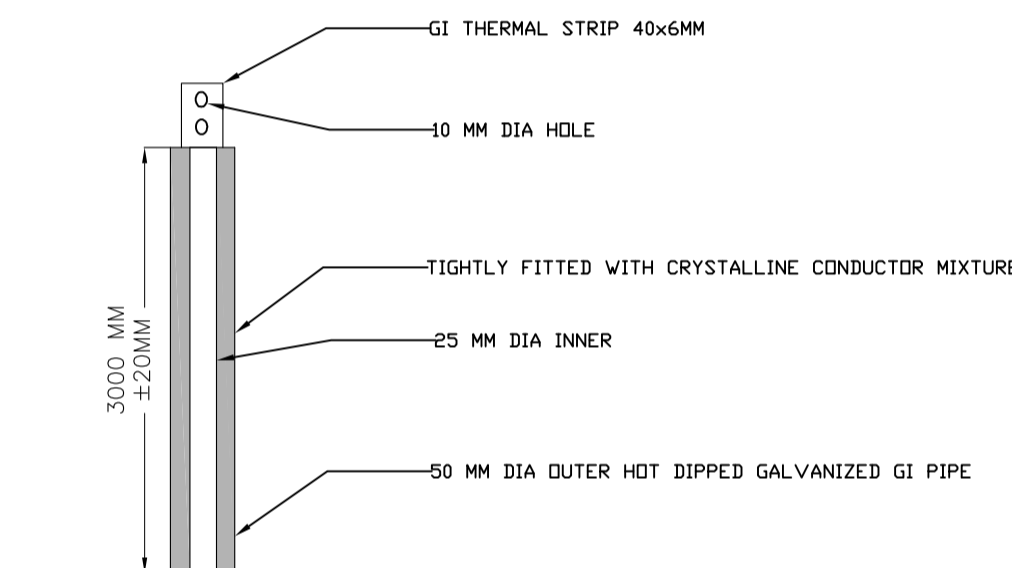

EARTH PIT DETAILS

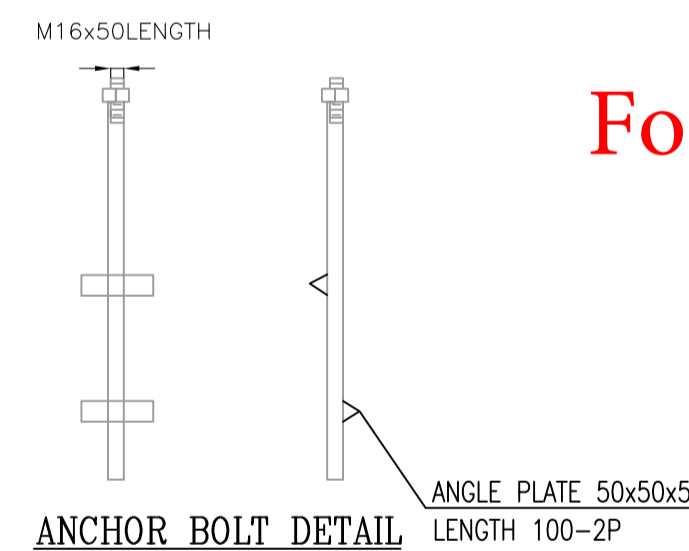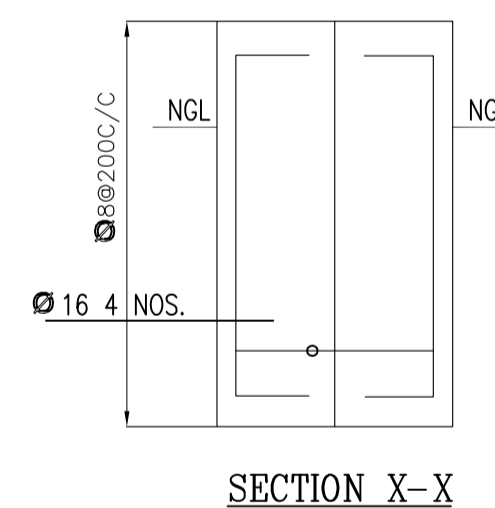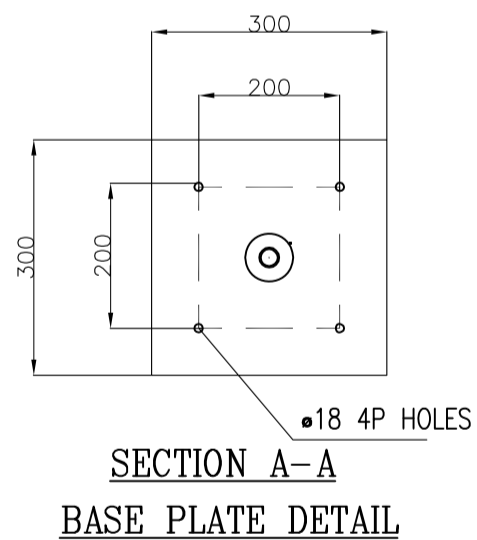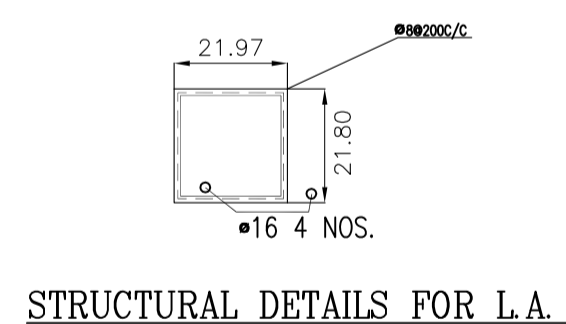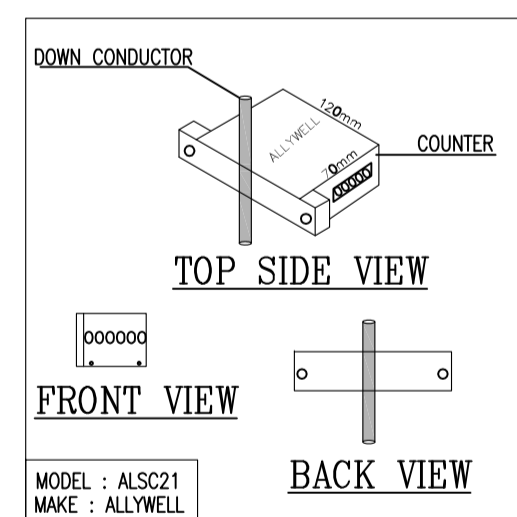

For Tender Purpose Only

THE INFORMATION ON THIS DOCUMENT IS THE PROPERTY OF BHARAT HEAVY ELECTRICALS LIMITED. IT MUST NOT BE USED DIRECTLY OR INDIRECTLY IN ANY WAY DETRIMENTAL TO THE INTEREST OF THE COMPANY.

GENERAL DIMENSIONAL LIMITS, FITS & TOLERANCES AS PER HY0230261

INVENTORY NO. SIGN. AND DATE REF. DRG. NO. COMPUTER FILE NAME

REV.	DATE	ALTERED CHD/APPD	REV.	DATE	ALTERED CHD/APPD	REV.	DATE	ALTERED CHD/APPD	REV.	DATE	ALTERED CHD/APPD	REV.	DATE	ALTERED CHD/APPD	REV.	DATE	ALTERED CHD/APPD	REV.	DATE	ALTERED CHD/APPD	REV.	DATE	ALTERED CHD/APPD	REV.	DATE	ALTERED CHD/APPD	

PROJECT : 65MW AC SOLAR POWER PLANT									
CUSTOMER : NEYVELI LIGNITE CORPORATION LTD. NEYVELI-TAMILNADU									
DEPT. PE&SD		UNTO. DIMS. GR.		SCALE		WEIGHT (KG)		REF. TO ASSY. DRG.	
450	g/m/y					N.A.	N.A.	N.A.	N.A.
TITLE		CARD CODE		DRAWING NO.		REV.		NO. OF ITEMS	
OVERALL LIGHTNING PROTECTION LAYOUT		NA		PY-LL-1-M088-2001-01		000		08	
SHT. No 08		NO. OF SHT. 08							