
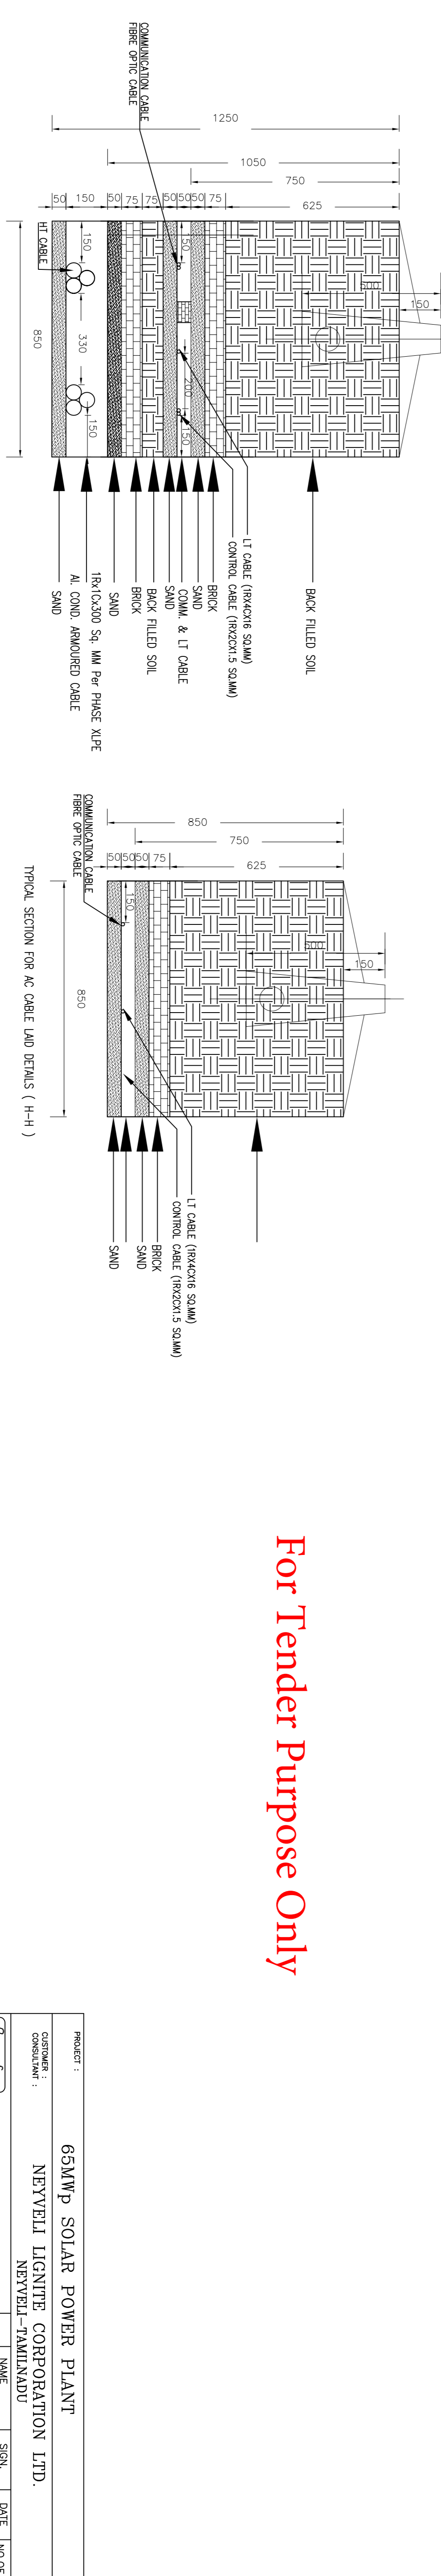
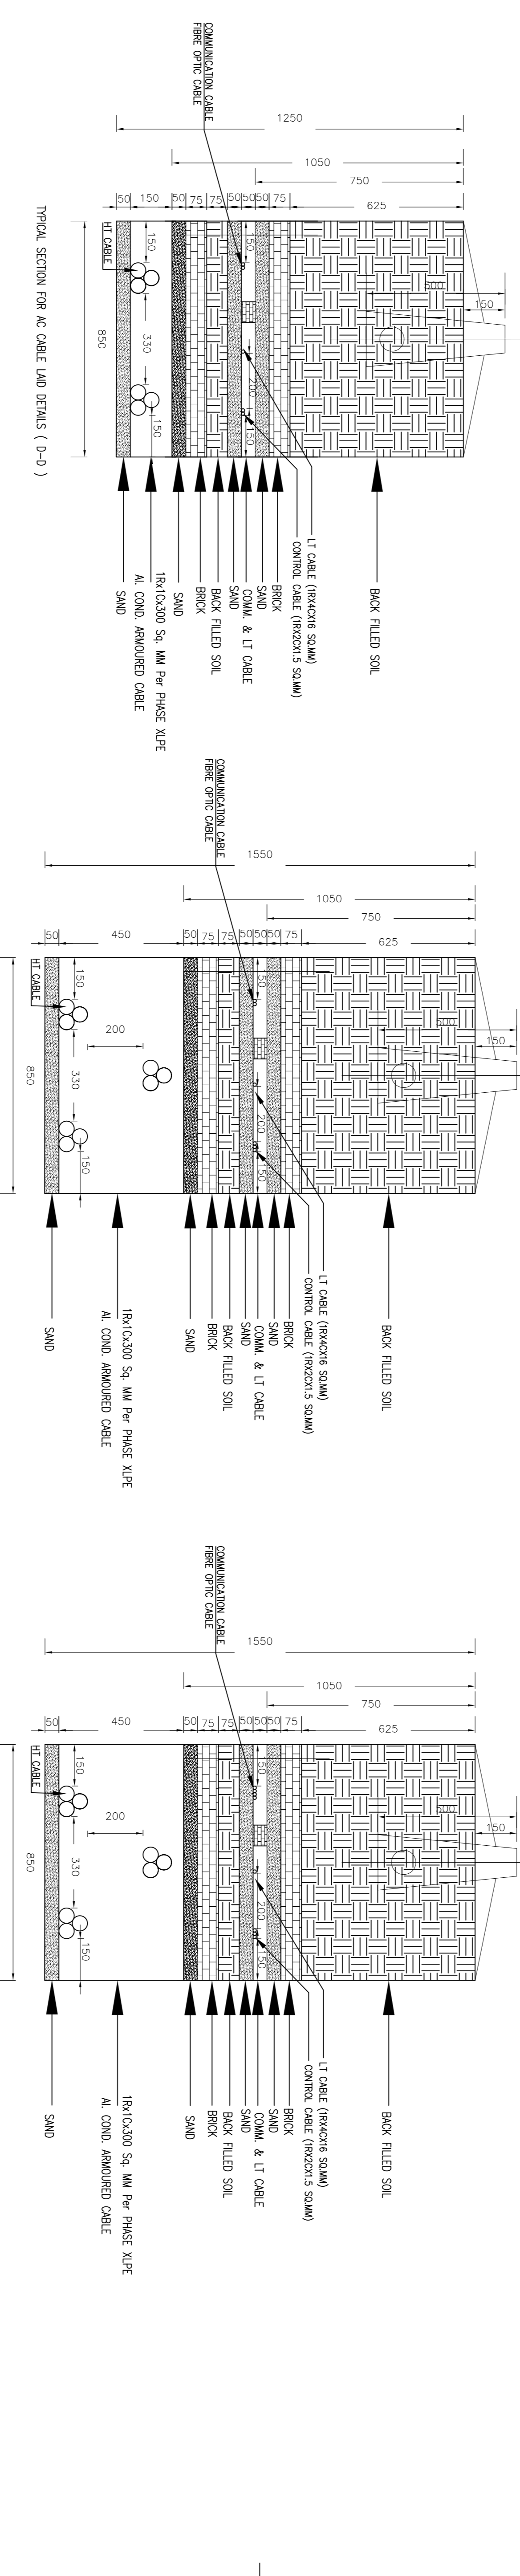


GENERAL DIMENSIONAL LIMITS, FITS & TOLERANCES AS PER HY0230261

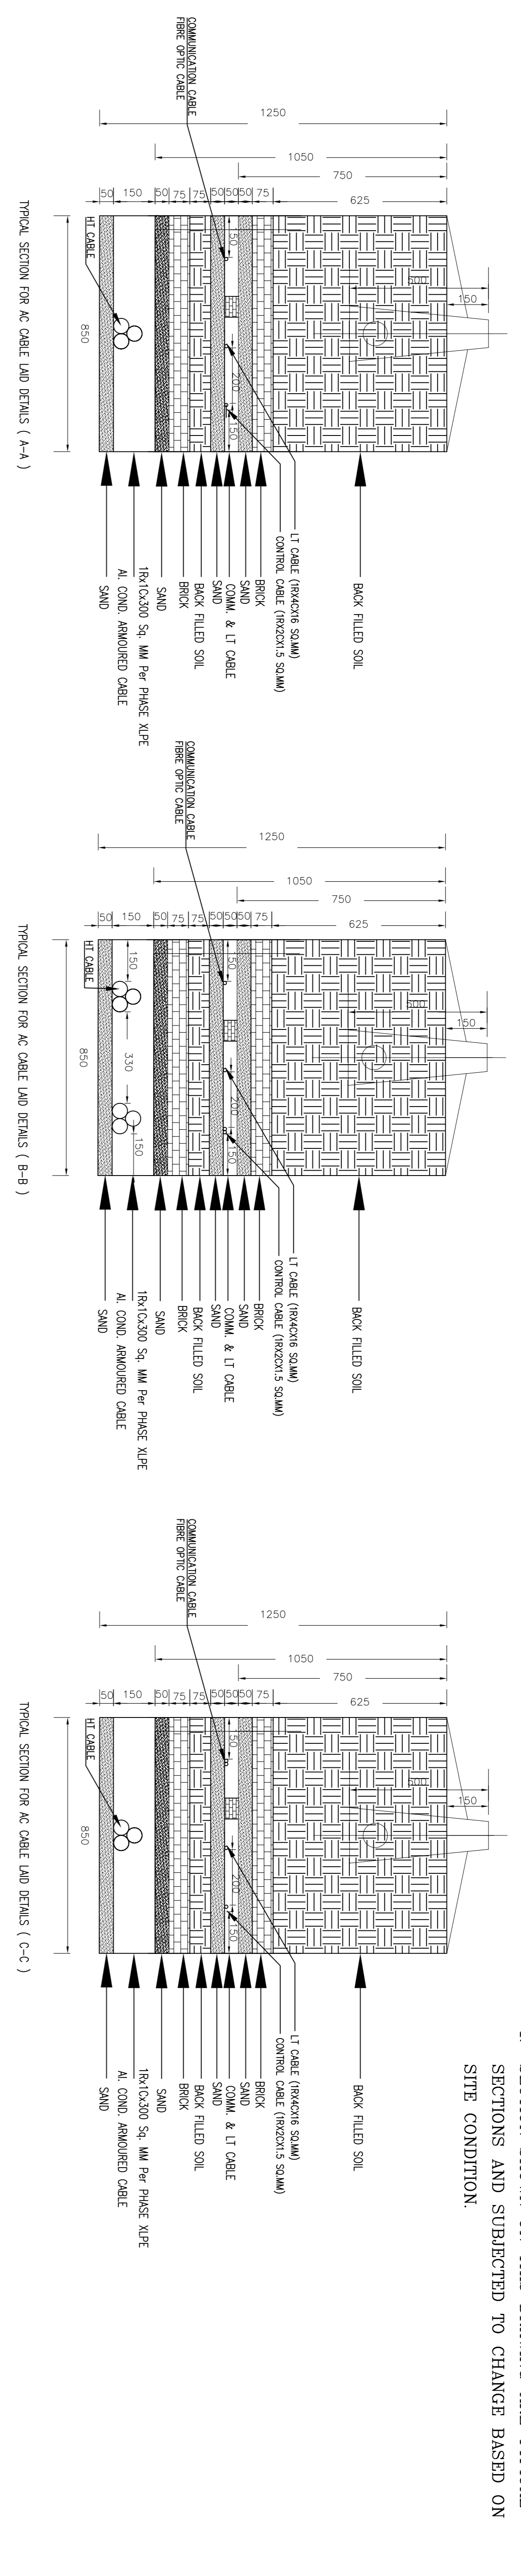

NOTE:
1. SECTIONS SHOWN ON THIS DRAWING ARE TYPICAL SECTIONS AND SUBJECT TO CHANGE BASED ON SITE CONDITION.

For Tender Purpose Only

REV.	DATE	ALTERED	REV.	DATE	ALTERED	REV.	DATE	ALTERED	REV.	DATE	ALTERED	REV.	DATE	ALTERED	REV.	DATE	ALTERED	REV.	DATE	ALTERED															
ZONE		CHD/APPD	ZONE		CHD/APPD	ZONE		CHD/APPD	ZONE		CHD/APPD	ZONE		CHD/APPD	ZONE		CHD/APPD	ZONE		CHD/APPD															
1			2			3			4			5			6			7			8			9			10			11			12		

65MWP SOLAR POWER PLANT

NEVEVELI LIGHTING CORPORATION LTD.

PROJECT :
CUSTOMER :
CONSULTANT :

BHARAT HEAVY ELECTRICALS LTD.
UNIT : PEASD-HYDERABAD
NEVEVELI-TAMILNADU

DEPT. :
FEASD
CODE :
450
TITLE :

UNTO. DMS. :
OR. :
P/N/Y :

SCALE :

WEIGHT (KG) REF. TO ASSY. DRG. :
APPD :
N.A.

DATE :
06.08.16
06.08.16
06.08.16
N.A.

NO. OF :
VAR :
ITEM NO. :
ITEMS :
N.A.
N.A.

REV. :
DRAWING NO. :
PY-12-1-M088-1260-02_00
SHT. No. 01 NO. OF SHT. 02