

ADDITIONAL INFORMATION W.C.N.O. R.A.S.T.O.				प्रकल्प/संविधानका नाम TAMILNADU GENERATION AND DISTRIBUTION CORPORATION (TANGEDCO)			
STATUS OF DRAWING DISTRIBUTION OF PRINTS				NAME OF CUSTOMER/PROJECT GREAT GUN AT 1 & 600 KM BOMBAY RISE SUPERCRITICAL THERMAL POWER PROJECT AT ASH DYE OF NCTP			
				NAME OF CONSULTANT DESSEIN PRIVATE LIMITED, NEW DELHI.			
				फारम डेरी इलेक्ट्रिकल्स लिमिटेड रणधन भार्गव कपडू BHARAT HEAVY ELECTRICALS LTD. TRANSMISSION BUSINESS GROUP			
REK. DATE ALTRD. DATE CHECKED APPROVED		REK. DATE ALTRD. DATE CHECKED APPROVED		REV. DATE ALTRD. DATE CHECKED APPROVED		REV. DATE ALTRD. DATE CHECKED APPROVED	
ZONE		ZONE		ZONE		ZONE	
REVISED INLINE WITH REV IN ELECTRICAL PLAN LAYOUT.				उपमान / SCALE १:१०० शेड कोड CODE			
				शीटसं./पृष्ठ NUMBER SHEETS/PAGES FOR STRUCTURE CONTROL ROOM (PLAT LAYOUT) FOR 400KV SWITCHYARD BOMBAY			
				शीटसं./पृष्ठ नं. ०१ SHEET NO. 01			
				ड्राइंग नं./DRAWING NO. 7B-07B-010-008			
				पृष्ठ सं./पृष्ठ नं. ०१ PAGE NO./PAGE NO. 01			

COPY RIGHT AND CONFIDENTIAL
The information on this document is the property of BHARAT HEAVY ELECTRICALS LIMITED
It must not be used directly or indirectly in anyway detrimental to the interest of the company.


COMPUTER DRG. PATH NAME :

REF. DRG. No.

SIGN & DATE

INVENTORY No.

FIRST ANGLE PROJECTION (ALL DIMENSIONS ARE IN MM.)

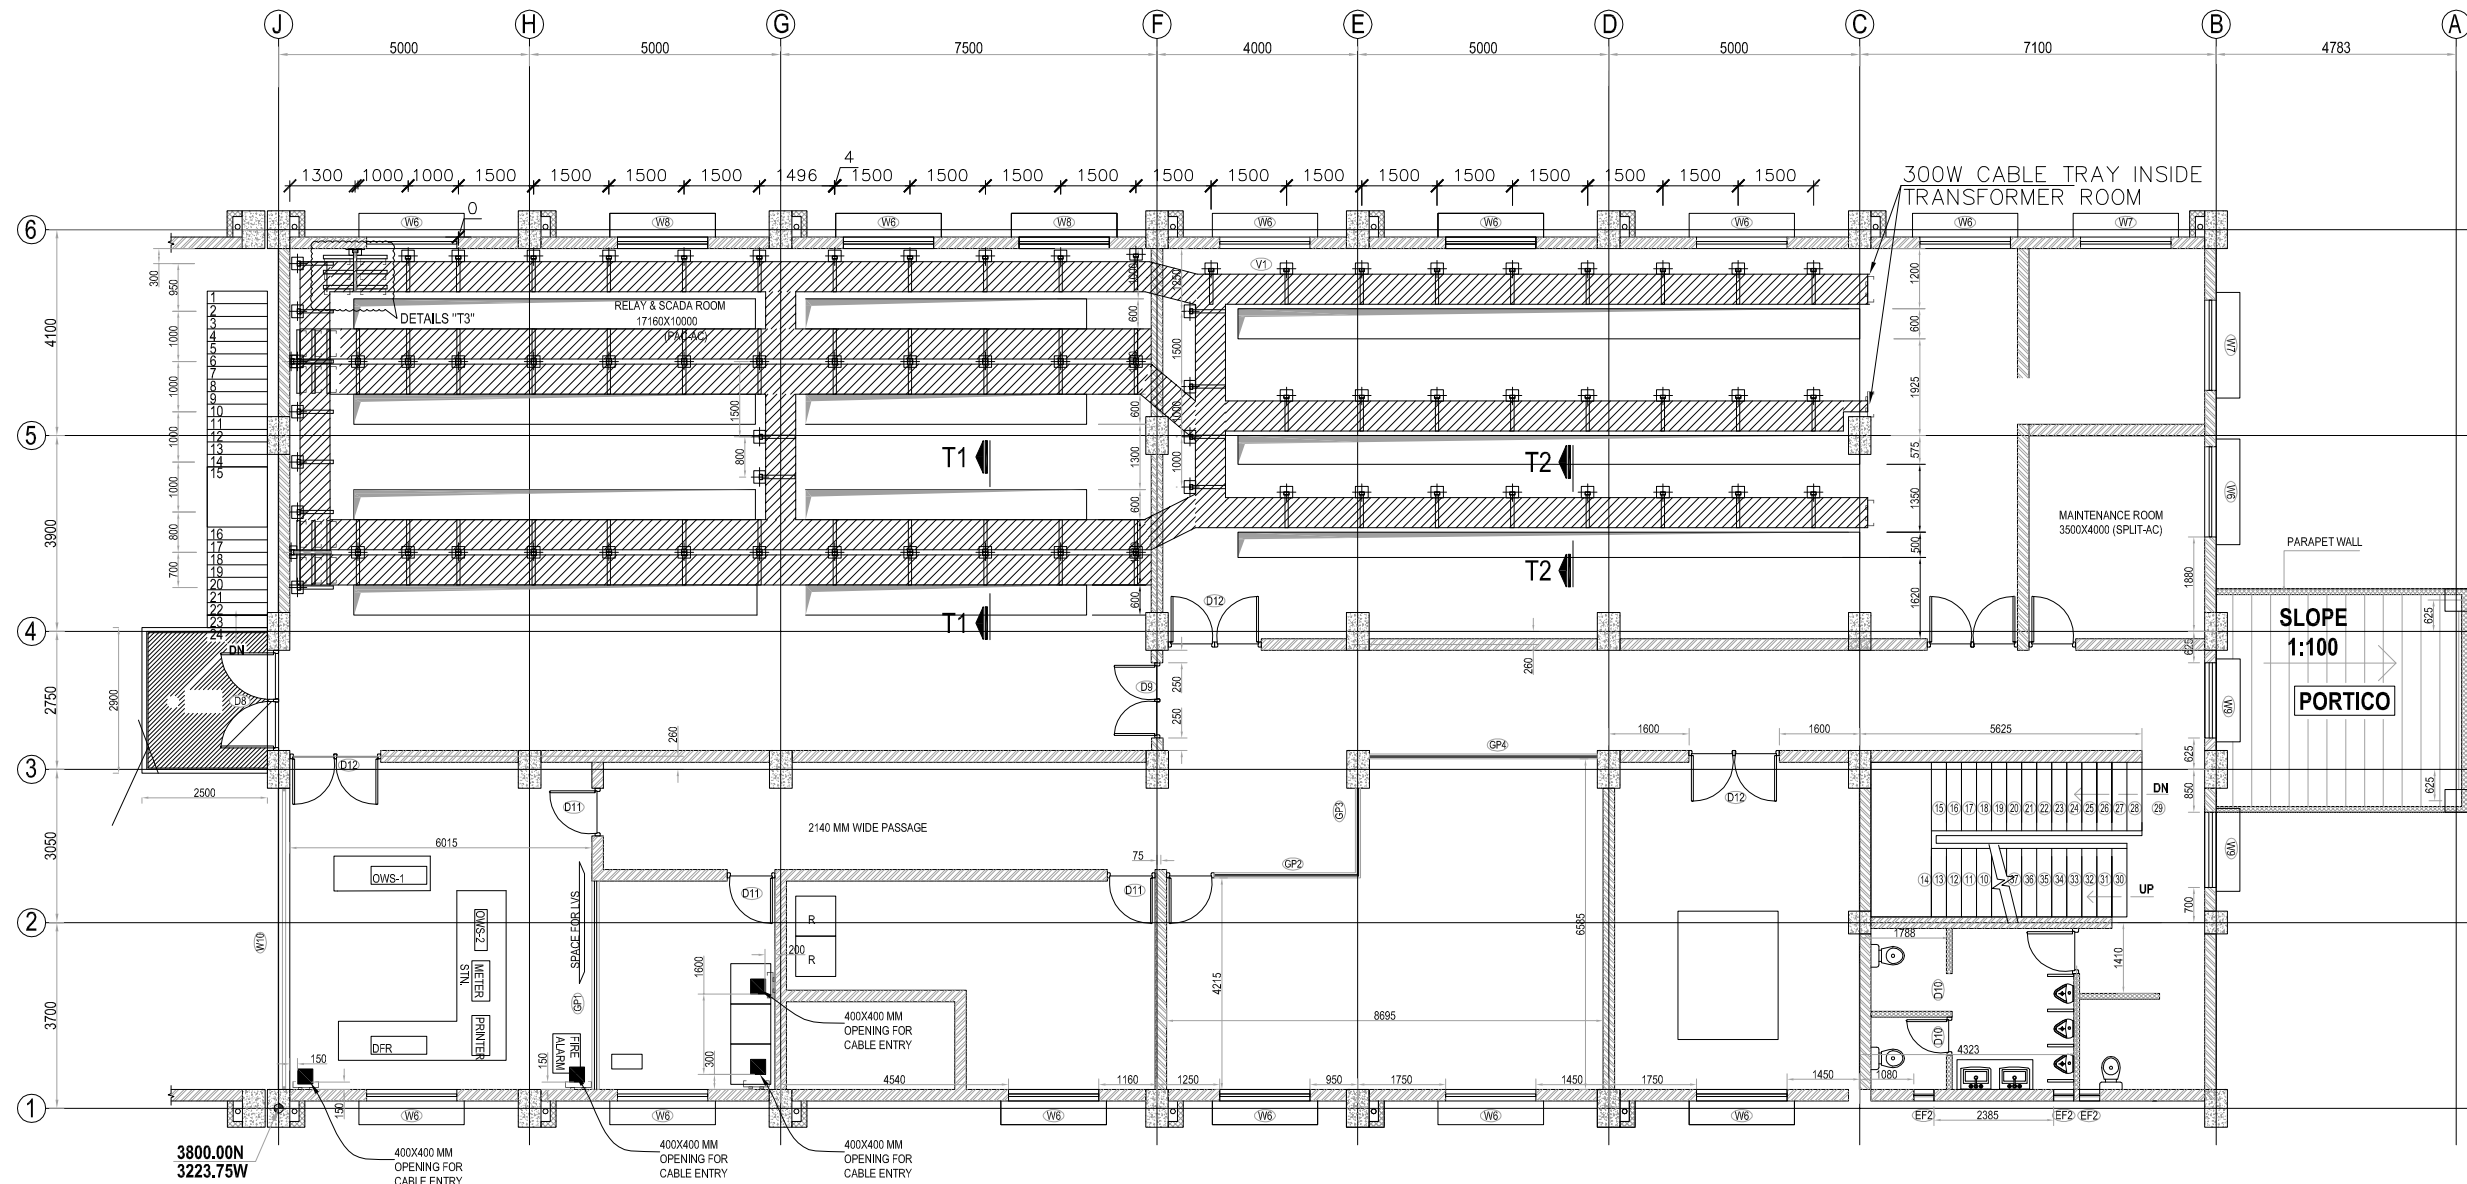

CABLE HANGER / TRAY MOUNTING ARRANGEMENT UNDER GROUND FLOOR ROOF SLAB

REV	DATE	APPROVED	DATE	APPROVED	DATE	APPROVED
01	10-10-17		02		03	

REV	DATE	APPROVED	DATE	APPROVED	DATE	APPROVED
01	10-10-17		02		03	

REV	DATE	APPROVED	DATE	APPROVED	DATE	APPROVED
01	10-10-17		02		03	

REV	DATE	APPROVED	DATE	APPROVED	DATE	APPROVED
01	10-10-17		02		03	

REV	DATE	APPROVED	DATE	APPROVED	DATE	APPROVED
01	10-10-17		02		03	

ADDITIONAL INFORMATION B.O.D. NO. 84807	NAME OF CUSTOMER/PROJECT TAMILNADU GENERATION AND DISTRIBUTION CORPORATION (TANGEDCO)
STATUS OF DRAWING STATUS OF PRINTS	NAME OF CONSULTANT DISESH PRIVATE LIMITED, NEW DELHI
DATE 10-10-17	SCALE 1:100
REVISIONS REV. NO. 01	DATE 10-10-17
REVISIONS REV. NO. 02	DATE 10-10-17
REVISIONS REV. NO. 03	DATE 10-10-17

