




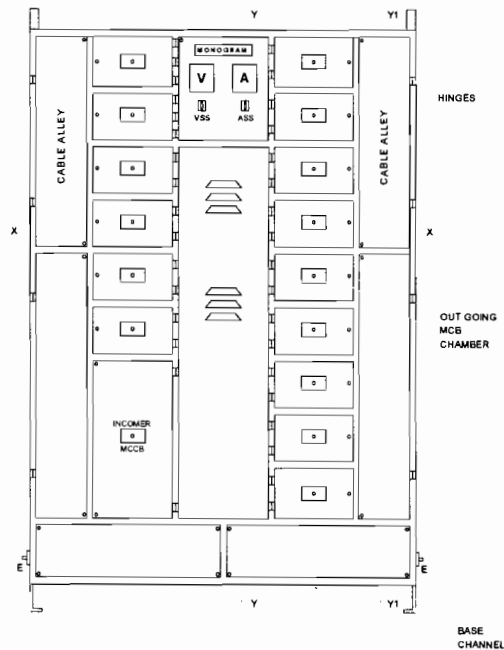


FRONT VIEW

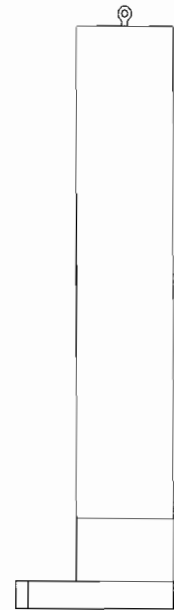

SIDE VIEW

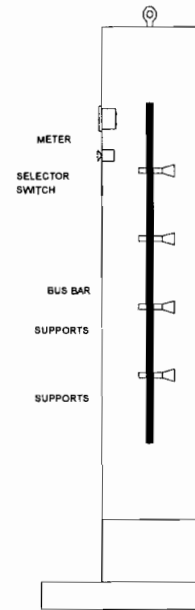


SECTIONAL VIEW Y-Y

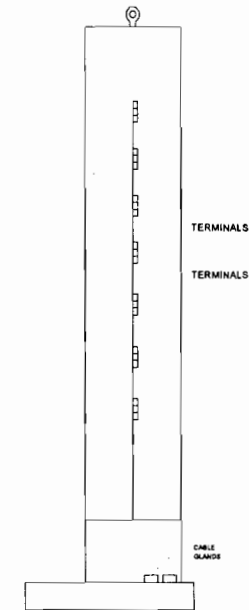


SECTIONAL VIEW Y1-Y1



BOTTOM VIEW

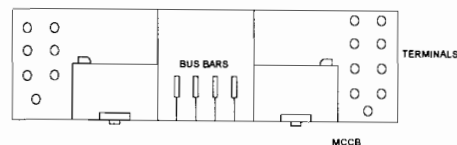


SECTIONAL VIEW X-X

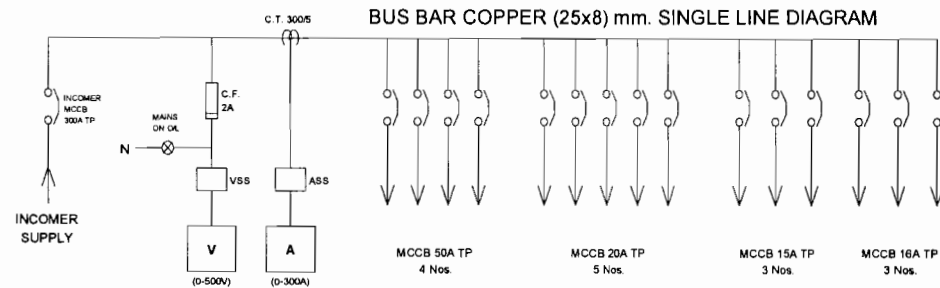

1. DIMENSION IN MM.
2. SCALE N.T.S.
3. SHEET THICKNESS 2.5 MM.
4. TOLERANCE $\pm 10\%$
5. COLOUR FINISH (EXTERIOR-LIGHT GREY) (INTERIOR-WHITE)
6. BASE CHANNEL-100x50 MM
7. BUS BAR-25x8 MM. EC GRADE COPPER
8. CABLE GLANDS SHALL BE PROVIDED AS PER SPECIFICATION

415 VOLTS A.C. DISTRIBUTION BOARD		NAME	DATE
G.A. DRAWING		DRAWN	
SINGLE LINE DIAGRAM		PREPARED	CAD-CELL
		CHECKED	
		APPROVED	
SCALE	OFFICE OF THE EXECUTIVE DIRECTOR IT&PI	DRAWING NUMBER	
N.T.S.	MADHYA PRADESH POWER TRANSMISSION CO. LTD. JABALPUR	JICA/MPPTCL/TR-101 TO 107/ GA 415V AC BOARD	

Annexure - 4

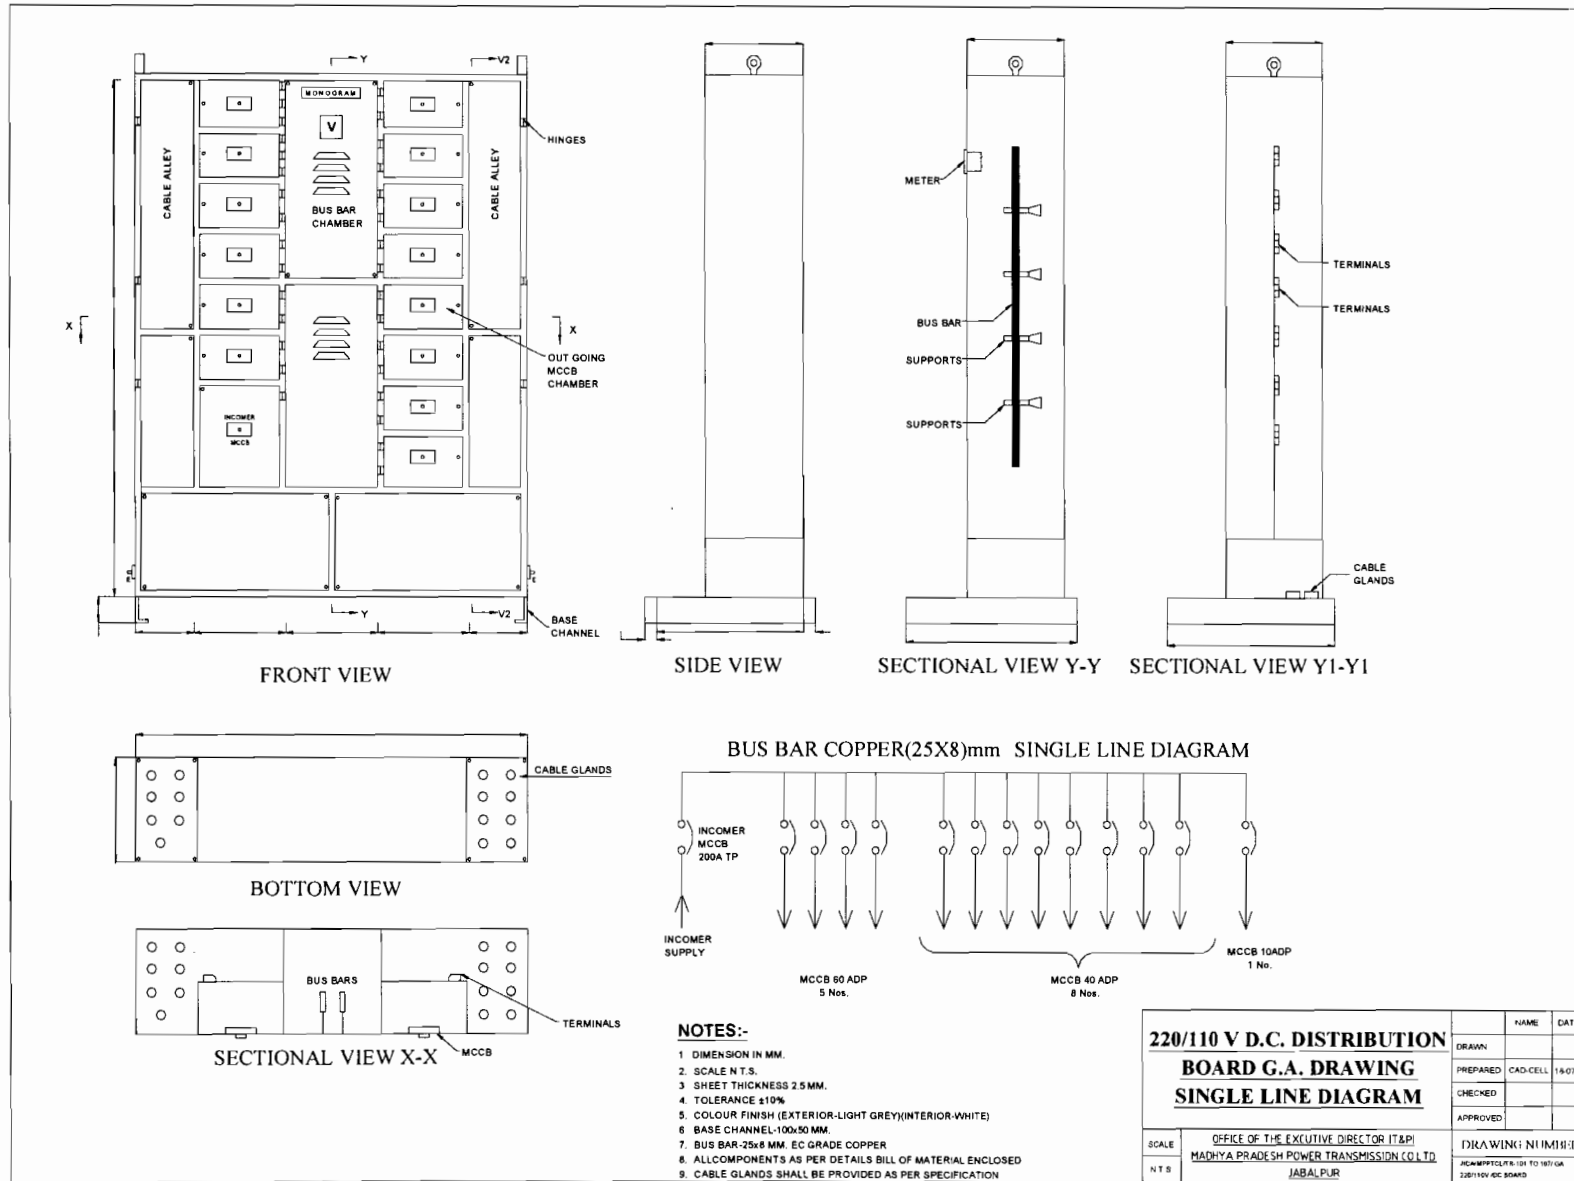

AC/DC Board / Junction Boxes

123

MPPTCL/TECH/PROC/10/JULY13

Vol.II Part-8/Section-II

Page 2 of 2