



Additional Control Building Ground floor plan

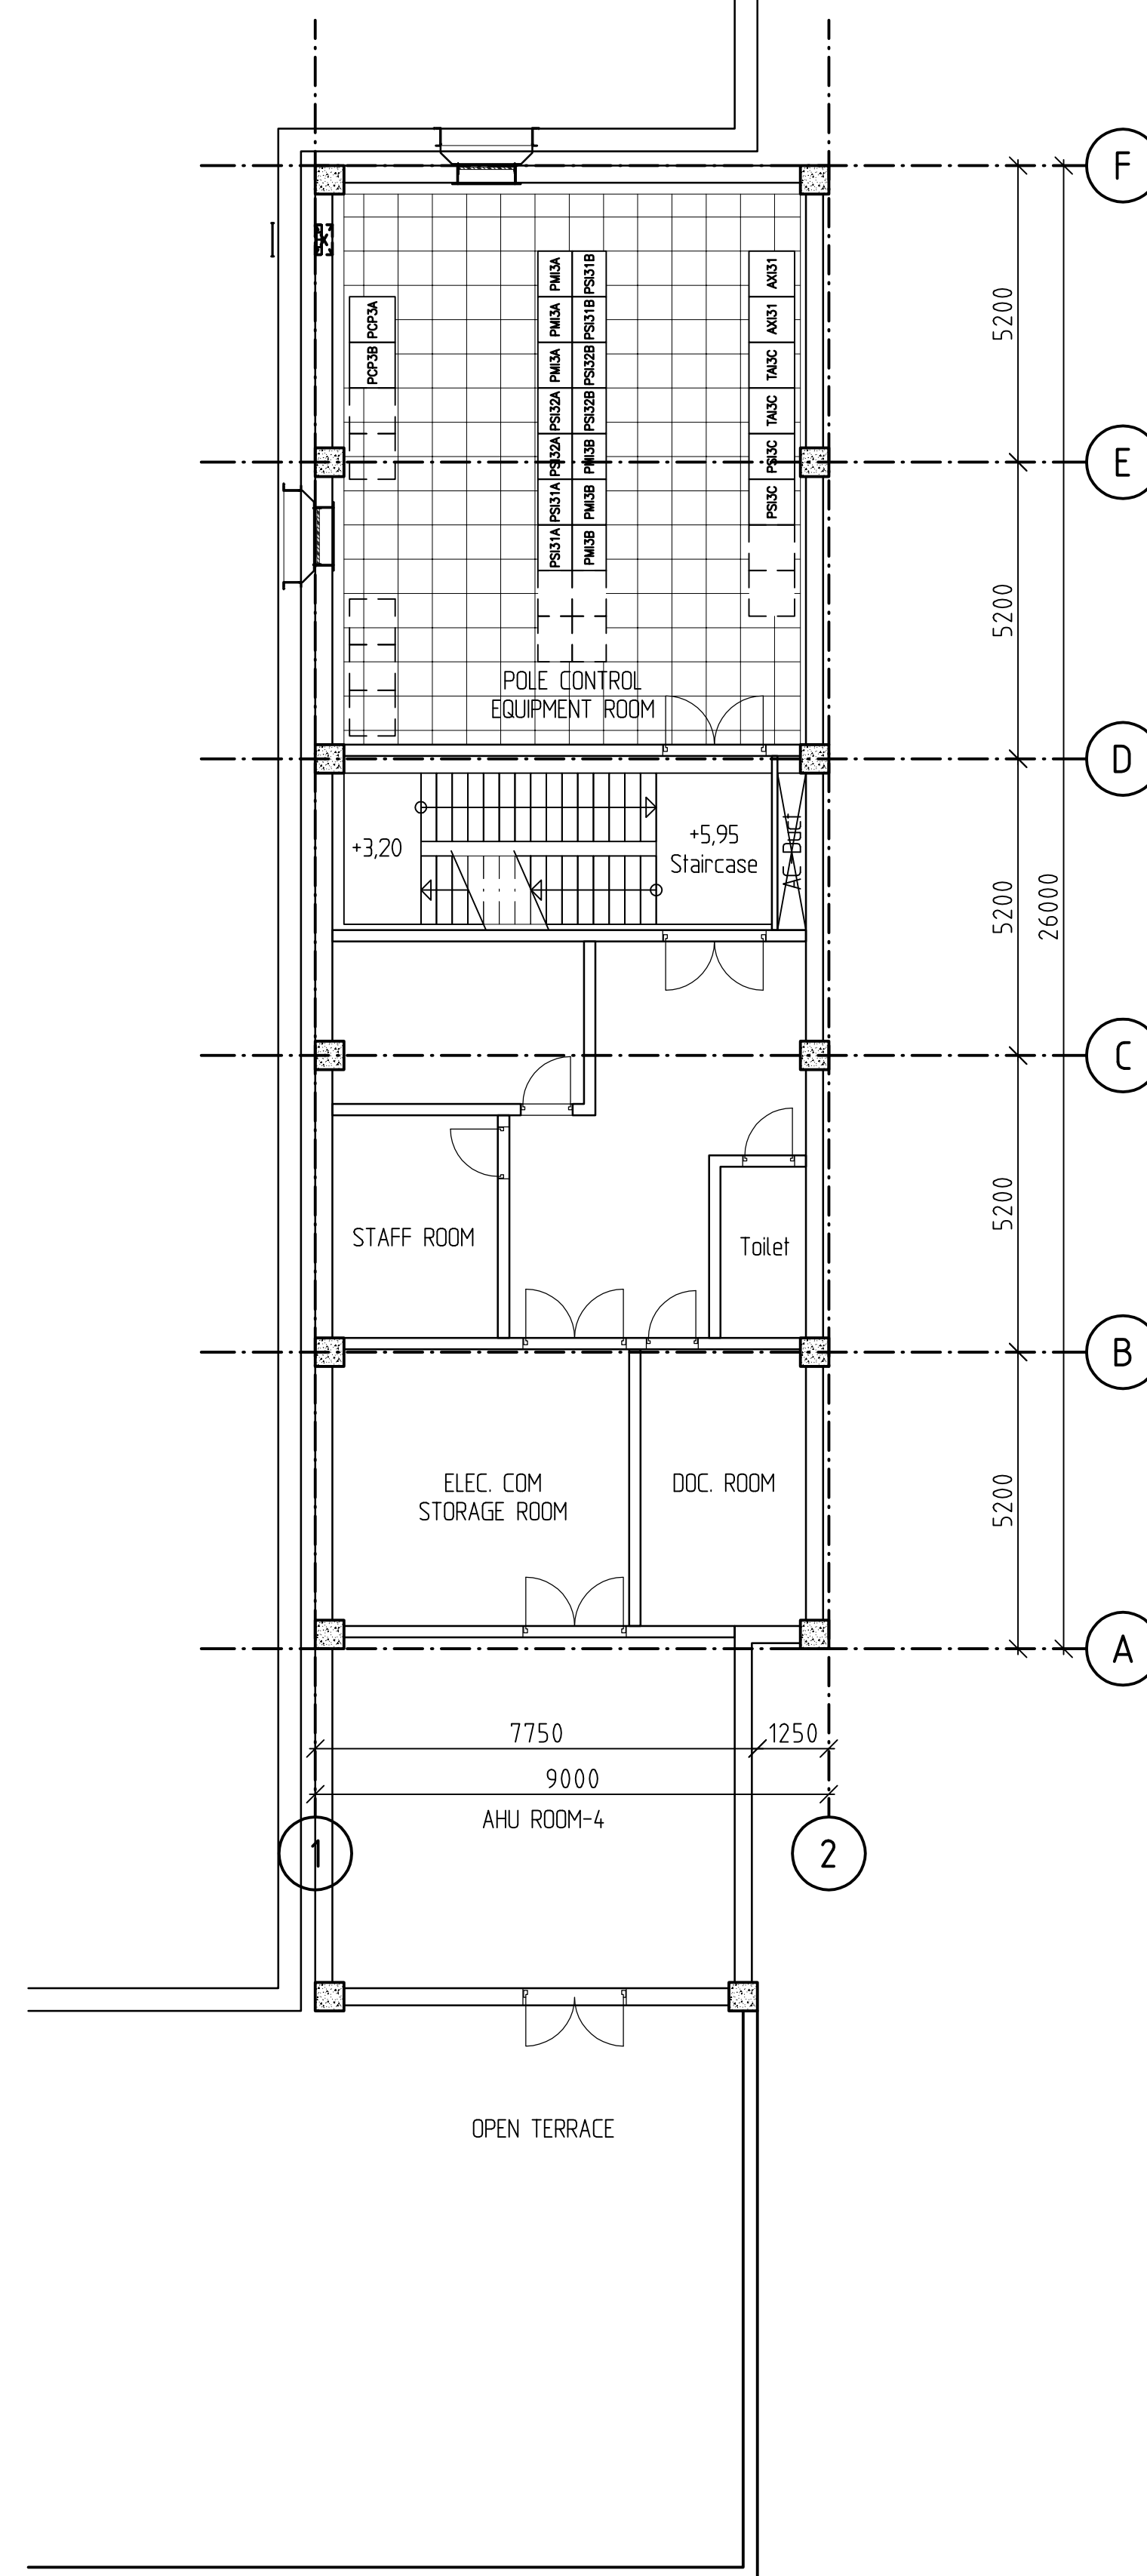

Additional Control Building First floor plan

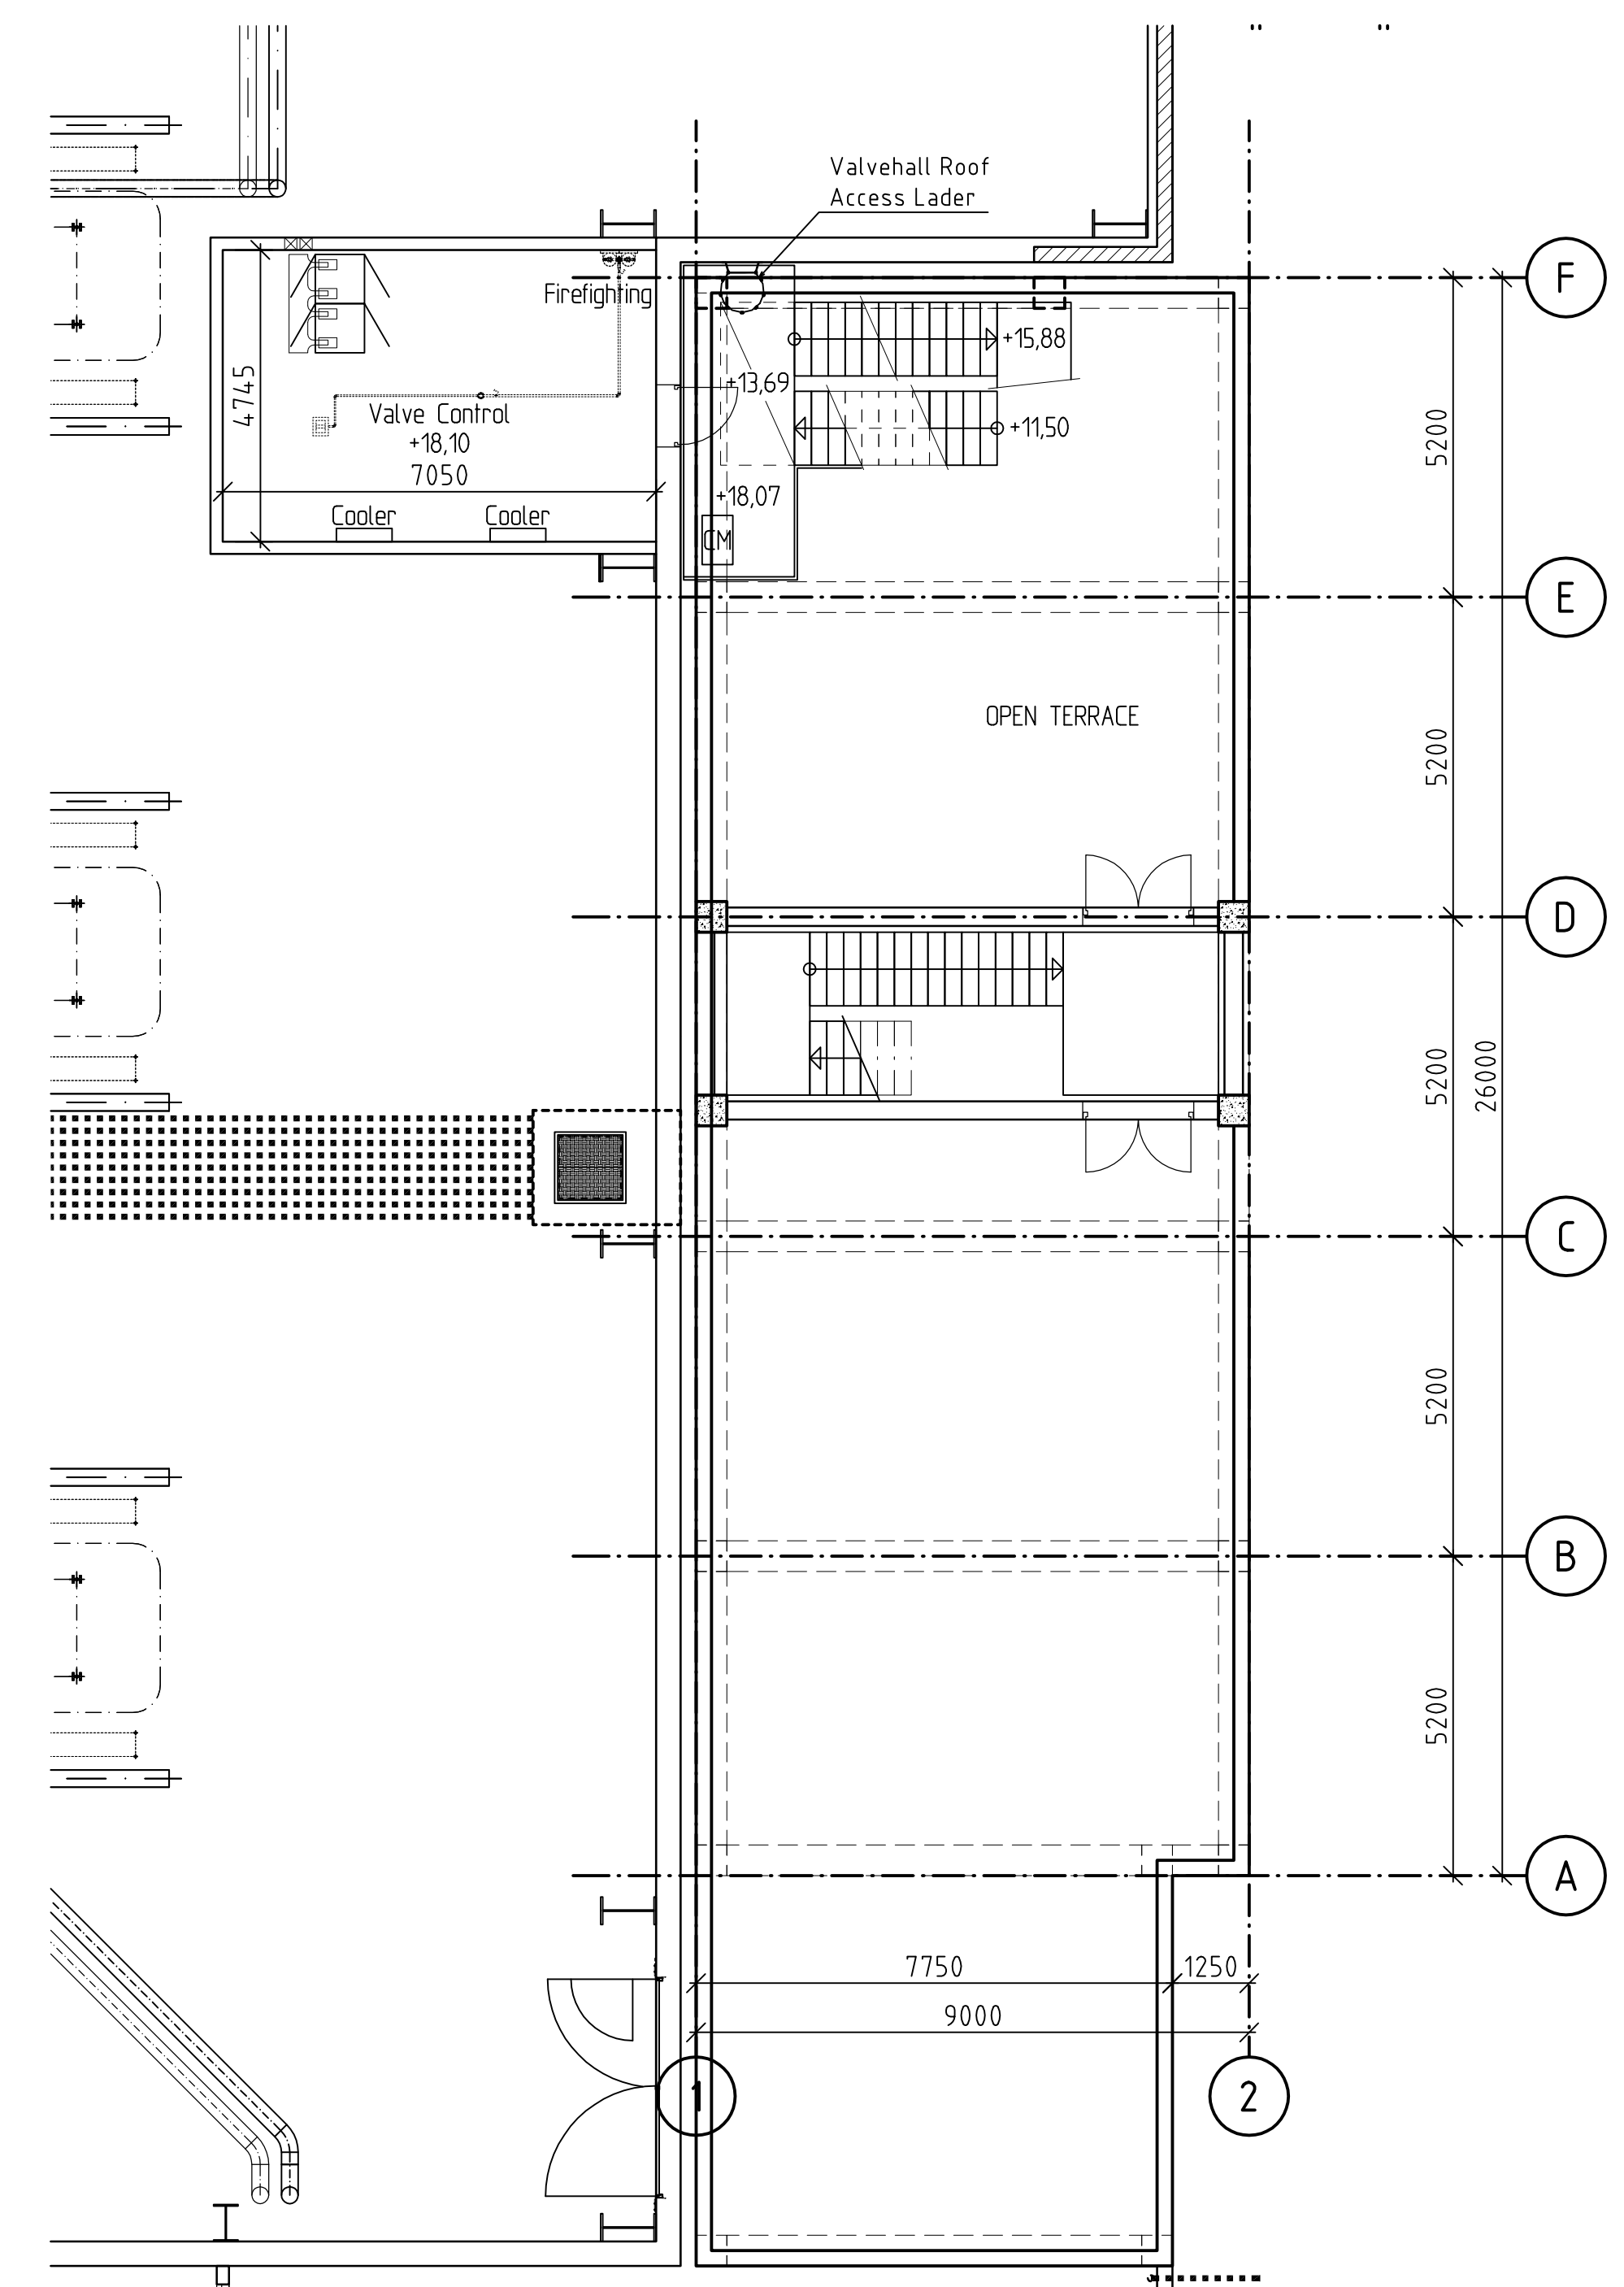

Additional Control Building Roof plan

FOR TENDER PURPOSE ONLY

ADVANCE COPY 2012-04-23

PRELIMINARY DESIGN INPUT

POWER GRID CORPORATION OF INDIA LIMITED
(A government of India Enterprise)

±800 kV 6000 MW HVDC Multi Terminal
NER/ER - NR/WR Interconnector-I



ABB AB
S-721 80 LUDVICA, Sweden
Telephone: +46 240 782000



BHARAT HEAVY ELECTRICALS LTD.
TRANSMISSION PROJECTS DIVISION

Civil and Building Works incl EL and Mech. Services.

Kadesjö
INGENJÖRSBYRÅ AB
P.O. Box 1013
S-721 26 VÄSTERÅS, SWEDEN
Telephone: +46 21 155800
Telefax: +46 21 181190
E-mail: kadesjos@kadesjos.se

AGRA
CONVERTER STATION

ADDITIONAL SERVICE BUILDING - POLE 3
GENERAL BUILDING LAYOUT, ALTERNATIVE

Date	Drawn by	Checked by	Scale (A1-Print)	Drawing No.	Rev
2012-04-02	P. Ericson	A.D.	1:100	5517- 3-31-340	-

0 50 100 mm

THIS MEASUREMENT IS 100 mm ON ORIGINAL DRAWING
IF NOT 100 mm ON THIS COPY, ADJUST SCALES ACCORDINGLY.

Rev.ind Revision Year Week Appd.

J:\01-New Projects\551700-NEA-800\Winng\3-Agra\3-31-340.dwg