


FIRST ANGLE PROJECTION ( ALL DIMENSIONS ARE IN MM. )

DRAWING No. TB-408-510-S01

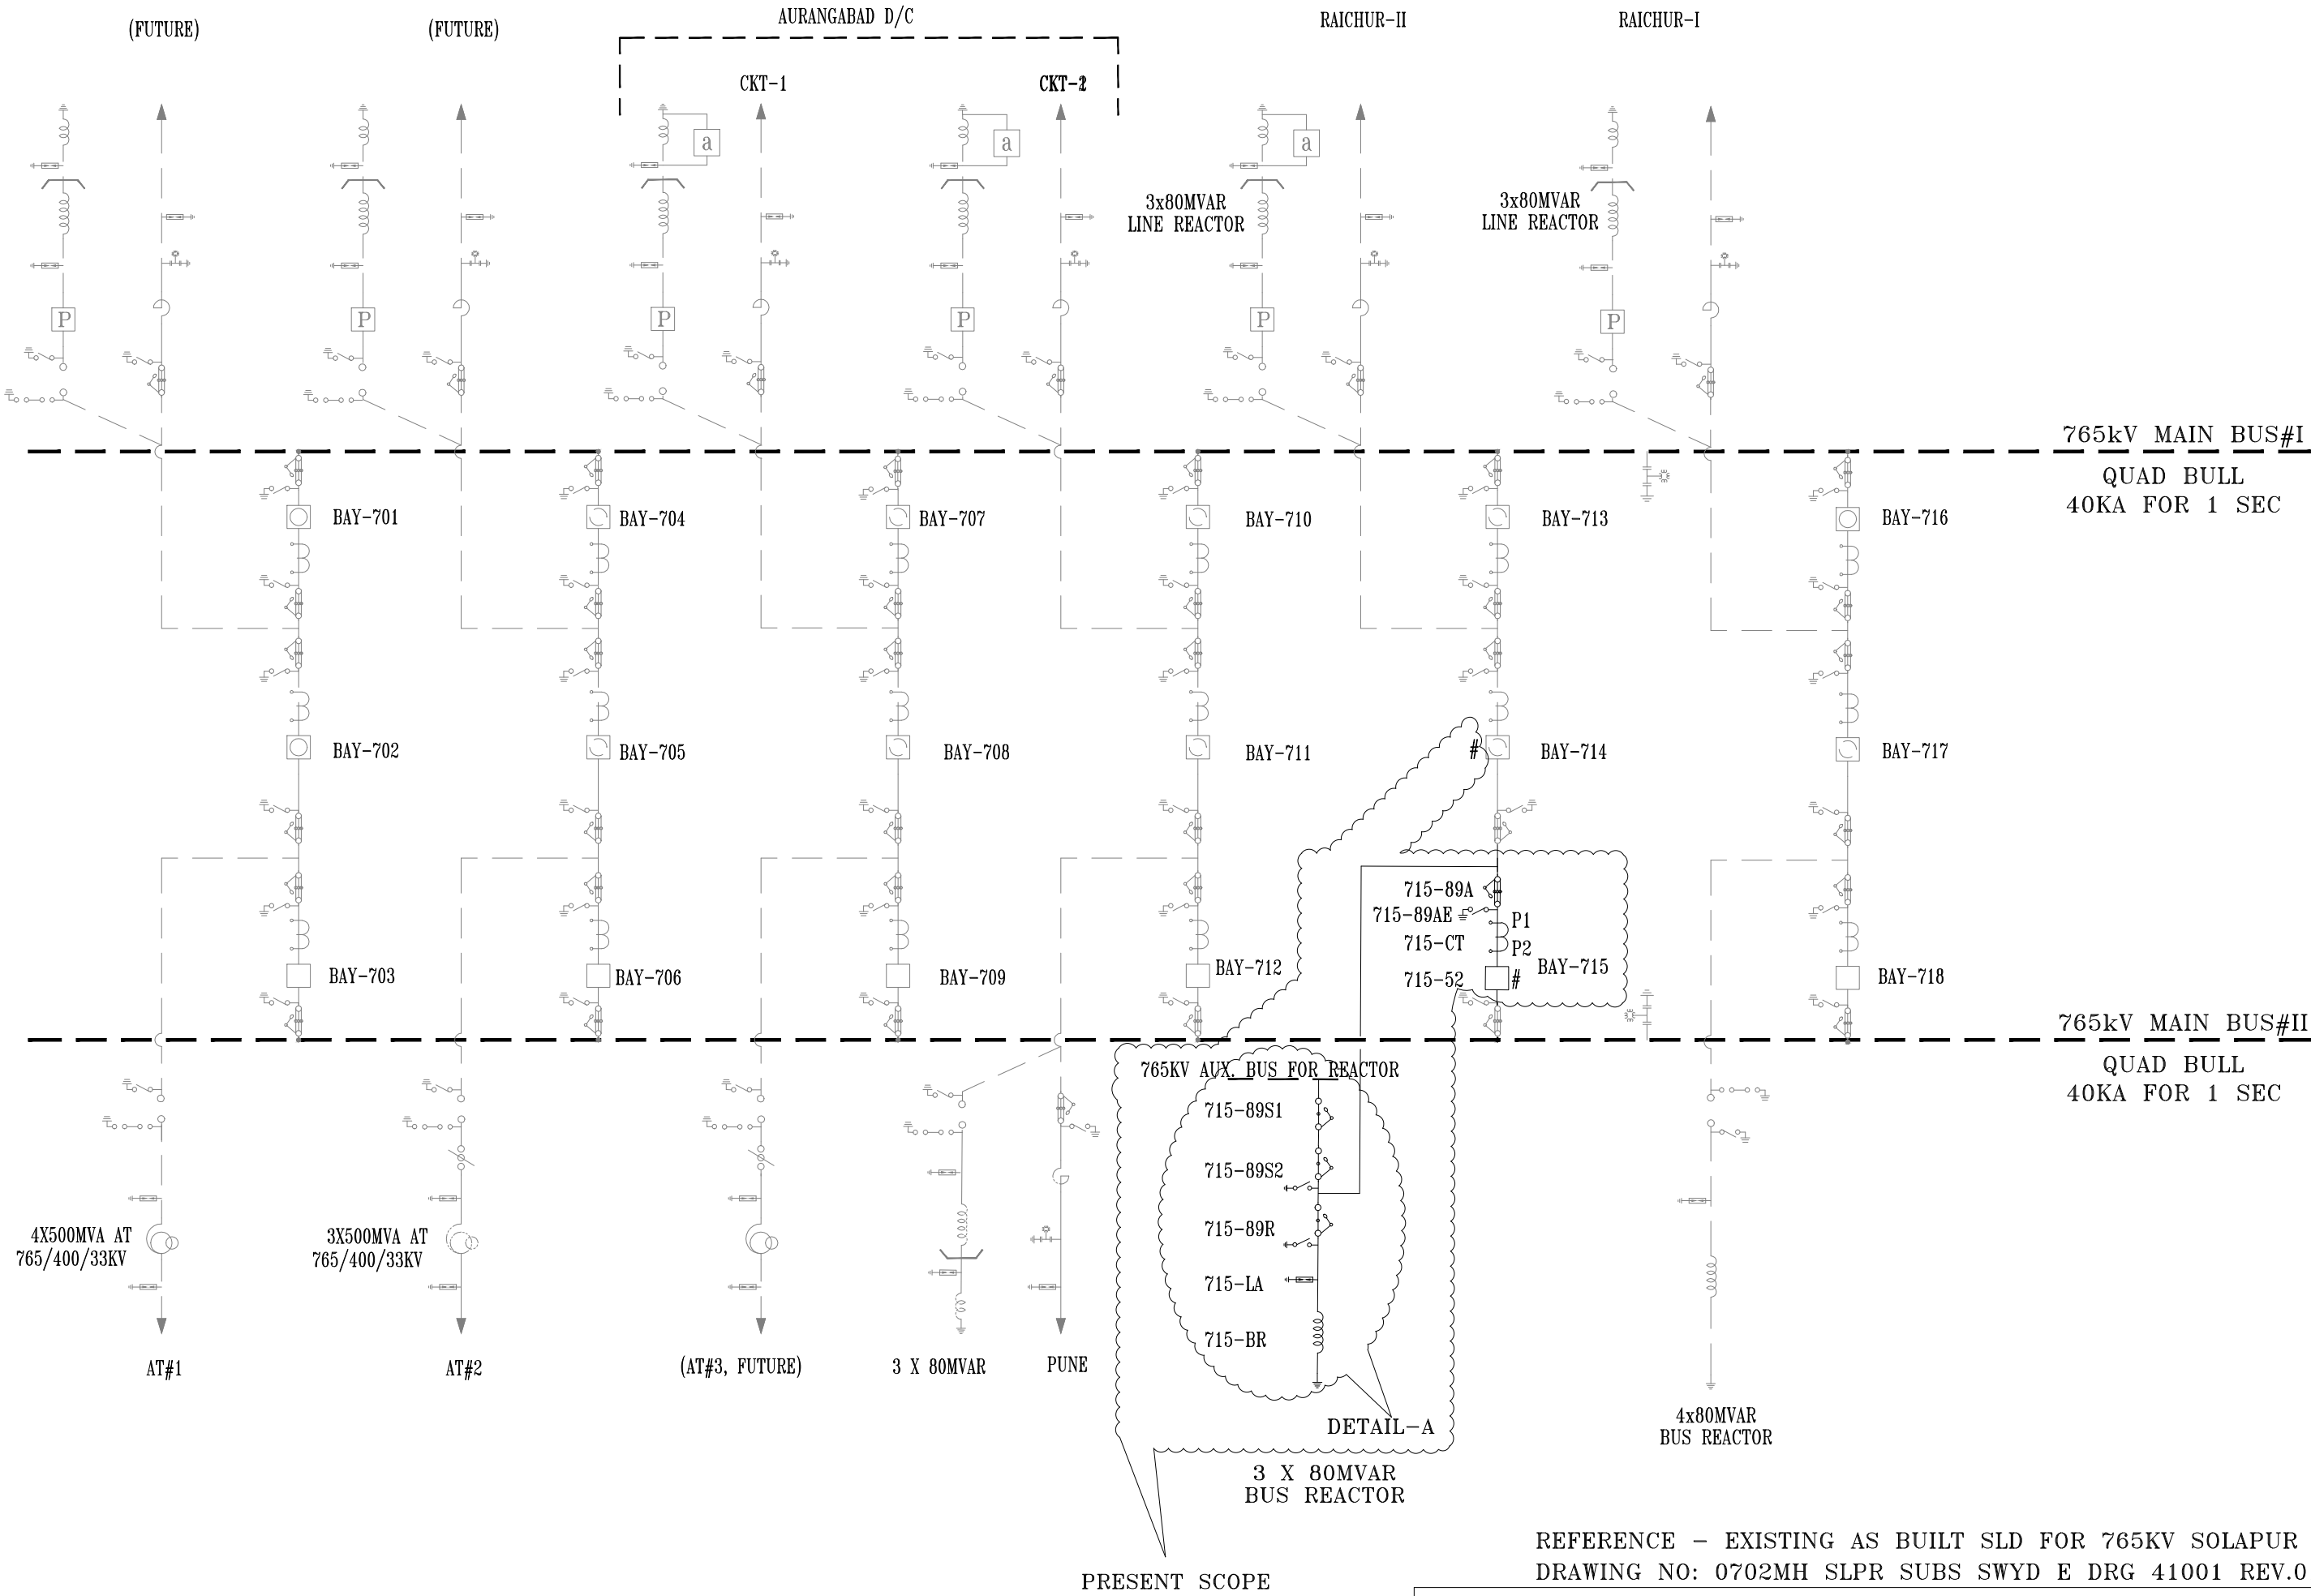


REFERENCE - EXISTING AS BUILT SLD FOR 765KV SOLAPUR S/S,  
DRAWING NO: 0702MH SLPR SUBS SWYD E DRG 41001 REV.01 SHEET 1 OF 2

NOA NO. : CC-CS/901-WR2/SS-3931/3/G3/NOA-I/8864 & 8865 DT. 29.07.19

ADDITIONAL INFORMATION W.O.No. 119TB00001		ग्राहक/परियोजना का नाम POWER GRID CORPORATION OF INDIA LIMITED	
STATUS OF DRAWING CONTRACT		NAME OF CUSTOMER/PROJECT Substation Package-SS19 for extension of (i) 765kV Solapur S/S; (ii) 765kV Aurangabad S/S; (iii) 765kV Wardha S/S; (iv) 400kV Khandwa S/S; (v) 400kV Rajgarh S/S; (vi) 400kV Champa S/S; (vii) 400/220kV Itarsi S/S & (viii) 400/220kV Jabalpur Substation under WRSS-20.	
DISTRIBUTION OF PRINTS		<div>बीएचईएल</div> <div>भारत हेवी इलेक्ट्रिकल्स लिमिटेड</div> <div>दूरसंचालन परियोजना विभाग</div> <div>BHARAT HEAVY ELECTRICALS LTD.</div> <div>TRANSMISSION PROJECTS DIVISION</div>	
REV.	DATE	ALTERED CHECKED APPROVED	विभाग TBEM DEPT. कोड 422 CODE
ZONE			अनुपात / SCALE NTS कॉड कोड CARD CODE
शीर्षक/TITLE		SINGLE LINE DIAGRAM FOR EXTN. OF 765KV SOLAPUR SUBSTATION	
डाईग.कं./DRAWING NO.		TB-408-510-S01	
पृष्ठ कं./SHEET No.01		अगला पृष्ठ/NEXT SHEET 02	
पुनः/REV.		00	

EQUIPMENT IDENTIFICATION:-

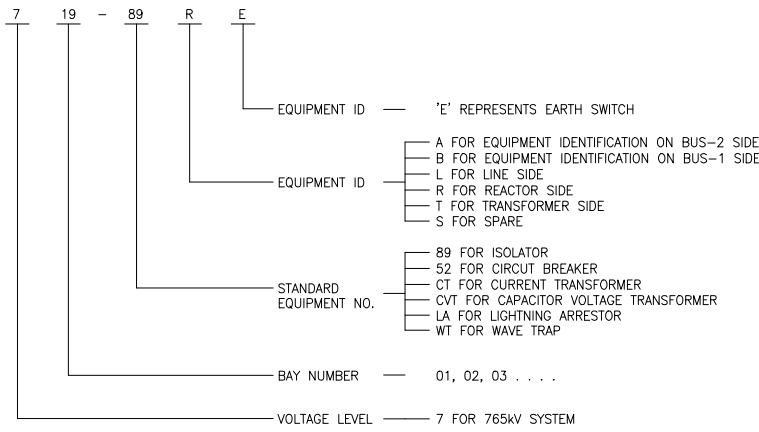

LEGENDS:-

— — — — — PRESENT SCOPE  
- - - - - EXISTING / FUTURE



[illegible]