




FORM-66.101

OWNER:		TELANGANA STATE POWER GENERATION CORPORATION LTD.					
		HYDERABAD – TELANGANA, INDIA					
CUSTOMER'S CONSULTANT:		DEVELOPMENT CONSULTANTS PVT. LTD.					
		CONSULTING ENGINEERS					
PROJECT :		KOLKATA . MUMBAI . CHENNAI . NEW DELHI					
		KOTHAGUDEM THERMAL POWER STATION					
		STAGE-VII, UNIT # 12 (1X800 MW), KOTHAGUDEM, TELANGANA, INDIA					
		COAL HANDLING SYSTEM PACKAGE					
EPC CONTRACTOR		BHARAT HEAVY ELECTRICALS LIMITED					
		INDUSTRIAL SYSTEMS GROUP					
		ISG-BANGALORE					
BHEL'S CONTRACTOR							
			NAME	SIGN	DATE	REV	
		DRN.	PVN		16.10.15	00	
		CHD	SSD		16.10.15	NO	
		APP	RSP		16.10.15	OF	
						VAR	
TITLE :		GA of BC#6A/6B				07	
						01	
SCALE		BHEL JOB NO	IS-1-14-2006	BHEL/ISG DRG. NO.	IS-1-GA-690-101-M012	REV	
						01	

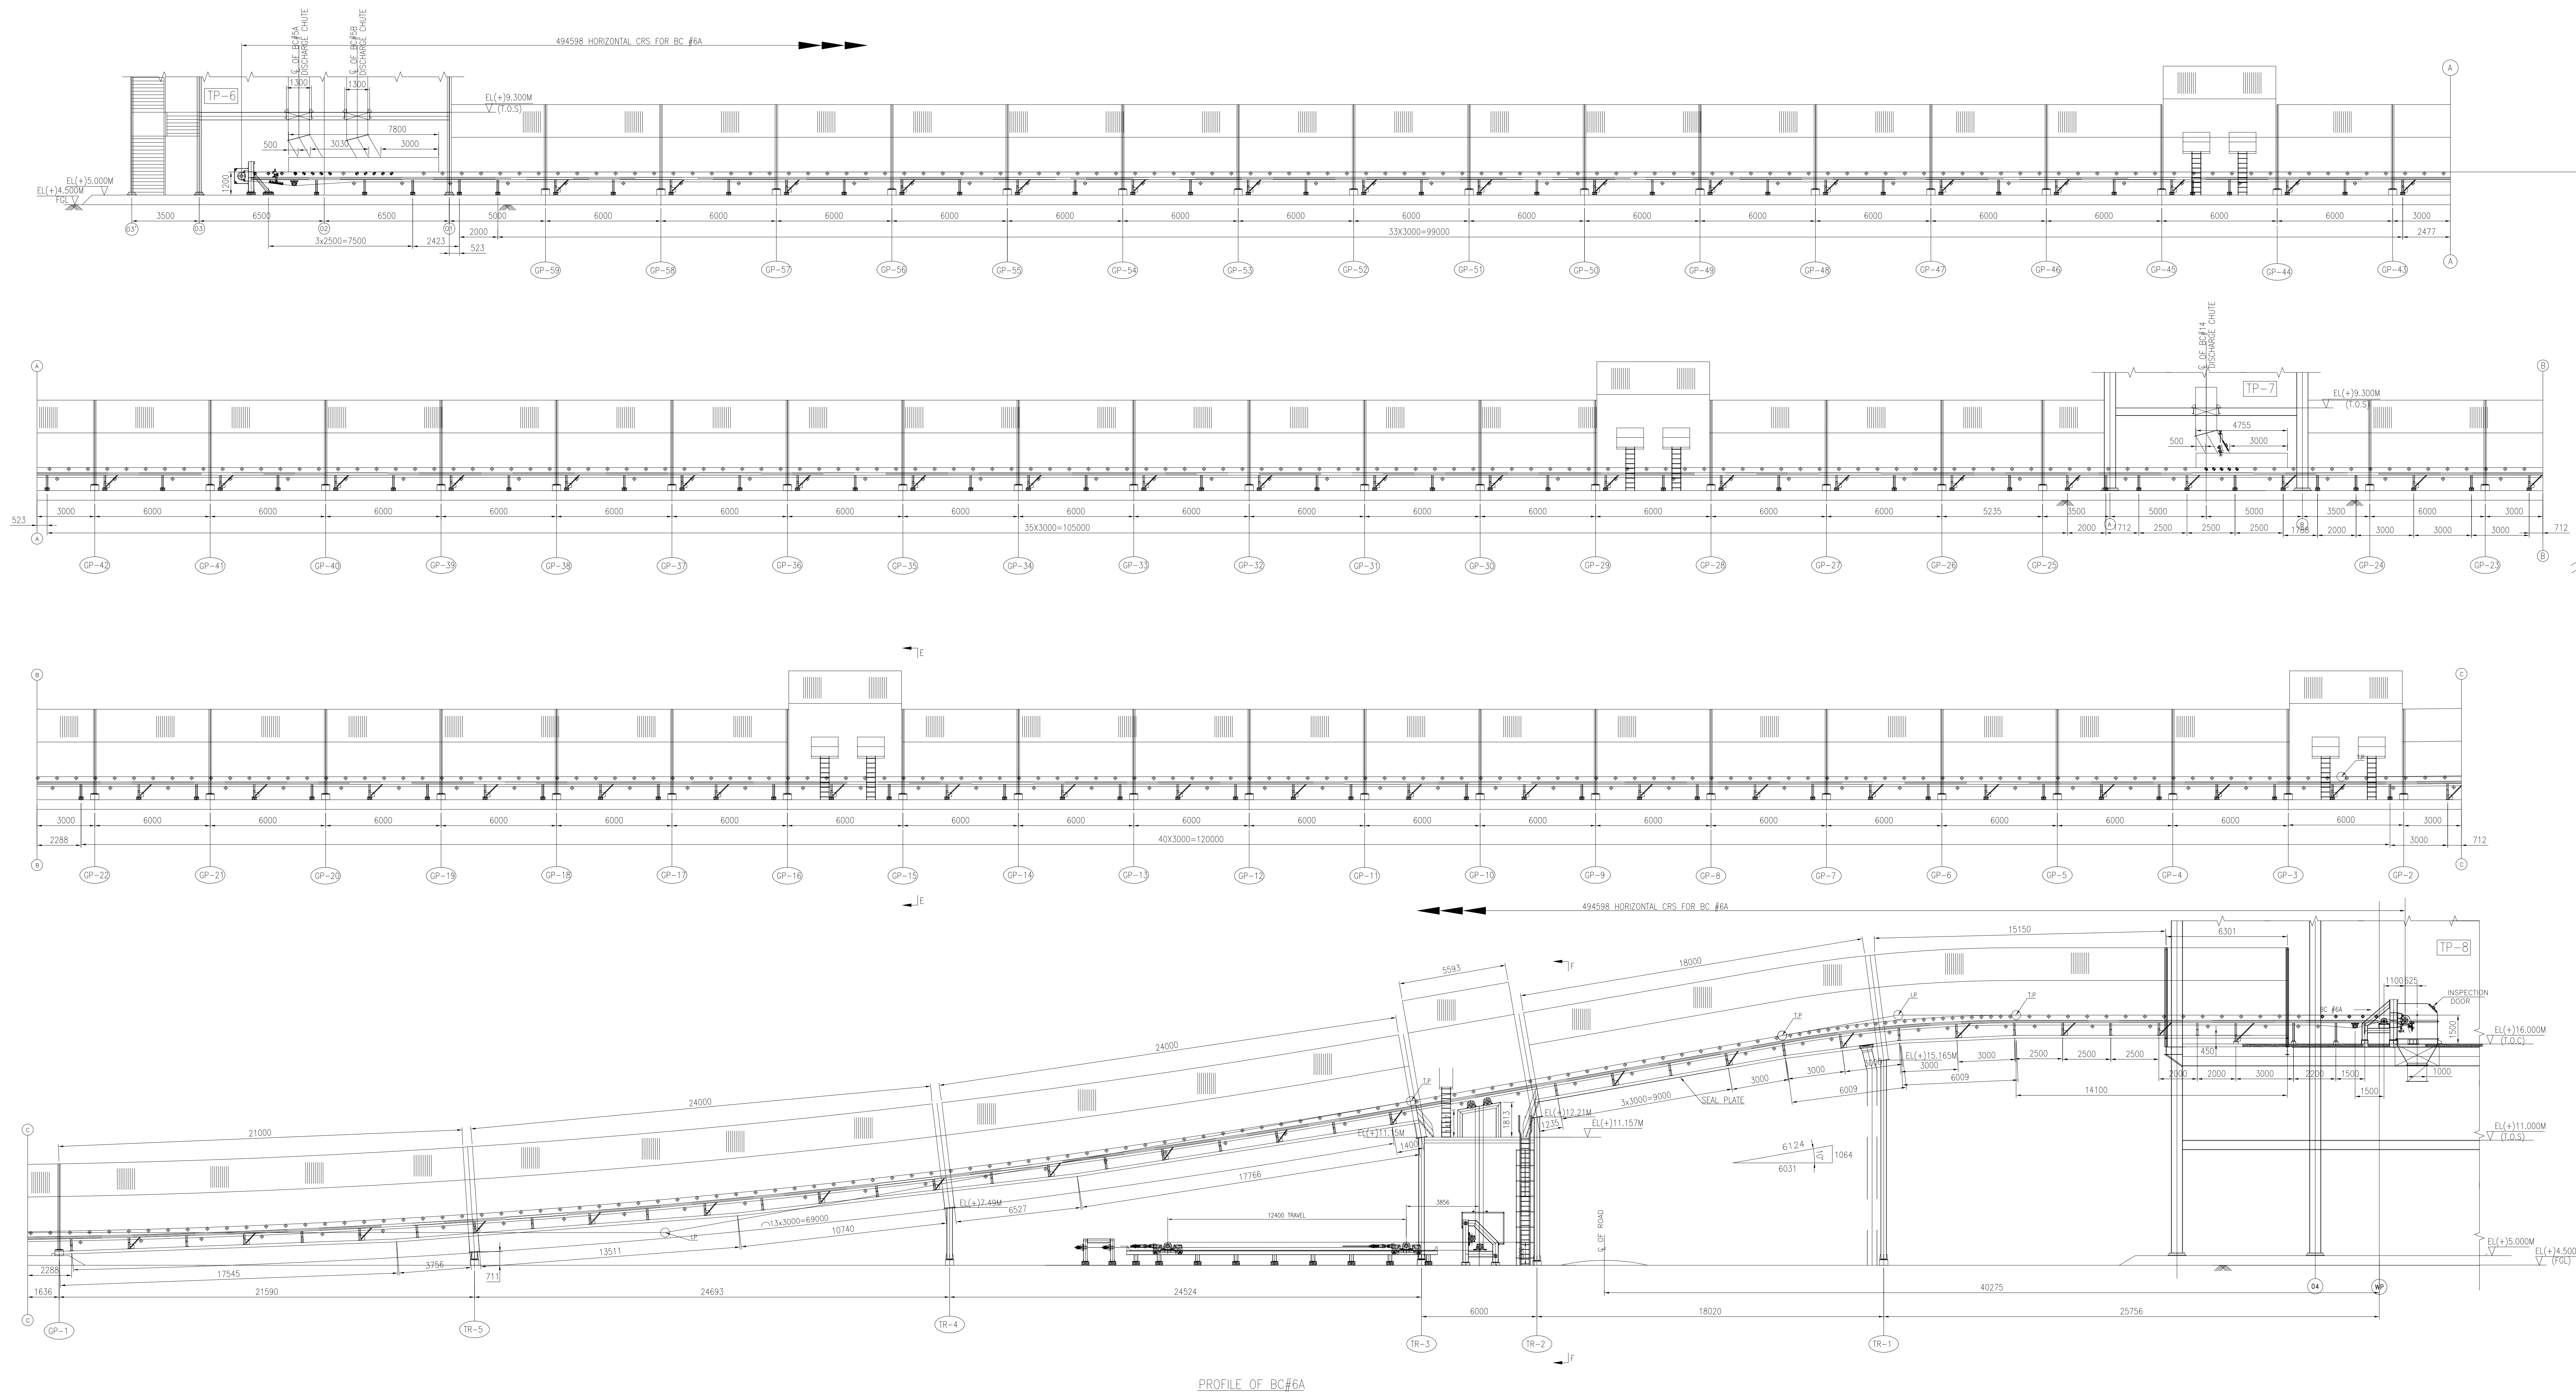

COPYRIGHT AND CONFIDENTIAL

The information on this document is the property of BHARAT HEAVY ELECTRICALS LIMITED
It must not be used in any way detrimental to the interest of the Company.

REF.DRG.NO.


SIGN & DATE

ENTORY NO.

0		FOR APPROVAL		
R.No:	DATE	BRIEF RECORD	BY	APP
		REVISIONS		
		9		

OWNER:	TELANGANA STATE POWER GENERATION CORPORATION LTD.					
	HYDERABAD – TELANGANA, INDIA					
CUSTOMER'S CONSULTANT	DEVELOPMENT CONSULTANTS PVT. LTD. CONSULTING ENGINEERS KOLKATA , MUMBAI , CHENNAI , NEW DELHI					
PROJECT :	KOTHAGUDEM THERMAL POWER STATION STAGE-VII, UNIT # 12 (1x800 MW), KOTHAGUDEM, TELANGANA, INDIA COAL HANDLING SYSTEM PACKAGE					
EPC CONTRACTOR	BHARAT HEAVY ELECTRICALS LIMITED INDUSTRIAL SYSTEMS GROUP ISG-BANGALORE					
BHEL'S CONTRACTOR			NAME	SIGN	DATE	REV
		DRN	PVN		16.10.15	00
		CHD	SSD		16.10.15	NO OF
		APP	RSP		16.10.15	VAR
	TITLE : GA of BC#6A/6B					07
						02
SCALE	BHEL JOB NO. IS-14-2006	BHEL-ISG DRG. NO.	IS-1-GA-690-101-M012			REV
						01

DO NOT SCALE. IF IN DOUBT, ASK.

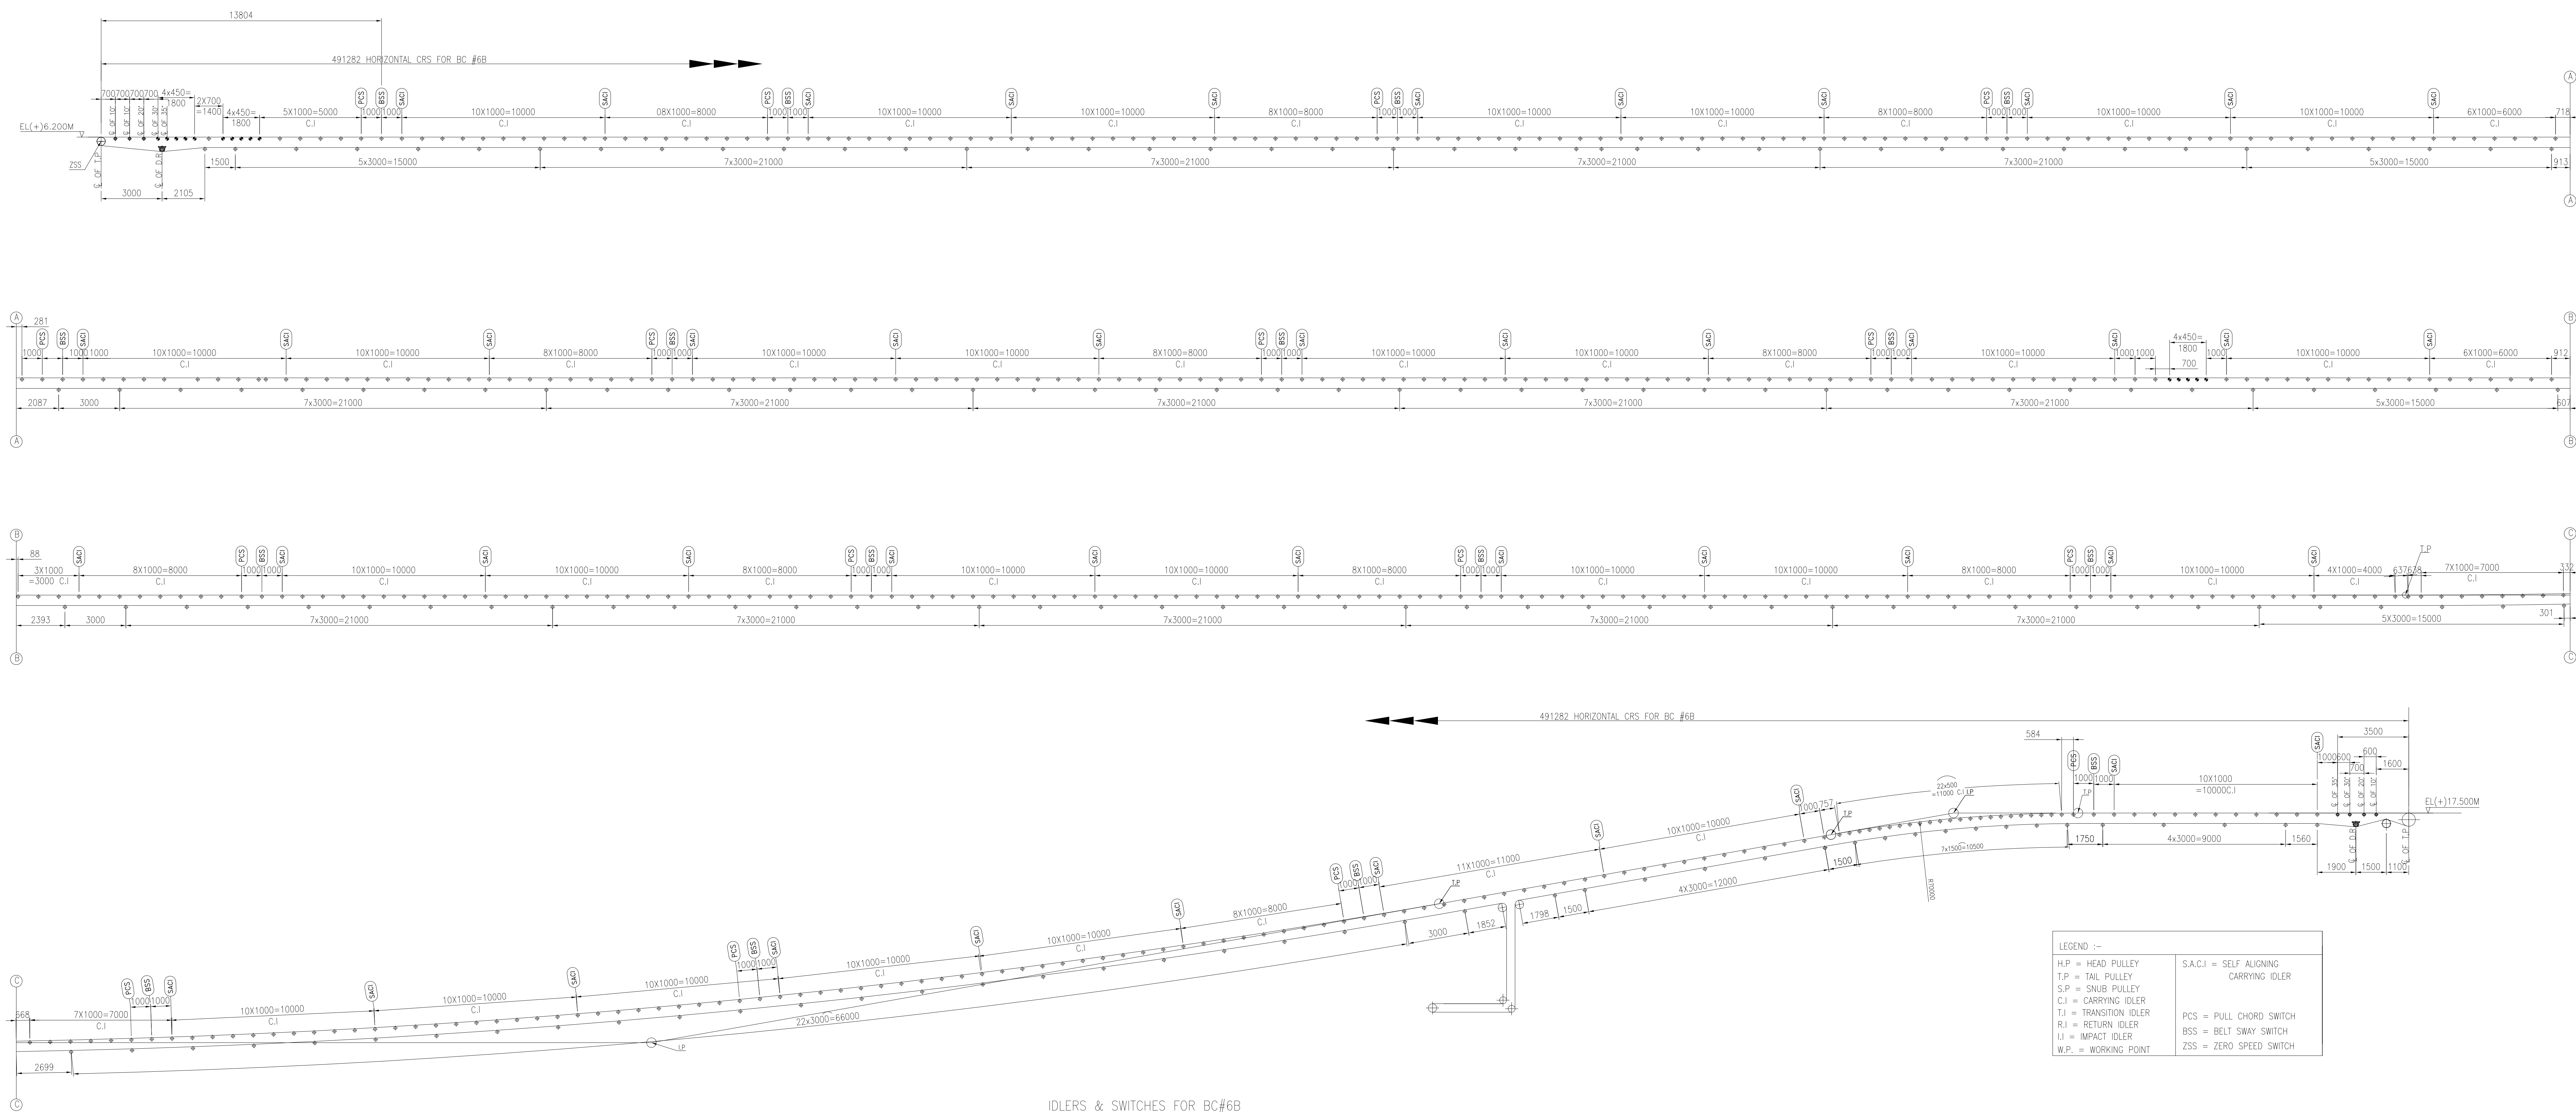

IDLERS & SWITCHES FOR BC#6B

Copyright and Confidential
The information on this document is the property of BHARAT HEAVY ELECTRICALS LIMITED
It must not be used in any way detrimental to the interest of the Company.


REF.DRG.NO.


SIGN & DATE

INVENTORY NO.

0		FOR APPROVAL		
R.No:	DATE	BRIEF RECORD		BY APPD
REVISIONS				

OWNER:	TELANGANA STATE POWER GENERATION CORPORATION LTD. HYDERABAD – TELANGANA, INDIA				
CUSTOMER'S CONSULTANT:	DEVELOPMENT CONSULTANCY PVT. LTD. CONSULTING ENGINEERS KOLKATA . MUMBAI . CHENNAI . NEW DELHI				
PROJECT :	KOTHAGUDEM THERMAL POWER STATION STAGE-VII, UNIT # 12 (1X800 MW), KOTHAGUDEM, TELANGANA, INDIA COAL HANDLING SYSTEM PACKAGE				
EPC CONTRACTOR:	BHARAT HEAVY ELECTRICALS LIMITED INDUSTRIAL SYSTEMS GROUP ISG-BANGALORE				
BHEL'S CONTRACTOR:		NAME	SIGN	DATE	REVISION
	DRN	PVN		16.10.15	00
	CHD	SSD		16.10.15	01
	APP	RSP		16.10.15	02
	TITLE : GA of BC#6A/6B				03
SCALE	BHEL JOB NO. IS-1-14-2006	BHEL-ISG MOBILE NO.	IS-1-GA-690-101-M012		REVISION

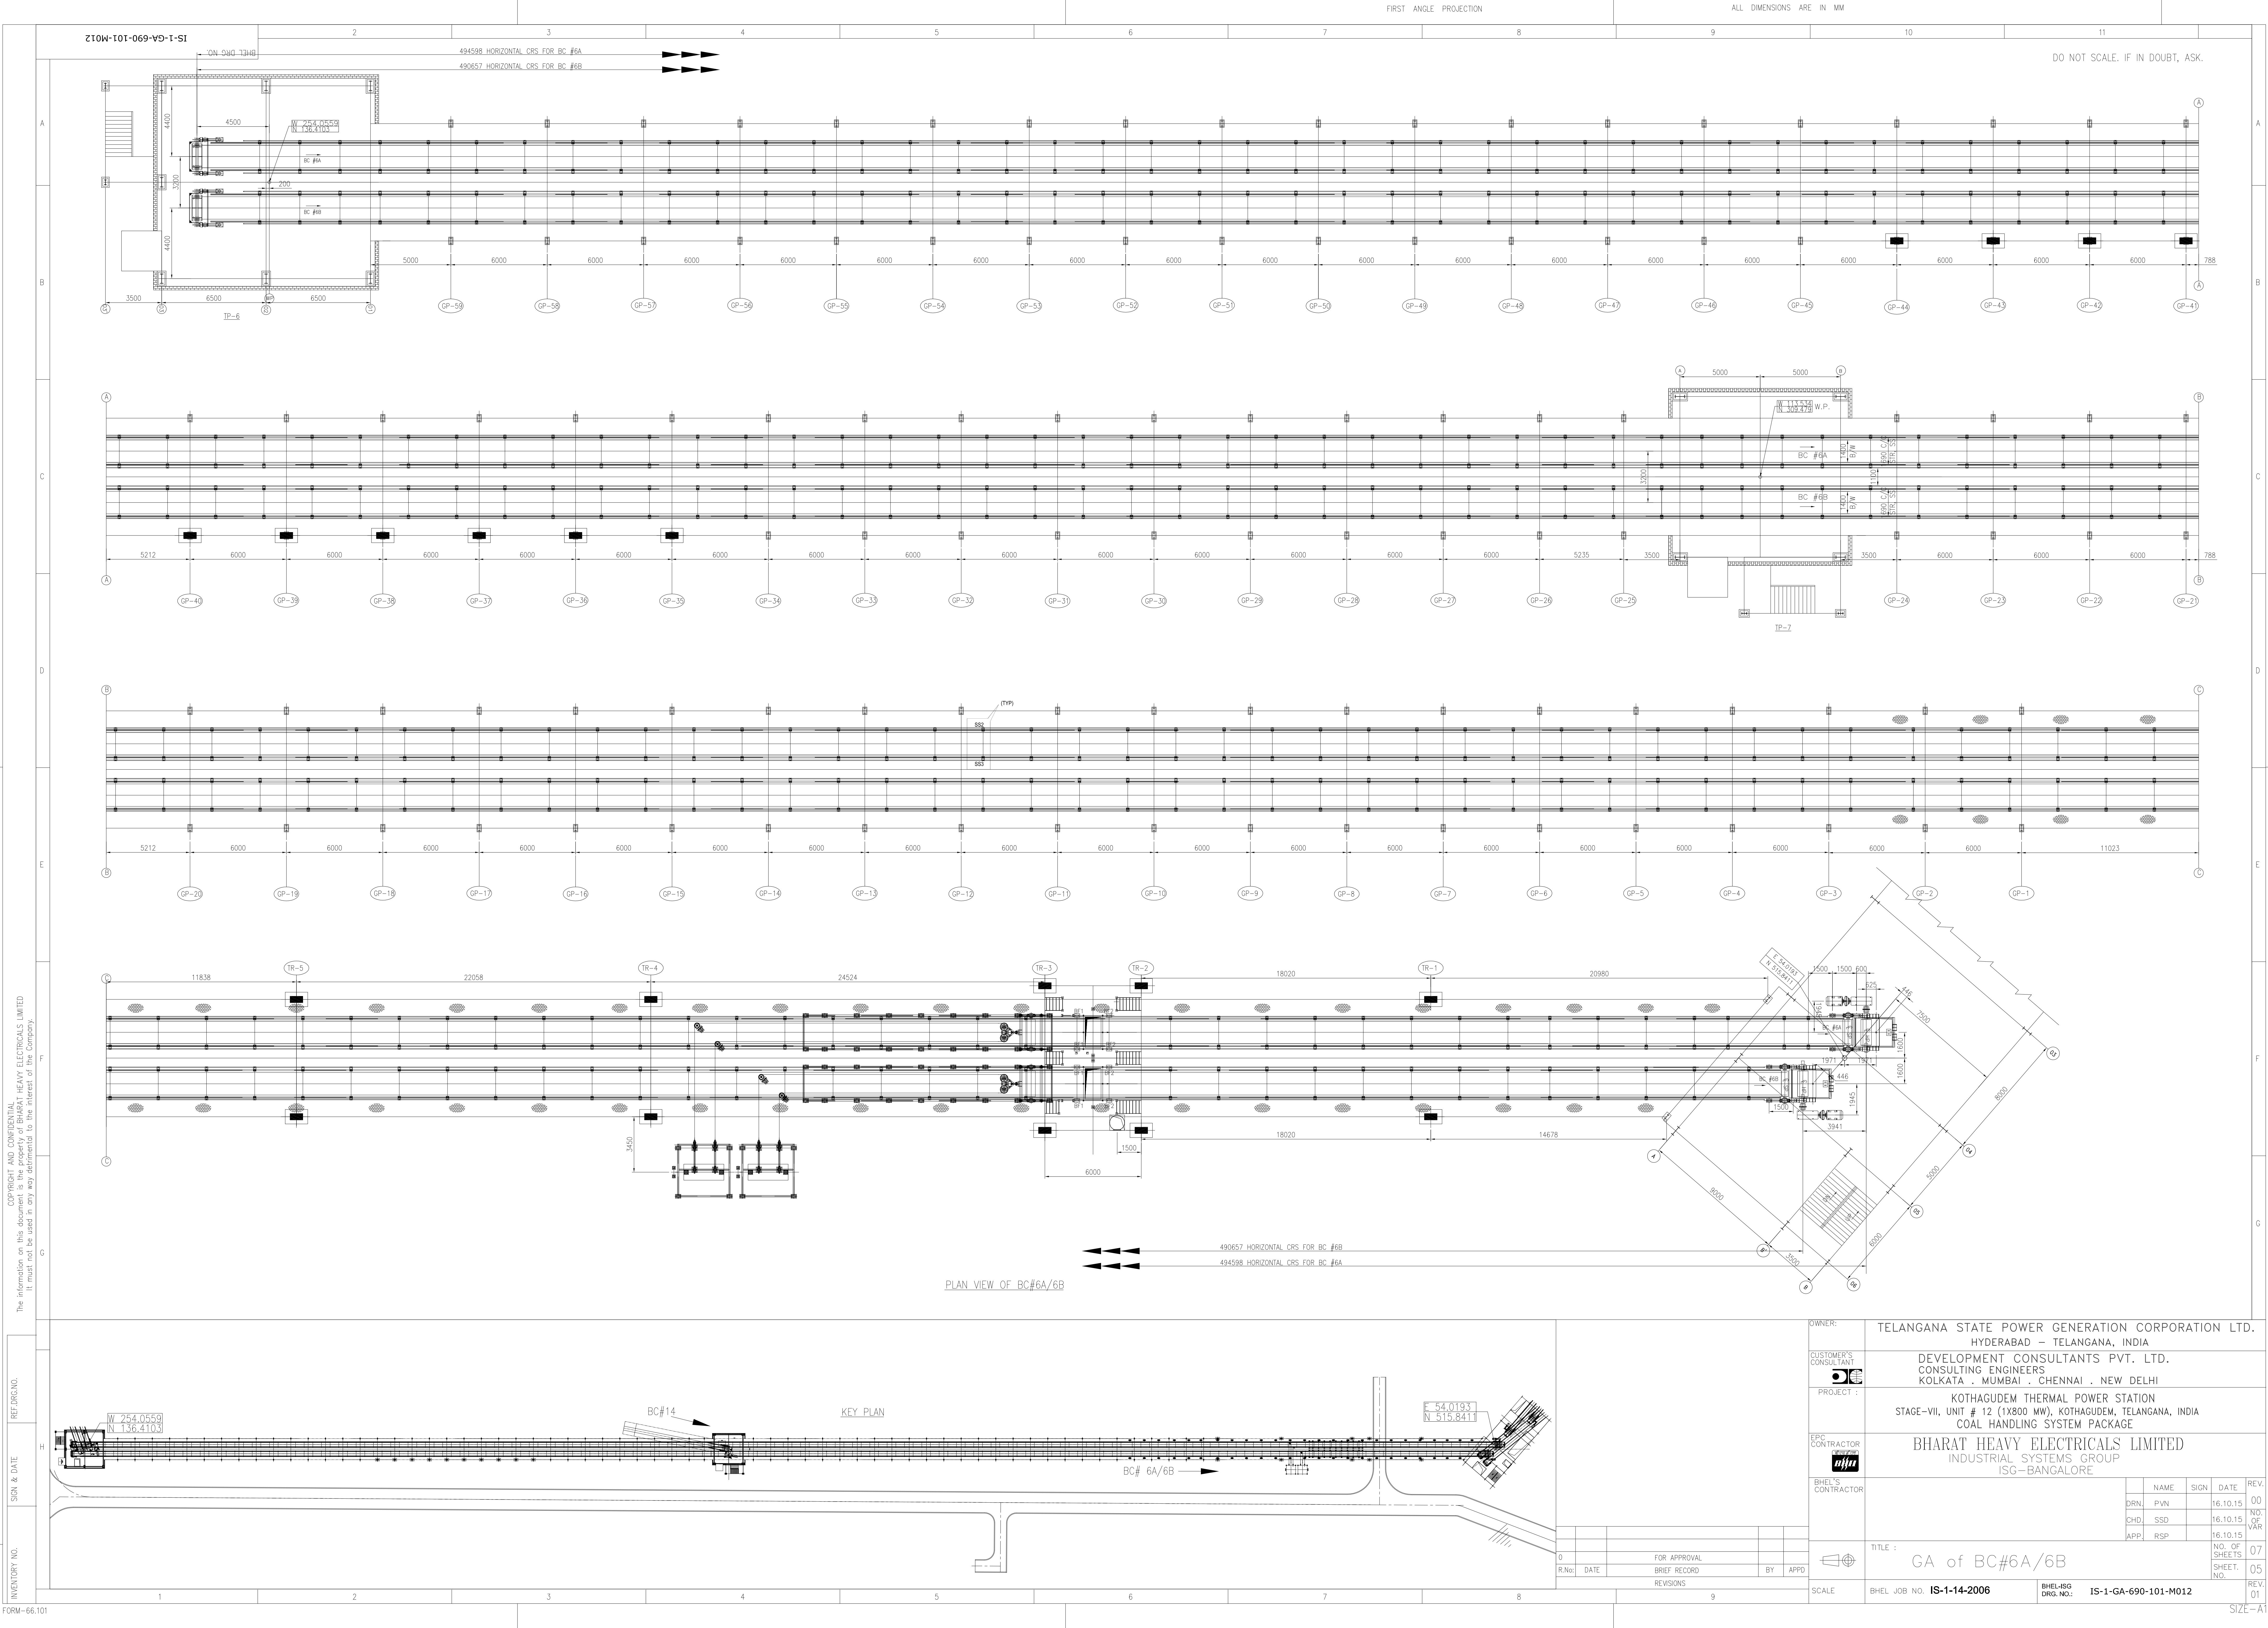

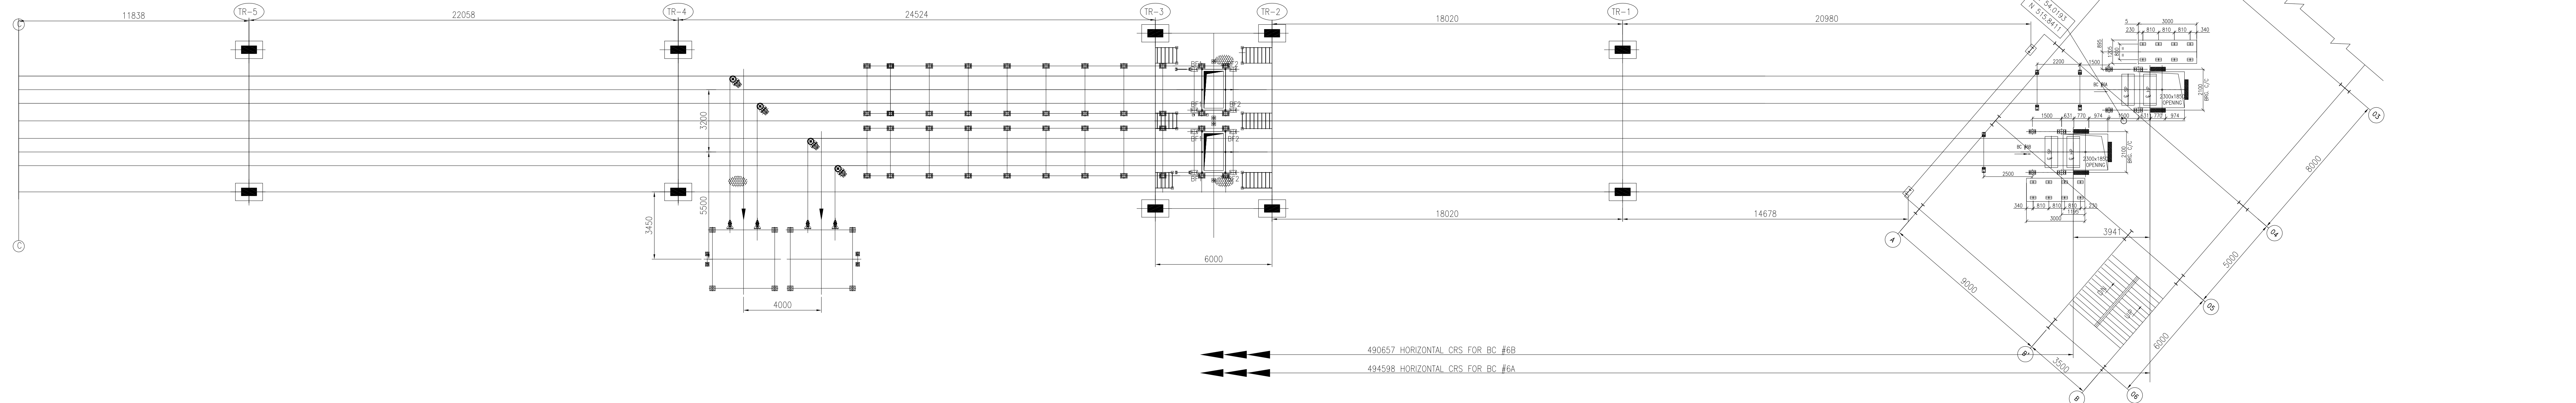

FOUNDATION PLAN VIEW OF BC#6A/6B

OWNER:	TELANGANA STATE POWER GENERATION CORPORATION LTD.					
	HYDERABAD — TELANGANA, INDIA					
CUSTOMER'S CONSULTANT:	DEVELOPMENT CONSULTANTS PVT. LTD.					
	CONSULTING ENGINEERS					
	KOLKATA . MUMBAI . CHENNAI . NEW DELHI					
PROJECT :	KOTHAGUDEM THERMAL POWER STATION					
	STAGE-VII, UNIT # 12 (1X800 MW), KOTHAGUDEM, TELANGANA, INDIA					
	COAL HANDLING SYSTEM PACKAGE					
EPC CONTRACTOR	BHARAT HEAVY ELECTRICALS LIMITED					
	INDUSTRIAL SYSTEMS GROUP					
	ISG-BANGALORE					
BHEL'S CONTRACTOR		NAME	SIGN	DATE	REV.	
	DRN.	PVN		16.10.15	00	
	CHD	SSD		16.10.15	NO. OF VAR	
	APP	RSP		16.10.15		
	TITLE :				07	
	GA of BC#6A/6B				06	
SCALE	BHEL JOB NO.	IS-1-14-2006	BHEL-ISG DRG. NO.	IS-1-GA-690-101-M012	01	

0		FOR APPROVAL		
R.No:	DATE	BRIEF RECORD	BY	APPROVED
		REVISIONS		
		9		

