

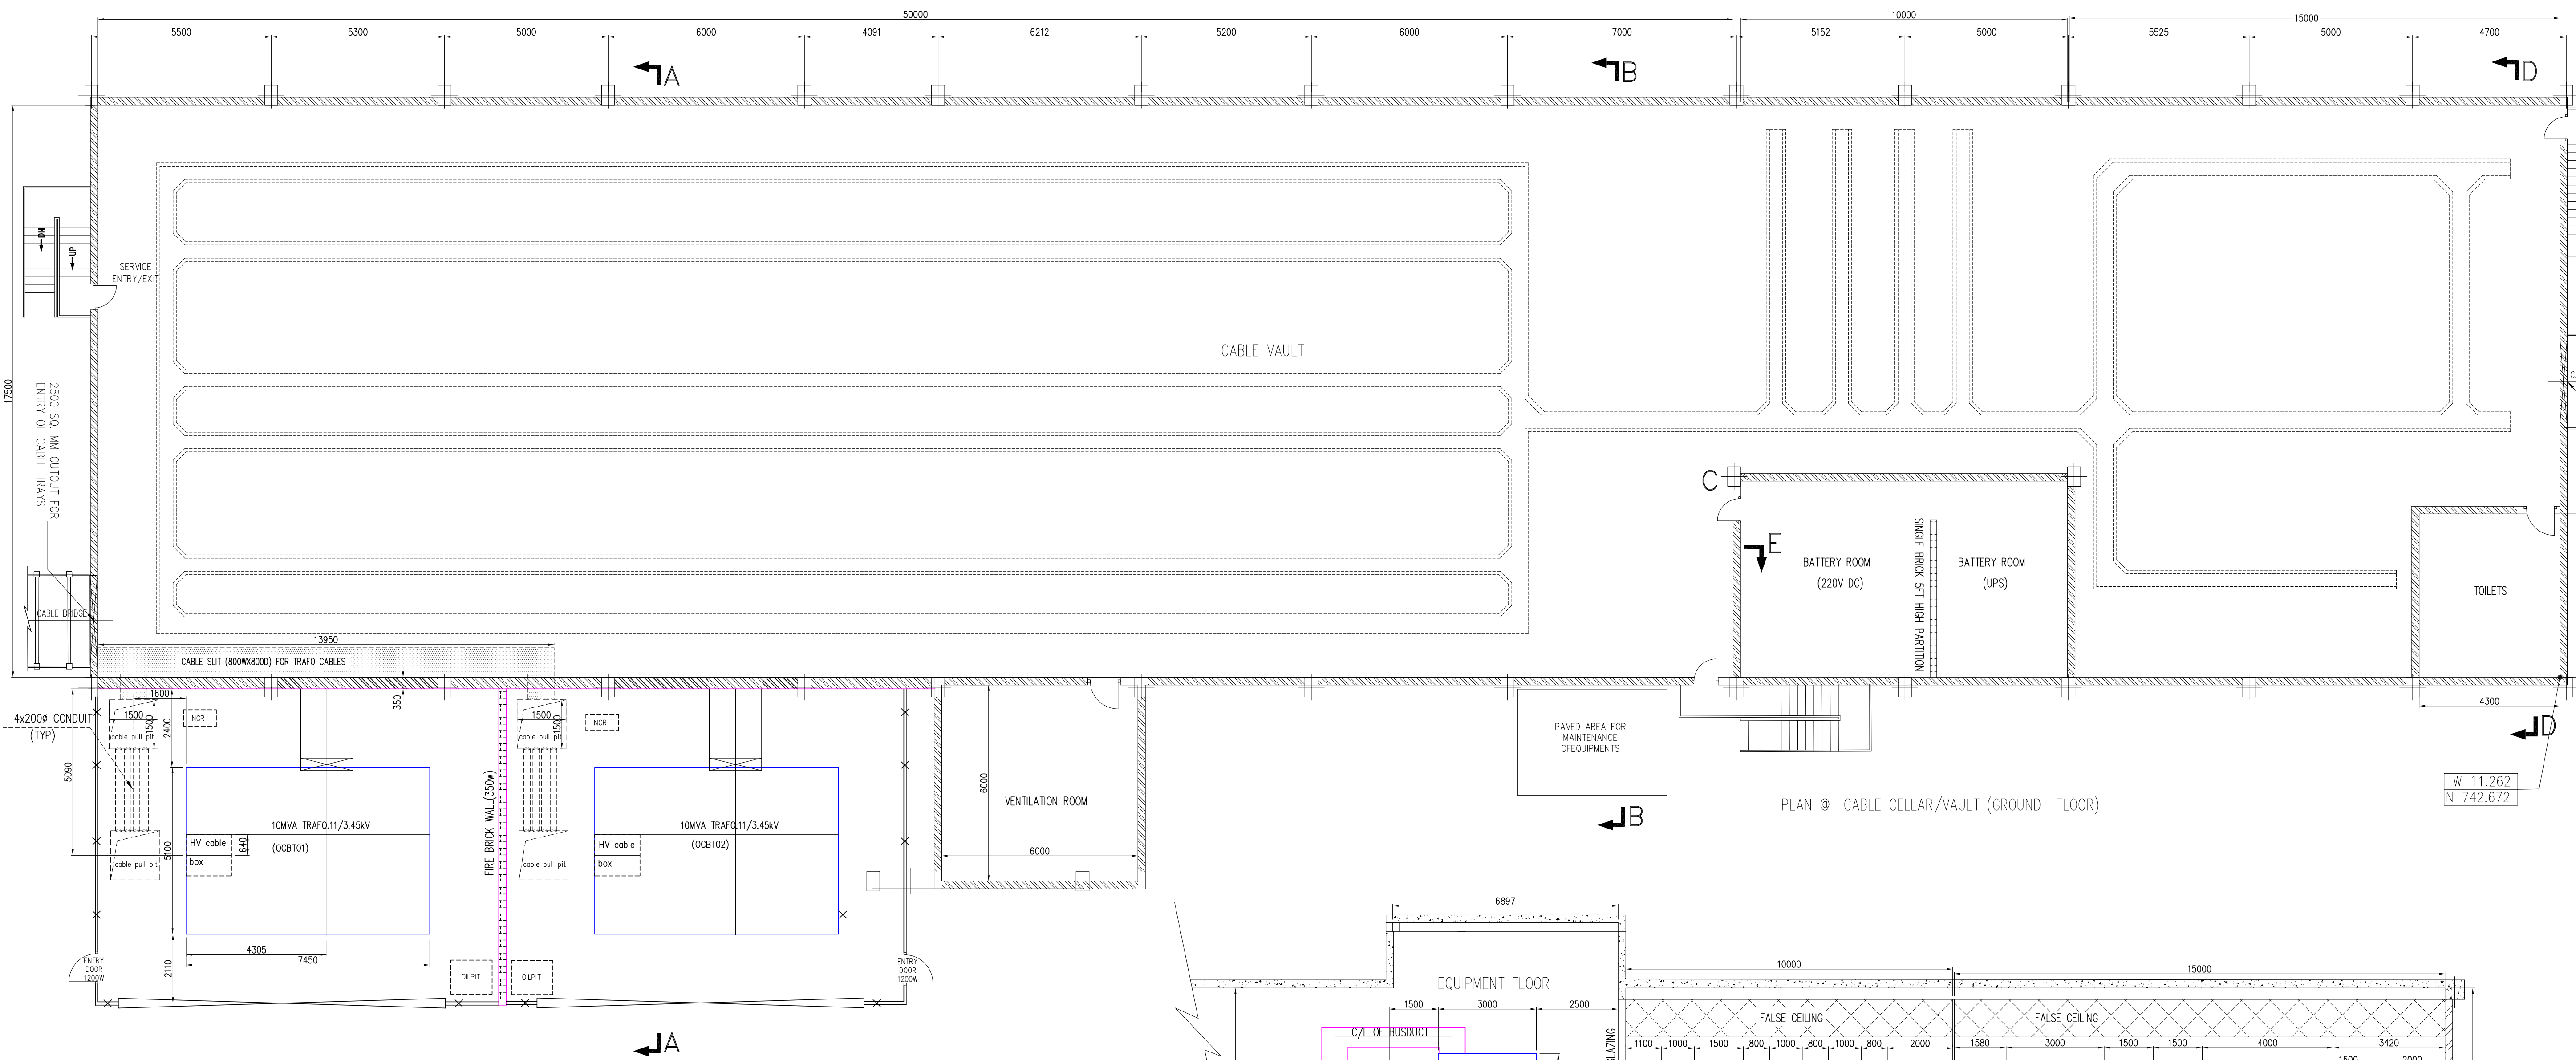
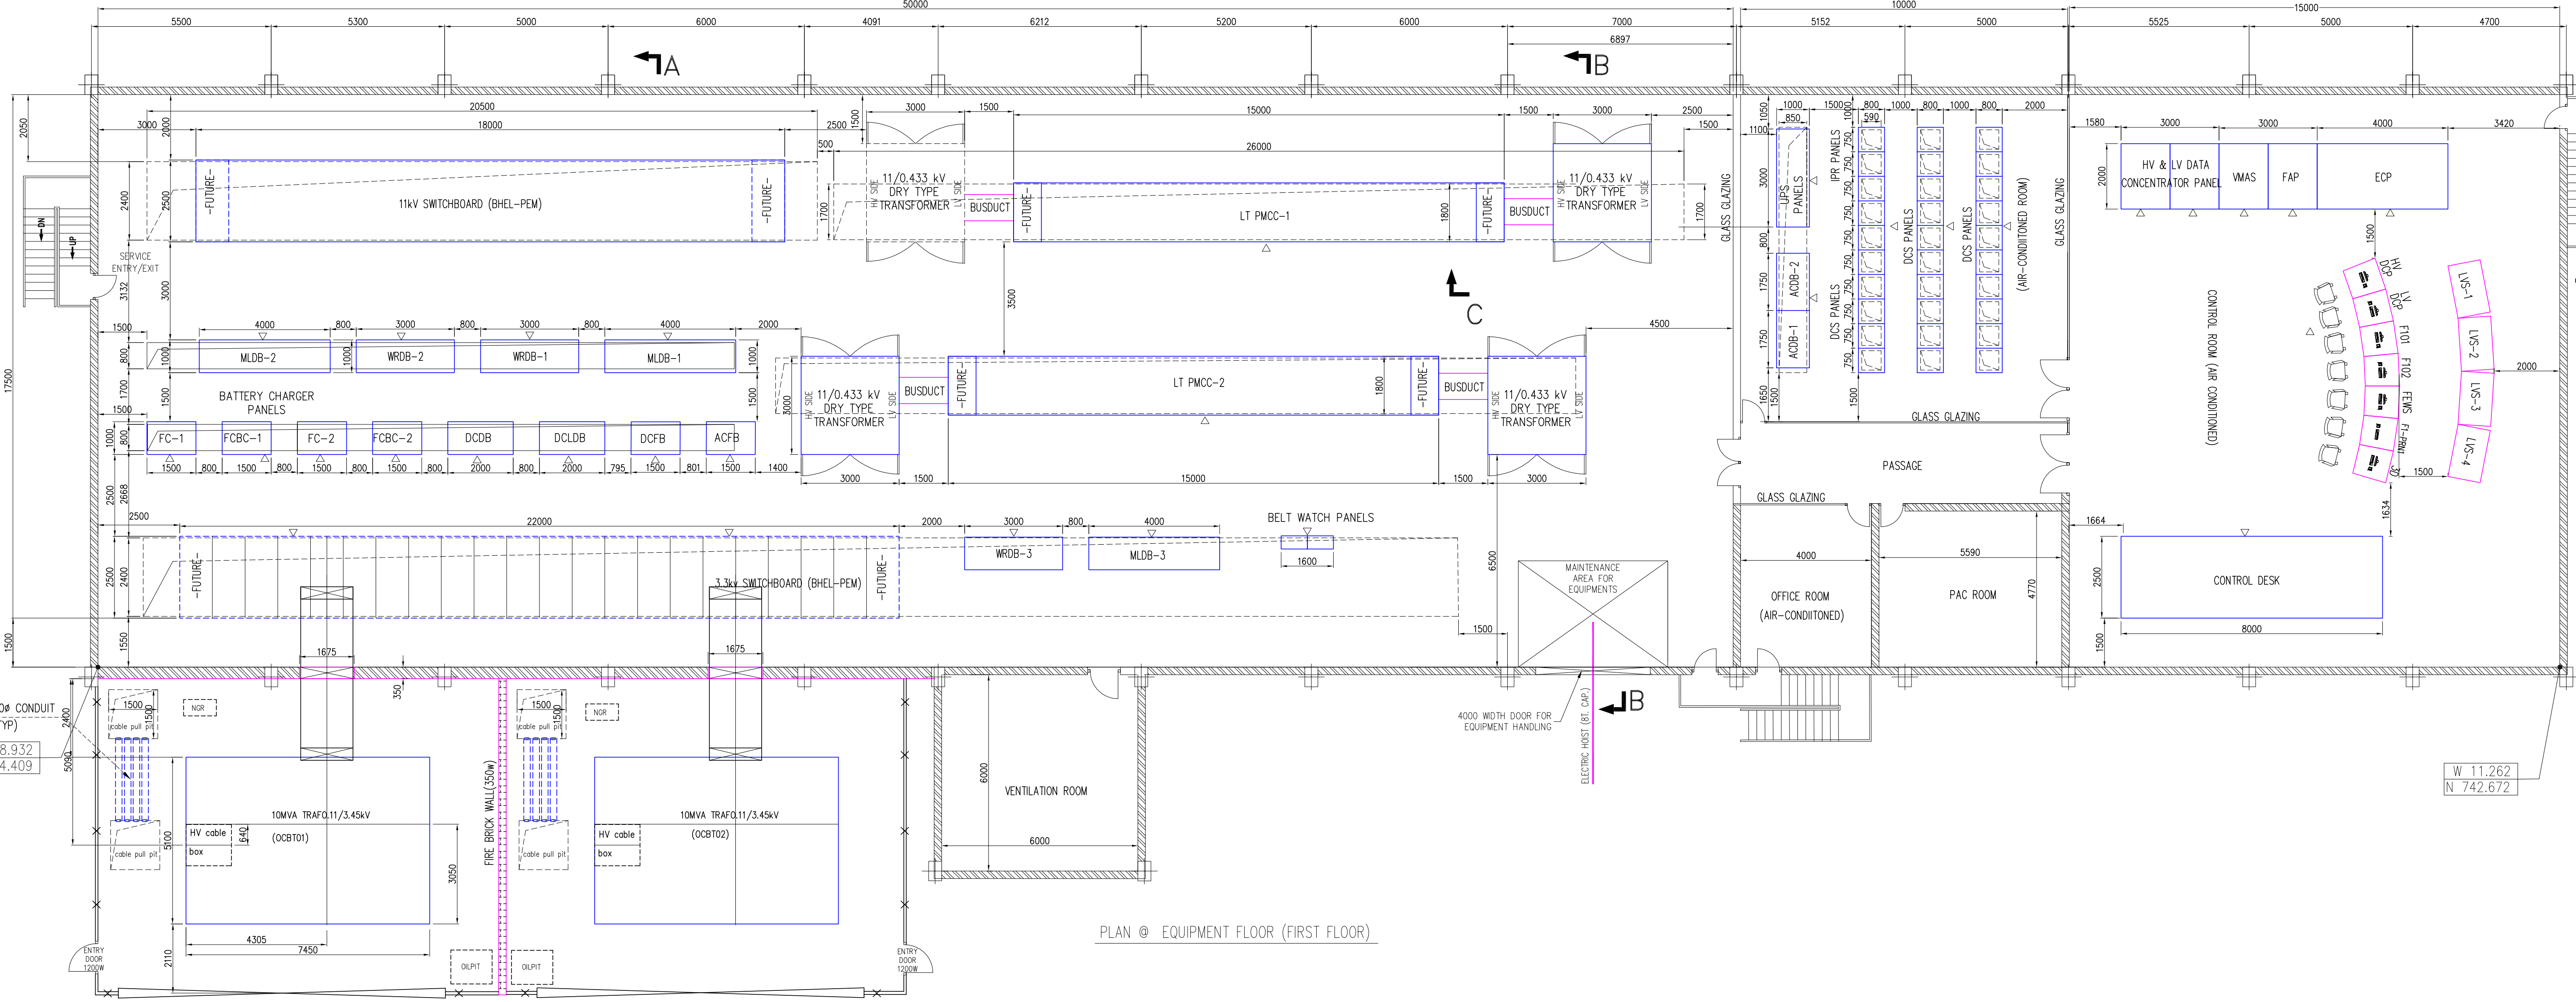
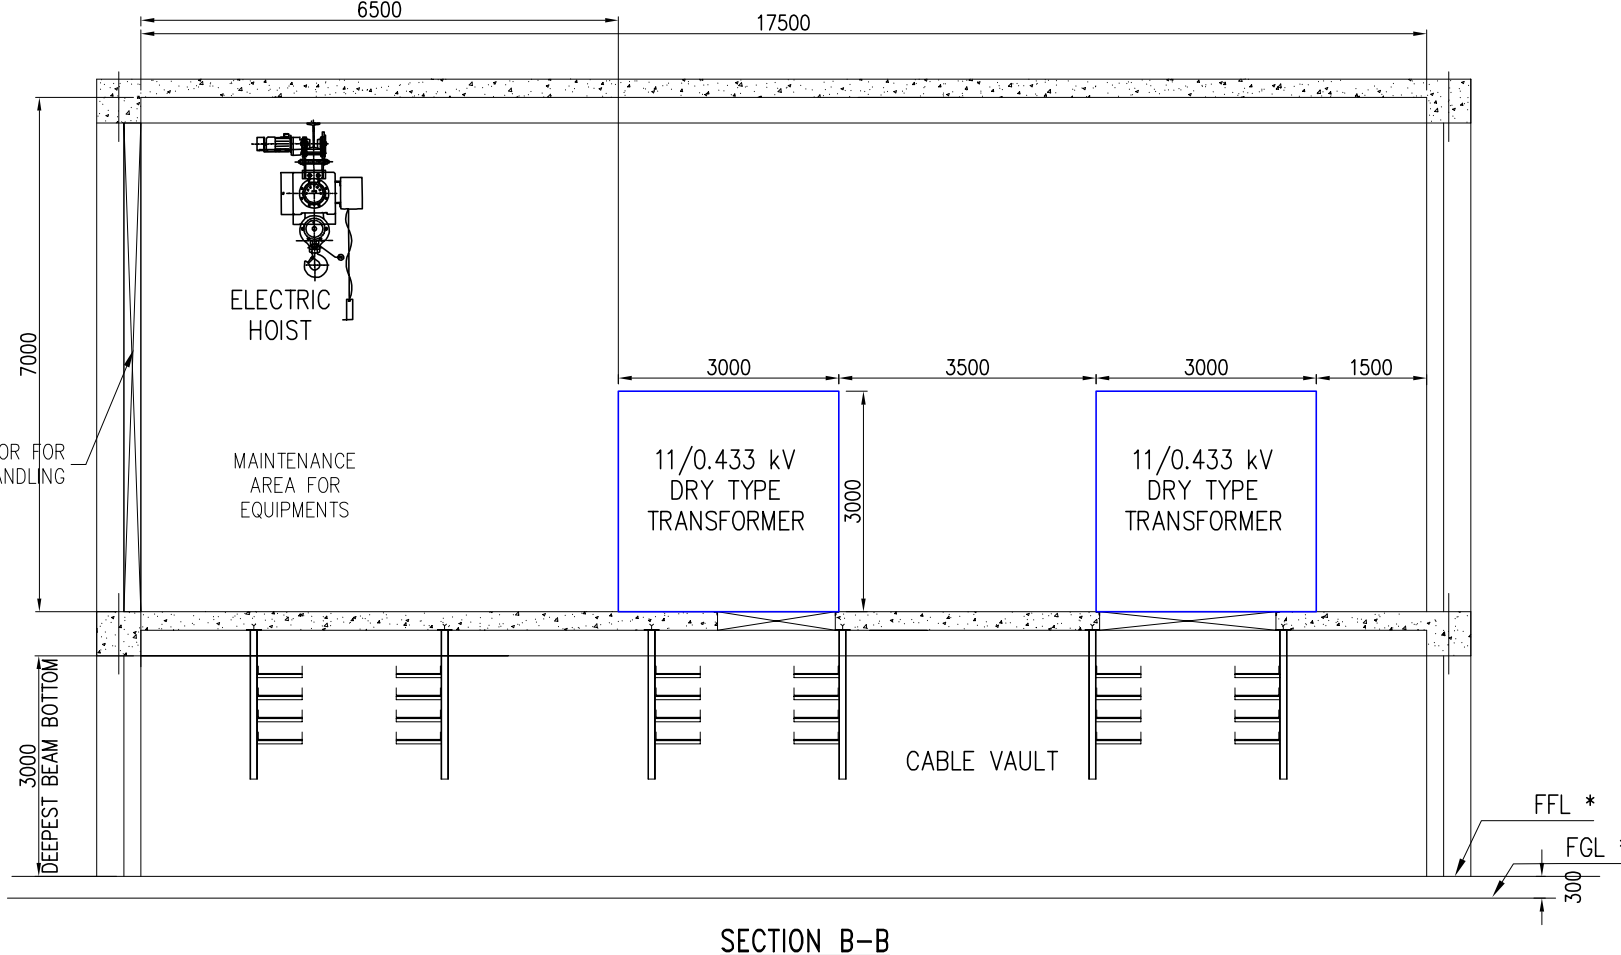
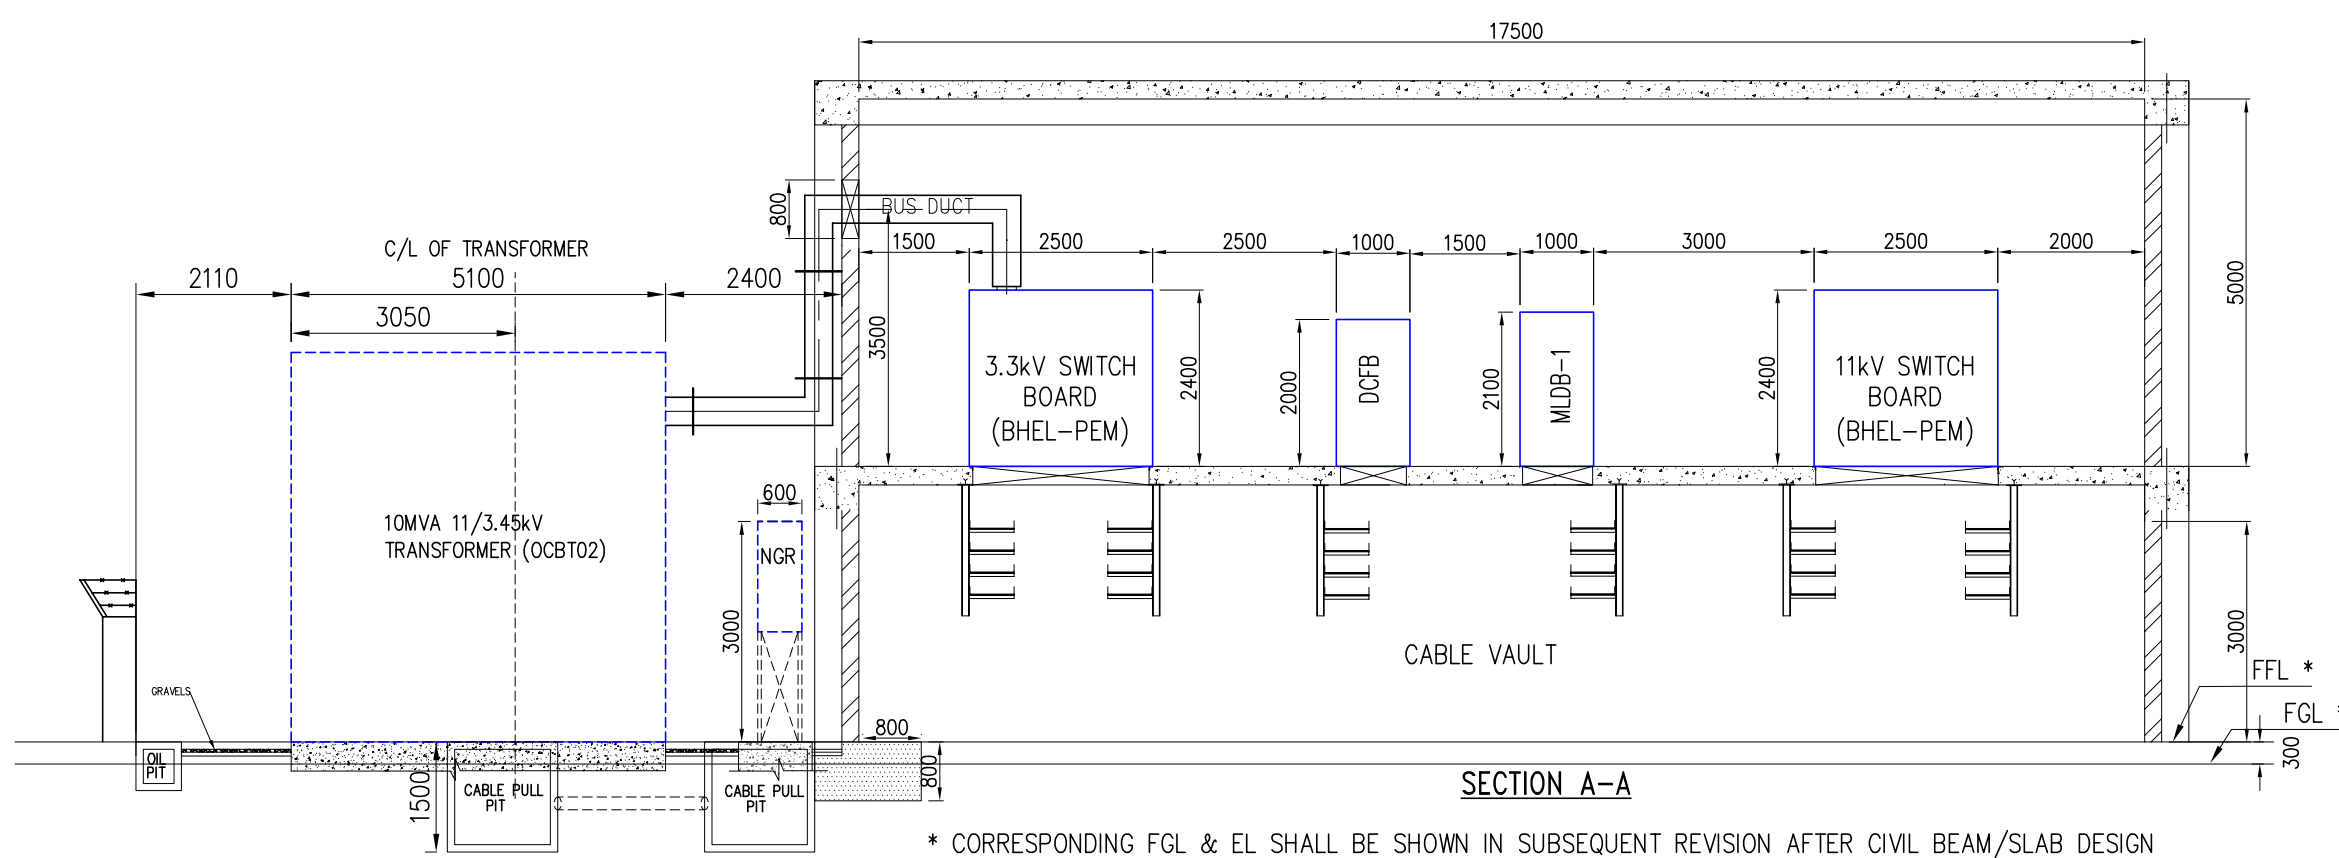


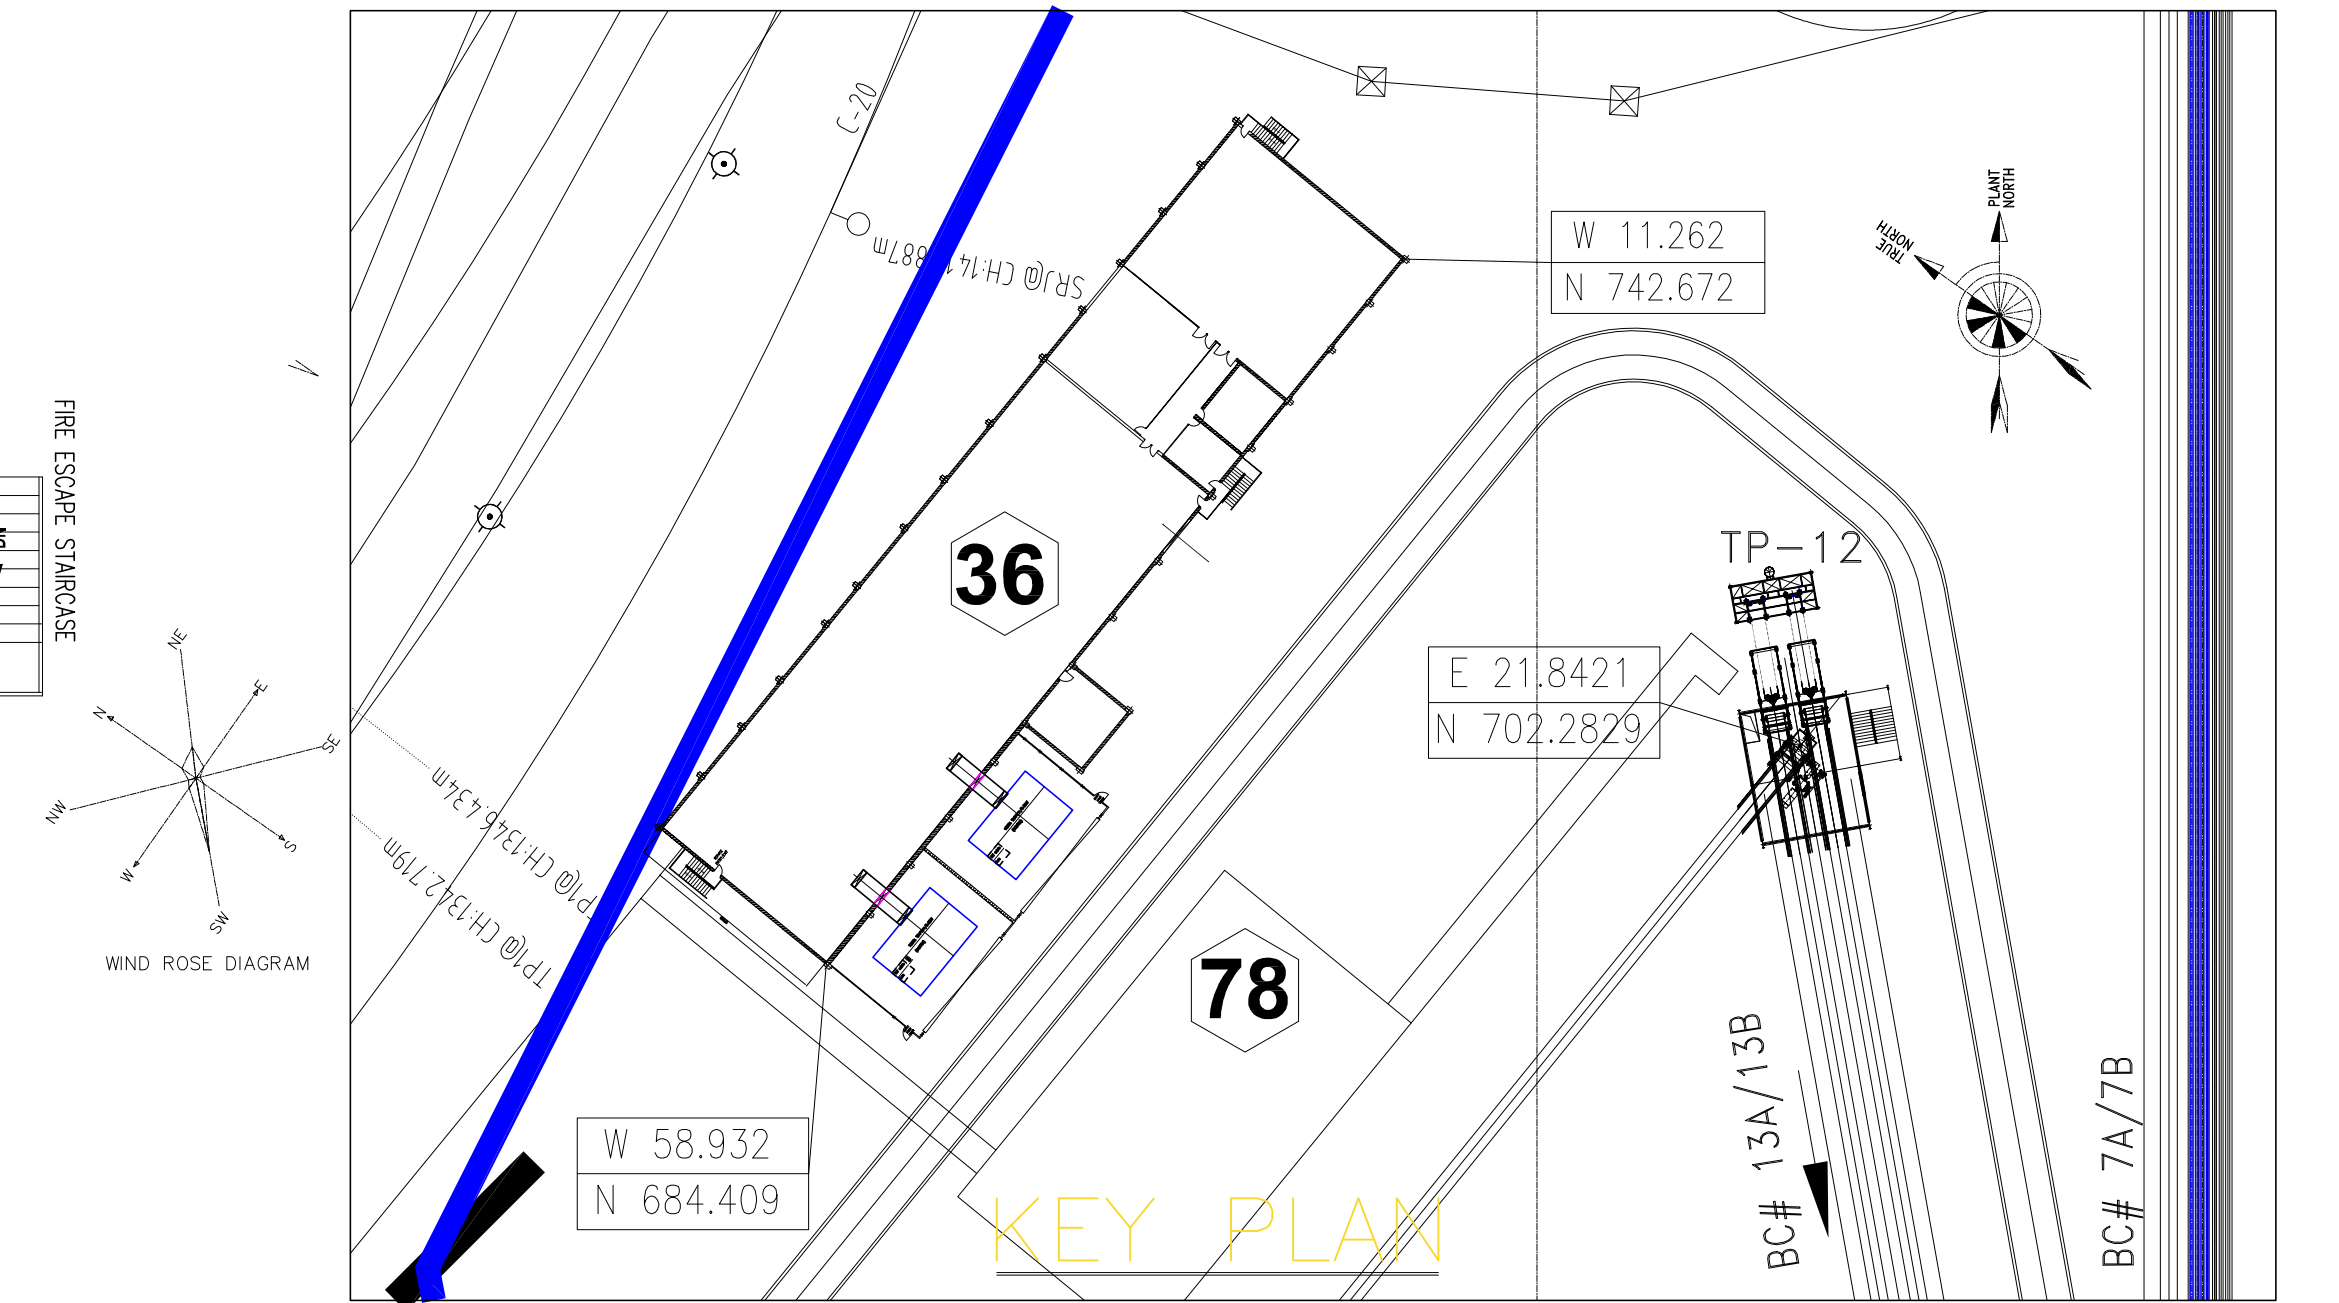

NOTES

- DIMENSIONS INDICATED ARE IN MM UNLESS NOTED.
- EXACT DIMENSIONS OF EQPT. SHALL BE INDICATED ON RECEIPT OF GA DRGS FROM SUPPLIERS.
- ALL SWITCHGEAR ROOM DOORS SHALL BE OF FIRE PROOF TYPE AND SHALL BE RATED FOR 2 HOURS
- CABLE TRESTLE/BIDGE ROUTING SHOWN IS INDICATIVE ONLY.
- TRANSFORMER FOUNDATION DETAILS SHALL BE SUBMITTED AFTER RECEIPT OF TRANSFORMER DRAWING FROM MANUFACTURER
- BUS DUCT ROUTING SHOWN IS INDICATIVE, SHALL BE FINALIZED ON DETAIL ENGINEERING.
- ROOM SIZE BEING FINALIZED CONSIDERING TENTATIVE LOADS. HOWEVER ANY CHANGE IN THE ROOM SIZE / LAYOUT AS PER PROJECT REQUIREMENT WILL BE COMPLIED BY BHEL.
- THIS DRAWING MAY BE REFERRED ONLY FOR EQUIPMENT LOCATION, LAYOUT FOR CABLE TRAY & EARTHING LAYOUT SHALL BE SUBMITTED SEPARATELY.
- ALL PANELS ARE SUITABLE FOR BOTTOM ENTRY OF POWER AND CONTROL CABLES.
- APPROX. WEIGHT OF THE HEAVIEST EQUIPMENT IS 6T I.E., WEIGHT OF DRY TYPE TRANSFORMER.
- CUTOUTS MARKED ARE TENTATIVE. EXACT DIMENSIONS SHALL BE INDICATED IN THE SUBSEQUENT REVISION AFTER RECEIPT OF GA DRAWINGS.

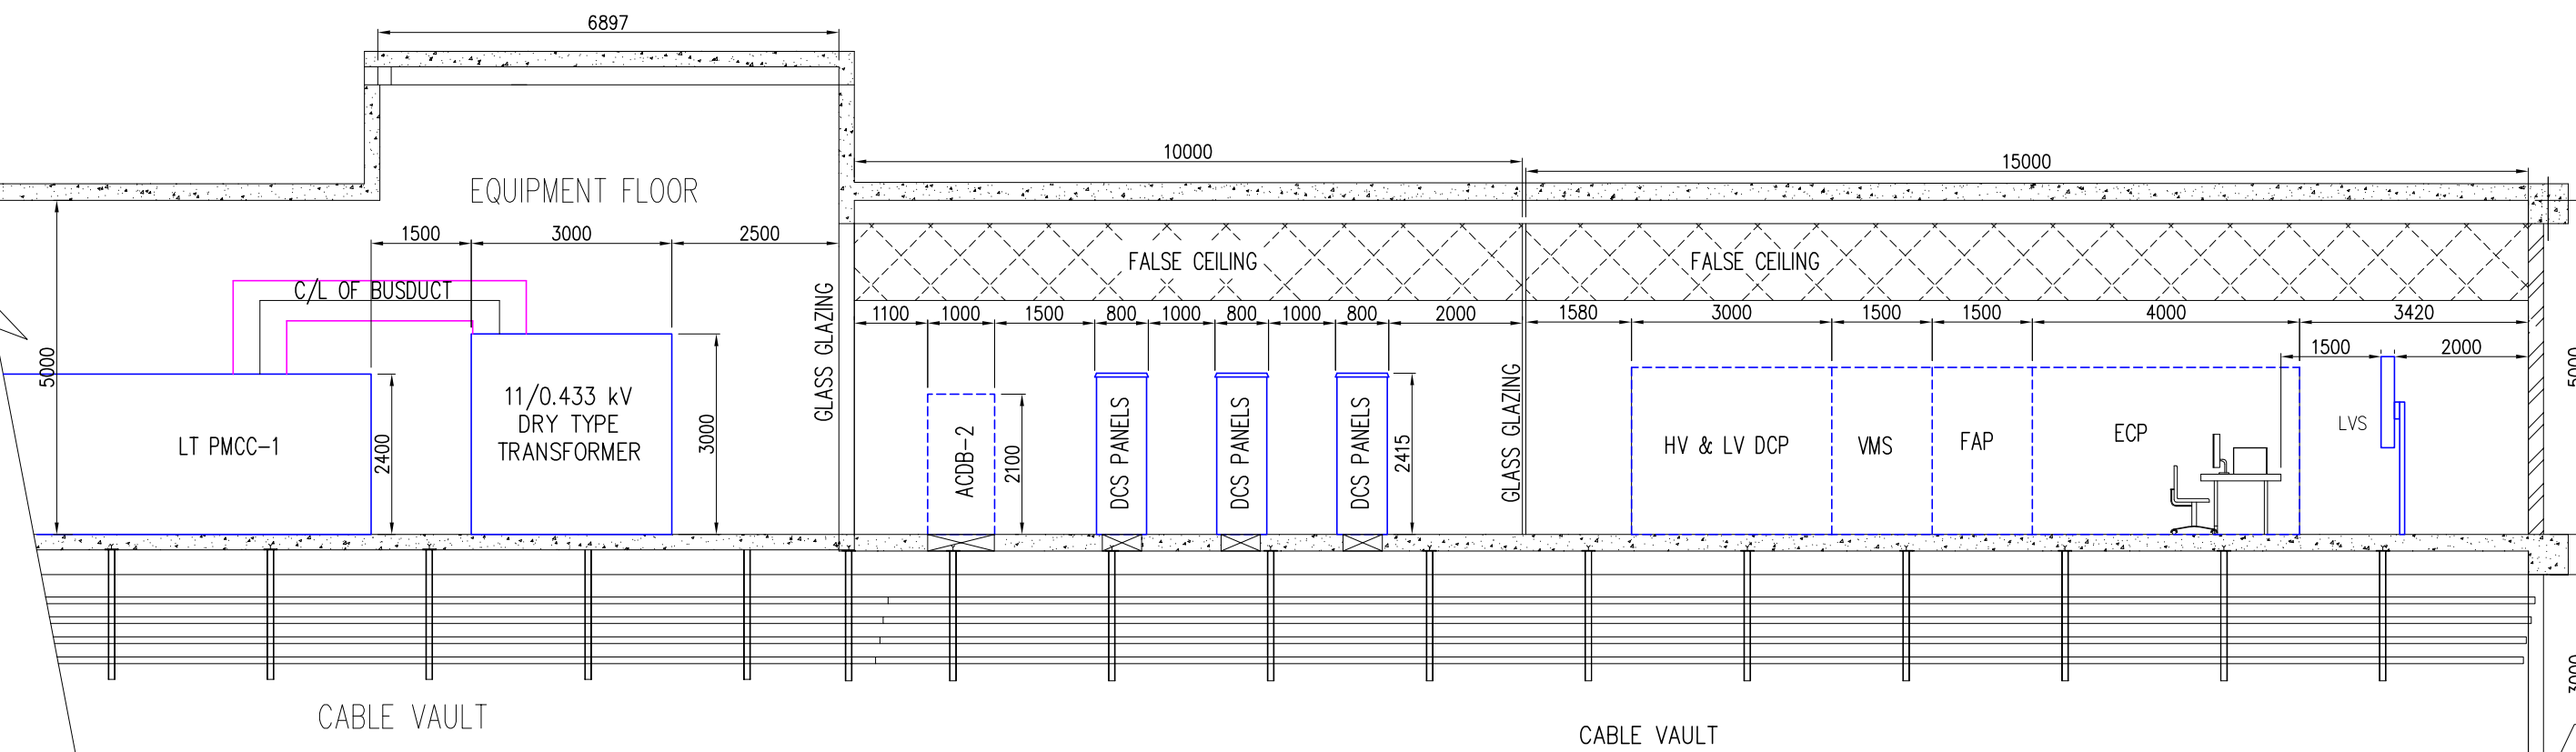

JOB NO.	IS - 1 - 14 - 2006
STATUS OF DRAWING	
DISTRIBUTION OF PRINTS	QTY.

CUSTOMER : TELANGANA STATE POWERGENERATION CORPORATION LTD. CHP		CONSULTANT : DEVELOPMENT CONSULTANTS PVT. LTD.	
1x800 MW KOTHAGUDAM TPS STAGE -VII UNIT #12, PALONCHA		CONSULTING ENGINEERS	
KOLKATA MUMBAI CHENNAI NEW DELHI		INDUSTRIAL SYSTEMS GROUP, BANGALORE	
NAME	SIGN.	DATE	NO. OF VAR
Diwakar		04-04-2016	
Nanditha		11-04-2016	
Bindu		11-04-2016	
REF. TO ASSY.DRG.	ITEM NO.	NO. OF ITEMS	
TITLE : ELECTRICAL EQUIPMENT LAYOUT OF CHP MCC -1, CONTROL cum SWITCHGEAR ROOM NEAR TP-12	DRAWING NO. IS-1-EE-690-121-E002	REV. 0	
SHEET NO. 01	NO. OF SHEETS. 01		