

DRAWING NO.


DO NOT SCALE. IF IN DOUBT, ASK.



圖 1-1



 144181
HORIZONTAL ORS BC-48



OWNER:		TELANGANA STATE POWER GENERATION CORPORATION LTD.											
		HYDERABAD – TELANGANA, INDIA											
CONSULTANT:		DESEIN PRIVATE LIMITED											
PROJECT:		BHADRADRI THERMAL POWER STATION 4 X 270 MW, UNITS-1 TO 4, MANUGURU, TELANGANA, INDIA											
EPC CONTRACTOR		BHARAT HEAVY ELECTRICALS LIMITED								REV.			
		INDUSTRIAL SYSTEMS GROUP								DATE:			
		ISO - BANGALORE								03.08.15			
		DRN	NAME	SIGN					NO. VAR				
		CHD	MNK					03.08.15					
		APP	RSP /VSD					TOTAL SHEETS		05			
		TITLE : GA AND LOAD DATA OF BCN-4A & 4B								SHEET NO.		01	
SCALE	BHEL JOB NO.	IS-1-14-2007				BHEL-ISO DRG.NO.:		IS-1-GA-691-101-M011				REV.	01
SHEET NO.													

SIZE-A1

Copyright and Confidentiality
The information on this drawing is the property of Bharat Heavy Electricals Limited. It is to be used only for the purpose for which it is provided and is not to be reproduced or used in any manner without the prior written consent of Bharat Heavy Electricals Limited.

PROJECT NO.
ISSN & DATE
REV. NO.



FIRST ANGLE PROJECTION

ALL DIMENSIONS ARE IN MM

T10W-101-T69-V9-I-SI

ON DRAWING

DO NOT SCALE IF IN DOUBT, ASK.

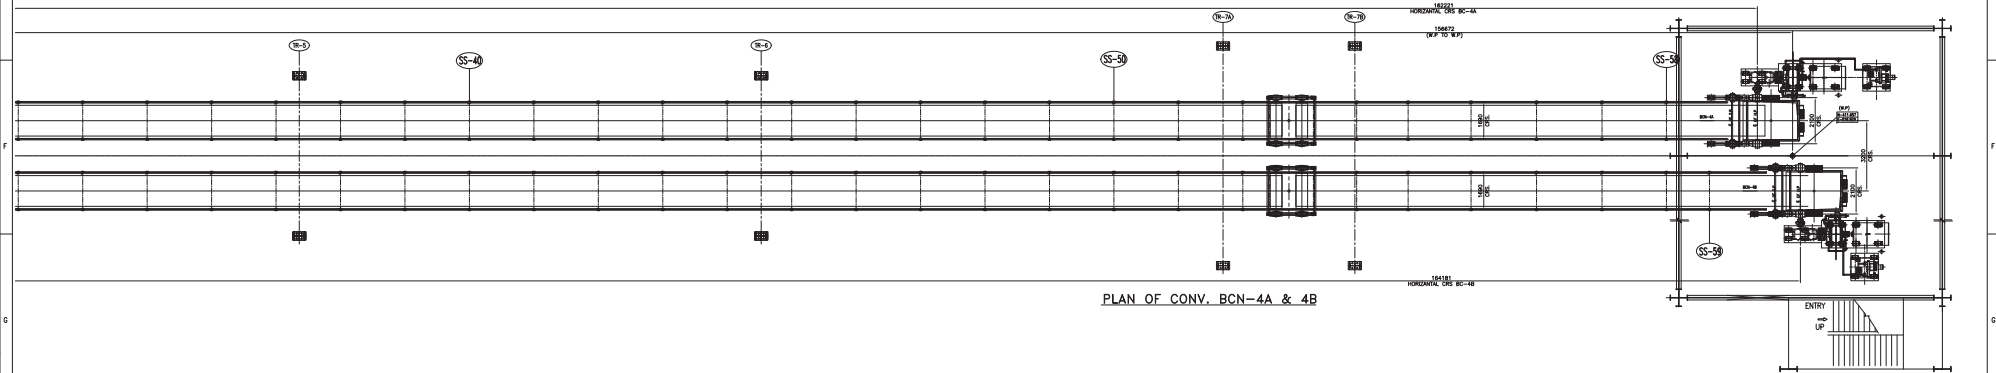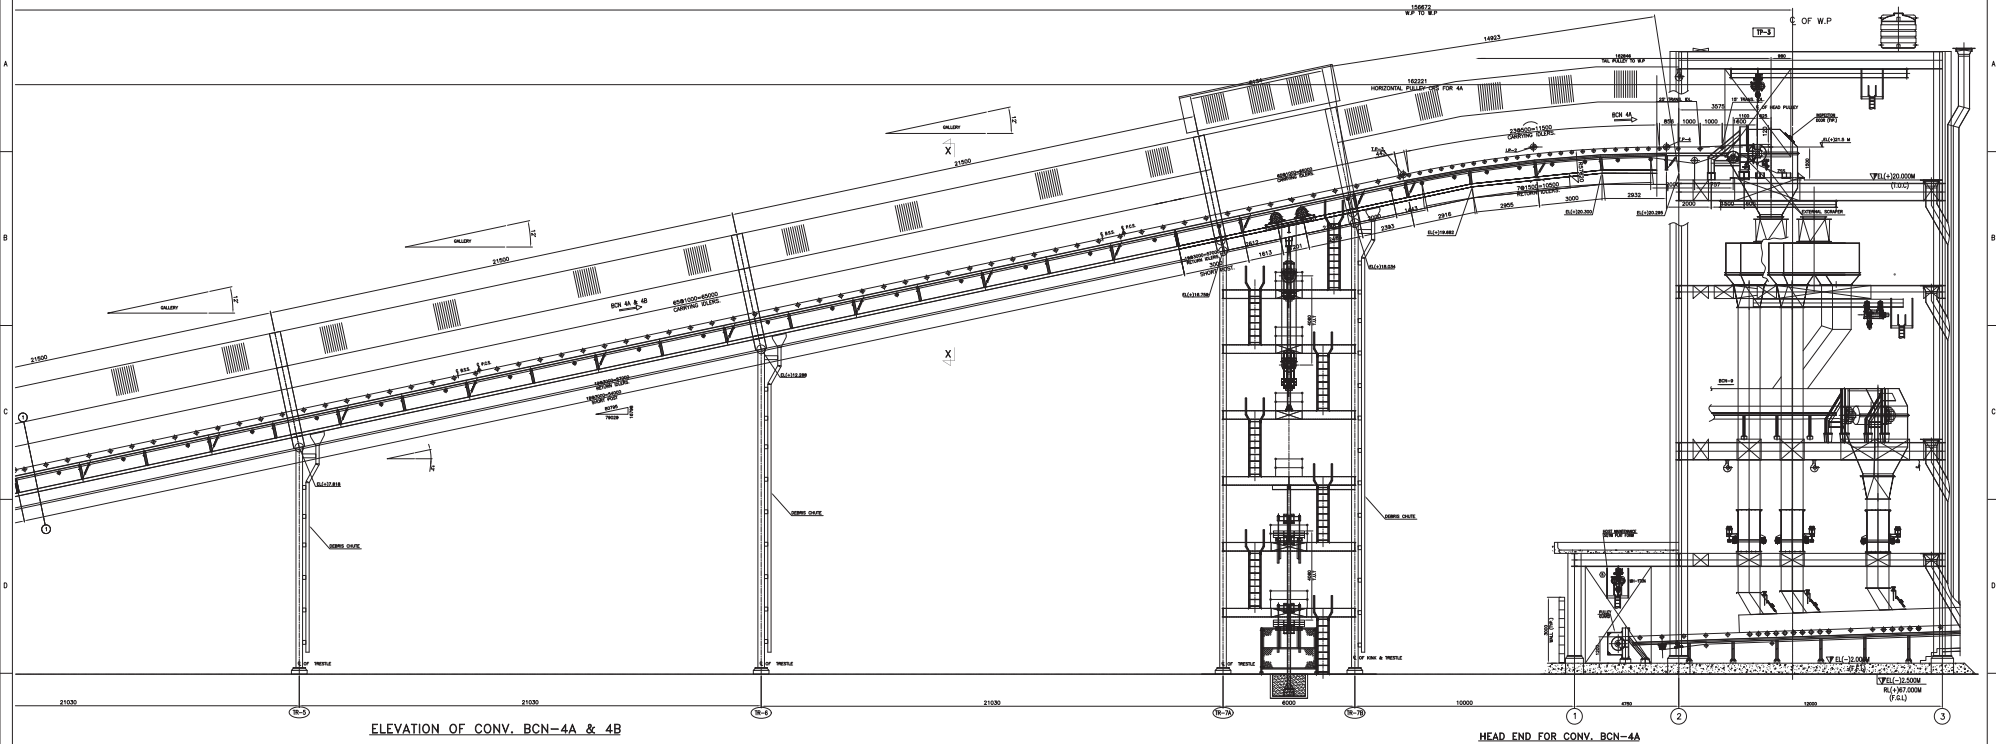

R/No	DATE	BRIEF RECORD	BY	APPRO
		REVISIONS		

OWNER:	TELANGANA STATE POWER GENERATION CORPORATION LTD. HYDERABAD - TELANGANA, INDIA			
CONSULTANT:	DESEIN PRIVATE LIMITED			
PROJECT :	BHADRADRI THERMAL POWER STATION 4 X 270 MW, UNITS-1 TO 4, MANUGURU, TELANGANA, INDIA			
CONTRACTOR:	BHARAT HEAVY ELECTRICALS LIMITED INDUSTRIAL SYSTEMS GROUP ISG-BANGALORE			
TITLE :	GA AND LOAD DATA OF BCN-4A & 4B			
SCALE	BHEL JOB NO. IS-1-14-2007	BHEL-ISG DRG/NO.:	IS-1-GA-691-101-M011	REV: 00
				SIZE-A1

NAME	SIGN	DATE	REV.
DRN: BMH		03.08.15	NO.
CHD: MNK		03.08.15	05
APP: RSP/VSS		03.08.15	02
			00

Copyright and Confidentiality
The information on this drawing is the property of BHARAT HEAVY ELECTRICALS LIMITED
No part of this drawing may be reproduced or transmitted in any form or by any means electronic or mechanical, including photocopying, recording, or by any information storage or retrieval system, without the prior written permission of BHARAT HEAVY ELECTRICALS LIMITED.


FIRST ANGLE PROJECTION

ALL DIMENSIONS ARE IN MM


T10W-101-T69-V9-I-SI

ON DRAWING


DO NOT SCALE IF IN DOUBT, ASK.

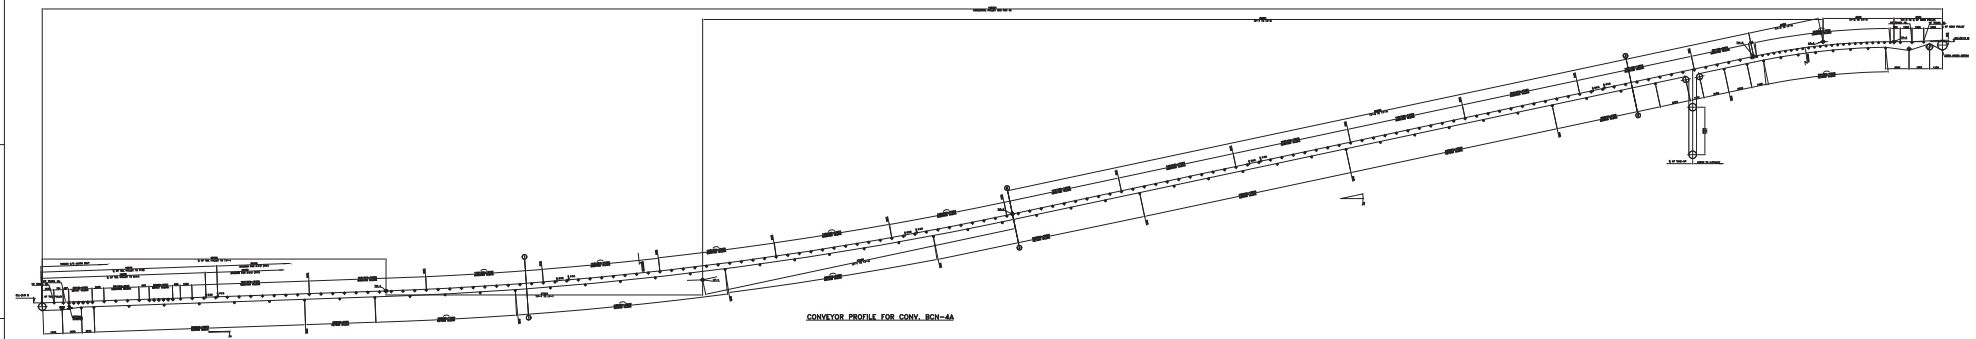


CONVEYOR PROFILE FOR CONV. BCN-4A

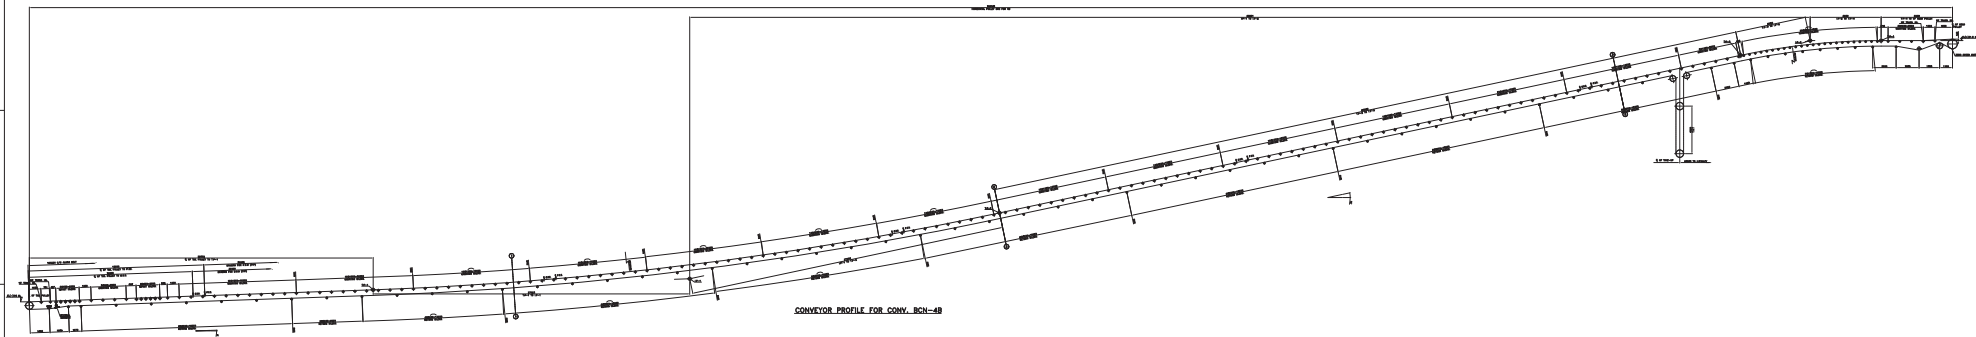

CONVEYOR PROFILE FOR CONV. BCN-4B

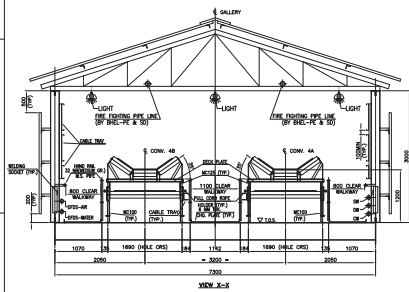


VIEW X-X

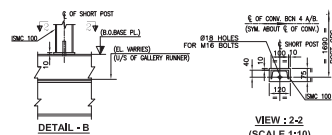


DETAIL - B

 VIEW : 2-2
(SCALE 1:10)
(SS-11 TO SS-59)




DETAIL - A

VIEW : 1-1
(SCALE 1:10)

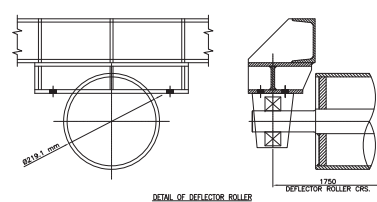


DETAIL OF DEFLECTOR ROLLER

 DEFLECTOR ROLLER 'C' S



ENCL. DTS. AT-X
AT HEAD

 VIEW ON A1-A1



ENCL. DTS. AT-Y
AT HEAD

VIEW ON B1-B1

R/NO	DATE	BRIEF RECORD	BY	APPRO
		REVISIONS		

OWNER:	TELANGANA STATE POWER GENERATION CORPORATION LTD. HYDERABAD - TELANGANA, INDIA			
CONSULTANT:	DESEIN PRIVATE LIMITED			
PROJECT :	BHADRADRI THERMAL POWER STATION 4 X 270 MW, UNITS-1 TO 4, MANUGURU, TELANGANA, INDIA			
CONTRACTOR:	BHARAT HEAVY ELECTRICALS LIMITED INDUSTRIAL SYSTEMS GROUP ISG-BANGALORE			
TITLE :	GA AND LOAD DATA OF BCN-4A & 4B			
SCALE:	BHEL JOB NO. IS-1-14-2007	BHEL-ISG DRG.NO.:	IS-1-GA-691-101-M011	REV. 00
			TOTAL SHEETS: 05	SHEET NO. 04


FIRST ANGLE PROJECTION

ALL DIMENSIONS ARE IN MM


T10W-101-T69-V9-I-SI

ON DRAWING


DO NOT SCALE IF IN DOUBT, ASK

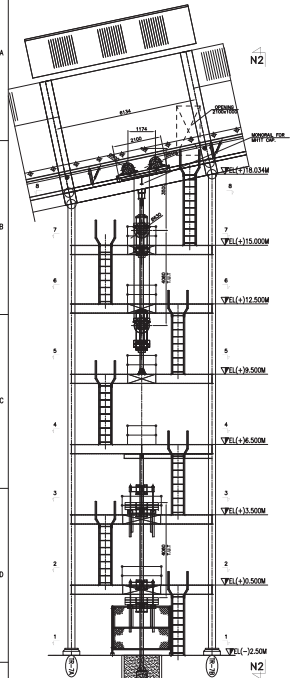


ARRGT. OF VGTU FOR
CONVEYOR NOS. BCN 4A/4B

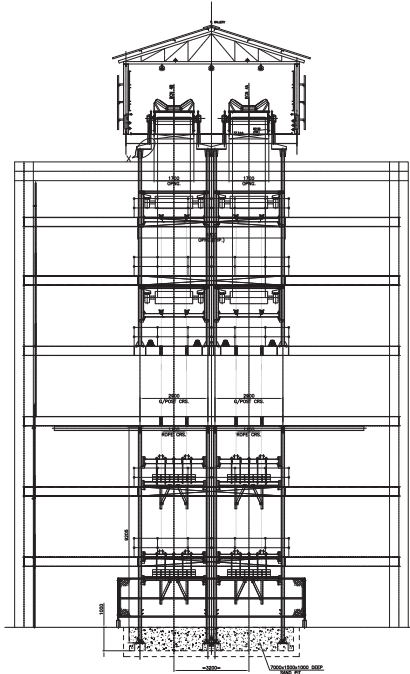


SECTION N2-N2

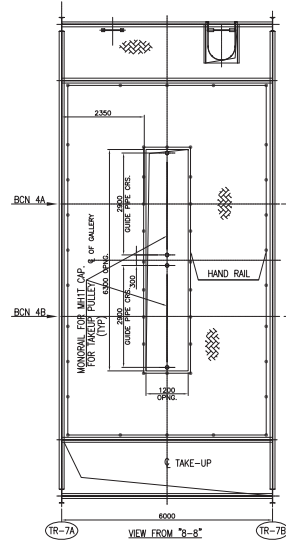


VIEW FROM "7B-8"

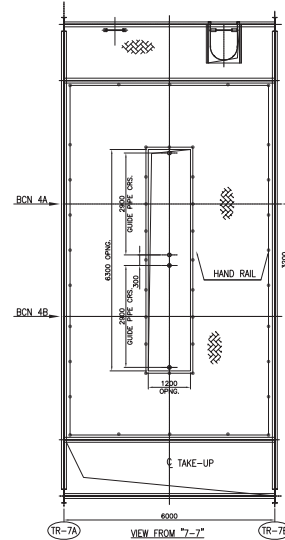


VIEW FROM "7-7"

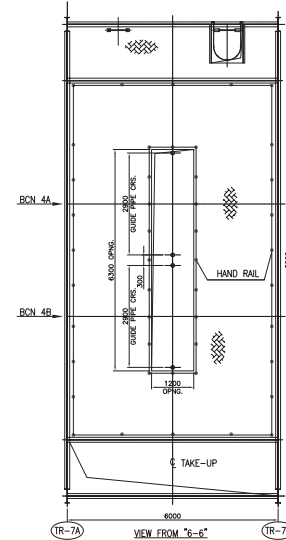


VIEW FROM "6-6"

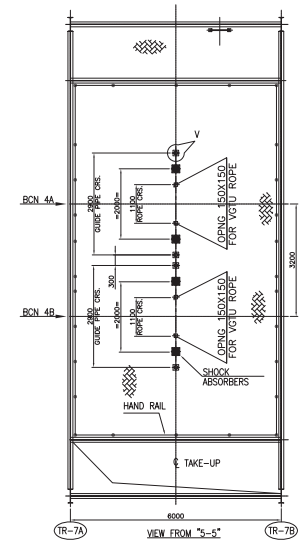


VIEW FROM "5-5"

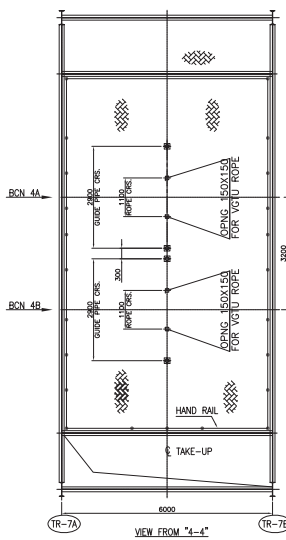


VIEW FROM "4-4"

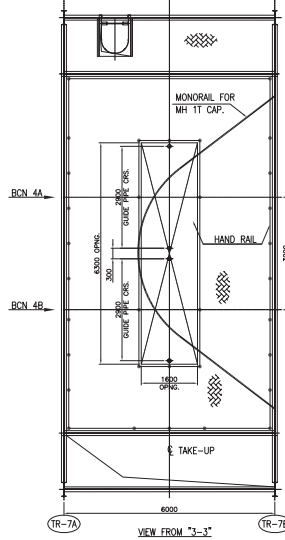

VIEW FROM "3-3"













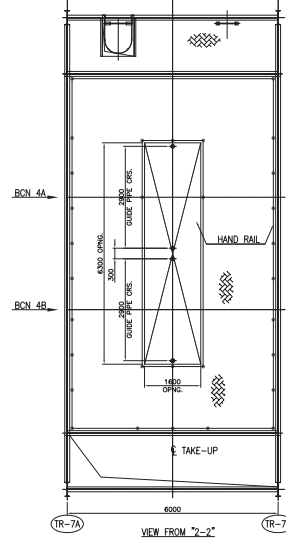


VIEW FROM "2-2"

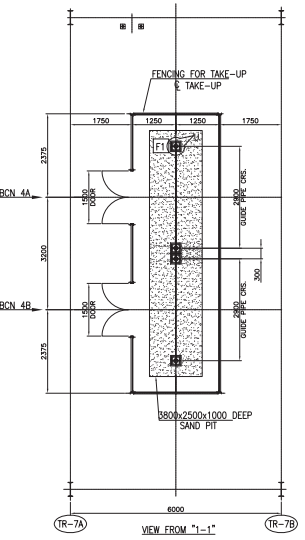

VIEW FROM "1-1"

     FLOOR PLANS OF VGTU

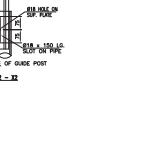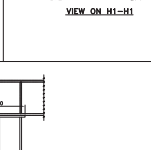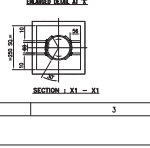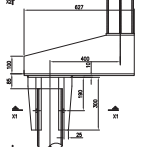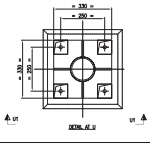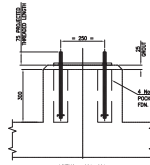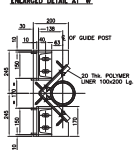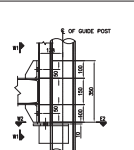

OWNER:	TELANGANA STATE POWER GENERATION CORPORATION LTD. HYDERABAD - TELANGANA, INDIA			
CONSULTANT:	DESEIN PRIVATE LIMITED			
PROJECT :	BHADRADRI THERMAL POWER STATION 4 X 270 MW, UNITS-1 TO 4, MANUGURI, TELANGANA, INDIA			
CONTRACTOR:	BHARAT HEAVY ELECTRICALS LIMITED INDUSTRIAL SYSTEMS GROUP ISG-BANGALORE			
TITLE :	GA AND LOAD DATA OF BCN-4A & 4B			
SCALE:	BHEL JOB NO. IS-14-2007	BHEL-ISG DRG.NO.1	IS-1-GA-691-101-M011	REV: 00
				SIZE-A1

R/NO	DATE	BRIEF RECORD	BY	APPD
		REVISIONS		

DRN	BMH	03.08.15	NO
SHD	MNK	03.08.15	NR
APP	RSP/VSS		
		TOTAL SHEETS	05
		SHEET NO.	05
		REV	00